



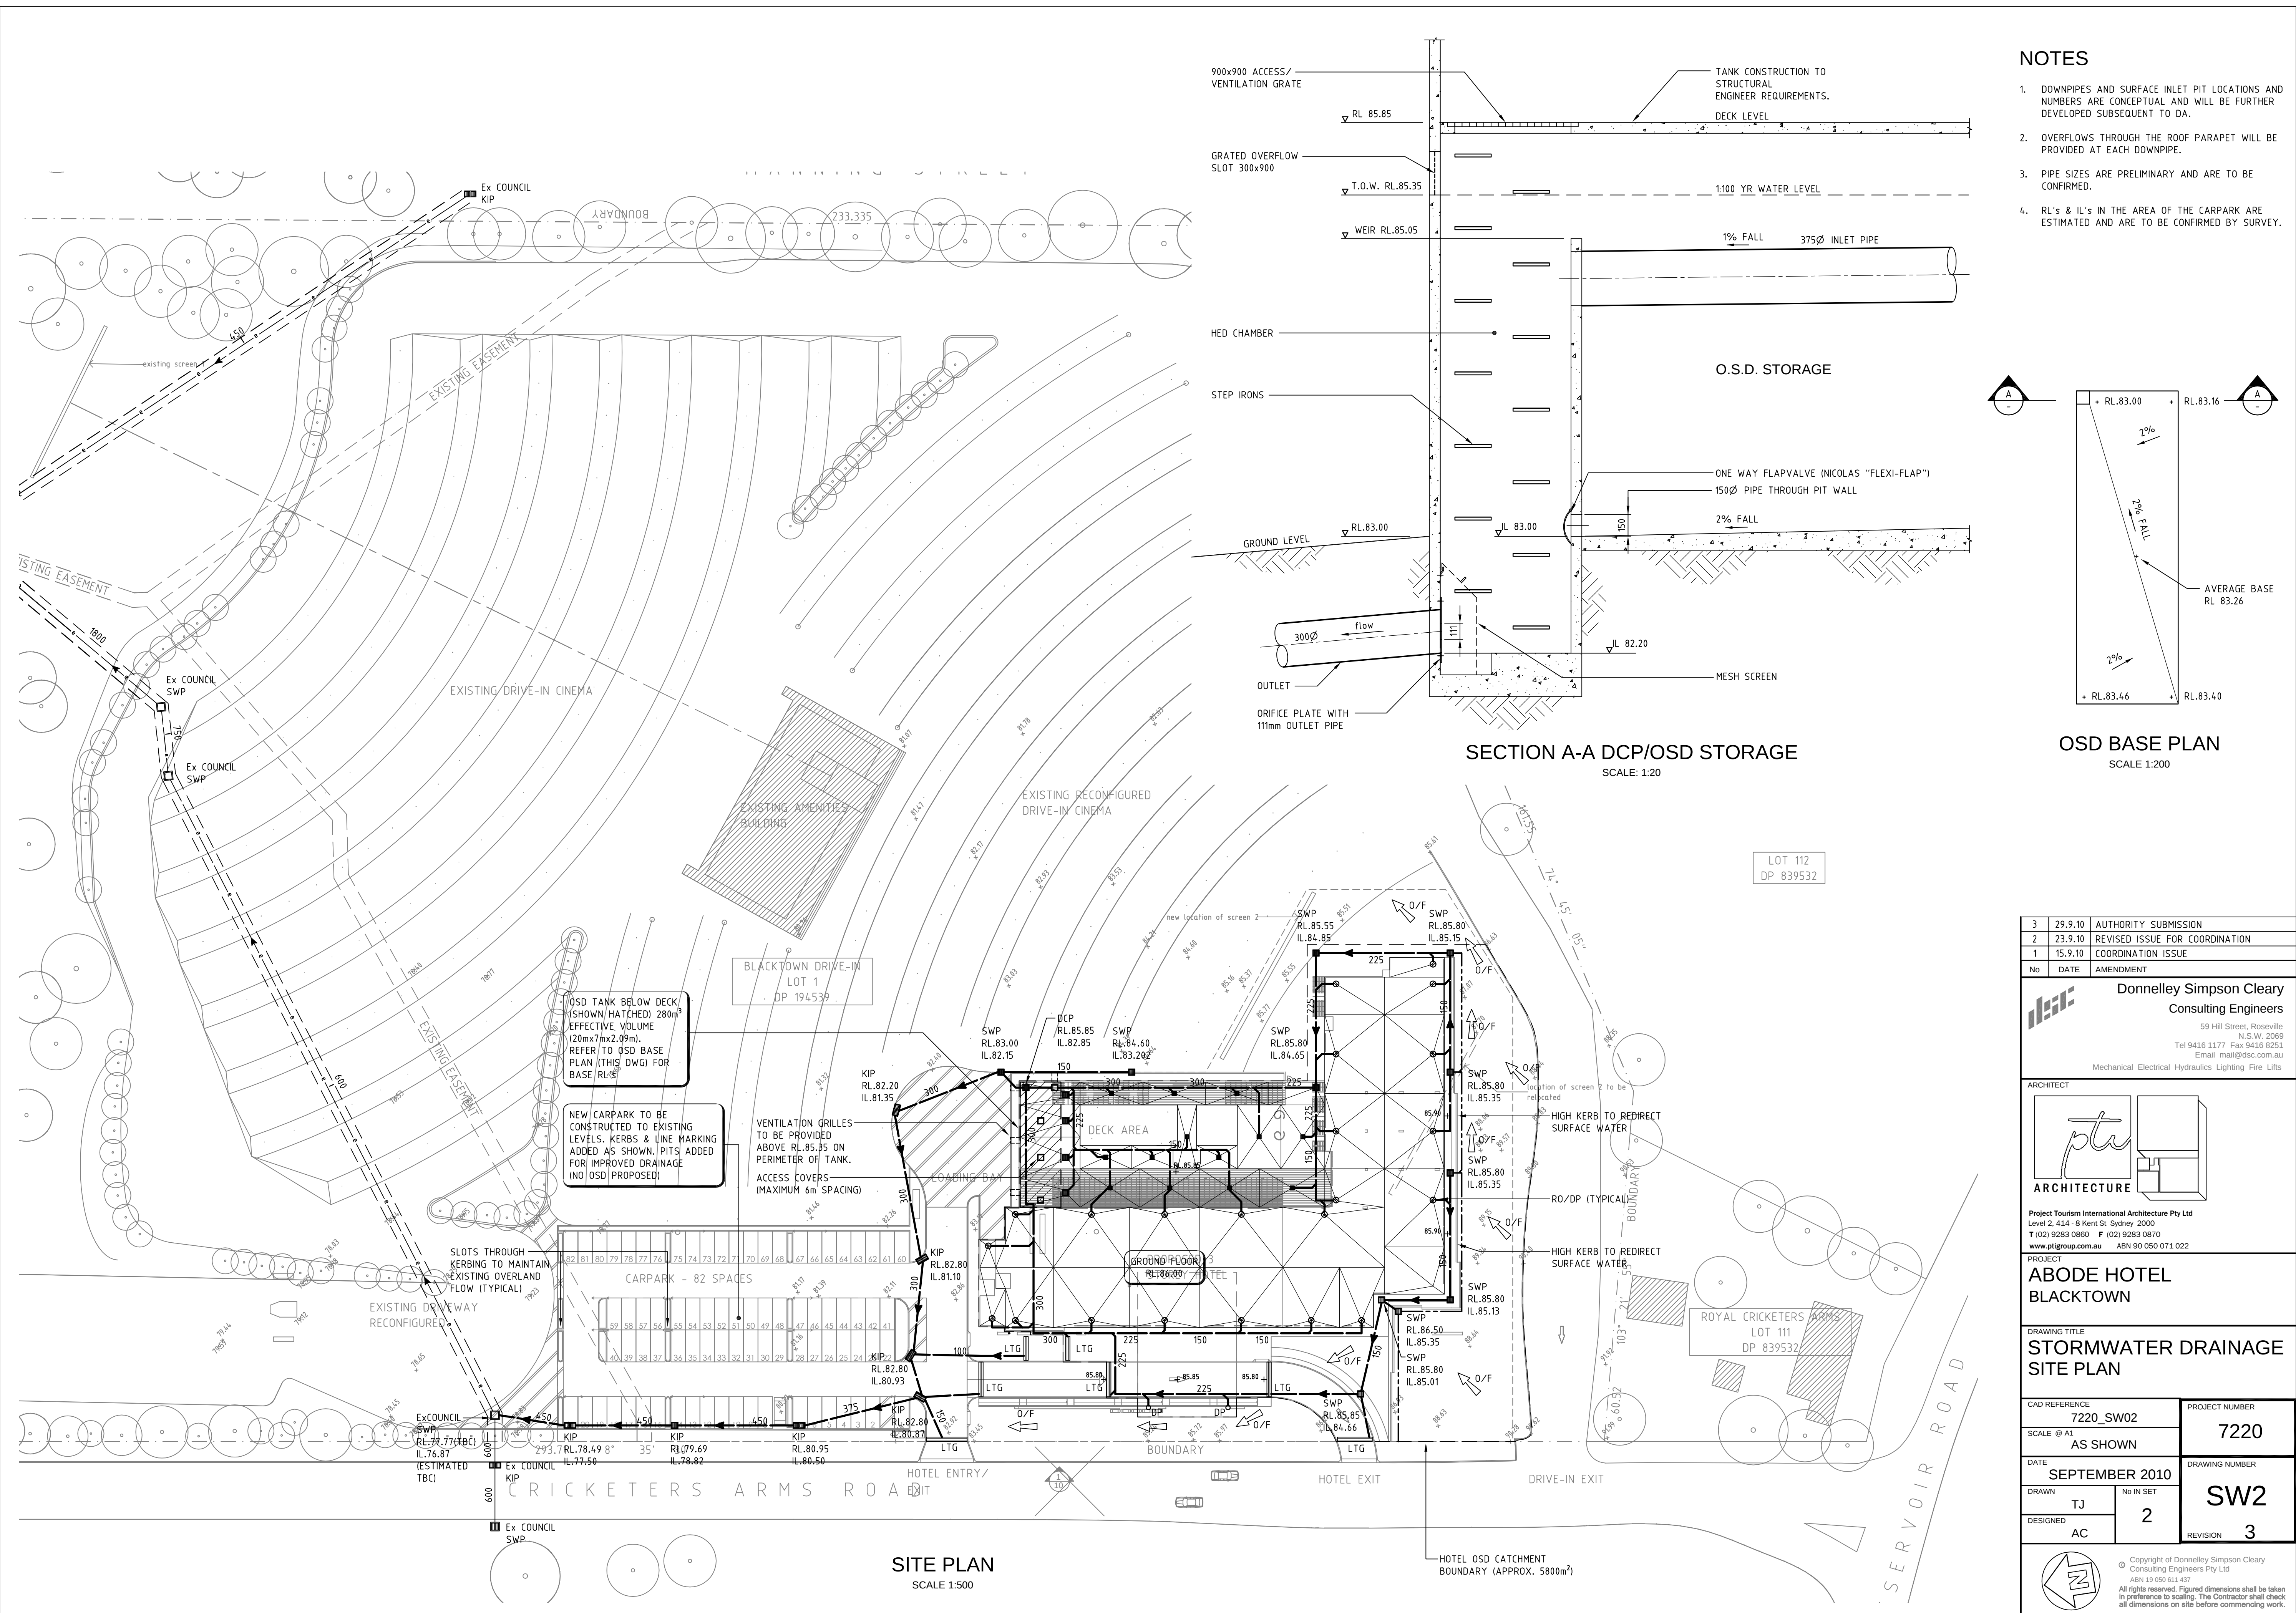

- NOTES
1. DOWNPIPES AND SURFACE INLET PIT LOCATIONS AND NUMBERS ARE CONCEPTUAL AND WILL BE FURTHER DEVELOPED SUBSEQUENT TO DA.
 2. OVERFLOWS THROUGH THE ROOF PARAPET WILL BE PROVIDED AT EACH DOWNPIPE.
 3. PIPE SIZES ARE PRELIMINARY AND ARE TO BE CONFIRMED.
 4. RL's & IL's IN THE AREA OF THE CARPARK ARE ESTIMATED AND ARE TO BE CONFIRMED BY SURVEY.

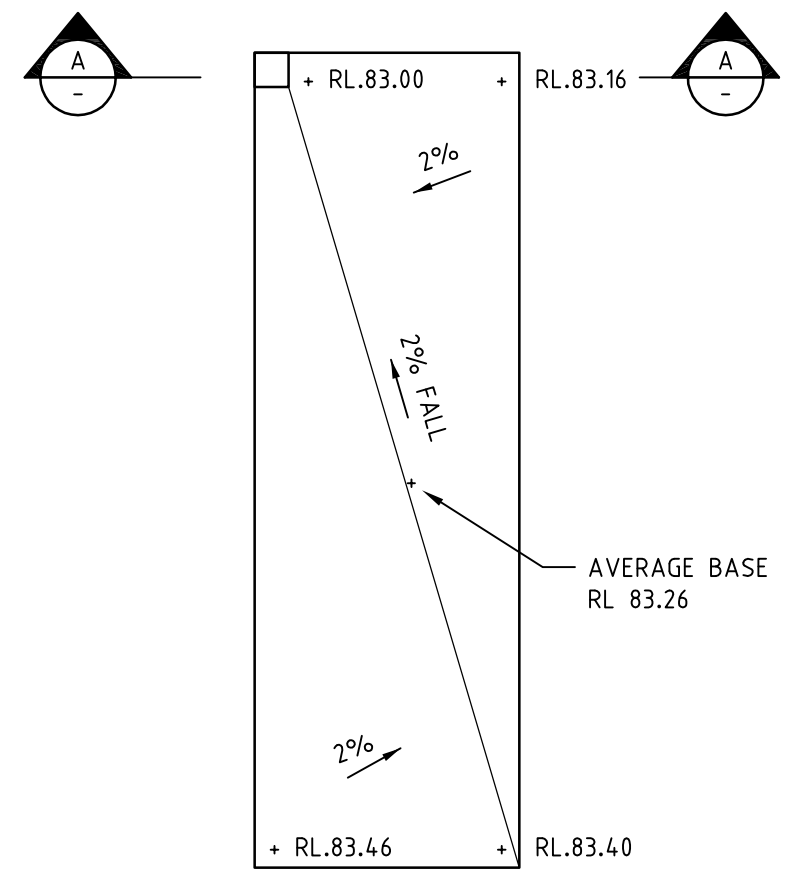

SECTION A-A DCP/OSD STORAGE
SCALE 1:20

OSD BASE PLAN
SCALE 1:200

3	29.9.10	AUTHORITY SUBMISSION
2	23.9.10	REVISED ISSUE FOR COORDINATION
1	15.9.10	COORDINATION ISSUE
No	DATE	AMENDMENT
Donnelley Simpson Cleary Consulting Engineers 59 Hill Street, Roseville N.S.W. 2069 Tel 9416 1177 Fax 9416 0251 Email mail@dtsc.com.au Mechanical Electrical Hydraulics Lighting Fire Lifts		
ARCHITECT ARCHITECTURE Project Tourism International Architecture Pty Ltd Level 2, 414 - 8 Kent St Sydney 2000 T (02) 9283 0860 F (02) 9283 0870 www.ptigroup.com.au ABN 90 050 071 022		
PROJECT ABODE HOTEL BLACKTOWN		
DRAWING TITLE STORMWATER DRAINAGE SITE PLAN		
CAD REFERENCE 7220_SW02		PROJECT NUMBER 7220
SCALE @ A1 AS SHOWN		DRAWING NUMBER SW2
DATE SEPTEMBER 2010		REVISION 3
DRAWN TJ	No IN SET 2	
DESIGNED AC		
 Copyright of Donnelley Simpson Cleary Consulting Engineers Pty Ltd ABN 19 050 611 437 All rights reserved. Figured dimensions shall be taken in preference to scaling. The Contractor shall check all dimensions on site before commencing work.		