

DRAWING SCHEDULE -

			DATE OF ISSUE						
04.06.10	23.06.10	06.08.10							

ARCHITECTURAL DRAWINGS

		A	B	C											
A-00	COVER SHEET														
A-01	SITE LOCATION PLAN														
A-02	SITE LAYOUT PLAN														
A-03	ELEVATION														

SURVEY DRAWINGS

--	--	--	--	--	--	--	--	--	--	--	--	--	--	--	--

TYPICAL DETAILS DRAWINGS

STRUCTURAL DRAWINGS

OH&S DRAWINGS

--	--	--	--	--	--	--	--	--	--	--	--	--	--	--	--

EME ZONES DRAWING

--	--	--	--	--	--	--	--	--	--	--	--	--	--	--	--

ELECTRICAL DRAWINGS

DISTRIBUTION

CROWN CASTLE INTERNATIONAL	1	1	1												
----------------------------	---	---	---	--	--	--	--	--	--	--	--	--	--	--	--




SITE NAME : EASTERN CREEK RACEWAY
 SITE NUMBER : 34000XX
 SITE ADDRESS : GATE 2, BRABHAM DRIVE
 EASTERN CREEK
 NSW, 2766



65A Mill Hill Rd
 Bondi Junction NSW 2022
 E-mail: info@commplan.com.au
 Phone: (02) 9369 2872
 Fax: (02) 85804885
 www.commplan.com.au

MYD Consulting Engineers Pty Ltd
 Level 1,
 230 Victoria Road
 Gladesville, NSW 2111
 Tel: 02 9817 2811
 Fax: 02 9817 2633
 Email: info@mydconsulting.com
 www.mydconsulting.com

FOR APPROVAL

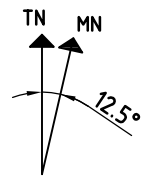


**EASTERN CREEK RACEWAY
SITE 34000XX**



MAPPING AND DATA COPYRIGHT © UNIVERSAL PUBLISHERS PTY LTD 2004
 SYDNEY UBD REFERENCE
 MAP : 236
 GRID REFERENCE : E2

LOCALITY PLAN
 SCALE = N.T.S

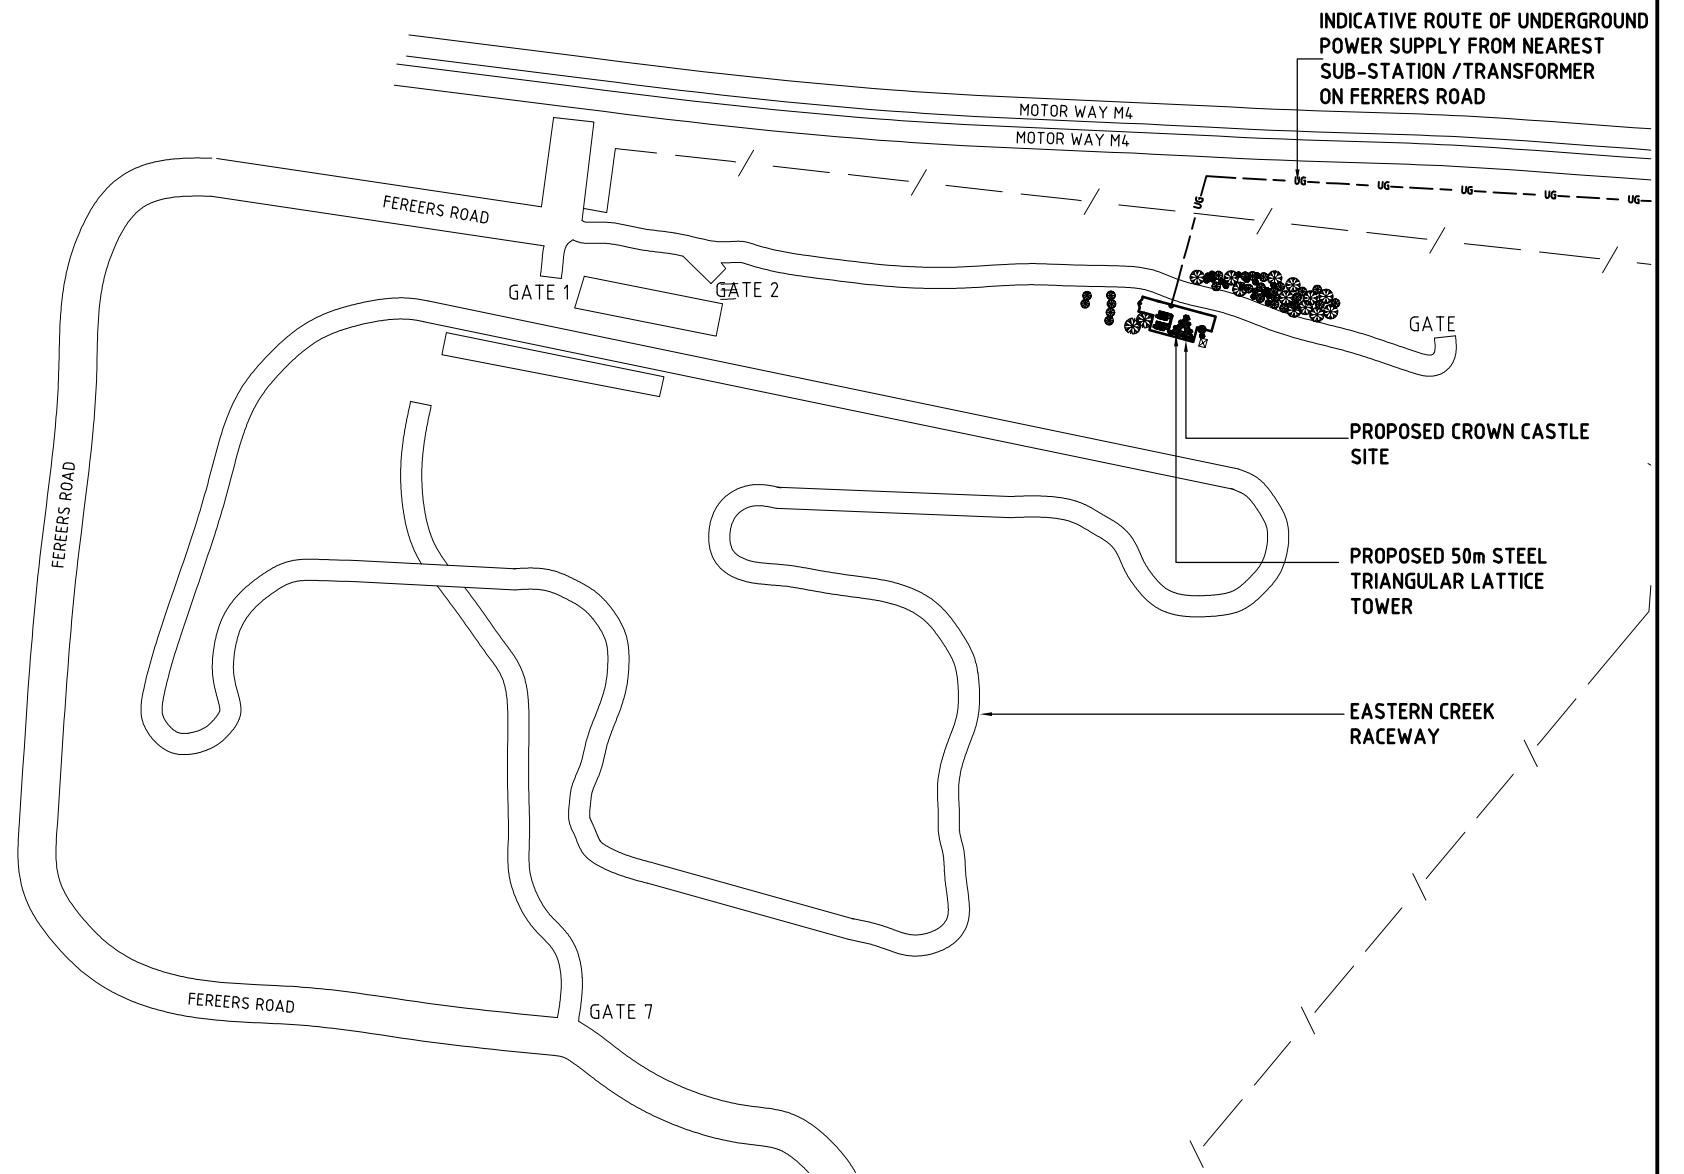

SITE LOCATION PLAN
 SCALE = 1:2500

NOTE:
 THIS DRAWING IS DIAGRAMMATIC ONLY
 AND SHOULD NOT BE SCALED.
 DIMENSIONS, CO-ORDINATES, AND LEVELS
 SHOWN ARE NOMINAL AND SUBJECT TO
 CONFIRMATION BY SURVEYOR.

FOR APPROVAL

Rev	Date	Revision Details	Co.	By	Ver.	App.
C	06.08.10	ISSUED FOR APPROVAL	-	FP	P.M	
B	23.06.10	ISSUED FOR APPROVAL	-	FP	P.M	
A	04.06.10	ISSUED FOR APPROVAL	-	FP	P.M	

myd MYD Consulting Engineers Pty Ltd
 Level 1, 230 Victoria Road, Gladesville, NSW 2111
 Tel: 02 9817 2811
 Fax: 02 9817 2833
 Email: info@mydconsulting.com
 www.mydconsulting.com

Structural Civil Stormwater Telecommunications

Communications Planning Pty Ltd
 65A Mill Hill Rd, Bondi Junction NSW 2022
 E-mail: info@commplan.com.au
 Phone: (02) 9369 2872
 Fax: (02) 85804885

Client: **CROWN CASTLE INTERNATIONAL**

Project: **EASTERN CREEK RACEWAY SITE No: 34000XX EASTERN CREEK**


Drawing Title: **SITE LOCATION PLAN**

Designed PM	Drawn FP	Date 06.08.10
Verified	Scale AS SHOWN	
Approved DD	Project No. T388	
Drawing No. 34000XX-A01	Revision C	


PRIVATE ACCESS ROAD

EMERGENCY ASSEMBLY POINT SIGN

GATE 4

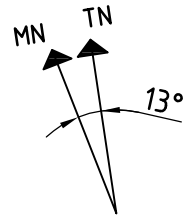

NOTE:
PROPOSED CROWN CASTLE SITE TO BE FINISHED WITH 100mm DEEP BLUE METAL OVER GEOTEXTILE WEEDMATTING.

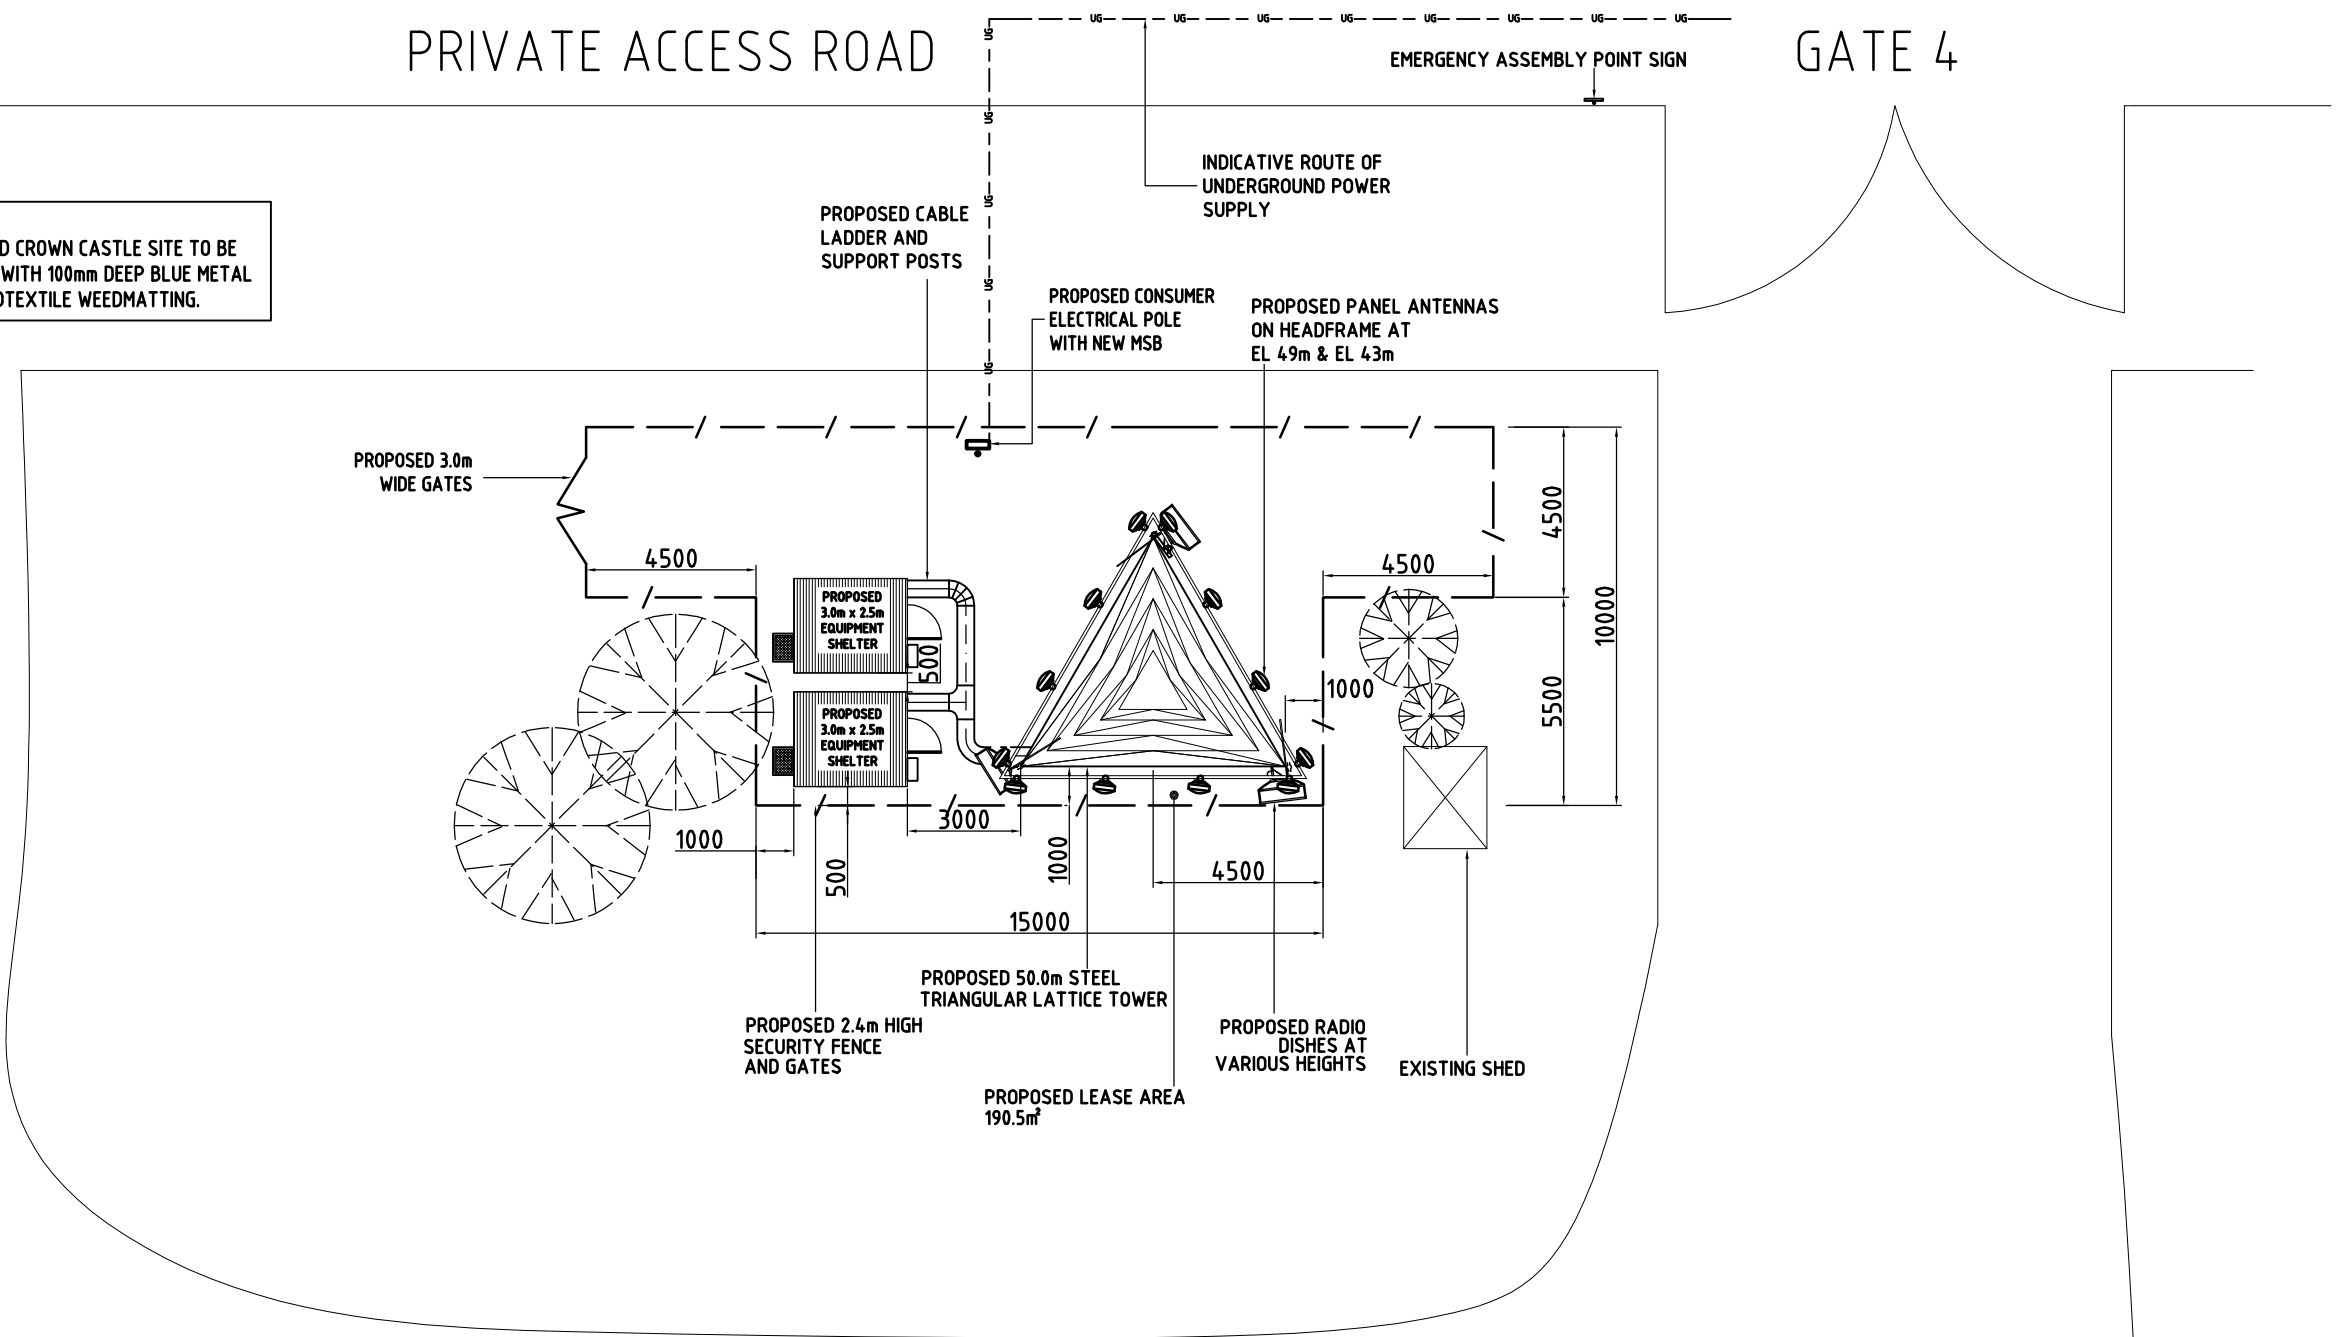

SITE LOCATION PLAN

SCALE = 1:100

NOTE:
- FEEDERS TO RUN INSIDE CABLE TRAYS THEN ON TOWER LEGS ON LEG CLAMPS IN PIGGY BACK FASHION.

NOTE:
EXISTING TREES NOT TO BE REMOVED

FOR APPROVAL

Rev	Date	Revision Details	Co.	By	Ver.	App.
C	06.08.10	ISSUED FOR APPROVAL	-	FP	P.M	
B	23.06.10	ISSUED FOR APPROVAL	-	FP	P.M	
A	04.06.10	ISSUED FOR APPROVAL	-	FP	P.M	

MYD Consulting Engineers Pty Ltd
 Level 1,
 230 Victoria Road
 Gladesville, NSW 2111
 Tel: 02 9817 2811
 Fax: 02 9817 2833
 Email: info@mydconsulting.com
 www.mydconsulting.com


Communications Planning Pty Ltd
 65A Mill Hill Rd
 Bondi Junction NSW 2022
 E-mail: info@commplan.com.au
 Phone: (02) 9369 2872
 Fax: (02) 85804885

Client:
CROWN CASTLE INTERNATIONAL

Project:
**EASTERN CREEK RACEWAY
 SITE No:34000XX
 EASTERN CREEK**

Drawing Title:
SITE LAYOUT PLAN

Designed PM	Drawn FP	Date 06.08.10
Verified	Scale AS SHOWN	
Approved DD	Project No. T388	
Drawing No. 34000XX-A02 B		Revision

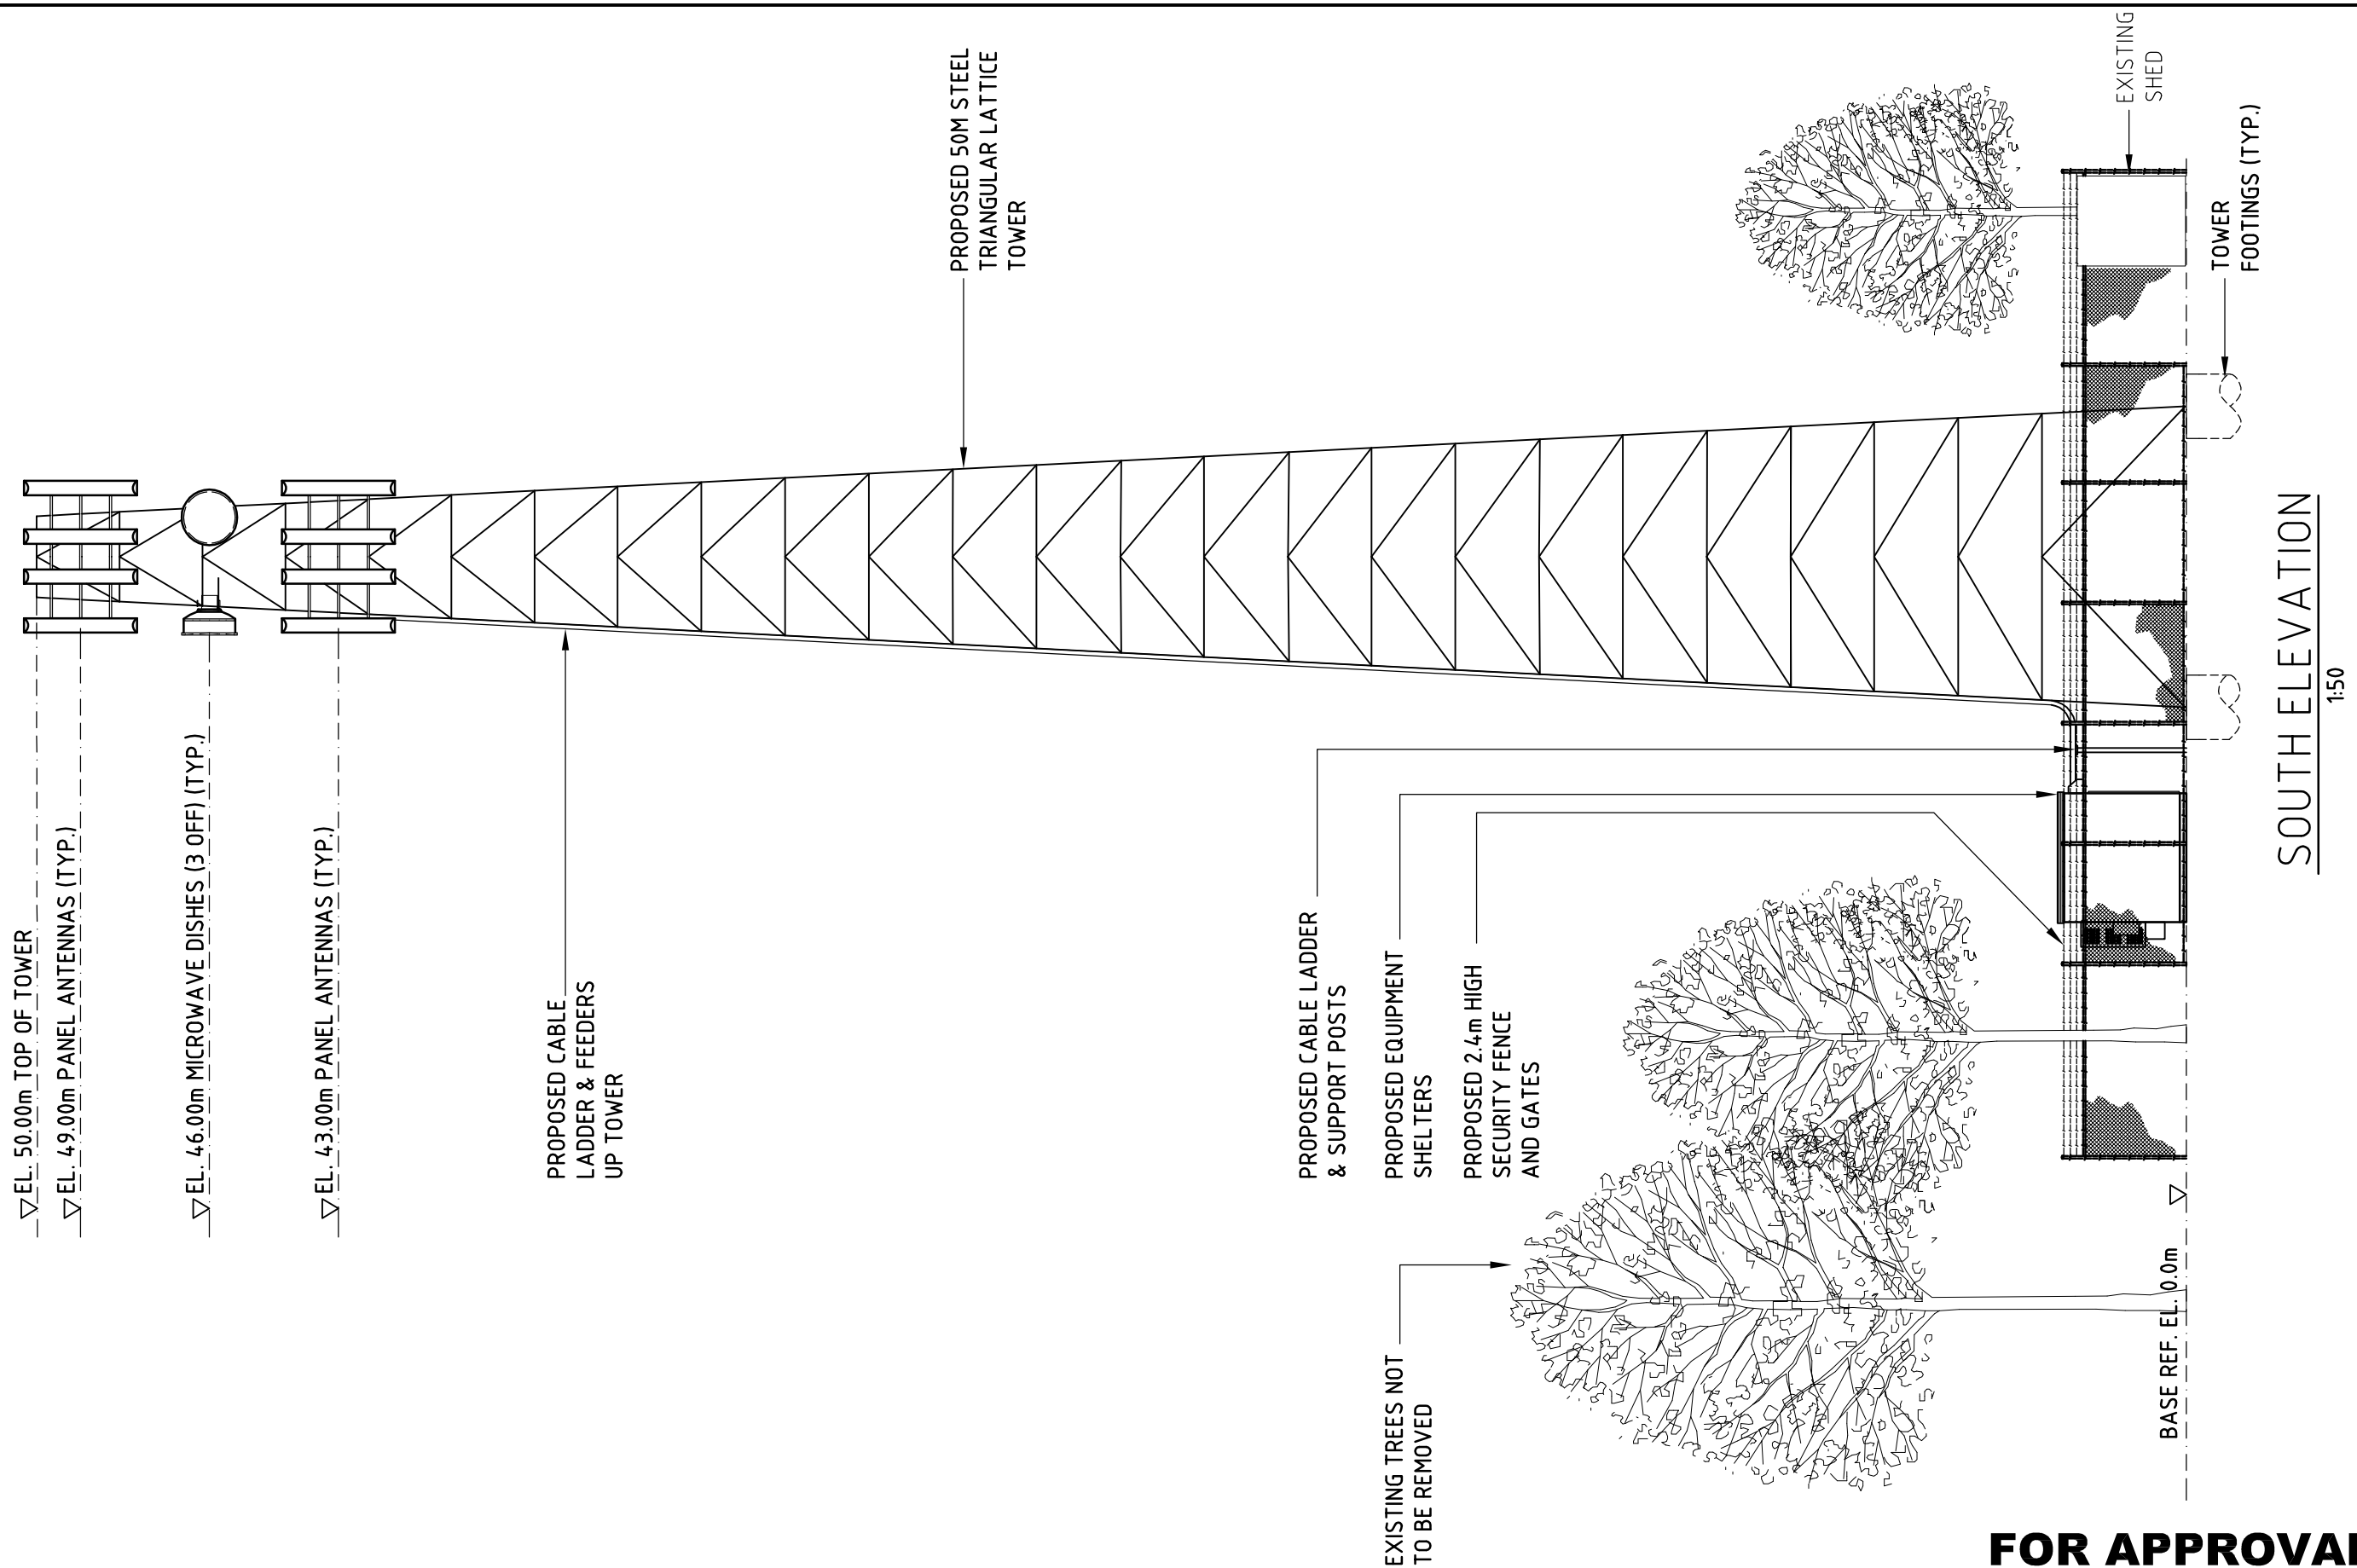

FOR APPROVAL

Rev	Date	Revision Details	Co.	By	Ver.	App.
C	06.08.10	ISSUED FOR APPROVAL	-	FP	P.M	
B	23.06.10	ISSUED FOR APPROVAL	-	FP	P.M	
A	04.06.10	ISSUED FOR APPROVAL	-	FP	P.M	

myd MYD Consulting Engineers Pty Ltd
 Level 1, 230 Victoria Road, Glebeville, NSW 2111
 Tel: 02 9817 2811
 Fax: 02 9817 2833
 Email: info@mydconsulting.com
 www.mydconsulting.com

Structural Civil Stormwater Telecommunications

Communications Planning Pty Ltd

65A Mill Hill Rd, Bondi Junction NSW 2022
 E-mail: info@commplan.com.au
 Phone: (02) 9369 2872
 Fax: (02) 85804885

Client: **CROWN CASTLE INTERNATIONAL**

Project: **EASTERN CREEK RACEWAY SITE No: 34000XX EASTERN CREEK**

Drawing Title: **ELEVATION**

Designed PM	Drawn FP	Date 06.08.10
Verified	Scale AS SHOWN	
Approved DD	Project No. T388	
Drawing No. 34000XX-A03		Revision C