




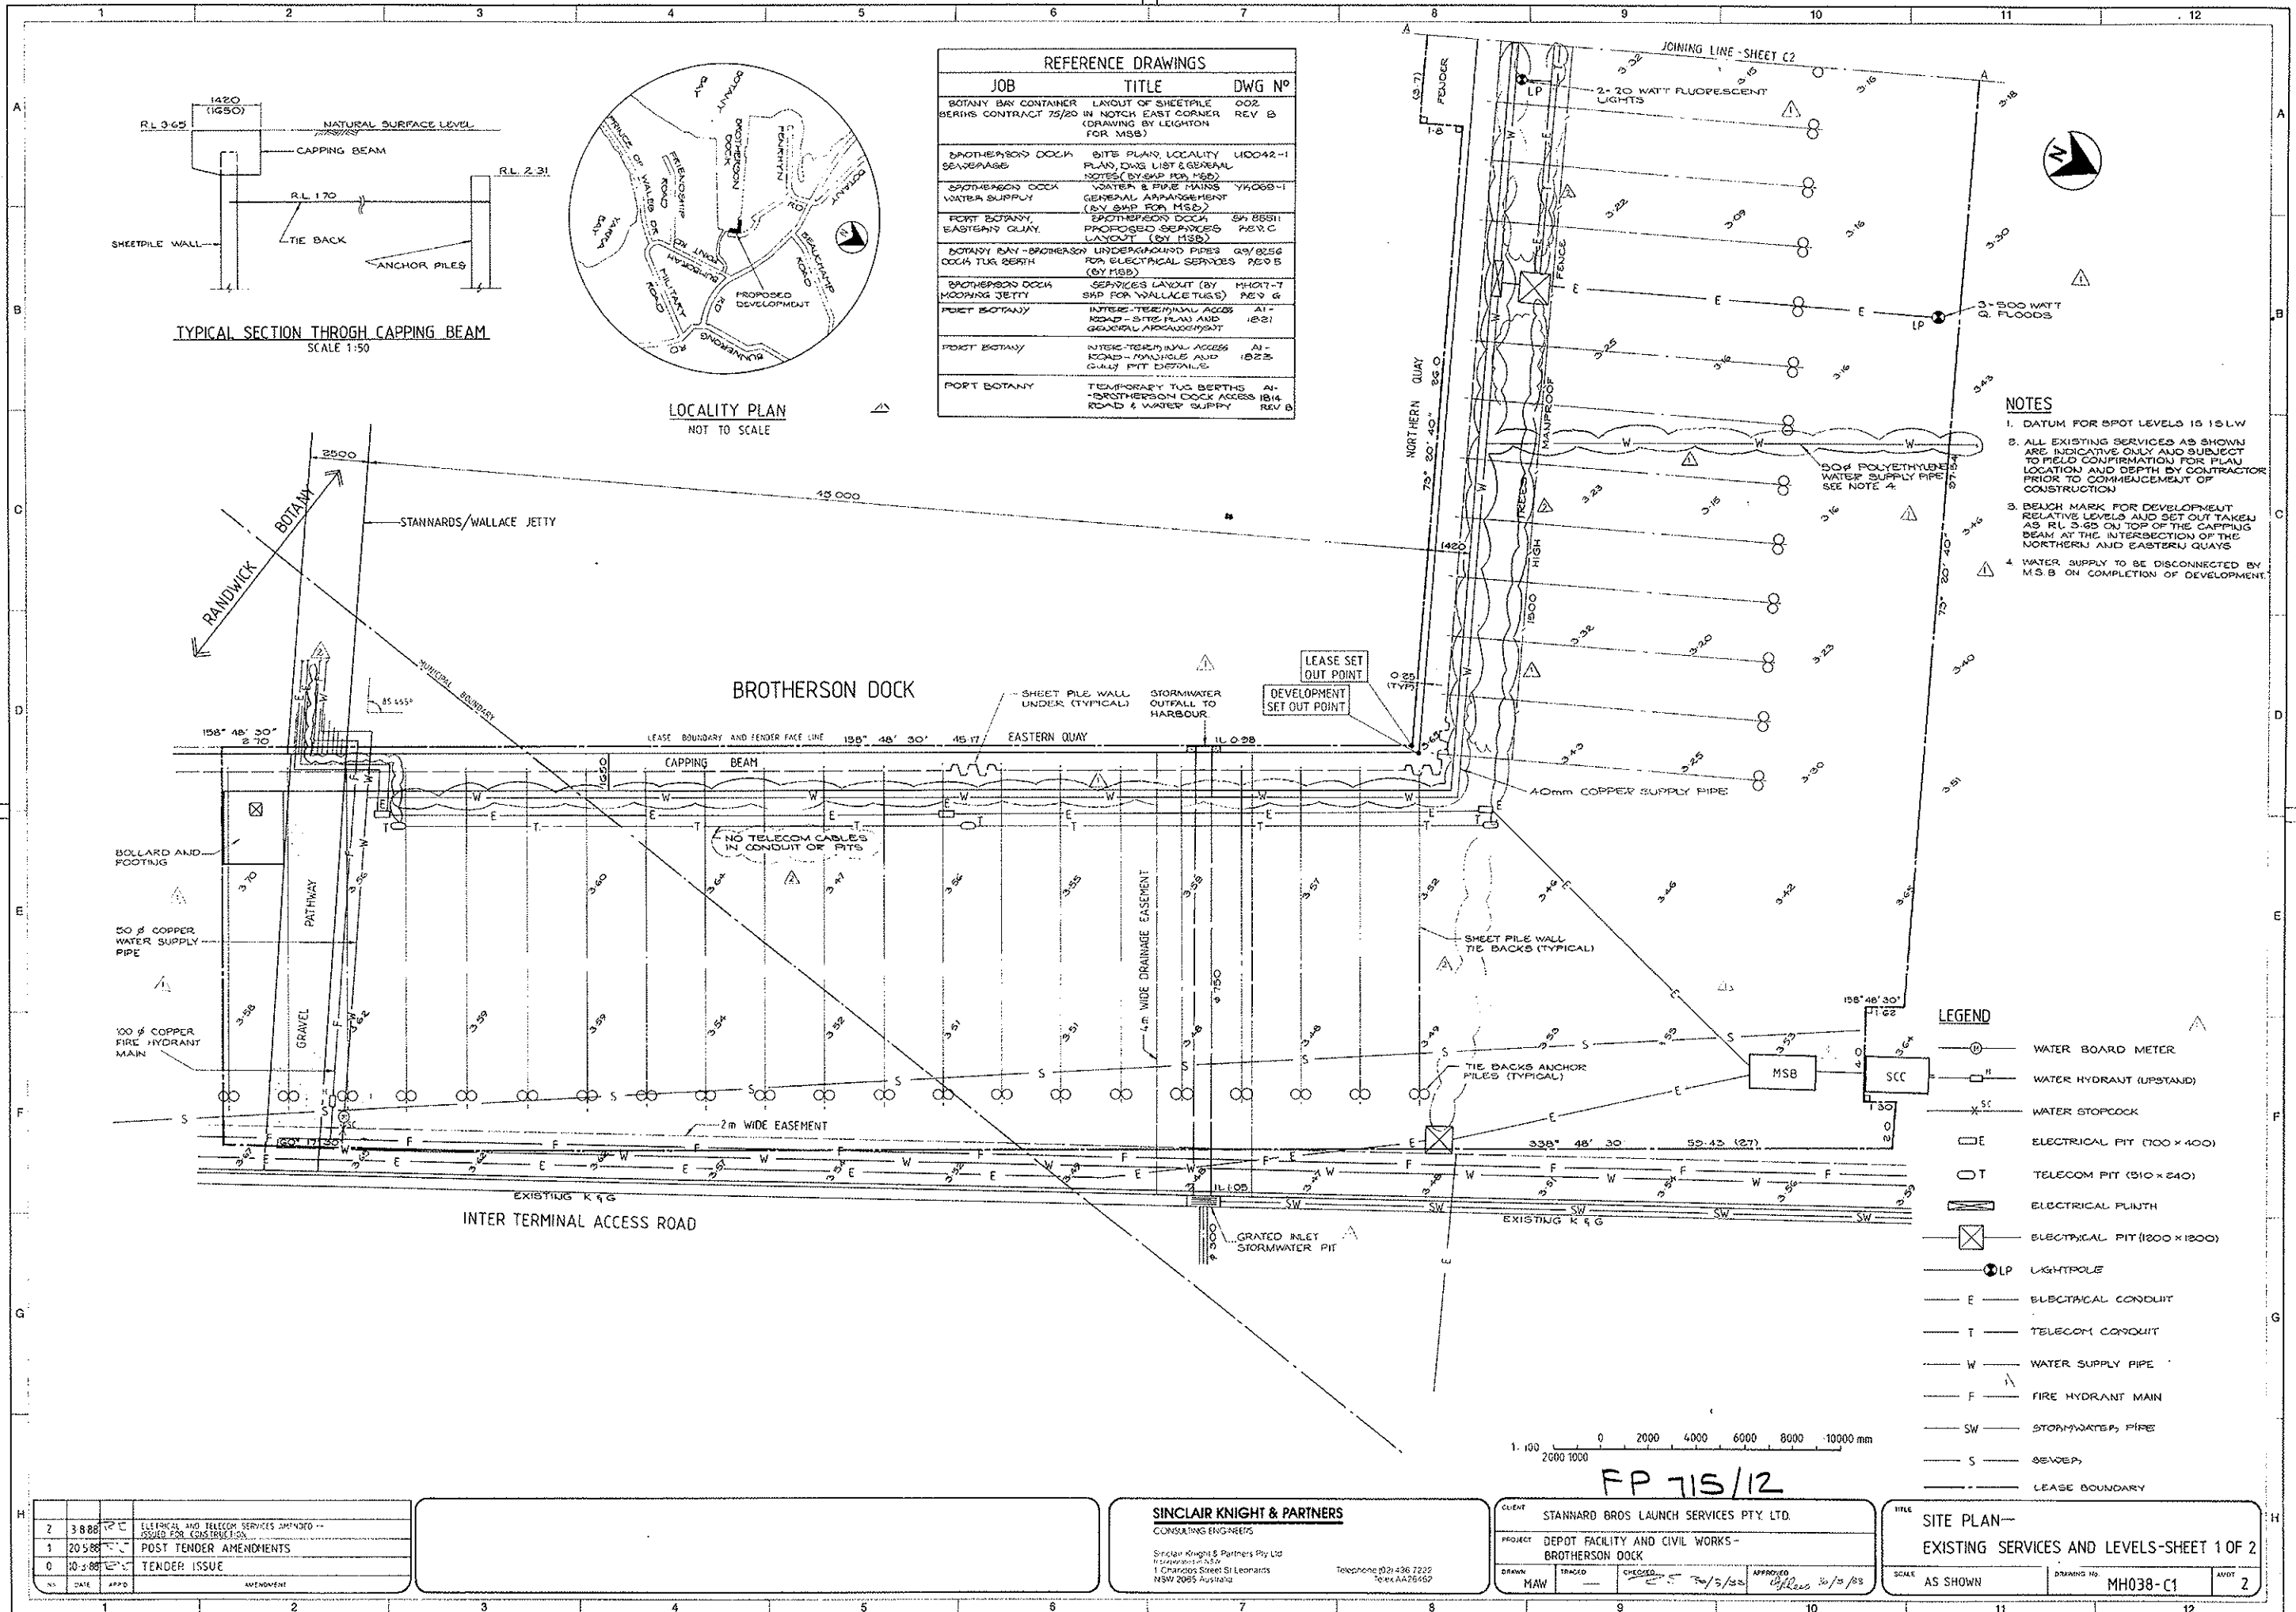

REFERENCE DRAWINGS		
JOB	TITLE	DWG NO
BOTANY BAY CONTAINER BERMS CONTRACT 75/20	LAYOUT OF SHEETPILE WALLS IN NOTCH EAST CORNER (DRAWING BY LEIGHTON FOR MSB)	002 REV B
BROTHERSON DOCK SEWERAGE	SITE PLAN, LOCALITY PLAN, DWG LIST & GENERAL NOTES (BY S&P FOR MSB)	110042-1
BROTHERSON DOCK WATER SUPPLY	WATER & FIRE MAINS GENERAL ARRANGEMENT (BY S&P FOR MSB)	Y1008-1
PORT BOTANY EASTERN QUAY	BROTHERSON DOCK PROPOSED SERVICES LAYOUT (BY MSB)	84 88511 REV C
BOTANY BAY - BROTHERSON DOCK TUG BERTH	UNDERGROUND PIPES FOR ELECTRICAL SERVICES (BY MSB)	G3/8256 REV B
BROTHERSON DOCK MOORING JETTY	SERVICES LAYOUT (BY MSB) SHIP FOR WALLACE TUGS (REV G)	M4017-7
PORT BOTANY	INTER-TERMINAL ACCESS ROAD - SITE PLAN AND GENERAL ARRANGEMENT	A1-1821
PORT BOTANY	INTER-TERMINAL ACCESS ROAD - MANHOLE AND GULLY FIT DETAILS	A1-1823
PORT BOTANY	TEMPORARY TUG BERTHS - BROTHERSON DOCK ACCESS 1814 ROAD & WATER SUPPLY	A1-1825 REV B

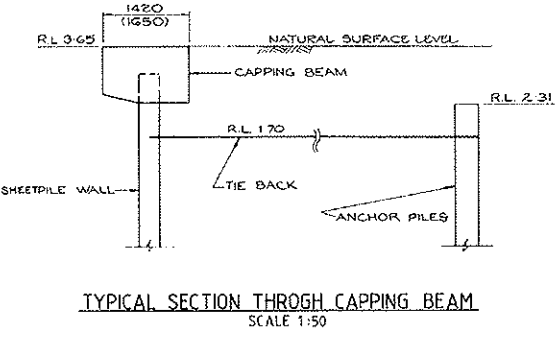

TYPICAL SECTION THROUGH CAPPING BEAM
SCALE 1:50

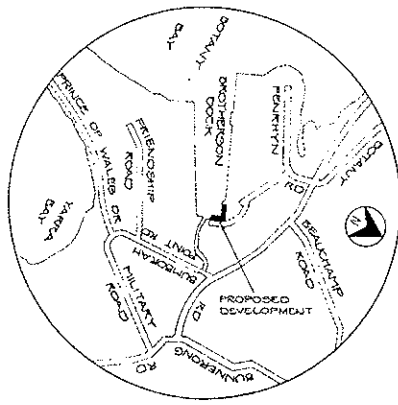

LOCALITY PLAN
NOT TO SCALE

- NOTES**
- DATUM FOR SPOT LEVELS IS 151.1W
 - ALL EXISTING SERVICES AS SHOWN ARE INDICATIVE ONLY AND SUBJECT TO FIELD CONFIRMATION FOR PLAN LOCATION AND DEPTH BY CONTRACTOR PRIOR TO COMMENCEMENT OF CONSTRUCTION
 - BEACH MARK FOR DEVELOPMENT RELATIVE LEVELS AND SET OUT TAKEN AS RL 3.65 ON TOP OF THE CAPPING BEAM AT THE INTERSECTION OF THE NORTHERN AND EASTERN QUAYS
 - WATER SUPPLY TO BE DISCONNECTED BY MSB ON COMPLETION OF DEVELOPMENT

- LEGEND**
- WATER BOARD METER
 - WATER HYDRANT (UPSTAND)
 - WATER STOPCOCK
 - ELECTRICAL PIT (700 x 400)
 - TELECOM PIT (310 x 240)
 - ELECTRICAL PLINTH
 - ELECTRICAL PIT (1200 x 1200)
 - LIGHTPOLE
 - ELECTRICAL CONDUIT
 - TELECOM CONDUIT
 - WATER SUPPLY PIPE
 - FIRE HYDRANT MAIN
 - STORMWATER PIPE
 - SEWER
 - LEASE BOUNDARY

2	3 888	ELECTRICAL AND TELECOM SERVICES AMENDED - ISSUED FOR CONSTRUCTION
1	20 588	POST TENDER AMENDMENTS
0	10 388	TENDER ISSUE

SINCLAIR KNIGHT & PARTNERS
CONSULTING ENGINEERS
Sinclair Knight & Partners Pty Ltd
1 Chandos Street St Leonards
NSW 2055 Australia
Telephone 02 436 7222
Telex AA7646P

CLIENT: STANNARD BROS LAUNCH SERVICES PTY LTD.
PROJECT: DEPOT FACILITY AND CIVIL WORKS - BROTHERSON DOCK
DRAWN: MAW
CHECKED: S. 7/3/83
APPROVED: 30/3/83

TITLE: SITE PLAN - EXISTING SERVICES AND LEVELS-SHEET 1 OF 2
SCALE: AS SHOWN
DRAWING NO: MH038-C1
A107: 2

FP 715/12

