



NOTE:
PROVIDE APPROPRIATE SIGNAGE ADJACENT UNDERGROUND TANKS;
'NO UNAUTHORISED ENTRY. CONFINED SPACE WORK PERMIT
REQUIRED FOR TANK ACCESS. NO UNAUTHORISED ENTRY.'

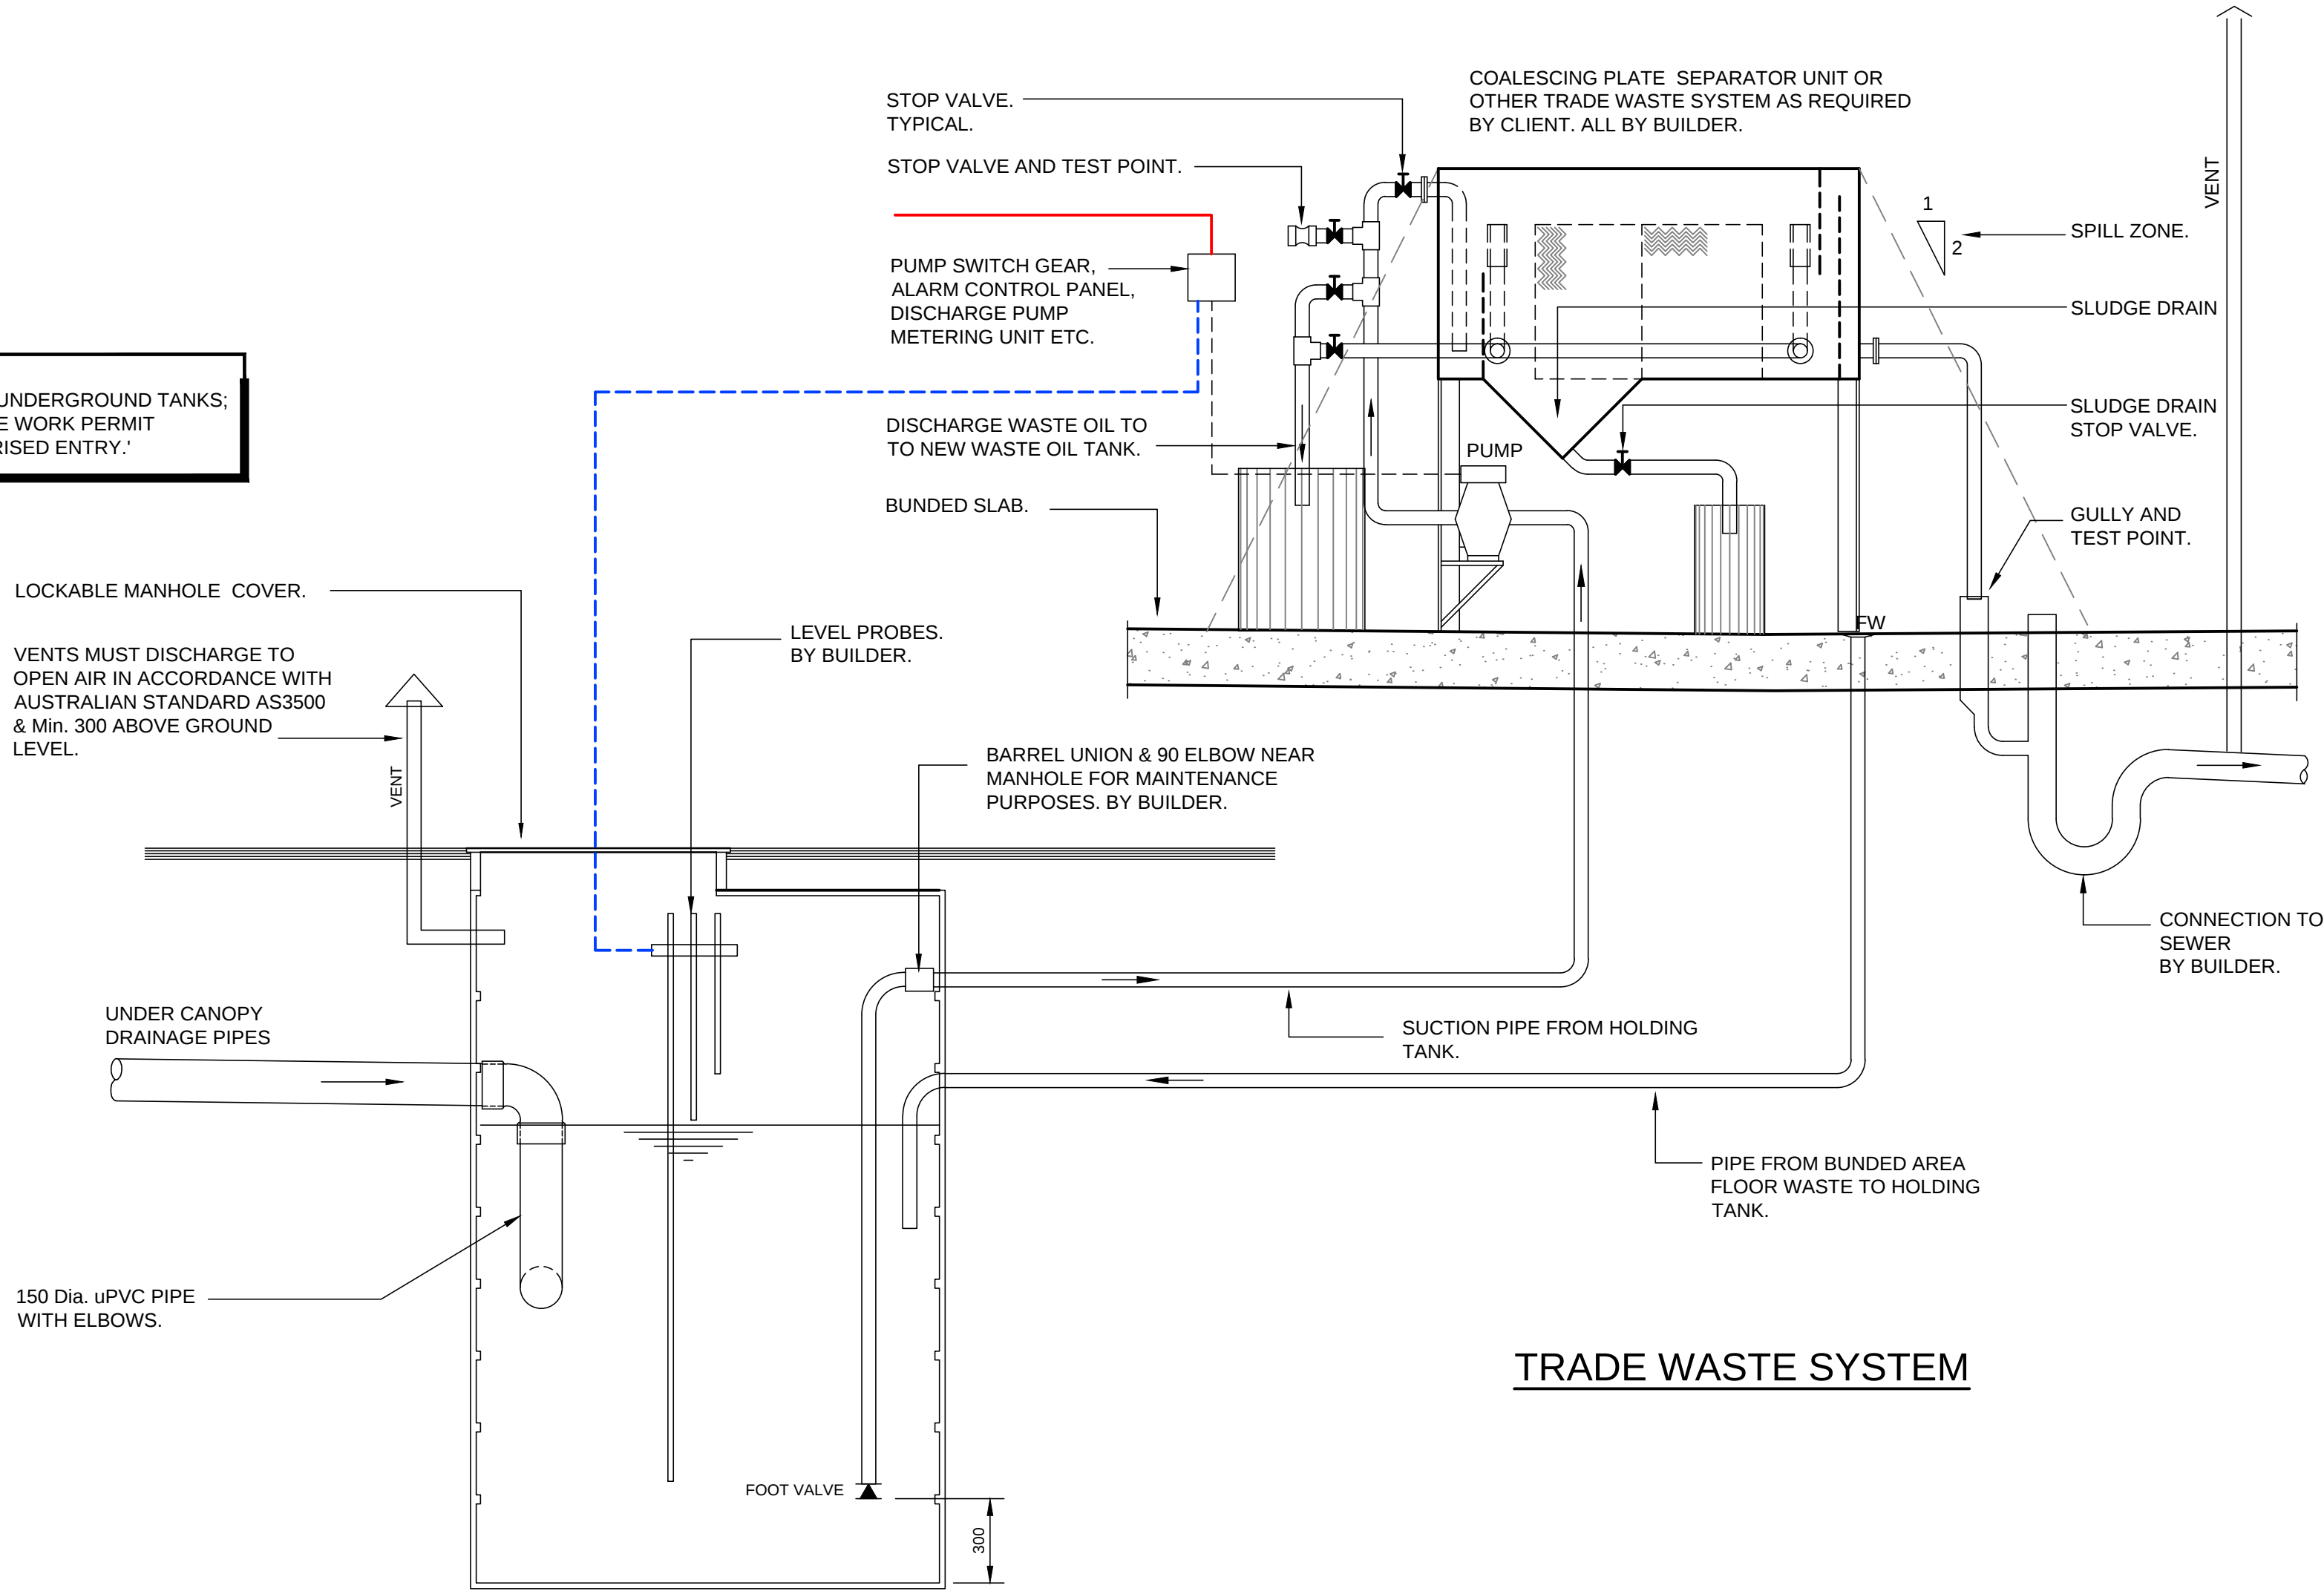


TRADE WASTE SYSTEM

OIL/WATER HOLDING TANK
3000 LITRES Nom. STORAGE BELOW
WATER LEVEL

SCHEMATIC ELEVATION OF POLLUTION CONTROL SYSTEM

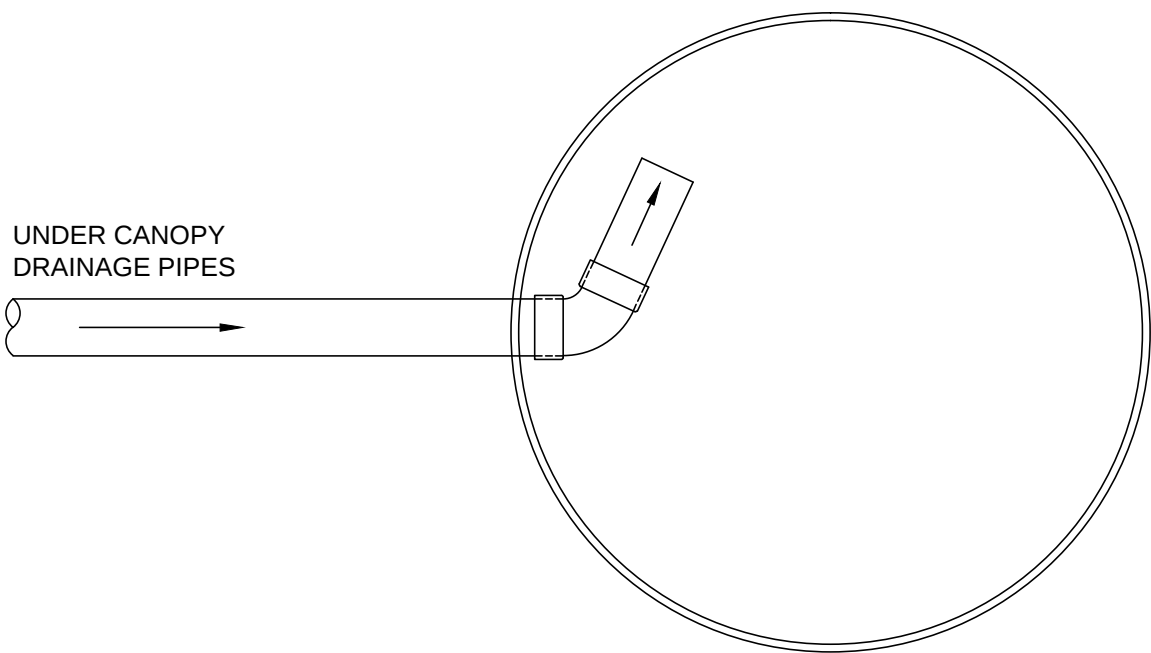


OIL/WATER HOLDING TANK

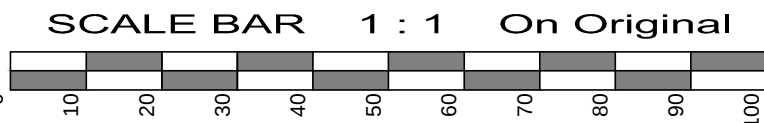

© 2014 R.J. SINCLAIR Pty Ltd ACN 002 050 526			
COPYRIGHT IN THESE DESIGNS AND DRAWINGS IS VESTED IN R.J. SINCLAIR PTY LTD. THE DESIGN AND DETAILS SHOWN ON THIS DRAWING ARE SPECIFIC TO THIS PROJECT ONLY AND MAY NOT BE REPRODUCED IN WHOLE OR IN PART BY ANY MEANS OR BE USED FOR ANY OTHER PROJECT OR PURPOSE WITHOUT THE WRITTEN CONSENT OF R.J. SINCLAIR PTY LTD.			
No.	Amendment	By	Date
P1	PRELIMINARY ISSUE. NOT FOR CONSTRUCTION.	VP	07.05.2014
P2	PRELIMINARY ISSUE FOR APPROVAL.	VP	14.05.2014
P3	PRELIMINARY ISSUE FOR FINAL APPROVAL BEFORE DA ISSUE. NOT FOR CONSTRUCTION..	VP	21.05.2014
DA-1	ISSUED FOR DEVELOPMENT APPROVAL ONLY. NOT FOR CONSTRUCTION.	VP	30.05.2014

Member BUILDING DESIGNERS
ASSOCIATION NSW
Accredited Building Designer : 6318
BBP Vic : DP-AD 15329
QBSA Lic. No : 1062914

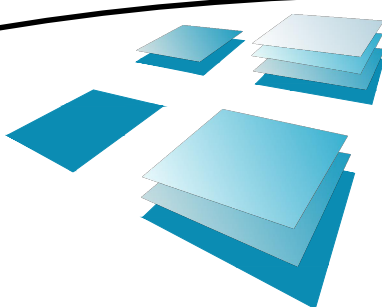

R.J. SINCLAIR Pty Ltd
Building Design
Office : Suite B111 - Sky City
NorWest Business Park
20 Lexington Drive
BELLA VISTA NSW 2153
Post : PO Box 503
ROUND CORNER NSW 2158
Phone : 02 8883 0999
Fax : 02 8883 1199
E-mail : design@rjsinclair.com.au
Web : www.rjsinclair.com.au
Architectural - Structural - Project Management

Project
KOORAGANG SERVICE CENTRE
Part Lot 1 DP 1195444 - 130 CORMORANT ROAD Cnr. EGRET STREET
KOORAGANG NSW
FOR
SOVECHLES DEVELOPMENTS Pty Ltd
Drawing Title
POLLUTION CONTROL SCHEMATIC ELEVATION

ISSUED FOR AMENDED
DEVELOPMENT APPROVAL
NOT FOR CONSTRUCTION

Approved		Designed	
Date		Drawn	
5th May 2014		VP	
Scale		Checked	
NTS			
Project No.	Drawing No.	Amdt.	
13 - 065	PC - 02	DA-1	