



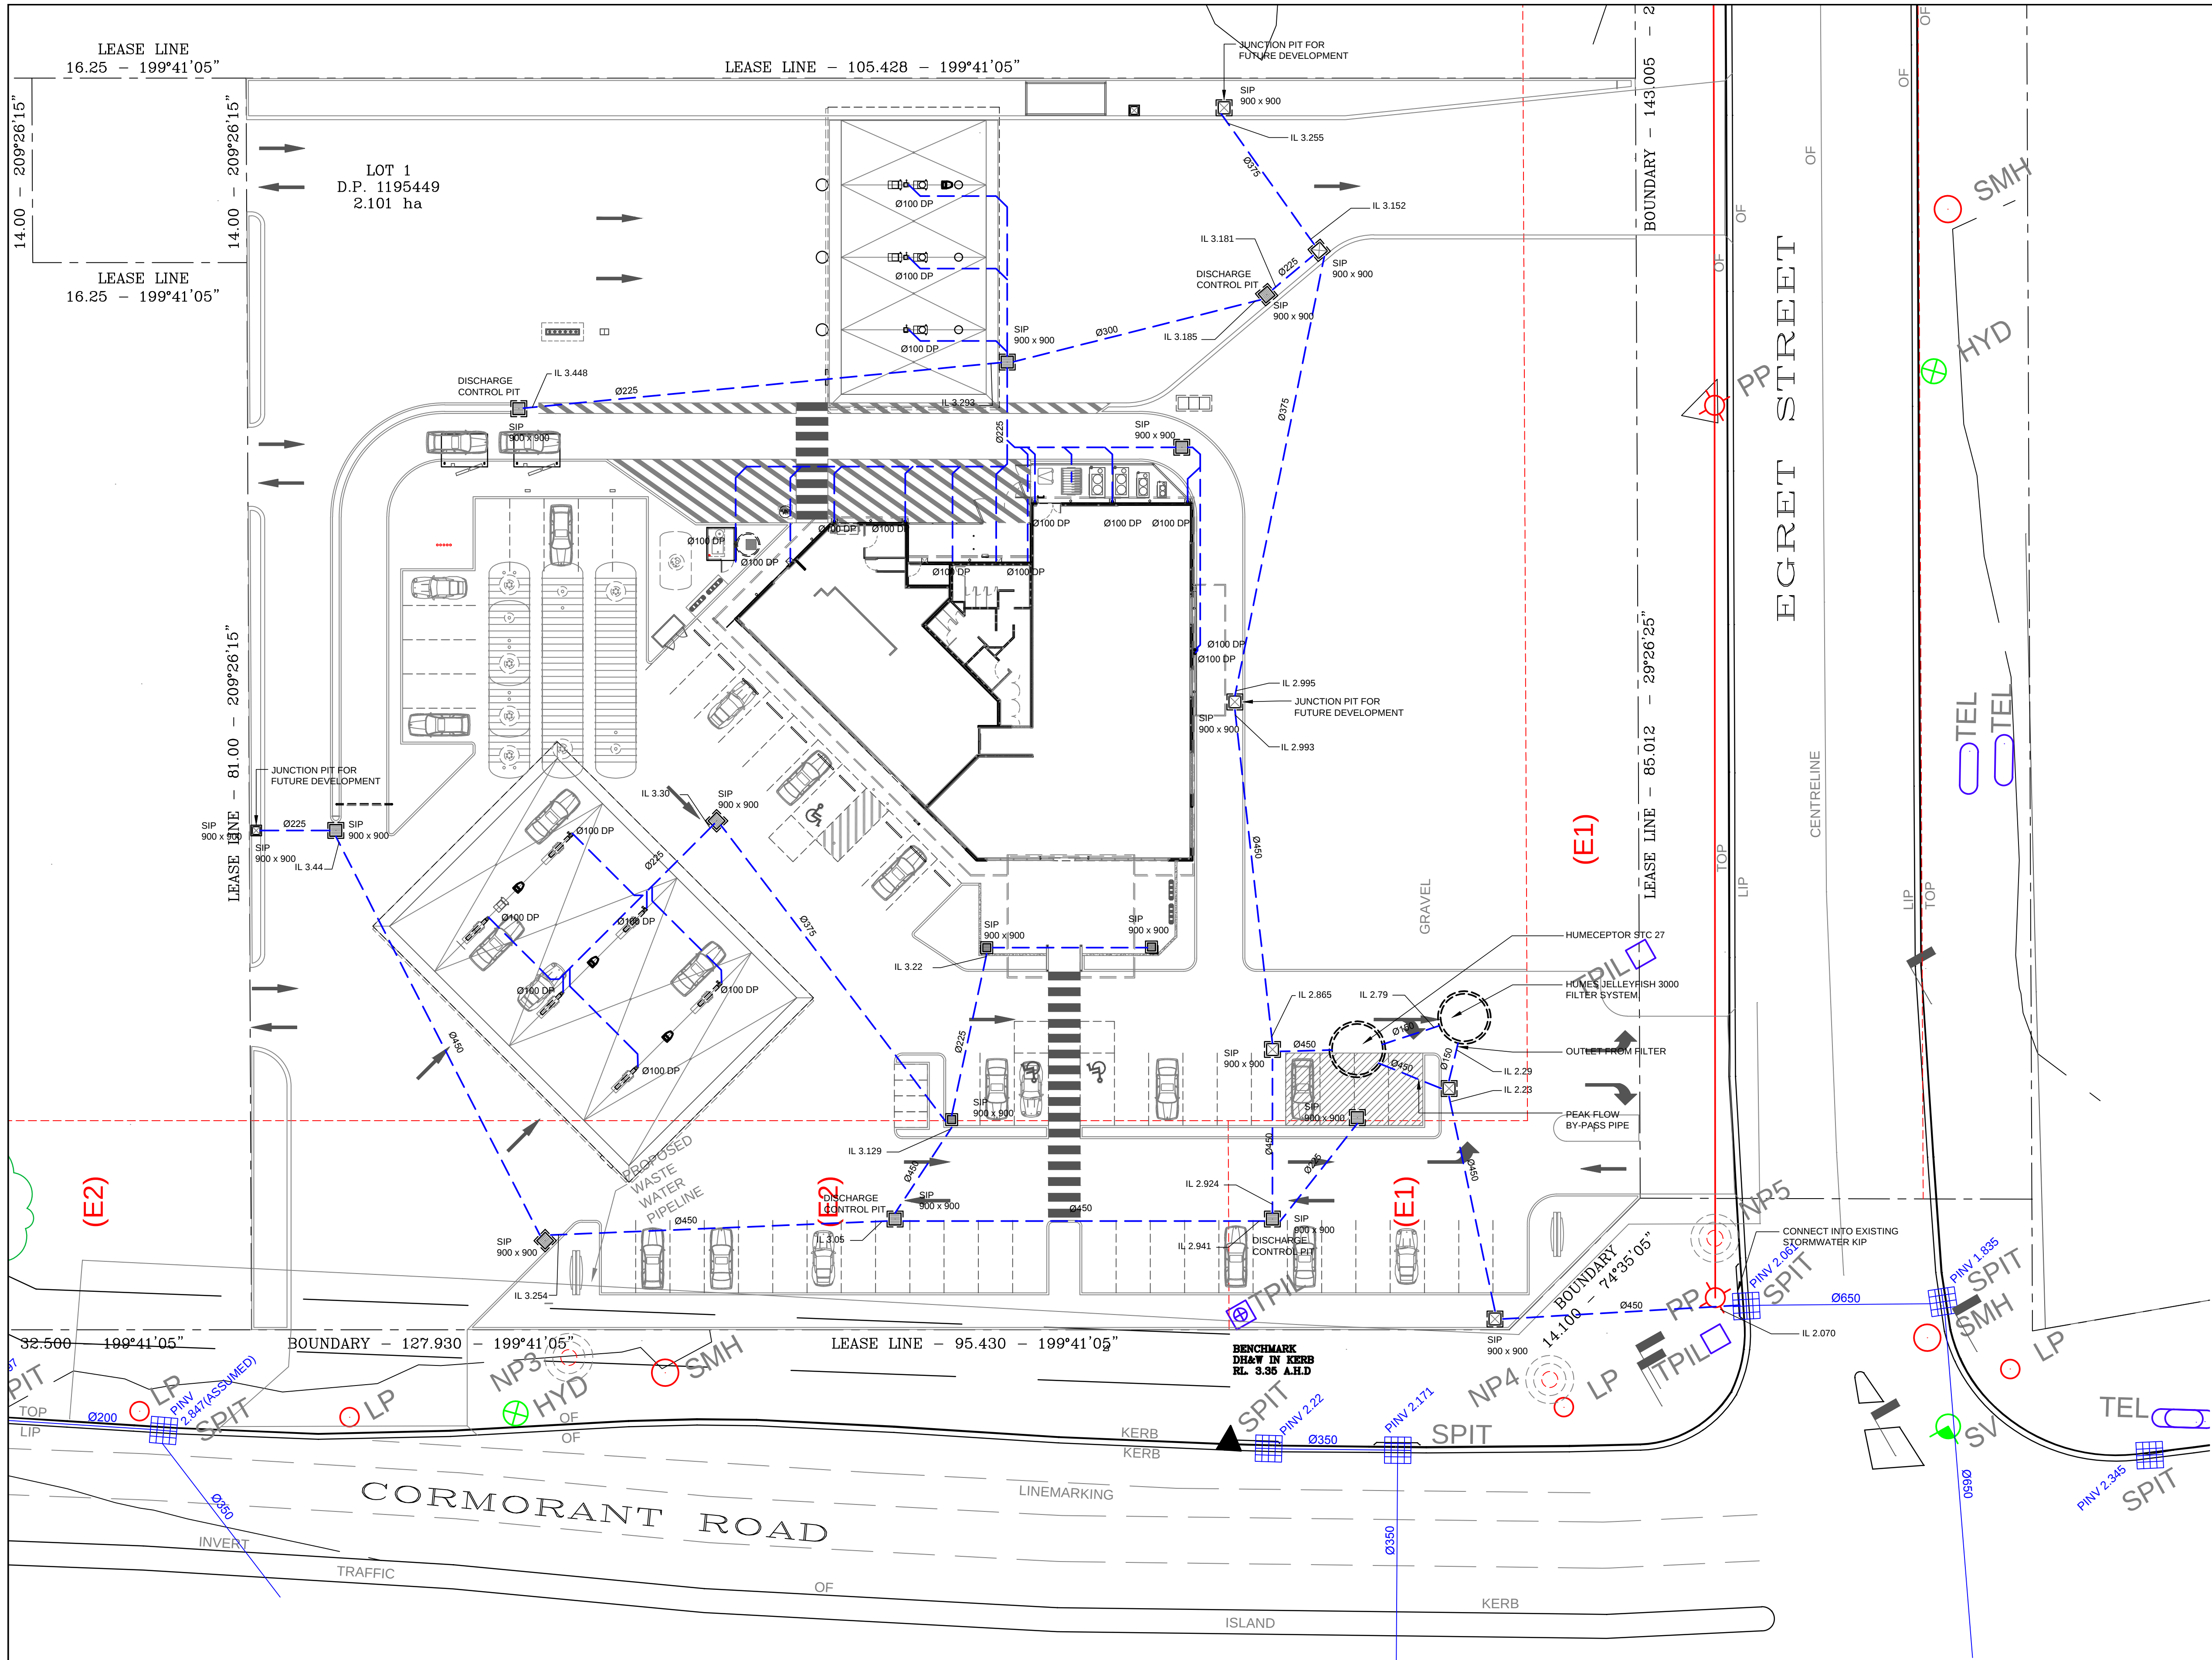


- NOTES:**
1. REFER TO DRAWING A - 02 FOR SITE LEVELS AND CONTOURS.
 2. ALL MATERIALS AND INSTALLATION SHALL BE IN ACCORDANCE WITH THE REQUIREMENTS OF THE RELEVANT AUTHORITIES, AUSTRALIAN STANDARDS AND CURRENT BCA.
 3. CONTRACTOR MUST VERIFY ALL DIMENSIONS ON SITE PRIOR TO COMMENCING ANY WORK.
 4. THIS IS AN INDICATIVE STORMWATER DRAINAGE PLAN ONLY. SITE SPECIFIC DESIGN AND SIZING OF DRAINS AND ASSOCIATED PITS IS TO BE UNDERTAKEN AT DETAILED DESIGN STAGE.
 5. ALL PITS AND COVERS TO PROPRIETARY PRECAST ITEMS, COVER LEVELS TO MATCH SURFACE.
 6. IT IS THE BUILDERS RESPONSIBILITY TO LAY ALL PIPES IN ACCORDANCE WITH ALL RELEVANT AUTHORITY REQUIREMENTS (EG. COUNCIL, EPA, AND TO AS 3500).
 7. SIZE OF STORMWATER PITS AND DRAINS TO BE CONFIRMED ON A SITE SPECIFIC BASIS DURING DESIGN STAGE.
 8. THE STORMWATER TREATMENT SYSTEM OF HUMECEPTOR AND HUME JELLY FISH HAS BEEN DESIGNED TO ALLOW FOR TOTAL DEVELOPMENT OF LOT 1, DP 1195449.
 9. JUNCTIONS PIT HAVE BEEN PROVIDED TO ALLOW CONNECTION OF FUTURE DEVELOPMENT.

SCALE BAR 1 : 1 On Original

No.	Amendment	By	Date
P1	PRELIMINARY ISSUE, NOT FOR CONSTRUCTION.	RJS	17.04.2014
P2	PRELIMINARY ISSUE FOR APPROVAL.	RJS	14.05.2014
P3	STORMWATER DRAINAGE PIPES & TAGS OUTLINED. PRELIMINARY ISSUE FOR APPROVAL. NOT FOR CONSTRUCTION.	RJS	20.05.2014
P4	PRELIMINARY ISSUE FOR FINAL APPROVAL BEFORE DA ISSUE. NOT FOR CONSTRUCTION.	VP	21.05.2014
DA-1	ISSUED FOR DEVELOPMENT APPROVAL ONLY. NOT FOR CONSTRUCTION.	VP	30.05.2014
P5	SITE LAYOUT UPDATED. ISSUED FOR APPROVAL ONLY. NOT FOR CONSTRUCTION.	VP	22.08.2014
DA-2	ISSUED FOR AMENDED DEVELOPMENT APPROVAL. NOT FOR CONSTRUCTION.	VP	17.12.2014

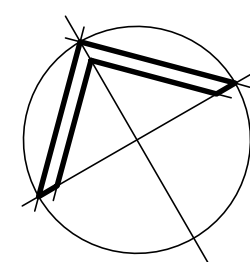

Member BUILDING DESIGNERS ASSOCIATION NSW
Accredited Building Designer: 6318
RBP No.: DP-AD 15329
QBSA Lic. No.: 1062914

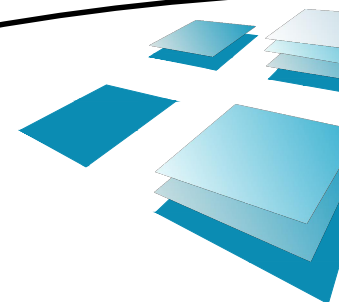

R.J. SINCLAIR Pty Ltd
Building Design

Office : Suite B111 - Sky City
NorWest Business Park
20 Lexington Drive
BELLA VISTA NSW 2153
Post : PO Box 503
ROUND CORNER NSW 2158
Phone : 02 8883 0999
Fax : 02 8883 1199
E-mail : design@rjsinclair.com.au
Web : www.rjsinclair.com.au
Architectural - Structural - Project Management

Project
KOORAGANG SERVICE CENTRE
Part Lot 1 DP 1195444 - 130 CORMORANT ROAD Cnr. EGRET STREET
KOORAGANG NSW
FOR
SOVECHLES DEVELOPMENTS Pty Ltd
Drawing Title
STORMWATER DRAINAGE PLAN

ISSUED FOR AMENDED
DEVELOPMENT APPROVAL
NOT FOR CONSTRUCTION

Approved	Designed
Date	17TH APRIL 2014
Scale	1:250 @ A1 1:500 @ A3
Project No.	13 - 065
Drawing No.	SD - 01
Amdt.	DA-2