



NOTE:
 PROVIDE APPROPRIATE SIGNAGE ADJACENT UNDERGROUND TANKS:
 'NO UNAUTHORISED ENTRY. CONFINED SPACE WORK PERMIT
 REQUIRED FOR TANK ACCESS. NO UNAUTHORISED ENTRY.'

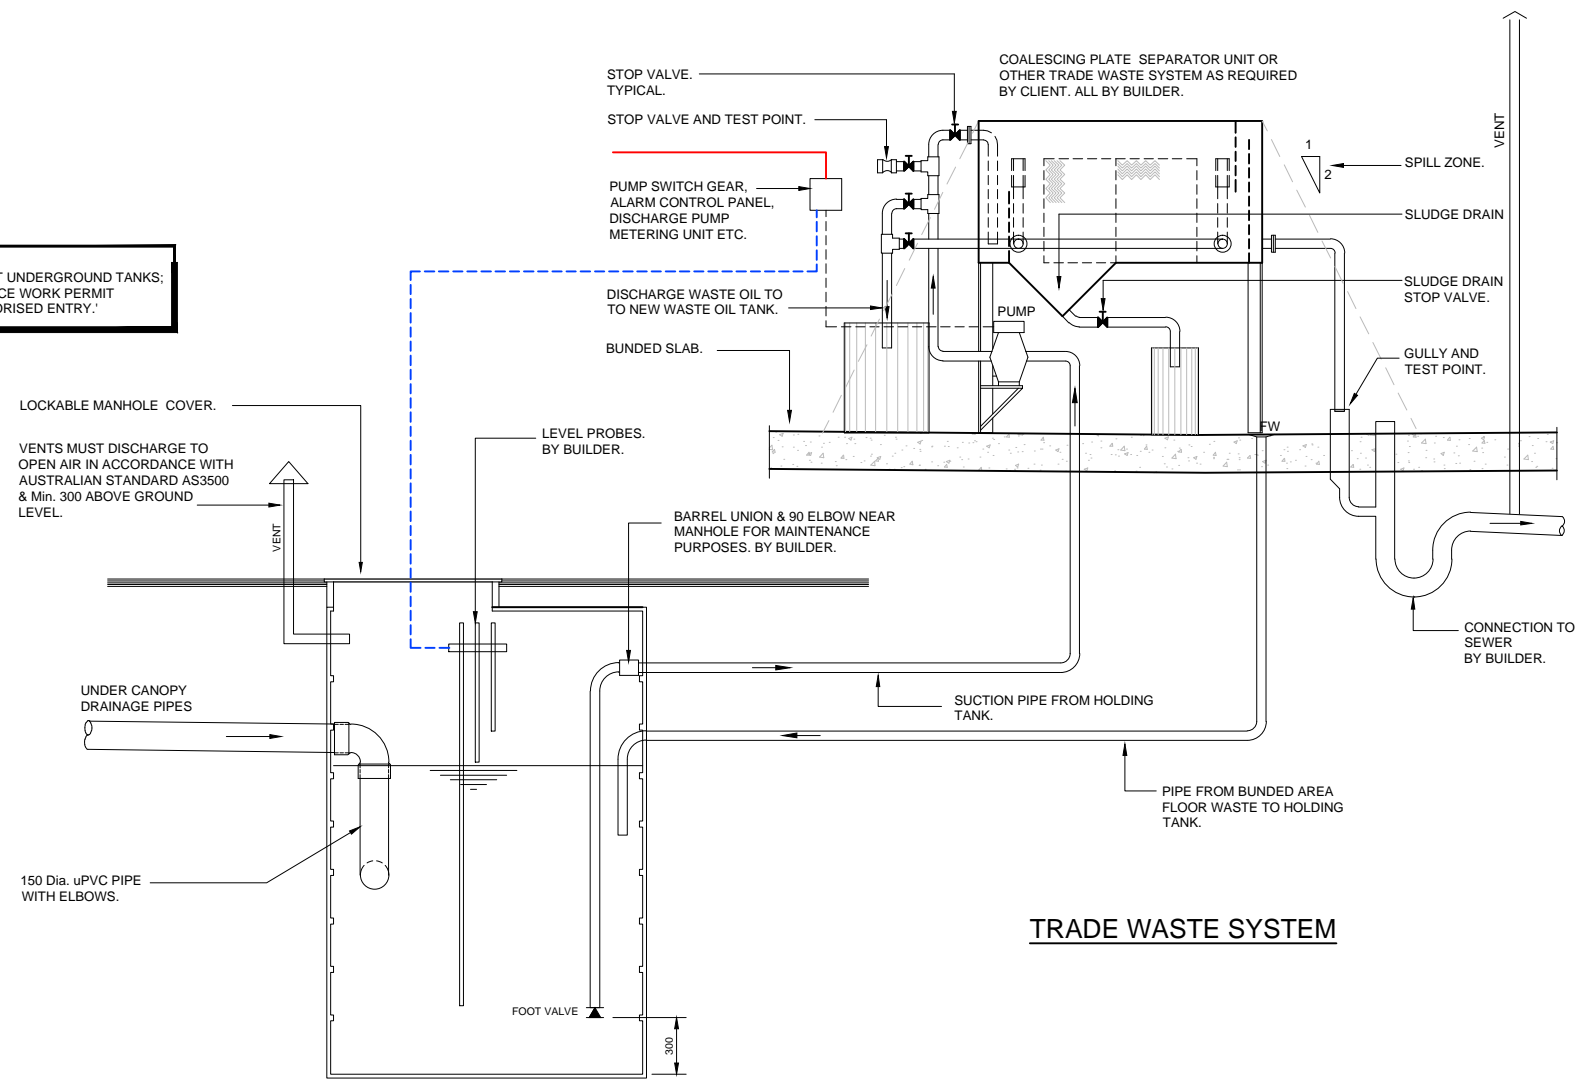

OIL/WATER HOLDING TANK
 3000 LITRES Nom. STORAGE BELOW
 WATER LEVEL


SCHEMATIC ELEVATION OF POLLUTION CONTROL SYSTEM

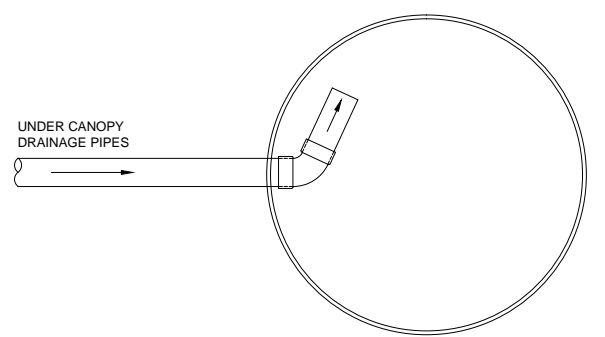

OIL/WATER HOLDING TANK

NOTES

 
1. ALL TANKS, EQUIPMENT ETC. IS TO BE SUPPLIED AND INSTALLED BY THE BUILDING CONTRACTOR UNLESS NOTED OTHERWISE.
2. TANKS ARE TO BE FIBRE GLASS CONSTRUCTION, AND FITTED WITH LADDER RUNGS IN ACCORDANCE WITH AUSTRALIAN STANDARDS, FOR CLEANOUT PURPOSES. COVER IS TO BE FITTED WITH HINGES AND CHILDPROOF LOCKING MECHANISM. ALL STEEL WORK IS TO BE HOT DIPPED GALV.
3. TANK TO HAVE THE FOLLOWING WORKING CAPACITY VOLUMES:
SEWER DISCHARGE PIT - 3000 LITRES STORAGE BELOW WATER LEVEL.
4. PROVIDE ONE COALESCING PLATE SEPARATOR OR OTHER TRADE WASTE SYSTEM, DEDICATED TO THE UNDERCANOPY DRAINAGE INSTALLATION. THIS SEPARATOR, COMBINED WITH THE HOLDING TANK PROVIDES POLLUTION CONTROL MEASURES FOR THE POTENTIAL OIL SPILL EFFLUENT.
5. HIGH LEVEL ALARM SYSTEM TO BE INSTALLED SO THAT VISUAL AND AUDIO ALARMS ARE ACTIVATED. PROVIDE VISUAL ALARM (AUDIO AND VISUAL) ON EXTERNAL WALL OF CONSOLE. PROVIDE ALARM PANEL TO INTERNAL STORE/PLANTROOM WHERE FUELS AND COMMS ARE LOCATED. PROVIDE ALL NECESSARY CONDUITS AND WIRING AS REQUIRED BY ALARM MANUFACTURER. FINAL LOCATION TO BE CONFIRMED ON SITE BY SHELL & CEXP.
6. PROVIDE VAPOUR MONITORING TO HOLDING TANK IN ACCORDANCE WITH SHELL STANDARDS AND MANUFACTURER'S SPECIFICATIONS.



ISSUED FOR DEVELOPMENT APPROVAL
 NOT FOR CONSTRUCTION

No.	Amendment	By	Date
P1	PRELIMINARY ISSUE. NOT FOR CONSTRUCTION.	VP	07.05.2014
P2	PRELIMINARY ISSUE FOR APPROVAL.	VP	14.05.2014
P3	PRELIMINARY ISSUE FOR FINAL APPROVAL BEFORE DA ISSUE. NOT FOR CONSTRUCTION.	VP	21.05.2014
DA-1	ISSUED FOR DEVELOPMENT APPROVAL ONLY. NOT FOR CONSTRUCTION.	VP	30.05.2014

Member: BUILDING DESIGNERS
 ASSOCIATION NSW
 100 WILSON ROAD SYDNEY
 NSW 1570
 QBISA Lic. No.: 1082914

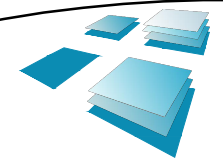

R.J. SINCLAIR Pty Ltd
 Building Design
 Office: Suite B111 - Sky City
 NorWest Business Park
 20 Lexington Drive
 BELLA VISTA NSW 2153
 Post: PO Box 503
 ROUND CORNER NSW 2158
 Phone: 02 8883 0999
 Fax: 02 8883 1199
 E-mail: design@rjsinclair.com.au
 Web: www.rjsinclair.com.au
 Architectural - Structural - Project Management

Project
KOORAGANG SERVICE CENTRE
 Cnr. CORMORANT ROAD & EGRET STREET
KOORAGANG NSW
 FOR
SOVECHLES DEVELOPMENTS Pty Ltd
 Drawing Title
 POLLUTION CONTROL SCHEMATIC ELEVATION

Approved	Designed
Date 5th May 2014	Drawn VP
Scale NTS	Checked
Project No. 13 - 065	Drawing No. PC - 02
	Amdt. DA-1