



ISSUE	DATE	FOR
A	10/11/2021	SSDA ISSUE
B	14/04/2022	SSDA UPDATES

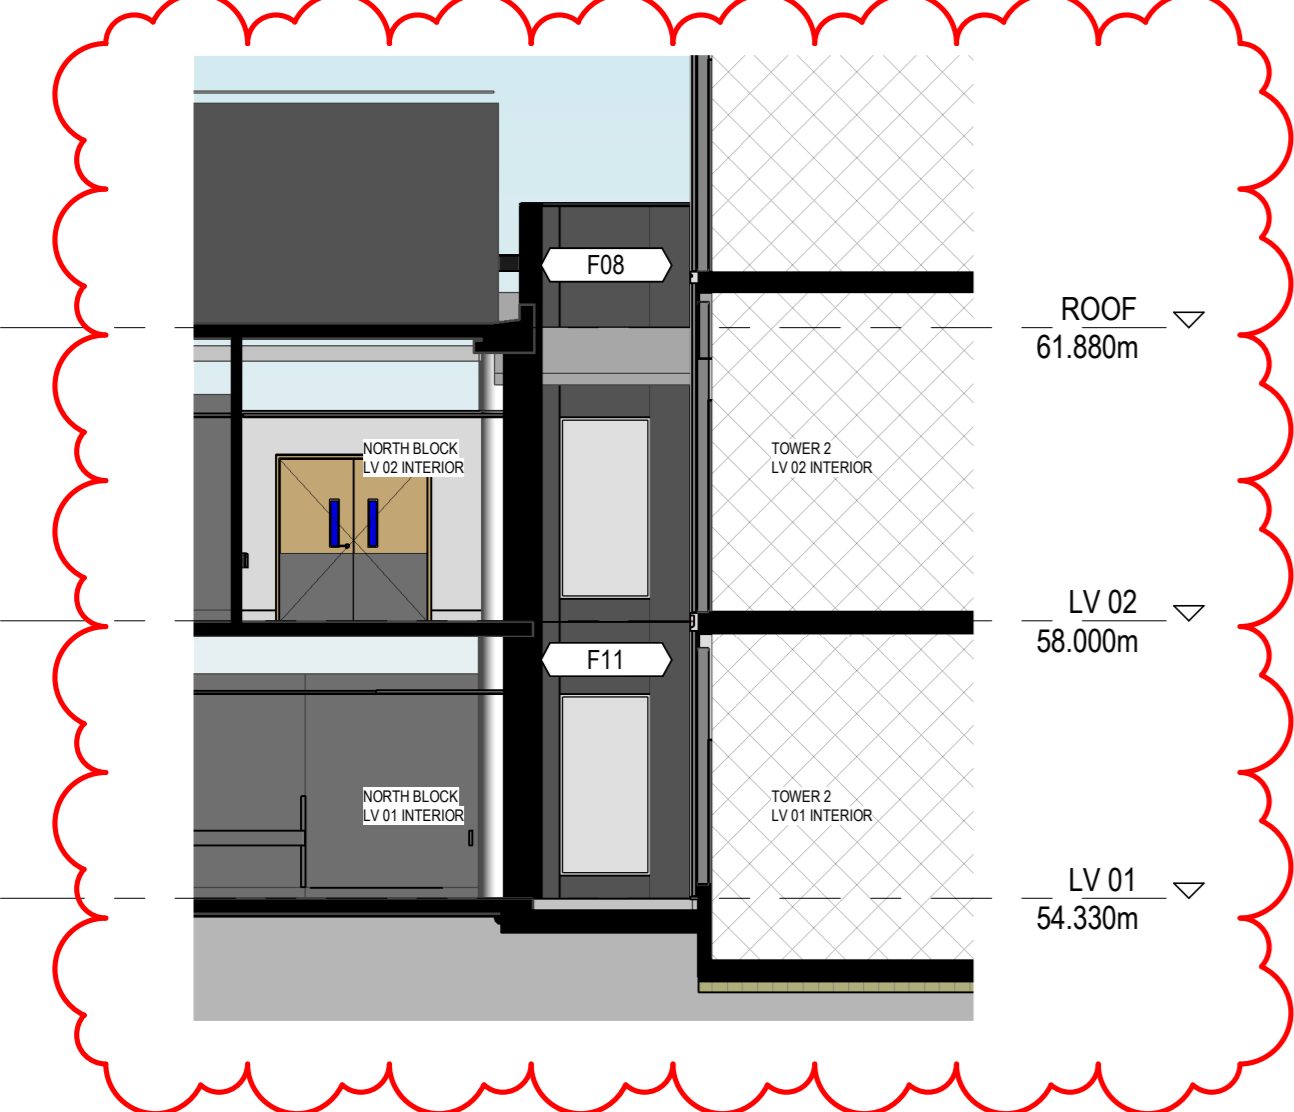

1 NORTH BLOCK - EAST ELEVATION

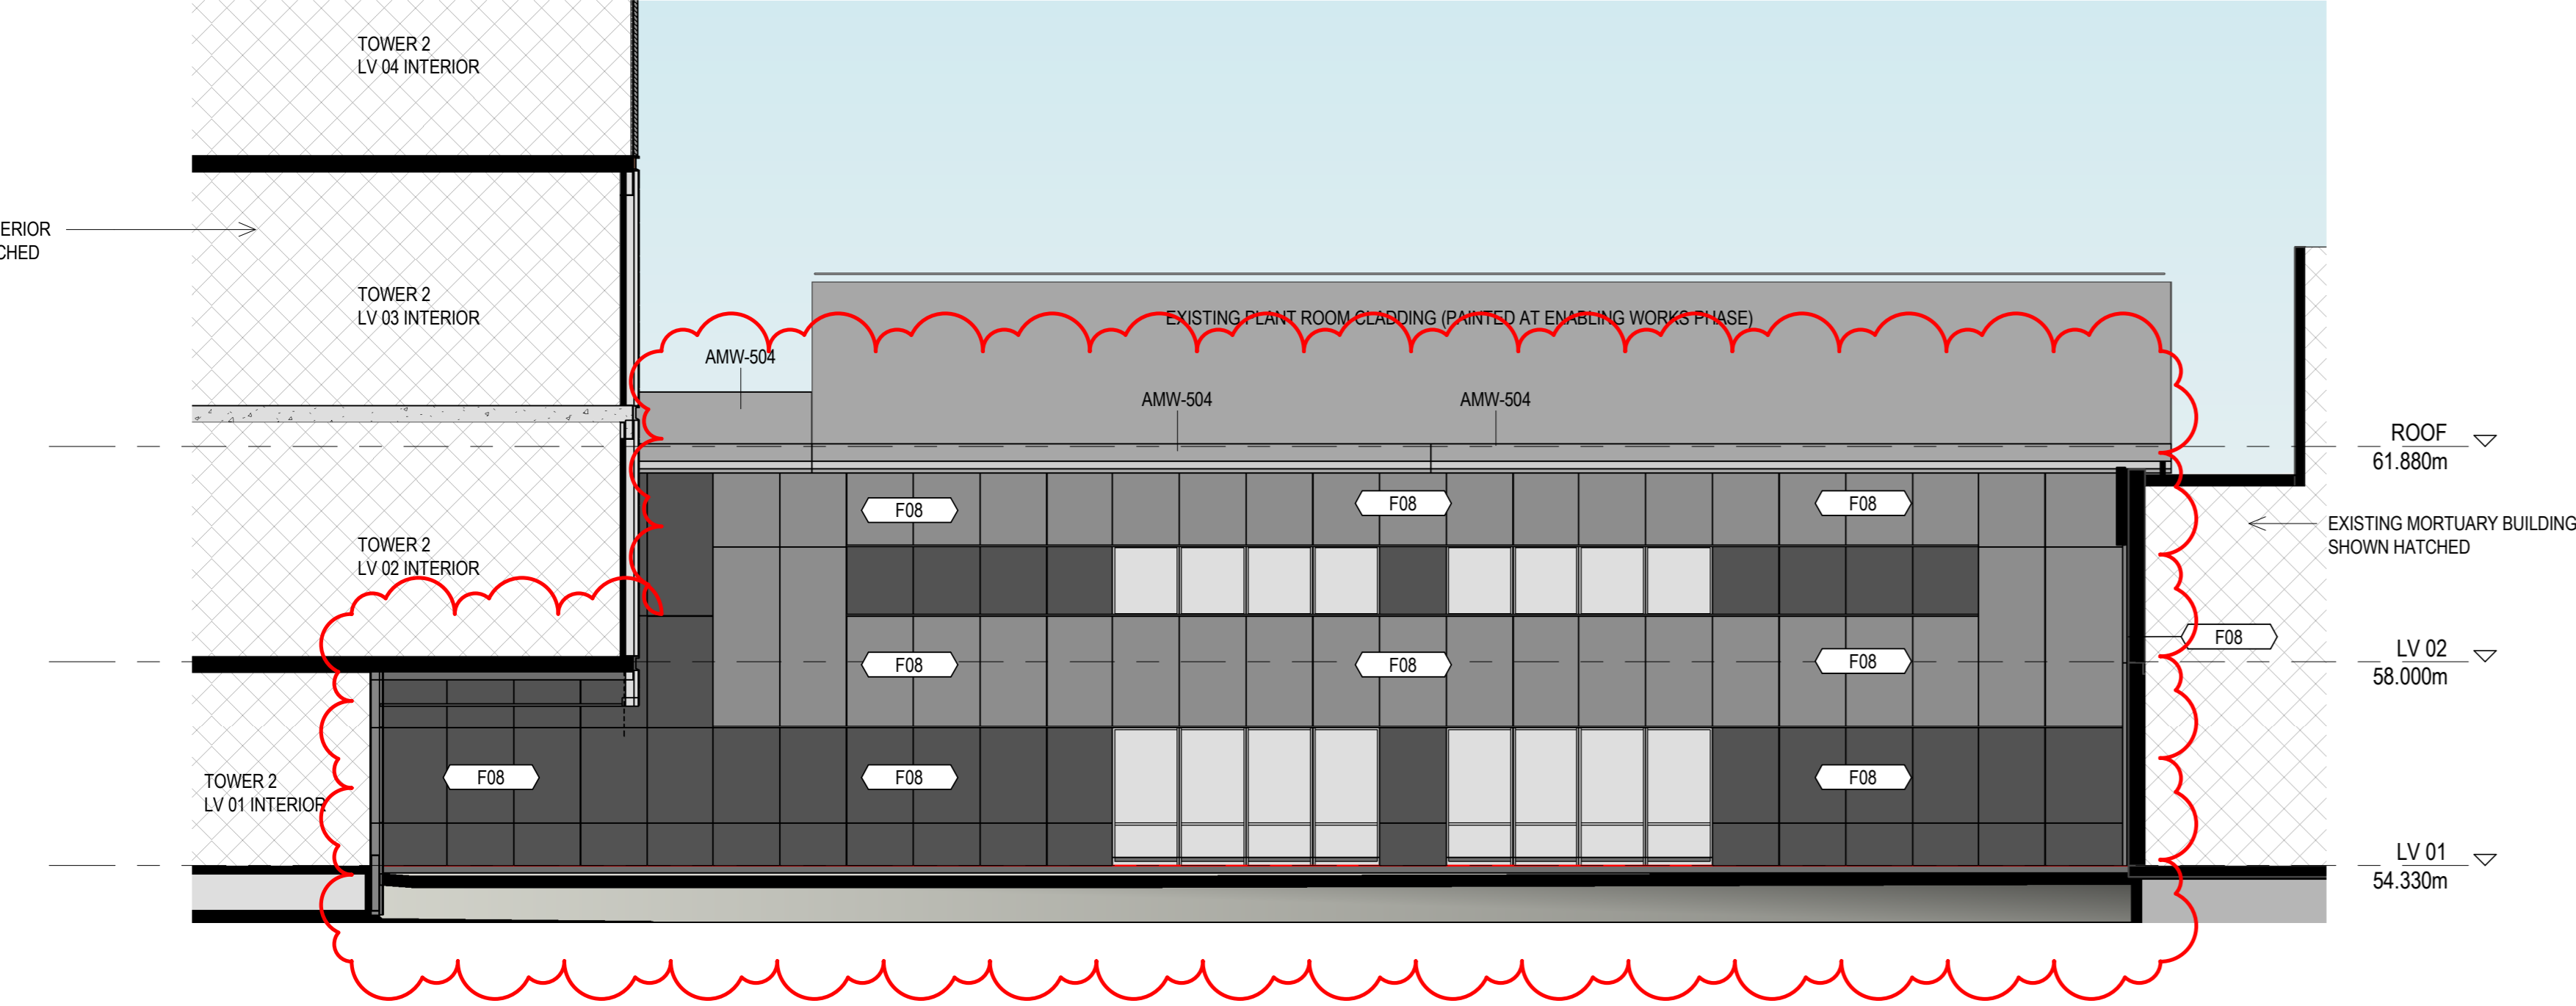

2 NORTH BLOCK - NORTH ELEVATION 1



3 NORTH BLOCK - NORTH ELEVATION 2



PROJECT MANAGERS
CBRE
TEL 02 9333 3333

ARCHITECT
BVN Architecture
TEL 02 8297 7200

STRUCTURE / CIVIL
ACOR
TEL 02 9438 5098

MECHANICAL
ARUP
TEL 02 9320 9320

ELECTRICAL / OCAMS
JHA
TEL 02 9437 1000



HYDRAULIC
ARUP
TEL 02 9320 9320

FIRE ENGINEERING
ARUP
TEL 02 9320 9320

LANDSCAPE
ARCADIA
TEL 02 8571 2900

BCA / DDA
BLACKETT MAGUIRE + GOLDSMITH
TEL 02 9211 7777

PROJECT
NEPEAN HOSPITAL - STAGE 2
DERBY ST
KINGSWOOD NSW 2747
NEPEAN
BVN PROJECT NUMBER
1903020.000
DRAWING KEY

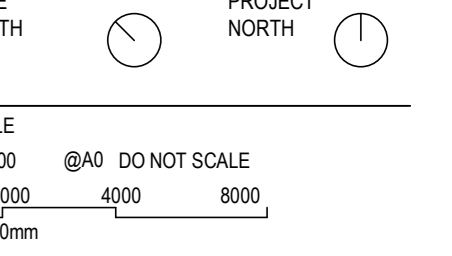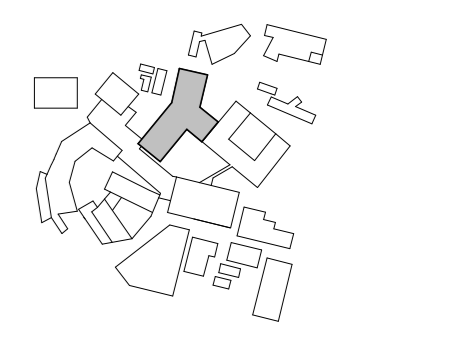

DRAWN BY: Author
CHECKED BY: Checker

DESIGNED BY: Designer
APPROVED BY: Approver

STATUS
SSDA
DRAWING

LINK ELEVATIONS	
DRAWING NUMBER	ISSUE
NHR-BVN-DRW-ARC-TB2-A0-505	B