


COPYRIGHT
 COPYRIGHT OF DESIGNS SHOWN HEREON IS
 RETAINED BY ARROW CONSULTING
 ENGINEERS. AUTHORITY IS REQUIRED FOR
 ANY REPRODUCTION.

REV	ISSUE	DATE
1	PRELIMINARY ISSUE	25/01/19
2	PRELIMINARY ISSUE	21/02/19

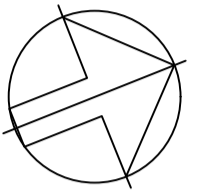

CLIENT
 SGCH

ARCHITECT

DKO

ARROW


CONSULTING
 ENGINEERS

86 REDFERN STREET,
 REDFERN NSW 2016
 PHONE: 02 9318 1431
 E-MAIL: admin@arrowce.com.au

PROJECT
 11 GIBBONS STREET
 REDFERN
 NSW 2016

TITLE
 MECHANICAL SERVICES
 ROOF
 AIR CONDITIONING AND
 VENTILATION LAYOUT

DRAWN	DESIGN	CHECK	DWG No.
E.O.	S.C.	S.C.	M06
JOB No.		SCALE	REV
NS18138		1:100@A1	2

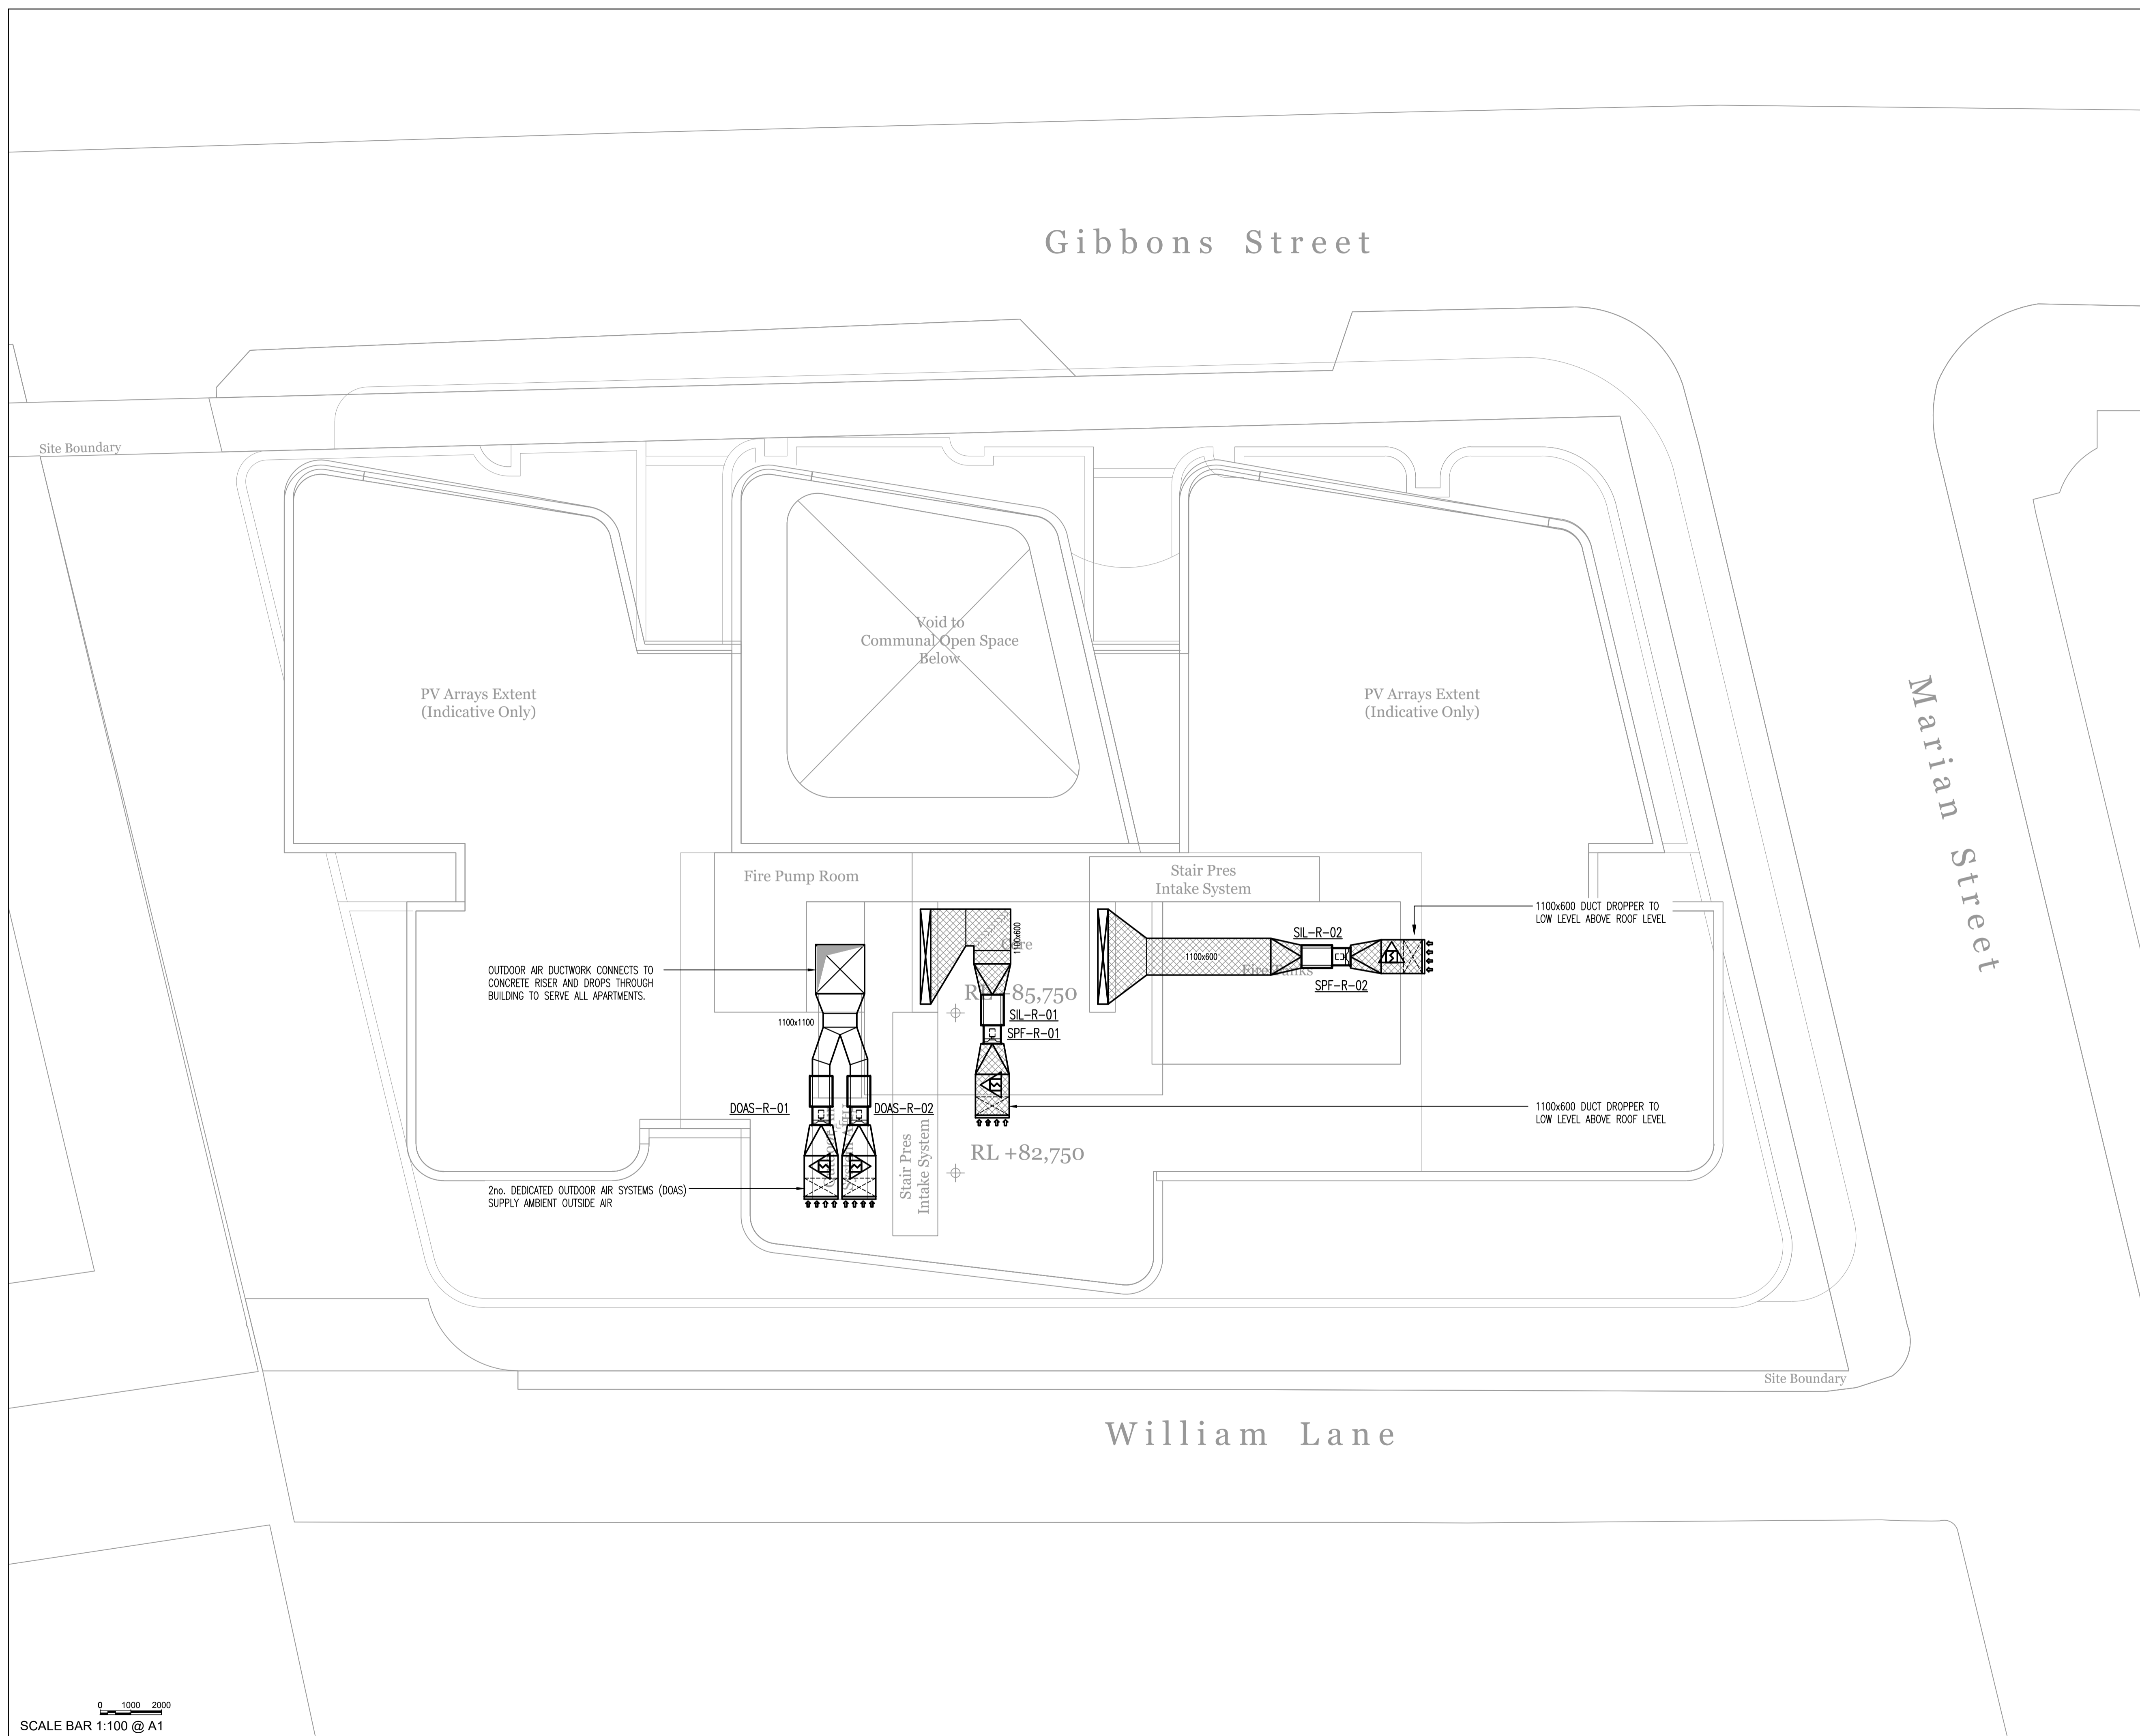

SCALE BAR 1:100 @ A1