
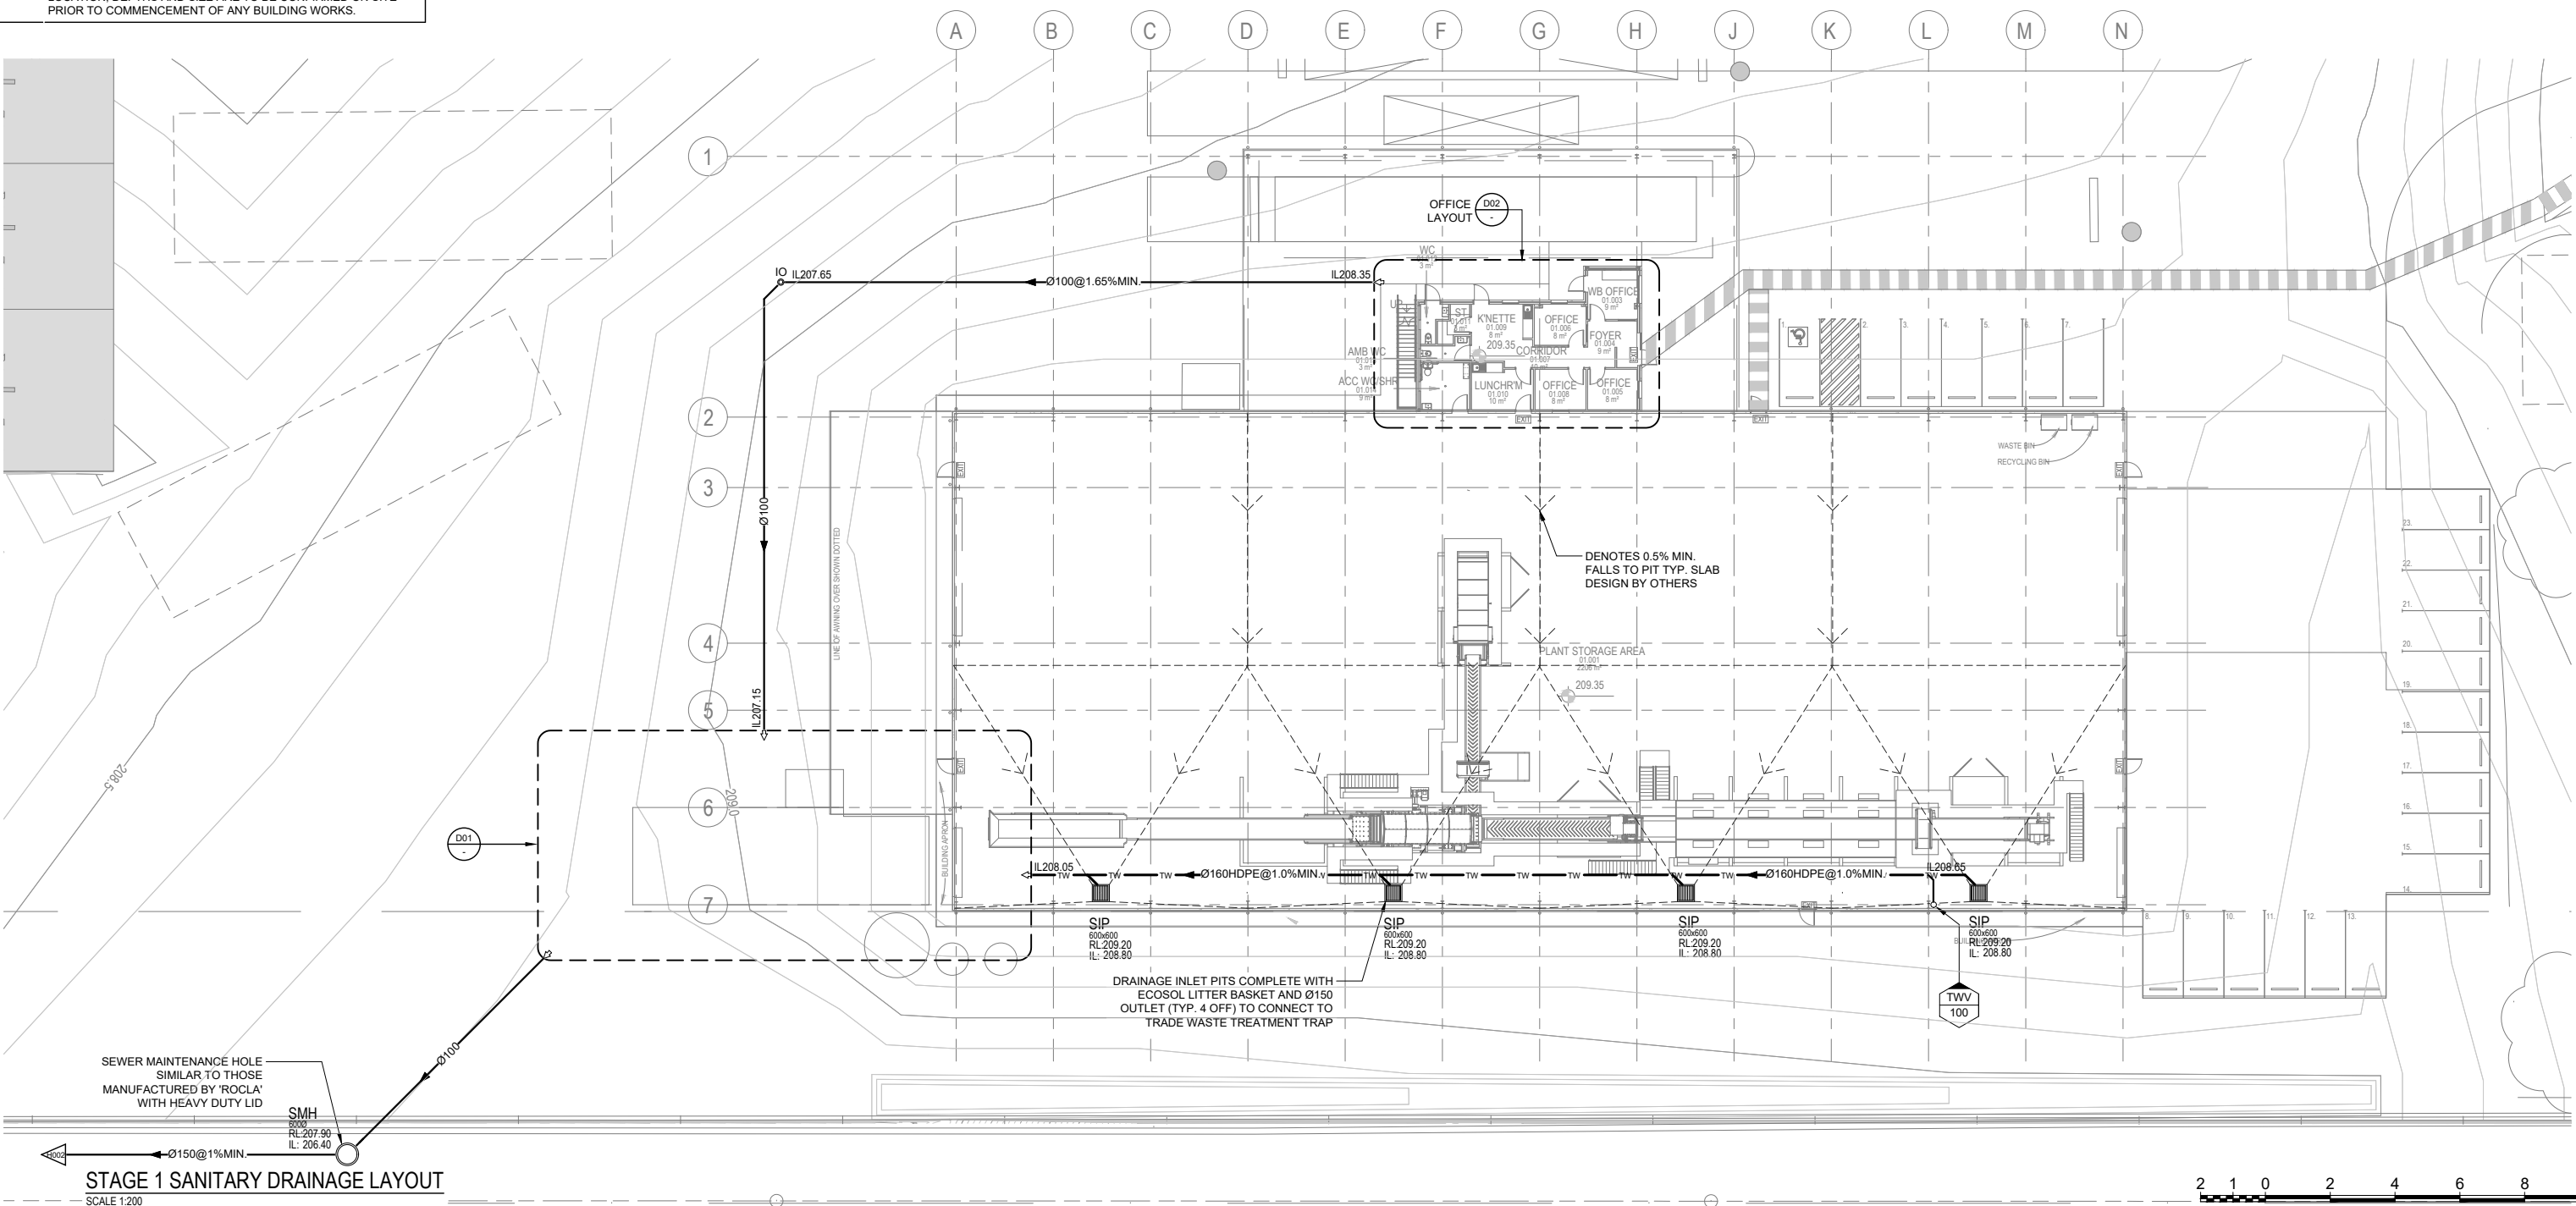
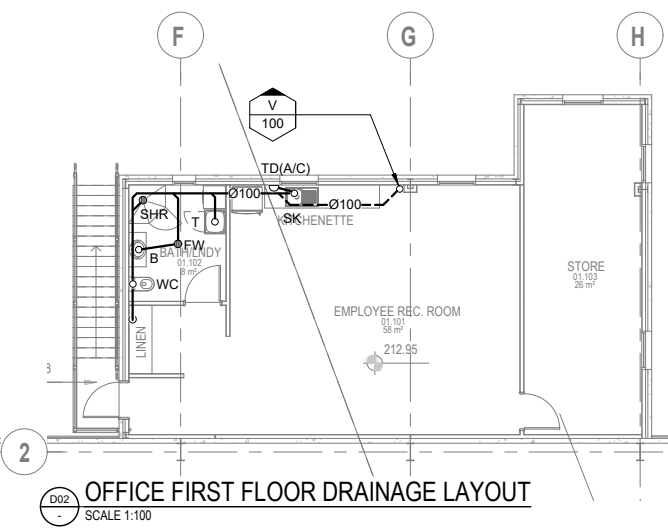
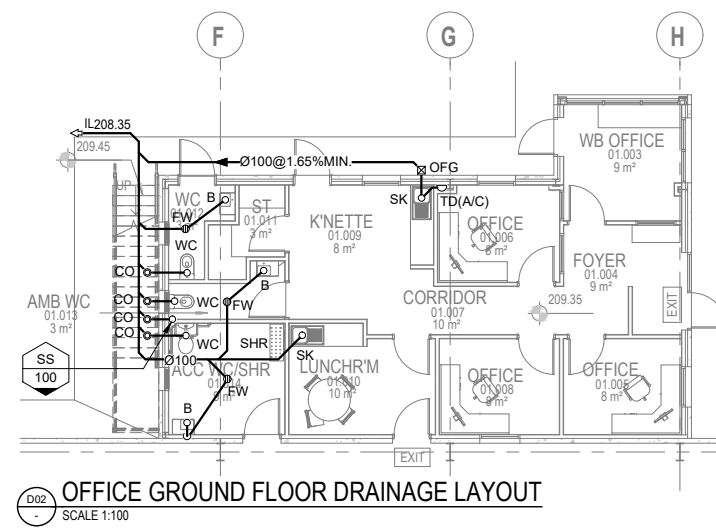


NOTES

- N1 ALLOW TO CONTACT AUTHORITIES AND SEAL OFF ALL DISUSED CONNECTIONS AT JUNCTIONS TO THE MAINS. ALL TO C.C.C. REQUIREMENTS.
- N2 TOP OF GULLIES TO BE 75mm ABOVE FGL AND 150mm BELOW FFL. REFER TO DETAIL ON SHEET H300.
- N3 ALL TRADE WASTE PIPEWORK SHALL BE FUSION WELDED HDPE.
- N4 REFER TO CIVIL ENGINEERS DRAWINGS FOR EXACT DEPTH & LOCATION OF STORMWATER TANKS, PITS & PIPES. COORDINATE WITH CIVIL CONTRACTOR FOR FINAL LOCATION OF PIPEWORK AND EQUIPMENT.
- N5 ALL VENTS TO TERMINATE TO ATMOSPHERE TO AS3500.2. (MIN. 150mm ABOVE ROOF LEVEL, MIN.3m HORIZONTALLY AND VERTICALLY FROM TRAFFICABLE ROOF DECK AND MIN. 5m FROM AN AIR INTAKE)
- N6 EXACT ROUTE OF NEW PIPEWORK TO BE COORDINATED WITH EXISTING SERVICES & STRUCTURES ON SITE.
- N7 ALL WORKS TO COMPLY TO AS 3500 AND C.C.C. REQUIREMENTS.
- N8 REFER TO ARCHITECTS DRAWINGS FOR DETAILS OF ALL SANITARY FIXTURES AND TAPWARE.
- N9 EXISTING SERVICES ARE SHOWN FOR INDICATION ONLY. EXACT LOCATION, DEPTHS AND SIZE ARE TO BE CONFIRMED ON SITE PRIOR TO COMMENCEMENT OF ANY BUILDING WORKS.

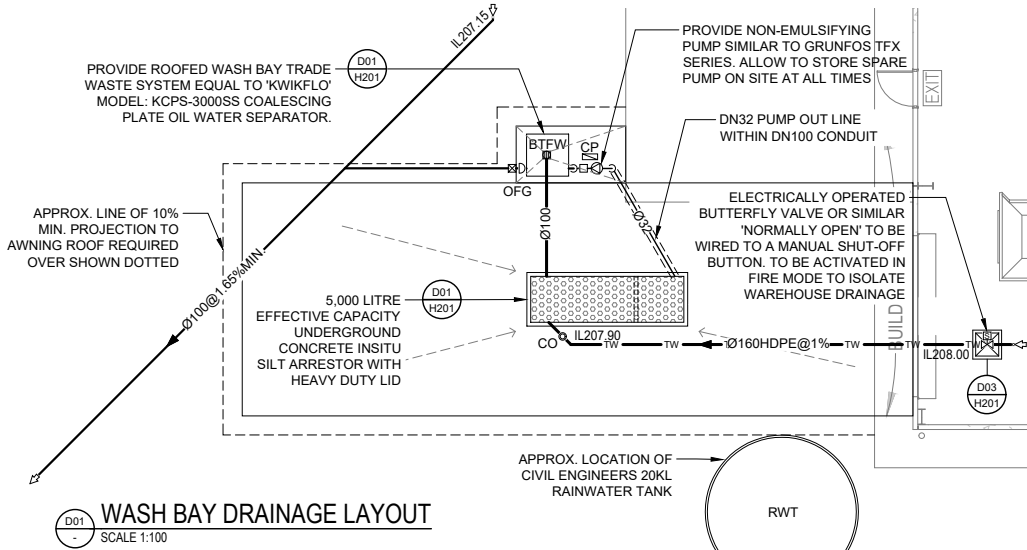

STAGE 1 SANITARY DRAINAGE LAYOUT
SCALE 1:200

2 1 0 2 4 6 8 10
SCALE OF METRES (1:100 AT A1 SHEET BEFORE REDUCTION) A1

REVISION	DESCRIPTION	DATE	VERSION
A	PRELIMINARY ISSUE	16.01.20	
B	TENDER ISSUE	03.02.20	

FOR TENDER

SCALE
4 2 0 4 8 12 16 20
SCALE OF METRES (1:200 AT A1 SHEET BEFORE REDUCTION)

RGH CONSULTING GROUP
Multi-discipline Engineering

Postal Address: PO Box 3197, Tuggerah NSW 2259
Central Coast Office: Unit 1, 3 Teamster Close, Tuggerah NSW 2259
PH 02 4353 9032
Newcastle Office: Unit 5, 166 Hannell Street, Maryville NSW 2293
Sydney Office: PH 02 4058 2137
PH 02 8524 0583
www.rghconsulting.com.au

PROJECT MANAGER

RAYBAL CONSTRUCTIONS

CLIENT **KARIONG SAND & SOIL SUPPLIES**

ADDRESS **90 GINDURRA ROAD, SOMERSBY - LOT 4, DP227279**

PROJECT **PROPOSED KARIONG SAND & SOIL SUPPLIES FACILITY - SSD8660**

DRAWING TITLE **HYDRAULIC SERVICES STAGE 1 SANITARY & TRADE WASTE LAYOUT**

SCALE	SHOWN	INT.	SHEET
DRAWN	A.G.		H101
DESIGNED	S.G.T.		
CHECKED	B.T.R.		
DATE	DECEMBER 2019		REV B
JOB NUMBER	20180015A		