


LEGEND

- STRUCTURE
- STRUCTURE UNDER

- MR1 STAIR 1 - PRESSURISATION RISER
- MR2 STAIR 2 - PRESSURISATION RISER
- MR3 STAIR RELIEF RISER
- MP4 WATER-COOLED CONDENSERS PLANTROOM (RES)
- MR5 REFRIGERANT PIPER WORK RISER
- MR6 RETAIL KITCHEN EXHAUST
- MP7 LOADING DOCK EXHAUST
- MP8 CAR LIFT EXHAUST
- MP9 FIRE PUMP FLUE
- GE GARBAGE EXHASUST
- WE WASTE EXHASUST
- ER1 MAIN ELECTRICAL RISER
- ER2 MAIN COMMUNICATIONS RISER
- FP2 FIRE BOOSTER ASSEMBLY
- FP4 STAIR 1 - FIRE SERVICES RISER
- FP5 STAIR 2 - FIRE SERVICES RISER
- FCR FIRE CONTROL ROOM
- HP3 COLD WATER METER ROOM
- HP6 GREASER ARRESTOR
- HP7 HYDRAULIC SANITARY RISER
- HP8 HYDRAULIC SERVICES RISER 1
- HP9 HYDRAULIC SERVICES RISER 2
- R RESIDENTIAL LIFT
- G GOODS LIFT
- ERL EXISTING RELATIVE LEVEL
- RL (PROPOSED) RELATIVE LEVEL

- S STORAGE
- L LAUNDRY
- P PANTRY
- F FRIDGE

- MRV SWEEP PATH IN
- MRV SWEEP PATH OUT

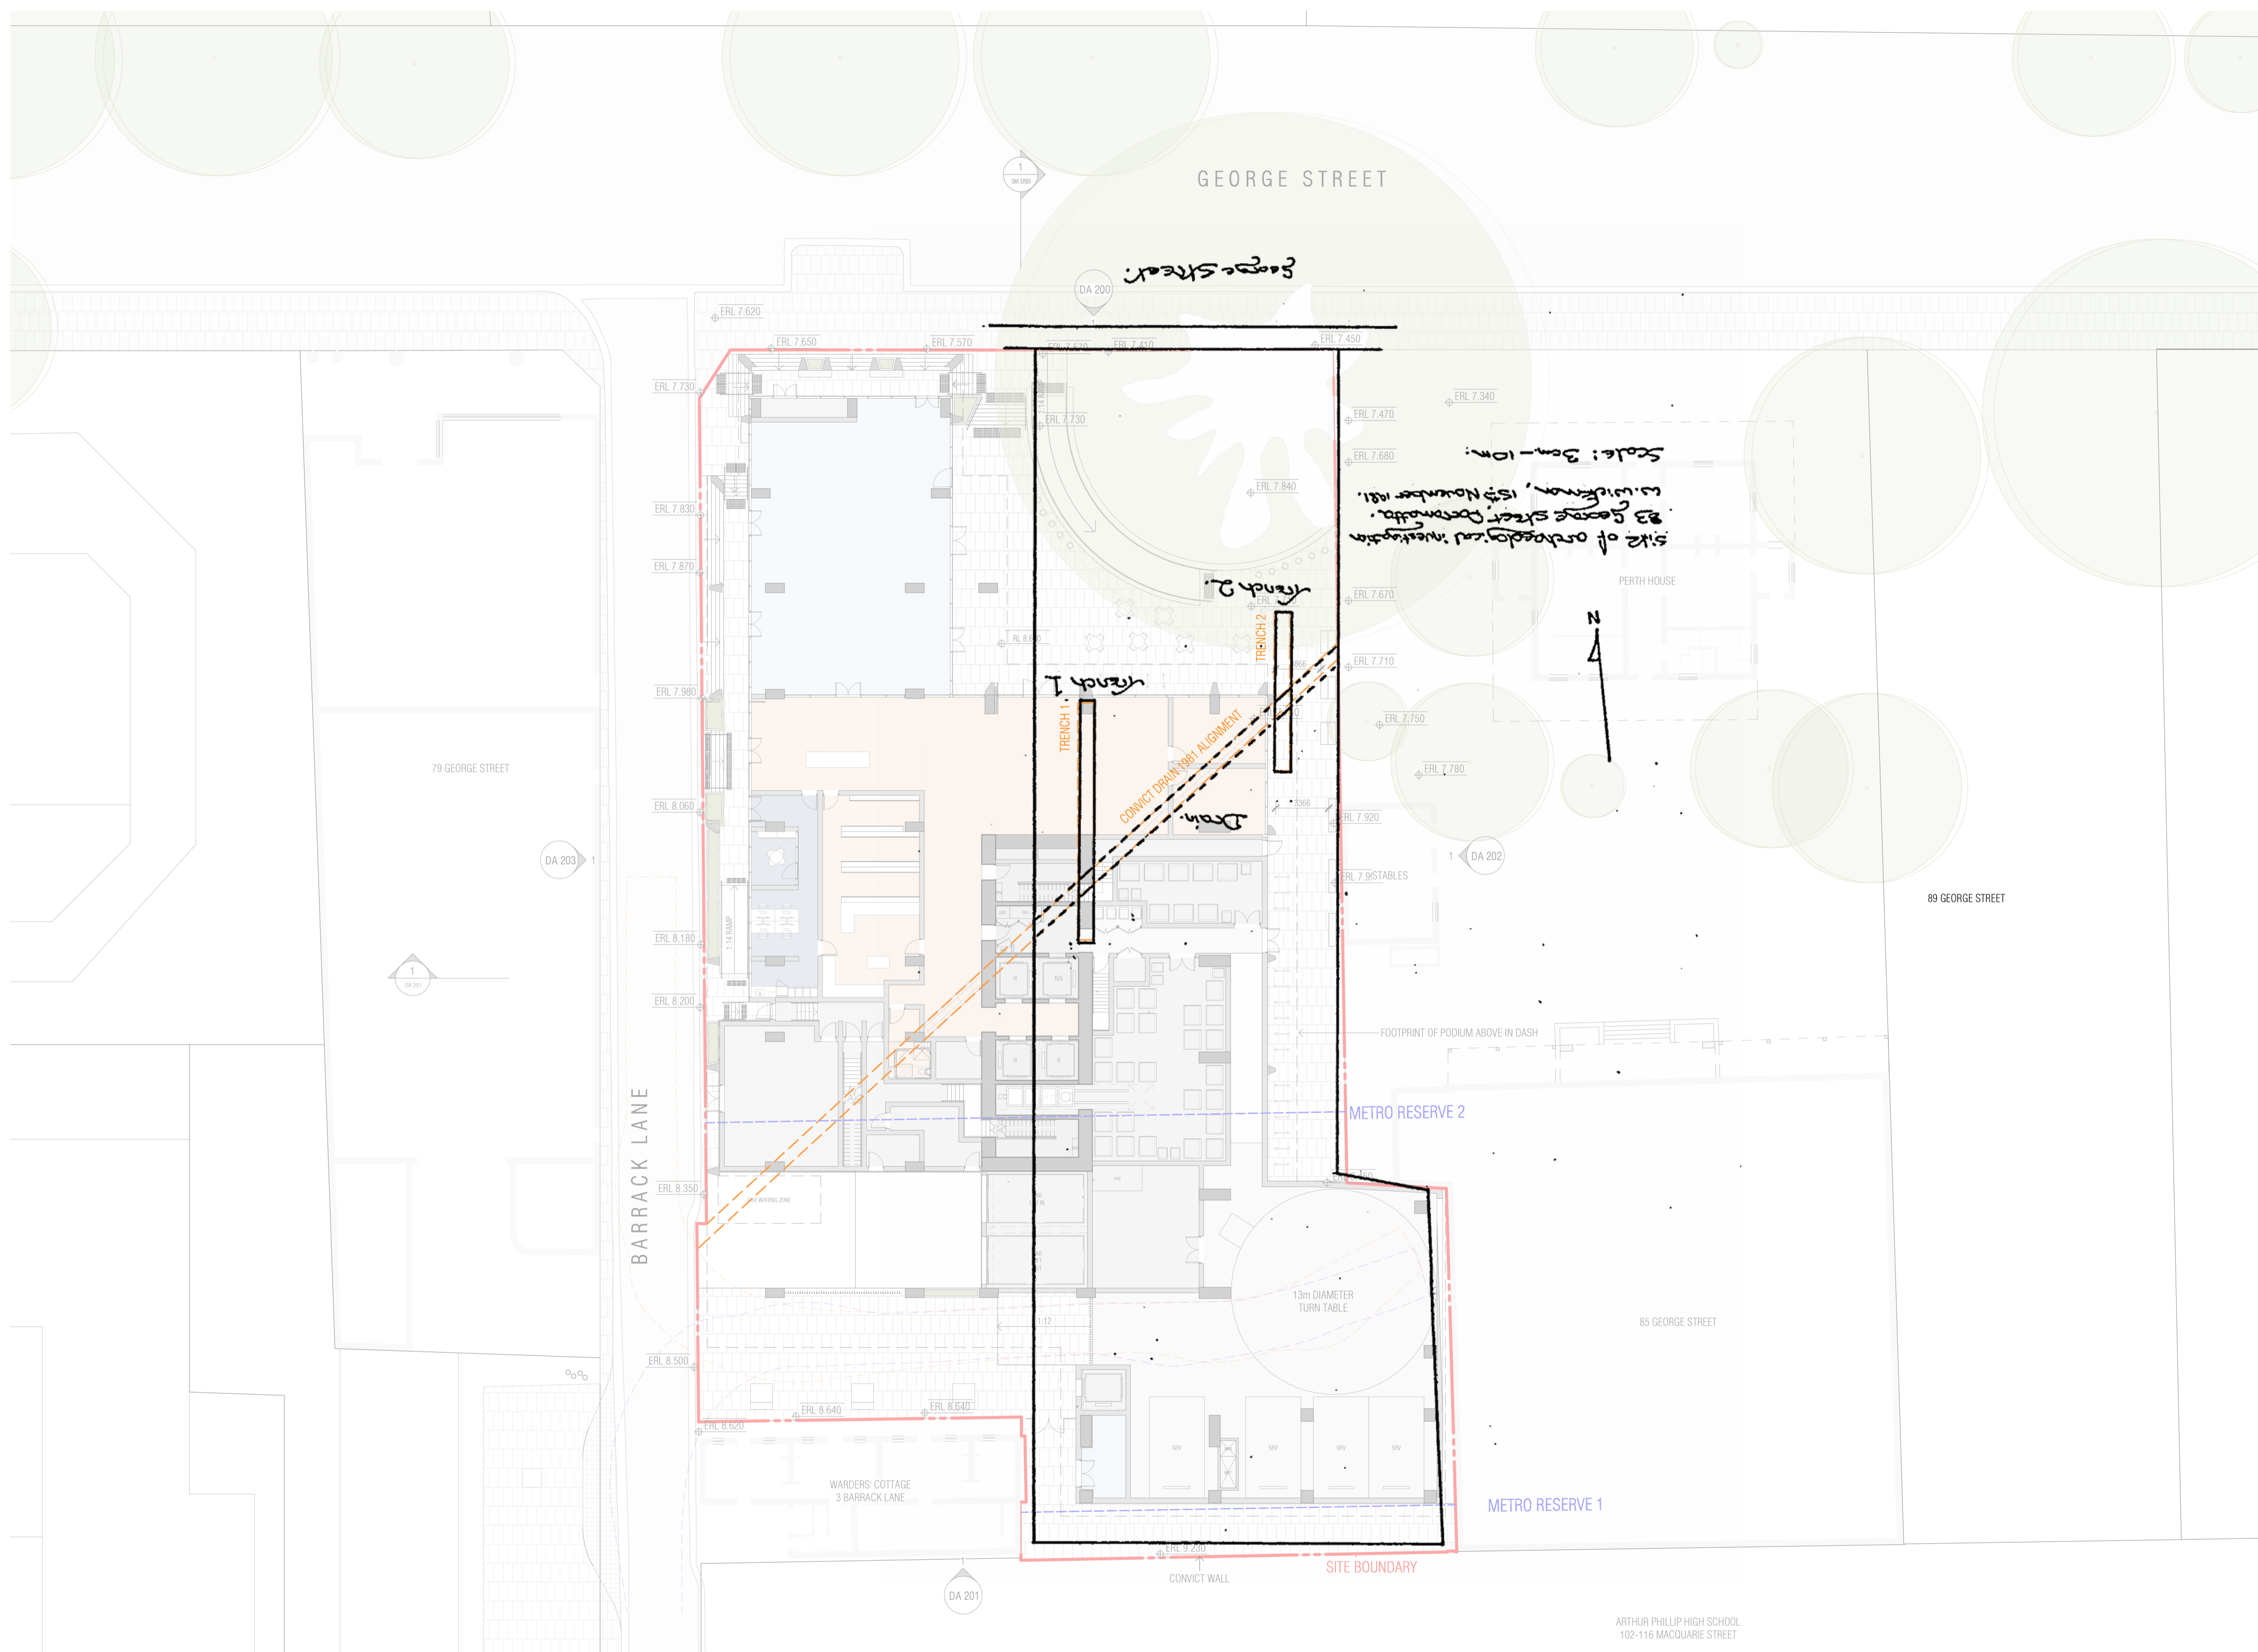

Autodesk Docs://25013 81-83 George Street Parramatta/25013_BASE_R24_RTS.rvt

REVISION		
A	SSDA SUBMISSION	FK 07/10/2025
B	RESEPNSE TO RTS	FK 13/03/2026


QUALITY ASSURANCE (FK IS A CERTIFIED COMPANY TO ISO 9001:2015)
 THIS PROJECT IS SUBJECT TO THE FK QUALITY ASSURANCE SYSTEM

UNCONTROLLED COPY

NOT FOR CONSTRUCTION

NOTES
 THIS DRAWING IS COPYRIGHT AND SHALL REMAIN THE PROPERTY OF FENDER KATSALIDIS (AUST) PTY LTD
 CHECK AND VERIFY ALL DIMENSIONS ON SITE PRIOR TO COMMENCING WORK. DRAWING TO BE READ
 IN CONJUNCTION WITH ALL OTHER CONTRACT DOCUMENTS. DO NOT SCALE DRAWINGS. USE FIGURED
 DIMENSIONS ONLY. SEEK CLARIFICATION OF INCONSISTENCIES / CONFLICTS.

DRAWN	CHECKED	DATE	JOB NO.	SCALE
AL	DS	06/03/2026	25013	1 : 200 @A1

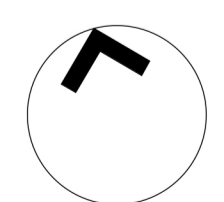


PROJECT
1 BARRACK LANE AND 81-83 GEORGE STREET PARRAMATTA

DRAWING TITLE
GROUND FLOOR WITH 1981 CONVICT DRAIN


CLIENT
FREECITY

FK
 WWW.FKAUSTRALIA.COM
 L21, 259 GEORGE STREET, SYDNEY
 NEW SOUTH WALES 2000 AUSTRALIA
 TELEPHONE: +61 2 8216 3500
 FENDER KATSALIDIS (AUST) PTY LTD ACN 092 943 032

ISSUE PURPOSE
RESEPNSE TO RTS

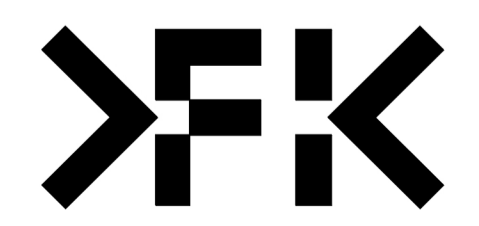

REV. **B** DRAWING NO. **DA* 100A**

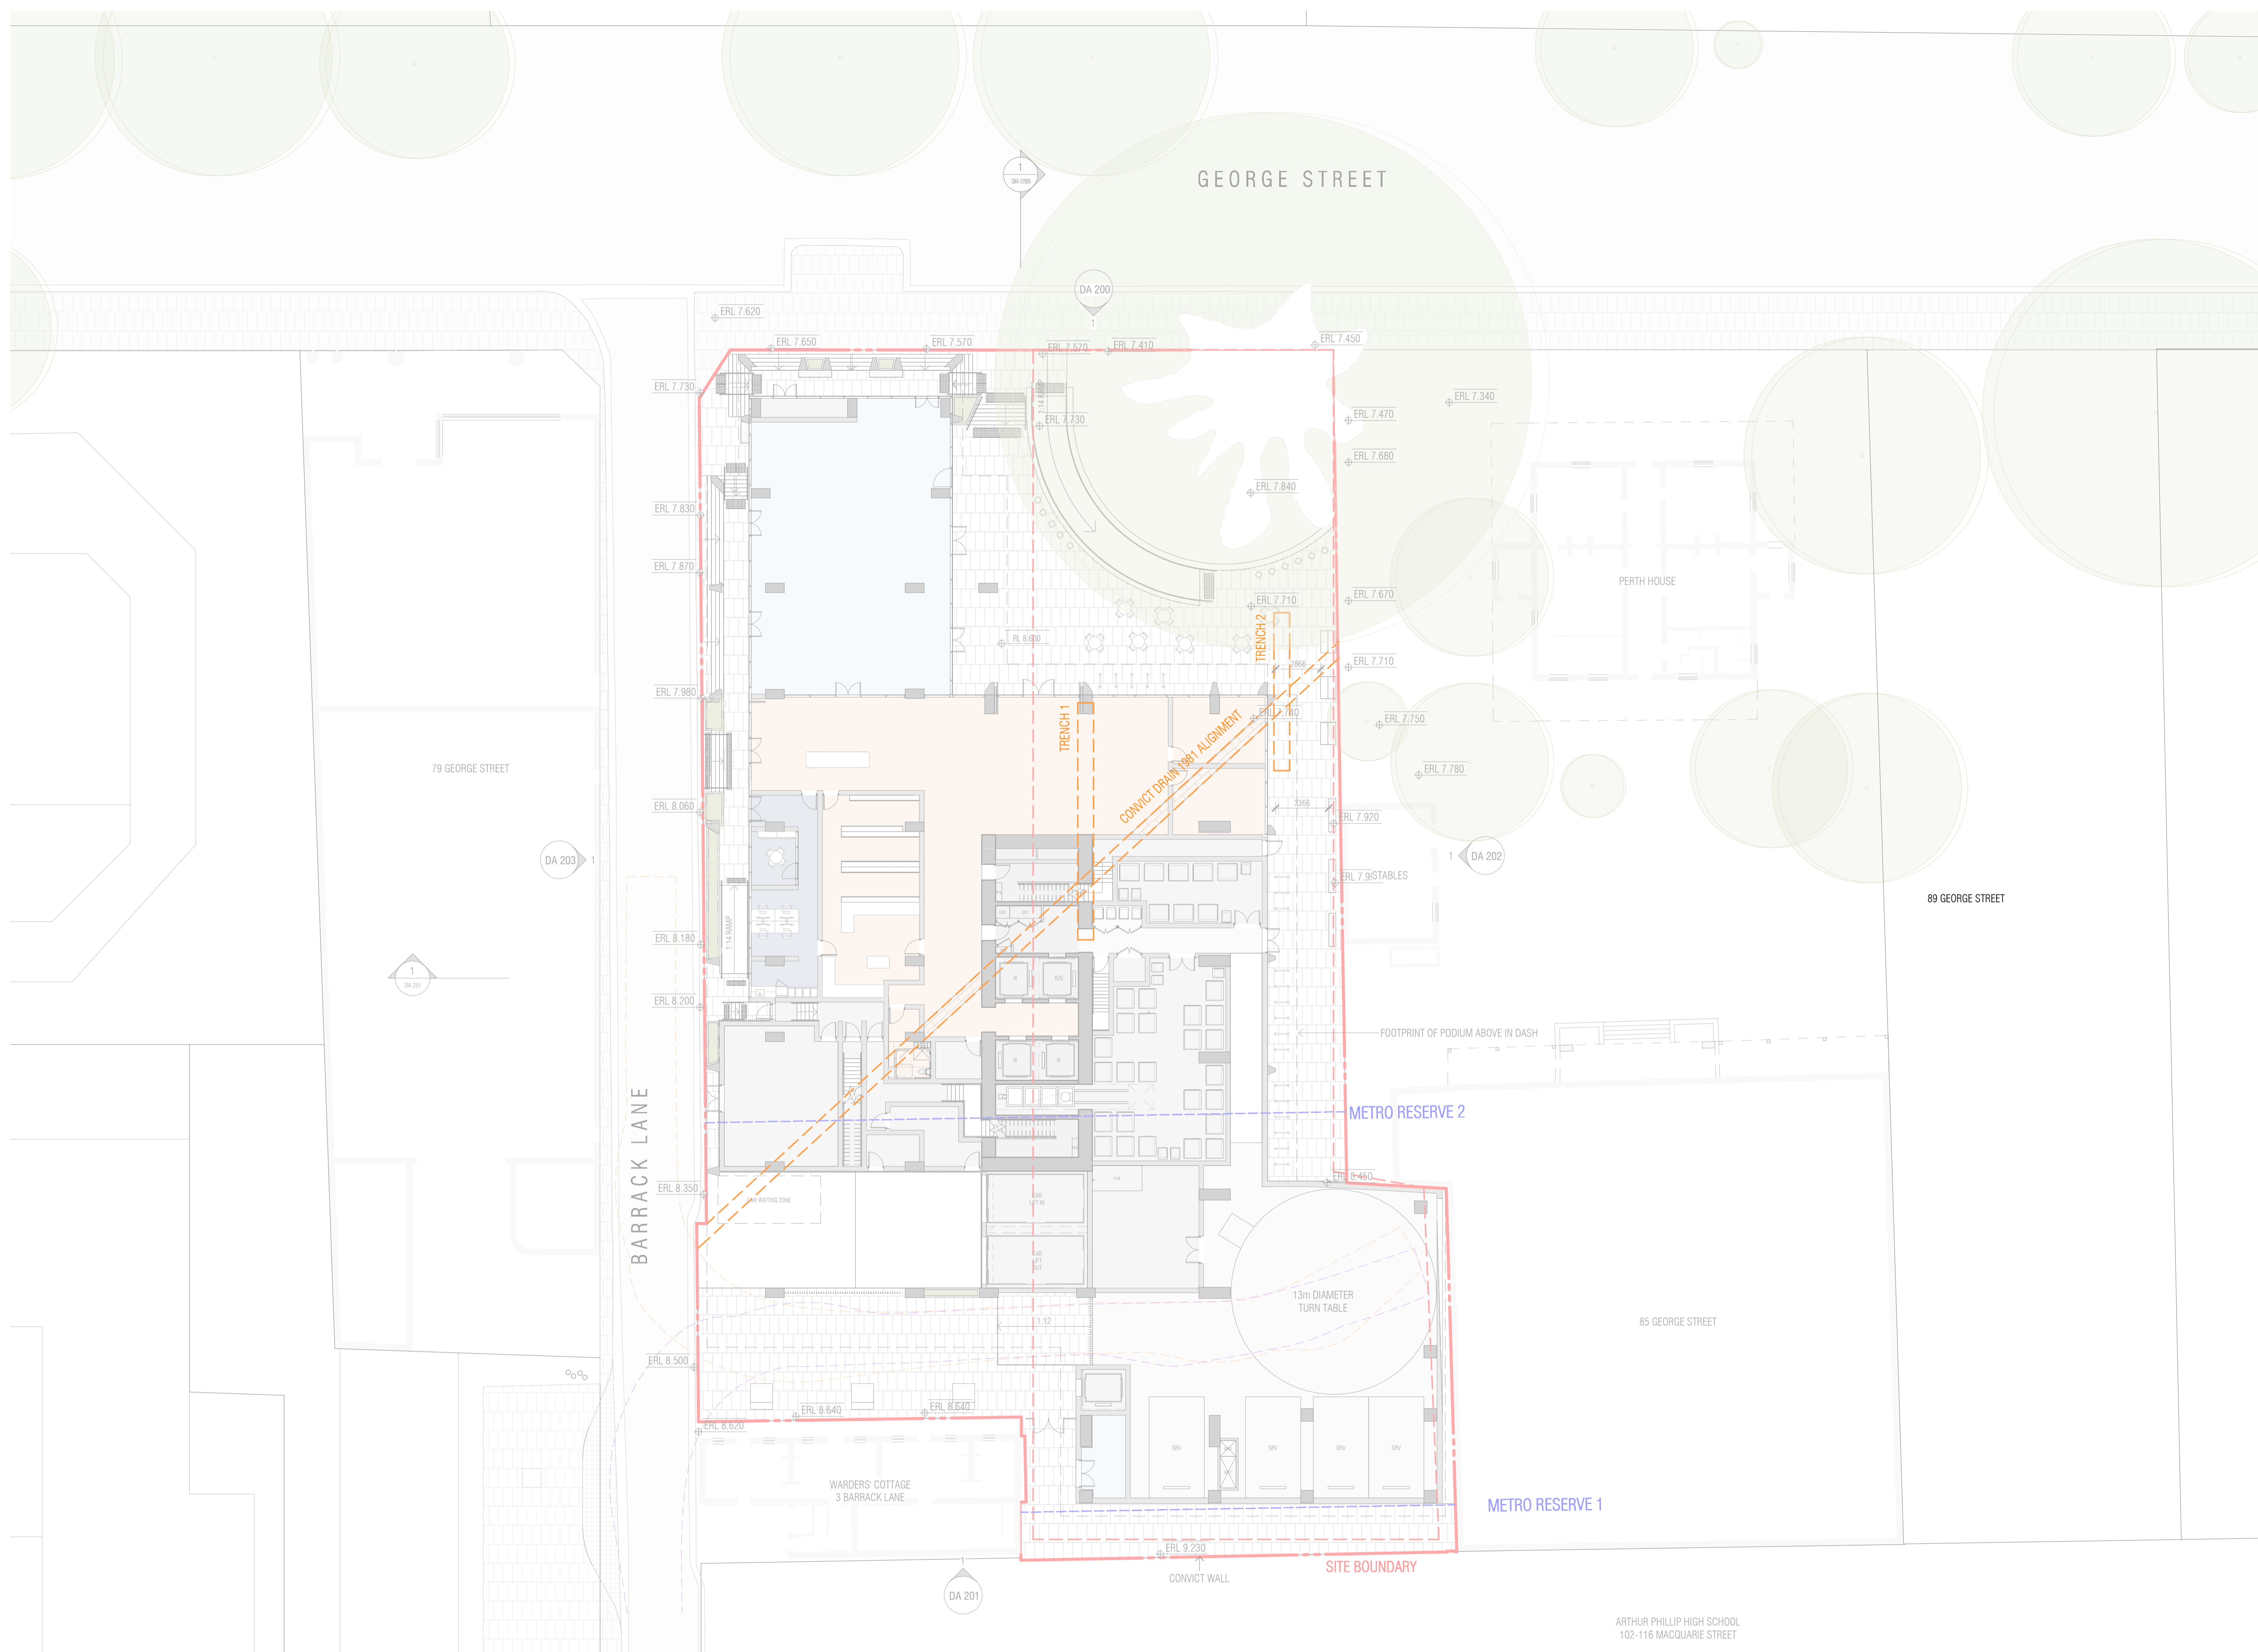

LEGEND

- STRUCTURE
- STRUCTURE UNDER
- MR1 STAIR 1 - PRESSURISATION RISER
- MR2 STAIR 2 - PRESSURISATION RISER
- MR3 STAIR RELIEF RISER
- MP4 WATER-COOLED CONDENSERS PLANTROOM (RESI)
- MR5 REFRIGERANT PIPER WORK RISER
- MR6 RETAIL KITCHEN EXHAUST
- MP7 LOADING DOCK EXHAUST
- MP8 CAR LIFT EXHAUST
- MP9 FIRE PUMP FLUE
- GE GARBAGE EXHAUST
- WE WASTE EXHAUST
- ER1 MAIN ELECTRICAL RISER
- ER2 MAIN COMMUNICATIONS RISER
- FP2 FIRE BOOSTER ASSEMBLY
- FP4 STAIR 1 - FIRE SERVICES RISER
- FP5 STAIR 2 - FIRE SERVICES RISER
- FCR FIRE CONTROL ROOM
- HP3 COLD WATER METER ROOM
- HP6 GREASER ARRESTOR
- HP7 HYDRAULIC SANITARY RISER
- HP8 HYDRAULIC SERVICES RISER 1
- HP9 HYDRAULIC SERVICES RISER 2
- R RESIDENTIAL LIFT
- G GOODS LIFT
- ERL EXISTING RELATIVE LEVEL
- RL (PROPOSED) RELATIVE LEVEL
- S STORAGE
- L LAUNDRY
- P PANTRY
- F FRIDGE
- - - MRV SWEEP PATH IN
- - - MRV SWEEP PATH OUT

Autodesk Docs://25013 81-83 George Street Parramatta/25013_BASE_R24_RTS.rvt

REVISION			
A	SSDA SUBMISSION	FK	07/10/2025
B	RESEPNSE TO RTS	FK	13/03/2026

QUALITY ASSURANCE (FK IS A CERTIFIED COMPANY TO ISO 9001:2015)
THIS PROJECT IS SUBJECT TO THE FK QUALITY ASSURANCE SYSTEM

UNCONTROLLED COPY

NOT FOR CONSTRUCTION

NOTES
THIS DRAWING IS COPYRIGHT AND SHALL REMAIN THE PROPERTY OF FENDER KATSALIDIS (AUST) PTY LTD. CHECK AND VERIFY ALL DIMENSIONS ON SITE PRIOR TO COMMENCING WORK. DRAWINGS TO BE READ IN CONJUNCTION WITH ALL OTHER CONTRACT DOCUMENTS. DO NOT SCALE DRAWINGS. USE FIGURED DIMENSIONS ONLY. SEEK CLARIFICATION OF INCONSISTENCIES / CONFLICTS.

DRAWN	CHECKED	DATE	JOB NO.	SCALE
AL	DS	06/03/2026	25013	1 : 200 @A1

PROJECT
1 BARRACK LANE AND 81-83 GEORGE STREET PARRAMATTA

DRAWING TITLE
GROUND FLOOR WITH 1981 CONVICT DRAIN

CLIENT
FREECITY

FK
WWW.FKAUSTRALIA.COM
L21, 269 GEORGE STREET, SYDNEY
NEW SOUTH WALES 2000 AUSTRALIA
TELEPHONE: +61 2 8216 3500
FENDER KATSALIDIS (AUST) PTY LTD ACN 092 943 032

ISSUE PURPOSE
RESEPNSE TO RTS



REV.
B

DRAWING NO.
DA* 100A