
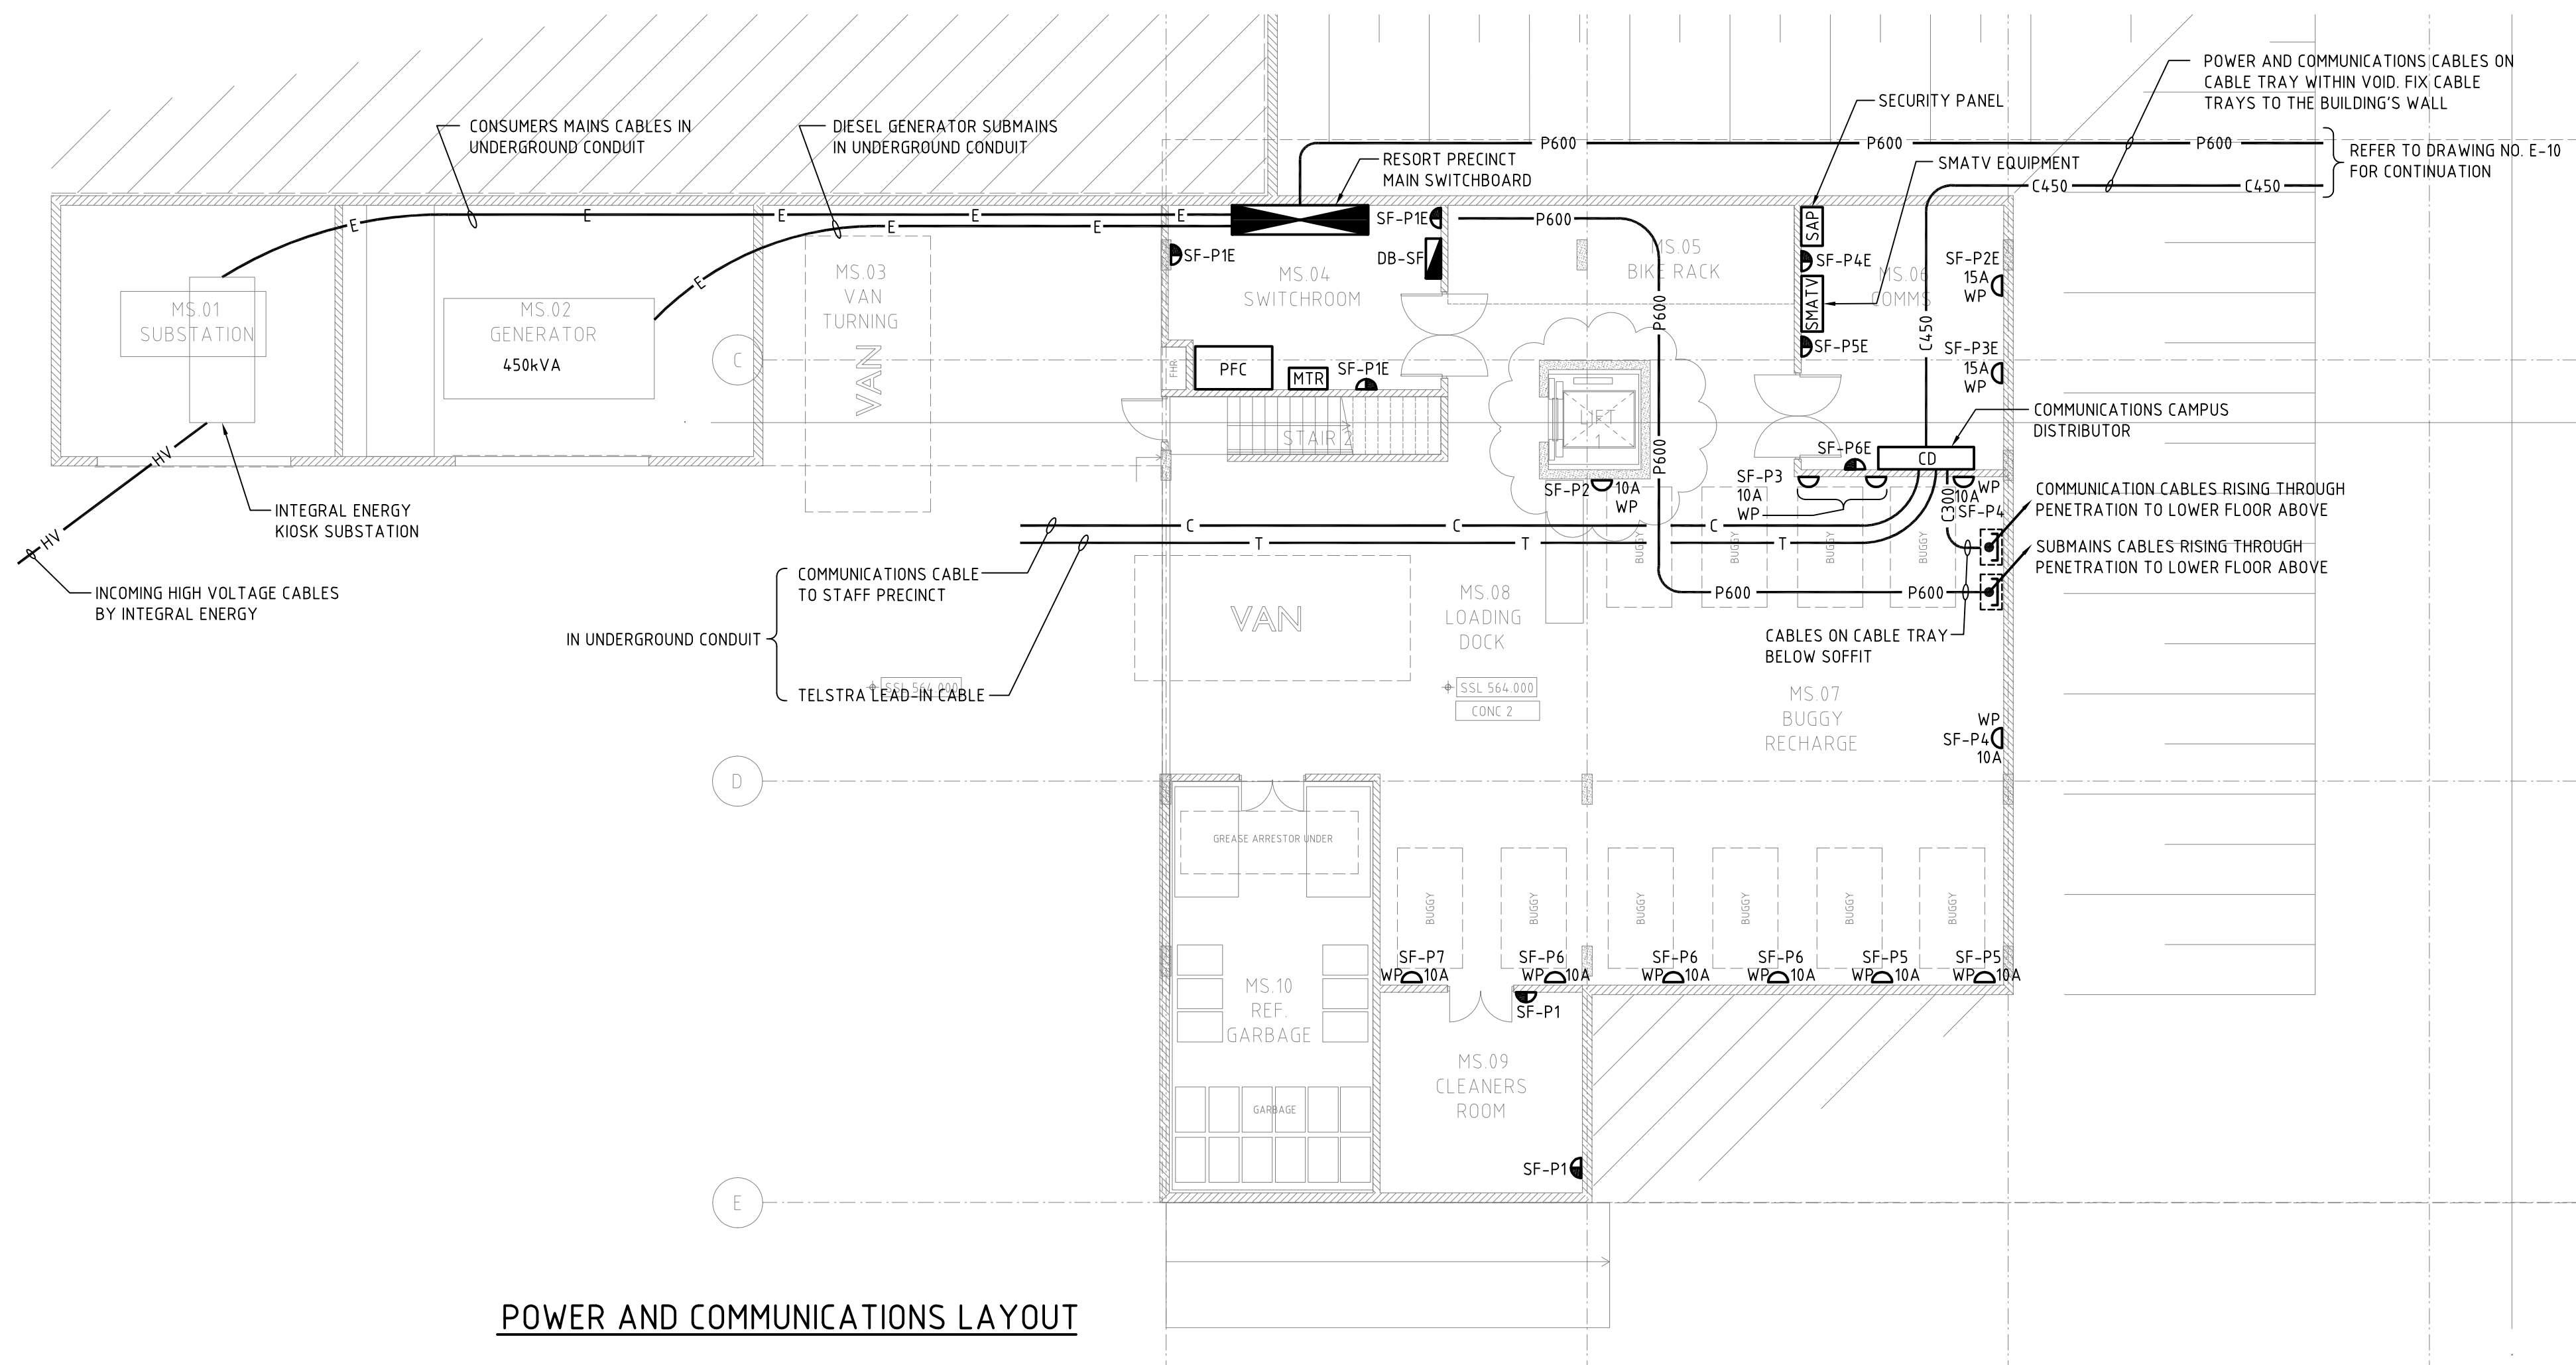


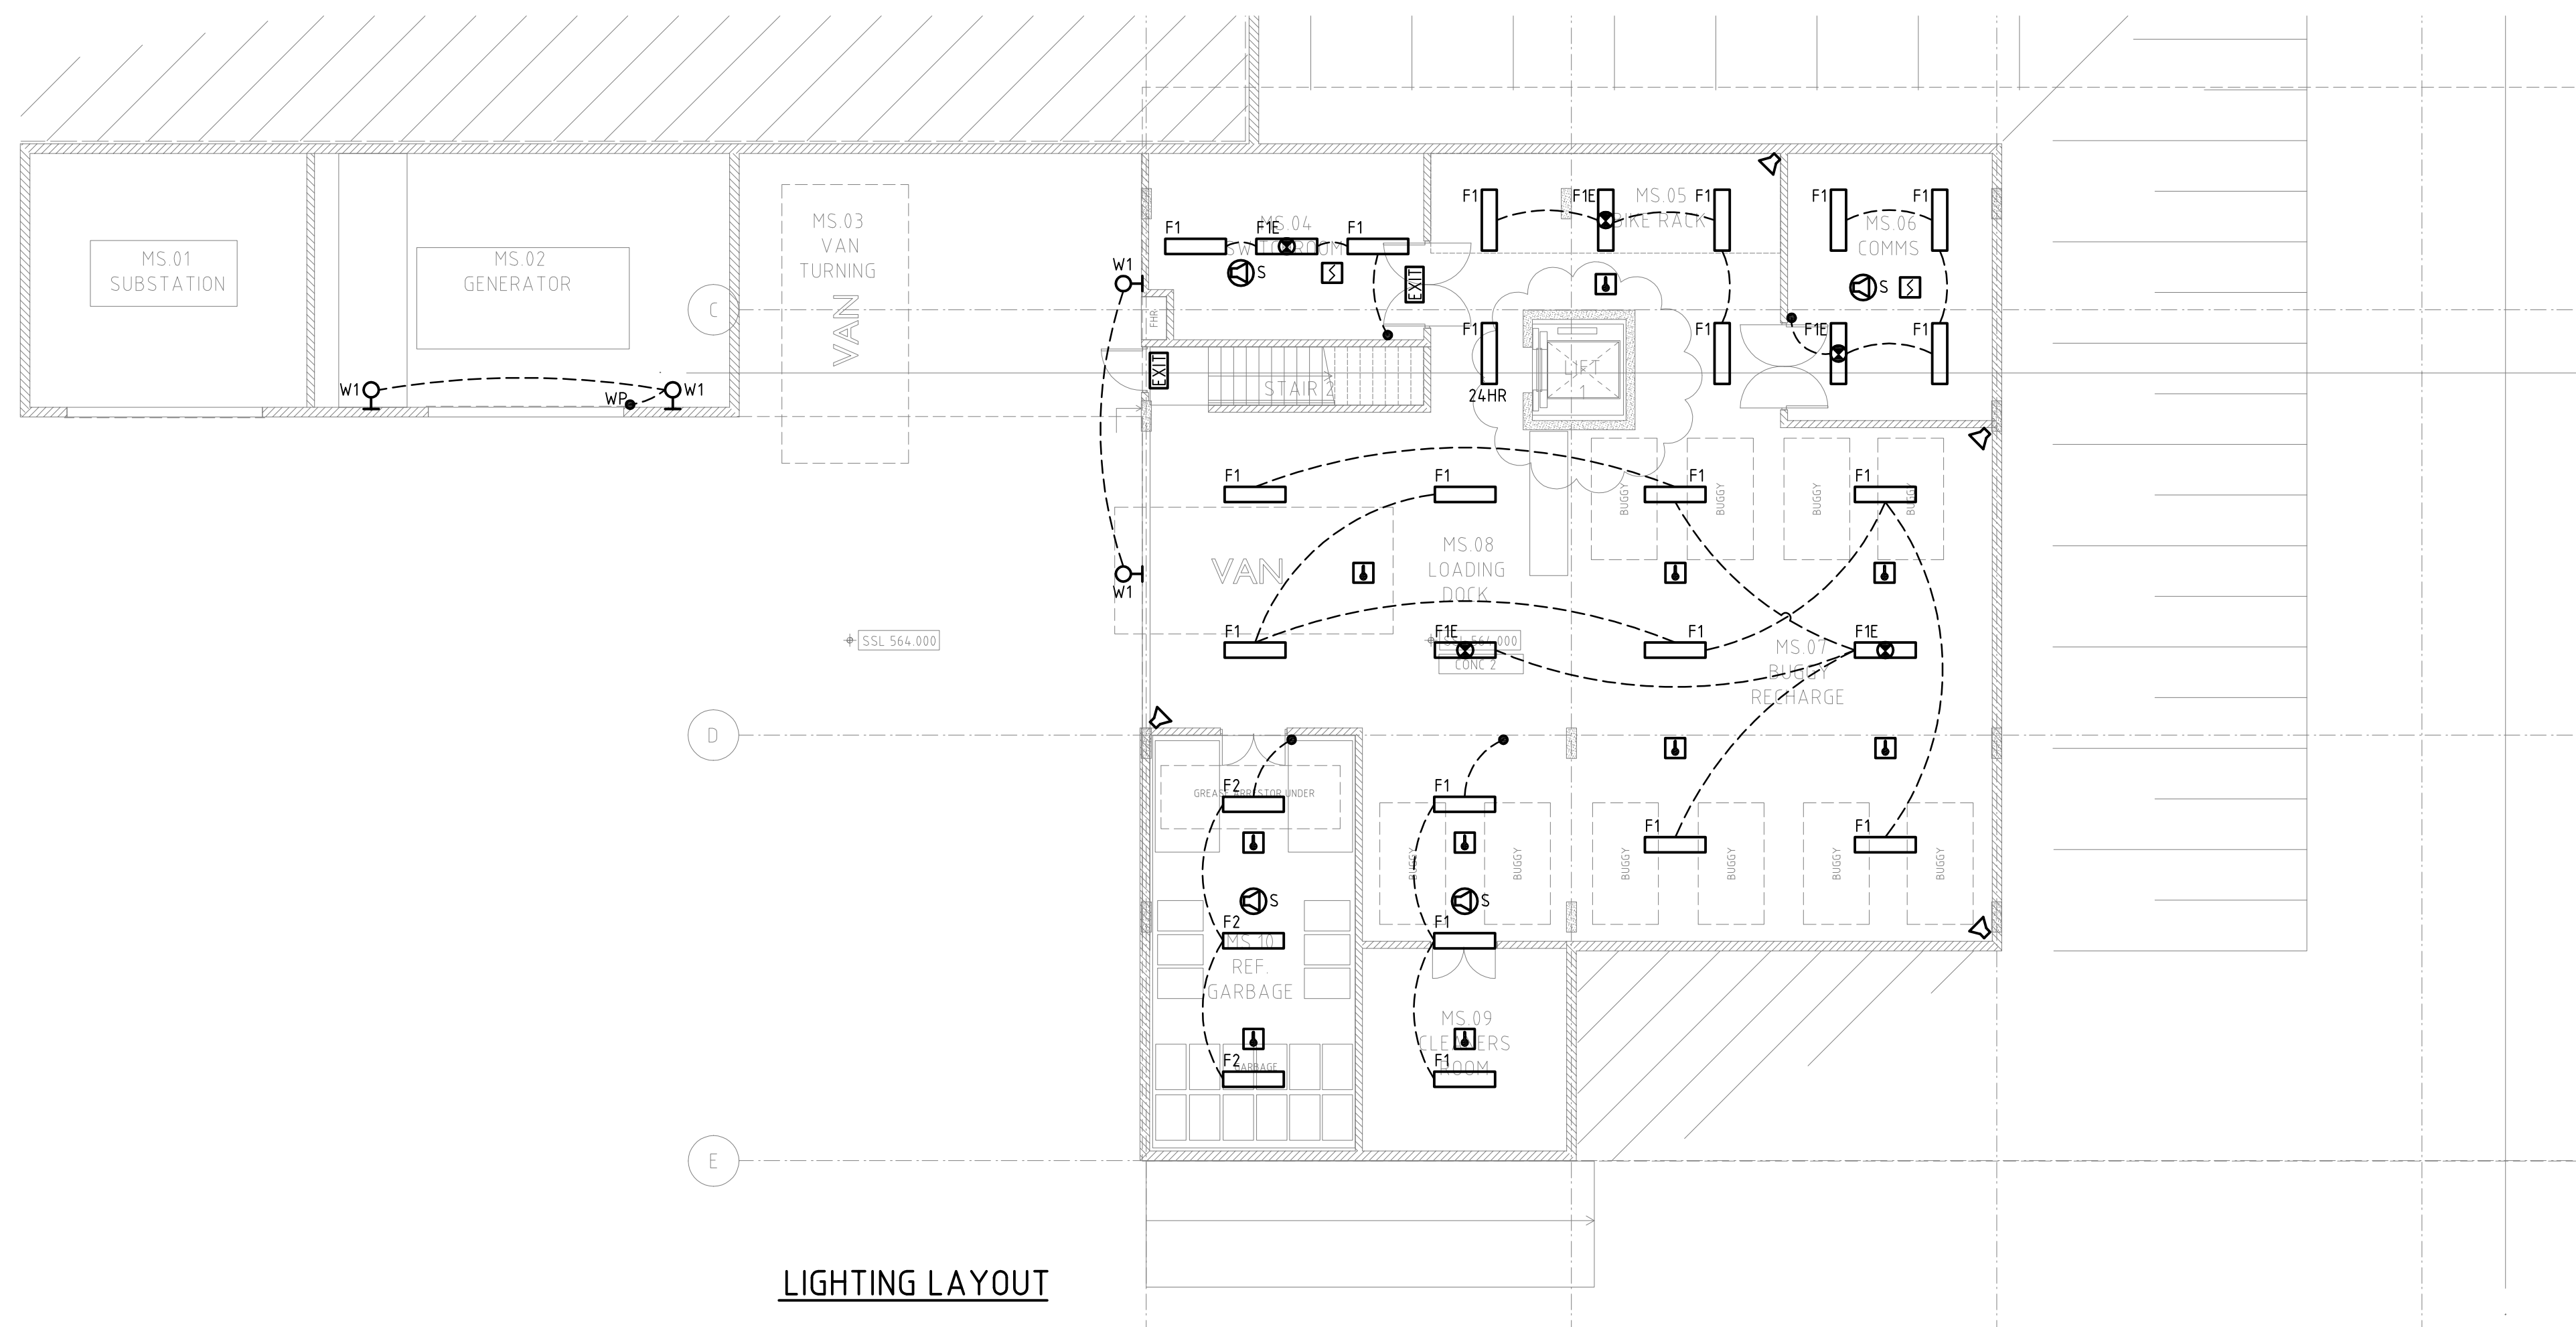

NOTES

1. THIS DRAWING SHALL BE READ IN CONJUNCTION WITH THE ELECTRICAL SERVICES SECTION OF THE SPECIFICATION, THE ARCHITECTURAL DRAWINGS AND ALL OTHER RELEVANT SERVICES DRAWINGS.
2. ALL EQUIPMENT AND ACCESSORIES ARE NEW UNLESS NOTED OTHERWISE.
3. FINAL POSITION OF ALL EQUIPMENT TO BE DETERMINED ON SITE PRIOR TO INSTALLATION. REFER TO ARCHITECTURAL FITOUT DRAWINGS.
4. RATINGS AND TERMINATIONS OF ALL EQUIPMENT TO BE CONFIRMED WITH SUPPLIER/MANUFACTURER'S RECOMMENDATIONS PRIOR TO INSTALLATION.

PA	PRELIMINARY ISSUE	JRR	---	--/--/06
REV.	DESCRIPTION	DRAWN	APP'D	DATE

Client

Emirates - Sydney
Level 9, 1 York Street
Sydney, NSW 2000
T 02 9290 9786
F 02 9299 9722



Project Manager

Clifton Coney Group Pty Ltd
Level 18, Citigroup Centre
Sydney, NSW 2000
T 02 9287 2100
F 02 9287 2188



Architect

TURNER+ASSOCIATES

LEVEL 1/ 586 CROWN STREET SURRY HILLS NSW 2010
T 02 9690 2855 F 02 9690 2411

NOMINATED ARCHITECT: Nicholas Turner 6695
DLQ QUALITY ENDORSED COMPANY ISO 9001:2000 LICENCE NUMBER 4168

Interior Designer

Chhada Siembieda
30 Boronia Street
Redfern, NSW 2016
T 02 9318 2627
F 02 9318 2151



PROJECT:
EMIRATES LUXURY RESORT
WOLGAN VALLEY
NEW SOUTH WALES

TITLE:
ELECTRICAL SERVICES
MAIN BUILDING-SERVICES FLOOR
LIGHTING, POWER AND
COMMUNICATIONS LAYOUTS

PRELIMINARY
NOT FOR CONSTRUCTION

DESIGNED : LVS	VERIFIED : -	--/--/06
DRAWN : JRR	APPROVED FOR TENDER : -	--/--/06
SCALE : 1:100	APPROVED FOR CONSTRUCTION : -	--/--/06
CAD FILE: 18438-SYD-E/ELEC/E-08		11:33 30/08/06

DRAWING No.	REVISION
18438-SYD-E-08	PA