

NOTES

1.

THIS DRAWING SHALL BE READ IN CONJUNCTION WITH THE ELECTRICAL SERVICES SECTION OF THE SPECIFICATION, THE ARCHITECTURAL DRAWINGS AND ALL OTHER RELEVANT SERVICES DRAWINGS.
2.

ALL EQUIPMENT AND ACCESSORIES ARE NEW UNLESS NOTED OTHERWISE.
3.

FINAL POSITION OF ALL EQUIPMENT TO BE DETERMINED ON SITE PRIOR TO INSTALLATION. REFER TO ARCHITECTURAL FITOUT DRAWINGS.
4.

RATINGS AND TERMINATIONS OF ALL EQUIPMENT TO BE CONFIRMED WITH SUPPLIER/MANUFACTURER'S RECOMMENDATIONS PRIOR TO INSTALLATION.

PA	PRELIMINARY ISSUE	JRR	---	--/--/06
REV.	DESCRIPTION	DRAWN	APP'D	DATE

Client

Emirates - Sydney
Level 9, 1 York Street
Sydney, NSW 2000
T 02 9290 9786
F 02 9299 9722



Project Manager

Clifton Coney Group Pty Ltd
Level 18, Citigroup Centre
Sydney, NSW 2000
T 02 9287 2100
F 02 9287 2188



Architect

TURNER+ASSOCIATES

LEVEL 1/ 586 CROWN STREET SURRY HILLS NSW 2010
T 02 9690 2855 F 02 9690 2411

NO MINATED ARCHITECT: Nicholas Turner 6695
DLQ QUALITY ENDORSED COMPANY ISO 9001:2000 LICENCE NUMBER 4168

Interior Designer

Chhada Siembieda
30 Boronia Street
Redfern, NSW 2016
T 02 9318 2627
F 02 9318 2151



WOOD & GRIEVE ENGINEERS

Wood & Grieve Pty Ltd
A.C.N. 008 808 786
2/33 Ryde Road
PYMBLE NSW 2073
Phone 02 9484 7000
Fax 02 9484 7100
Email wge@wge.com.au
Web www.wge.com.au

PERTH
MELBOURNE
SYDNEY
BRISBANE
ALBANY
TASMANIA
AUCKLAND
DUNEDIN

PROJECT:
EMIRATES LUXURY RESORT
WOLGAN VALLEY
NEW SOUTH WALES


TITLE:
ELECTRICAL SERVICES
POOL BUILDING-LOWER FLOOR
LIGHTING, POWER, COMMUNICATIONS
AND SECURITY LAYOUTS

PRELIMINARY
NOT FOR CONSTRUCTION

DESIGNED :	LVS	VERIFIED :	-	--/--/06
DRAWN :	JRR	APPROVED FOR TENDER :	-	--/--/06
SCALE :	1:100	APPROVED FOR CONSTRUCTION :	-	--/--/06
CAD FILE:	18438-SYD-E/ELEC/E-13	345	04/10/06	

DRAWING No.	REVISION
18438-SYD-E-13	PA

NOTE: RWP LOCATIONS TO BE CONFIRMED WITH HYDRAULIC ENGINEER

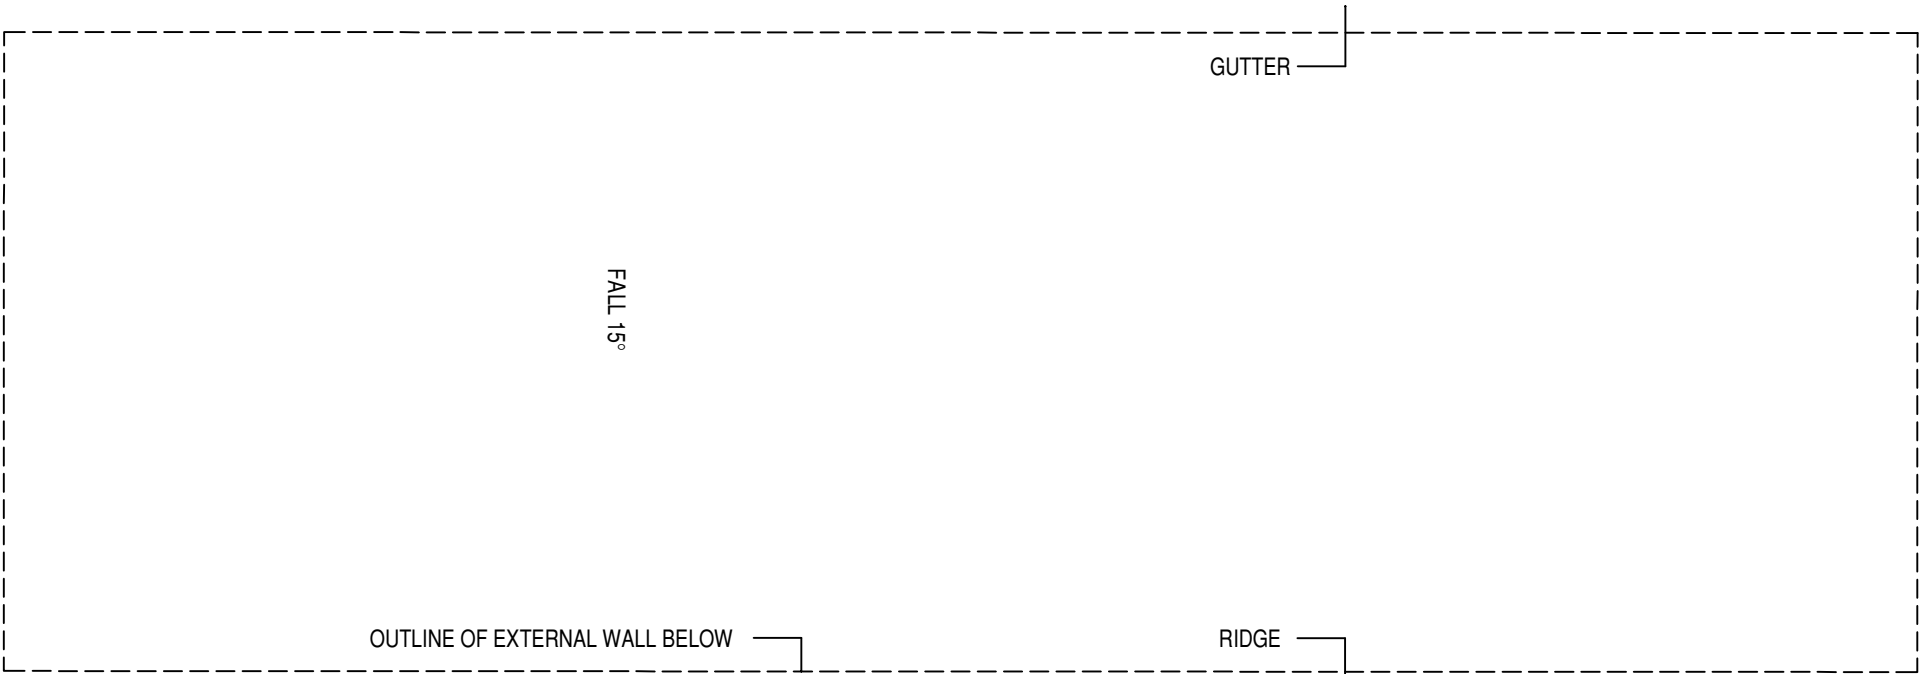


TIMBER PERGOLA ROOF TO MAIN BUILDING

METAL FRAMED AWNING WITH TIMBER BATTEN BLADES BELOW

LIGHTING LAYOUT

NOTE: RWP LOCATIONS TO BE CONFIRMED WITH HYDRAULIC ENGINEER

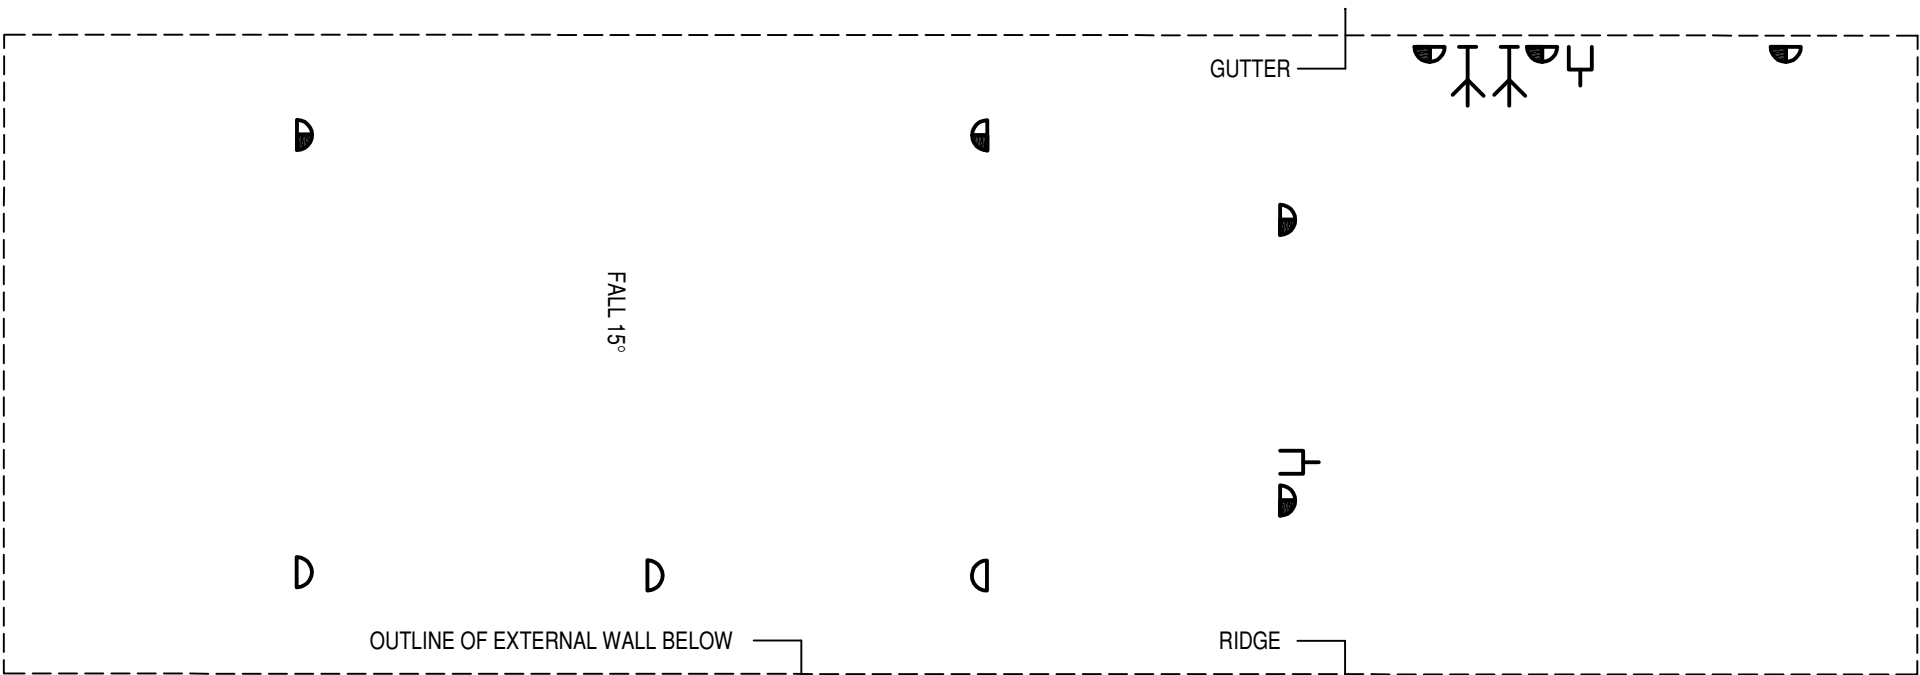

TIMBER PERGOLA ROOF TO MAIN BUILDING

METAL FRAMED AWNING WITH TIMBER BATTEN BLADES BELOW

POWER LAYOUT