

NOTES

- THIS DRAWING SHALL BE READ IN CONJUNCTION WITH THE ELECTRICAL SERVICES SECTION OF THE SPECIFICATION, THE ARCHITECTURAL DRAWINGS AND ALL OTHER RELEVANT SERVICES DRAWINGS.
- ALL EQUIPMENT AND ACCESSORIES ARE NEW UNLESS NOTED OTHERWISE.
- FINAL POSITION OF ALL EQUIPMENT TO BE DETERMINED ON SITE PRIOR TO INSTALLATION. REFER TO ARCHITECTURAL FITOUT DRAWINGS.
- RATINGS AND TERMINATIONS OF ALL EQUIPMENT TO BE CONFIRMED WITH SUPPLIER/MANUFACTURER'S RECOMMENDATIONS PRIOR TO INSTALLATION.
- WALL LAMPS, FLOOR LAMPS, FANS, PENDANTS AND READING LAMPS WILL BE SUPPLIED TO THE ELECTRICAL CONTRACTOR "FREE OF CHARGE" FOR INSTALLATION CONNECTION AND TESTING.
- FOR SET-OUTS REFER TO INTERIOR DESIGNER'S PLANS.

PA	PRELIMINARY ISSUE	JRR	APP'D	--/--/06	
REV.	DESCRIPTION	DRAWN	APP'D	DATE	

Client

Emirates - Sydney
Level 9, 1 York Street
Sydney, NSW 2000
T 02 9290 9786
F 02 9299 9722



Project Manager

Clifton Coney Group Pty Ltd
Level 18, Citigroup Centre
Sydney, NSW 2000
T 02 9287 2100
F 02 9287 2188



Architect

TURNER+ASSOCIATES

LEVEL 1/ 586 CROWN STREET SURRY HILLS NSW 2010
T 02 9690 2855 F 02 9690 2411

NOMINATED ARCHITECT: Nicholas Turner 6695
DLIO QUALITY ENDORSED COMPANY ISO 9001:2000 LICENCE NUMBER 4168

Interior Designer

Chhada Siembieda
30 Boronia Street
Redfern, NSW 2016
T 02 9318 2627
F 02 9318 2151




PROJECT:
EMIRATES LUXURY RESORT
WOLGAN VALLEY
NEW SOUTH WALES

TITLE:
ELECTRICAL SERVICES
1-BEDROOM VILLA
LIGHTING LAYOUT

PRELIMINARY
NOT FOR CONSTRUCTION

DESIGNED :	LVS	VERIFIED :	-	--/--/06
DRAWN :	JRR	APPROVED FOR TENDER :	-	--/--/06
SCALE :	1:50	APPROVED FOR CONSTRUCTION :	-	--/--/06
CAD FILE:	18438-SYD-E/ELEC/E-16		4-10	31/08/06

DRAWING No.	REVISION
18438-SYD-E-16	PA

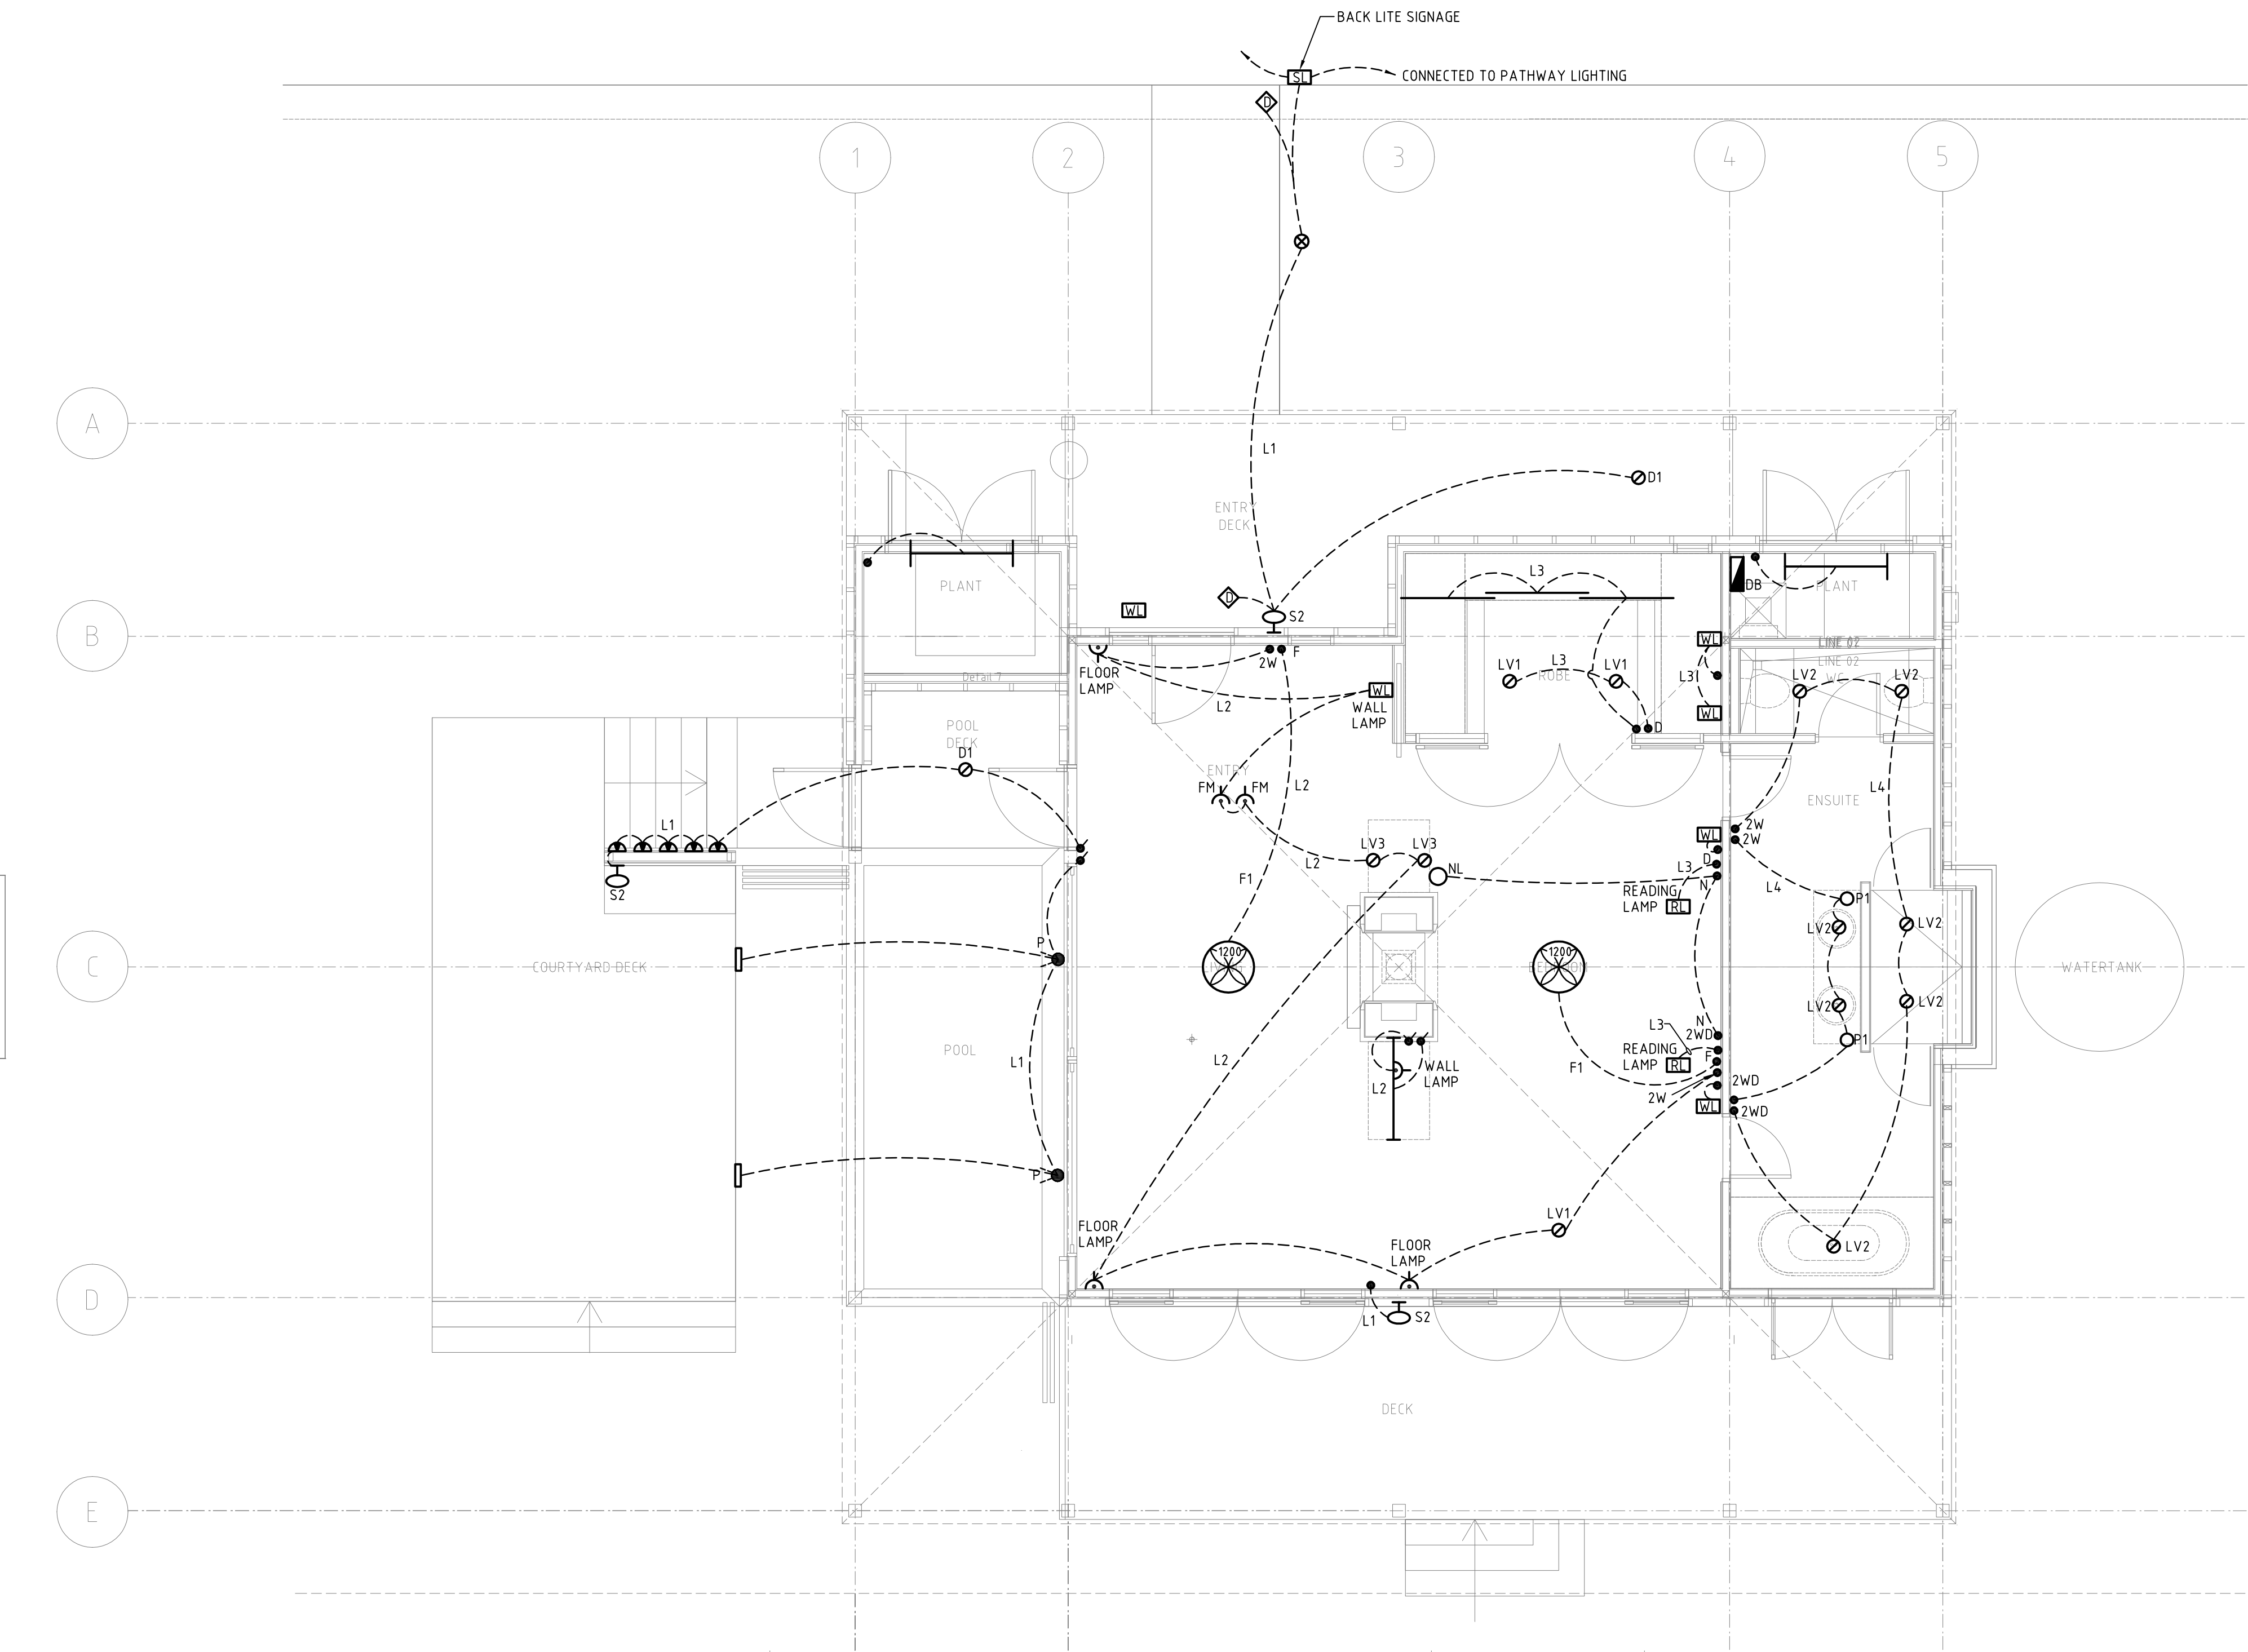

LEGEND-(REFER TO SCHEDULE OF LIGHT FITTINGS FOR DETAILS)

•	SINGLE LEVER SWITCH-D-DENOTES DIMMER
● 2W	2 WAY LIGHT SWITCH-2WD-DENOTES DIMMER
—	1200 SINGLE BATTEN FLUORESCENT LIGHT FITTING
—	1200 OVER-LAPPING FLUORESCENT BATTENS
○ P	PENDANT FITTING
○ LV1	RECESSED DOWNLIGHTER
○ LV2	RECESSED LOW VOLTAGE DOWNLIGHTER
○ D1	RECESSED IP65 LOW VOLTAGE DOWNLIGHTER
○ S2	RECESSED EXTERIOR DOWNLIGHTER
○ S2	WALL MOUNTED FITTING (EXTERIOR)
○ P	UNDERWATER POOL LIGHT (LED)
○	LED STEP LIGHT
○	LOW LEVEL LED BOLLARD LIGHT
○	UNSWITCHED SOCKET OUTLET FOR FREE STANDING LAMPS
○	FM-DENOTES FLOOR MOUNTED
○	CEILING SWEEP FAN
○	MOTION SENSOR