



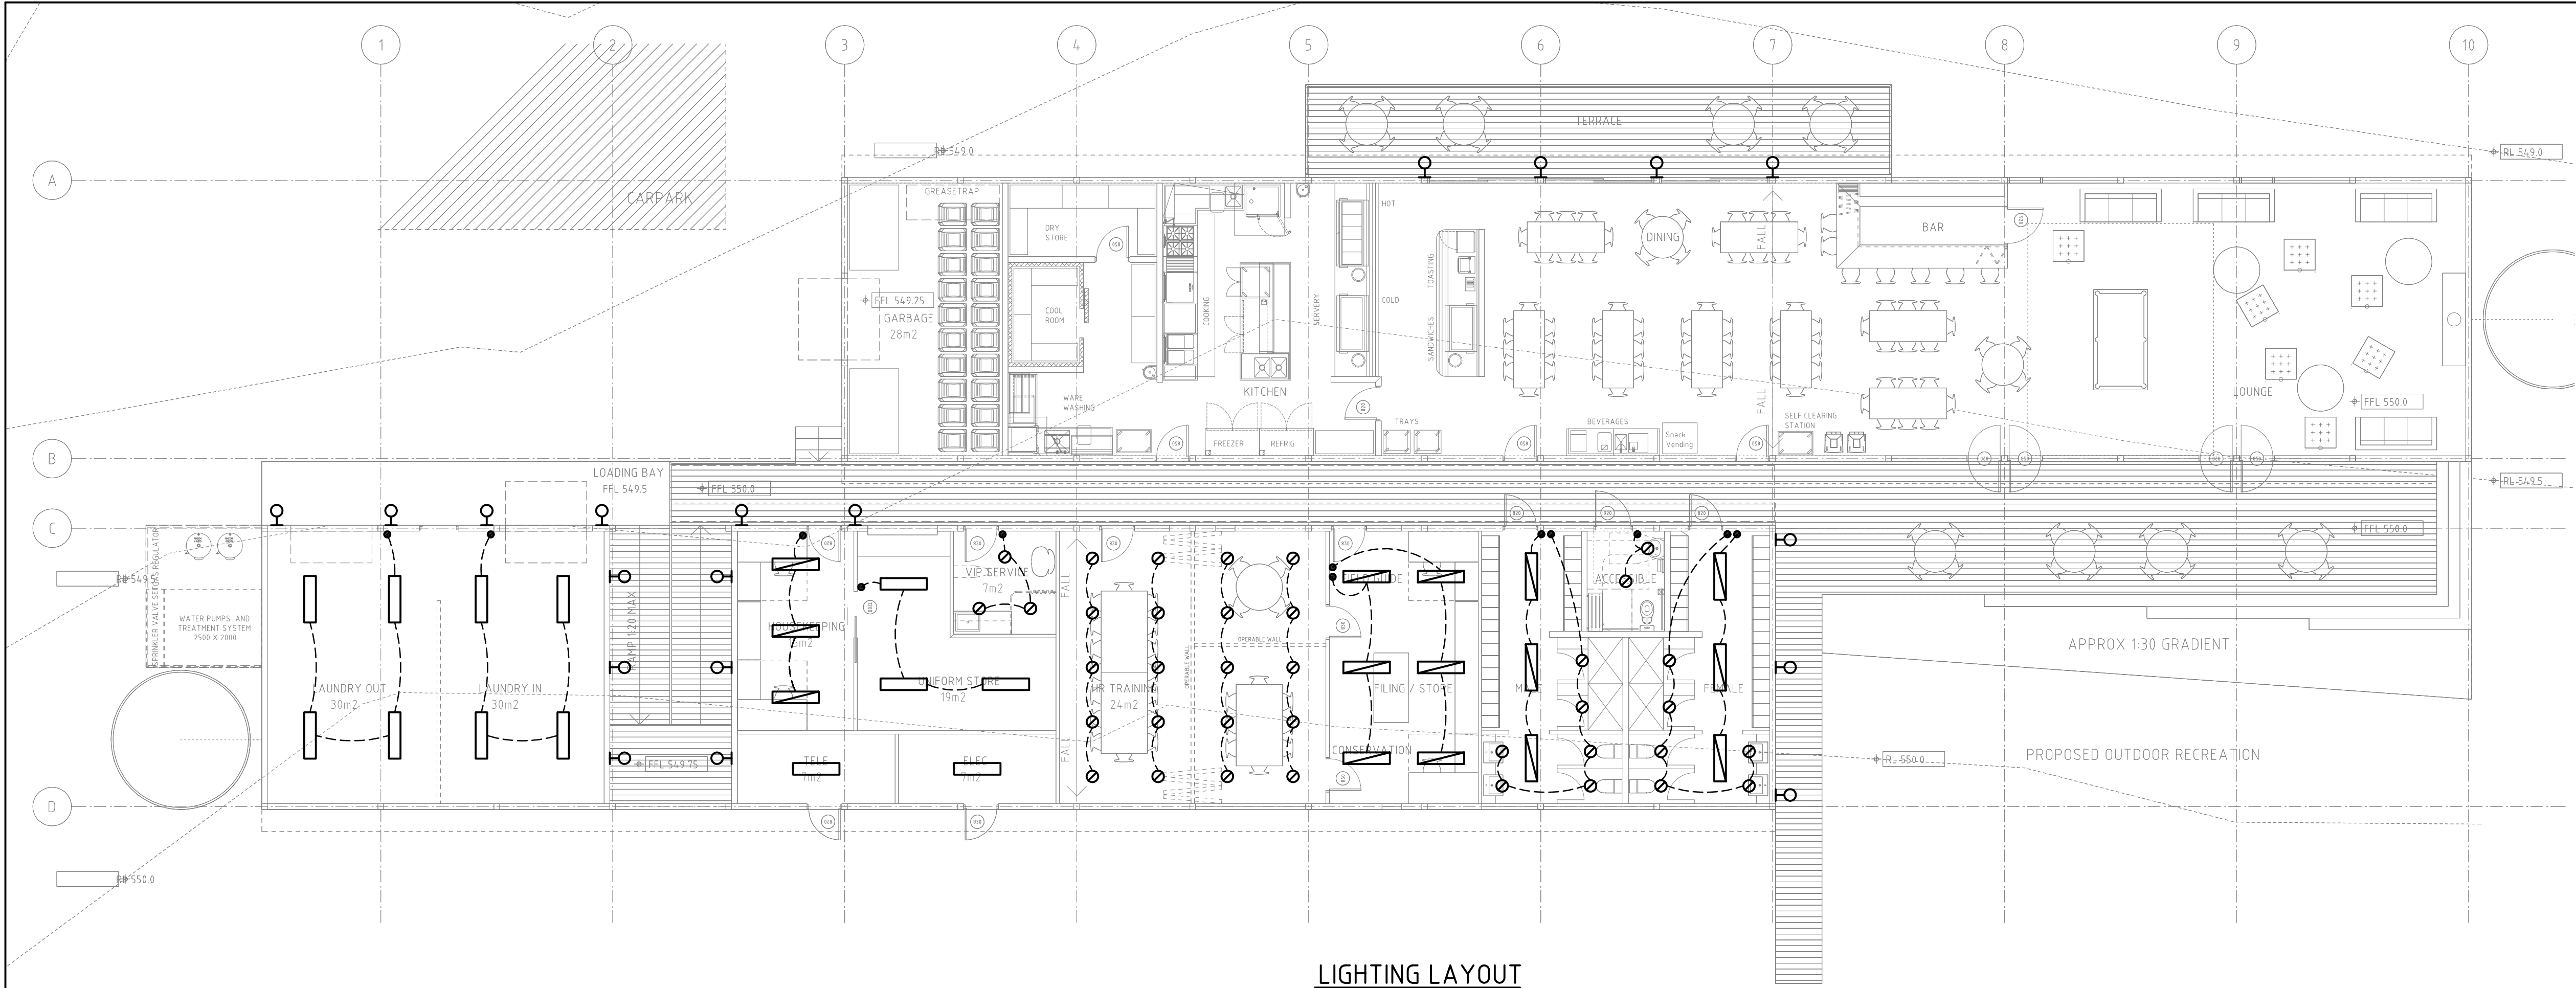

LIGHTING LAYOUT

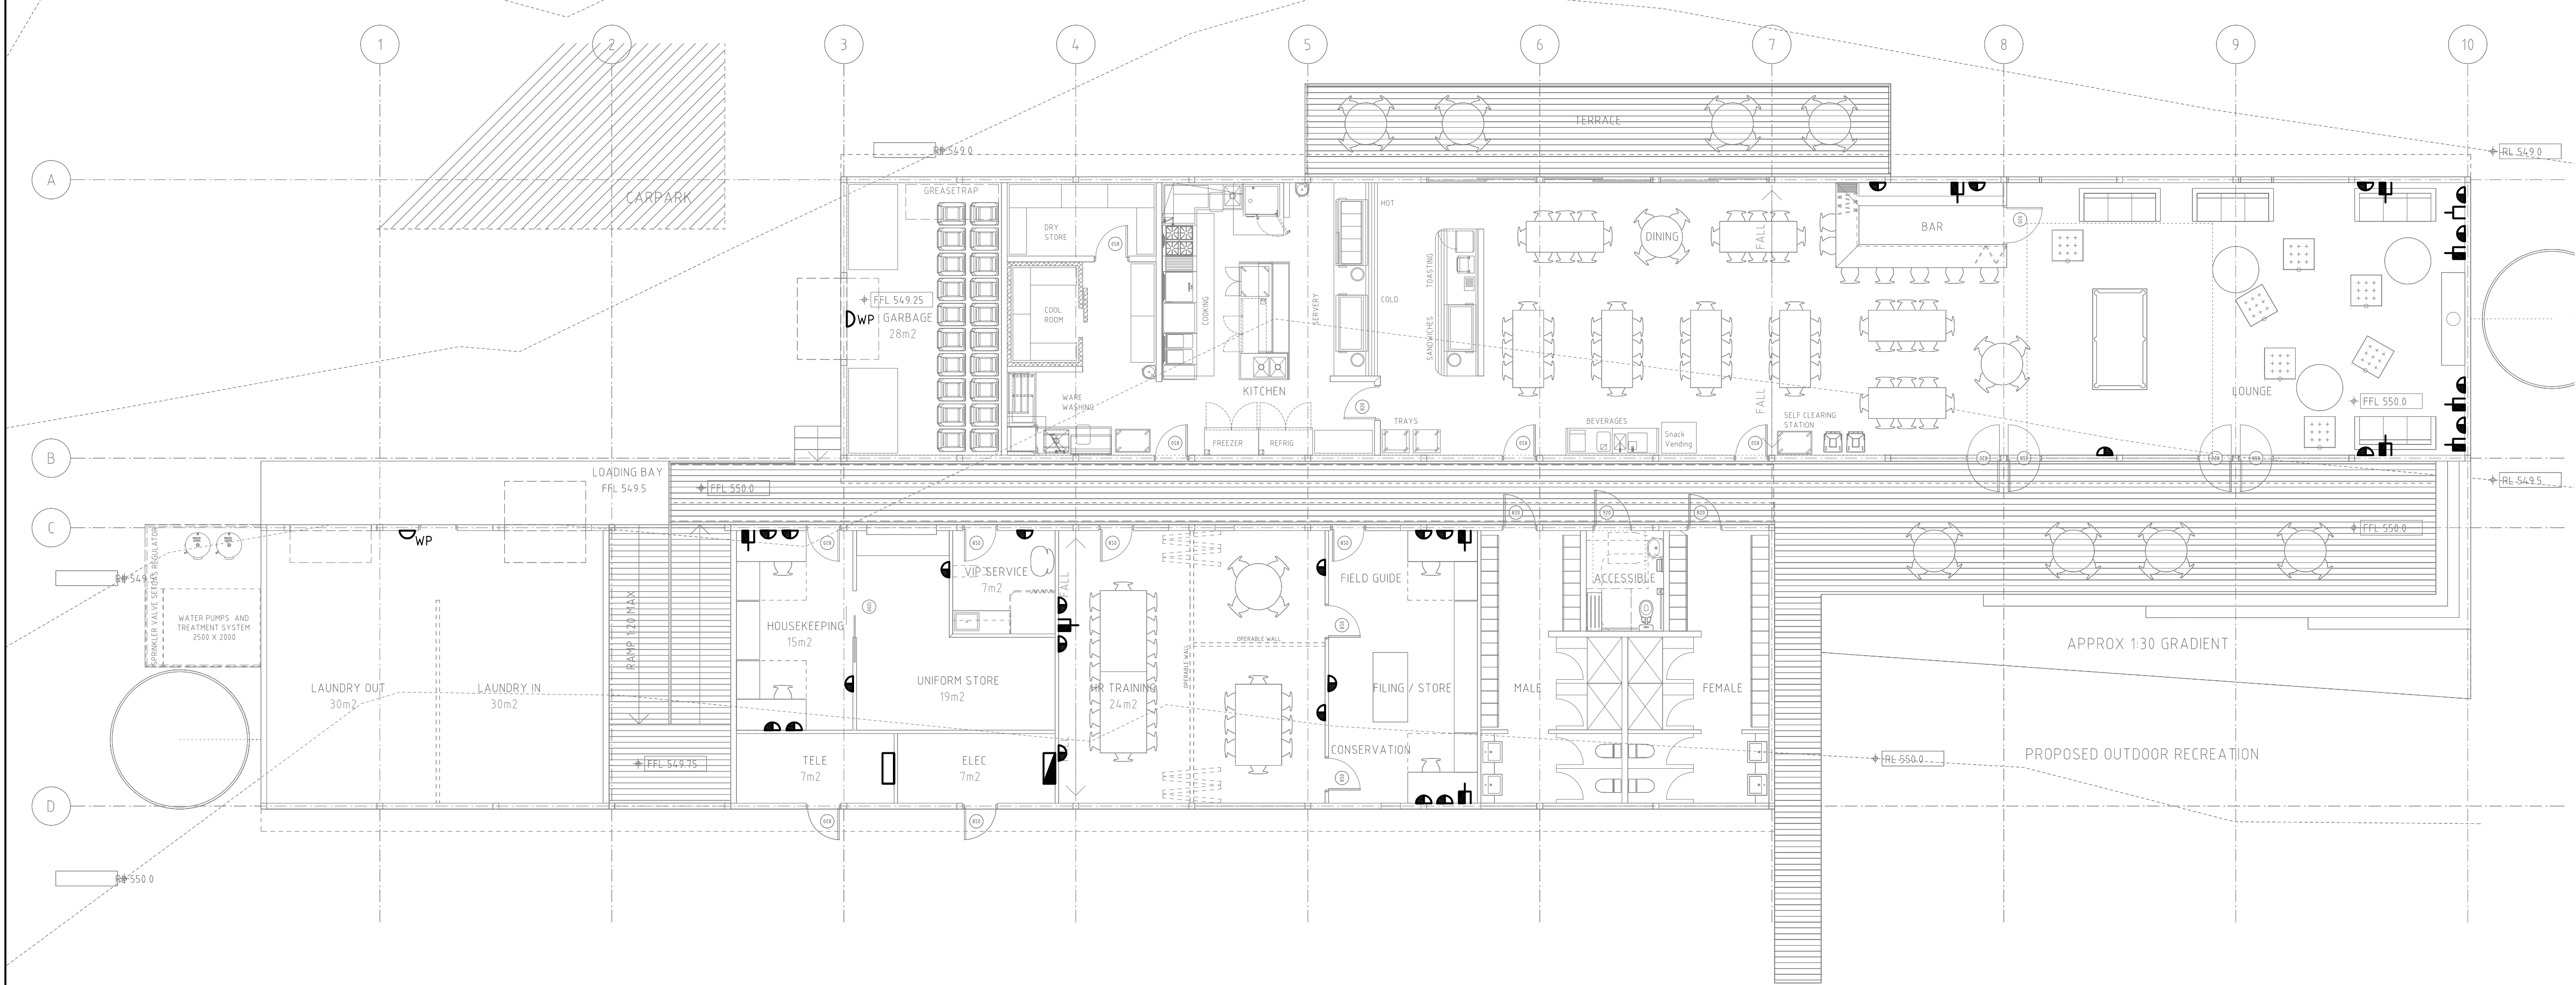

POWER LAYOUT

NOTES

- THIS DRAWING SHALL BE READ IN CONJUNCTION WITH THE ELECTRICAL SERVICES SECTION OF THE SPECIFICATION, THE ARCHITECTURAL DRAWINGS AND ALL OTHER RELEVANT SERVICES DRAWINGS.
- ALL EQUIPMENT AND ACCESSORIES ARE NEW UNLESS NOTED OTHERWISE.
- FINAL POSITION OF ALL EQUIPMENT TO BE DETERMINED ON SITE PRIOR TO INSTALLATION. REFER TO ARCHITECTURAL FITOUT DRAWINGS.
- RATINGS AND TERMINATIONS OF ALL EQUIPMENT TO BE CONFIRMED WITH SUPPLIER/MANUFACTURER'S RECOMMENDATIONS PRIOR TO INSTALLATION.

REV.	DESCRIPTION	DRAWN	APP'D	DATE
PA	PRELIMINARY ISSUE	JRR	APP'D	--/--/06

Client

Emirates - Sydney
Level 9, 1 York Street
Sydney, NSW 2000
T 02 9290 9786
F 02 9299 9722



Project Manager

Clifton Coney Group Pty Ltd
Level 18, Citigroup Centre
Sydney, NSW 2000
T 02 9287 2100
F 02 9287 2188




Architect

TURNER+ASSOCIATES

LEVEL 1/ 586 CROWN STREET SURRY HILLS NSW 2010
T 02 9690 2855 F 02 9690 2411
NOMINATED ARCHITECT: Nicholas Turner 6695
DLQ QUALITY ENDORSED COMPANY ISO 9001:2000 LICENCE NUMBER 4168

Interior Designer

Chhada Siembieda
30 Boronia Street
Redfern, NSW 2016
T 02 9318 2627
F 02 9318 2151

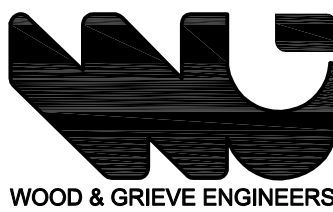

Wood & Griev Pty Ltd
A.C.N. 008 938 786
203 Ryde Road
PYMBLE NSW 2073
Phone 02 9484 7000
Fax 02 9484 7100
Email wge@wge.com.au
Web www.wge.com.au

PROJECT:
EMIRATES LUXURY RESORT
WOLGAN VALLEY
NEW SOUTH WALES

TITLE:
ELECTRICAL SERVICES
STAFF AMENITY BUILDING
LIGHTING, POWER, COMMUNICATIONS
AND SECURITY LAYOUTS

PRELIMINARY
NOT FOR CONSTRUCTION

DESIGNED :	LVS	VERIFIED :	-	--/--/06
DRAWN :	JRR	APPROVED FOR TENDER :	-	--/--/06
SCALE :	1:100	APPROVED FOR CONSTRUCTION :	-	--/--/06
CAD FILE:	18438-SYD-E/ELEC/E-24	1141	18/10/06	

DRAWING No.	REVISION
18438-SYD-E-24	PA