



NOTES


- THIS DRAWING SHALL BE READ IN CONJUNCTION WITH THE ELECTRICAL SERVICES SECTION OF THE SPECIFICATION, THE ARCHITECTURAL DRAWINGS AND ALL OTHER RELEVANT SERVICES DRAWINGS.
- ALL EQUIPMENT AND ACCESSORIES ARE NEW UNLESS NOTED OTHERWISE.
- FINAL POSITION OF ALL EQUIPMENT TO BE DETERMINED ON SITE PRIOR TO INSTALLATION. REFER TO ARCHITECTURAL FITOUT DRAWINGS.
- RATINGS AND TERMINATIONS OF ALL EQUIPMENT TO BE CONFIRMED WITH SUPPLIER/MANUFACTURER'S RECOMMENDATIONS PRIOR TO INSTALLATION.
- INSTALL PATHWAY LIGHTING DISTRIBUTION BOARDS TO VILLAS' PLANTROOM AREAS, WHERE SHOWN ON THE DRAWINGS. DISTRIBUTION BOARDS TO HAVE WEATHERPROOF ENCLOSURE WITH LOCKABLE DOOR. WIRE DISTRIBUTION BOARDS TO THE NEAREST ELECTRICAL PILLAR.

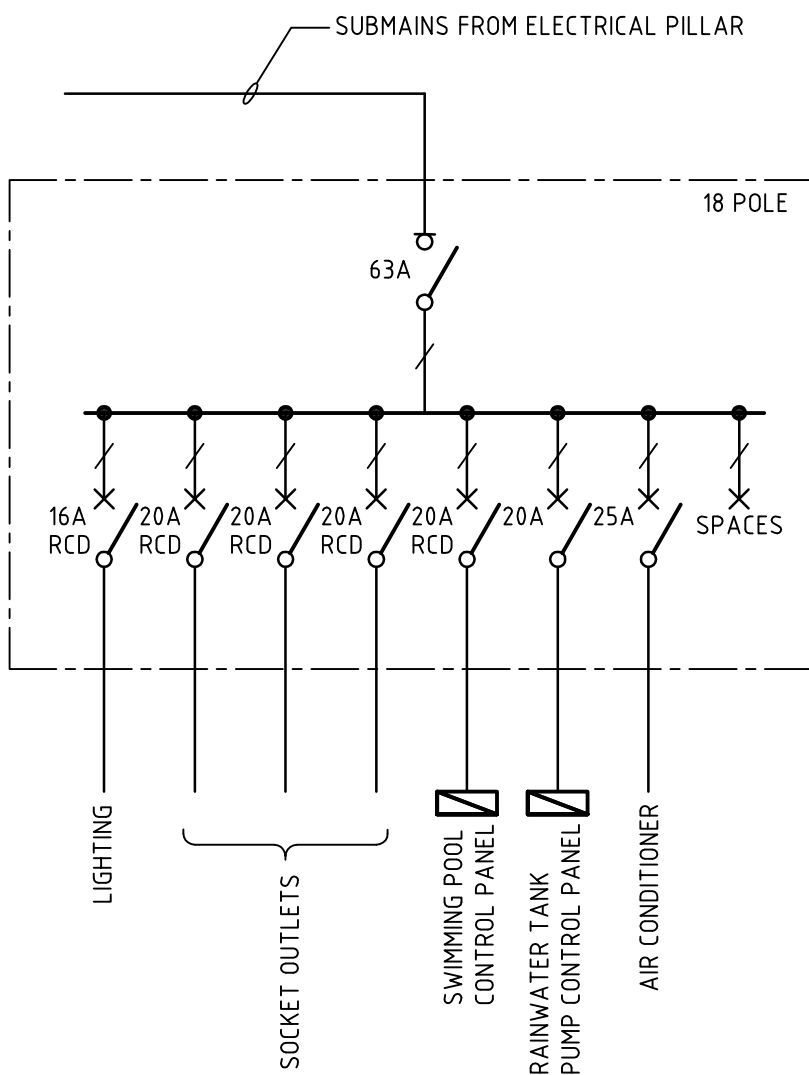


1 BEDROOM VILLA-DB SCHEMATIC

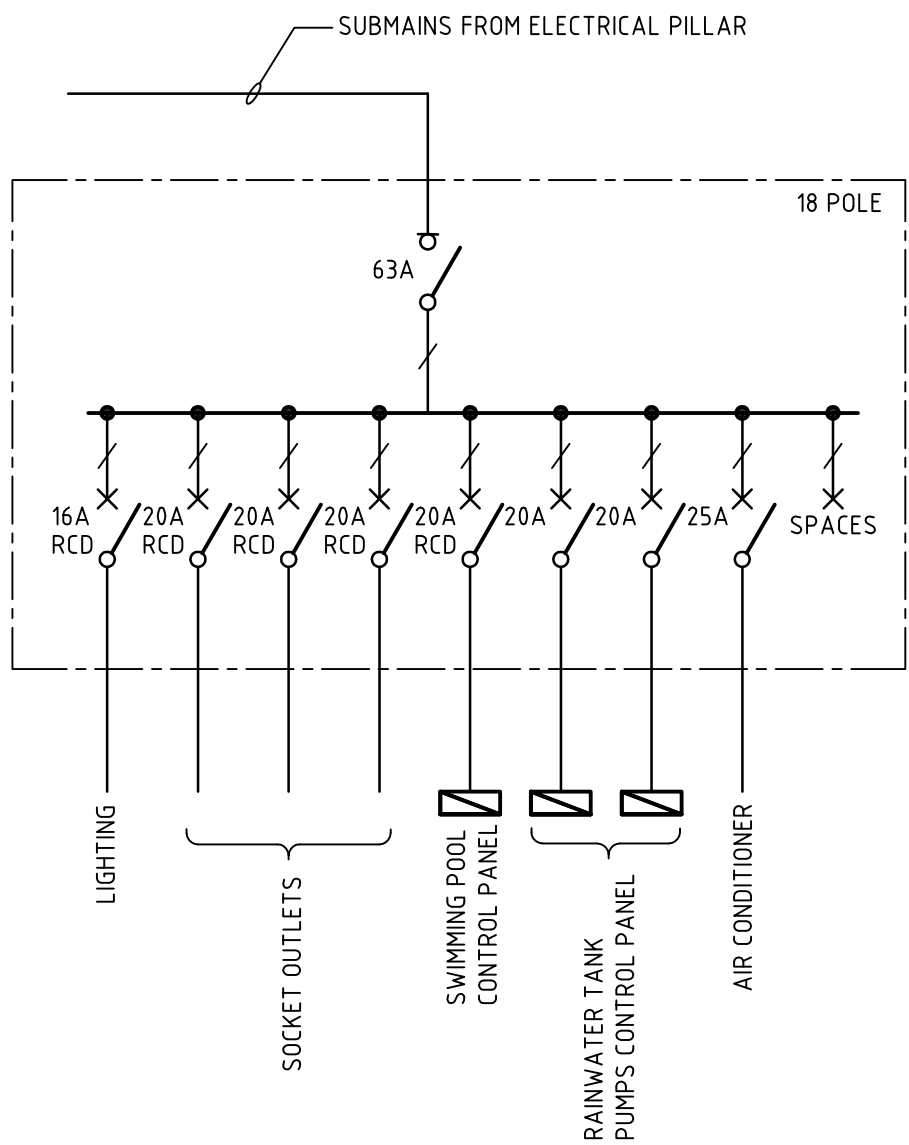


2 BEDROOM VILLA-DB SCHEMATIC

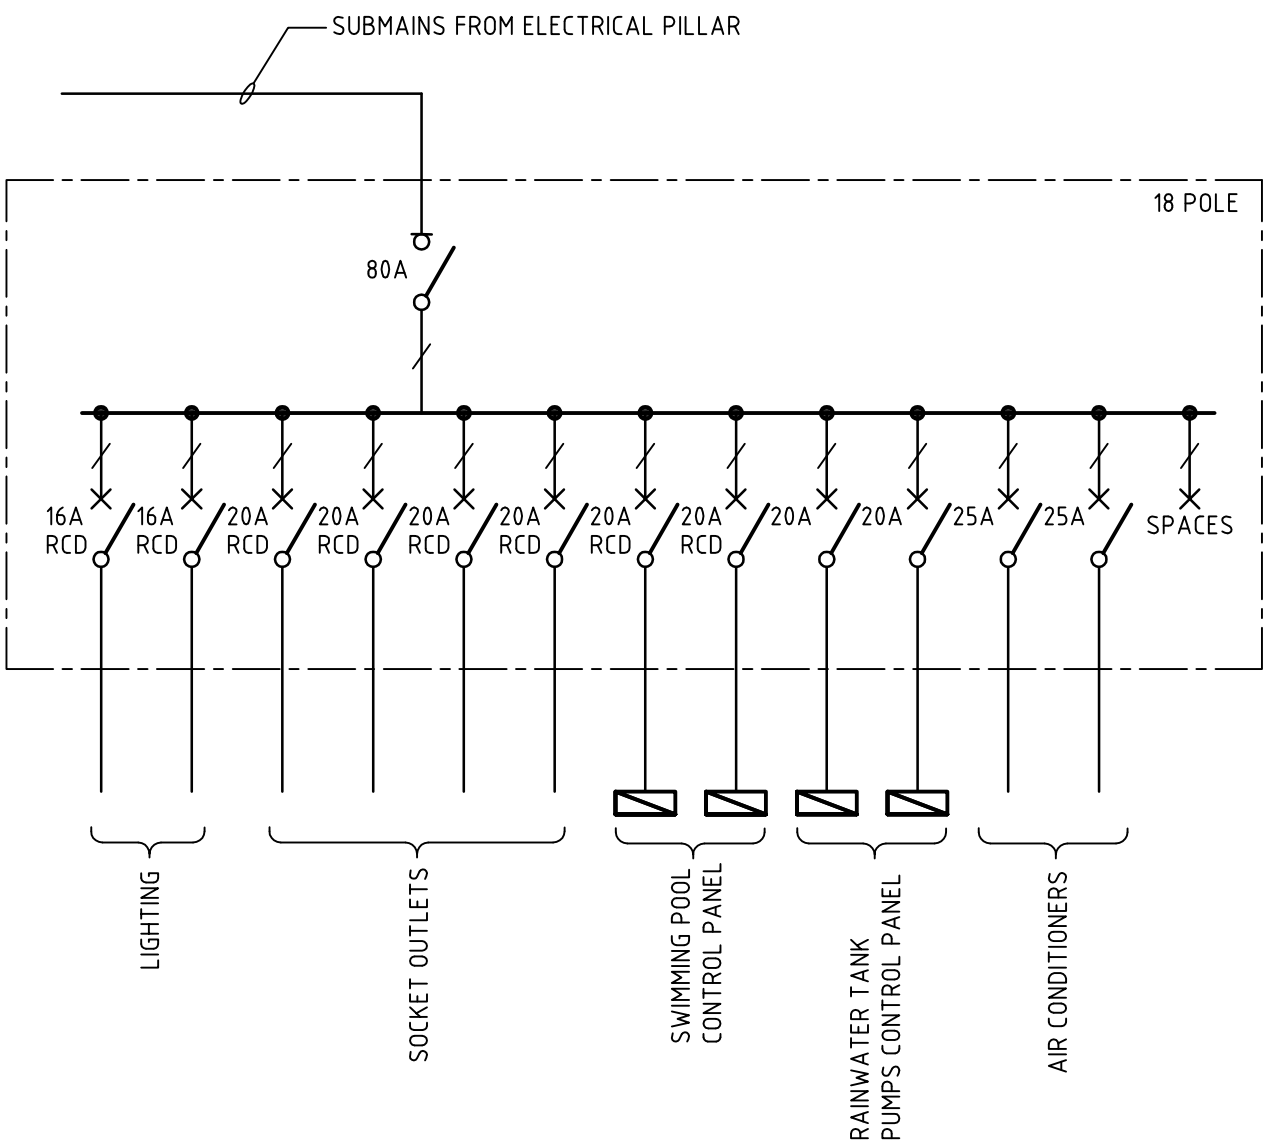

DUPLEX VILLA-DB SCHEMATIC

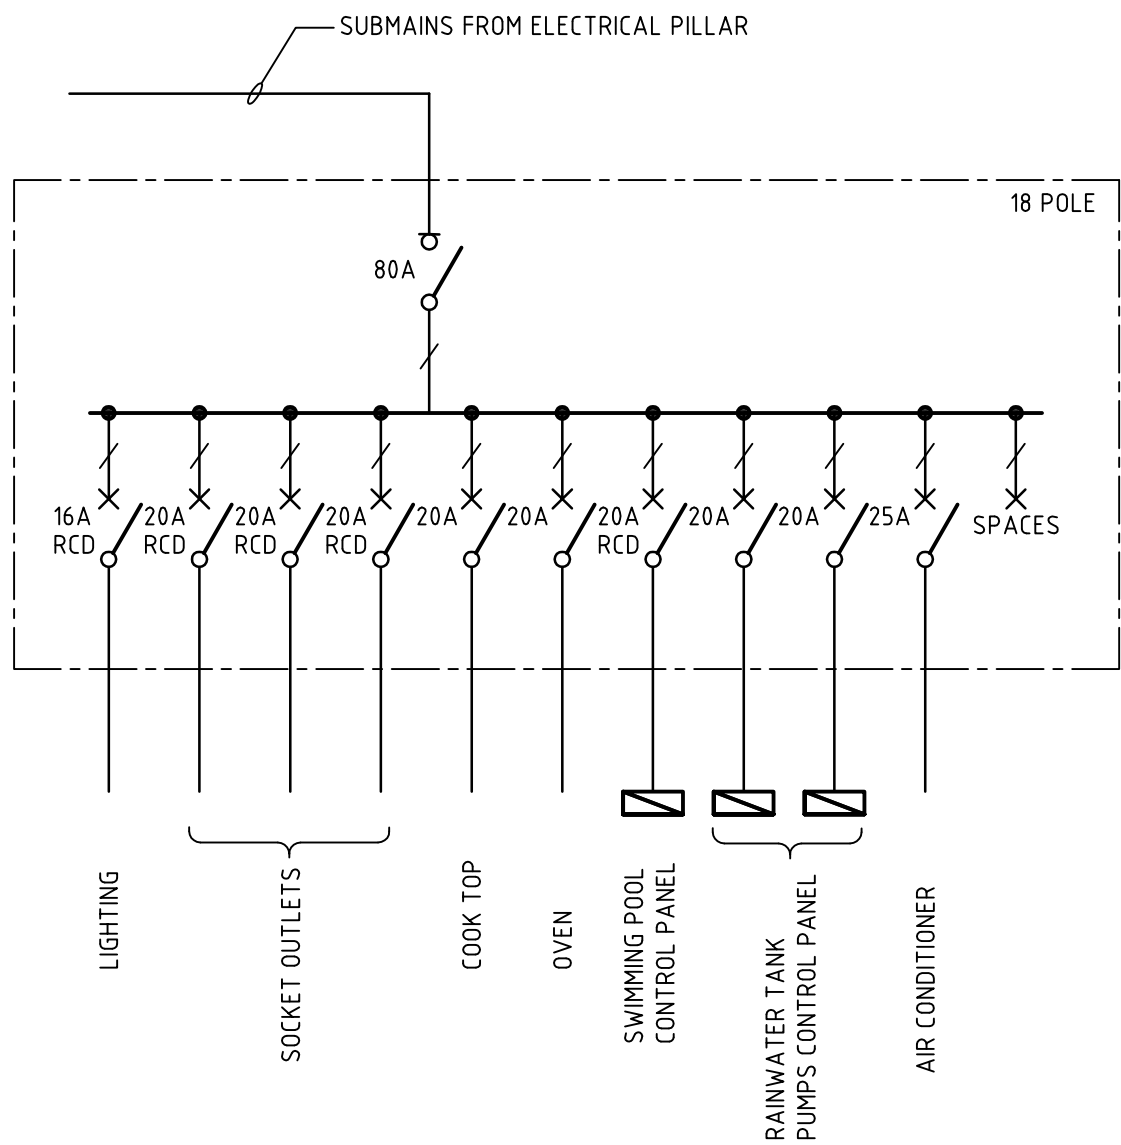

OWNER'S VILLA-DB SCHEMATIC

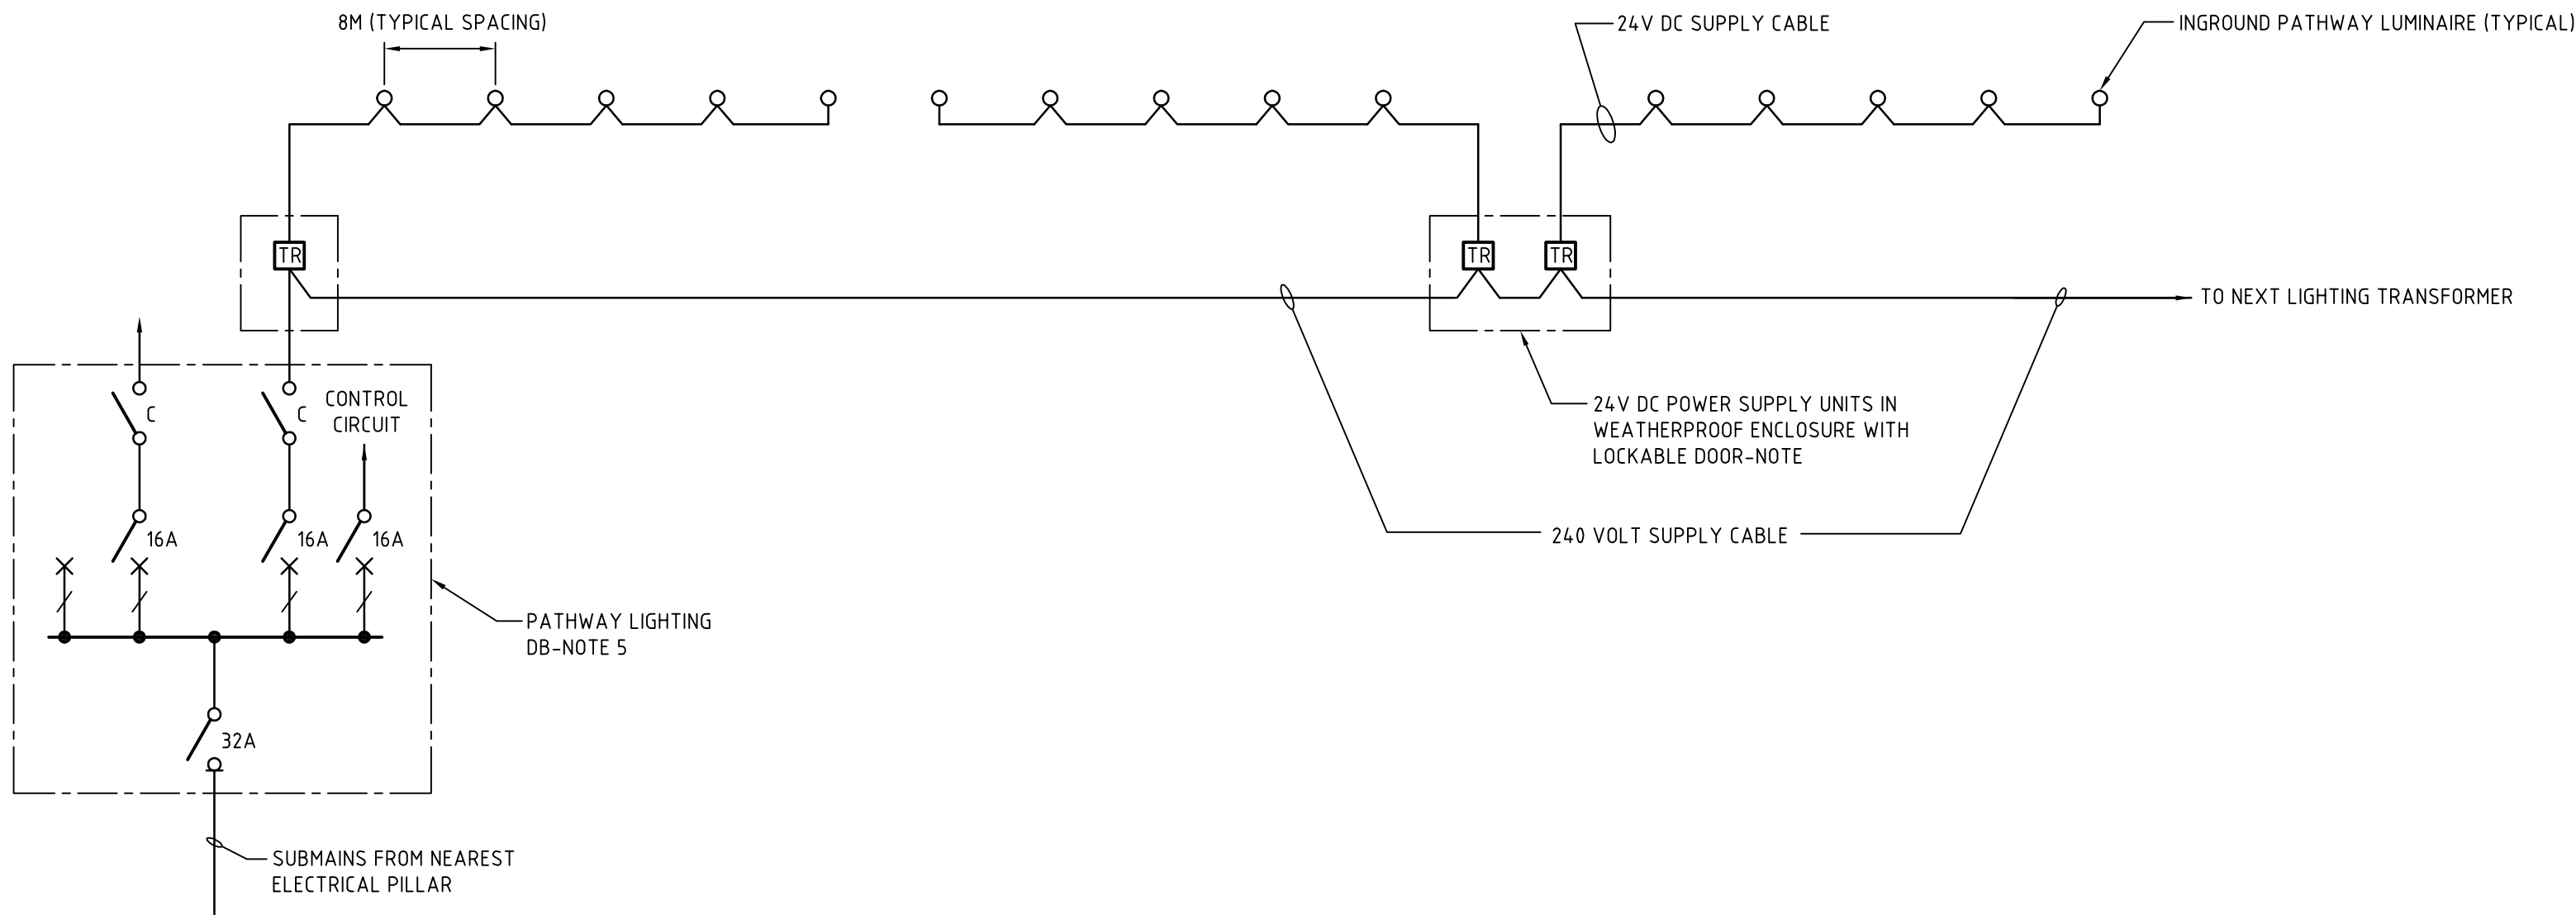

PATHWAY LIGHTING ARRANGEMENT DIAGRAM
(TYPICAL FOR PATHWAY LIGHTING AT RESORT PRECINCT)

PA	PRELIMINARY ISSUE	JRR	APP'D	5/09/06
REV.	DESCRIPTION	DRAWN	APP'D	DATE

Client

Emirates - Sydney
Level 9, 1 York Street
Sydney, NSW 2000
T 02 9290 9786
F 02 9299 9722



Project Manager

Clifton Coney Group Pty Ltd
Level 18, Citigroup Centre
Sydney, NSW 2000
T 02 9287 2100
F 02 9287 2188



Architect

TURNER+ASSOCIATES

LEVEL 1/ 586 CROWN STREET SURRY HILLS NSW 2010
T 02 9690 2855 F 02 9690 2411
NOMINATED ARCHITECT: Nicholas Turner 6695
DLQ QUALITY ENDORSED COMPANY ISO 9001:2000 LICENCE NUMBER 4168

Interior Designer

Chhada Siembieda
30 Boronia Street
Redfern, NSW 2016
T 02 9318 2627
F 02 9318 2151



Wood & Griev Pty Ltd
A.C.N. 008 938 786
2/33 Ryde Road
PYMBLE NSW 2073
Phone 02 9484 7000
Fax 02 9484 7100
Email wge@wge.com.au
Web www.wge.com.au



PROJECT:
EMIRATES LUXURY RESORT
WOLGAN VALLEY
NEW SOUTH WALES

TITLE:
ELECTRICAL SERVICES
RESORT PRECINCT RETICULATION
DBS-SINGLE LINE DIAGRAM

PRELIMINARY
NOT FOR CONSTRUCTION

DESIGNED :	LVS	VERIFIED :	-	--/--/06
DRAWN :	JRR	APPROVED FOR TENDER :	-	--/--/06
SCALE :	N.T.S.	APPROVED FOR CONSTRUCTION :	-	--/--/06
CAD FILE:	18438-SYD-E/ELEC/E-26	1121	26/09/06	

DRAWING No.	REVISION
18438-SYD-E-26	PA