


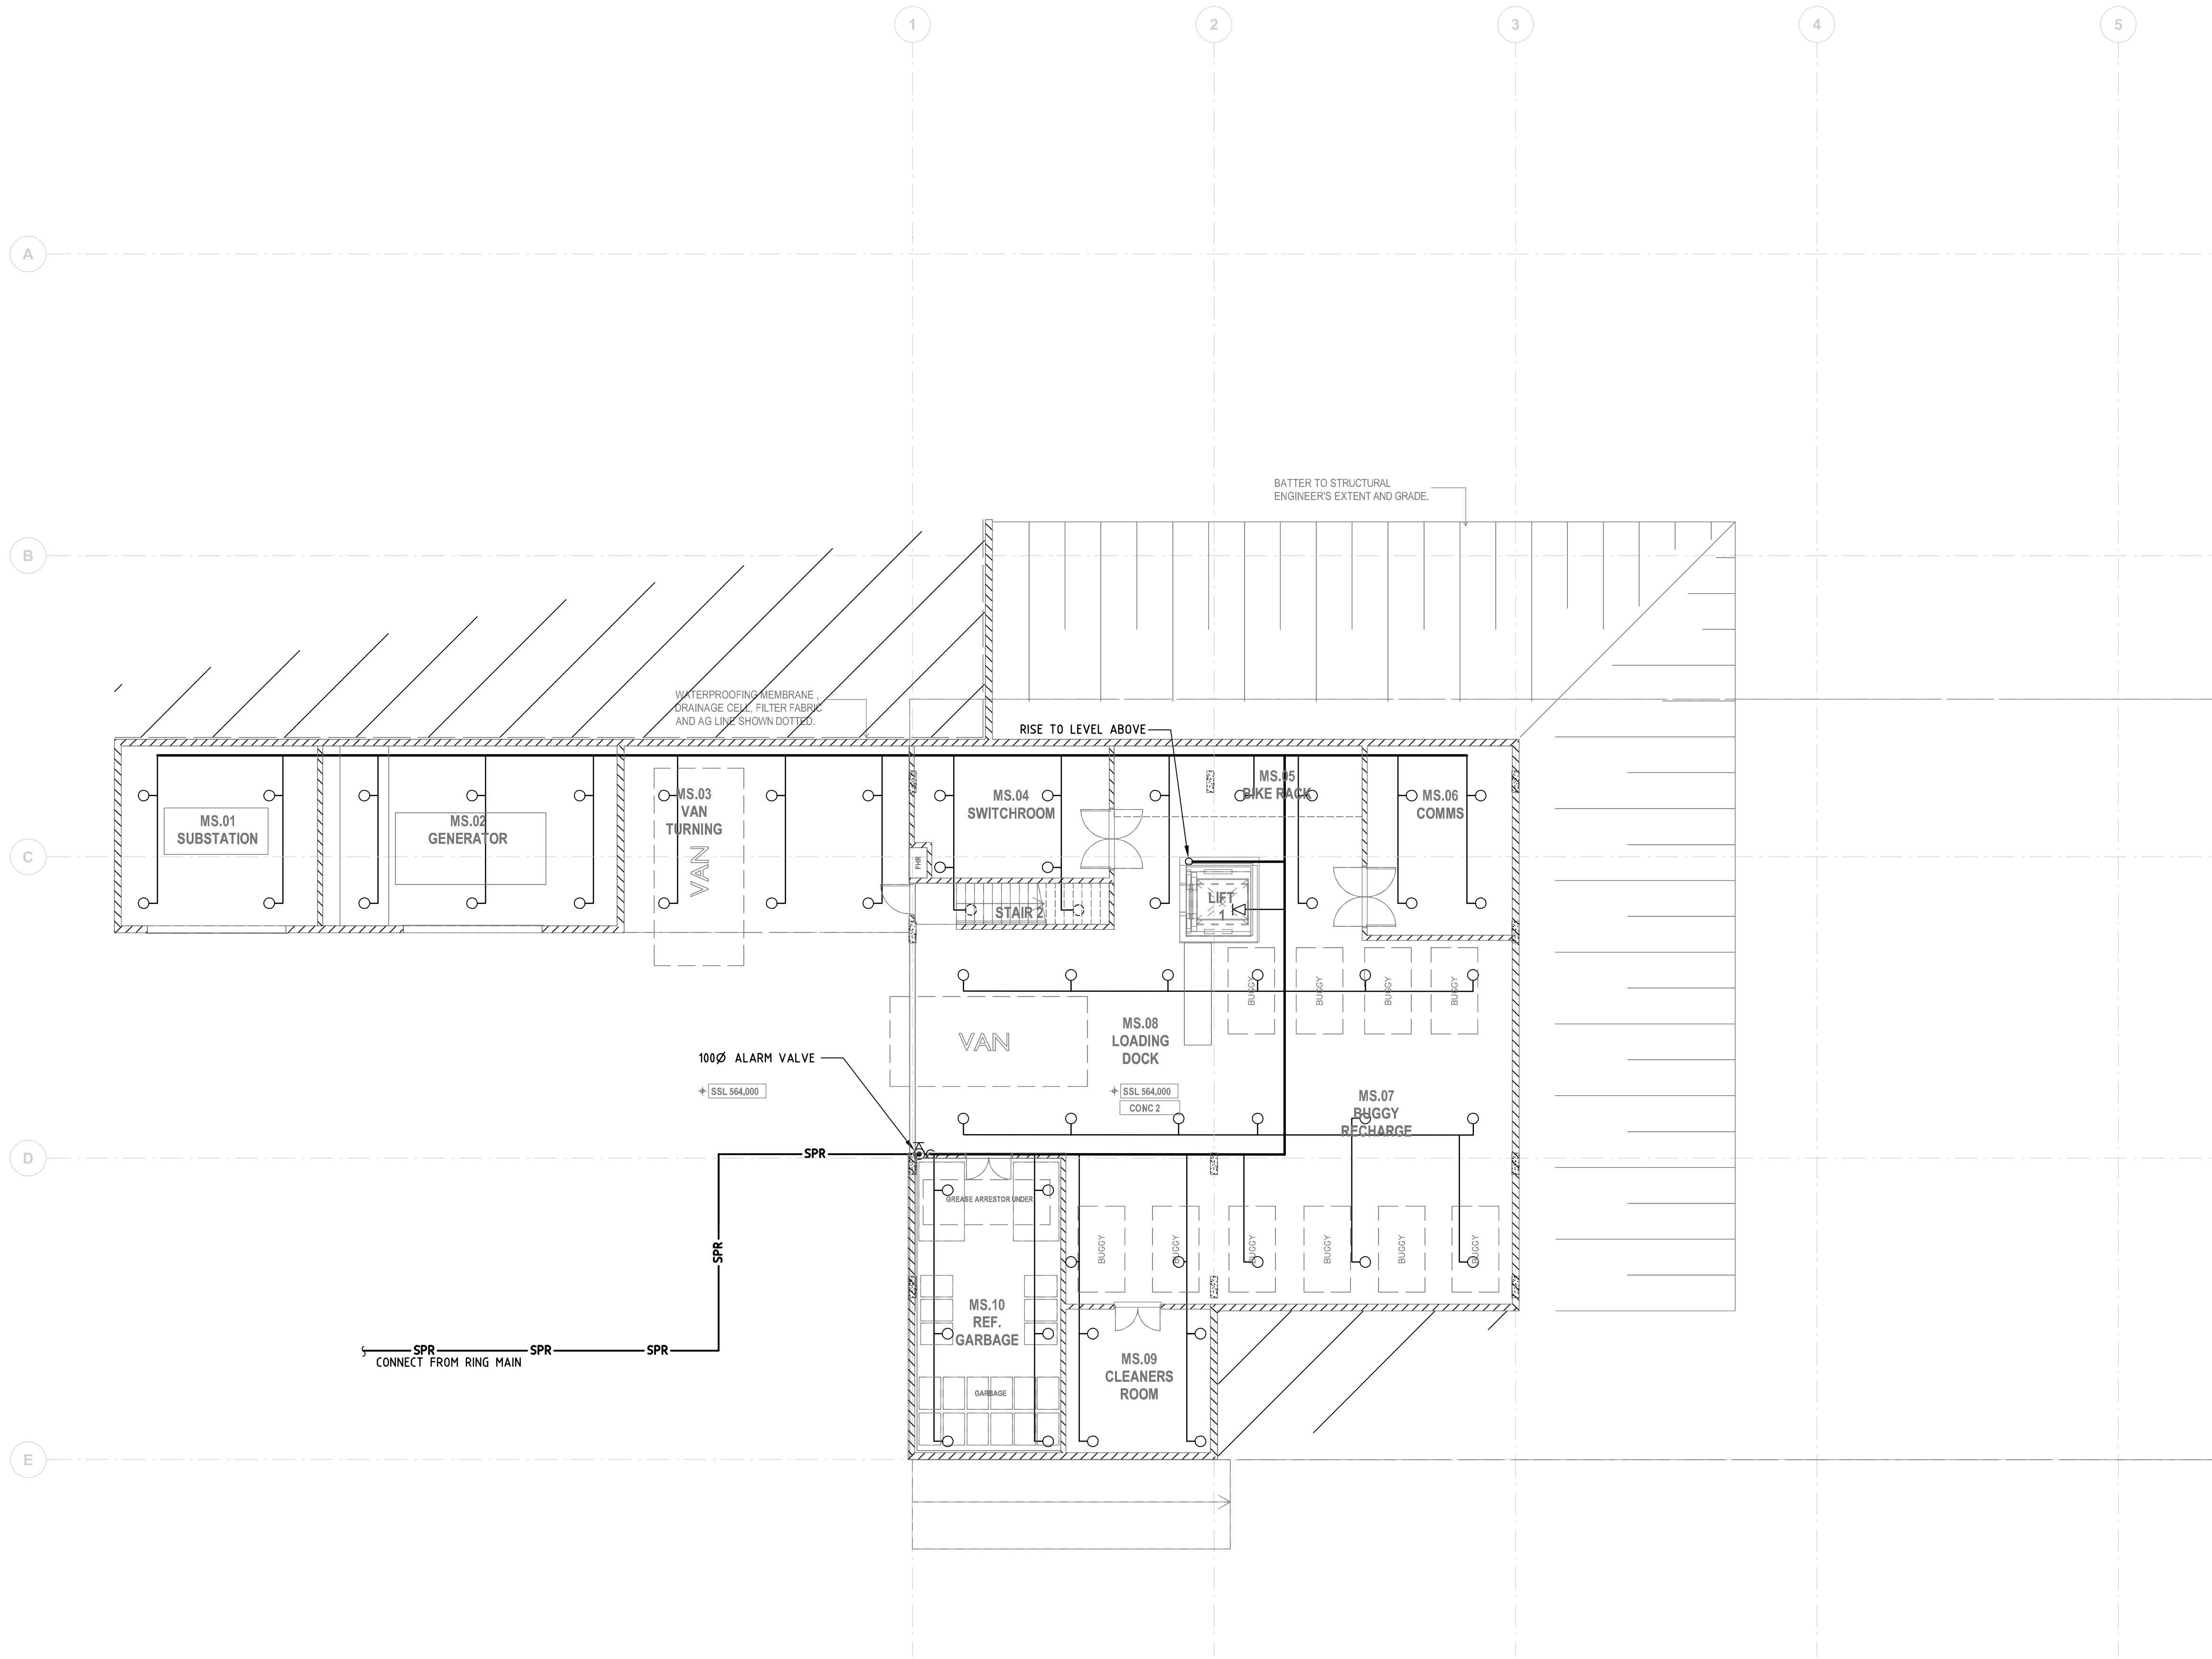

PRELIMINARY ISSUE

NOTE : SYMBOLS ARE DRAWN IN THE CORRECT POSITION BUT ARE NOT SHOWN TO SCALE

Issue	Date	Amendment	Int.	App.
1	20.10.06	TENDER REVIEW	ER	DC

Client:



Emirates

Project Manager:



CliftonConey Group
CLIFTON CONEY GROUP PTY LTD
Level 18, Citigroup Centre
SYDNEY NSW 2000
T 02 9287 2100
F 02 9287 2188

Architect:

TURNER + ASSOCIATES

LEVEL 1/ 586 CROWN STREET
SURRY HILLS NSW 2010
T 02 9690 2855
F 02 9690 2411

NOMINATED ARCHITECT: Nicholas Turner 6695
DLQ QUALITY ENDORSED COMPANY ISO 9001:2000
LICENCE NUMBER 4188

Hydraulic Consultant:



STEVE PAUL & PARTNERS
Hydraulic Fire Environmental
A.C.N. : 088 131 793 A.B.N. : 78 088 131 793
EMAIL: mail@sydspap.com.au
WEBSITE: http://www.stevepaulpartners.com

Level 3 - 432 Kent St.
SYDNEY NSW 2000
Ph (02) 9261 1300
Fax (02) 9261 1600




Project:

**EMIRATES LUXURY RESORT
WOLGAN VALLEY**

Drawing Title:

**FIRE SPRINKLER SERVICES
MAIN BUILDING
SERVICES FLOOR PLAN**

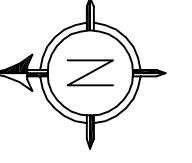North Point:	Design:
	ED REA
Date:	Design Validated:
AUGUST 2006	DARREN CAMPBELL
Job No:	Amendment Approved:
S05066 - F - 100 - PR - 1	
Scale:	Drawn:
(A1) 1:100 (A3)	HERBERT XIA
Disc:	Stage:
Issue:	

FILE NAME & PATH: C:\Users\2005\325566 - Emirates Luxury Resort - Uthmaniyah\NSW\CAD Section\SPR Drawing\FIREY-100-MAIN BUILDING SERVICES FLOOR.dwg
PLOT DATE & TIME: 23 Oct. 2006 - 3:40pm
PLOTTED BY: me

ORIGINAL SIZE: A1