

NOTE : SYMBOLS ARE DRAWN IN THE CORRECT POSITION BUT ARE NOT SHOWN TO SCALE

Issue	Date	Amendment	Int.	App.
1	20.10.06	TENDER REVIEW	ER	DC



Client:  
**CliftonConey Group**  
 CLIFTON CONEY GROUP PTY LTD  
 Level 18, Citigroup Centre  
 SYDNEY NSW 2000  
 T 02 9287 2100  
 F 02 9287 2188

Architect:  
**TURNER + ASSOCIATES**  
 LEVEL 1/ 586 CROWN STREET  
 SURRY HILLS NSW 2010  
 T 02 9690 2855  
 F 02 9690 2411  
 NOMINATED ARCHITECT: Nicholas Turner 6695  
 DLQ QUALITY ENDORSED COMPANY ISO 9001:2000  
 LICENCE NUMBER 4168

Hydraulic Consultant:  
**STEVE PAUL & PARTNERS**  
 SPP  
 Level 3 - 432 Kent St.  
 SYDNEY NSW 2000  
 Ph (02) 9261 1300  
 Fax (02) 9261 1600  
 Hydraulic Fire Environmental  
 A.C.N.: 088 131 793 A.B.N.: 78 088 131 793  
 EMAIL: mail@sydspap.com.au  
 WEBSITE: http://www.stevepaulpartners.com

Project:  
**EMIRATES LUXURY RESORT  
 WOLGAN VALLEY**


Drawing Title:  
**FIRE SPRINKLER SERVICES  
 MAIN BUILDING  
 LOWER FLOOR PLAN**

North Point:

Design: ED REA  
 Design Validated: DARREN CAMPBELL  
 Amendment Approved:  
 Drawn: HERBERT XIA

Date: AUGUST 2006 Scale: (A1) 1:100 (A3)  
 Job No: S05066 - F - 101 - PR - 1  
 Disc: Dwg No: Stage: Issue:

**PRELIMINARY ISSUE**

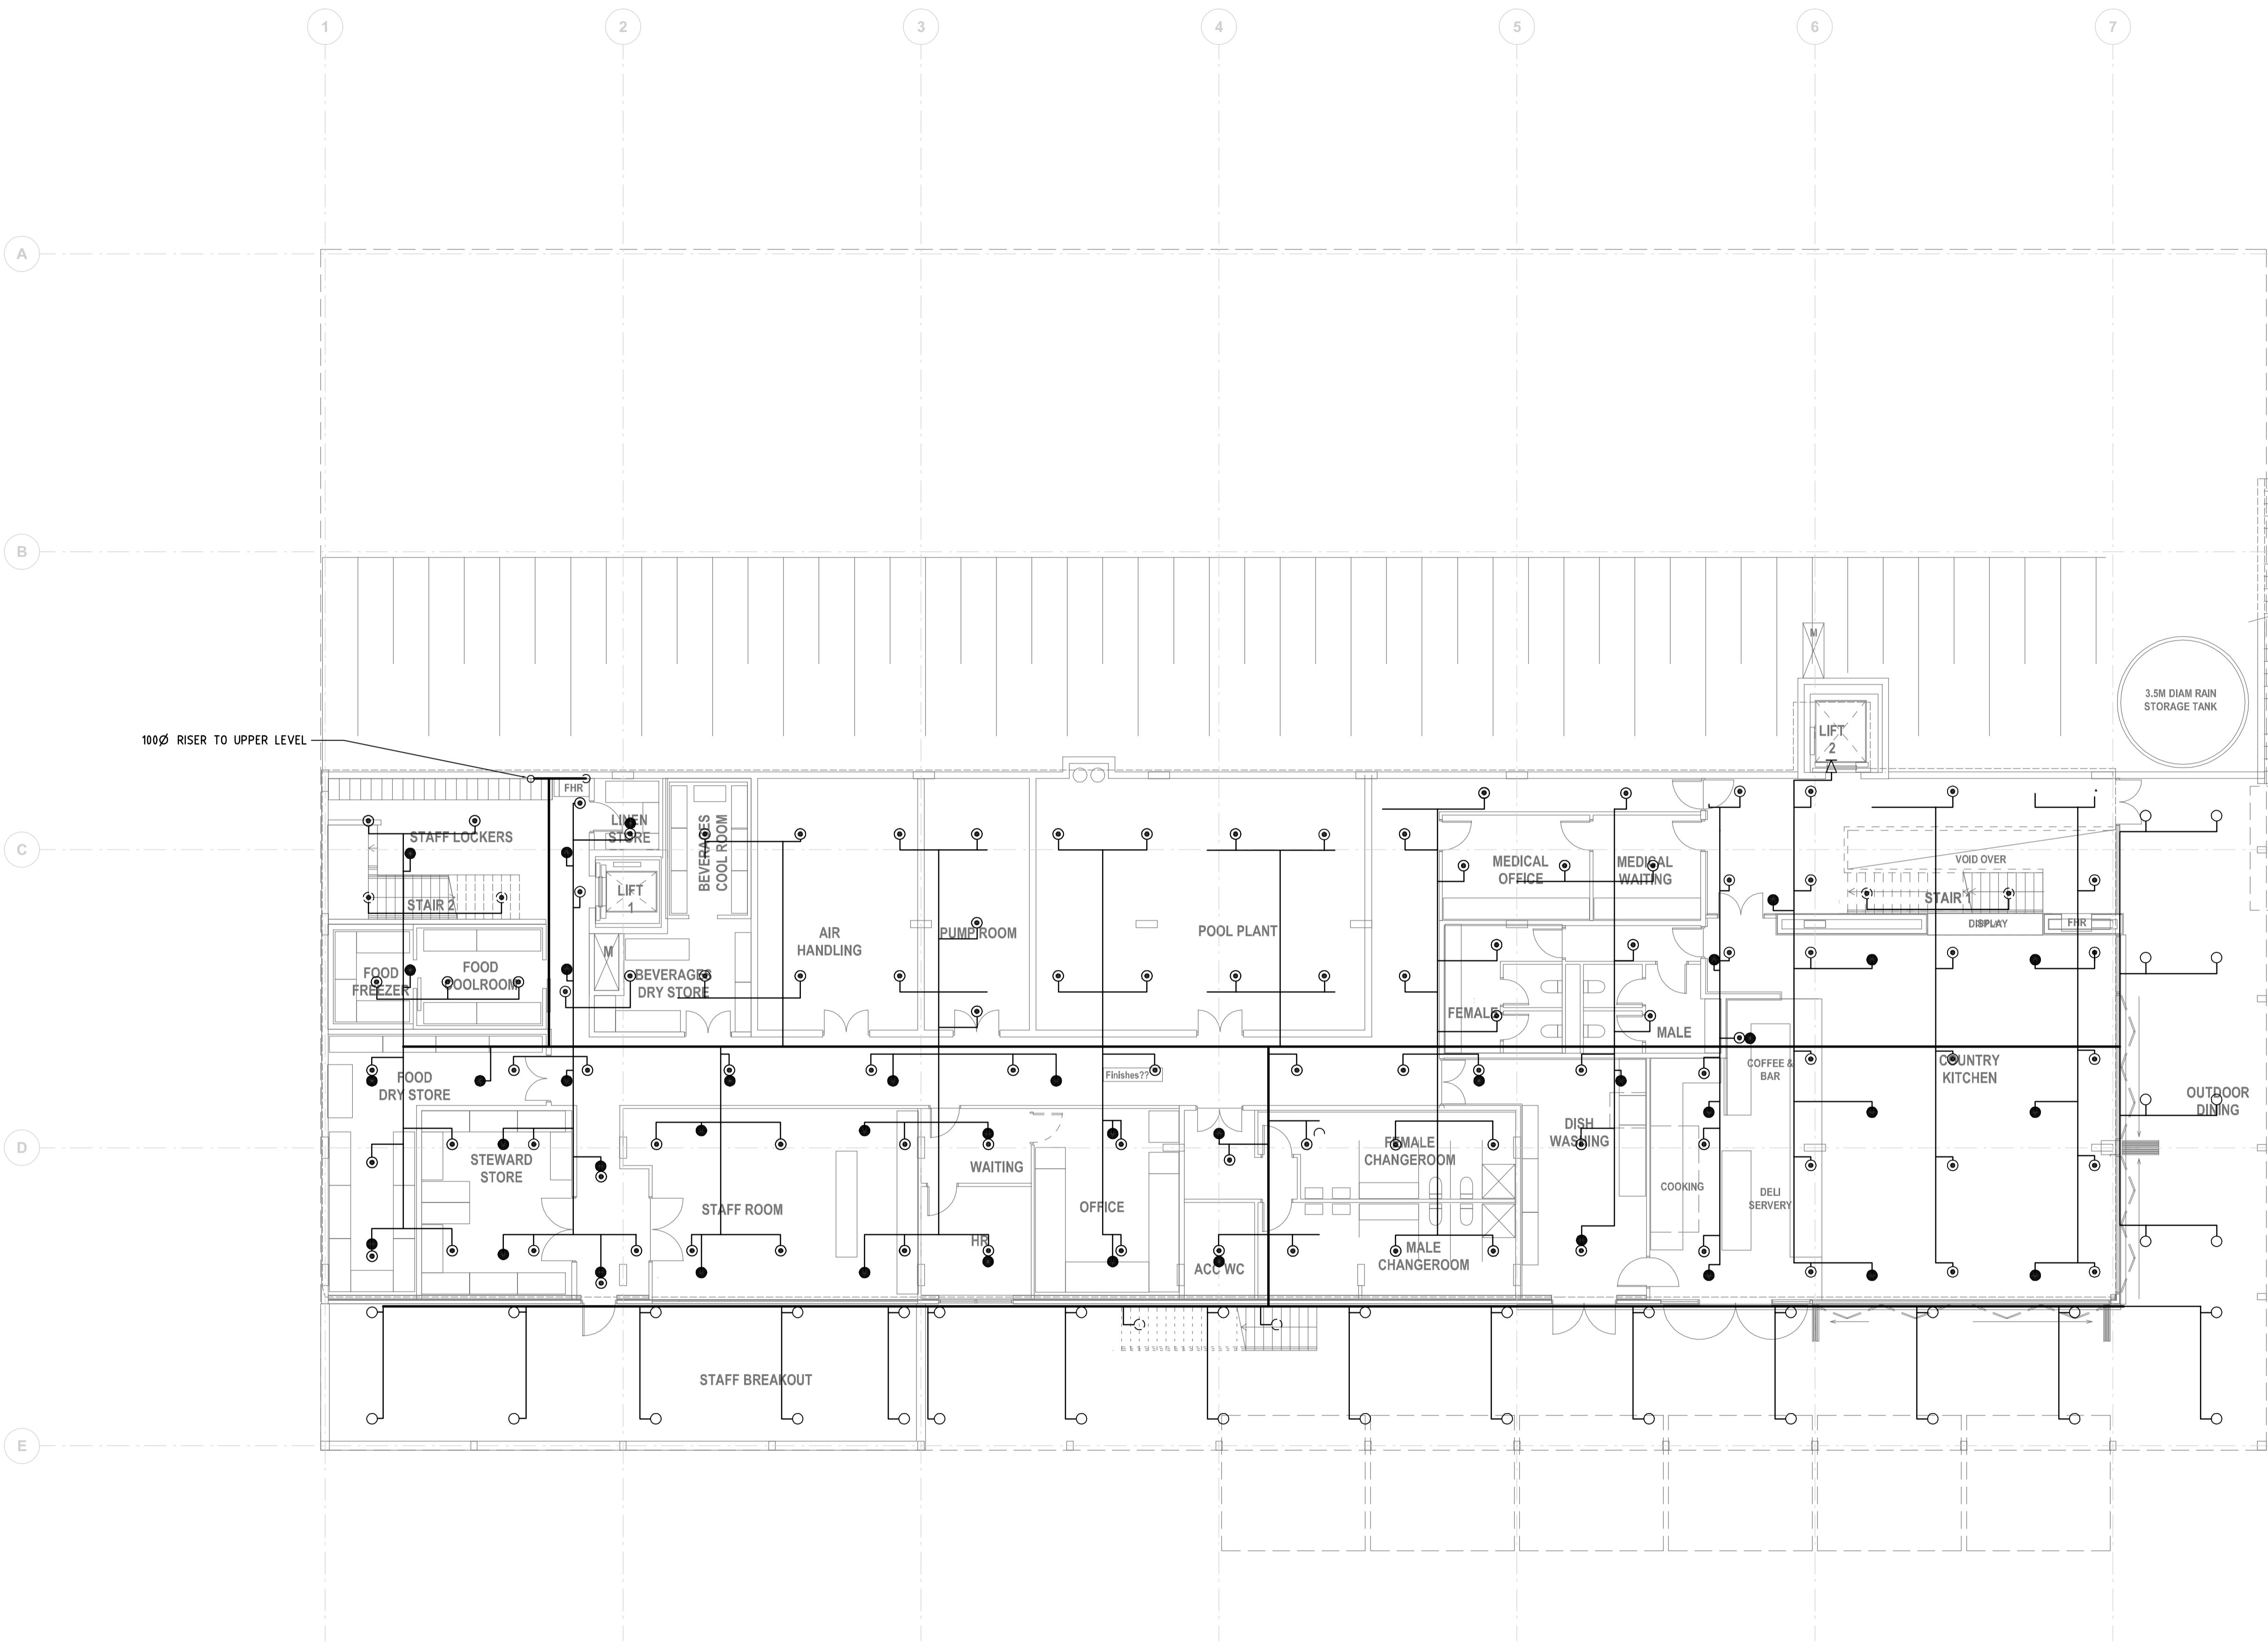

PLOT DATE & TIME: 23 OCT 2006 - 3:40pm PLOTTED BY: m