


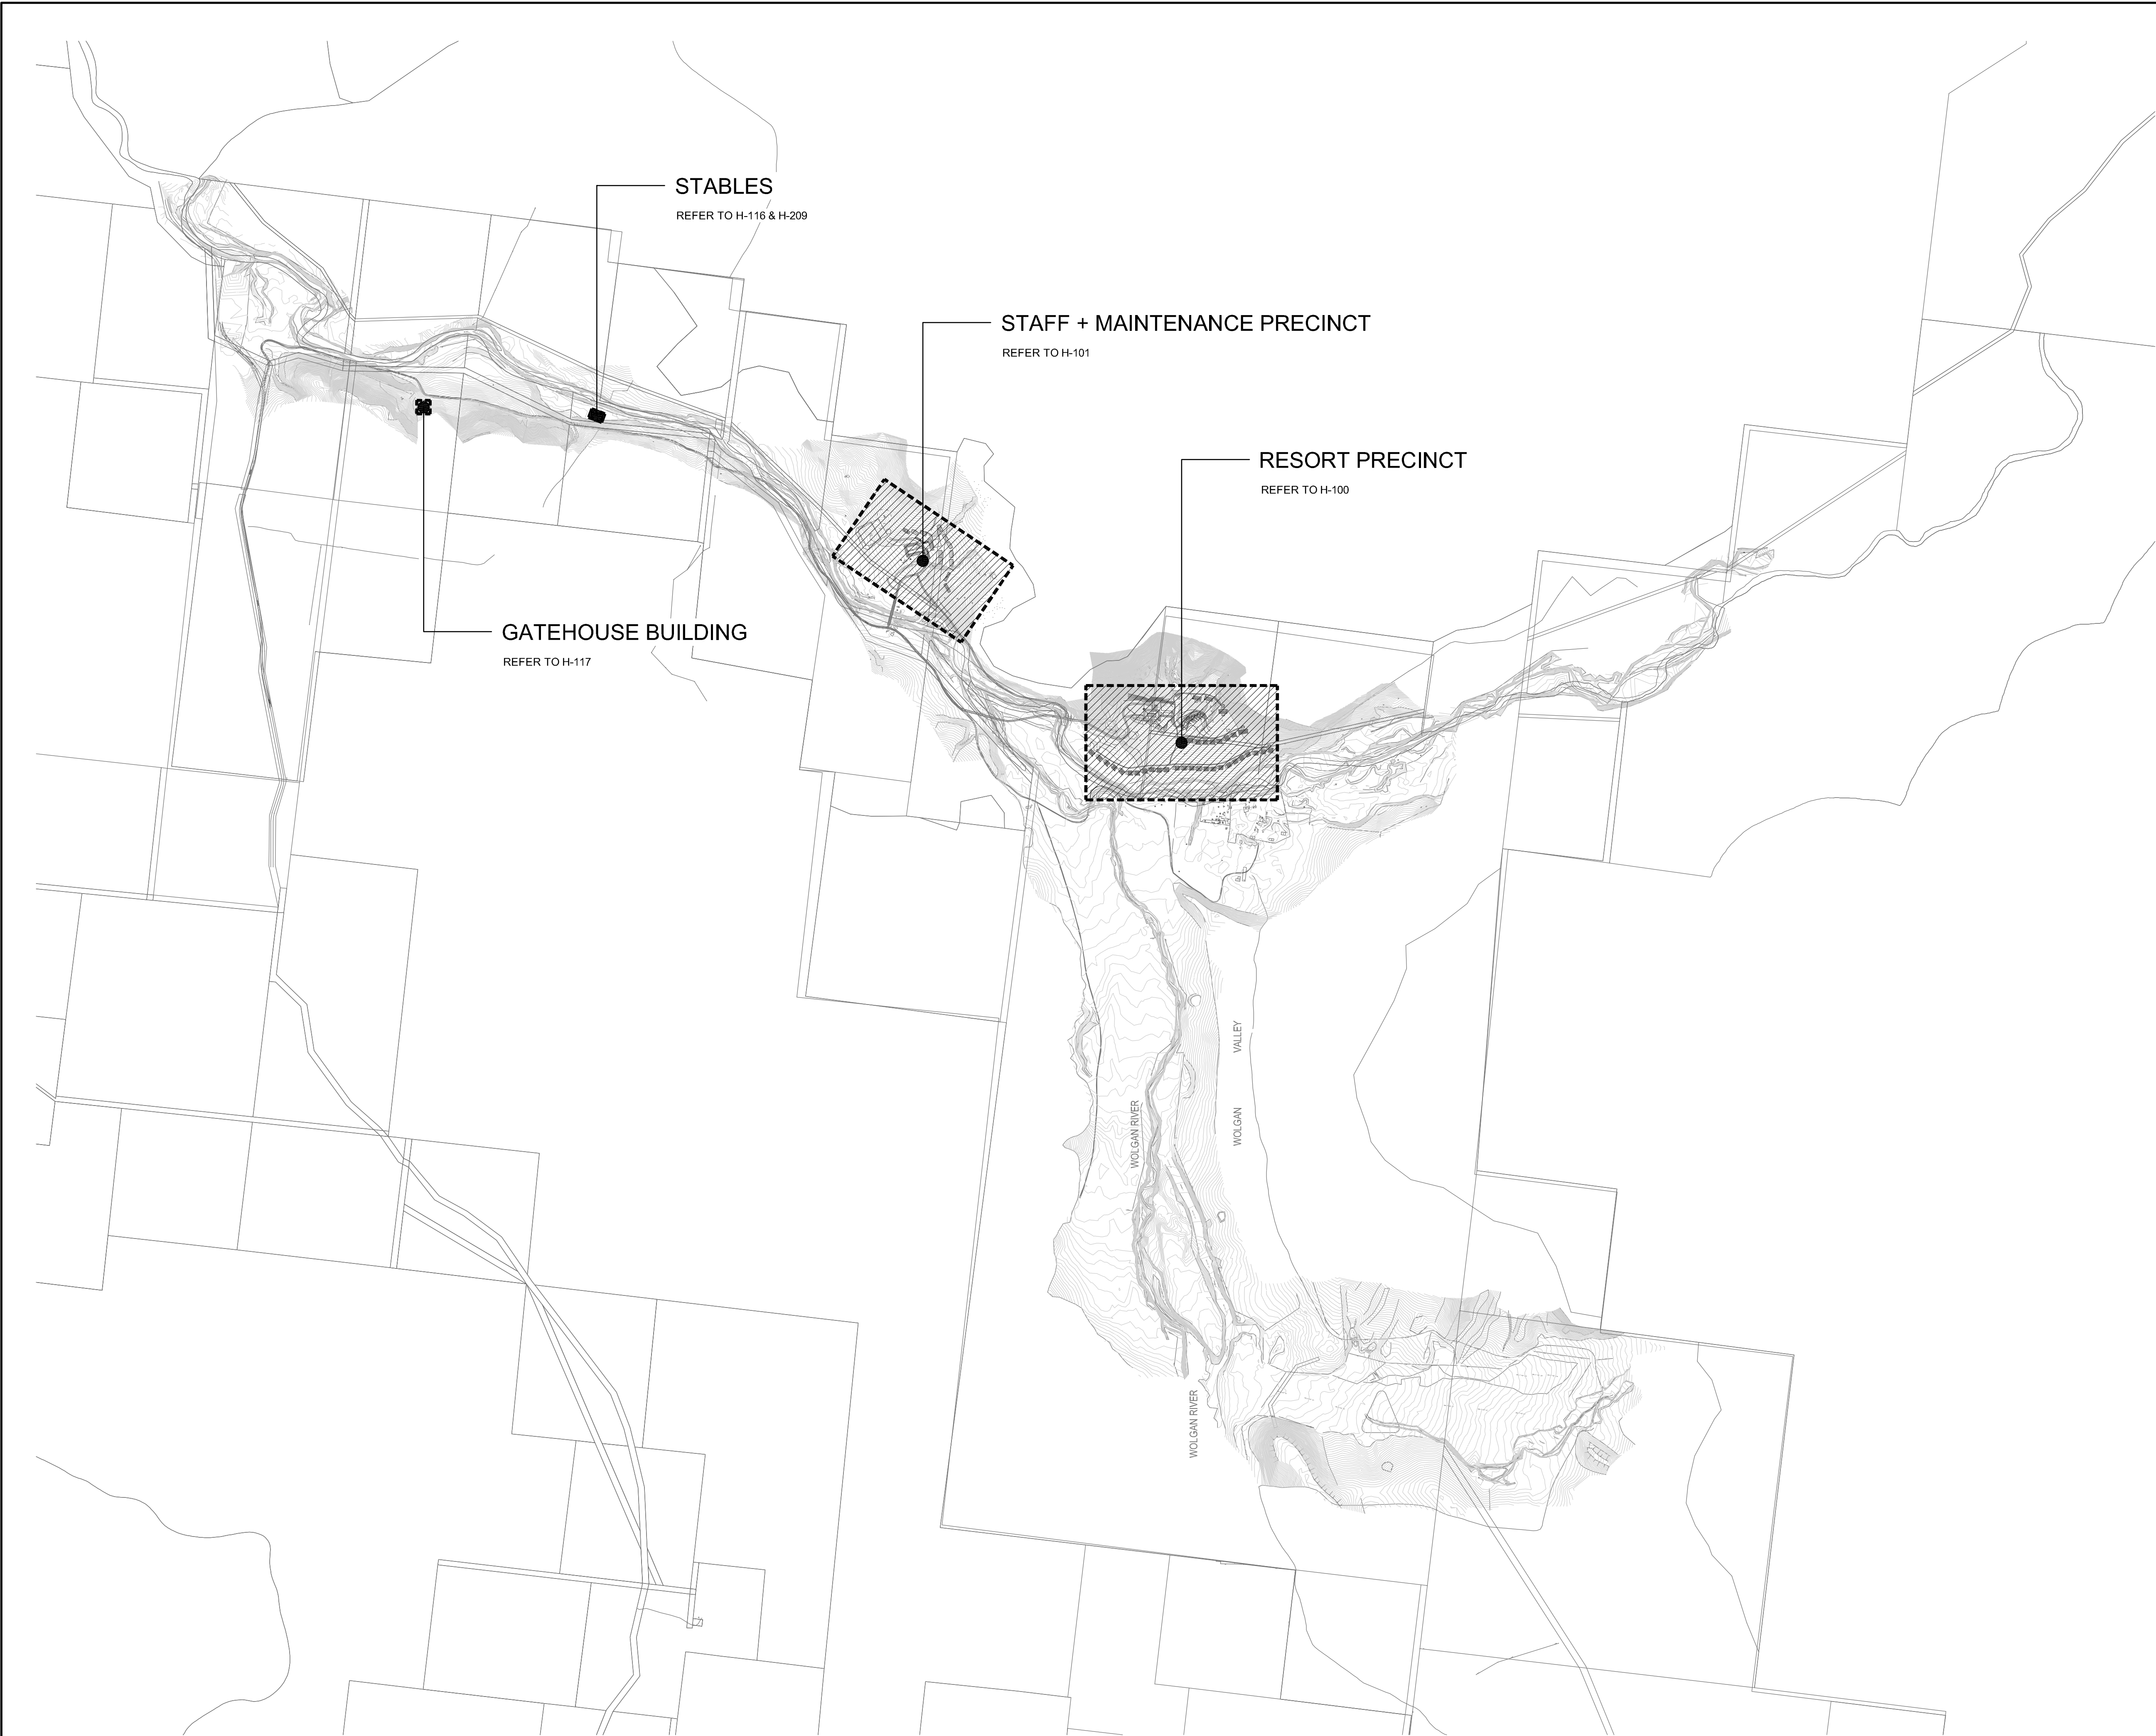

NOTE : SYMBOLS ARE DRAWN IN THE CORRECT POSITION BUT ARE NOT SHOWN TO SCALE

Issue	Date	Amendment	Int.	App.
1	19.10.06	TENDER REVIEW ISSUE	AM	DC

Client:



Emirates

Project Manager:



CliftonConey Group

CLIFTON CONEY GROUP PTY LTD
Level 18, Citigroup Centre
SYDNEY NSW 2000
T 02 9287 2100
F 02 9287 2188

Architect:

TURNER + ASSOCIATES

LEVEL 1/ 586 CROWN STREET
SURRY HILLS NSW 2010
T 02 9690 2855
F 02 9690 2411

NOMINATED ARCHITECT: Nicholas Turner 6695
DLQ QUALITY ENDORSED COMPANY ISO 9001:2000
LICENCE NUMBER 4188

Hydraulic Consultant:



STEVE PAUL & PARTNERS

Level 3 - 432 Kent St.
SYDNEY NSW 2000
Ph (02) 9261 1300
Fax (02) 9261 1600

Hydraulic Fire Environmental

A.C.N.: 088 131 793 A.B.N.: 78 088 131 793
EMAIL: mail@sydspap.com.au
WEBSITE: http://www.stevepaulpartners.com



Project:

EMIRATES LUXURY RESORT WOLGAN VALLEY

Drawing Title:

HYDRAULIC SERVICES SITE PLAN

North Point:	Design: MATTHEW ADAM
	Design Validated: DARREN CAMPBELL
	Amendment Approved:
	Drawn: RYAN PETKOVICH
Date: AUGUST 2006	Scale: (A1) 1:10000 (A3)
Job No: S05066 - H - 001 - TR - 1	Disc: Dwg No: Stage: Issue:

FILE NAME & PATH: C:\Users\2055\Documents - Emirates Luxury Resort_Uthmaniyah\HYDRAULICS\H-001-SITE.dwg

ORIGINAL SIZE: A1