


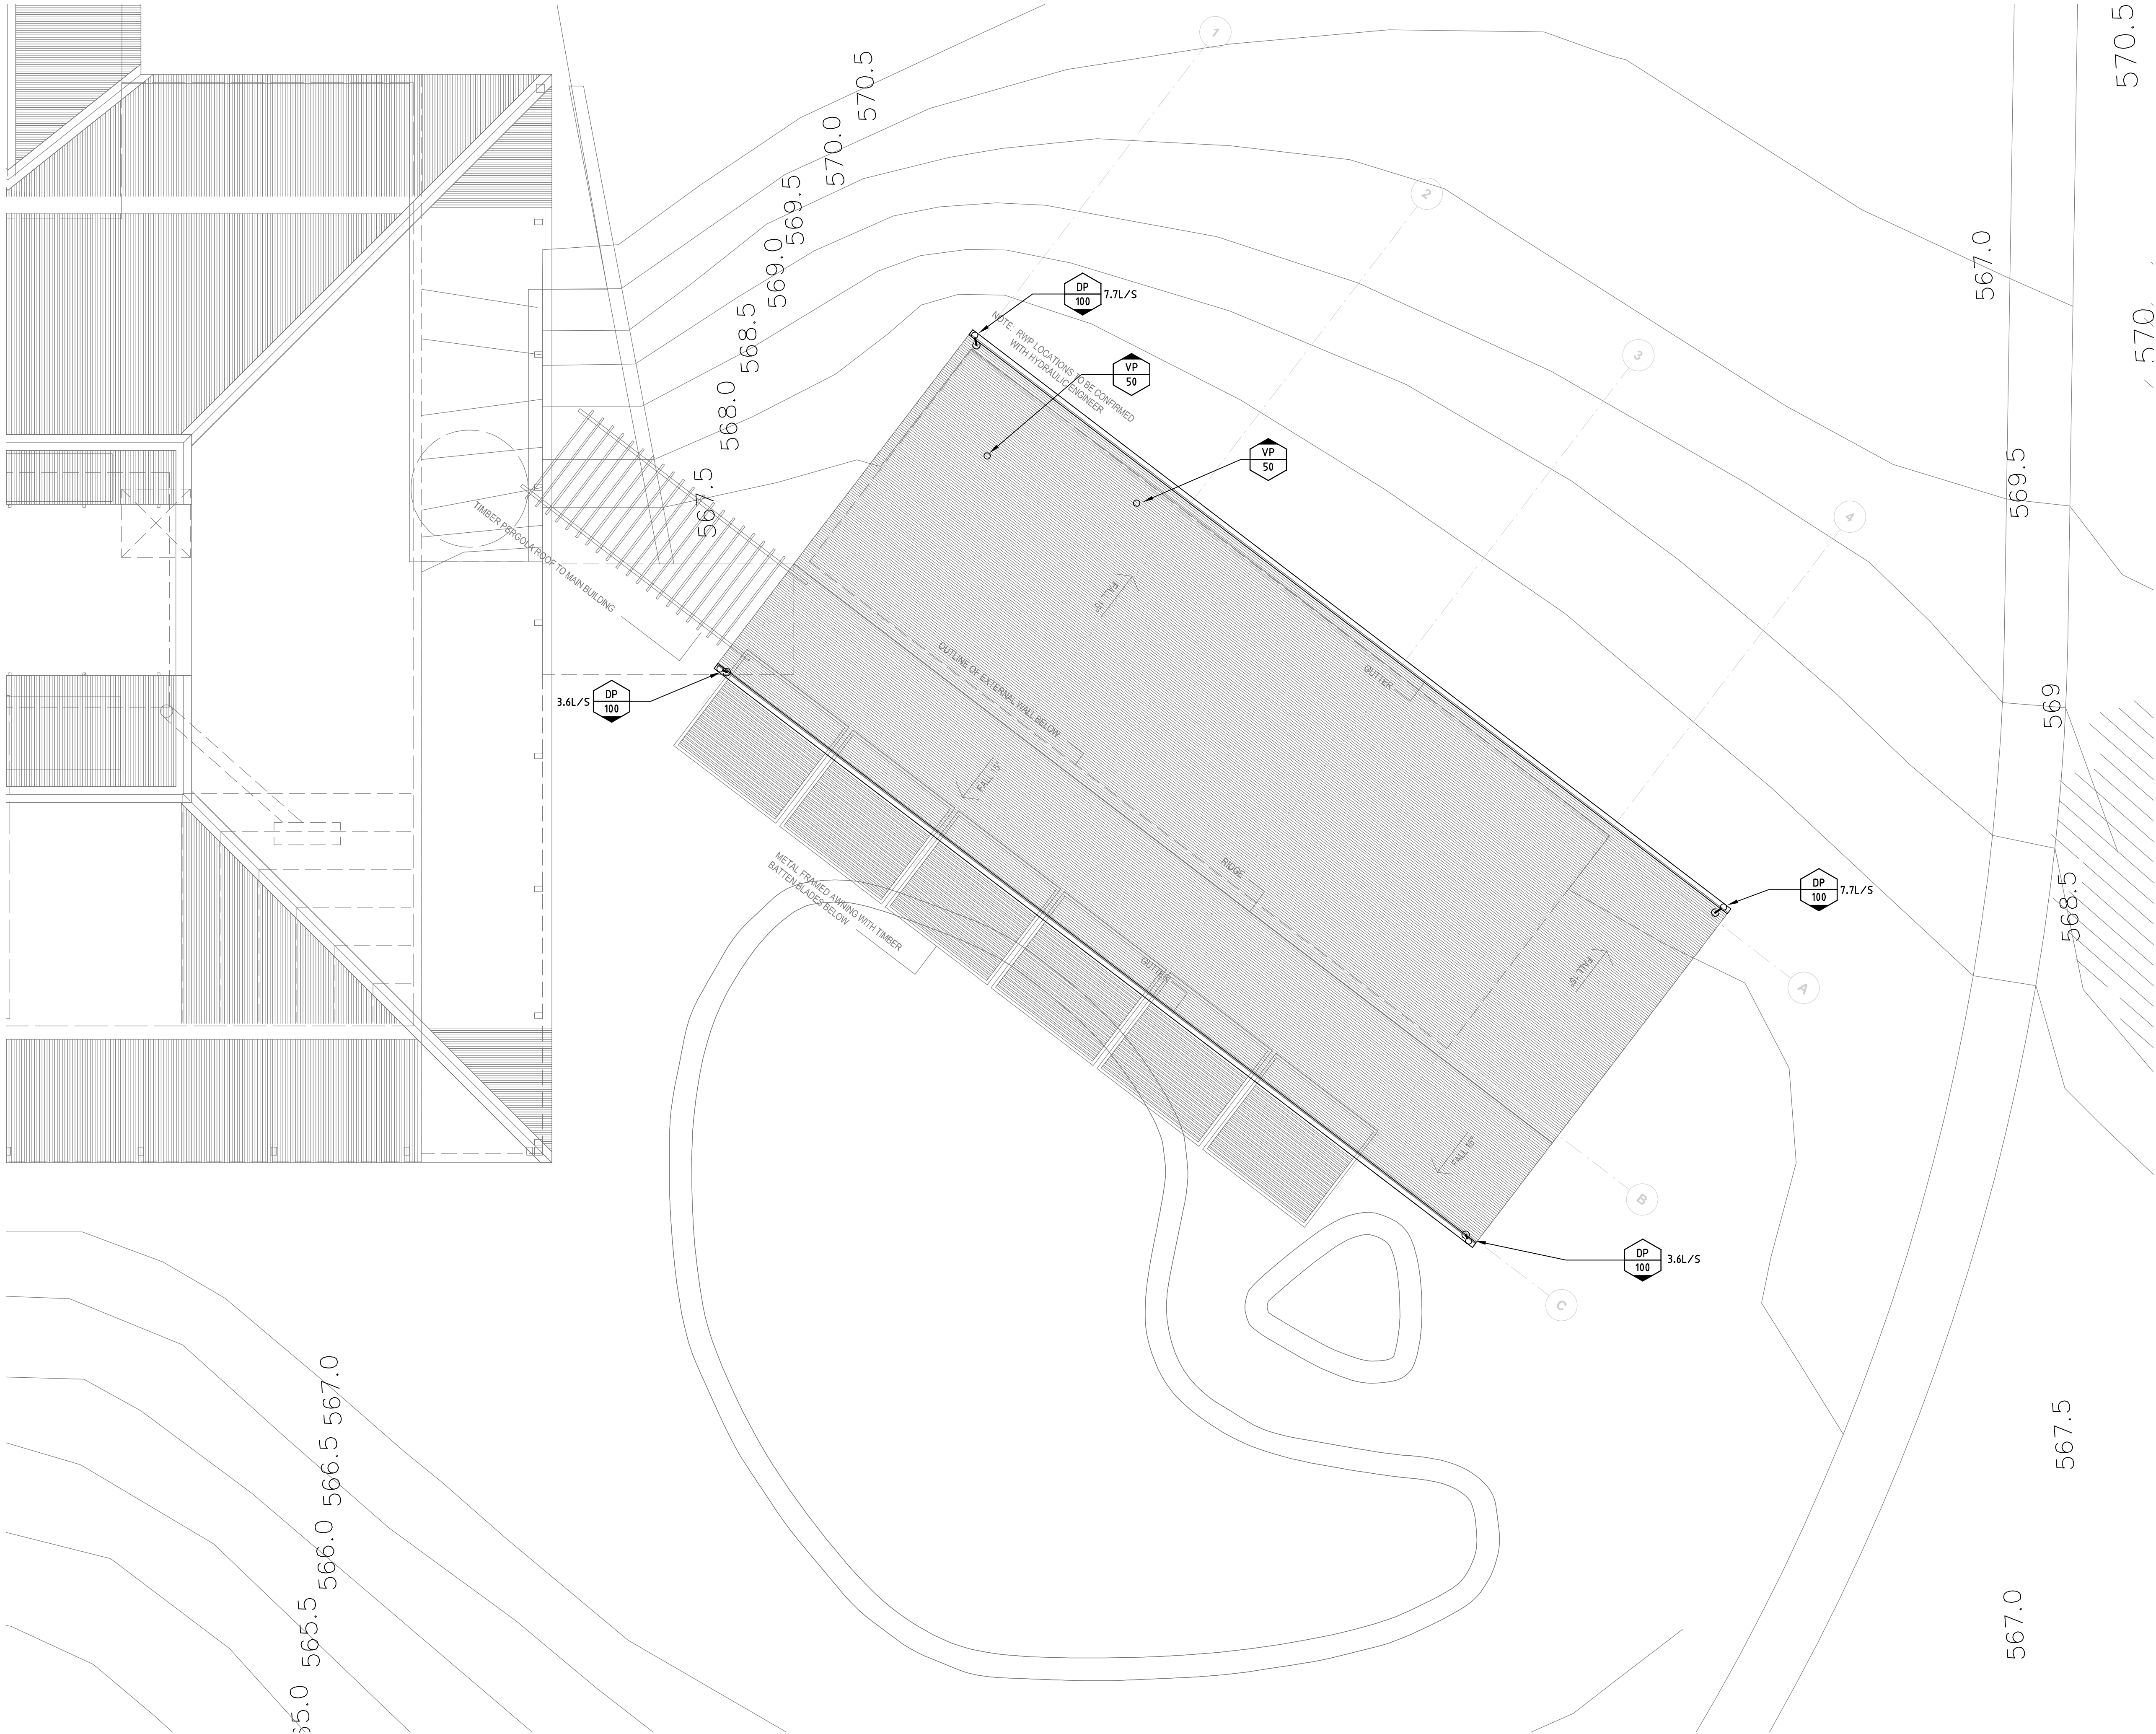

NOTE : SYMBOLS ARE DRAWN IN THE CORRECT POSITION BUT ARE NOT SHOWN TO SCALE

Issue	Date	Amendment	Int.	App.
1	19.10.06	TENDER REVIEW ISSUE	AM	DC

Client:



Project Manager:



CLIFTON CONEY GROUP PTY LTD
Level 18, Clitgroup Centre
SYDNEY NSW 2000
T 02 9287 2100
F 02 9287 2188

Architect:

TURNER + ASSOCIATES

LEVEL 17/ 586 CROWN STREET
SURRY HILLS NSW 2010
T 02 9690 2855
F 02 9690 2411

NOMINATED ARCHITECT: Nicholas Turner 6695
DLIQ QUALITY ENDORSED COMPANY ISO 9001:2000
LICENCE NUMBER 4188

Hydraulic Consultant:



STEVE PAUL & PARTNERS
SPP
Level 3 - 432 Kent St.
SYDNEY NSW 2000
Ph (02) 9261 1300
Fax (02) 9261 1600

Hydraulic Fire Environmental

A.C.N.: 088 131 793 A.B.N.: 78 088 131 793
EMAIL: mail@sydspap.com.au
WEBSITE: http://www.stevepaulpartners.com

Project:


**EMIRATES LUXURY RESORT
WOLGAN VALLEY**

Drawing Title:

**HYDRAULIC SERVICES
MAIN BUILDING
GYM ROOF PLAN**

DRAINAGE SERVICES

North Point:

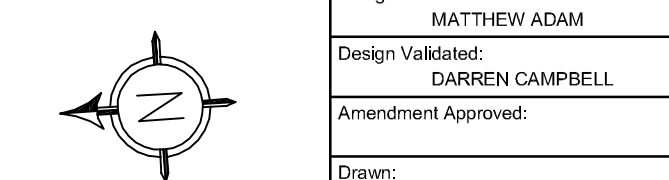

Design: MATTHEW ADAM
Design Validated: DARREN CAMPBELL
Amendment Approved:
Drawn: RYAN PETKOVICH

Date: AUGUST 2006 Scale: (A1) 1:100 (A3)
Job No: Disc: Dwg No: Stage: Issue:
S05066 - H - 110 - TR - 1

FILE NAME & PATH: C:\Users\2005\325586 - Emirates Luxury Resort_Ulghow NSW\CAD Section\3PP Drawing\HYDRAULICS\H-110-GYM BUILDING ROOF.dwg
PLOT DATE & TIME: 19 Oct, 2006 - 2:51pm
PLOTED BY: me

ORIGINAL SIZE: A1