




Typical Creekline Plan > 1:200 @ A1



V1 > View Upstream in Riparian Creek

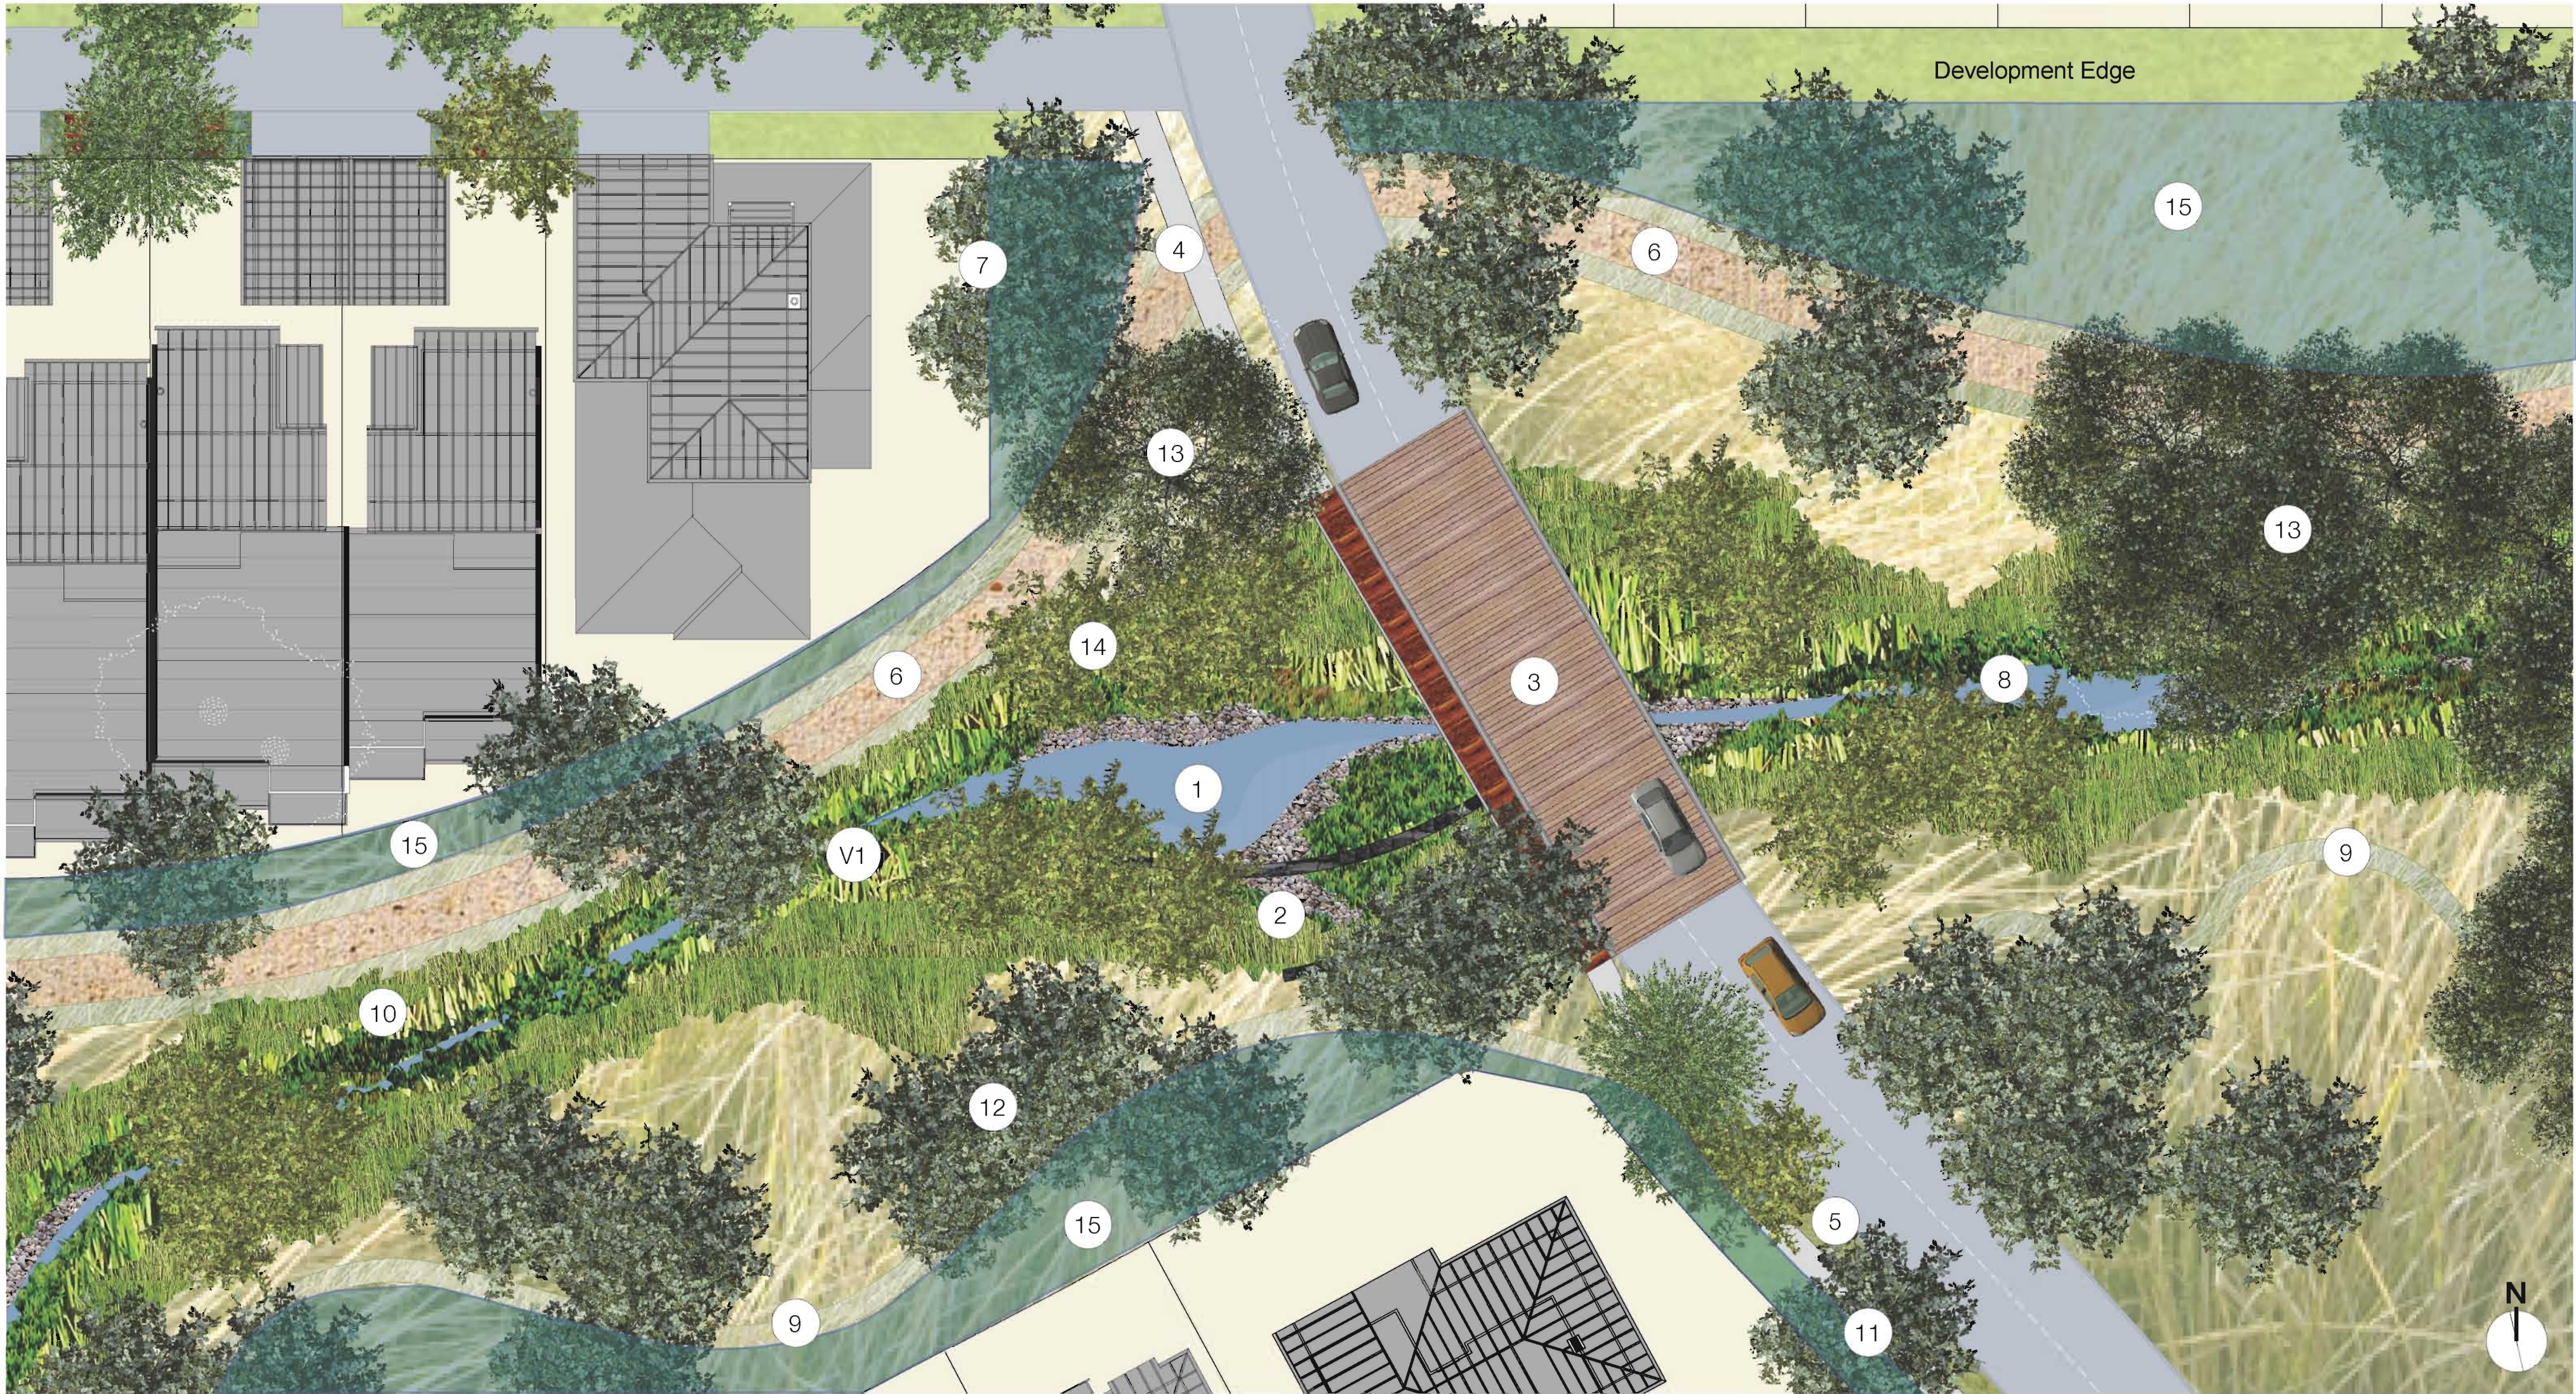

Riparian Corridor Character Images

- KEY:**
- 1 Ephemeral pond
 - 2 Sculptural gabion walls / erosion protection to drainage outlet
 - 3 Bridge element to creekline
 - 4 Pedestrian access path to creekline
 - 5 Verge planting - refer Access Rd sections
 - 6 Pedestrian footpath 2m wide with 1m cleared either side for emergency access vehicles
 - 7 Seating area to base of existing and proposed trees
 - 8 Existing creekline to be enhanced and retained
 - 9 Informal gravel "sheep track" path
 - 10 Banded plantings to creekline - refer montage
 - 11 Street trees
 - 12 Copses of Eucalypts - refer Planting Schedule for detail
 - 13 Existing trees to be retained
 - 14 Copses of Melaleucas - refer Planting Schedule for detail
 - 15 Managed Riparian Zone

EDAWAECOM

NOTES:

Builder / Contractor shall verify job dimensions before any job commences.

Figured dimensions take precedence over drawings and job dimensions.

All shop drawings shall be submitted to the Architect/Consultant, and manufacture shall not commence prior to return of inspected shop drawings by the Architect/Consultant.

KEY PLAN:

REVISIONS:

REV.	DESCRIPTION	DATE
C	Client Approval	09.12.08
B	Client Approval	08.04.08
A	Client Approval	13.06.07

CONSULTANTS:

URBAN DESIGN / PLANNING: EDAW 2-14 Mountain St Ultimo NSW 2007 T (02) 9212 3666 F (02) 9212 4499 ACN 003 886 306 Jon Shinkfield - Project Principal M 0411 551 512 E jon.shinkfield@edaw.com John O'Driscoll - Urban Planning M 0411 759 540 E john.odriscoll@edaw.com Cara Yandell - Urban Design / Landscape Architect M 0405 707 144 E cara.yandell@edaw.com Natasha Mavlan - Planning	ARCHITECTURE + MASTERPLANNING: dko Architecture C18/36-48 Macquarie St Ultimo NSW 2007 ABN 54 740 188 257 Contact: Jeff Kesteven (architecture - houses) E jeff@dko.com.au ARCHITECTURE (wellness centre): Steno Harding 123 Commonwealth St Surry Hills NSW 2010 ACN 003 631 301 Contact: Andy Harding - Director T (02) 9211 5710 F (02) 9211 5366 M 0414 416 686 E andy@steno-harding.com.au
CIVIL / ACOUSTIC ENGINEERING: Hyder Consulting L6/141 Walker St North Sydney NSW 2060 ABN 76 104 485 289 Contact: John McDermott - Associate T (02) 9807 9000 F (02) 9807 9001 M 0408 031 971 E john.mcdermott@hyderconsulting.com	ARCHITECTURE (apartments): Durbach Brock Level 7/ 71 York Street Sydney NSW 2000 ABN Contact: Neil Durbach T (02) 9297 3500 F (02) 9297 3510 M 0414 472 310 E neil@durbachbrock.com
TRAFFIC & TRANSPORT PLANNING: CTA Consultants L10/ 815 Pacific Hwy Chatswood NSW 2057 ACN 006 633 646 Contact: Alan Stewart - Project Manager T (02) 9448 1800 F (02) 9448 1810 M 0422 401 006 E alan.stewart@cta.com.au	BASIS: Damen CT/role Town Planning L2/ 29 Shepherd St Chippendale NSW 2008 ABN Contact: Damien O'Keefe T (02) 9200 4541 F (02) 9200 4577 M 0413 031 971 E damien@overplanning.net.au
ECONOMIC ANALYSIS: Sphere Property Corporation Suite 10/ Quay West Centre 96 Gloucester St Sydney NSW 2000 ABN 34 003 463 461 Contact: John Jackson - Managing Director T (02) 9252 7066 F (02) 9252 7067 M 0418 293 025 E sphere@sphere.com.au	FLOOD MANAGEMENT / WSUD: Evans & Peck 20/360 Eastern Valley Way East Roseville NSW 2059 ACN 008 008 815 Contact: Steve Peters - Principal T (02) 9882 0500 F (02) 9417 8850 M 0413 244 400 E speters@evanspeck.com
BUSHFIRE HAZARD: Australian Bushfire Protection Planners RMB 311 Dog Track Rd Somersby NSW 2250 ACN 083 510 173 Contact: Graham Smith - Principal T (02) 4362 2112 F (02) 4362 2204 M 0427 422 204 E gsmith@bgsppd.net.au	SOILS CAPABILITY: Sydney Environmental & Soil Laboratory 16 Chivers Rd Pennant Hills NSW 2120 PO Box 207 Pennant Hills NSW 2115 ACN 106 810 708 Contact: Simon Seel - Principal T (02) 9680 6554 F (02) 9484 2427 M 0403 128 729 E simon@seel.com.au
EUROPEAN HERITAGE: City Plan Heritage	ECOLOGY: Keystone Ecological PO Box 9096 Singsie Bay NSW 2257 ACN 099 456 149 Contact: Elizabeth Jubbey - Senior Ecologist T (02) 4368 1108 F (02) 4368 2361 E e.jubbey@keystone-ecological.com.au
ACCESSIBILITY CONSULTANTS: Mavis Coding Accessibility Consultants Unit 105/ 55 Bowman St The Cooperrage Parramatta NSW 2009 Contact: David Sengco T (02) 9692 9322 F (02) 9692 8433 E david@mgac.com.au	INDIGENOUS ARCHAEOLOGY: NSW Archaeology Pty Ltd

CLIENT:

SILVER SPIRIT PARTNERS

ARCHITECT:

SYDNEY BRISBANE
MELBOURNE
SUNSHINE COAST

2-14 MOUNTAIN STREET ULTIMO NSW 2007
T 02 9212 3666 F 02 9212 4499 E SYDNEY@EDAW.COM

PROJECT DETAILS:

Moruya East Village

DRAWING TITLE:

Riparian Corridor
Detail Plan and Perspectives

DRAWN: CY/DG CHECKED:

SCALE: 1:200 @ A1 DATE: 23/03/2007

PROJECT NUMBER: 06502307 DRAWING NUMBER: SK03 REV: C