


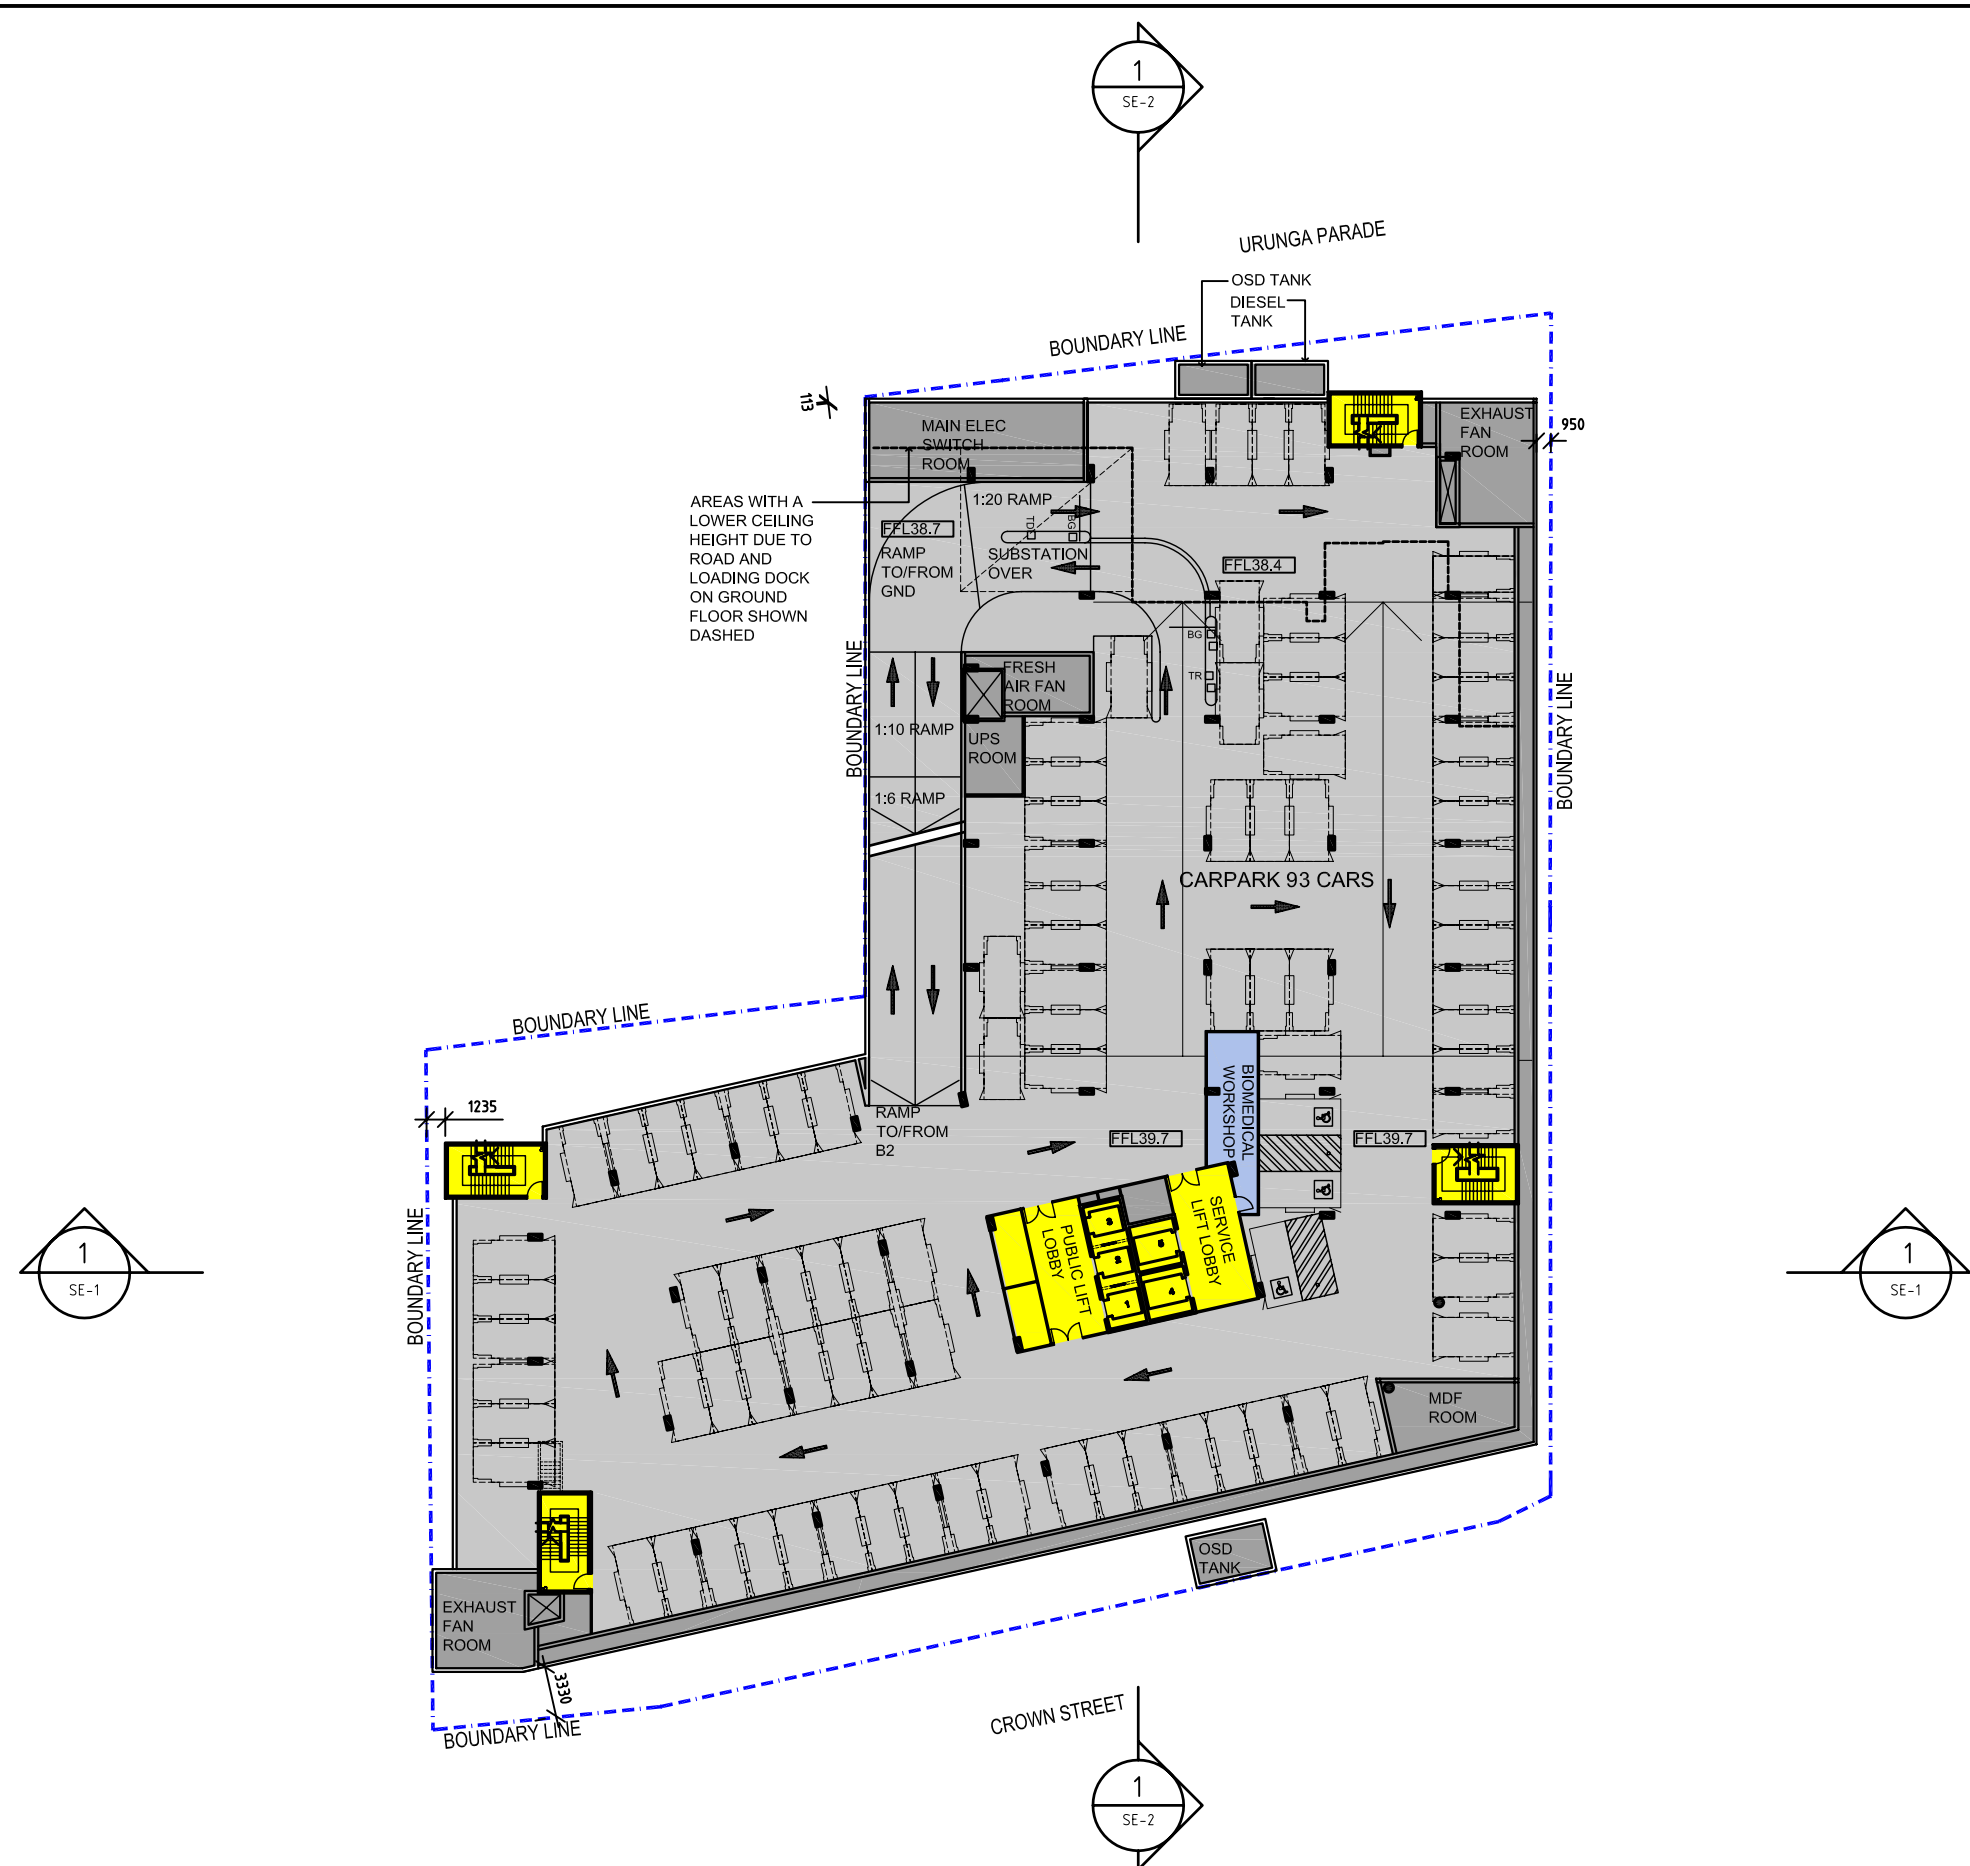

LEGEND	
	PRIVATE HOSPITAL
	COMMON AREAS
	TENANCY
	RETAIL
	ENGINEERING
	CARPARK
	TRAVEL

4	CARPARK REVISED	18.06.13	HMC
3	CROWN ST DRIVE WAY	06.06.13	CX
	REVISED		
	REVISED UPS ROOM AS PER		
	ENG. NOTES REVISED		
2	BOOM GATES SHOWN AS	04.06.13	SYH
	PER TRF CONS. ADVICE		
	ELECTRICAL PLANTROOM		
	REVISED AS PER ENG.		
1	FIRST ISSUE	03.06.13	HMC
Rev	Revision description	Date	By

Project
**WOLLONGONG
PRIVATE HOSPITAL**
Principal
AA CROWN HOLDINGS

USE FIGURED DIMENSIONS ONLY. DO NOT SCALE.
ALL DIMENSIONS SHALL BE VERIFIED ON SITE AND DISCREPANCIES IMMEDIATELY BROUGHT TO THE ATTENTION OF THE PROJECT MANAGER FOR RESOLUTION

"CLOUDS" & REVISIONS ARE INTENDED AS GUIDES AND DO NOT NECESSARILY DESCRIBE THE FULL EXTENT OF REVISIONS.
ASCERTAIN FULL EXTENT BY COMPARISON WITH PREVIOUS VERSION.

QA
CHECK

Subject	By	Date	Subject	By	Date	Subject	By	Date
RDS			STRUCT			PROJ. ARCH		
ARCH			SPEC. CONS					
AUT			SERV					

TRUE NORTH	Drawn CQ	Checked HMC	Date 03.06.13	Scale 1:500 @ A3
PROJECT NORTH	Drawing Title PLAN - BASEMENT LEVEL 1			

HP	HEALTH PROJECTS INTERNATIONAL Architects and Health Facility Planners ACH 066 856 595 Ground Floor, Suite 1, 65 Alfred Street Milsons Point, NSW 2061 Ph: (02) 9460 4199 Fax: (02) 9460 4299		
CAD File WGPH-P-B1	Dwg No. WGPH-P-B1-75W	Issue 4	