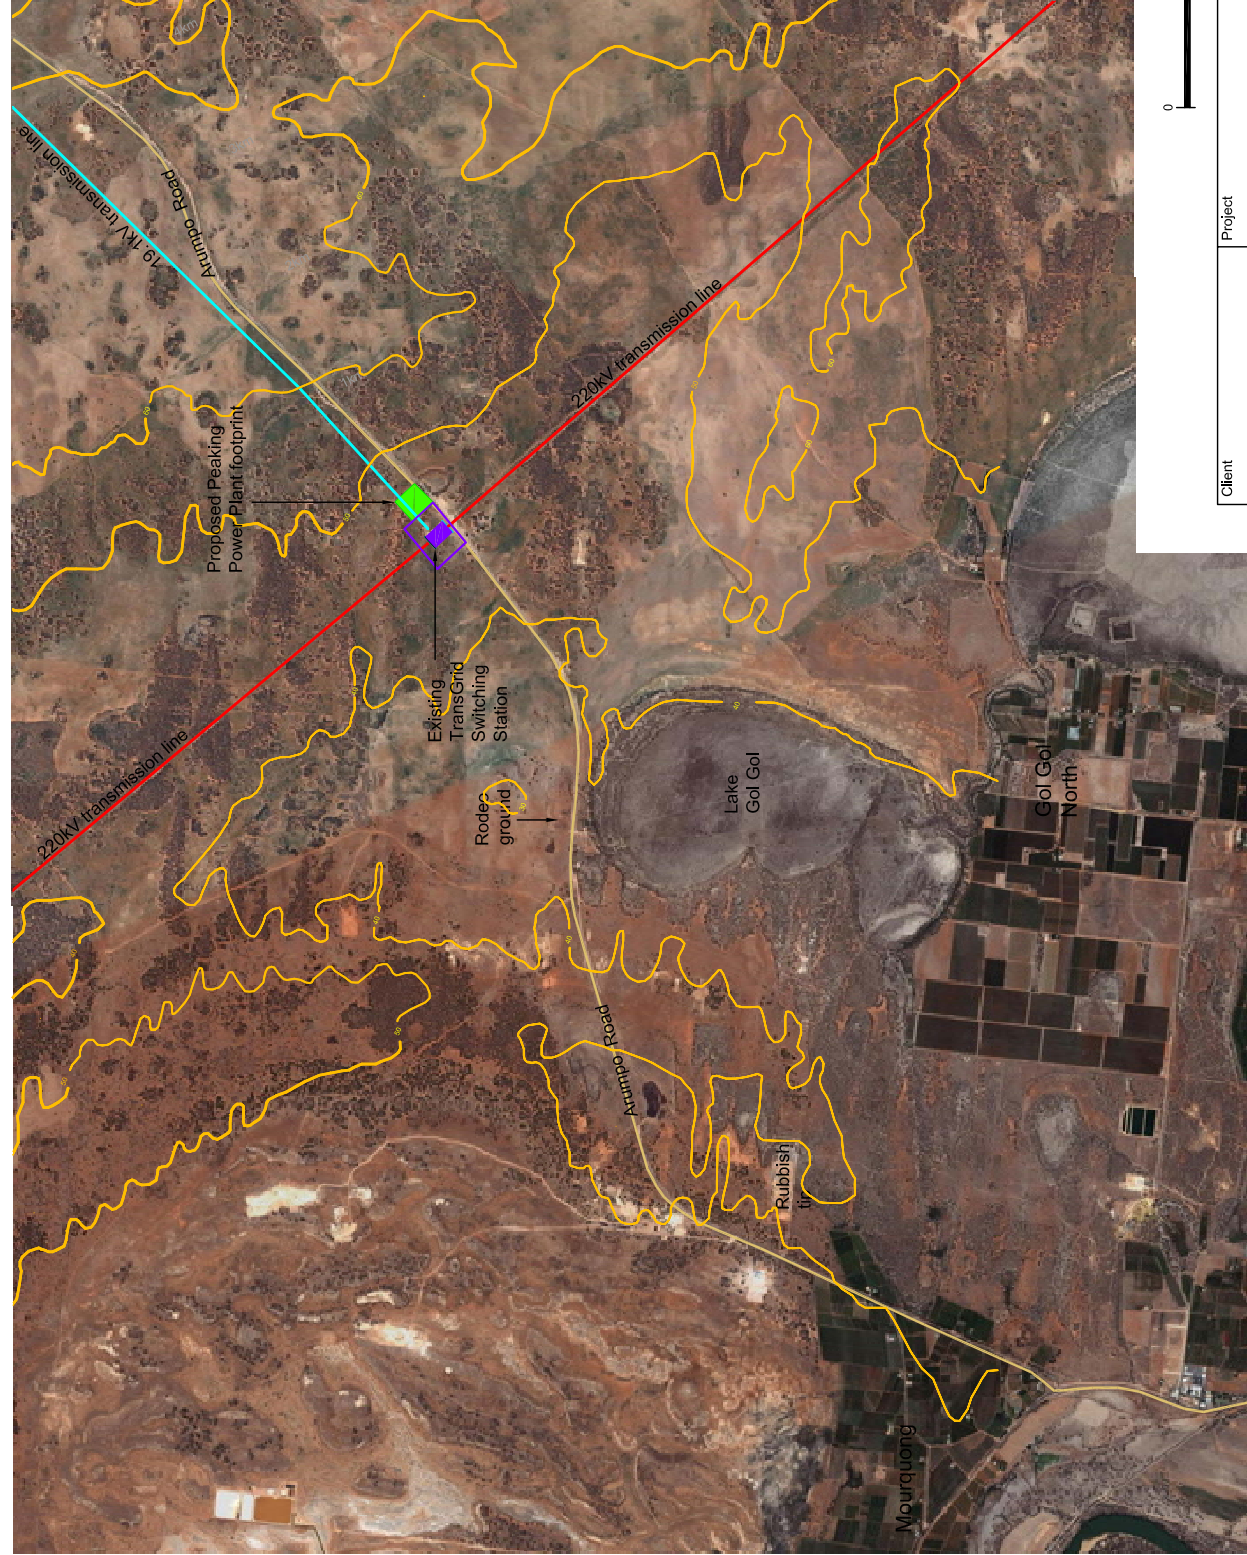


Client INTERNATIONAL POWER (AUSTRALIA) PTY LTD URS	Project	ENVIRONMENTAL ASSESSMENT BURONGA PEAKING POWER PLANT		Title
	Drawn: AH	Approved: WB	Date: 07/12/07	Figure: 9-2
	Job No: 43177457		File No: 431774567001	