
 
 


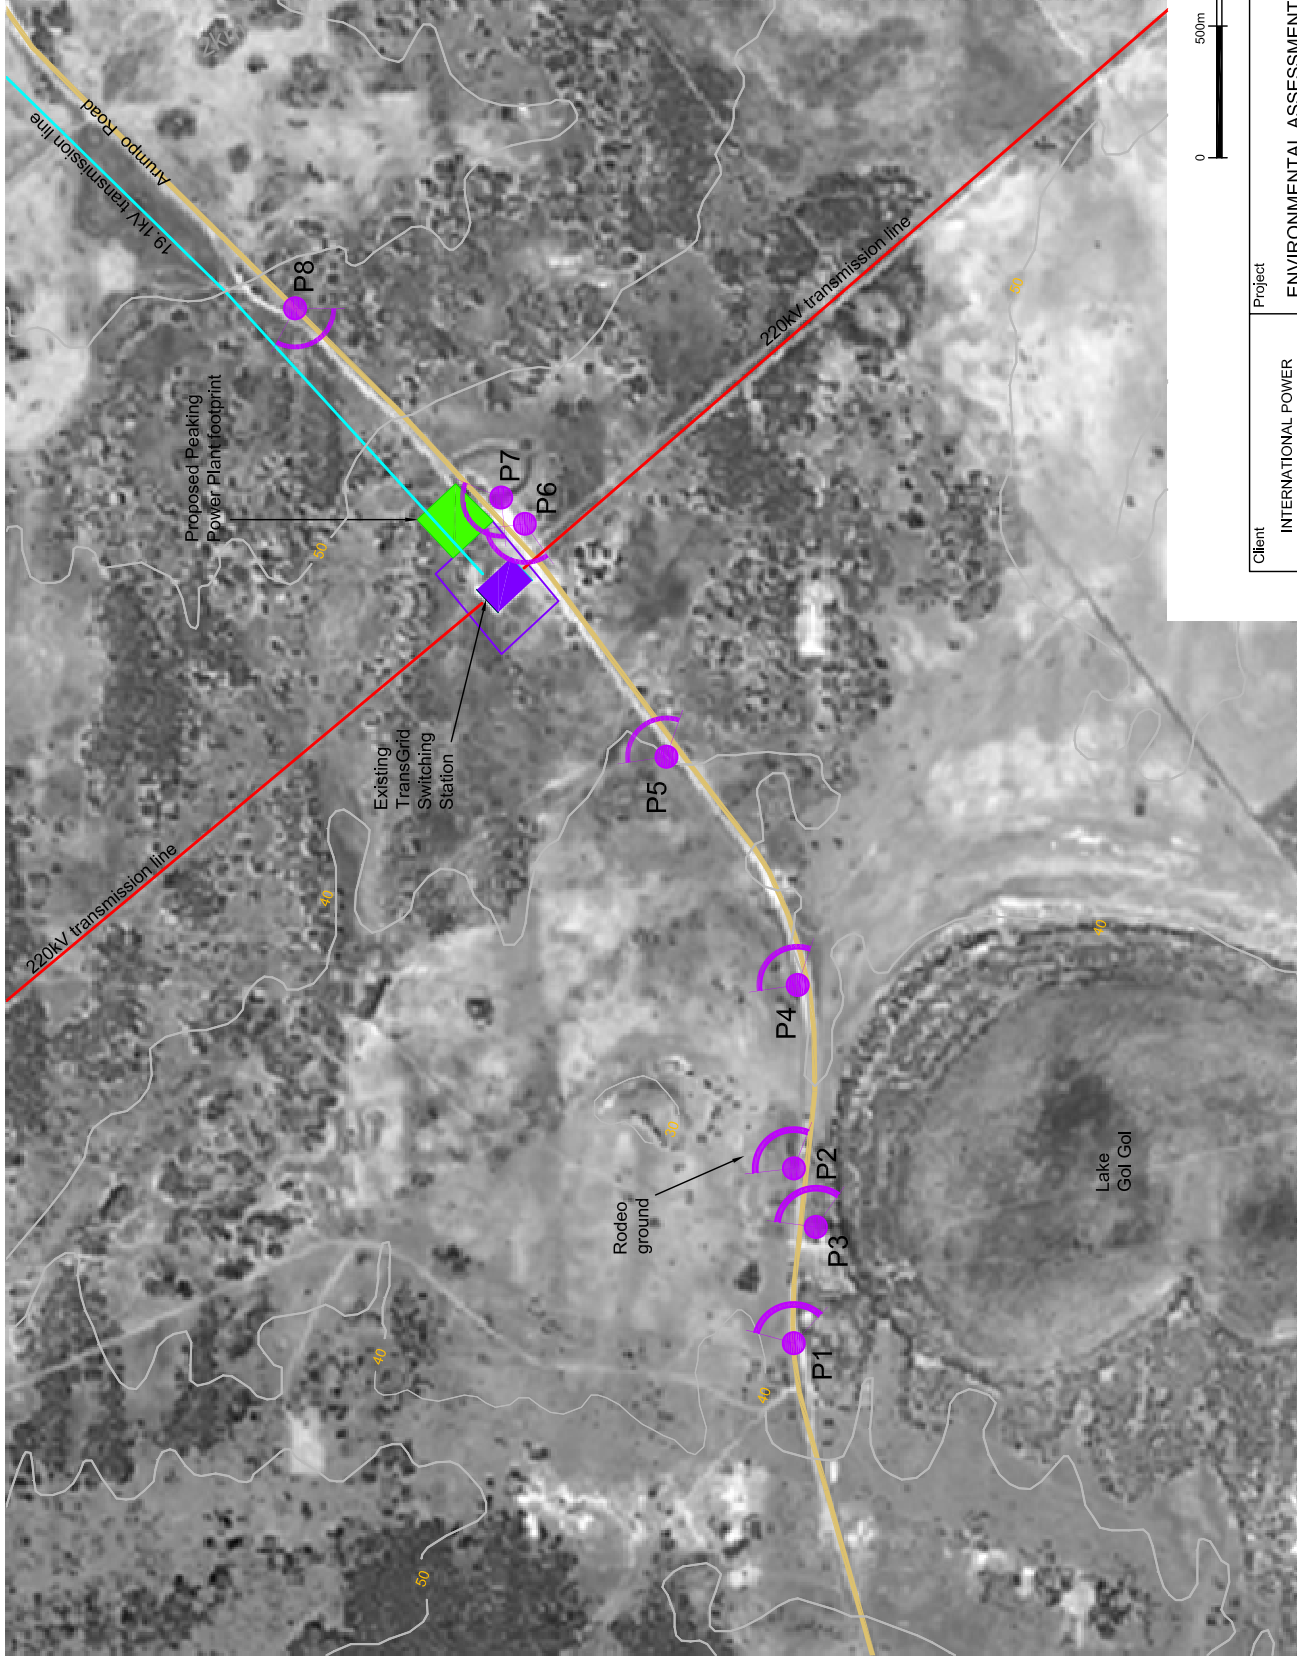

LEGEND



 
Buronga Peaking Power
Plant footprint




Existing TransGrid
Switching Station footprint



Existing 220kV
transmission line



Existing 19.1kV
transmission line

 



1km distance marker



Existing contour line



  Photo Location
P4



Client	Project	Title	
		ENVIRONMENTAL ASSESSMENT BURONGA PEAKING POWER PLANT	PHOTO LOCATIONS
URS INTERNATIONAL POWER (AUSTRALIA) PTY LTD	Drawn: AH	Approved: WB	Figure: 9-4
	Job No: 43177457	Date: 07/12/07 File No: 431774567001	