
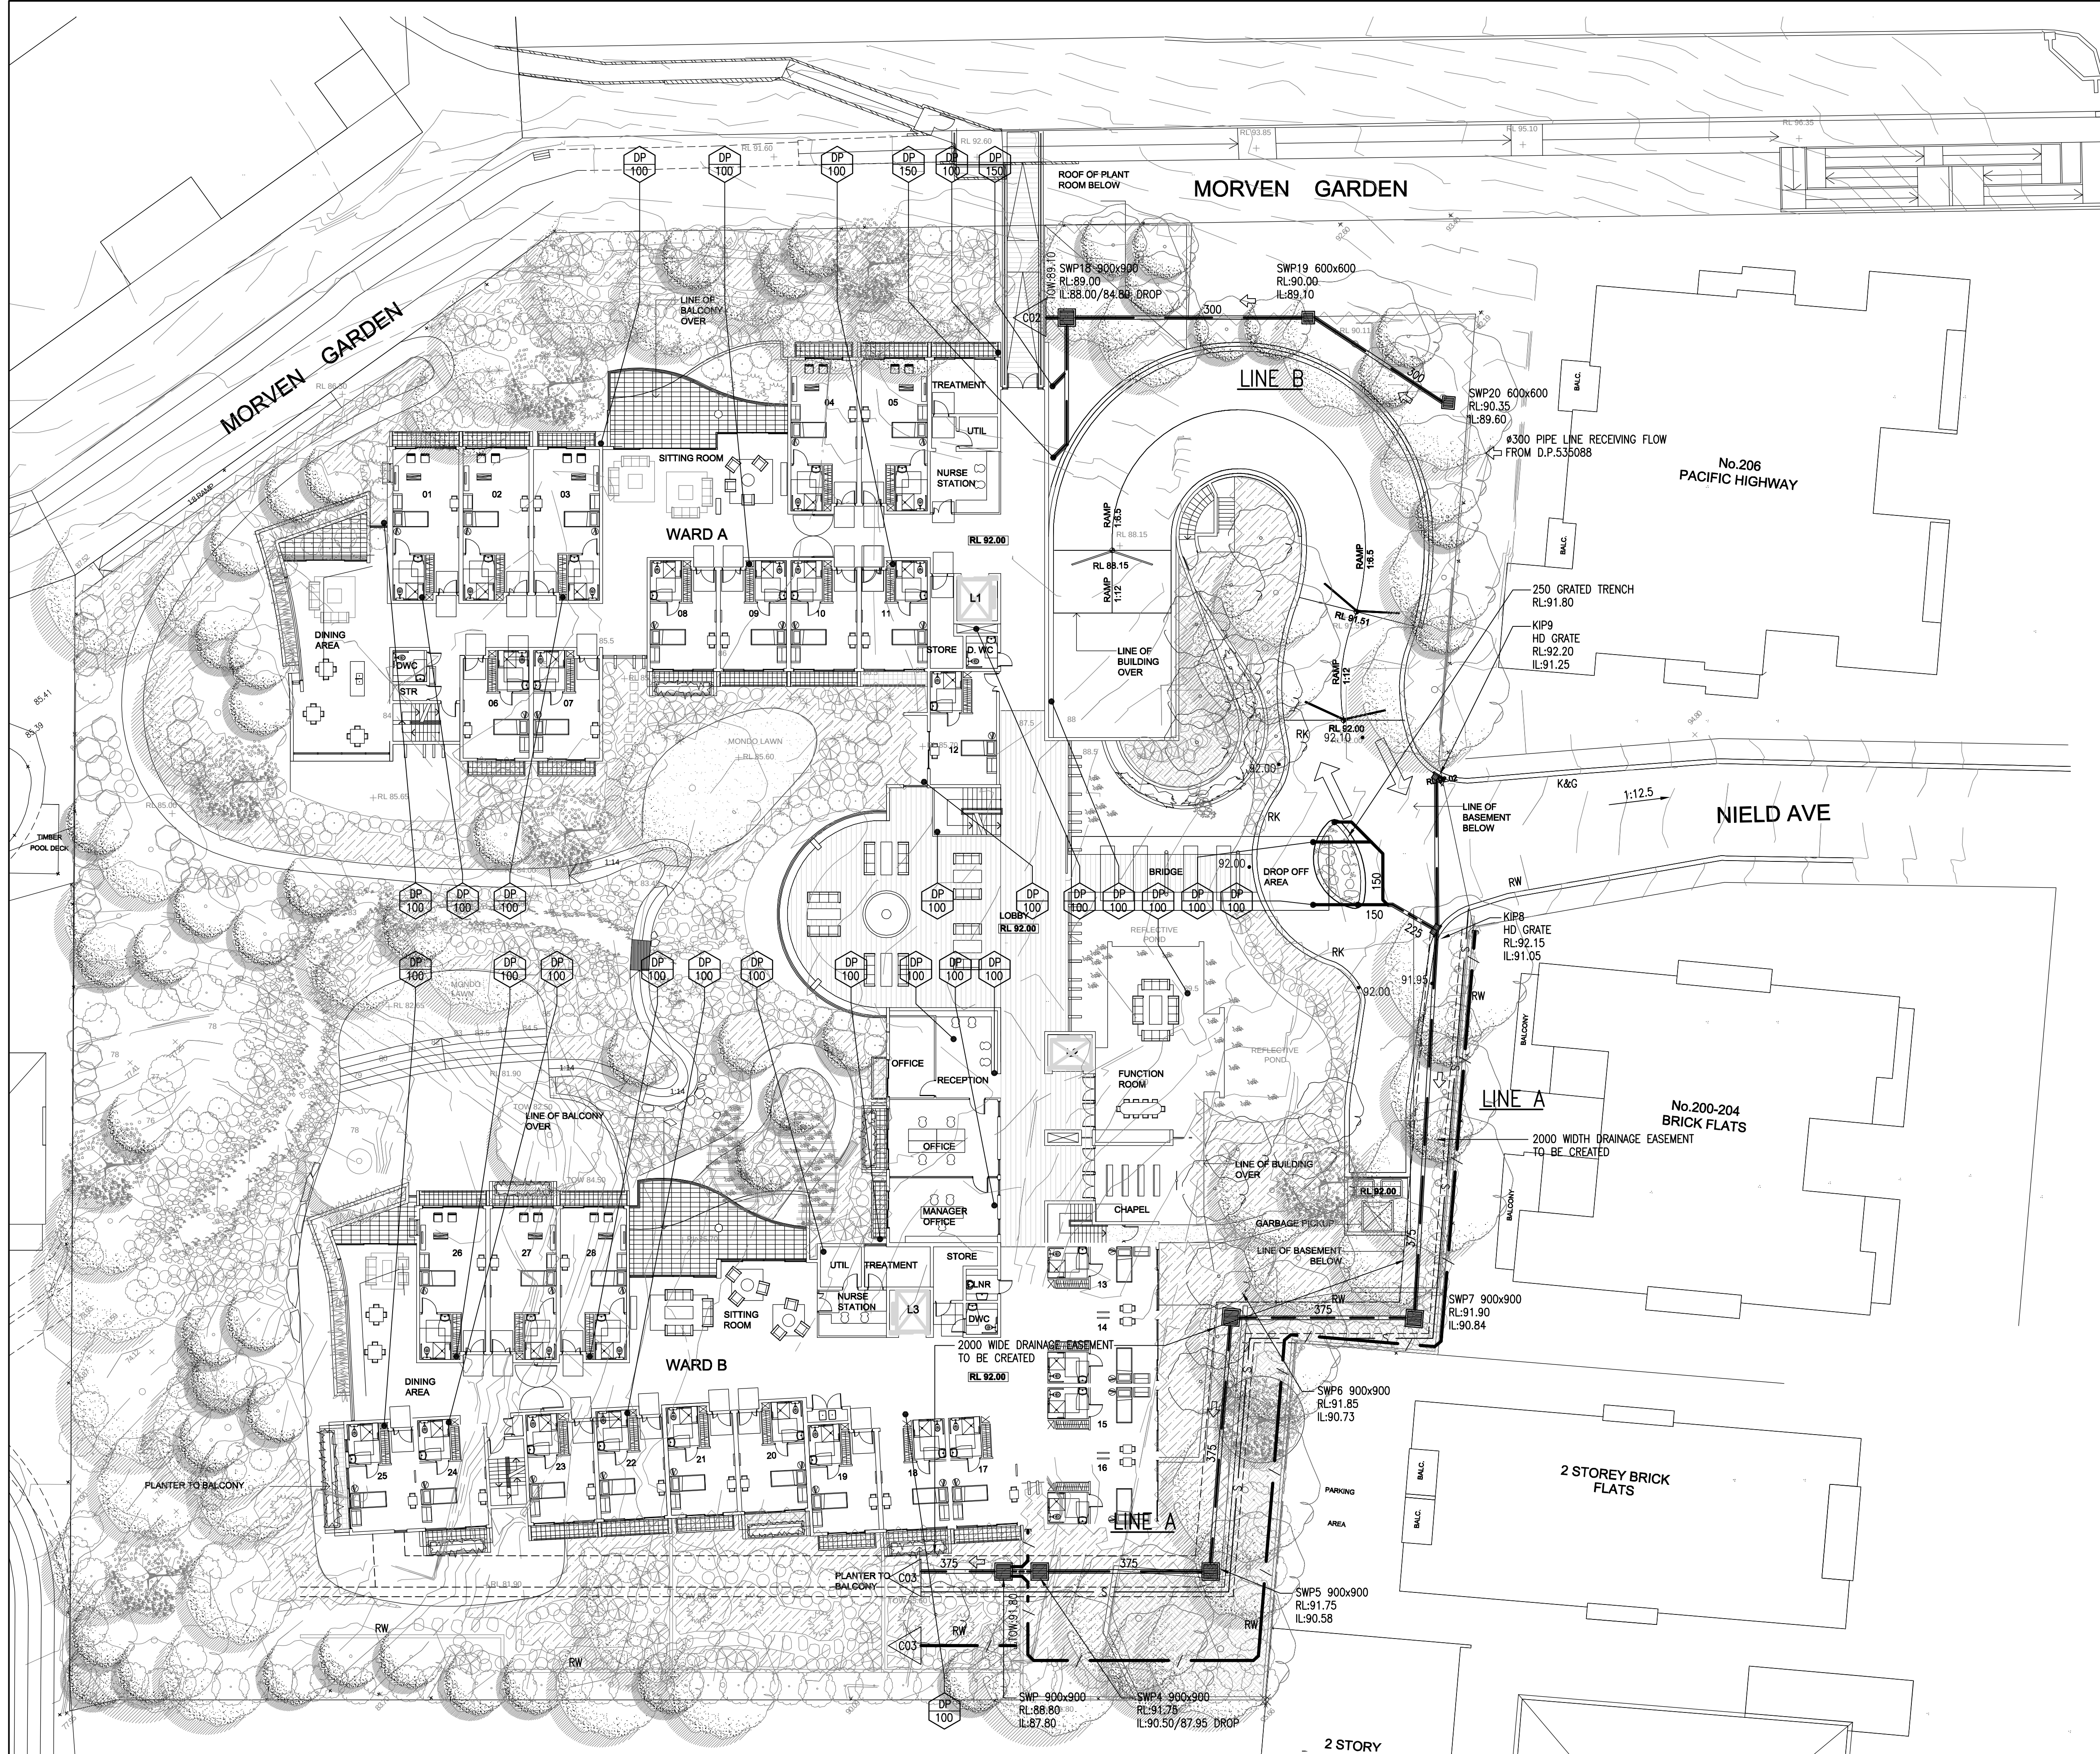


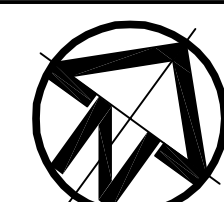


SERVICES ON THIS DRAWING
ARE SHOWN BELOW SLAB U.L.O.

Revision	Amendment	Date	Initial
F	D.A. ISSUE	10.10.08	ZO
E	D.A. ISSUE	25.09.08	ZO
D	D.A. ISSUE	21.05.08	ZO
C	D.A. ISSUE	15.10.07	ZO
B	D.A. ISSUE	27.03.07	ZO
A	D.A. SUBMISSION	19.03.07	ZO

Discipline	Dwg. No.	Date	Revisions
ARCHITECTURAL	DA-2.04	09.10.08	H
STRUCTURAL			
MECHANICAL			
ELECTRICAL			

Notes
Dimensions not shown to be checked on site. Do not scale of this drawing.
This drawing is to be read in conjunction with a specification. Invert levels are indicative only and are to be checked prior to commencement of work.
Position of Authorities mains and/or existing services are to be checked prior to commencement of work. Report any discrepancies to the Architect for decision/clarification before proceeding with the work. These designs, drawings, specifications and the copyright therein remain the property of The LHO Group and must not be used, altered, reproduced, or copied wholly or in part without the written permission of the owners.

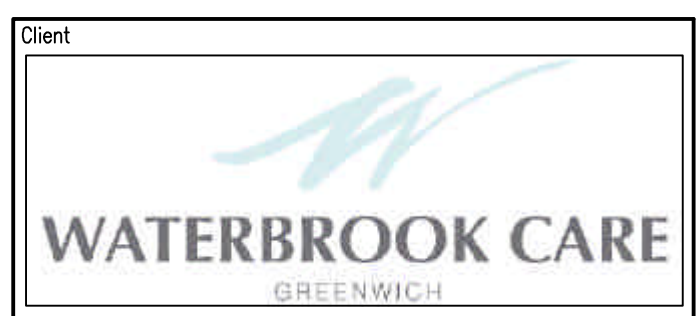

Architect
marchese + partners
architects
level 7, 107 mount street
north sydney nsw 2060
ph: (02) 9922 4375
fax: (02) 9929 5786
email: info@marchesepartners.com.au
web: www.marchesepartners.com.au
ACN: 067 427 687

Project
Proposed Private Hospital
1-8 Nield Avenue,
Greenwich

Consultant
LHO GROUP
LHO Group Pty Limited
Level 1, 25 Atchison Street
St Leonards NSW 2065
PO Box 134
St Leonards NSW 1590
p: 02 9439 1422
f: 02 9438 1242
e: sydney@lhogroup.com.au
www.lhogroup.com.au
ABN: 13 001 693 901
AS/NZS: ISO 9001
HYDRAULIC, FIRE PROTECTION & CIVIL ENGINEERS SYDNEY

Drawing **CIVIL SERVICES**
DRAINAGE CONCEPT
FLOOR PLAN - RL:92.00

Design	ZO	Drawn	JK
Date	FEB. 2007	Design Validated	MA
Sheet		QA Approved	
Scale	1:200	Computer Dwg.No.	
Job No.	0508-0028	Dwg.No.	C04
		Issue	F