




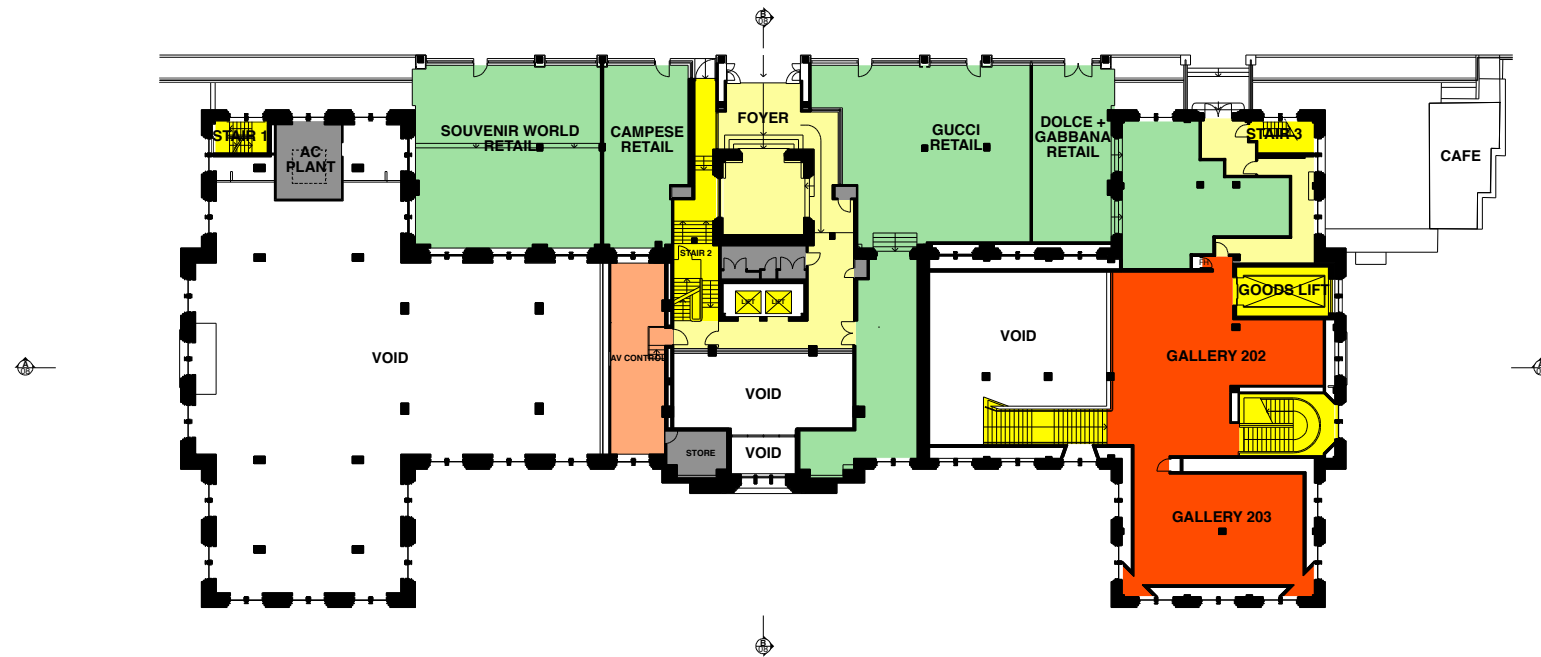



2

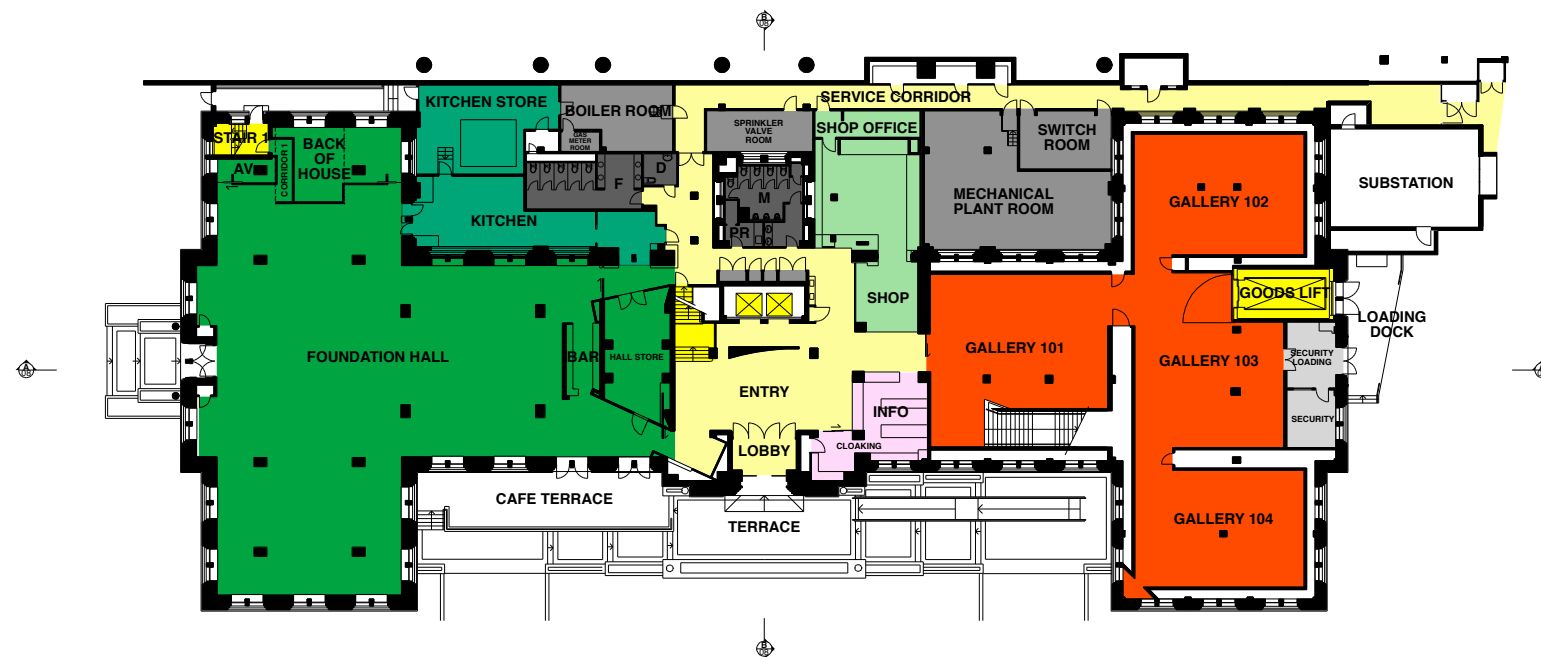


1

AMENDMENTS			LEGEND			ARCHITECTS IN ASSOCIATION		PROJECT MANAGER		CLIENT		PROJECT		DRAWING DESCRIPTION	
ISSUE	DATE	DETAILS	BOH	KE		LC	ARCHITECT MARSHALL PTY LTD	NSW DEPARTMENT OF COMMERCE	ROOT PROJECTS	MUSEUM OF CONTEMPORARY ART	MUSEUM OF CONTEMPORARY ART	PROJECT	DRAWING No		
C	02.12.08	FINAL PROJECT APPLICATION	C-Back of House CO-Communication CHA-Conservation Exhaust Air D-Common Outdoor Air E-Common Air Return F-Disposal Toilet FHD-Fire Hydrant FHS-Fire Mover Room FSA-Foyer Supply Air GSA-Gallery Return Air HSA-Gallery Supply Air H-Hydraulics	KE-Kitchen Exhaust Air LC-Lighting Controls LE-Lobby Exhaust Air LRA-Lecture Return Air LPA-Lecture Supply Air M-Male Toilet OFC-Off Form Concrete P-Pipework PR-Parents Room RD-Rainwater Outlet S-Sprinklers SW-Staircase WE-Workshop Exhaust Air	CONTACT: SAM MARSHALL NSW AFB NO. 4644	CONTACT: PETER MOULD NSW GOVERNMENT ARCHITECT NSW AFB NO. 3301 CONTACT: WILLIAM PHELPS	CONTACT: KRISTIN WARK	MUSEUM OF CONTEMPORARY ART CONTACT: EVAN UPSTON	MUSEUM OF CONTEMPORARY ART REDEVELOPMENT	140 GEORGE STREET THE ROCKS 2000	140 GEORGE STREET CIRCULAR QUAY	LEVEL 1 & LEVEL 2 FLOOR PLAN EXISTING	SCALE 1:500 @ A3	DRAWING No: PA04	ISSUE: C

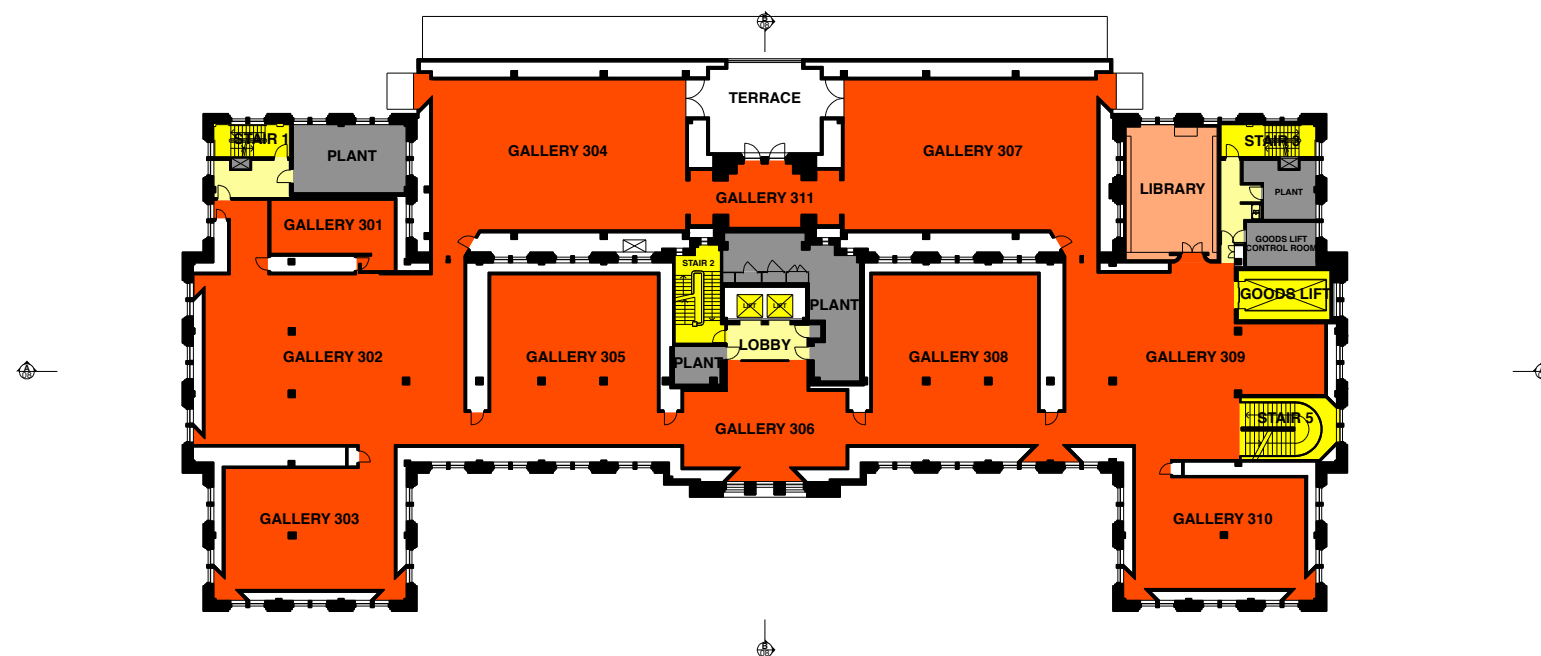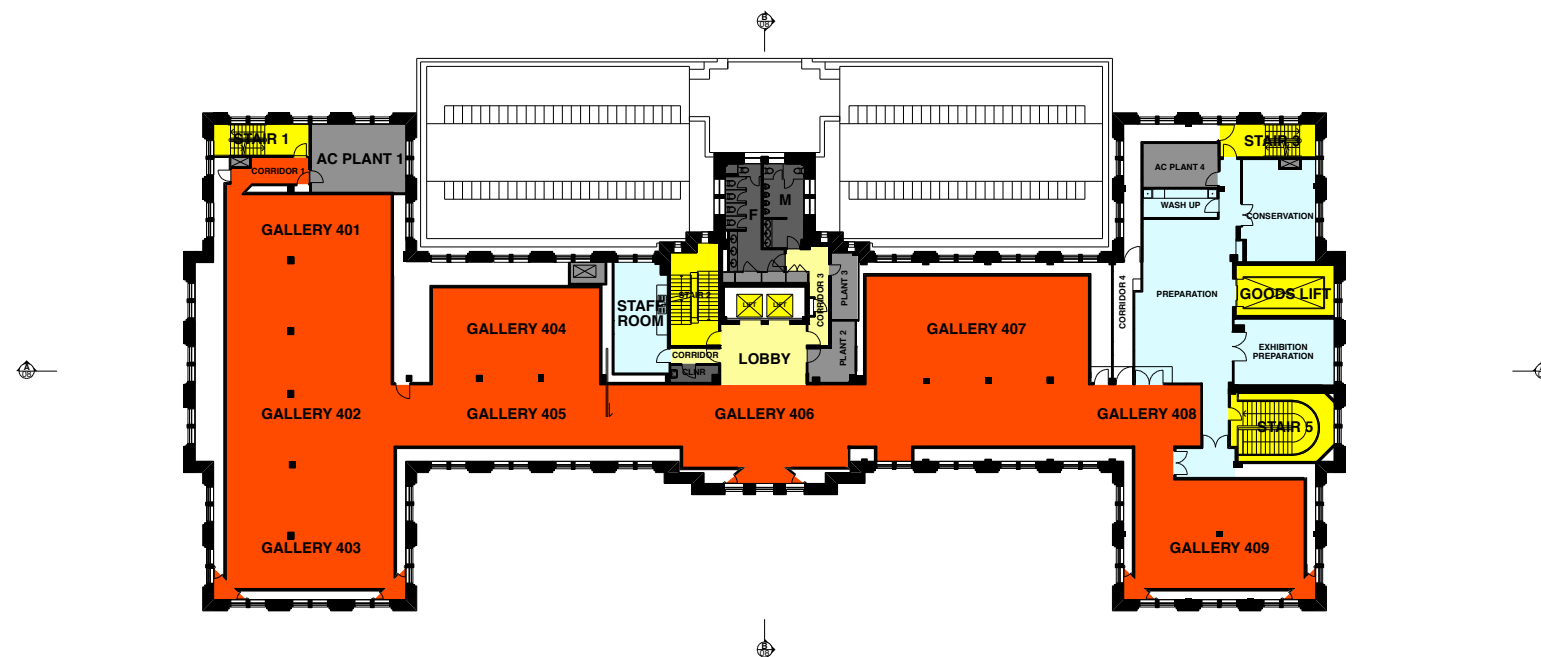[illegible]

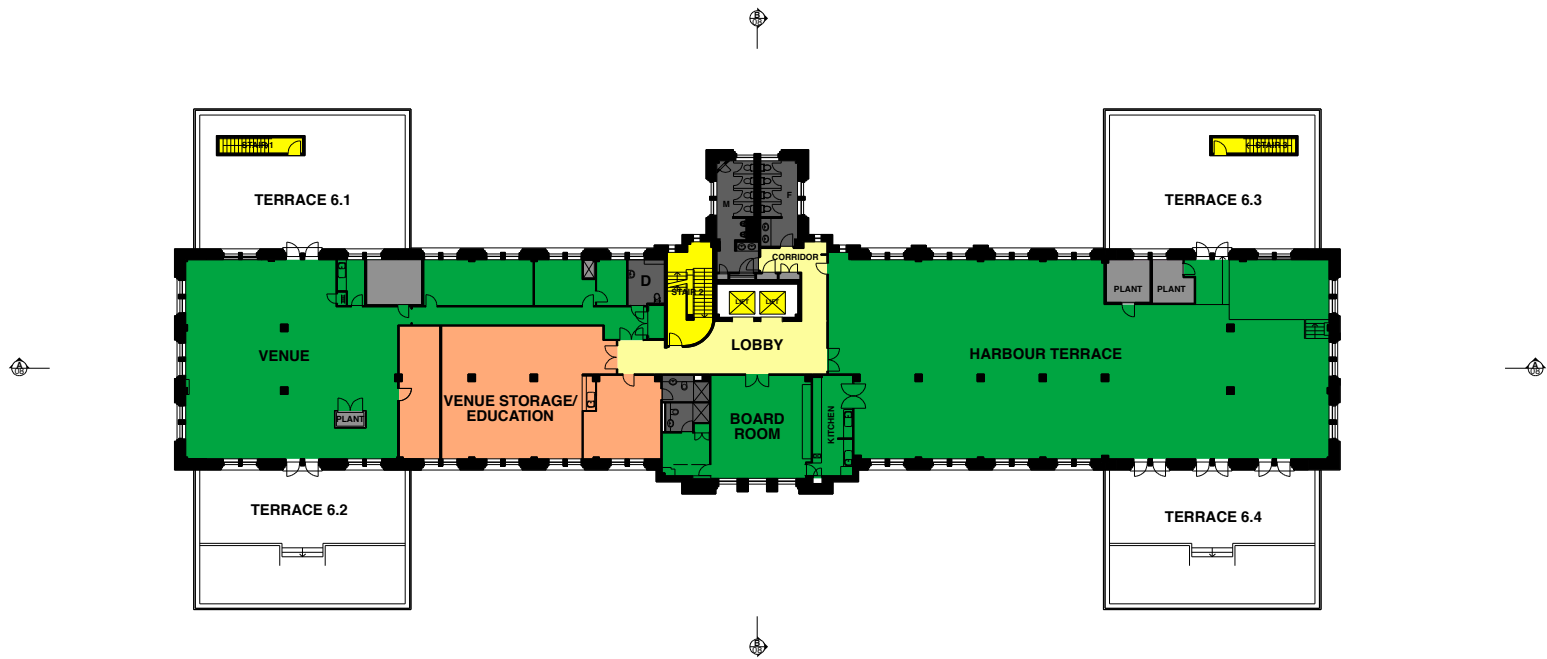


6


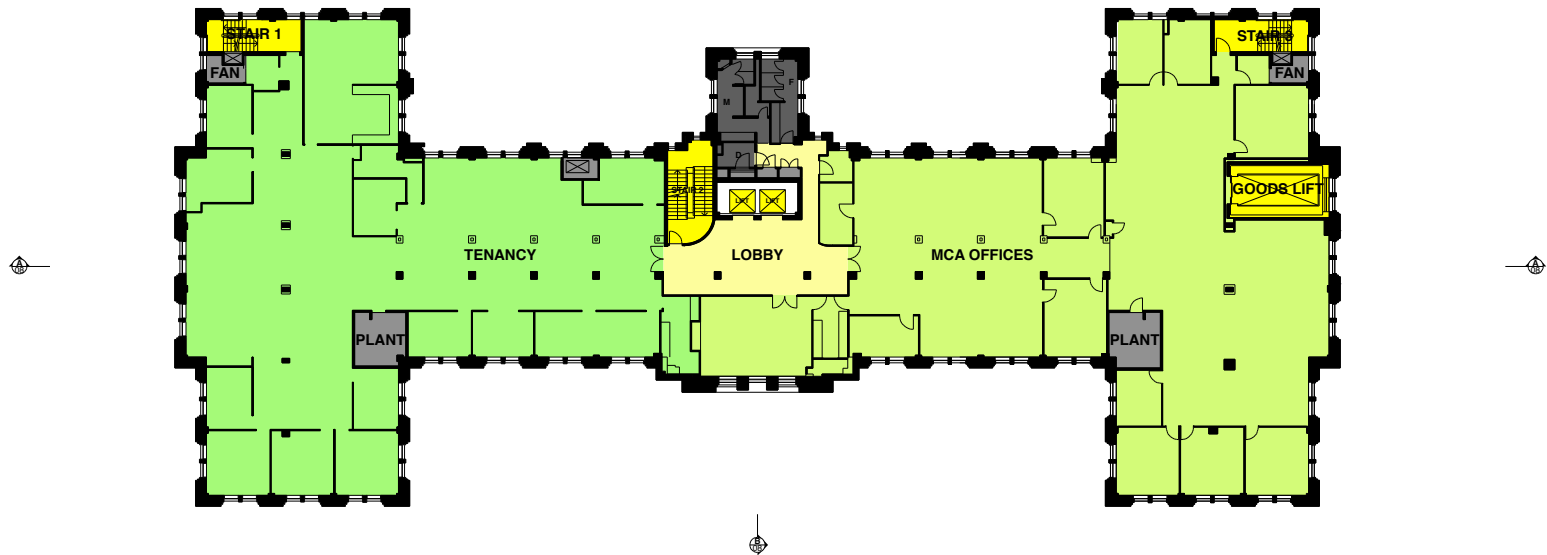


5


AMENDMENTS		LEGEND																	
ISSUE	DATE	DETAILS																	
C	02.12.08	FINAL PROJECT APPLICATION	BOH Back of House CE Common Outdoor Air COA Common Outdoor Air CHA Common Air Exhaust U Unisex Toilet E Electrical FHD Fire Hydrant FHS Fire Hose Reel FSA Fire Supply Air GSA Gallery Supply Air H Hydraulic	KE Kitchen Exhaust Air LC Lighting Controls LE Lighting Exhaust Air LRA Lecture Return Air LSP Lecture Supply Air M Male Toilet OFC Off Form Concrete P Pipework PR Parents Room RO Rainwater Outlet S Sprinklers SW Sewer WE Workshop Exhaust Air															
												ARCHITECTS IN ASSOCIATION		PROJECT MANAGER		CLIENT		PROJECT	
												ARCHITECT MARSHALL PTY LTD		ROOT PROJECTS		MUSEUM OF CONTEMPORARY ART		MUSEUM OF CONTEMPORARY ART	
												CONTACT: SAM MARSHALL		CONTACT: KRISTIN WARK		CONTACT: LUAN UPSTON		REDEVELOPMENT	
												PO BOX 790 DARLINGHURST 1300		LEVEL 18, MCKELL BUILDING 2-28 DAWSON PLACE SYDNEY 2000		LEVEL 5, 27-31 MACQUARIE PLACE SYDNEY 2000		140 GEORGE STREET THE ROCKS 2000	
												PHONE: 02 9310 7555		PHONE: 02 9251 8480		PHONE: 02 9251 8040		DRAWING NO.	
												FAX: 02 9310 4144		FAX: 02 9251 8144		FAX: 02 9241 5844		SCALE	
												EMAIL: sam@marshall.net.au		EMAIL: kristin@rootprojects.com.au		EMAIL: luan.upston@mca.com.au		1:500 @ A3	
																		DO NOT SCALE DRAWINGS. USE DIMENSIONS NOTED ON SITE.	
																		IF ANY DIMENSIONS ON SITE DIFFER FROM THOSE NOTED, THE DIMENSIONS ON SITE SHALL PREVAIL.	
																		IF IN DOUBT, PLEASE ASK.	
																		DRAWING NO.	
																		PA06 C	

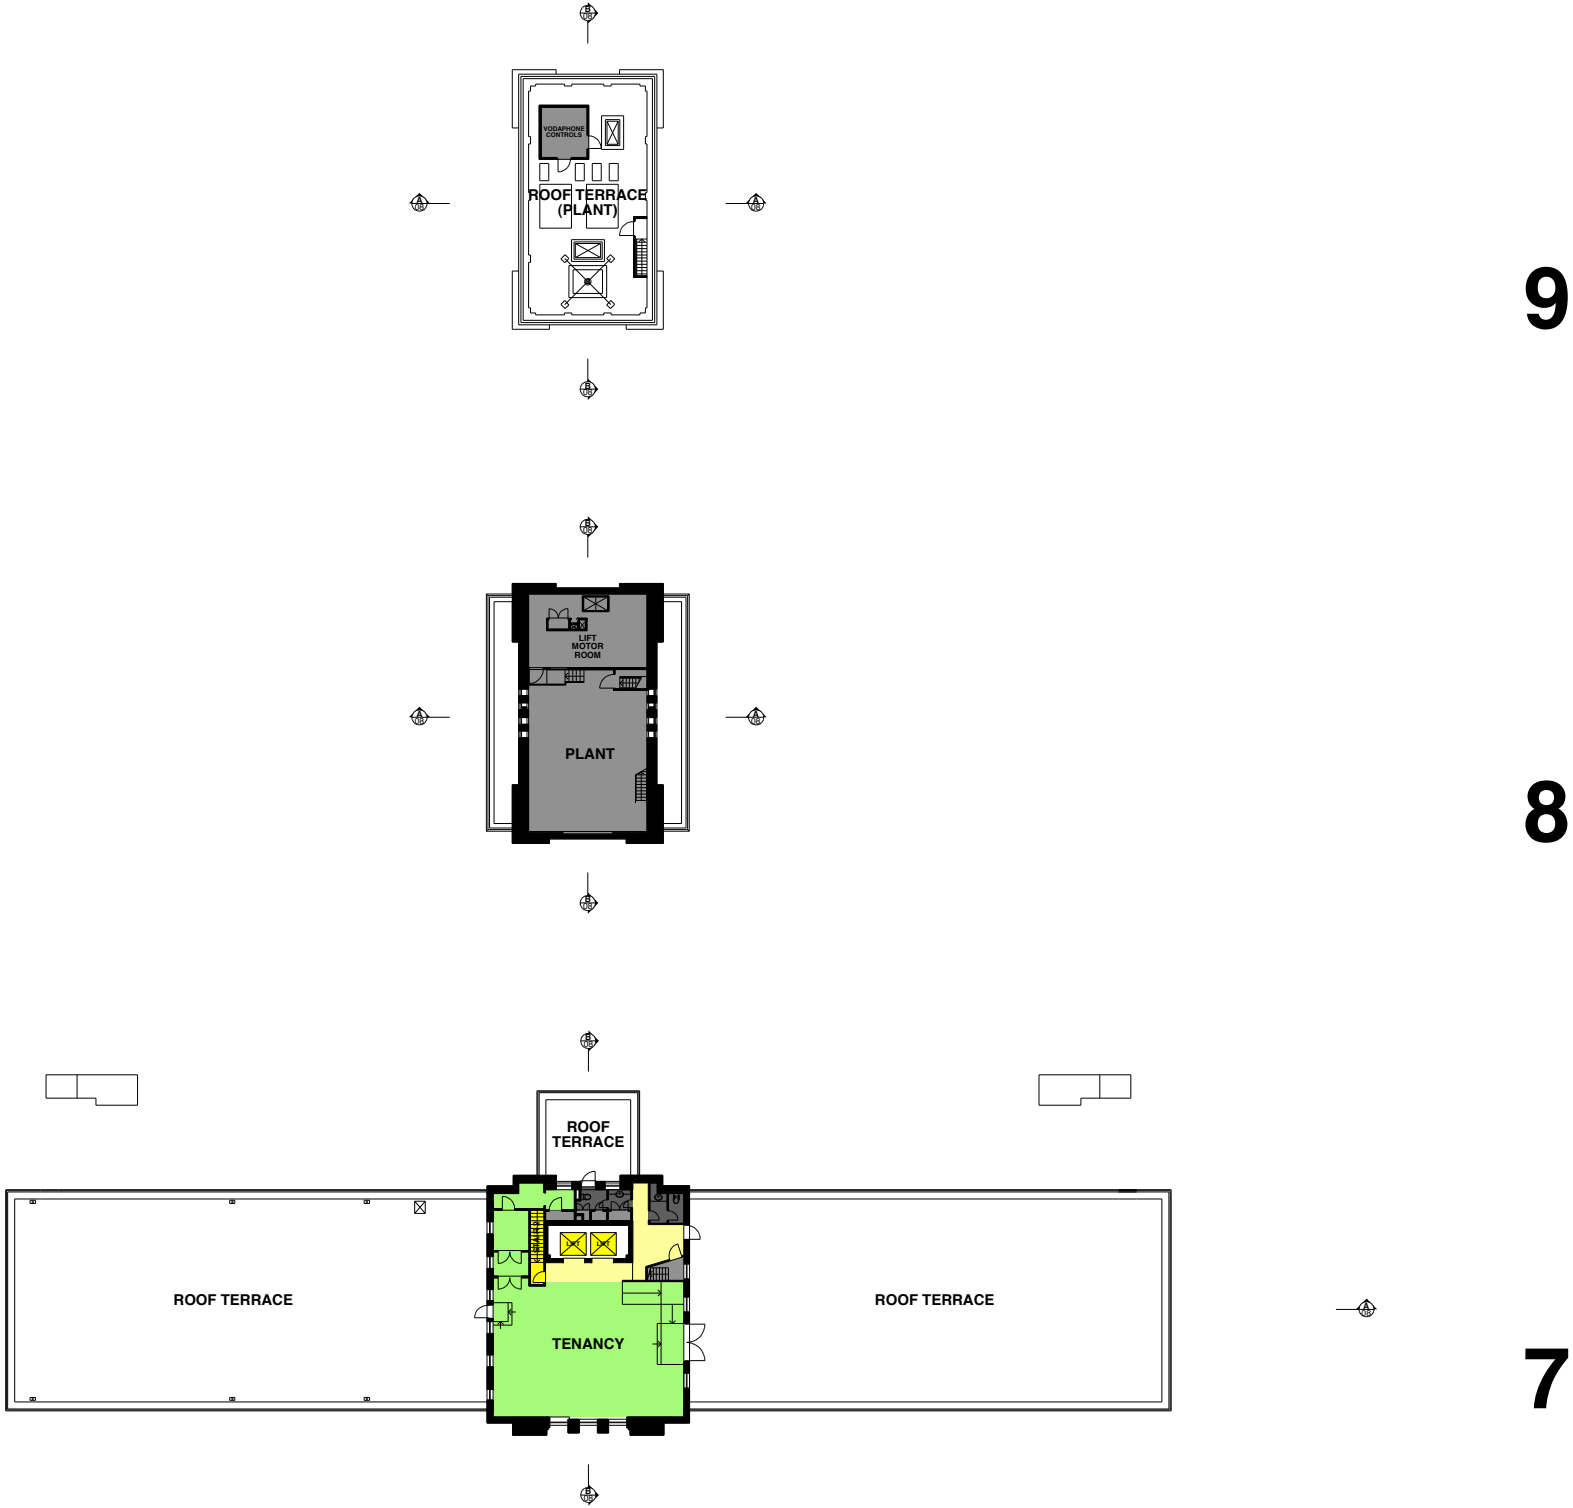


AMENDMENTS		LEGEND															
ISSUE	DATE	DETAILS															
C	02.12.08	FINAL PROJECT APPLICATION	BOH Back of House CE Common Exhaust Air COA Common Outdoor Air CHA Common Air Relief U Unisex Toilet E Electrical FHD Fire Hydrant FHS Fire Hose Reel FSA Foyer Supply Air GSA Gallery Supply Air GRC Glass Reinforced Cement GSA Gallery Supply Air H Hydraulics	KE Kitchen Exhaust Air LE Lighting Controls LEA Lecture Return Air LSP Lecture Supply Air M Male Toilet OFC Off Form Concrete P Pipework PR Parents Room RO Rainwater Outlet S Sprinklers SW Sewer WE Workshop Exhaust Air													

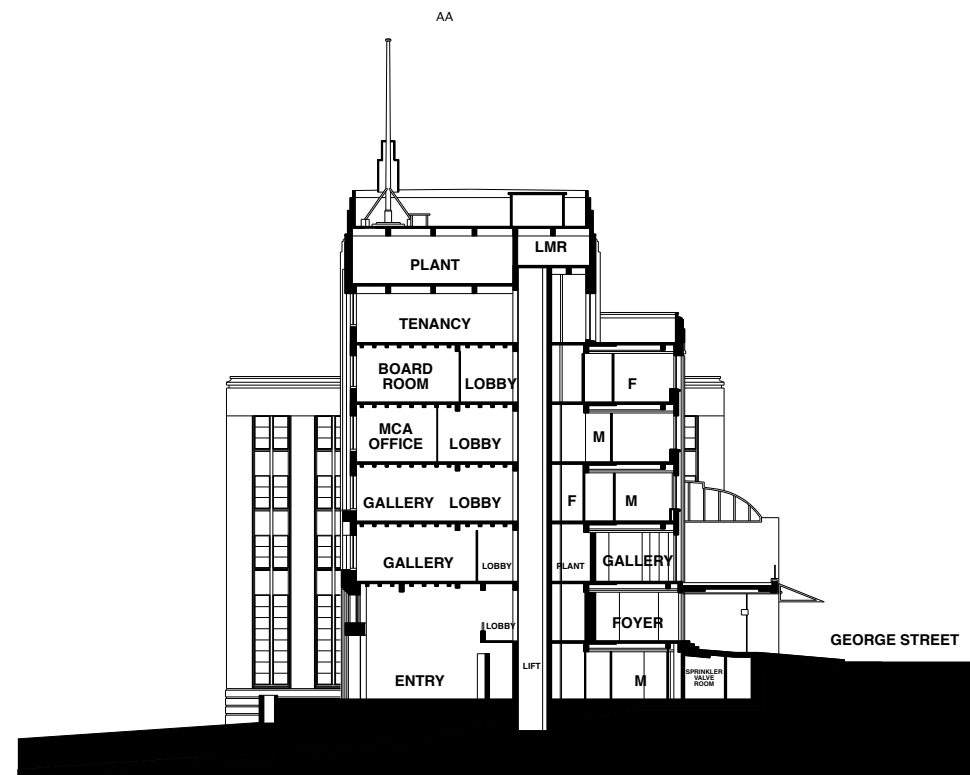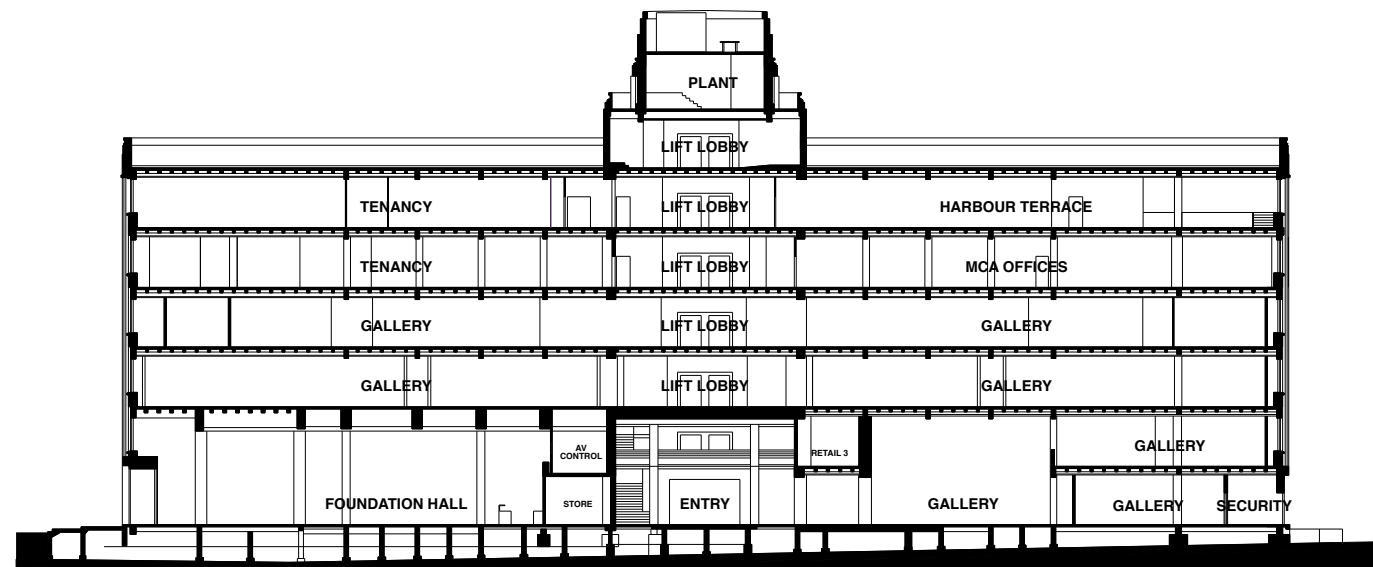

AMENDMENTS			LEGEND						ARCHITECTS IN ASSOCIATION			PROJECT MANAGER			CLIENT			PROJECT			DRAWING DESCRIPTION																																																																																																																																																																																																																																																																																																																																																																																																																																																																																																																																																																																																																																																																																																																																																																																																																																																																																																																																																																																																																																																																																																																																																																																																																																																																																																																																													
ISSUE	DATE	DETAILS	BOH	Bank of Housing	KE	Kitchens Exhaust Air	LG	Lighting Control	LRA	Lecture Return Air	LSA	Lecture Supply Air	OF	Off Form Concrete	PR	Parking Room	RO	Room Exhaust	SW	Sewer	WE	Workshop Exhaust Air																																																																																																																																																																																																																																																																																																																																																																																																																																																																																																																																																																																																																																																																																																																																																																																																																																																																																																																																																																																																																																																																																																																																																																																																																																																																																																																																												</

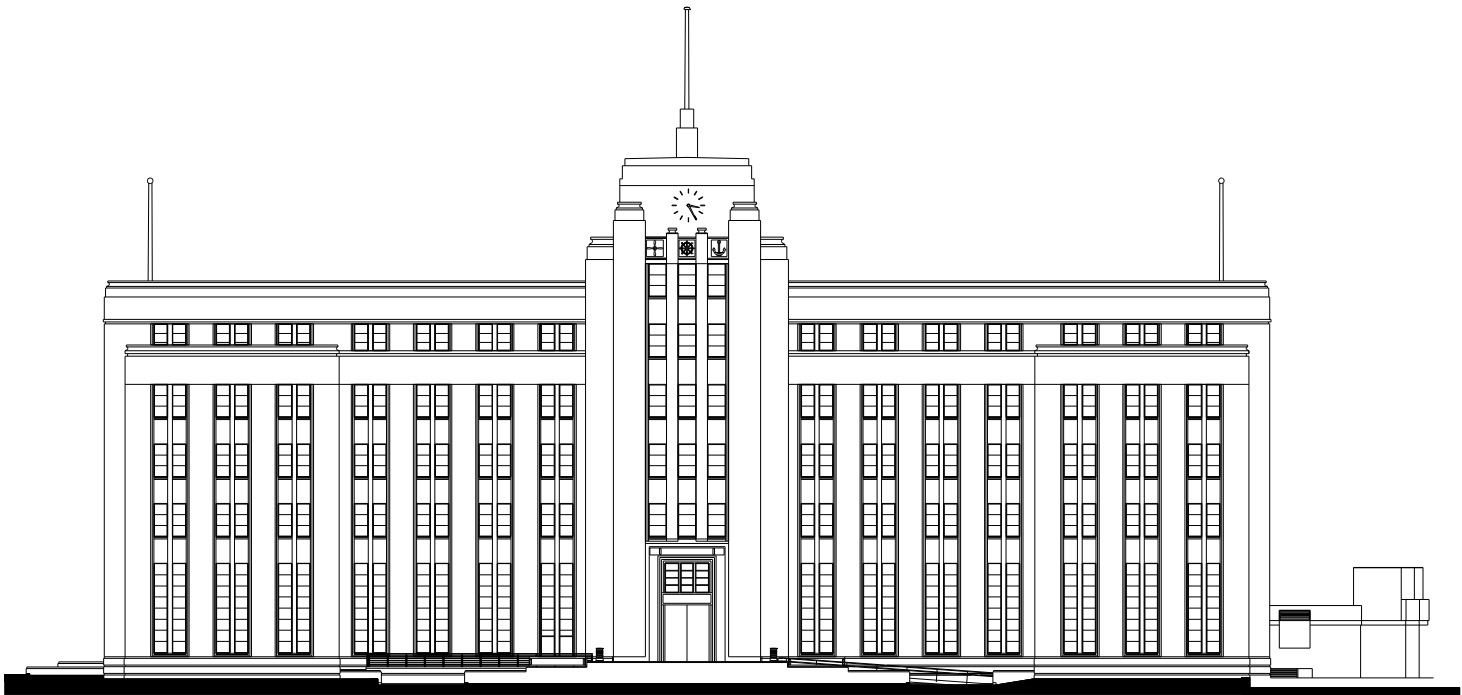

EAST
(CIRCULAR QUAY)

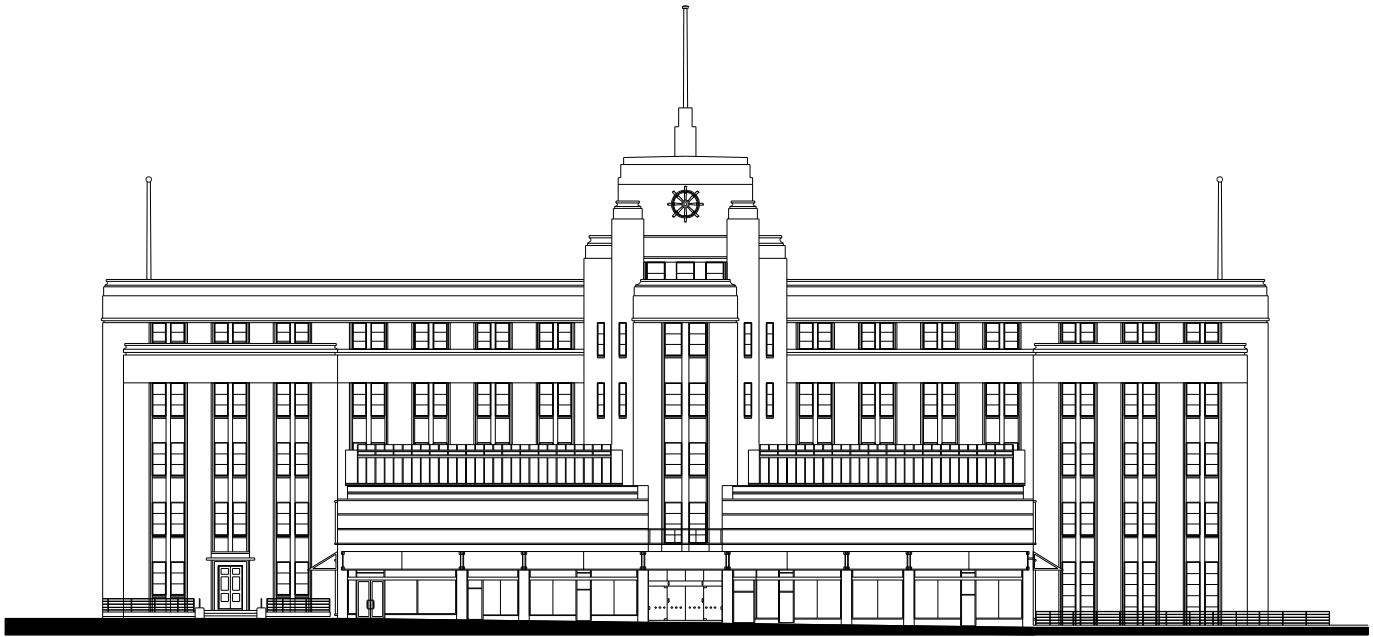


WEST
(GEORGE STREET)

AMENDMENTS		LEGEND		ARCHITECTS IN ASSOCIATION		PROJECT MANAGER		CLIENT		PROJECT		DRAWING DESCRIPTION	
ISSUE	DATE	DETAILS											
C	02.12.08	FINAL PROJECT APPLICATION	BOH Back of House CE Common Exhaust Air COA Common Outdoor Air CHA Common Air Panel U Unisex Toilet E Electrical F Female Toilet FHD Fire Hydrant FHS Fire Hose Reel FSA Foyer Supply Air GSA Gallery Supply Air GRC Glass Reinforced Cement GSA Gallery Supply Air H Hydraulics	KE Kitchen Exhaust Air LC Lighting Controls LE Lighting Exhaust Air LRA Lecture Return Air LPA Lecture Supply Air M Male Toilet OFC Off Form Concrete P Pipework PR Parents Room RO Rainwater Outlet S Sprinklers SW Sewer WE Workshop Exhaust Air	ARCHITECTS IN ASSOCIATION ARCHITECT MARSHALL PTY LTD CONTACT: SAM MARSHALL	NSW DEPARTMENT OF COMMERCE GOVERNMENT ARCHITECTS OFFICE PETER MOULD NSW GOVERNMENT ARCHITECT NSW ARB NO. 3301 CONTACT: WILLIAM PHELPS	PROJECT MANAGER ROOT PROJECTS AUSTRALIA CONTACT: KRISTIN WARK	MUSEUM OF CONTEMPORARY ART CONTACT: LUAN UPSTON	MUSEUM OF CONTEMPORARY ART REDEVELOPMENT	EAST & WEST ELEVATIONS EXISTING	140 GEORGE STREET CIRCULAR QUAY	DO NOT SCALE DRAWINGS. USE FIGURED DIMENSIONS ONLY. VERTICAL DIMENSIONS ON SITE. DIMENSIONS ARE TO FINISHED SURFACES UNLESS OTHERWISE NOTED. IF IN DOUBT, PLEASE ASK.	ISSUE
											SCALE 1:500 @ A3	PA09 C	



NORTH

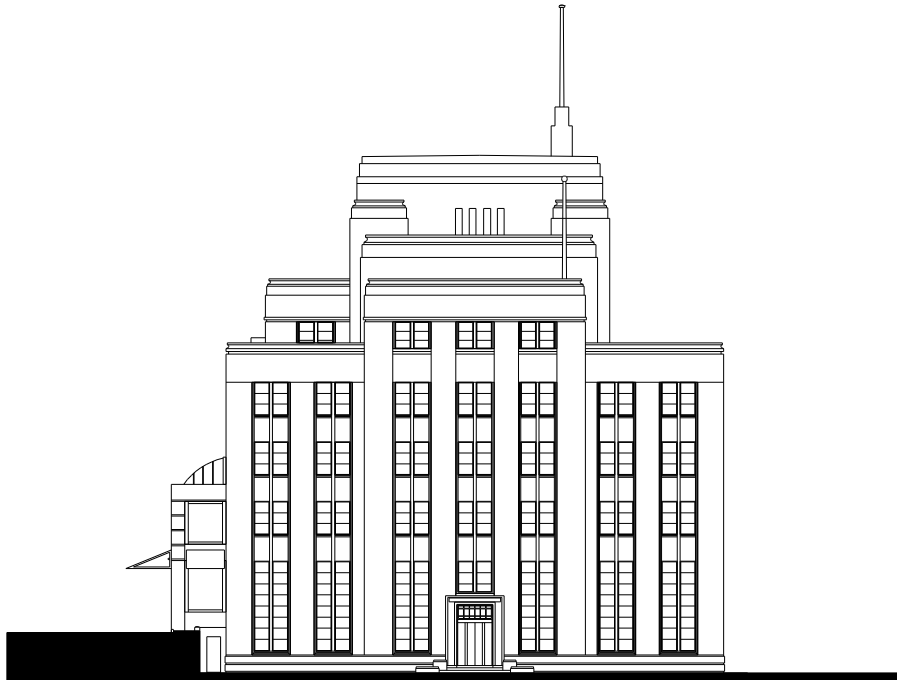

SOUTH

AMENDMENTS		LEGEND		ARCHITECTS IN ASSOCIATION		PROJECT MANAGER		CLIENT		PROJECT		DRAWING DESCRIPTION	
ISSUE	DATE	DETAILS											
C	02.12.08	FINAL PROJECT APPLICATION	BOH Back of House CE Common Exhaust Air COA Common Outdoor Air CHA Common Air Detail U Unusable Toilet E Electrical FHD Fire Hydrant FHS Fire Hose Reel FSA Foyer Supply Air GSA Gallery Supply Air GSA Gallery Supply Air H Hydraulics	KE Kitchen Exhaust Air LC Lighting Controls LE Lighting Exhaust Air LRA Lecture Return Air LPA Lecture Supply Air M Male Toilet OFC Off Form Concrete P Pipework PR Parents Room RO Rainwater Outlet S Sprinklers SW Sewer WE Workshop Exhaust Air		ARCHITECT MARSHALL PTY LTD CONTACT: SAM MARSHALL PO BOX 790 DARLINGHURST 1500 PHONE: 02 9310 7555 FAX: 02 9310 4144 EMAIL: sam@marshall.net.au	NSW DEPARTMENT OF COMMERCE GOVERNMENT ARCHITECTS OFFICE PETER MOULD NSW GOVERNMENT ARCHITECT NSW ARB NO. 3301 CONTACT: WILLIAM PHELPS LEVEL 18, MAKELL BUILDING 2-34 RAWSON PLACE SYDNEY 2000 PHONE: 02 9372 8469 FAX: 02 9372 8469 EMAIL: william.phelps@commerce.nsw.gov.au	ROOT PROJECTS AUSTRALIA CONTACT: KRISTIN WARK LEVEL 5, 27-31 MACQUARIE PLACE SYDNEY 2000 PHONE: 02 9251 8040 FAX: 02 9251 8144 EMAIL: kristin@rootprojects.com.au	MUSEUM OF CONTEMPORARY ART CONTACT: EUAN UPSTON 140 GEORGE STREET THE ROCKS 2000 PHONE: 02 9245 2416 FAX: 02 9241 5844 EMAIL: euan.upston@mca.com.au	MUSEUM OF CONTEMPORARY ART REDEVELOPMENT 140 GEORGE STREET CIRCULAR QUAY DO NOT SCALE DRAWINGS. USE FIGURED DIMENSIONS ONLY. VERTICAL DIMENSIONS ON SITE. DIMENSIONS ARE TO FINISHED SURFACES UNLESS OTHERWISE NOTED. IF IN DOUBT, PLEASE ASK.	NORTH & SOUTH ELEVATIONS EXISTING SCALE 1:500 @ A3 DRAWING No: PA10 ISSUE: C		