


STAR CITY PTY LIMITED
80 PYRMONT STREET
PYRMONT NSW 2009

CLIENT
STAR CITY PTY LTD
DATUM = A.H.D.

DP	DOWNPIPE
e	EXISTING
IL	INVERT LEVEL
l/s	LITRES PER SECOND
M	METRES
mm	MILLIMETRES
RWO	RAINWATER OUTLET
SDP	SYPHONIC DOWNPIPE
SWD	STORMWATER DRAIN
SWIC	STORMWATER INSPECTION CHAMBER
SWRM	STORMWATER RISING MAIN
TYP	TYPICAL

Diagram illustrating various stormwater line types and service connections:

- EXISTING STORMWATER LINE (Brown line)
- STORMWATER LINE (Blue line)
- STORMWATER RISING MAIN (Red line)
- SERVICE INFO (DROPPER) (Blue line with blue cap)
- SERVICE INFO (RISER) (Blue line with blue cap and blue riser)
- PIPE DROPPER (Blue line with blue cap and red riser)
- PIPE RISER (Blue line with red cap and red riser)
- CAPPED END (Red line with red cap)

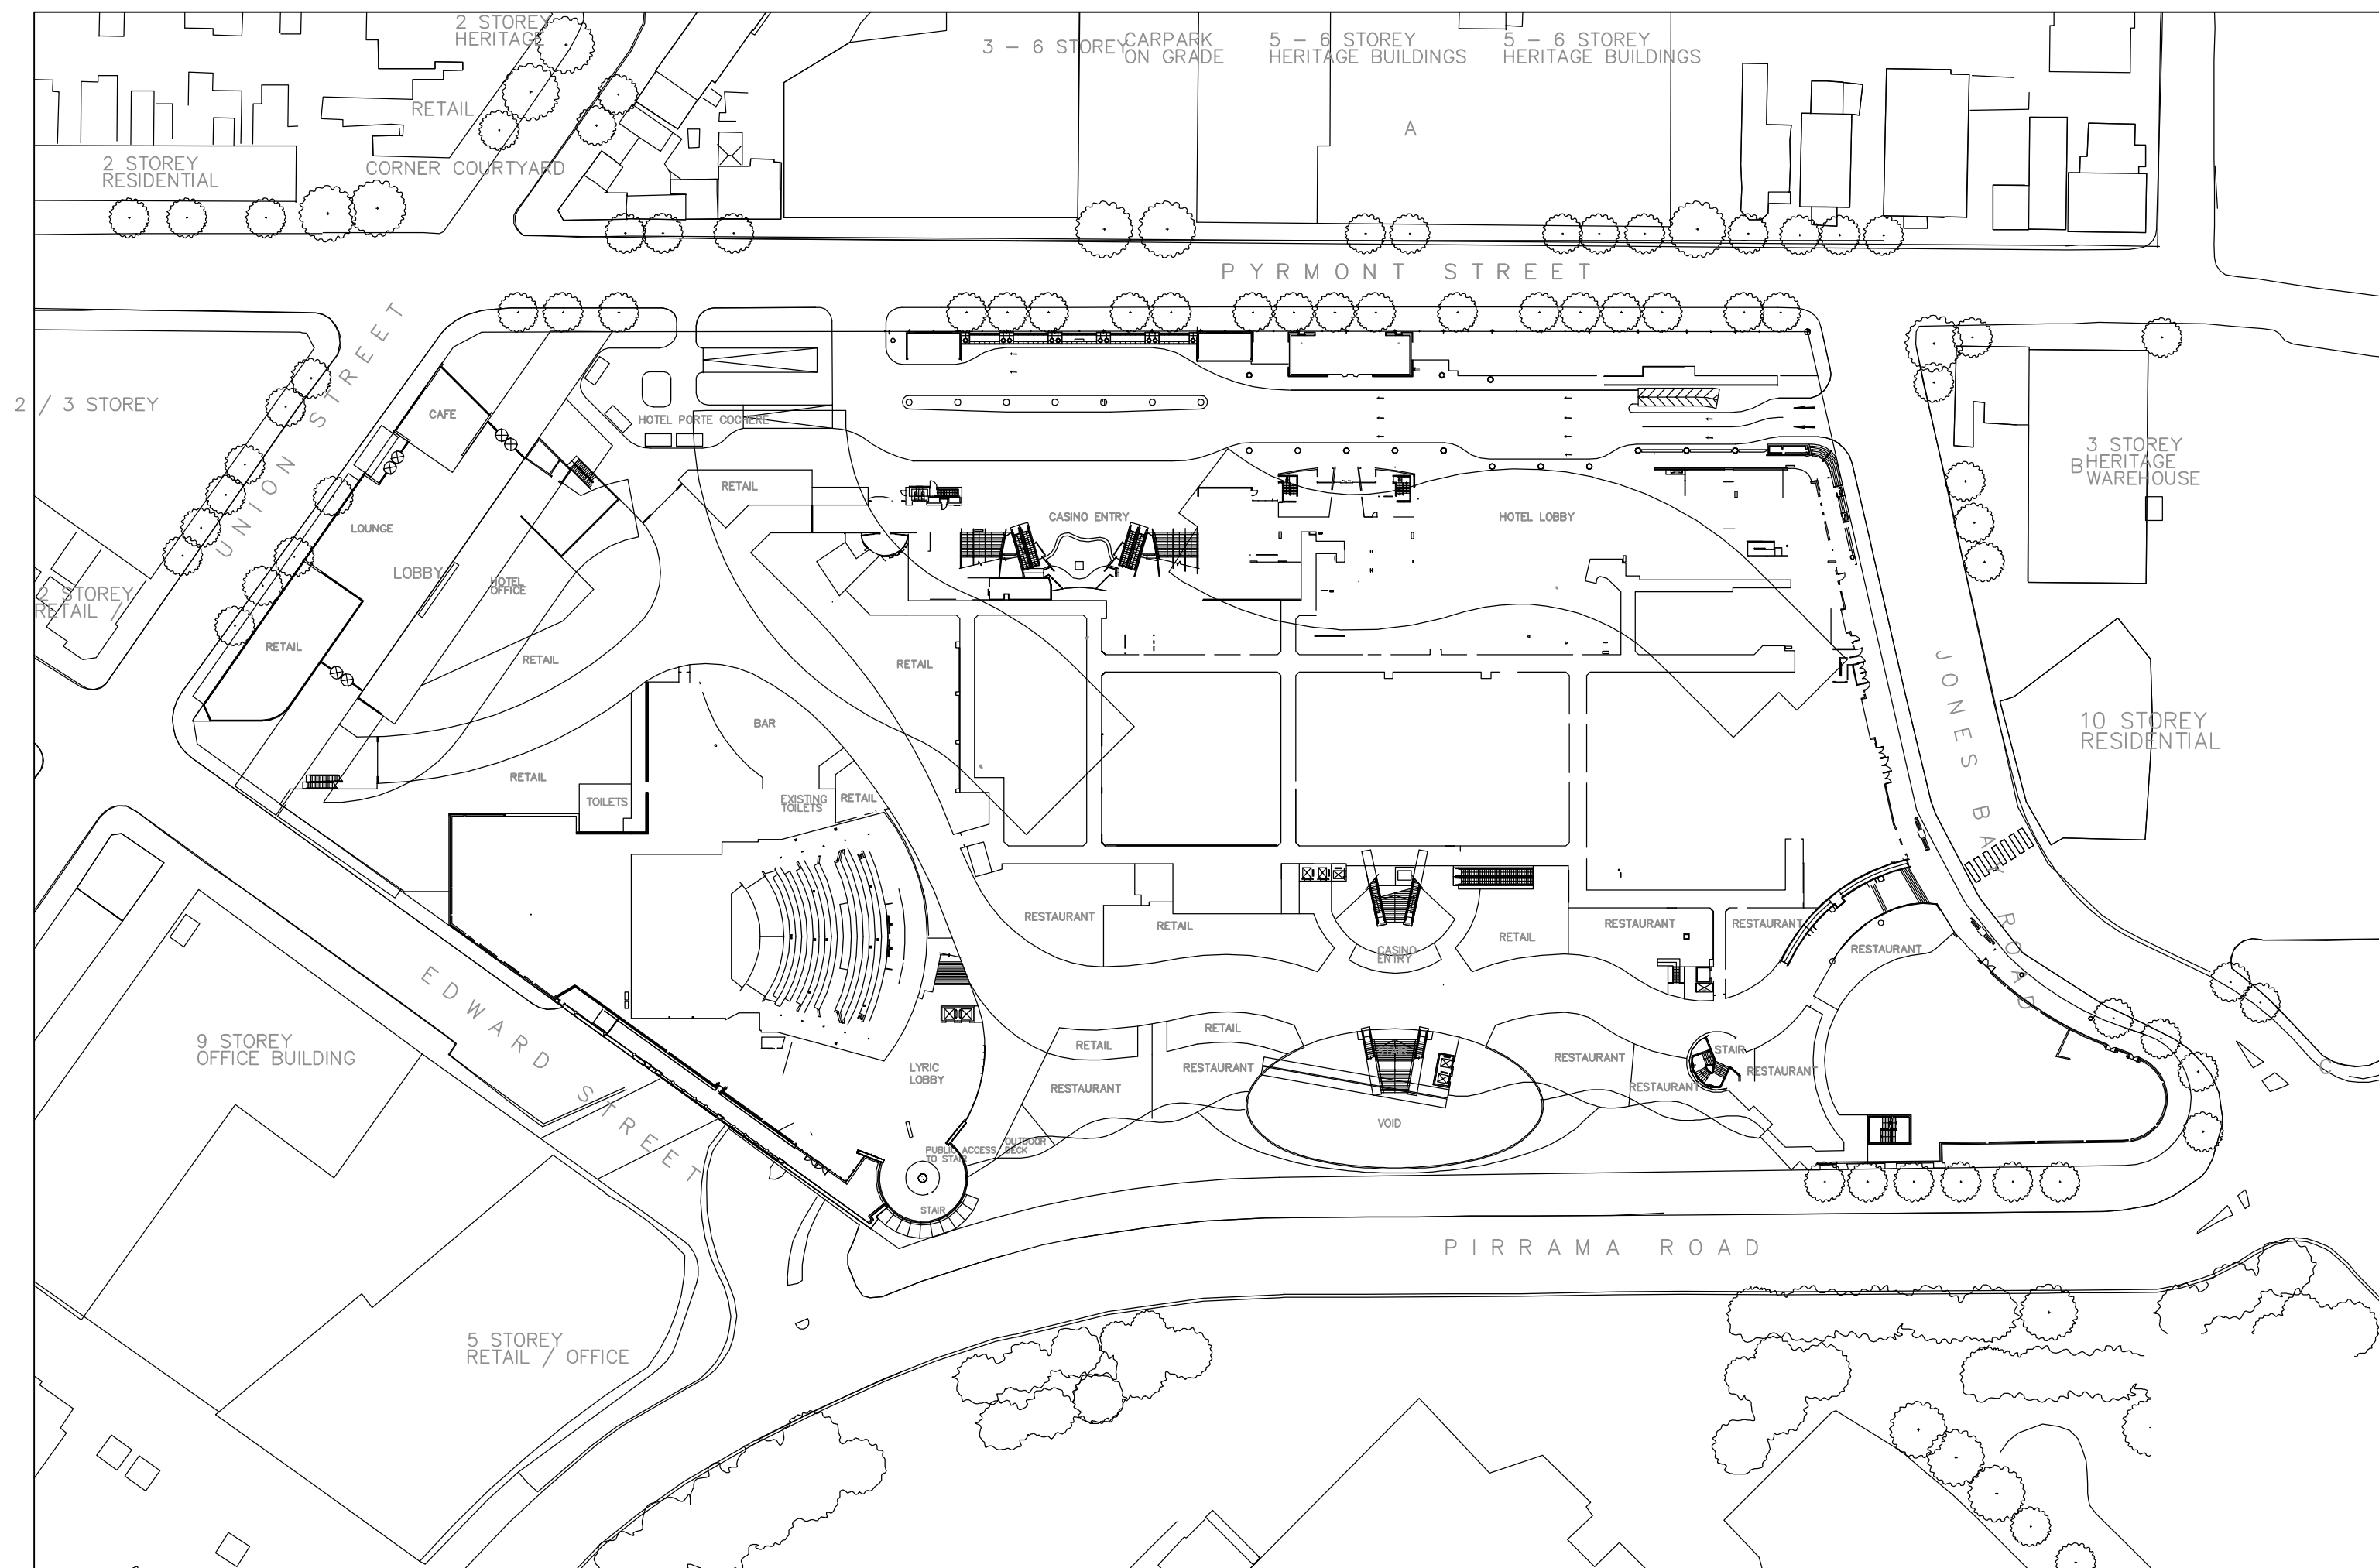

LOCALITY PLAN

DRAWING SCHEDULE CONT.			
DRG	TITLE	SERVICE	SCALE @ A1/A3
H-100	COVER SHEET AND LOCALITY PLAN	N/A	NTS
H-101	SITE PLAN	OVERALL CATCHMENT PLAN	1500 / 1000
H-102	LEVEL B2- CARPARK	EXISTING STORMWATER SERVICE	1200 / 1400
H-103	LEVEL B2- CARPARK	NEW STORMWATER SERVICE	1200 / 1400
H-104	LEVEL B1- CARPARK	STORMWATER SERVICE	1200 / 1400
H-105	LEVEL D0- RETAIL	STORMWATER SERVICE	1200 / 1400
H-106	LEVEL D1- GAMING	STORMWATER SERVICE	1200 / 1400
H-107	LEVEL D2-FUNCTION AREA	STORMWATER SERVICE	1200 / 1400
H-108	LEVEL D3- PODIUM AREA	STORMWATER SERVICE	1200 / 1400

NOTE : SYMBOLS ARE DRAWN IN THE CORRECT POSITION BUT ARE NOT SHOWN TO SCALE

[illegible]

Plan Design:

These plans have been designed to and comply with:

- Queensland Plumbing and drainage act 2002
- Queensland standard plumbing and drainage regulations 2003
- AS/NZS 3500.0 2003 Plumbing and drainage part 0 glossary of terms
- AS/NZS 3500.1 2003 Plumbing and drainage part 1 water service
- AS/NZS 3500.2 2003 Plumbing and drainage part 2 sanitary plumbing and drainage
- AS/NZS 3500.3 2003 Plumbing and drainage part 3 stormwater drainage
- AS/NZS 3500.2 2003 Plumbing and drainage part 4 heated water service
- AS 2419.1 2005 Fire hydrant installations part 1 system design, installation and commissioning
- AS 2441-1988 Installation of fire hose reel

Title Status:

FREEHOLD

Lot & RPD:

Owners Name:
STAR CITY CASINO

Tenant:

Project Manager

THE **BUCHAN** GROUP

Architect:

Cox Richardson

Level 2, 204 Clarence Street, Sydney 2000 Australia
Tel : 612 9267 9599 Fax : 612 9294 5844
Email : sydney@cox.com.au

Architecture Planning Urban design Interior design Health facility design

COX

Hydraulic Consultant:

**STEVE PAUL &
SPP**

PARTNERS

Hydraulic Fire Environmental

A.C.N.: 111 500 415 A.B.N.: 45 111 500 415
EMAIL: mail@brisppap.com.au
WEBSITE: www.stevepaulpartners.com

95 Leichhardt Street
P.O. Box 878
SPRING HILL QLD 4004
Ph (07) 3846 3077
Fax (07) 3844 4665


The Quality Standard
for
Business
Performance

Project:

STAR PROJECT

Drawing Title:


HYDRAULIC SERVICES
COVER SHEET
NOTES, LEGEND &
ABBREVIATIONS


North Point:

North Point:	BSA Licence No. 1087912
	Design: PHIL TURNER
	Design Validated: TONY SAMOROWSKI
	Drawn: PAUL LINDSAY

Date: 07.06.2008		Scale: (A1) NTS (A3) NTS		Sheet: 1 OF 9	
Job No:		Disc:		Dwg No:	
Stage:		Issue:			
BN08101-SW-100 - P - 1					
0 10 20 30 40 50 ORIGINAL SIZE: A1					

PLOTTED BY: 'bkolade'

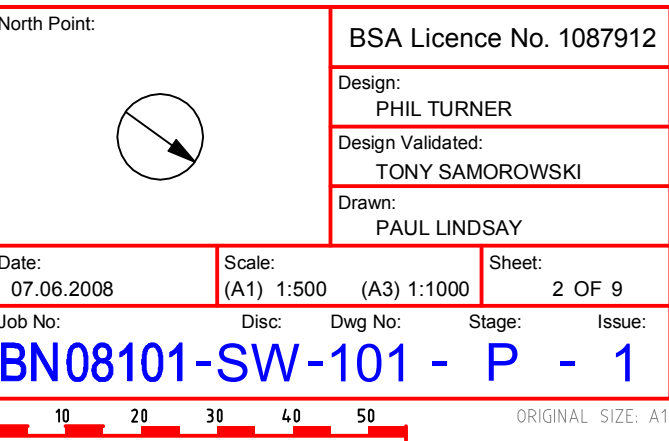

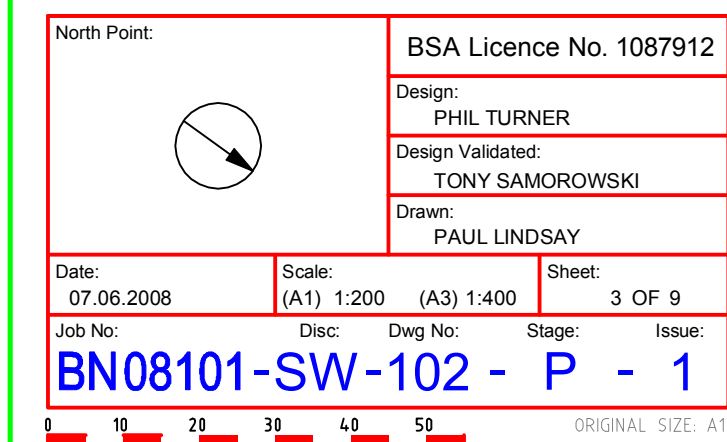

NOTE : SYMBOLS ARE DRAWN IN THE CORRECT POSITION BUT ARE NOT SHOWN TO SCALE

[illegible]

Plan Design:

These plans have been designed to and comply with:

- Queensland Plumbing and drainage act 2002
- Queensland standard plumbing and drainage regulations 2003
- AS/NZS 3500.0.2003 Plumbing and drainage part 0 glossary of terms
- AS/NZS 3500.1.2003 Plumbing and drainage part 1 water service
- AS/NZS 3500.2.2003 Plumbing and drainage part 2 sanitary plumbing and drainage
- AS/NZS 3500.2.2003 Plumbing and drainage part 3 stormwater drainage
- AS/NZS 3500.2.2003 Plumbing and drainage part 4 heated water service
- AS 2419.1.2005 Fire hydrant installations part 1 system design, installation and commissioning
- AS 2441.1988 Installation of fire hose reel

Title Status:

FREEHOLD

Lot & RPD:

Owners Name: **STAR CITY CASINO**

Tenant:

Project Manager

THE BUCHAN GROUP

Architect:

Cox Richardson

Level 2, 204 Clarence Street, Sydney 2000 Australia
Tel : 612 9267 5999 Fax : 612 9264 5844
Email : sydney@cox.com.au

Architecture Planning Urban design Interior design Health facility design

COX

Hydraulic Consultant:

STEVE PAUL & SPP

95 Leichhardt Street
P.O. Box 878
SPRING HILL QLD 4004

Ph (07) 3846 3067
Fax (07) 3844 4077

PARTNERS

Hydraulic Fire Environmental

A.C.N.: 111 500 415 A.B.N.: 45 111 500 415
EMAIL: mail@brisspap.com.au
WEBSITE: <http://www.stevepaulpartners.com>



brisspap
HYDRAULIC FIRE ENVIRONMENTAL
SPECIALISTS

Project: _____

STAR PROJECT

Drawing Title:

HYDRAULIC SERVICES
STORMWATER
CONCEPT PLAN
LEVEL B1 - CARPARK
STAR HOTEL

North Point:	PCA License No. 1007010
--------------	-------------------------



BSA Licence No. 108/912
Design: PHIL TURNER
Design Validated: TONY SAMOROWSKI
Drawn: PAUL LINDSAY

Date:	Scale:	Sheet:
-------	--------	--------

07.06.2008	(A1) 1:200	(A3) 1:400	5 OF 9	
Job No:	Disc:	Draw No:	Stage:	Issue:

Job No: **BN08101** Disc: **SW** Dwg No: **104** Stage: **D** Issue: **1**

BN06101-SW-104 - P - 1

0 10 20 30 40 50 ORIGINAL SIZE: A1

NOTE : SYMBOLS ARE DRAWN IN THE CORRECT POSITION BUT ARE NOT SHOWN TO SCALE

[illegible]

Title Status:	FREEHOLD
Lot & RPD:	

Owners Name:	STAR CITY CASINO
Tenant:	

Project Manager

THE **BUCHAN** GROUP



Architect:

Cox Richardson

Level 2, 204 Clarence Street, Sydney 2000 Australia
Tel: 612 9287 9099 Fax: 612 9284 5844
Email: sydney@cox.com.au

Architecture Planning Urban design Interior design Health facility design

COX

Hydraulic Consultant:

STEVE PAUL & SPP PARTNERS

95 Leichhardt Street
P.O. Box 878
SPRING HILL QLD 4004
Ph (07) 3846 3077
Fax (07) 3844 4665

Hydraulic Fire Environmental

A.C.N.: 111 500 415 A.B.N.: 45 111 500 415
EMAIL: mail@brissapp.com.au
WEBSITE: <http://www.stevepaulpartners.com>


brissapp
INCORPORATED
100 83421

Project:

STAR PROJECT


Drawing Title:

HYDRAULIC SERVICES

STORMWATER
CONCEPT PLAN

LEVEL 00 - RETAIL
STAR HOTEL

North Point		BSA Licence No. 1087912	
		Design: PHIL TURNER	
		Design Validated: TONY SAMOROWSKI	
		Drawn: PAUL LINDSAY	
Date: 07.06.2008	Scale: (A1) 1:200 (A3) 1:400	Sheet: 6 OF 9	
Job No:	Disc:	Dwg No:	Issue:
BN08101-SW-105		P - 1	

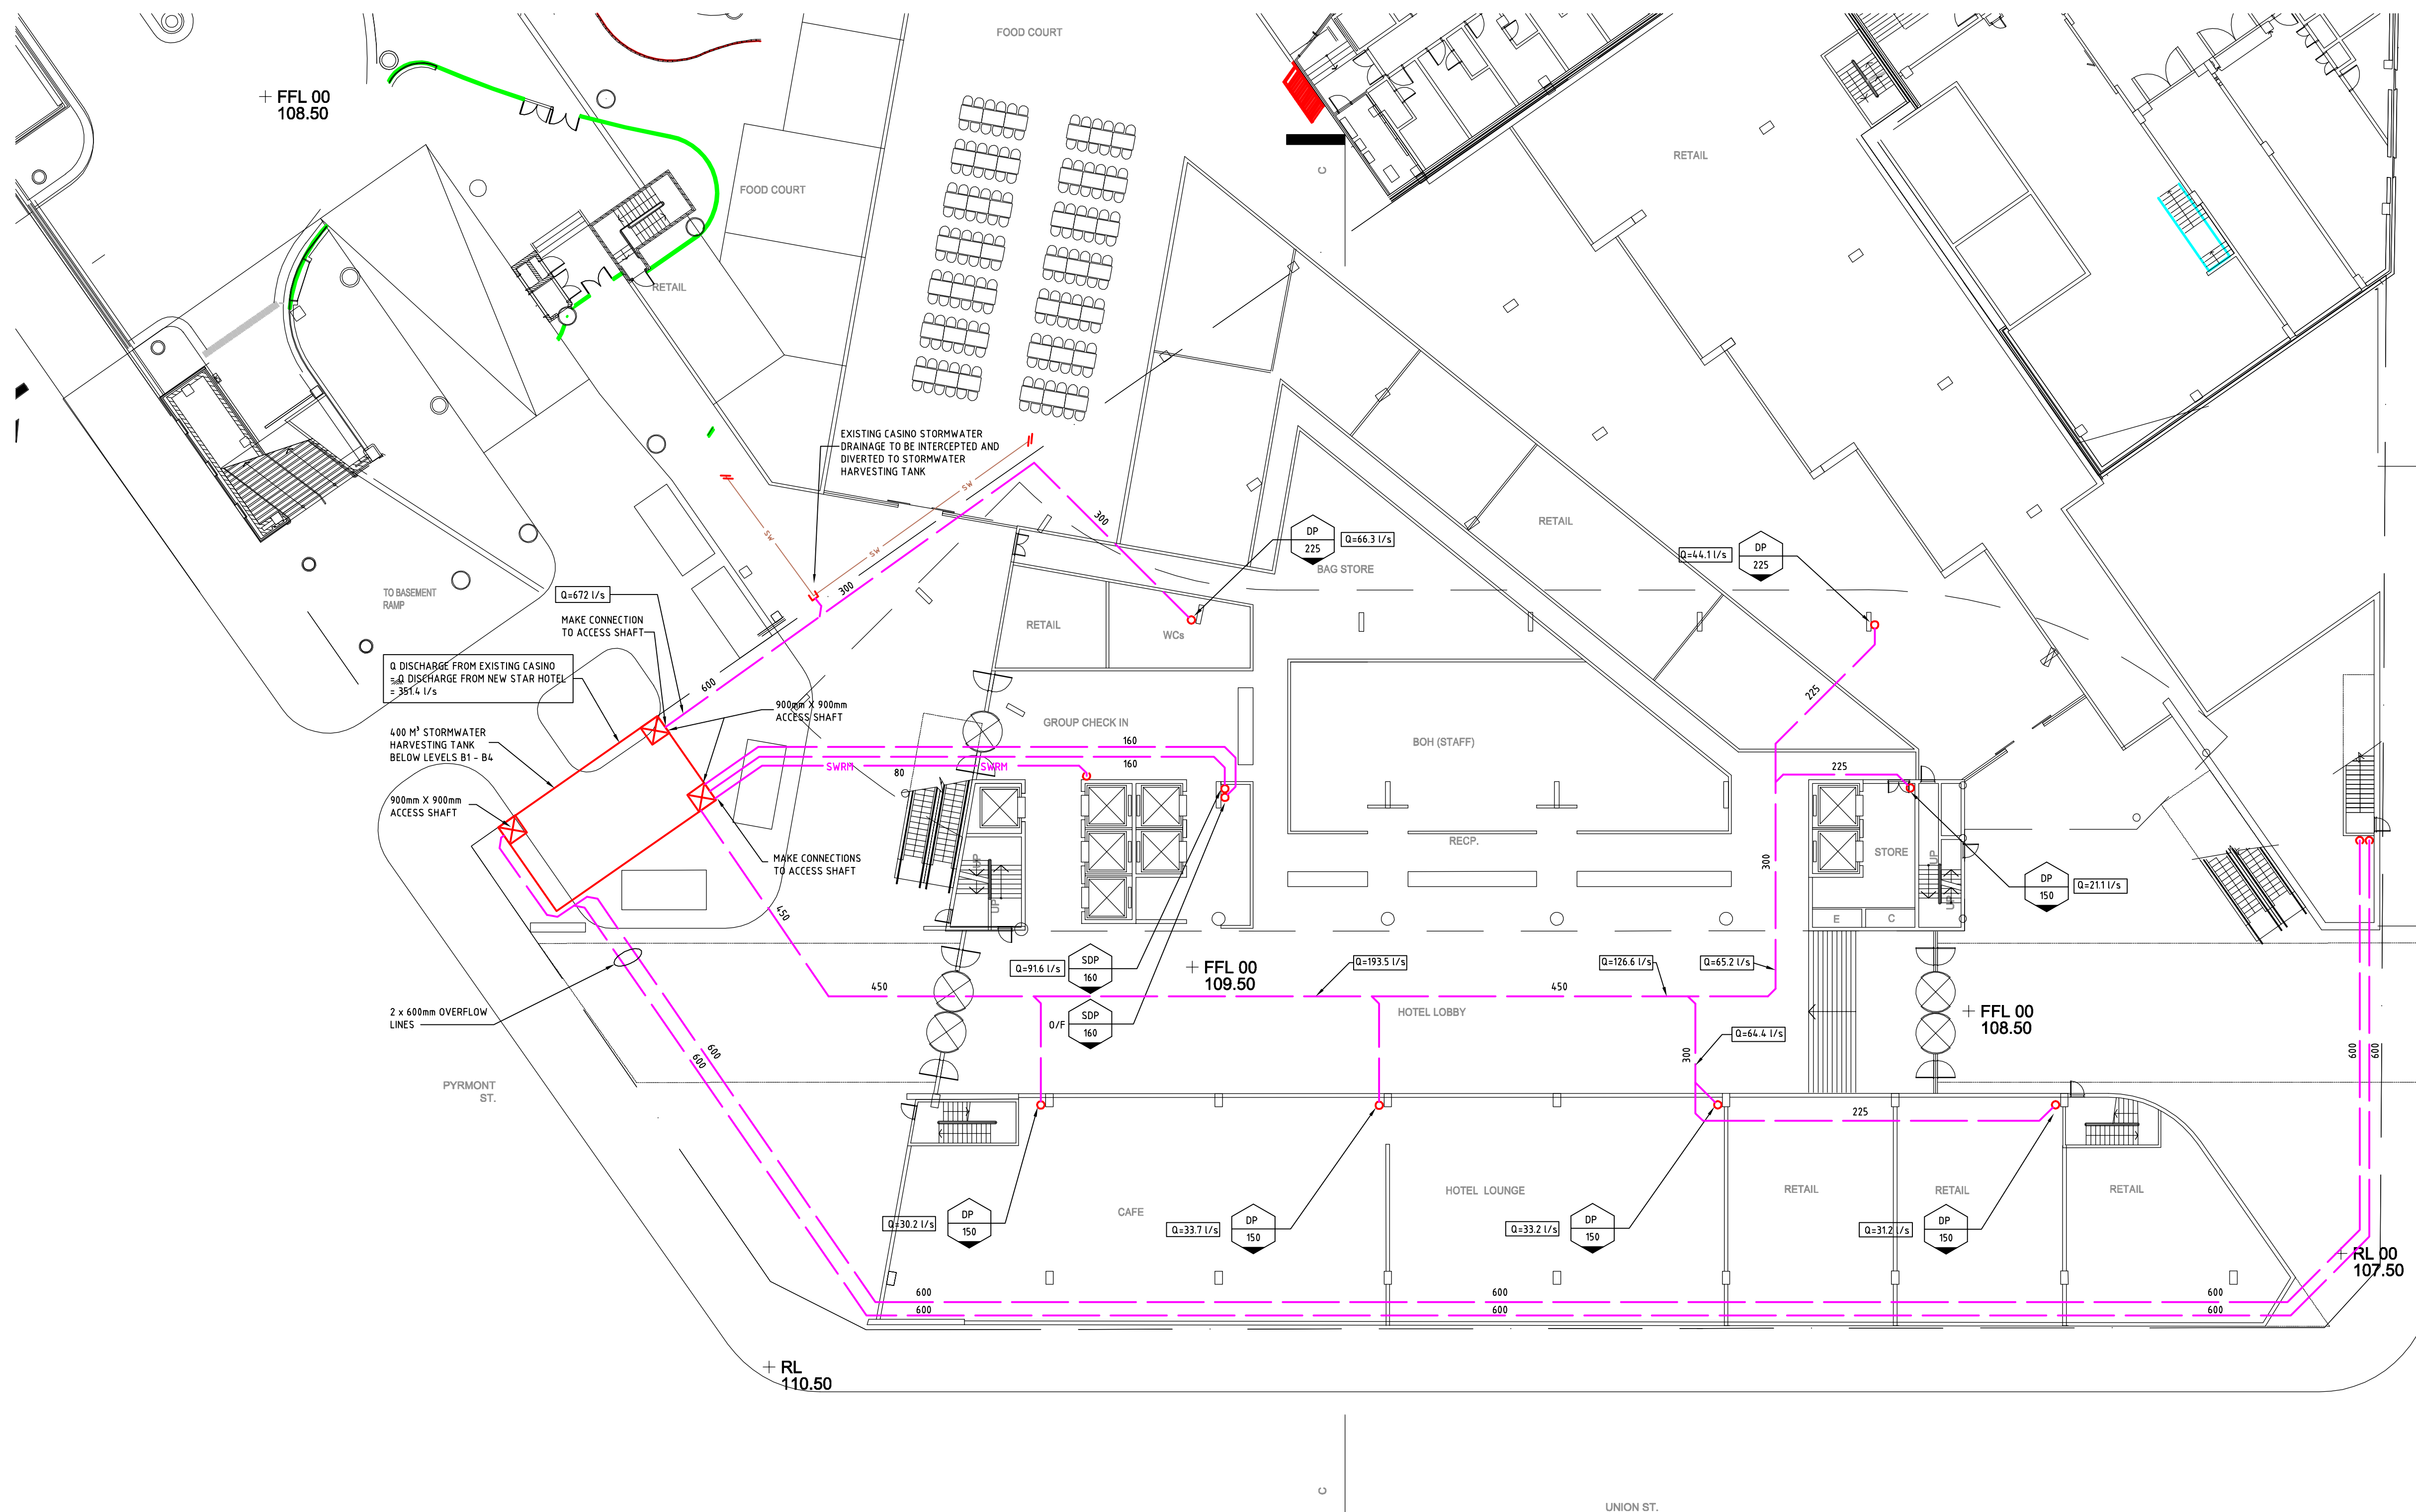

NOTE : SYMBOLS ARE DRAWN IN THE CORRECT POSITION BUT ARE NOT SHOWN TO SCALE

[illegible]

Title Status:	FREEHOLD
Lot & RPD:	

Owners Name:	STAR CITY CASINO
Tenant:	

Project Manager

THE BUCHAN GROUP



Architect:

Cox Richardson

Level 2, 204 Clarence Street, Sydney 2000 Australia
Tel: 612 9287 9599 Fax: 612 9284 5844
Email: sydney@cox.com.au

Architecture Planning Urban design Interior design Health facility design

COX

Hydraulic Consultant:

STEVE PAUL &
SPP
PARTNERS

95 Leichhardt Street
P.O. Box 878
SPRING HILL QLD 4004
Ph (07) 3846 3077
Fax (07) 3844 4665

A.C.N.: 111 500 415 A.B.N.: 45 111 500 415
EMAIL: mail@brisspap.com.au
WEBSITE: <http://www.stevepaulpartners.com>



brisspap
HYDRAULIC CONSULTANTS
180 8321 111

Project:

STAR PROJECT


Drawing Title:

HYDRAULIC SERVICES

STORMWATER
CONCEPT PLAN

LEVEL 01 - GAMING
STAR HOTEL

North Point:		BSA Licence No. 1087921	
		Design: PHIL TURNER	
		Design Validated: TONY SAMOROWSKI	
		Drawn: PAUL LINDSAY	
Date: 07.06.2008	Scale: (A1) 1:200 (A3) 1:400	Sheet: 7 OF 9	
Job No:	Disc:	Dwg No:	Issue:
BN08101-SW-106		P - 1	
0 10 20 40 50		ORIGINAL SIZE: A1	

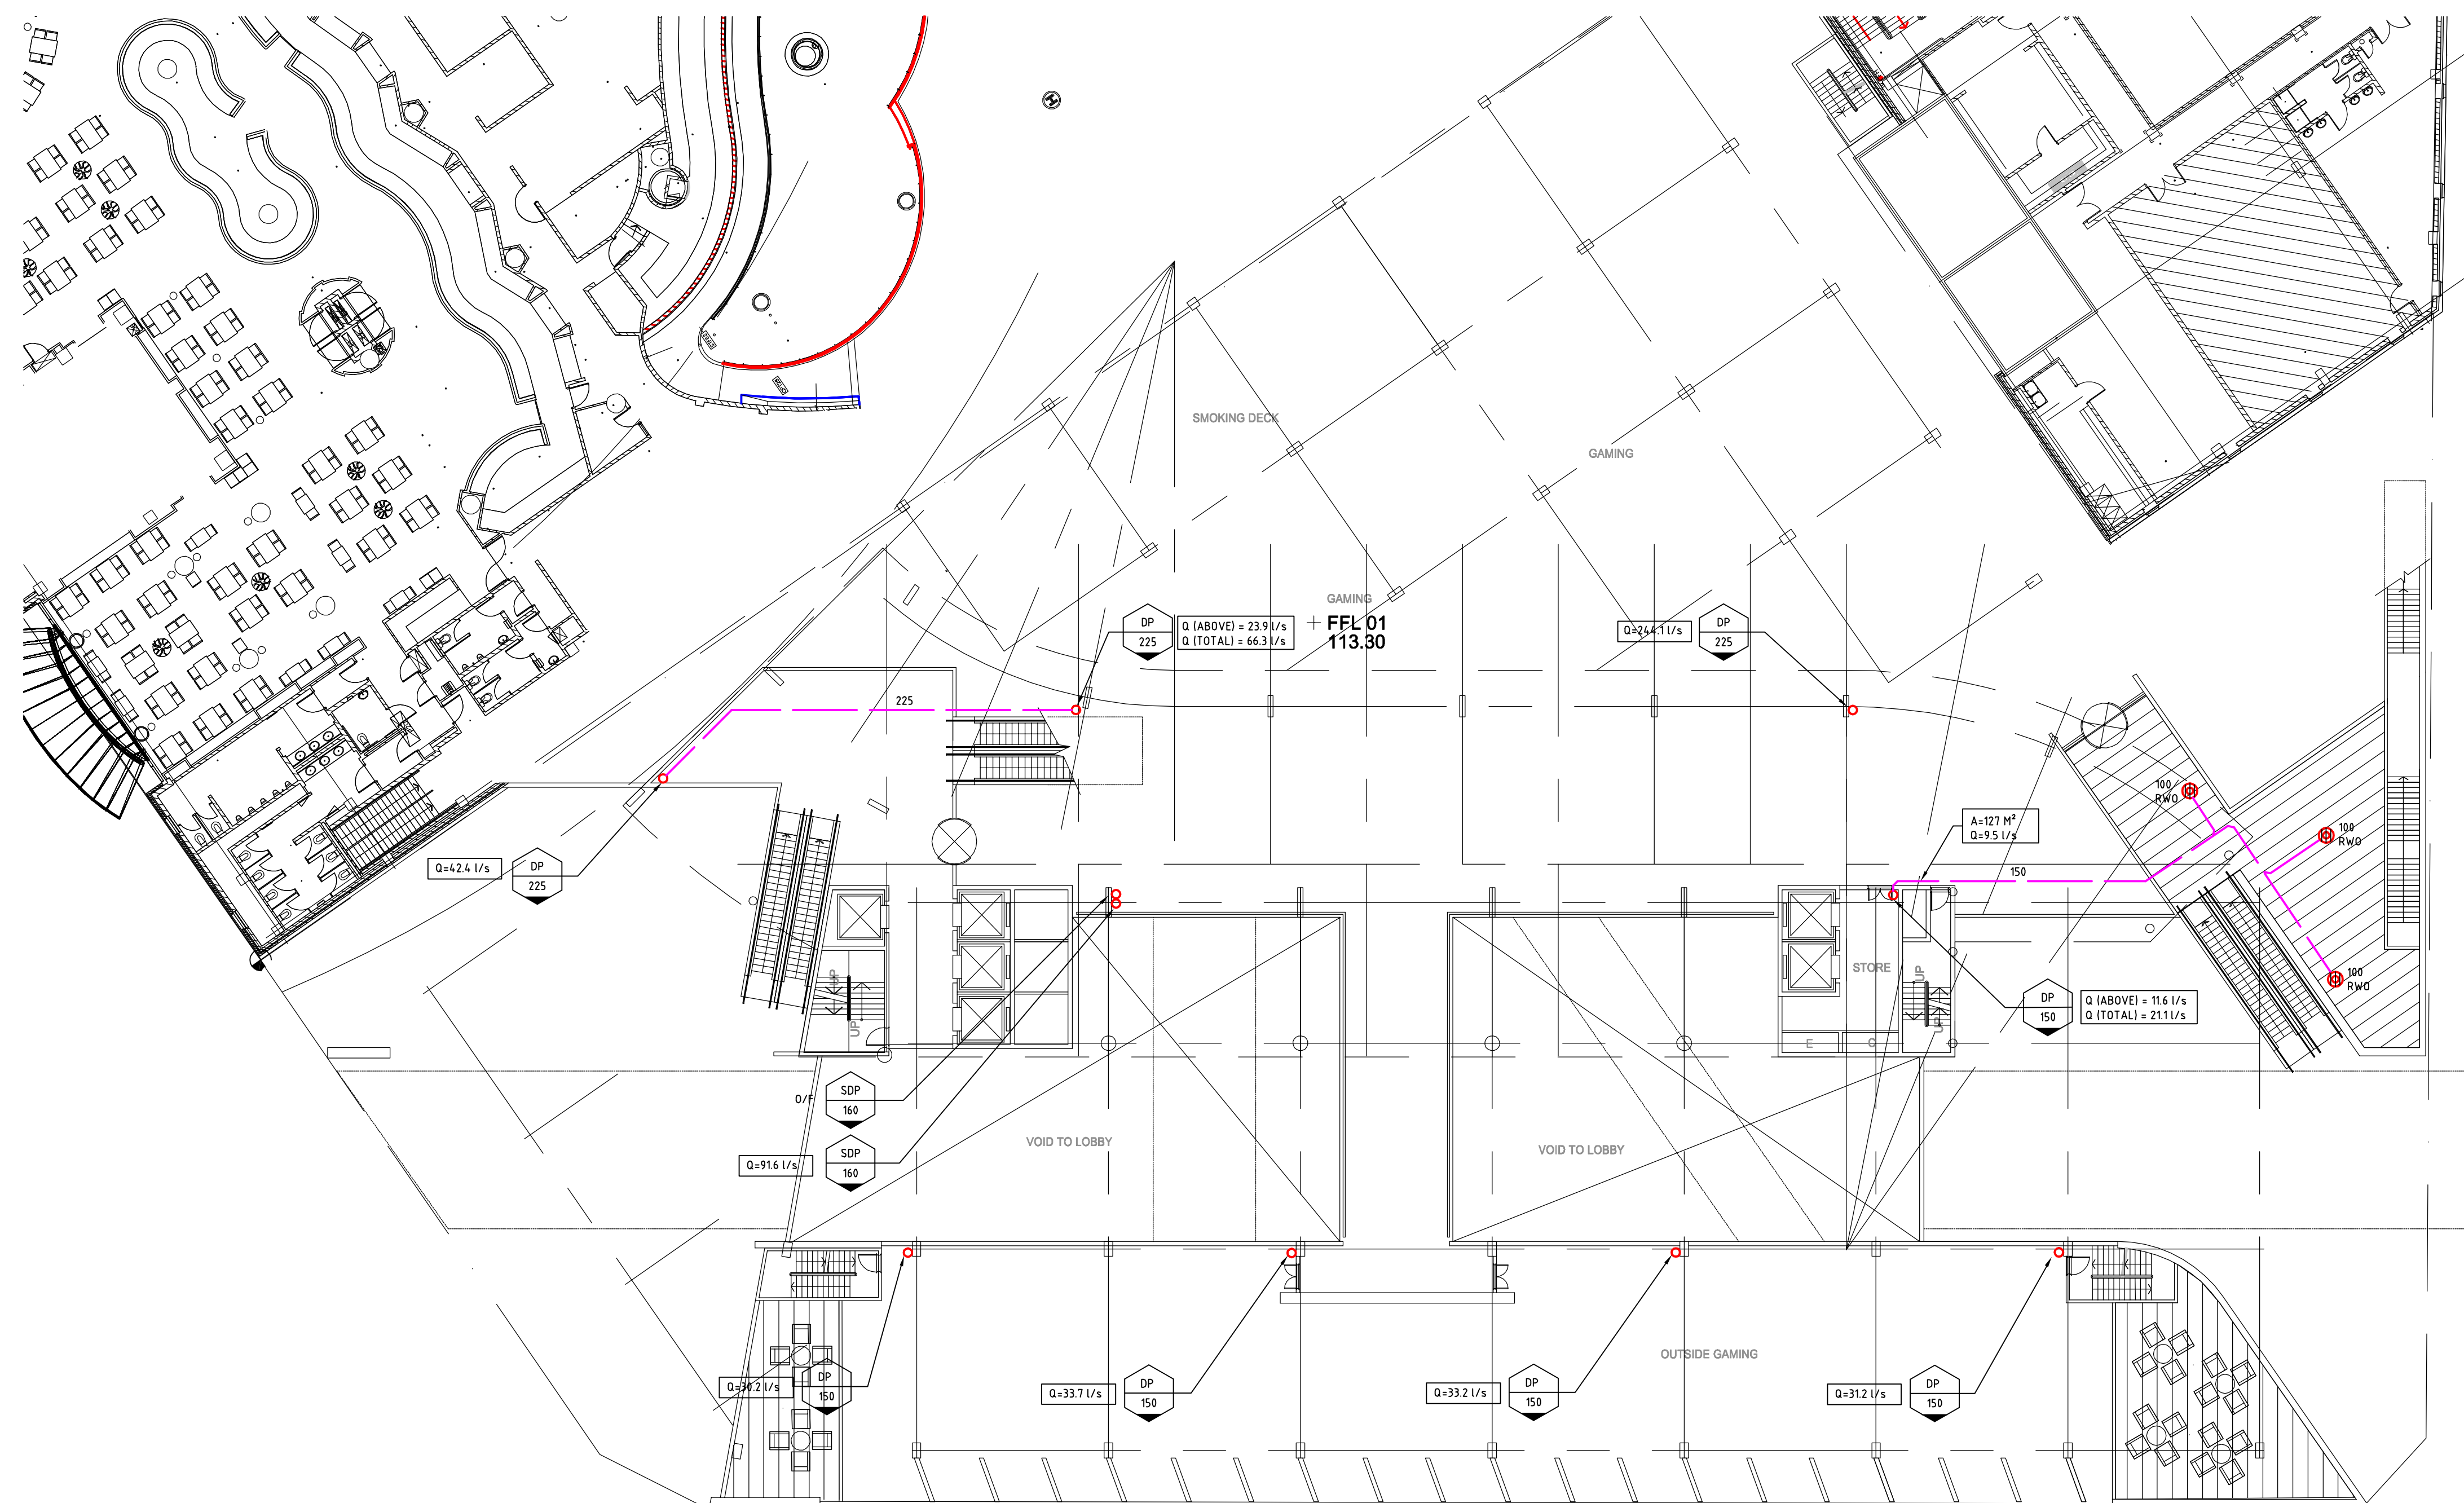

PLOTTED BY: 'bkolcde'

NOTE : SYMBOLS ARE DRAWN IN THE CORRECT POSITION BUT ARE NOT SHOWN TO SCALE

[illegible]

Title Status:

FREEHOLD

Lot & RPD:

Owners Name:
STAR CITY CASINO

Tenant:

Project Manager

THE BUCHAN GROUP



Architect:

Cox Richardson

Level 2, 204 Clarence Street, Sydney 2000 Australia
Tel: 612 9267 9599 Fax: 612 9264 5844
Email: sydney@cox.com.au

Architecture Planning Urban design Interior design Health facility design

COX

Hydraulic Consultant:

STEVE PAUL & SPP PARTNERS

95 Leichhardt Street
P.O. Box 878
SPRING HILL QLD 4004
Ph (07) 3846 3077
Fax (07) 3844 4665

Hydraulic Fire Environmental

A.C.N.: 111 500 415 A.B.N.: 51 111 500 415
EMAIL: mail@brisapp.com.au
WEBSITE: <http://www.stevepaulpartners.com>


steve paul & spp
partners
HYDRAULIC FIRE ENVIRONMENTAL
CONSULTANTS


Project:

STAR PROJECT

Drawing Title:

HYDRAULIC SERVICES
STORMWATER
CONCEPT PLAN
LEVEL 02 FUNCTION AREA
STAR HOTEL

North Point:		BSA Licence No. 1087912	
		Design: PHIL TURNER	
		Design Validated: TONY SAMOROWSKI	
		Drawn: PAUL LINDSAY	
Date: 07.06.2008	Scale: (A1) 1:200 (A3) 1:400	Sheet: 8 OF 9	
Job No:	Disc:	Dwg No:	Issue:
BN08101-SW-107		P - 1	
0 10 20 30 40 50		ORIGINAL SIZE A1	

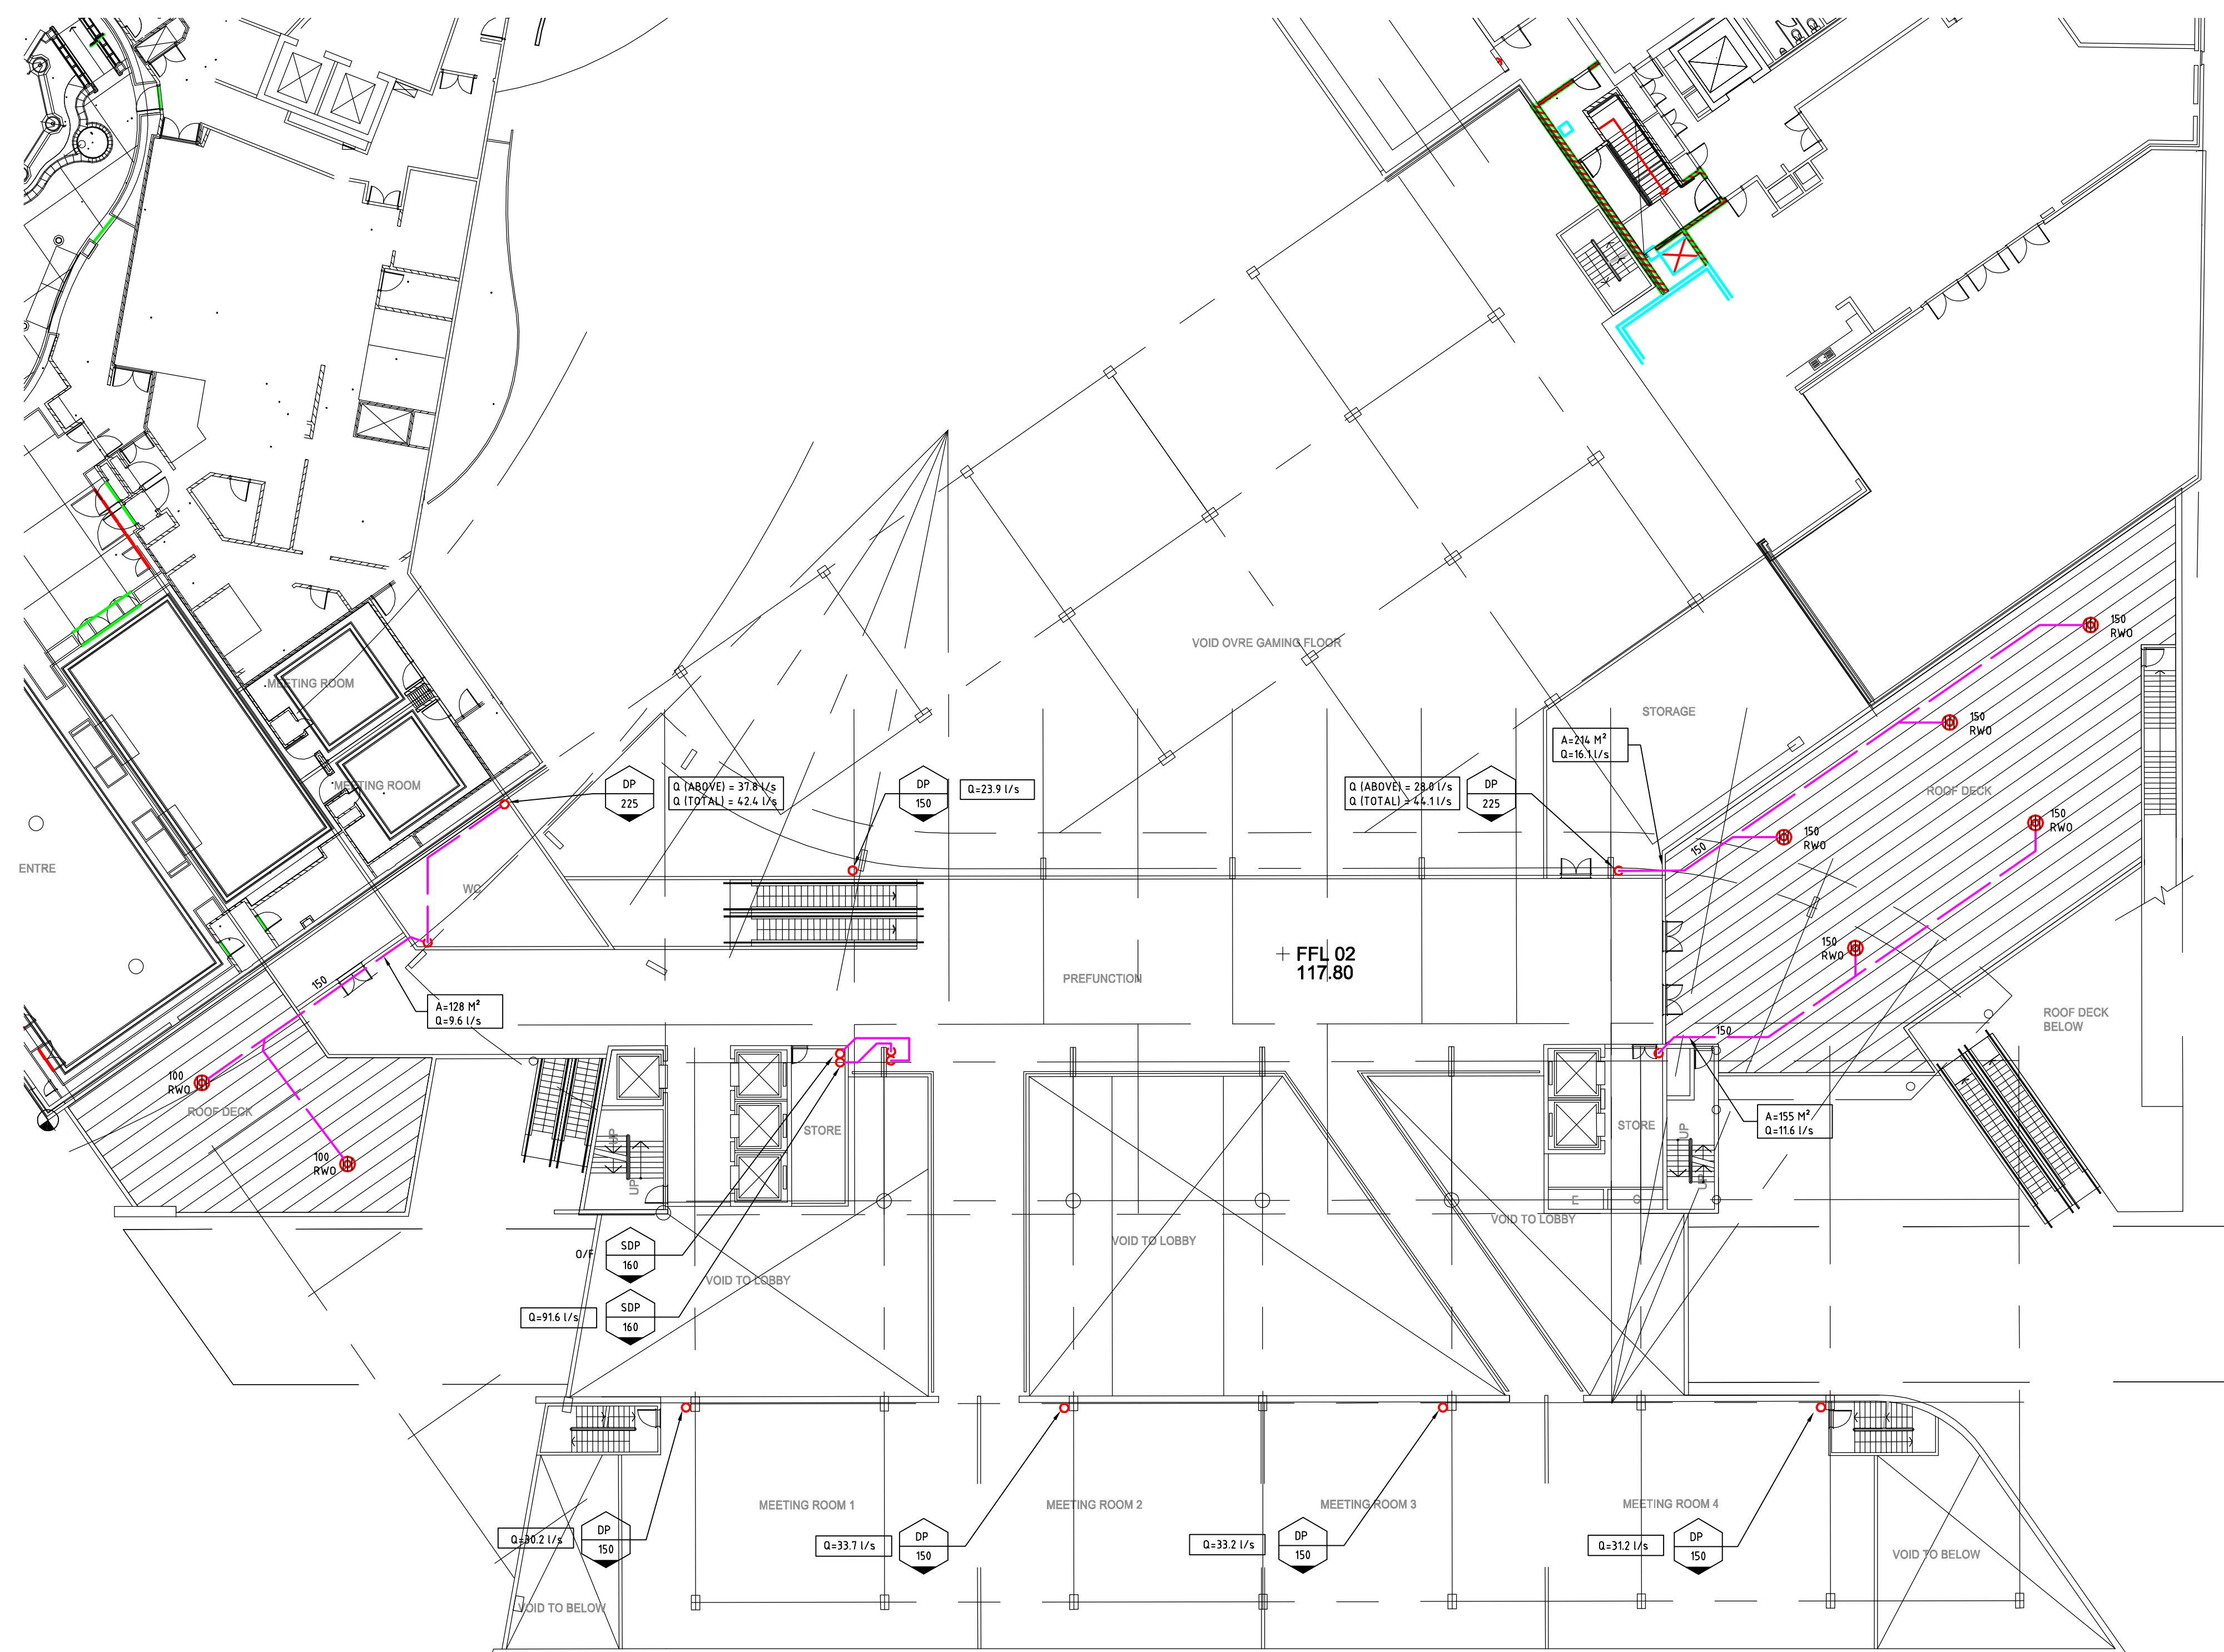

THIS DRAWING IS CONFIDENTIAL AND IS NOT TO BE REPRODUCED IN ANY FORM AS A WHOLE OR IN PART WITHOUT THE EXPRESS WRITTEN AUTHORITY OF STEPHEN PAUL HOLDINGS PTY LIMITED. THIS DRAWING IS NOT TO BE USED PREJUDICIAL TO THE INTERESTS OF STEPHEN PAUL HOLDINGS PTY LIMITED.

THIS DRAWING CONTAINS PATENTS PENDING AND INTELLECTUAL PROPERTY OWNED BY STEPHEN PAUL HOLDINGS PTY LIMITED.

© COPYRIGHT ALL RIGHTS RESERVED

NOTE : SYMBOLS ARE DRAWN IN THE CORRECT POSITION BUT ARE NOT SHOWN TO SCALE

[illegible]

Plan Design:
These plans have been designed to and comply with:
• Queensland Plumbing and drainage act 2002
• Queensland standard plumbing and drainage regulations 2003
• AS/NZS 3500.0:2003 Plumbing and drainage part 0 glossary of terms
• AS/NZS 3500.1:2003 Plumbing and drainage part 1 water service
• AS/NZS 3500.2:2003 Plumbing and drainage part 2 sanitary plumbing and drainage
• AS/NZS 3500.2:2003 Plumbing and drainage part 3 stormwater drainage
• AS/NZS 3500.2:2003 Plumbing and drainage part 4 heated water service
• AS 2449.1:2005 Fire hydrant installation part 1 system design, installation and commissioning
• AS 2449.1:1998 Installation of fire hose reels

Title Status:

FREEHOLD

Lot & RPD:

Owners Name:
STAR CITY CASINO

Tenant:

Project Manager

THE BUCHAN GROUP



Architect:

Cox Richardson

Level 2, 204 Clarence Street, Sydney 2000 Australia
Tel: 612 9287 8699 Fax: 612 9284 5844
Email: sydney@cox.com.au

Architecture Planning Urban design Interior design Health facility design

The logo for Cox Richardson, featuring the word "COX" in a bold, red, sans-serif font. The letter "O" is stylized with a white dot in the center.

Hydraulic Consultant:

STEVE PAUL & SPP PARTNERS

95 Leichhardt Street
P.O. Box 878
SPRING HILL QLD 4004
Ph (07) 3846 3077
Fax (07) 3844 4665

Hydraulic Fire Environmental

A.C.N.: 111 500 415 A.B.N.: 45 111 500 415
EMAIL: mail@brisapp.com.au
WEBSITE: <http://www.stevepaulpartners.com>


AS 4850.1-2007
WATER METERS
CLASS 1

Project:

STAR PROJECT

Drawing Title:

HYDRAULIC SERVICES


STORMWATER

CONCEPT PLAN

LEVEL 03 PODIUM

STAR HOTEL

North Point:		BSA Licence No. 1087	
		Design: PHIL TURNER	
		Design Validated: TONY SAMOROWSKI	
		Drawn: PAUL LINDSAY	
Date: 07.06.2008	Scale: (A1) 1:200 (A3) 1:400	Sheet: 9 OF 5	
Job No:	Disc:	Dwg No:	Stage: Ist
BN08101-SW-108 - P -			
			

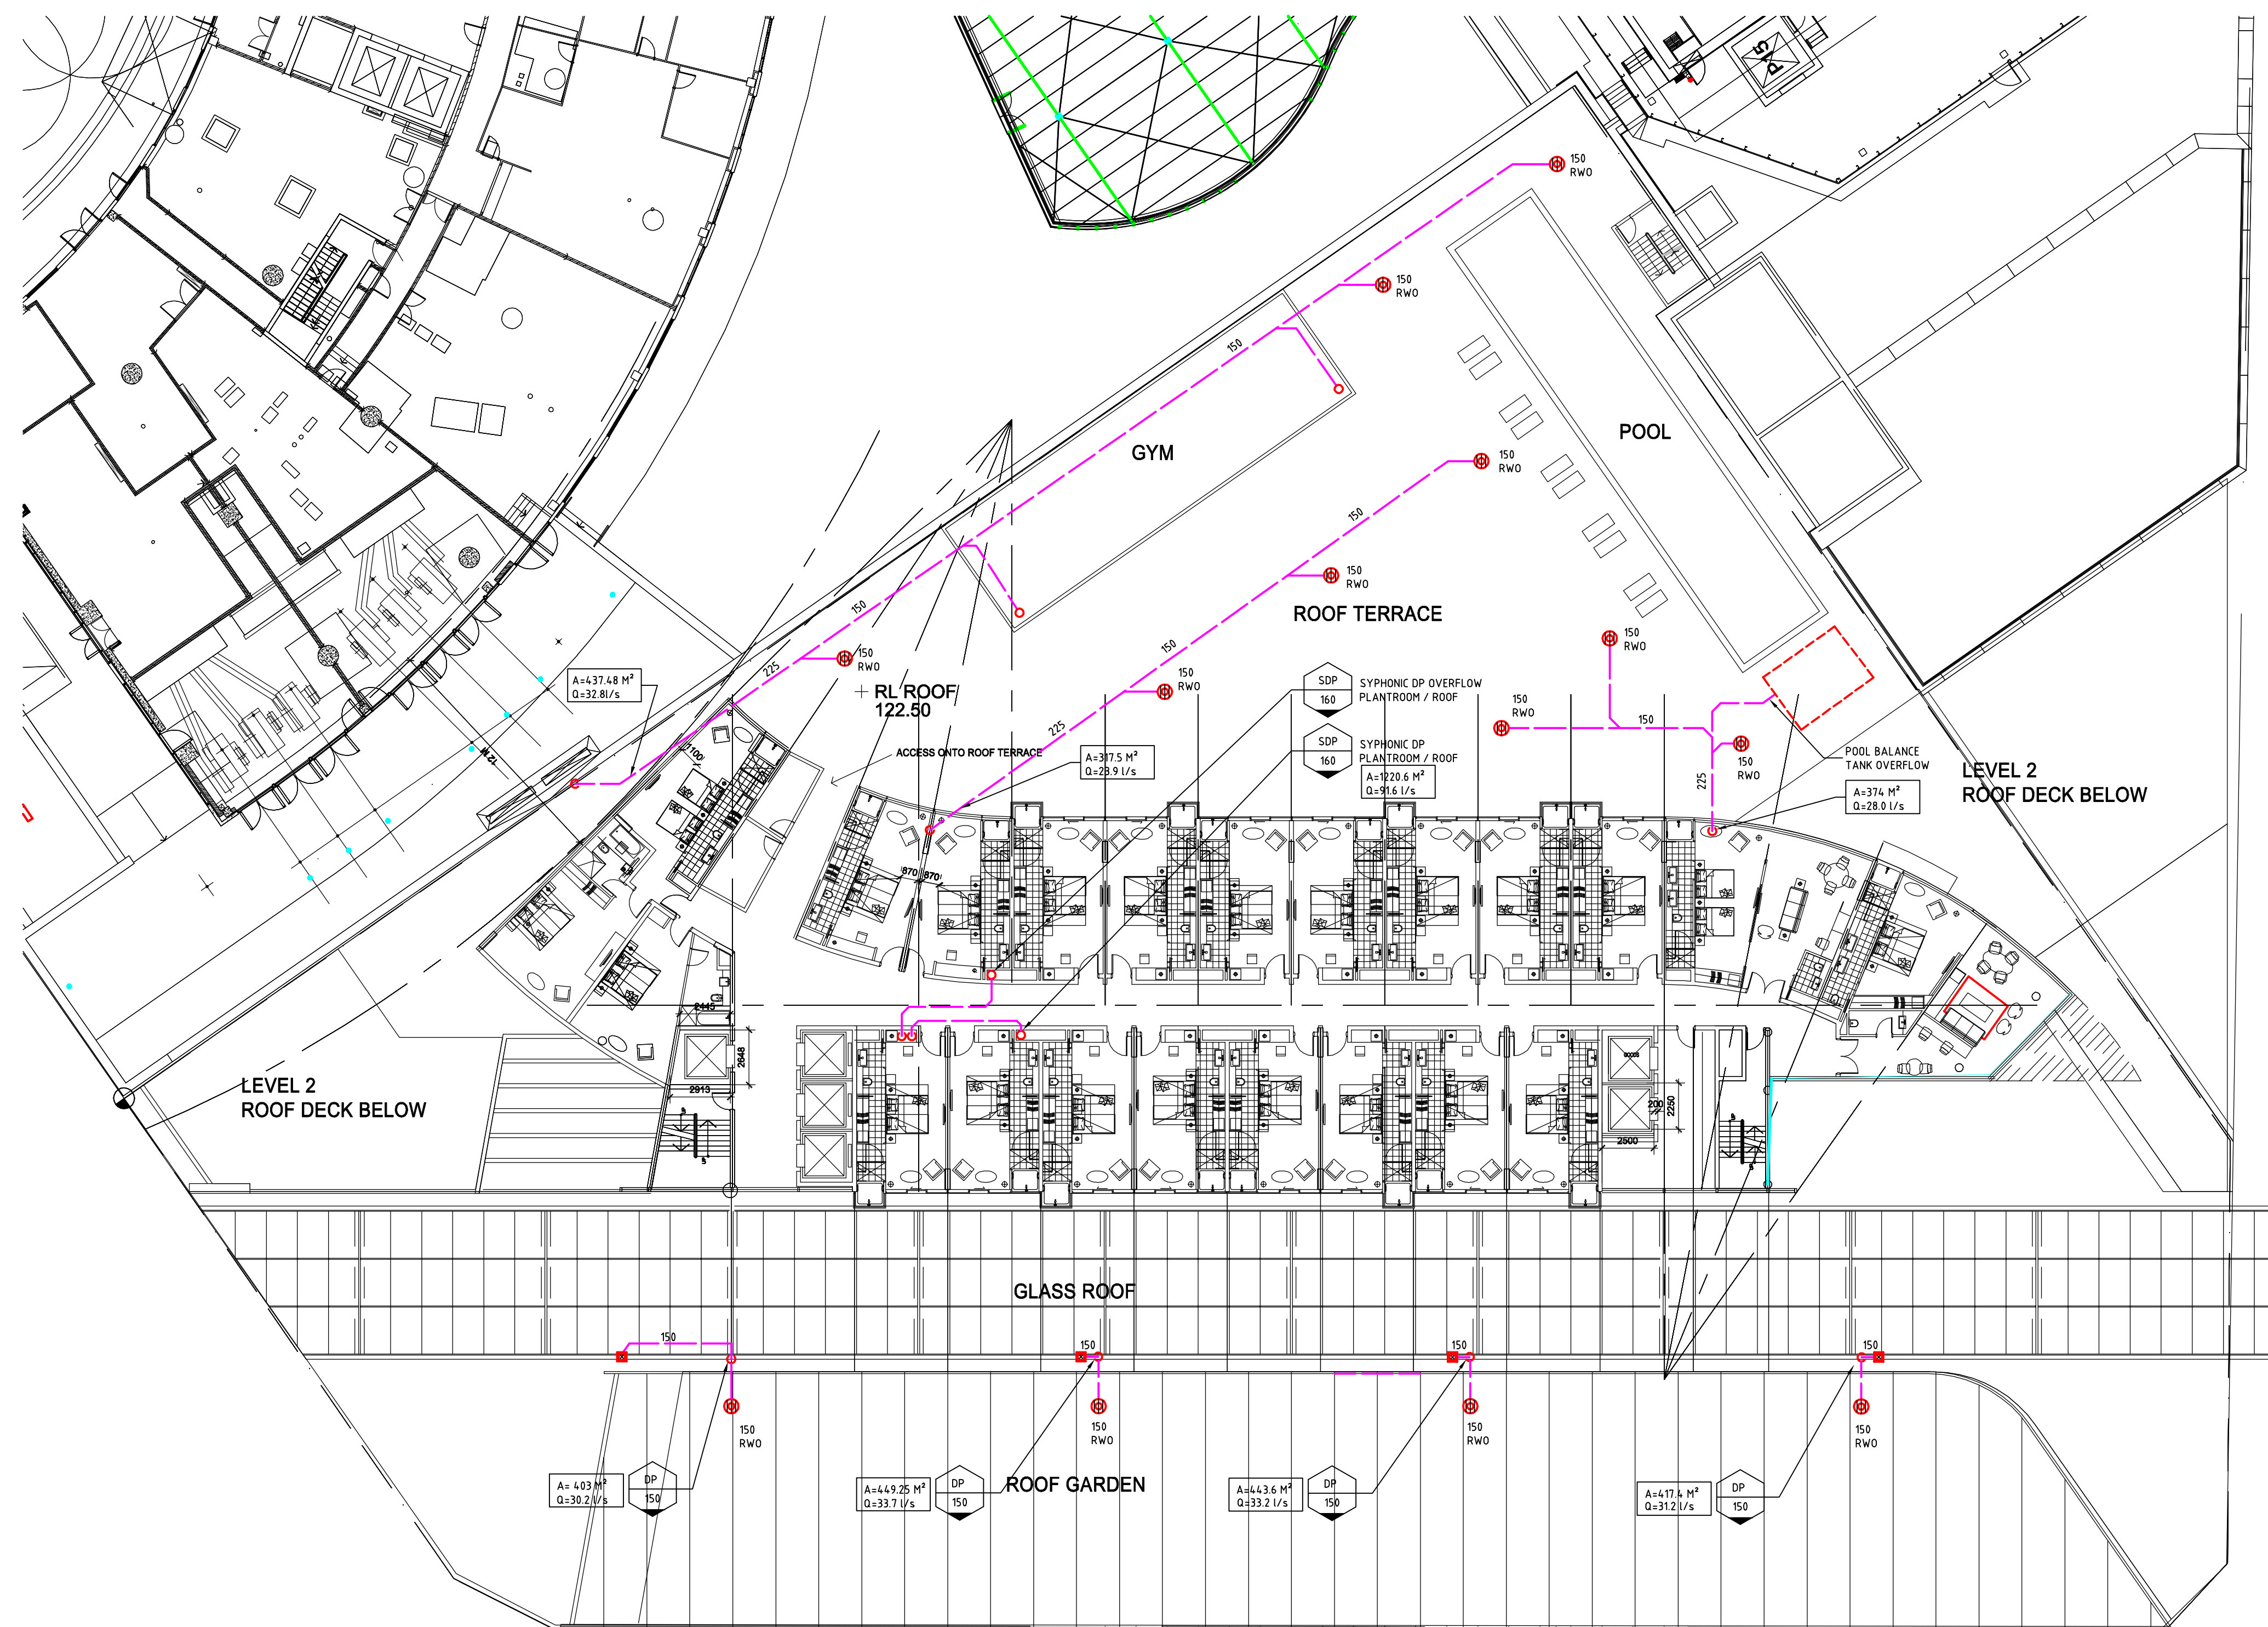[illegible]