


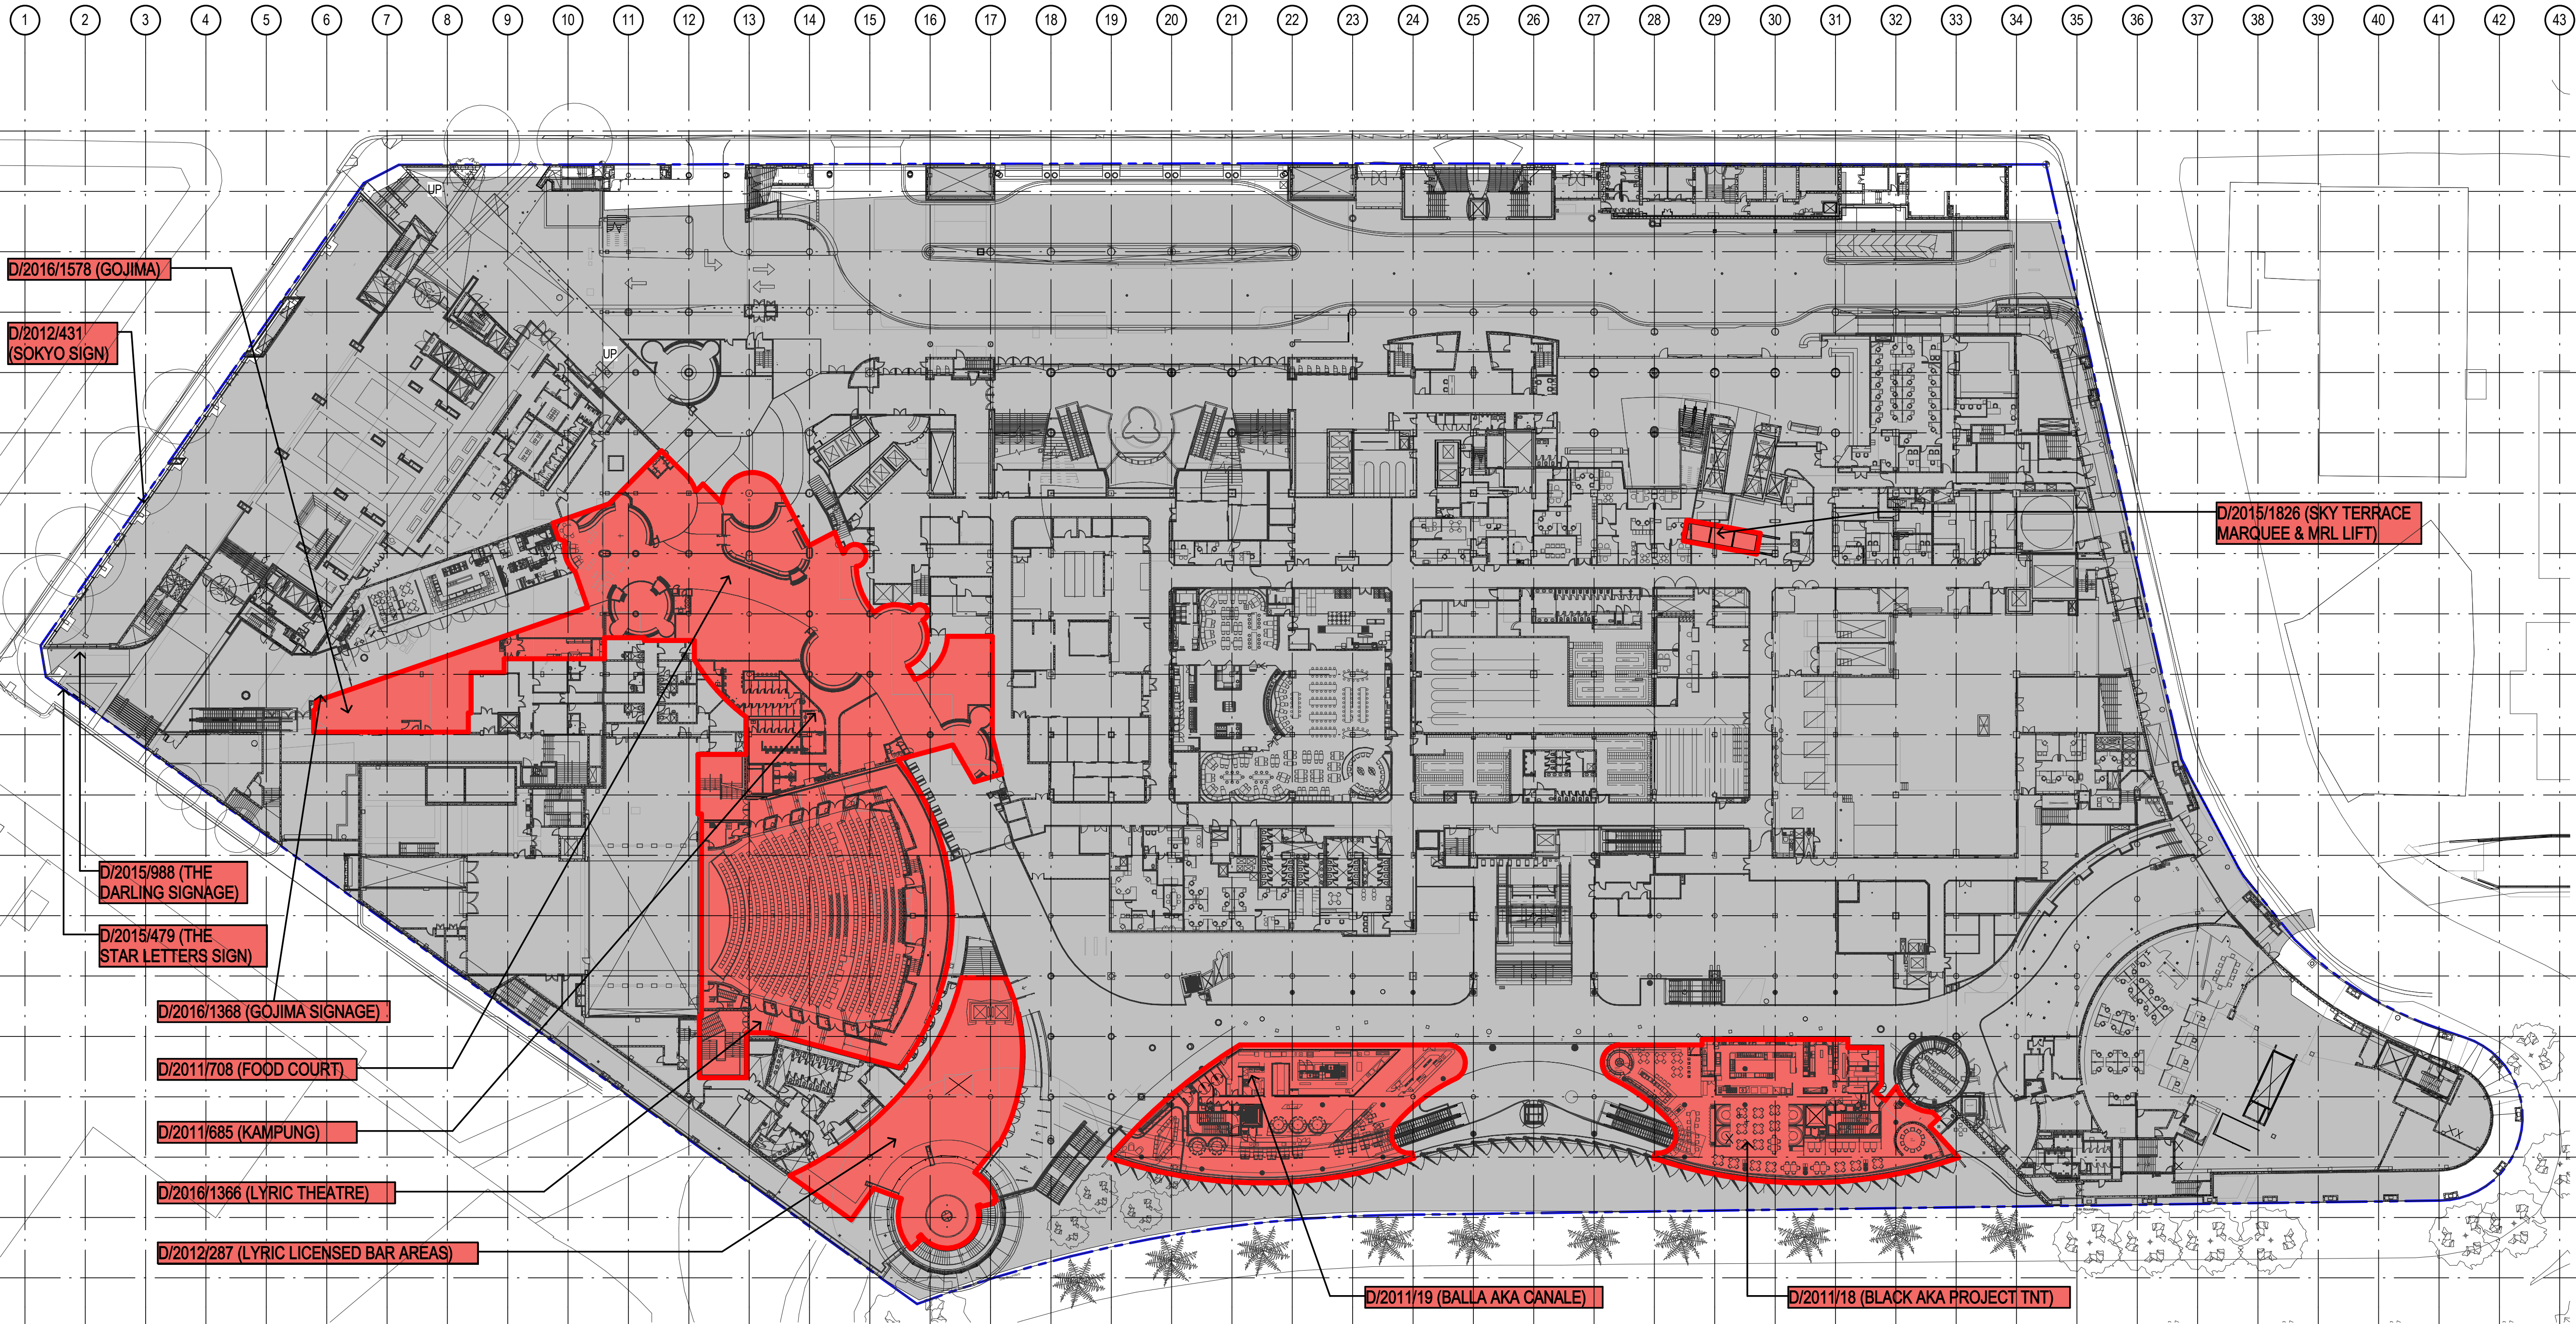

1 EXISTING SITE PLAN - LEVEL 00
1:500

Notes
The information contained in this document is copyright and may not be used or reproduced for any other project or purpose.
Verify all dimensions and levels on site and report any discrepancies to dwp[suters for direction prior to the commencement of work.
Drawings are to be read in conjunction with all other contract documents.
Use figured dimensions only. Do not scale from drawings. dwp[suters cannot guarantee the accuracy of content and format for copies of drawings issued electronically.
The completion of the Issue Details Checked and Authorised section is confirmation of the status of the drawing. The drawing shall not be used for construction unless endorsed 'For Construction' and authorised for issue.
© dwp Australia Pty Ltd
Registered Business Name dwp[suters ASN 37 169 328 018
Robert Macdonald Nominated Architect NSW AKB 4699

Consultants

Planner, Heritage & Social
URBIS

Structural & Civil Engineer
TAYLOR THOMSON WHITTING

Structural, Mechanical & Fire Protection Engineer
WSP/BRINCKERHOFF

Electrical, Communications & Hydraulic Engineer
UNSW L&I

BCA Consultant
McKenzie Group

URBIS

Taylor Thomson Whitting

WSP

BRINCKERHOFF

UNSW L&I


mckenzie group

LEGEND

EXISTING

CITY OF SYDNEY

DEPARTMENT OF PLANNING

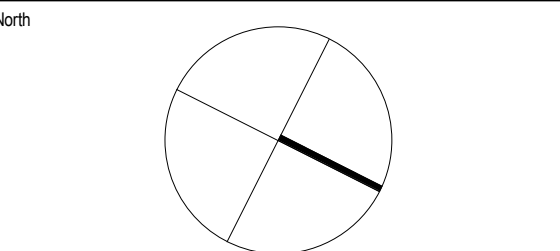

PRELIMINARY
NOT TO BE USED DURING CONSTRUCTION

F	REVISED MOD 14 FOR APPROVAL	05.05.2017
E	MODIFICATION 14, LIFT	11.04.2017
D	REVISED MOD 14 FOR APPROVAL	28.02.2017
C	REVISED MOD 14 FOR APPROVAL	23.01.2017
B	MODIFICATION 14	15-09-2016
A	TEST OF ADEQUACY	03-08-2016
Issue	Description	Date

Architect
dwp[suters
www.dwpsuters.com

Project
THE STAR - MODIFICATION 14

Location
80 PYRMONT STREET
PYRMONT NSW 2009

Client
THE STAR ENTERTAINMENT GROUP

THE STAR
ENTERTAINMENT GROUP

Drawing
EXISTING SITE PLAN - LEVEL 00

Scale
1:500 @ A1

Date Printed
5/10/2017 10:51:30 AM

Project Number
303457

Drawing Number
MOD14-A9200

Issue
F



File Name D:\projects\REVIT\2016\303457_THE STAR_MOD14_CENTRAL_R2016_A9200.dwg