


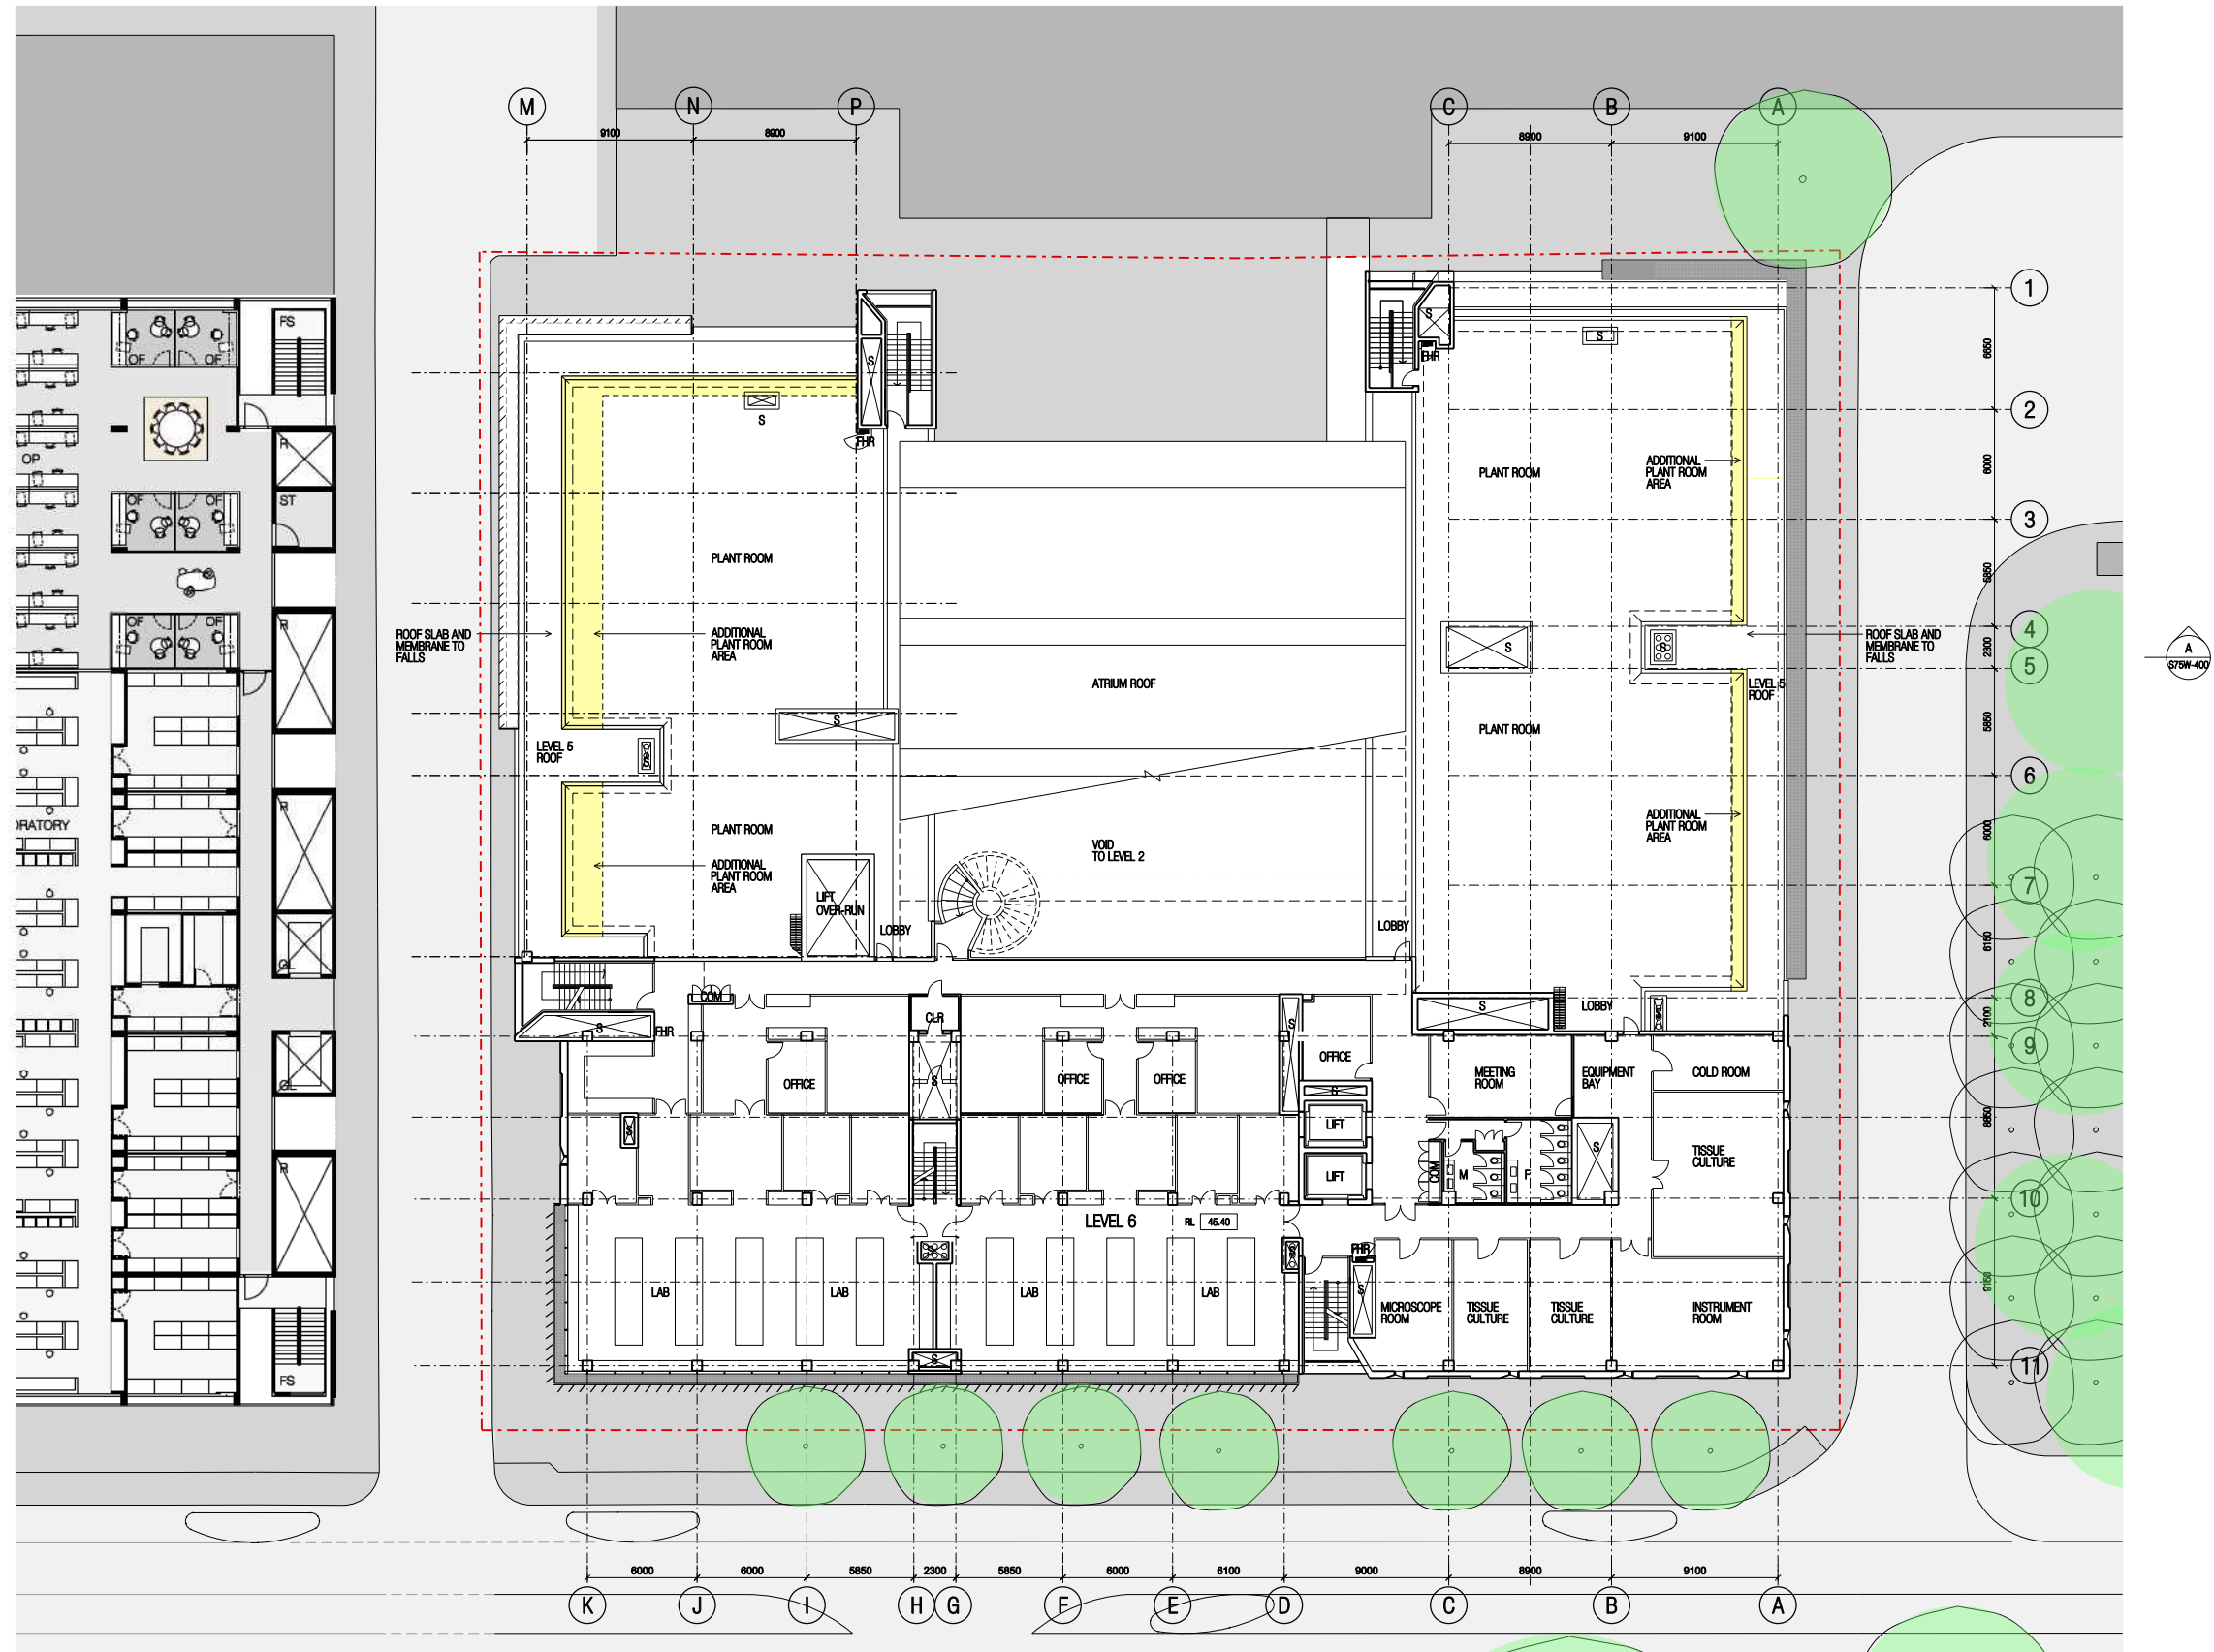

1 LEVEL 6 (RL 45.40)
SCALE 1:200

- LEGEND**
- EXTENT OF EXISTING STRUCTURE
 - EXISTING WALLS TO REMAIN
 - PROPOSED BUILDING
 - AWC DISABLED TOILETS
 - CLR CLEANER'S CUPBOARD
 - COM COMMUNICATIONS RISER
 - F FEMALE TOILETS
 - FHR FIRE HOSE REEL
 - K KITCHENETTE
 - M MALE TOILETS
 - RS ROLLER SHUTTER DOOR
 - S SERVICES RISER

revision	date	description	by	note
-	20th APRIL 2011	SECTION 75W MODIFICATION SUBMISSION	DC	Do not scale from drawings. All dimensions to be checked on site before commencement of work. All discrepancies to be brought to the attention of the Architect. This drawing is copyright and the property of the architect and must not be released, copied or used without the express authority of Anchor Mortlock Woolley Pty. Ltd.

Anchor/Mortlock/Woolley

Suite C3.16, Level 3, 22-30 Mountain Street, Ultimo NSW 2007, Australia
T + 61 2 9280 2445 F + 61 2 9280 2448 E amw@amwarchitects.com.au
Nominated Architect: Dale Swan Cart. No. 3316. Phil Bulgent Cart. No. 6174

project **REDEVELOPMENT OF CHILDREN'S MEDICAL RESEARCH INSTITUTE**
client **CHILDREN'S MEDICAL RESEARCH INSTITUTE**

drawing **LEVEL 6 PLAN**

4	2
3	1

scale 1:200DA1, 1:400DA3	0	2	4	10m
drawn by JP/MJ/SC				
project no 0807				
drawing no S75W-106				
revision -				