


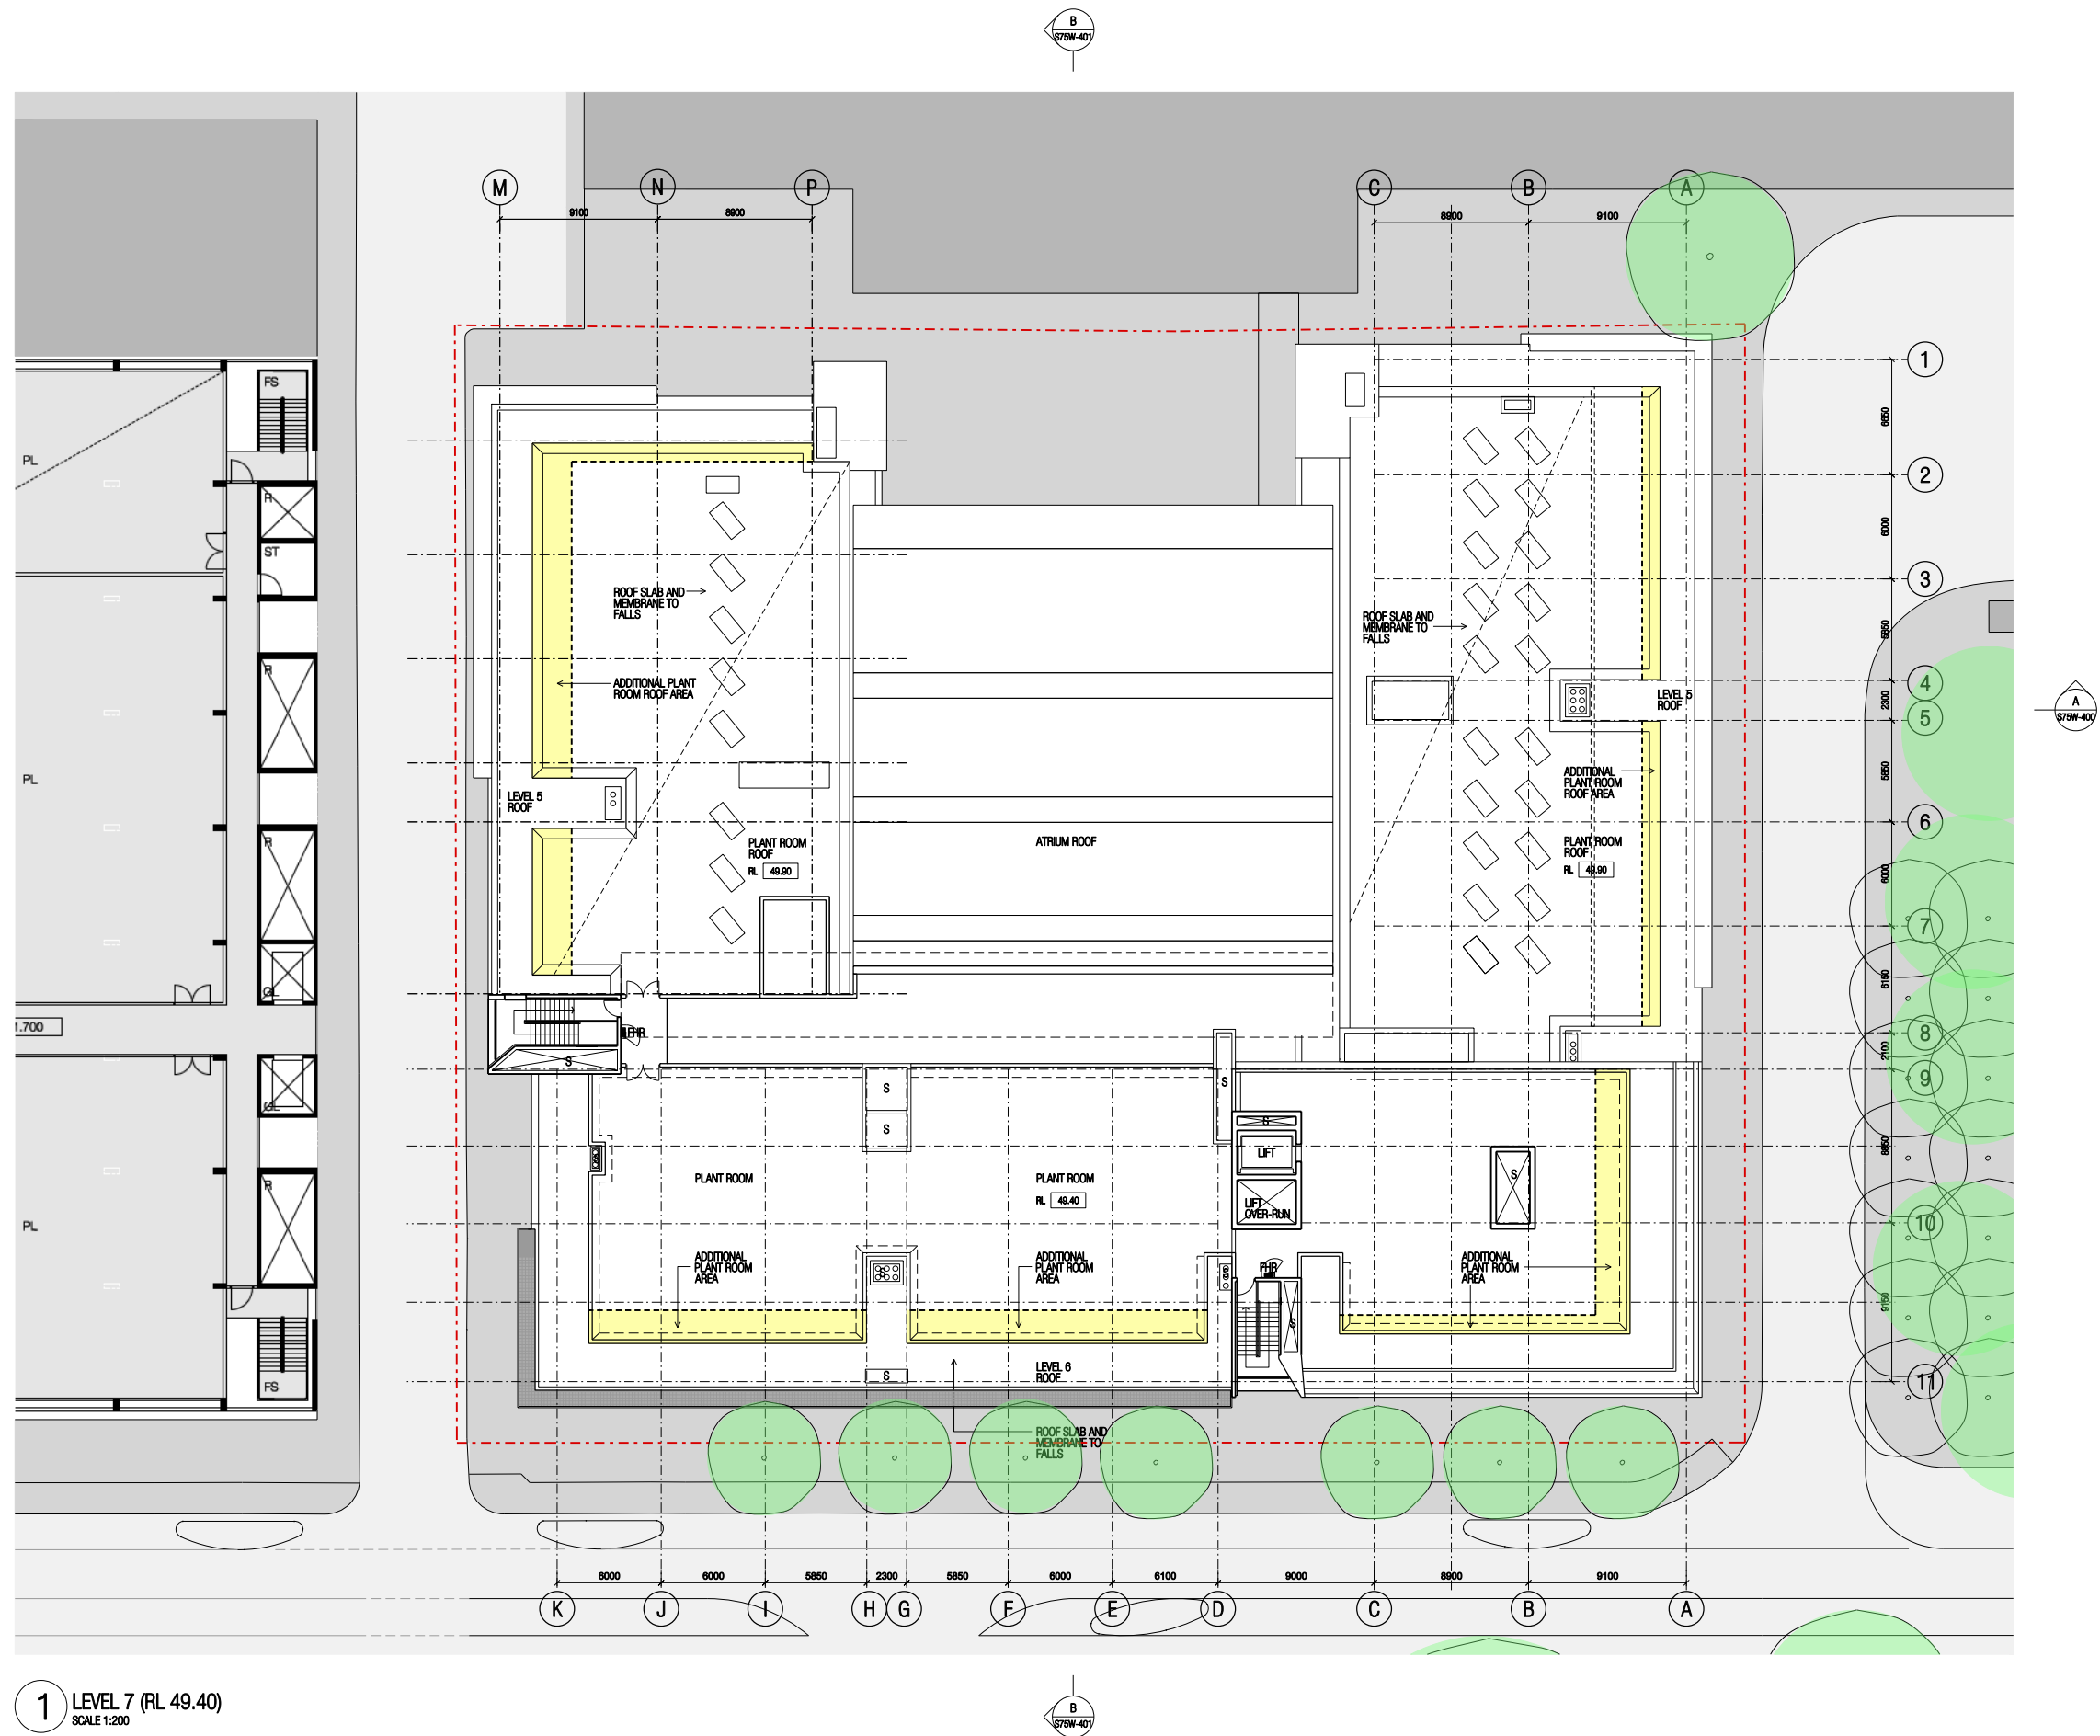

1 LEVEL 7 (RL 49.40)
SCALE 1:200

LEGEND

	EXTENT OF EXISTING STRUCTURE
	EXISTING WALLS TO REMAIN
	PROPOSED BUILDING
AWC	DISABLED TOILETS
CLR	CLEANER'S CUPBOARD
COM	COMMUNICATIONS RISER
F	FEMALE TOILETS
FHR	FIRE HOSE REEL
K	KITCHENETTE
M	MALE TOILETS
RS	ROLLER SHUTTER DOOR
S	SERVICES RISER

revision	date	description	by	note
-	2000 APRIL 2011	SECTION 75W MODIFICATION SUBMISSION	DC	Do not scale from drawings. All dimensions to be checked on or before commencement of work. All discrepancies to be brought to the attention of the Architect. This drawing is copyright and the property of the Architect; and must not be retained, copied or used without the express authority of the Architect. Network World Pty. Ltd.
20/04/2011	8:33:23 AM	R:\0007-CHRP\Code\Plot\Section_75W\S75W-107.dgn		

Ancher/Mortlock/Woolley

Suite C3.16, Level 3, 22-36 Mountain Street, Ultimo NSW 2007, Australia
T +61 2 9280 2445 F +61 2 9280 2448 E amw@amwarchitects.com.au
Nominated Architects: Dale Swan Cert. No. S316. Phil Baigent Cert. No. 6174

project	REDEVELOPMENT OF CHILDREN'S MEDICAL RESEARCH INSTITUTE
client	CHILDREN'S MEDICAL RESEARCH INSTITUTE

drawing **LEVEL 7 PLAN**

		scale 1:200@A1, 1:400@A3	0	2	4	10m
		drawn by NP/MO/GC				
project no 0807		drawing no S75W-107		revision -		