

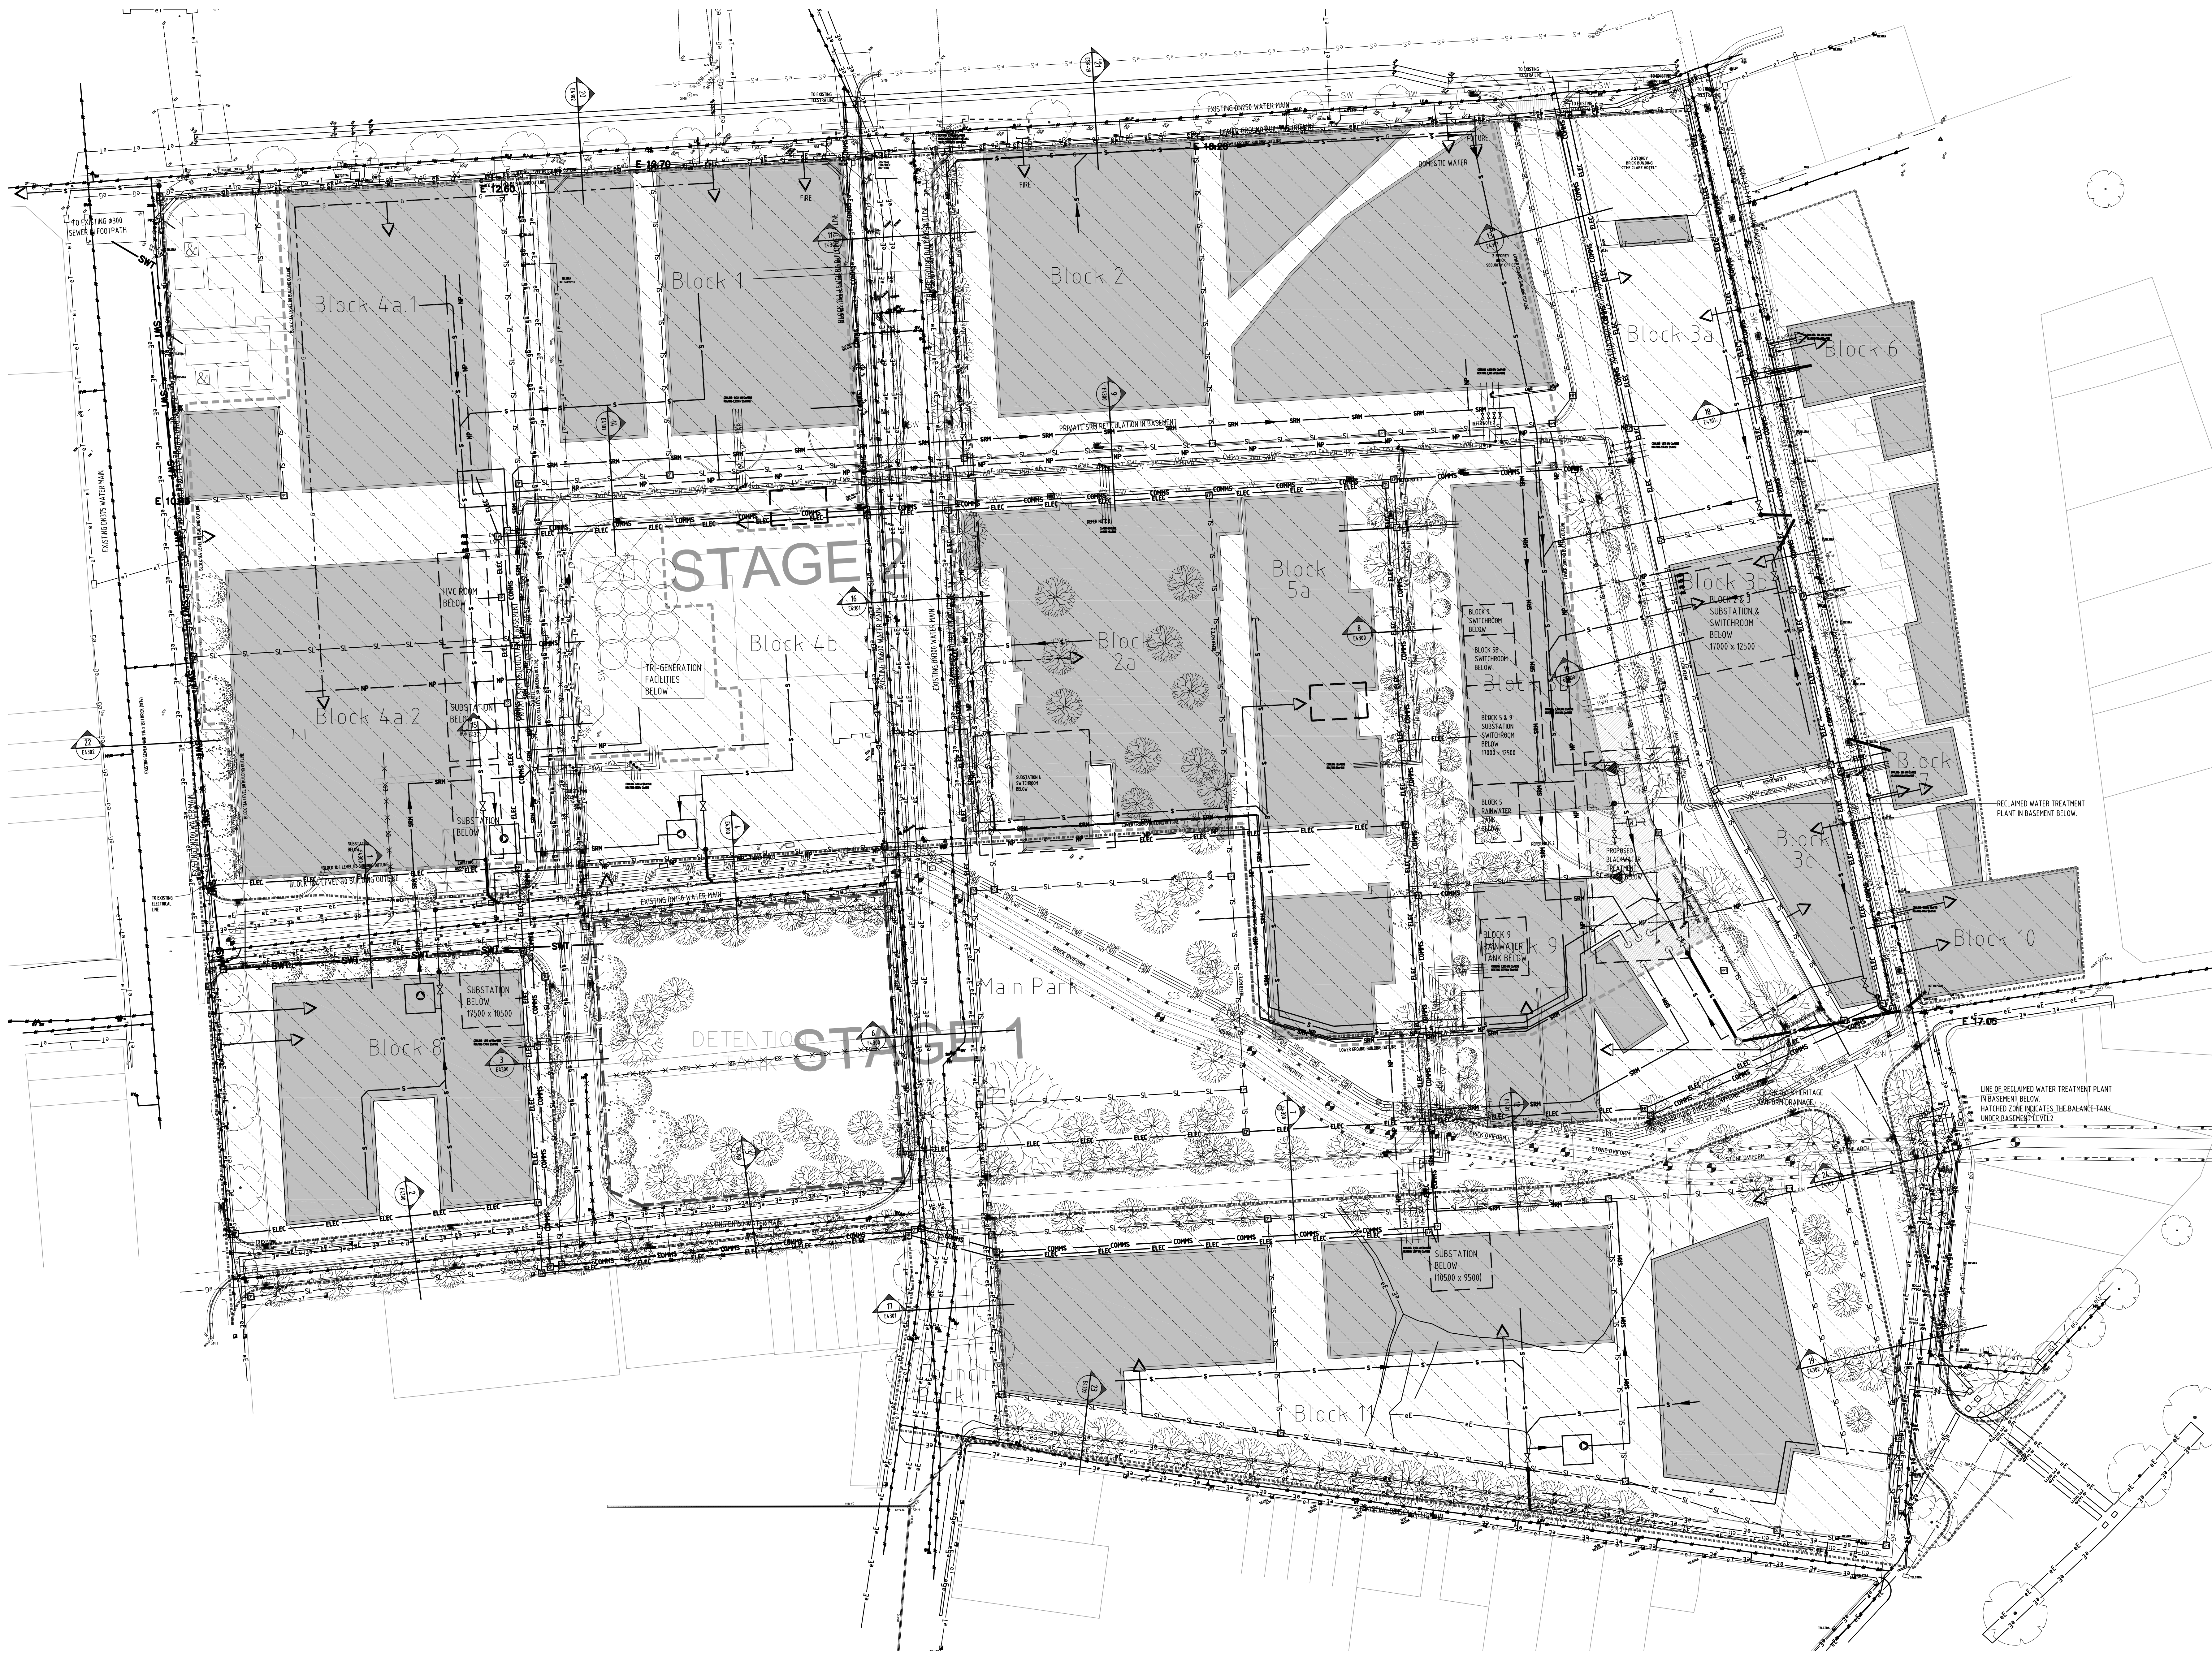


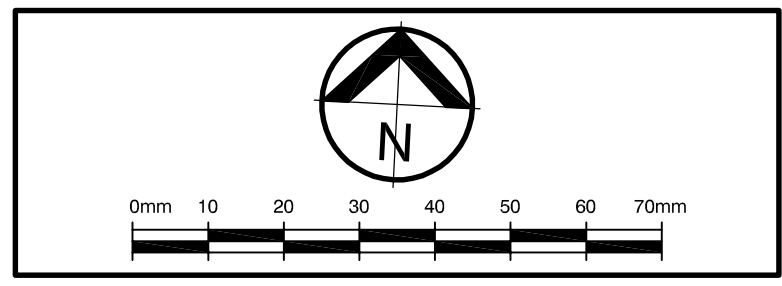

DATE	REV	AMENDMENT	BY	CHKD
04.05.09	01	PLANNING APPLICATION ISSUE	TDG	NJM

- NOTES:
- FOR LEGEND REFER TO DRAWING NUMBER E4001, H4001 & M4001.
 - FOR DETAILS, SECTIONS AND NOTES REFER TO DRAWING No. E4300, E4301 & E4302.
 - STORMWATER BY HUGHES TRUEMAN CONSULTANT. FOR FURTHER DETAIL ON PROPOSED STORM WATER INFRASTRUCTURE REFER TO HUGHES TRUEMAN DRAWINGS.
 - REFERENCE DOCUMENT FOR SITE INFRASTRUCTURE DRAWINGS ARE:
DEGOTARD SURVEY DWG No. 3162008/B & 3162008/C
HUGHES TRUEMAN DWG No. 075628C-HP08/A
JAAK & TOP DESIGN DWG No. 984-0721-EDU
GENTLY UNDER REFERENCE No. 08040725UB
JPM DWG No. P-A-A-BASE-1009-2-B
PTM DWG No. A-1759/76
 - FOR DECOMMISSIONED AND ABANDONED SERVICES REFER TO HUGHES TRUEMAN DRAWING No. 075628C-CA PROPOSED INFRASTRUCTURE DECOMMISSIONING PLAN AND WBSO DRAWING No. ESK-01, 02 & 03 EA HV/LV NETWORK RETECTIONS.
 - DRAWING NUMBER PREVIOUSLY WAS ESK-07 REVISION 06.

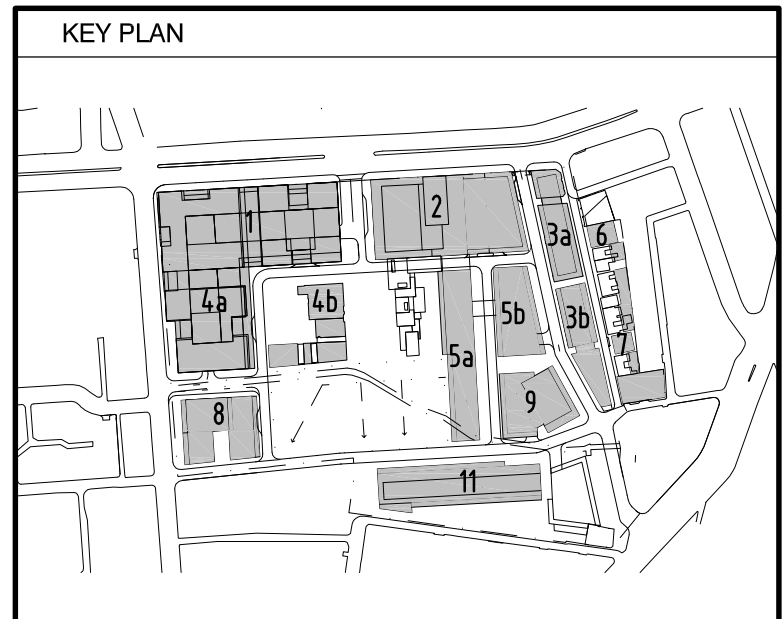

REFERENCE COORDINATION DRAWINGS				
DESCRIPTION	DRAWING NO.	REV	CHKD	
STORMWATER PLAN	075628C-HP08	A		
ROAD GRADING & EXISTING SERVICES	075628C-SH07	A		
HERITAGE DRAM PERMANENT PROTECTION	080553-SH01	A		
DETENTION TANK GEN. ARRANGEMENT	075628C-SH05	A		
SITE GRADING PLAN ROAD & VERGE	075628C-SK03	A		

Lincolne Scott
Consulting Engineers
Adelaide, Auckland, Bangkok, Brisbane, Cairns, Canberra, Gold Coast, Melbourne, Perth, San Diego, Singapore, Sydney, Townsville, Wollongong
Level 141 McLaren Street
PO Box 626 North Sydney
New South Wales 2060 Australia
Telephone 61 2 9607 0600
Facsimile 61 2 9607 4177
sydney@lincolnescott.com

PROJECT
**FRASERS BROADWAY
20-102 BROADWAY
SYDNEY**
CLIENT
FRASERS BROADWAY

DATE	22.04.09	DRAWN	TDG
SCALE	1:400	CHECKED	NJM
SHEET SIZE	A0	APPROVED	-
CAD FILE	P:\SYD080740C\Stage 1\SYD080740C.E4150.dwg		

TITLE
**STAGE 1 - SITE INFRASTRUCTURE
NEW AND EXISTING
PUBLIC & PRIVATE SERVICES**
PROJECT NO.
SYD080740C E4150 01

PRELIMINARY