

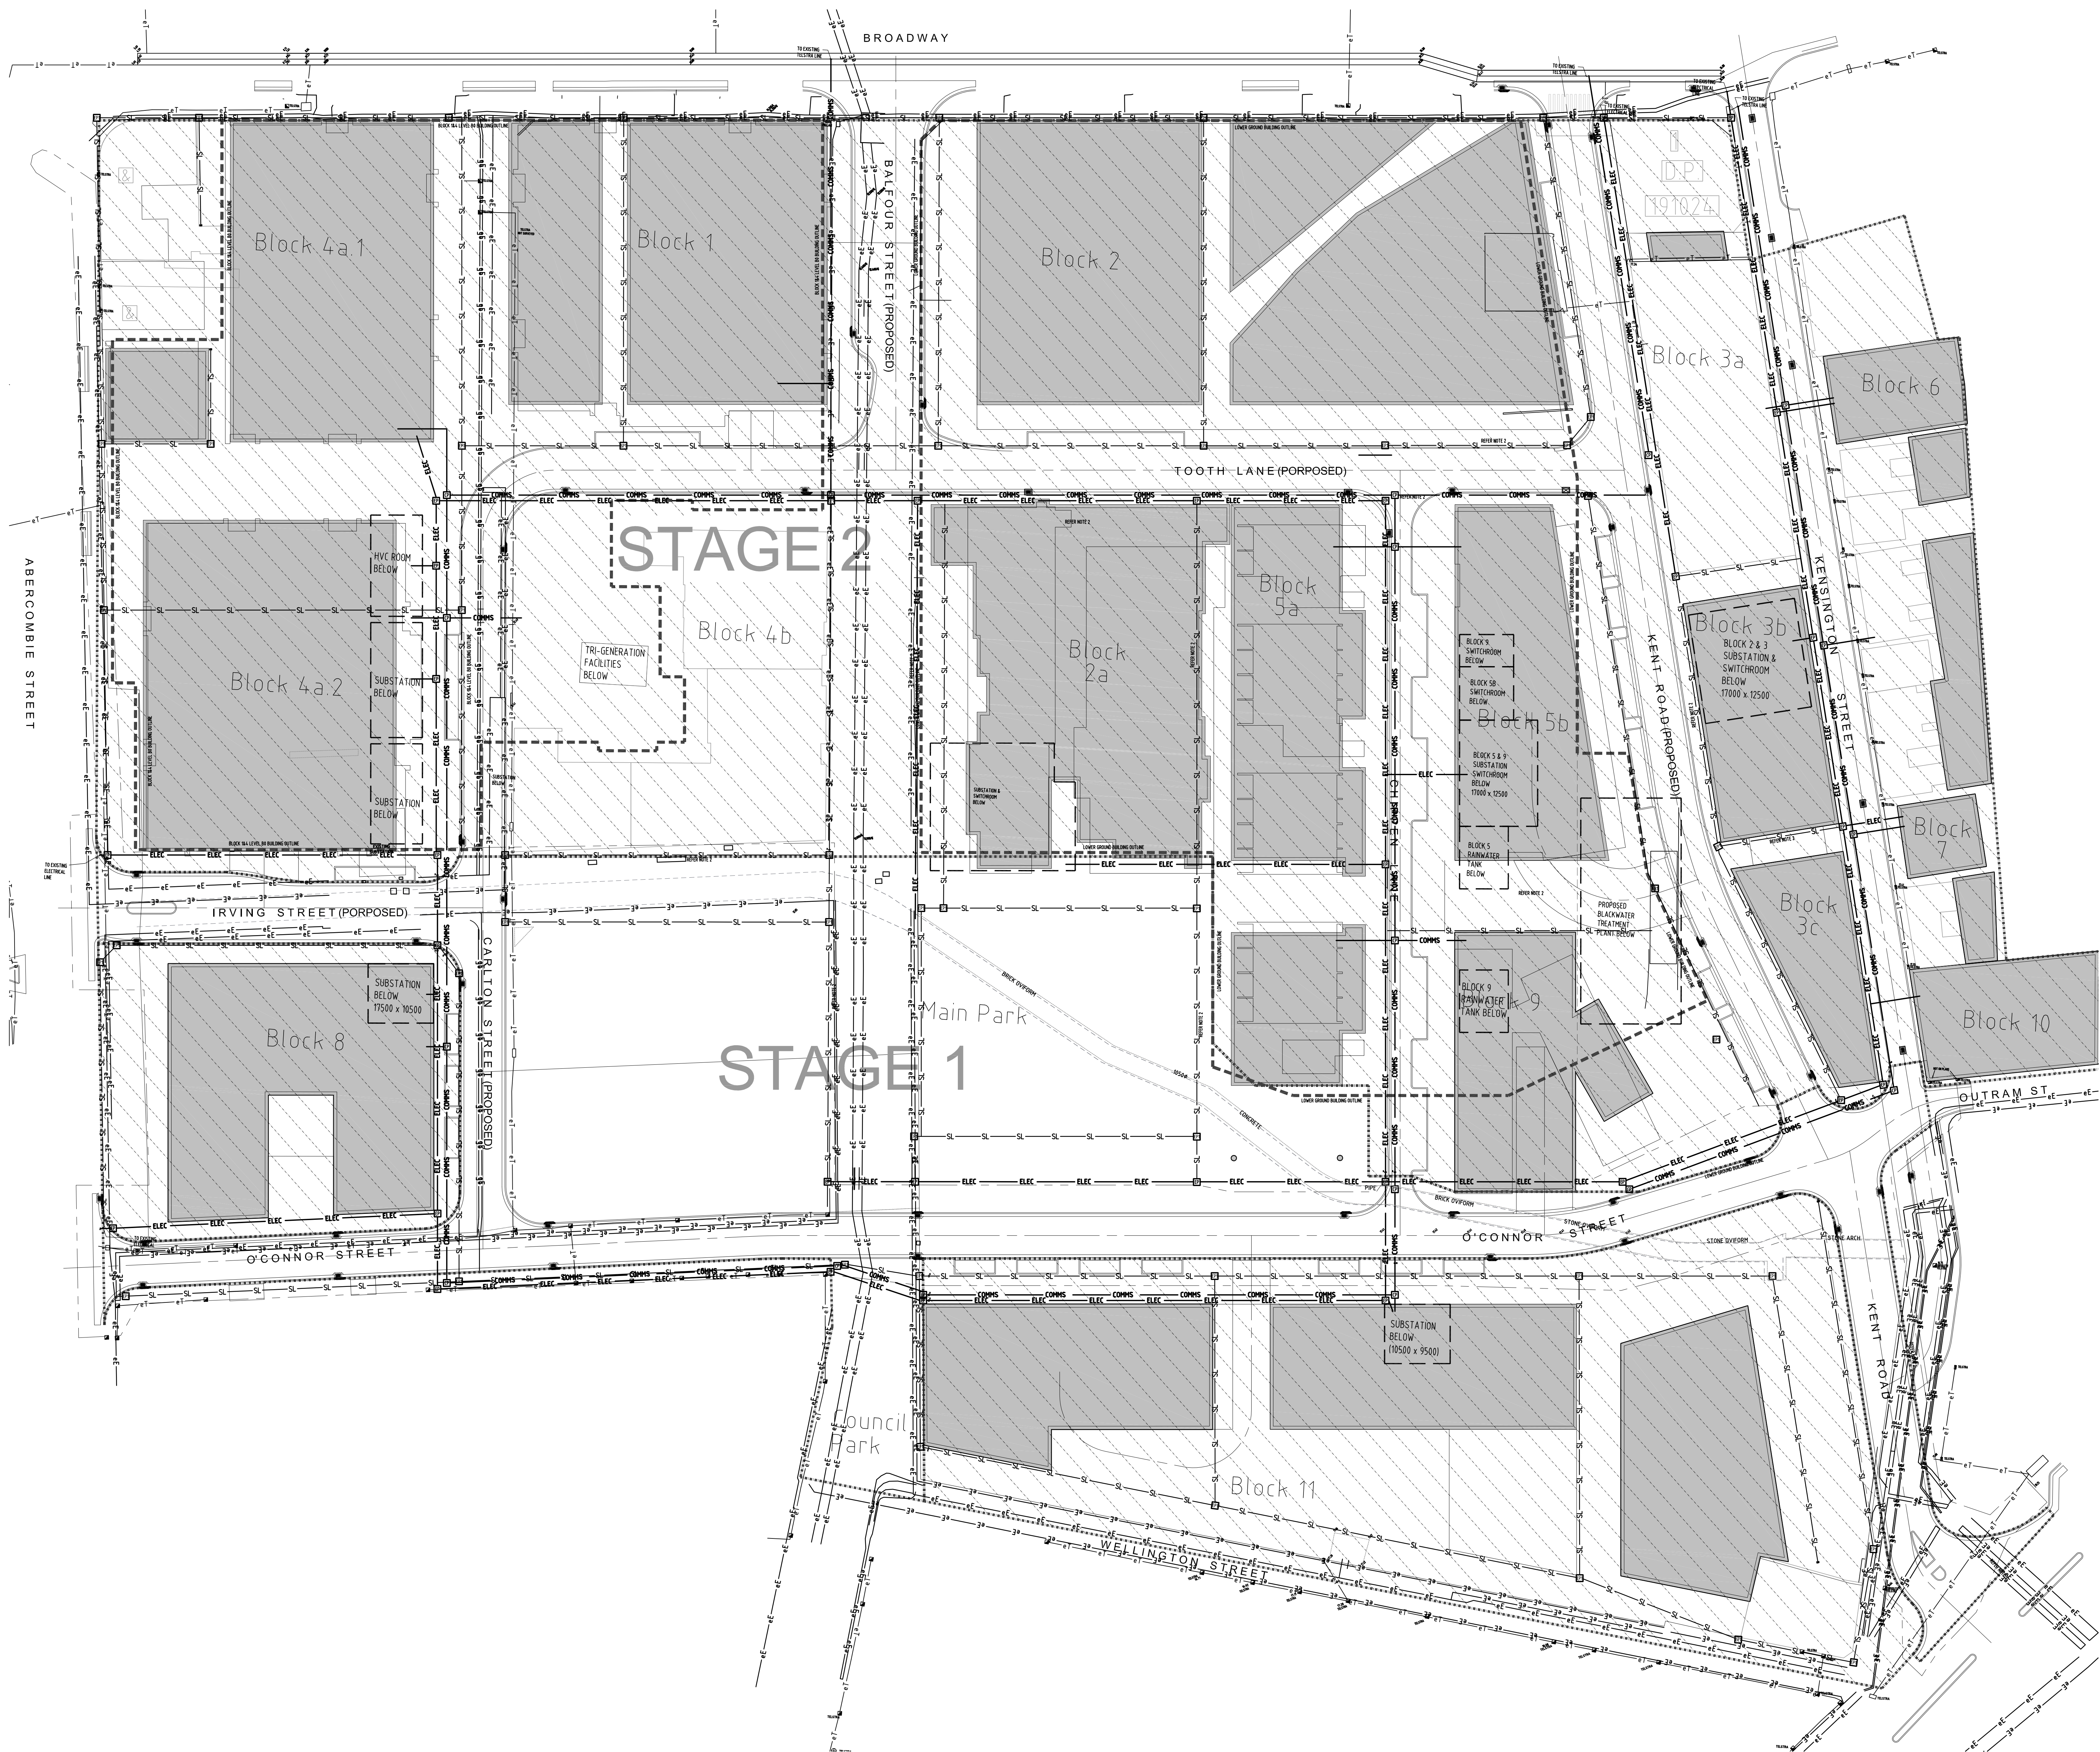


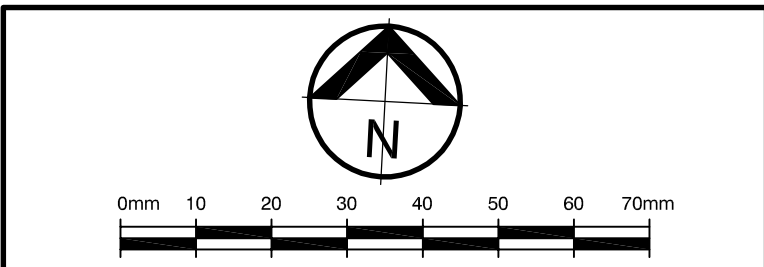

DATE	REV	AMENDMENT	BY	CHECK
04.05.09	01	PLANNING APPLICATION ISSUE	TDG	NJM

- NOTES:
- FOR LEGEND REFER TO DRAWING E4001.
 - FOR DECOMMISSIONED AND ABANDONED SERVICES REFER TO HUGHES TRUEMAN DRAWING No. 075428C-C04 PROPOSED INFRASTRUCTURE DECOMMISSIONING PLAN AND WEBB DRAWING Nos. ESK-01, 02 & 03 EA HV/LV NETWORK RETICULATIONS.

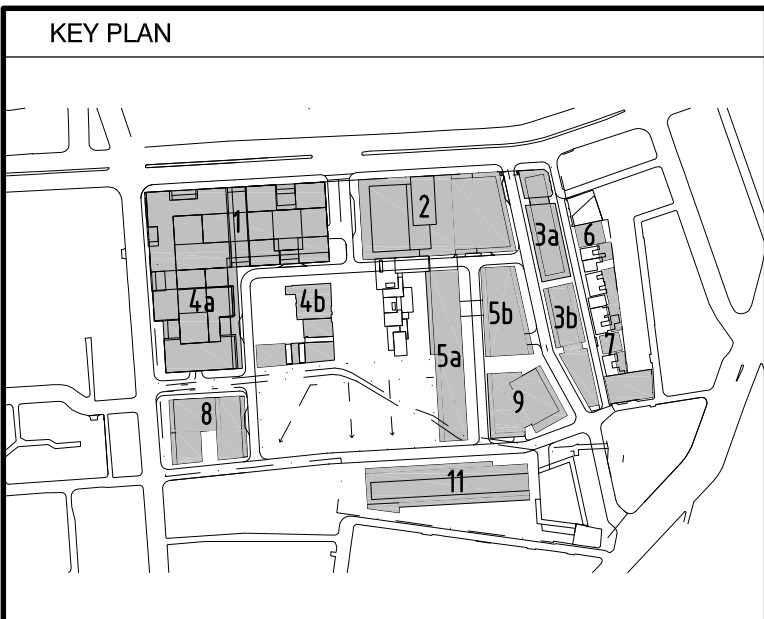

REFERENCE COORDINATION DRAWINGS			
DESCRIPTION	DRAWING NO.	REV	CHECK
STORMWATER PLAN	075428C-MP04	A	A
ROAD GRADING & EXISTING SERVICES	075428C-SK02	A	A
HERITAGE GRANT/PERMITS PROTECTION	086035-SK01-SK11	01	A
DETENTION TANK GEN. ARRANGEMENT	075428C-SK05	A	A
SITE GRADING PLAN/ROAD & VERGE	075428C-SK03	A	A
MASTER PLAN PUBLIC DOMAIN	984-021-LP09	A	K

Lincolne Scott
Consulting Engineers
Australia, Australia, Singapore
Brisbane, Cairns, Canberra
Hemel Hempstead, Melbourne, Perth
San Diego, Singapore, Sydney

Level 1, 61 McLaren Street
PO Box 610 North Sydney
New South Wales 1585 Australia
Telephone: +61 2 9557 6600
Facsimile: +61 2 9557 4127
sydney@lincolnescott.com

PROJECT
**FRASERS BROADWAY
20-102 BROADWAY
SYDNEY**
CLIENT
FRASERS BROADWAY

DATE	20.04.09	DRAWN	TDG
SCALE	1:400	CHECKED	NJM
SHEET SIZE	A0	APPROVED	-
CADD FILE: P:\SYD\080740C\Stage 1\SYD080740C-E4151.dwg			

TITLE
**STAGE 1- SITE INFRASTRUCTURE
NEW AND EXISTING ELECTRICAL
& COMMUNICATION**
PROJECT NO.
SYD 080740C E4151

DRAWING NO.
01

REVISION

PRELIMINARY