



DATE	REV	AMENDMENT	BY	CHKD
06.03.09	01	PRELIMINARY DESIGN DEVELOPMENT	ZZH	YWC
13.03.09	02	FOR INFORMATION ONLY	KV	DHS
13.04.09	03	REVISED PRELIMINARY ISSUE	YWC	DHS
04.05.09	04	PLANNING APPLICATION ISSUE	YWC	DHS

NOTES:

- COVERED THROUGH-SITE PUBLIC ACCESS AREA LIGHTING BY OTHERS. LIGHTING DESIGN TO BE REVIEWED TO BE IN ACCORDANCE WITH LIGHTING MASTERPLAN AND TO BE REVIEWED BY MASTERPLAN LIGHTING CONSULTANT.
- LIGHTING DESIGN PENDING FURTHER DETAIL.
- STAIR TREAD LIGHTING TO FUTURE DETAIL.
- NOT PART OF THIS CONTRACT. REFER TO MASTER PLAN.
- FOR LEGEND REFER TO DRAWING No. E4401

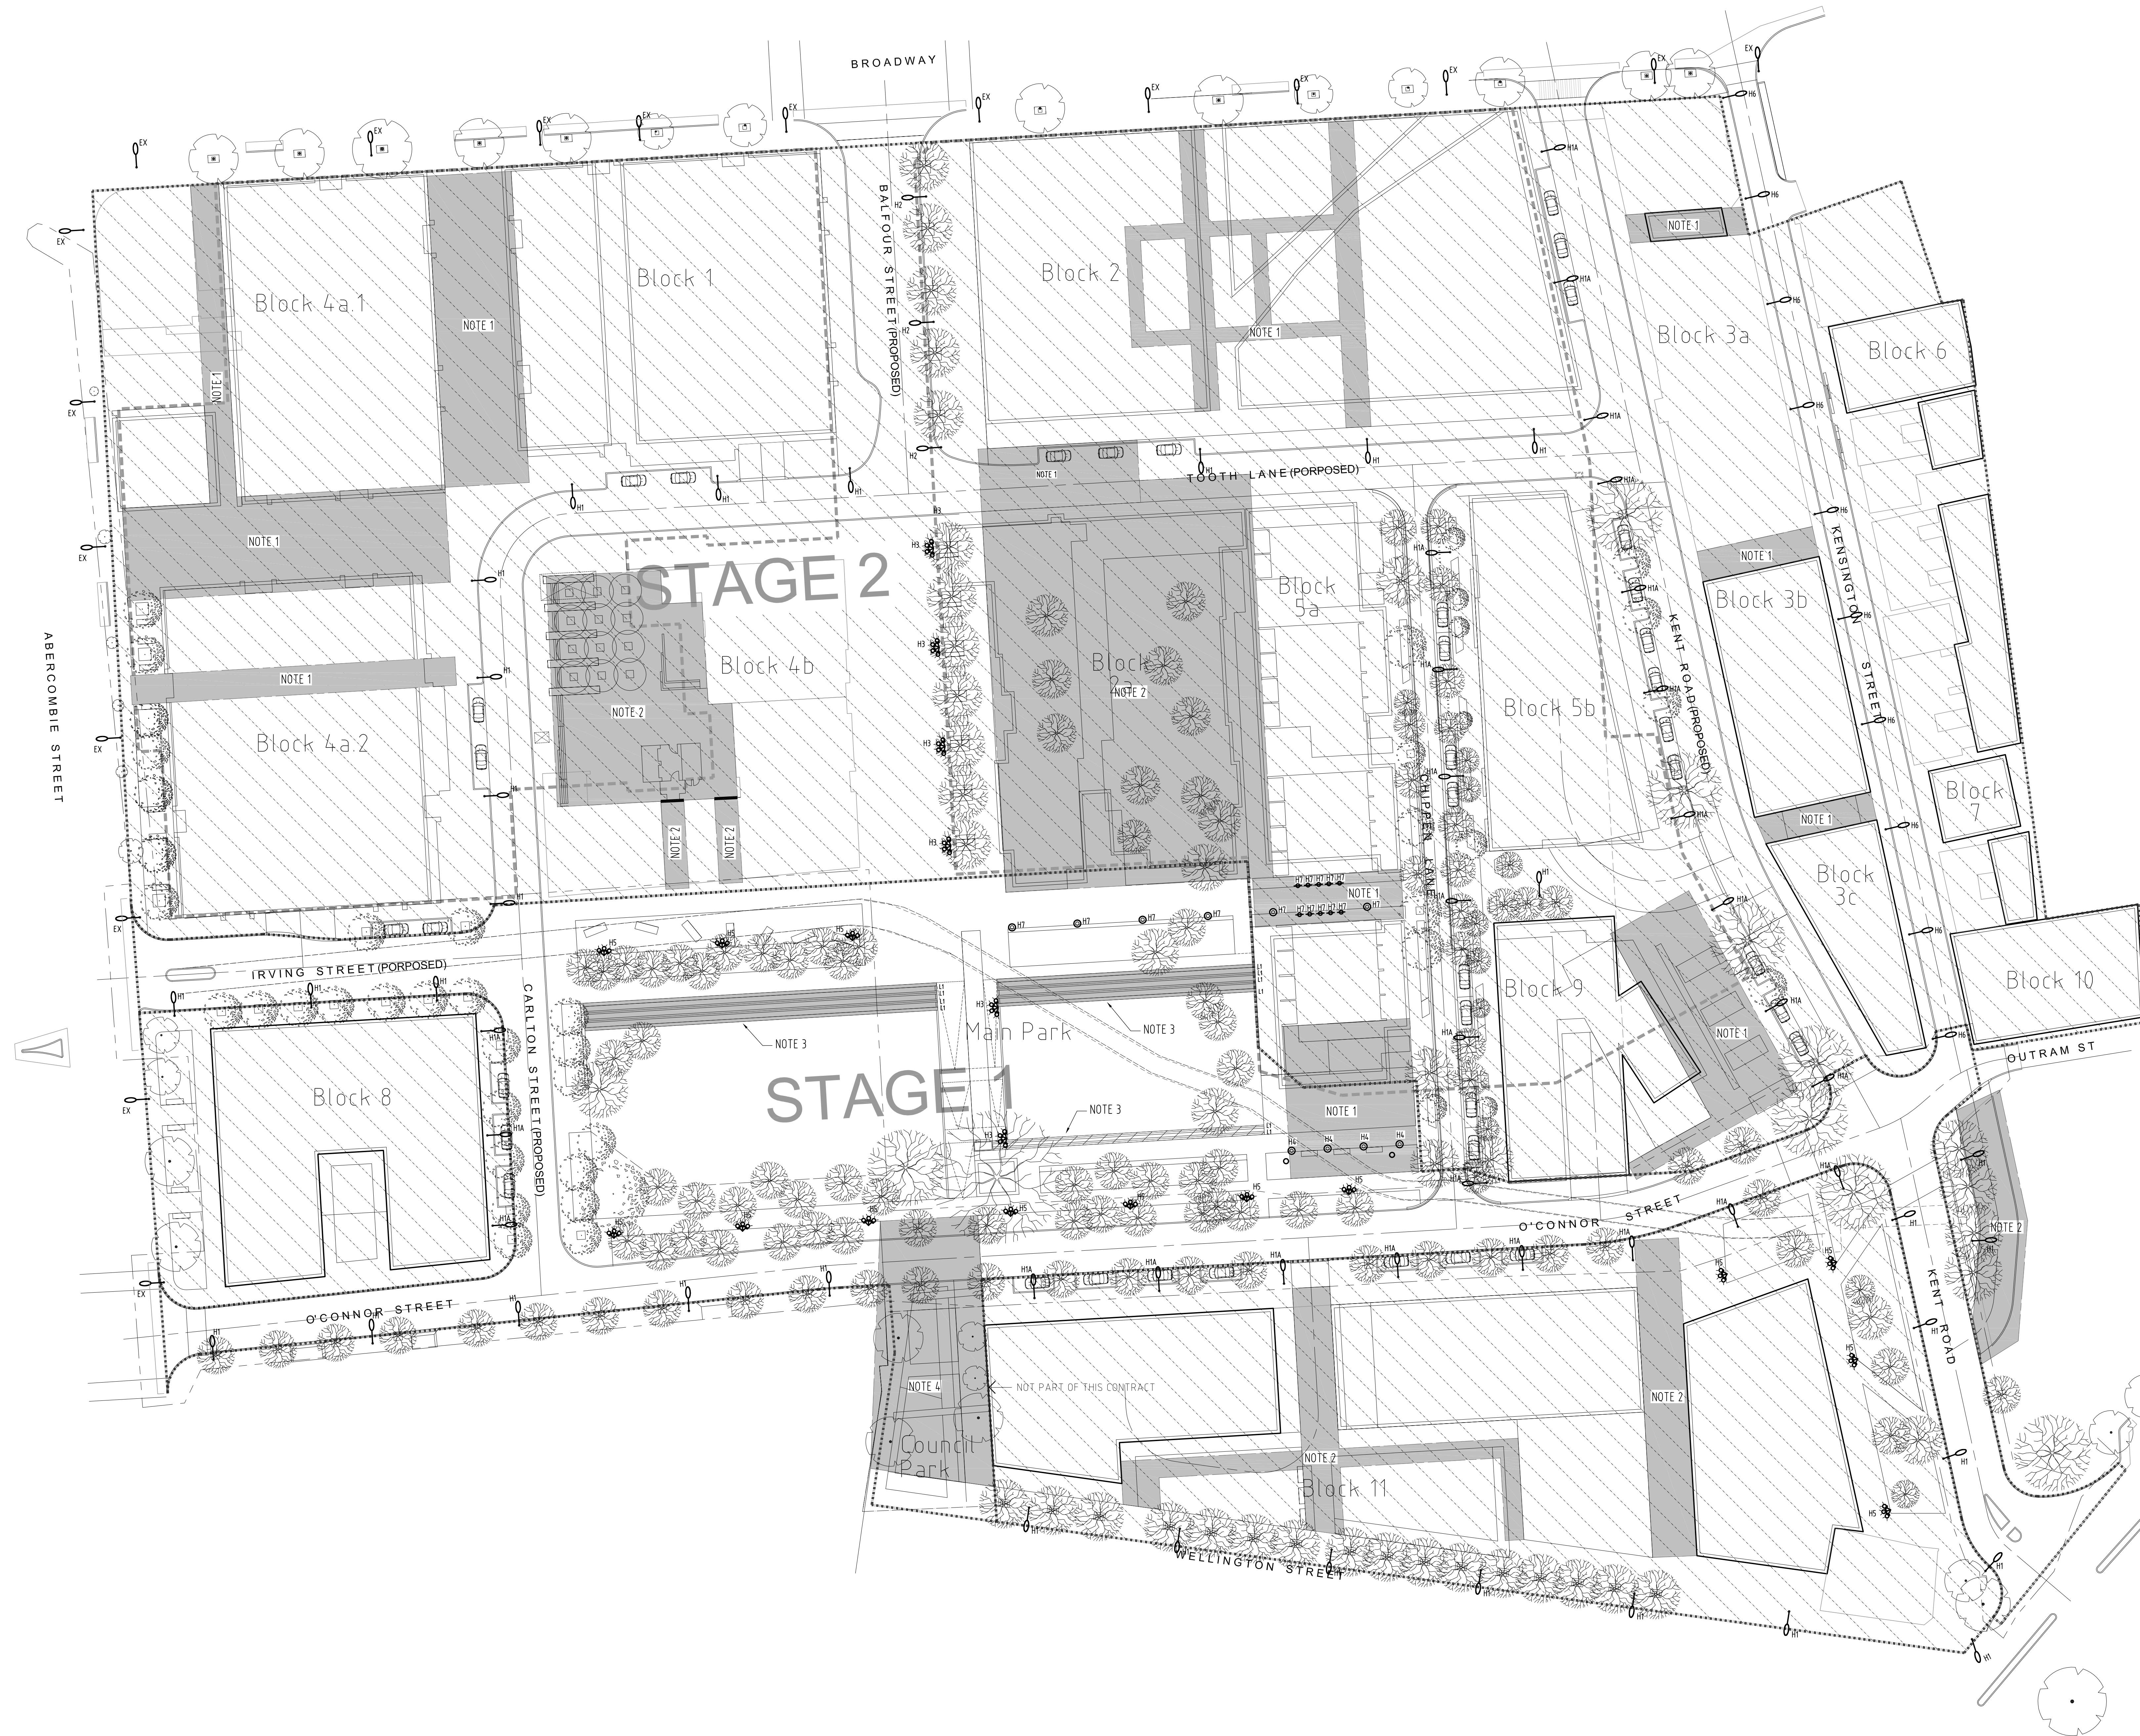

H1

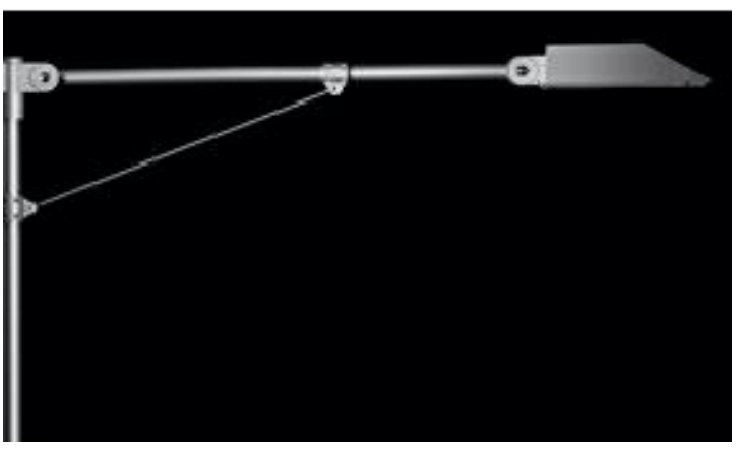

H1A



H2



H3



H4



H5





H6



H7

PRELIMINARY

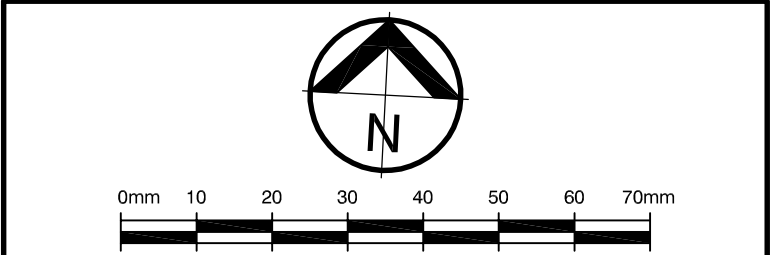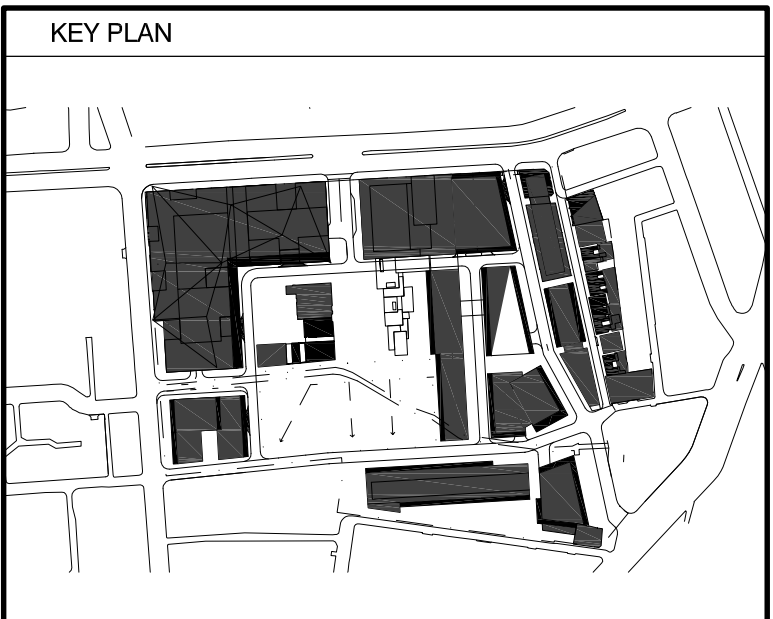

REFERENCE COORDINATION DRAWINGS	DRAWING NO.	REV	CHKD
MASTER PLAN PUBLIC DOMAIN	984-0721-4-PMP	H	A
SITE GRADING PLAN ROAD & VERGE	075628C-SKT3		



PROJECT
**FRASERS BROADWAY
20-102 BROADWAY
SYDNEY**
CLIENT
FRASERS BROADWAY

DATE	15.07.08	DRAWN	ZZH
SCALE	1:400	CHECKED	YWC
SHEET SIZE	A0	APPROVED	DHS
CAD FILE	P:\SYD080740C\Stage 1\SYD080740C.E4400.dwg		

TITLE
**STAGE 1 - SITE INFRASTRUCTURE
LIGHTING MASTER PLAN**

PROJECT NO.	DRAWING NO.	REVISION
SYD 080740C	E4400	04