



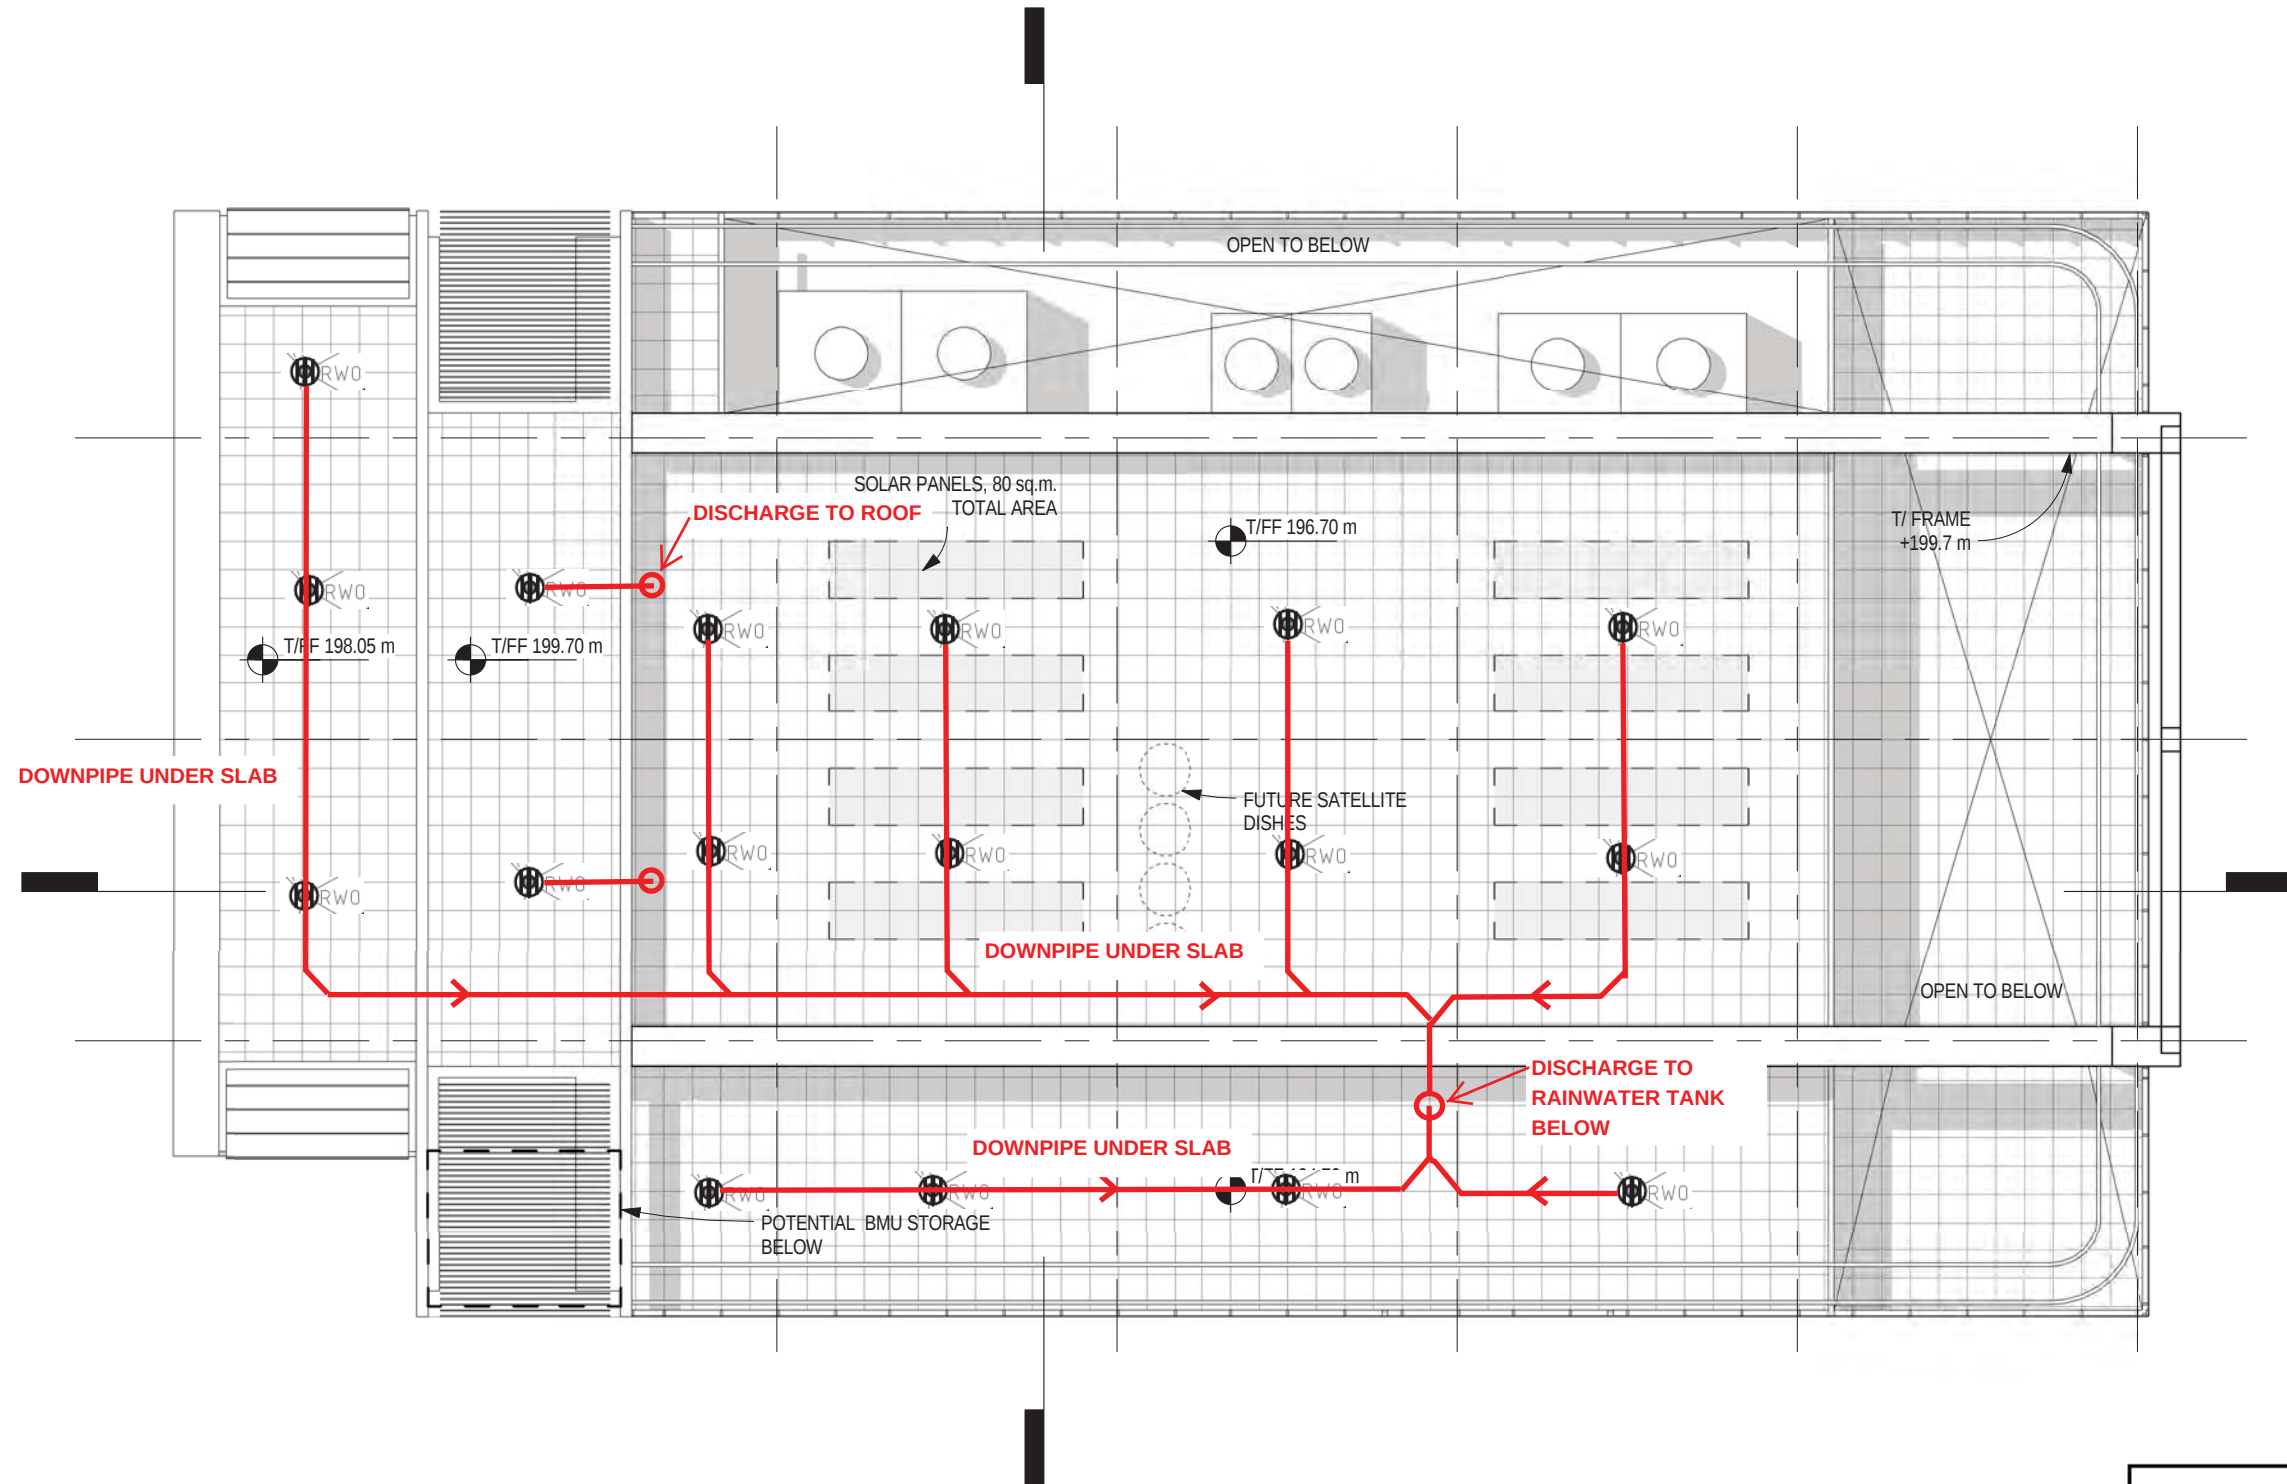

ARUP	
Project Name	100 Mount Street
Project No.	221811-00
Drawing Title	Stormwater Drainage Plan
	Sheet 1 of 4
Drawing No.	SK-H-01
Date	10/8/2011

ROOF PLAN

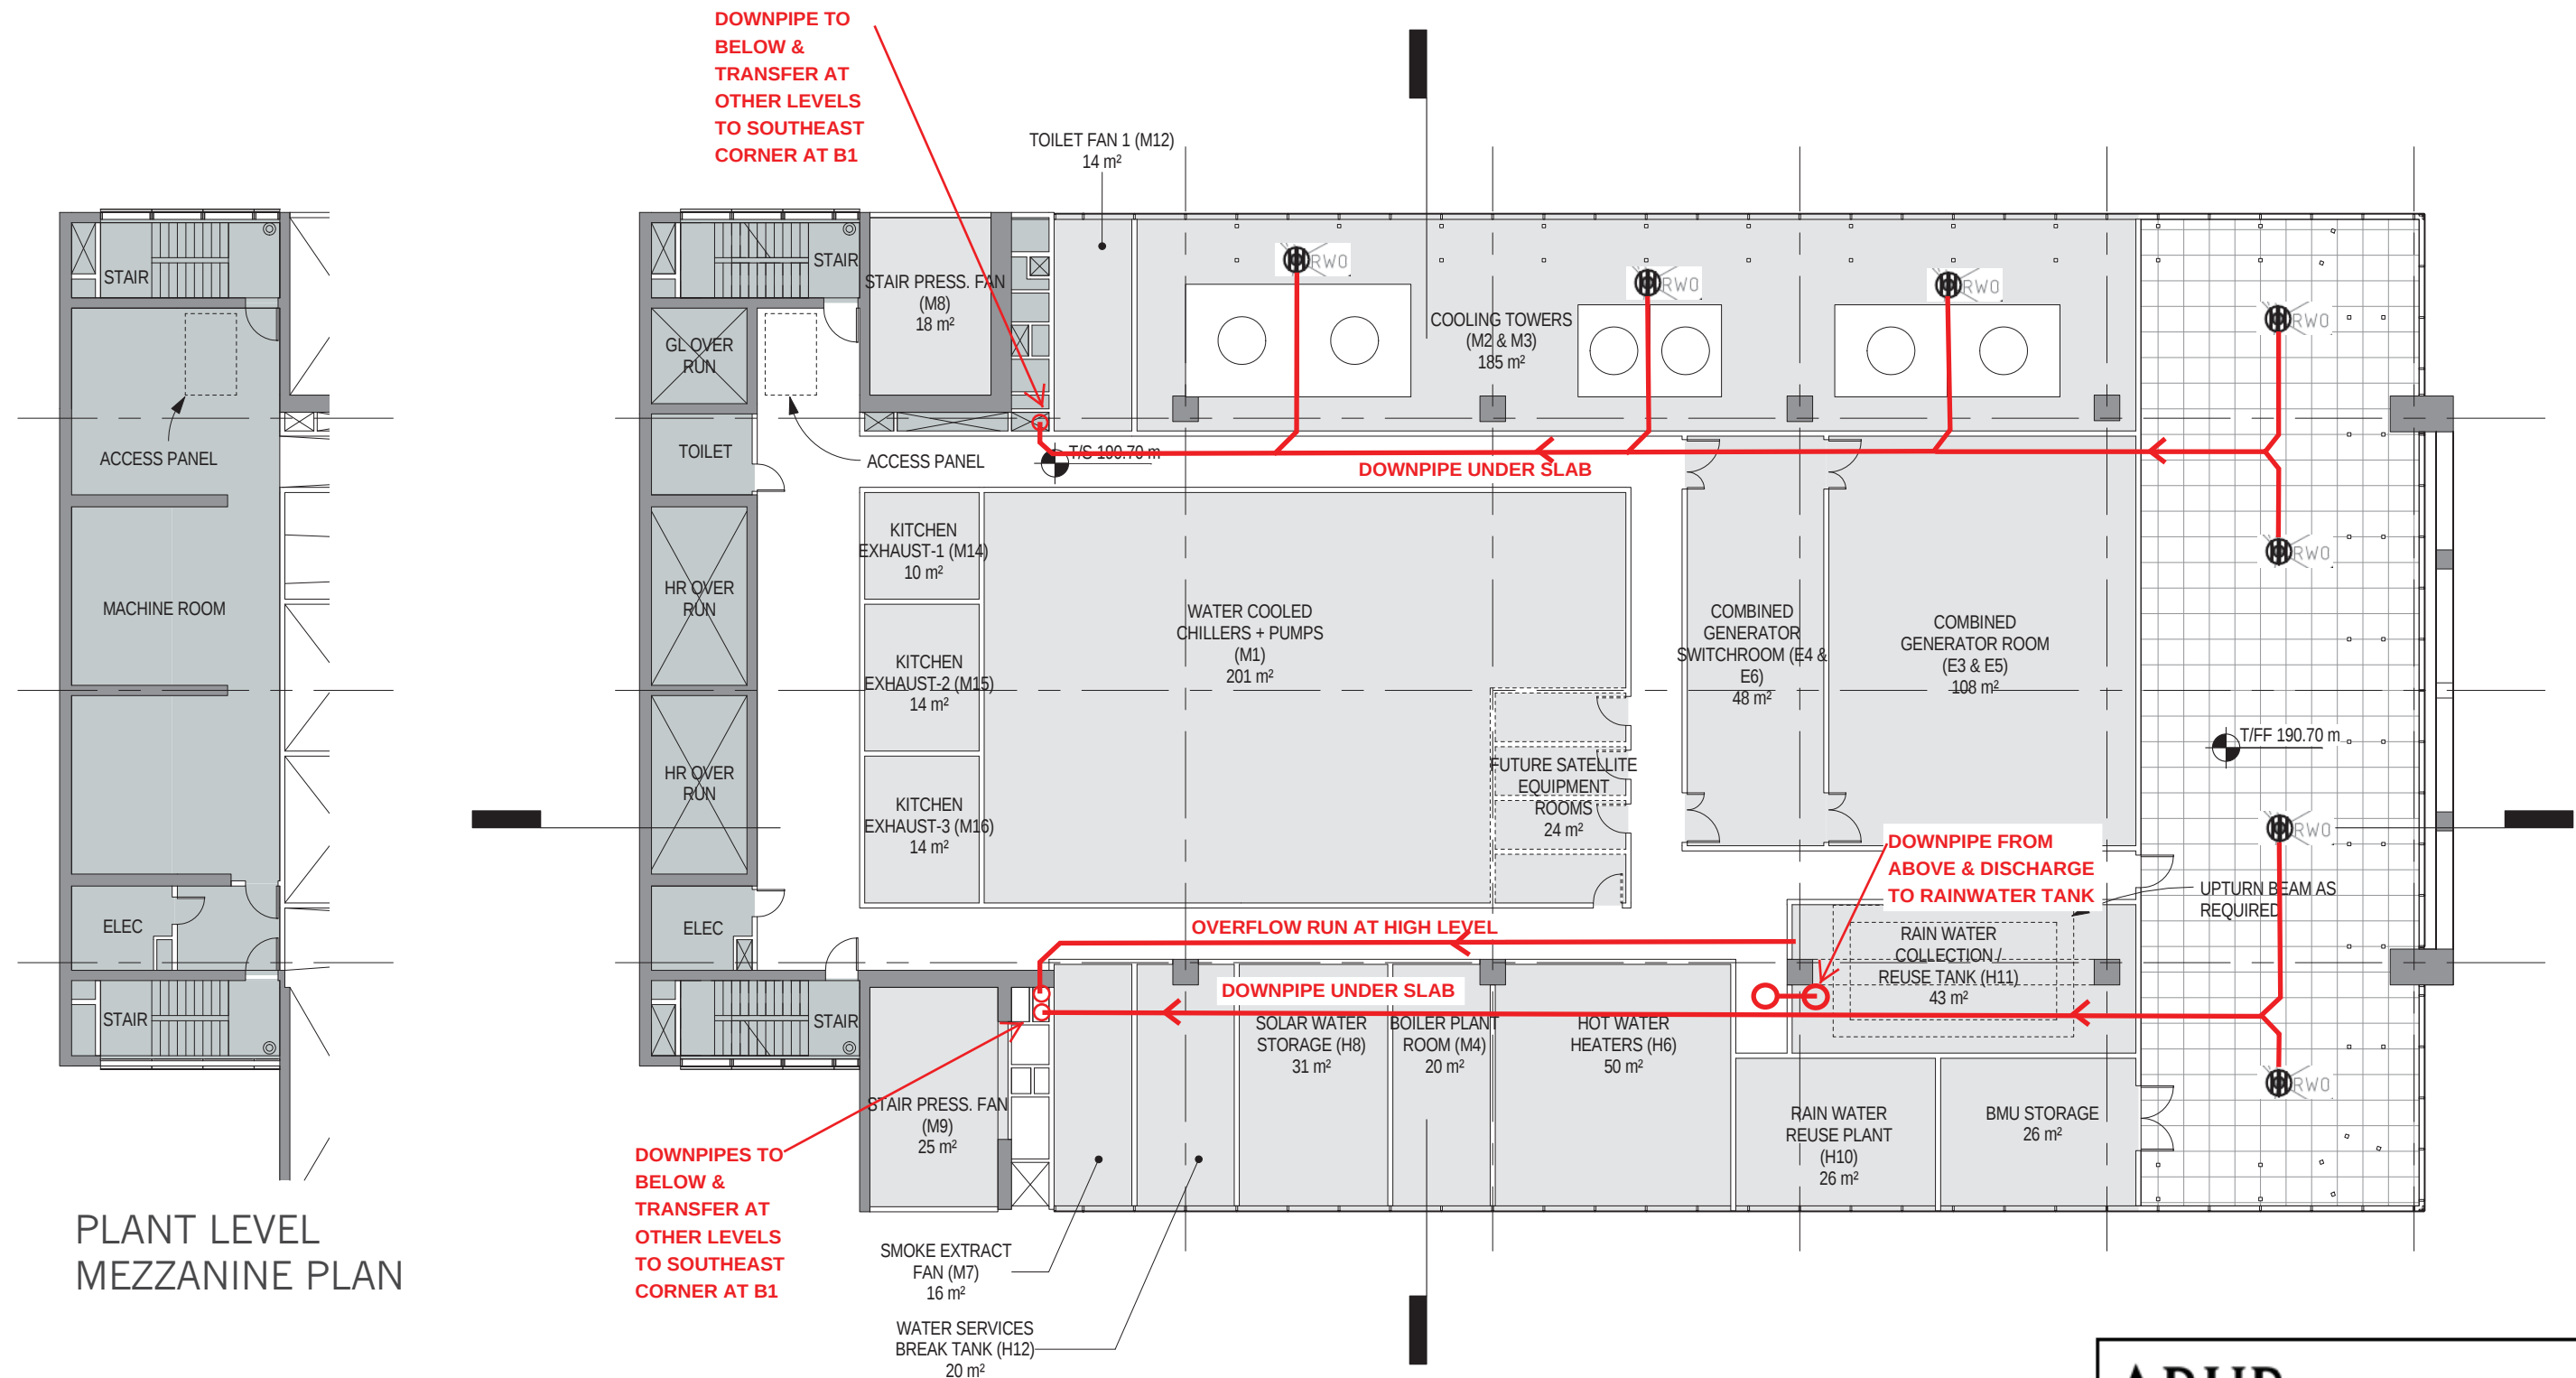


PLANT LEVEL
MEZZANINE PLAN



ARUP	
Project Name	100 Mount Street
Project No.	221811-00
Drawing Title	Stormwater Drainage Plan Sheet 2 of 4
Drawing No.	SK-H-02
Date	10 / 8 / 2011

PLANT LEVEL PLAN

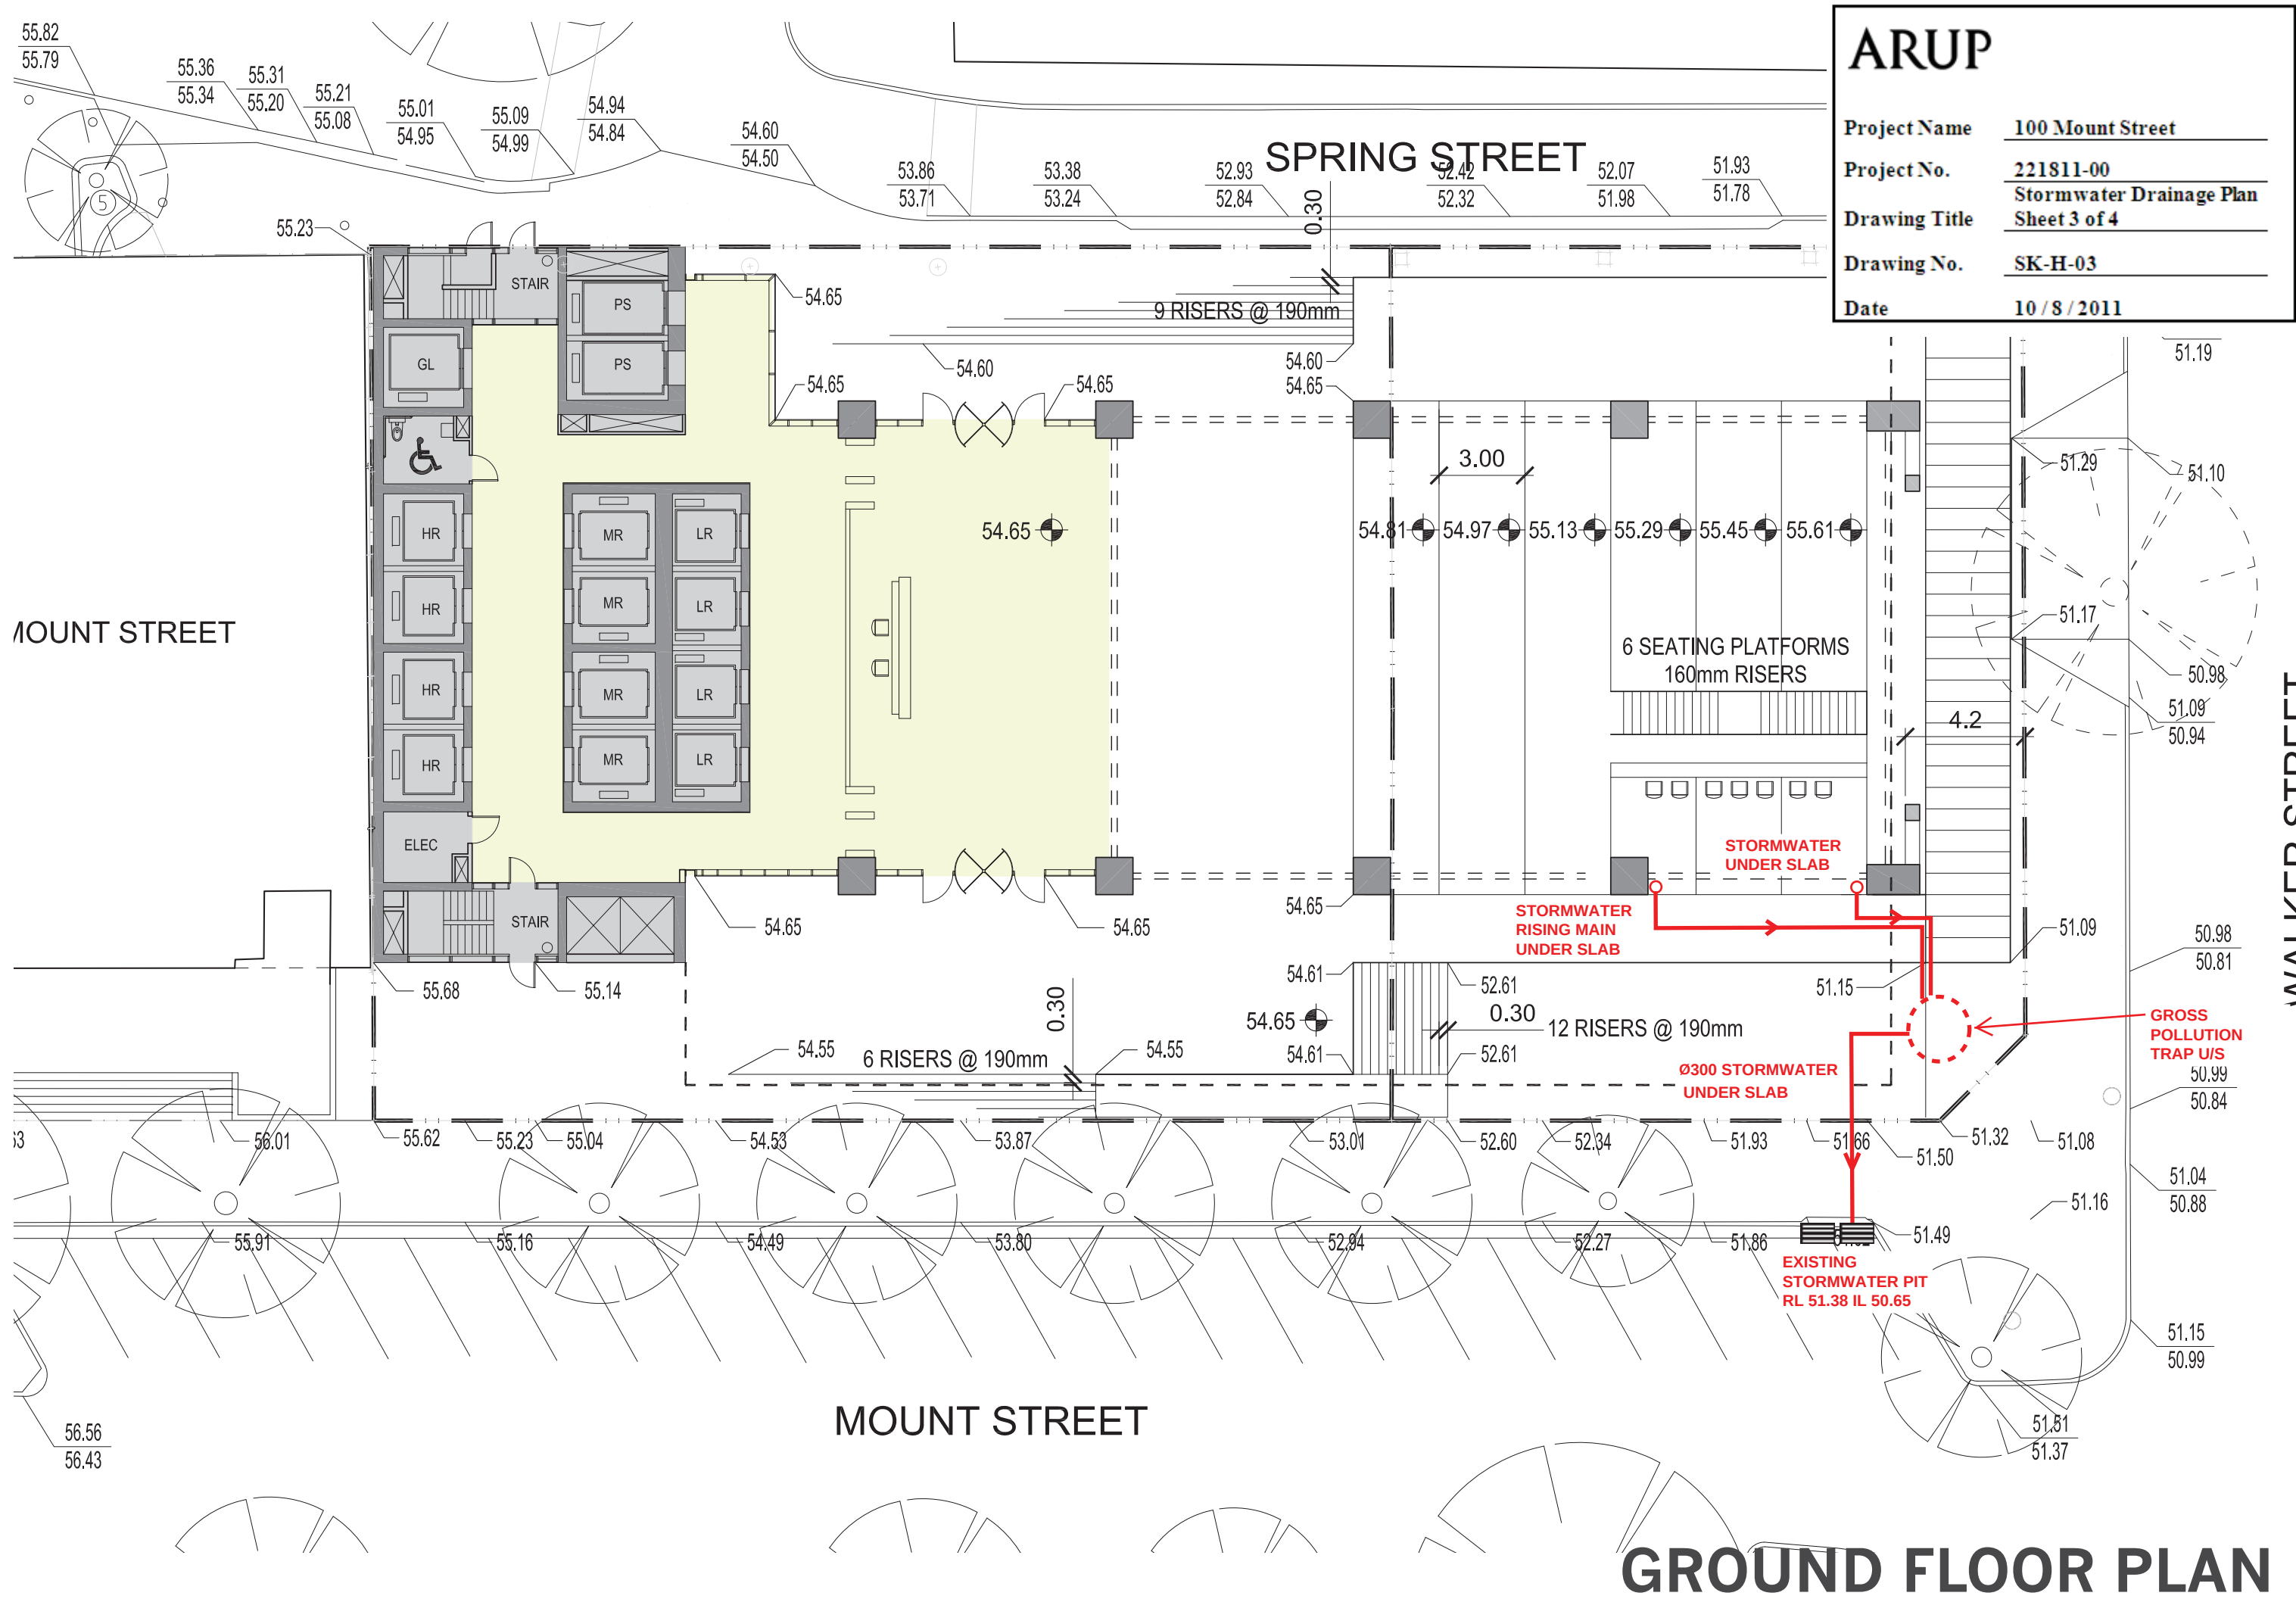

ARUP

Project Name

100 Mount Street

Project No.

221811-00

Drawing Title


Stormwater Drainage Plan

Drawing No.

SK-H-03

Date

10 / 8 / 2011

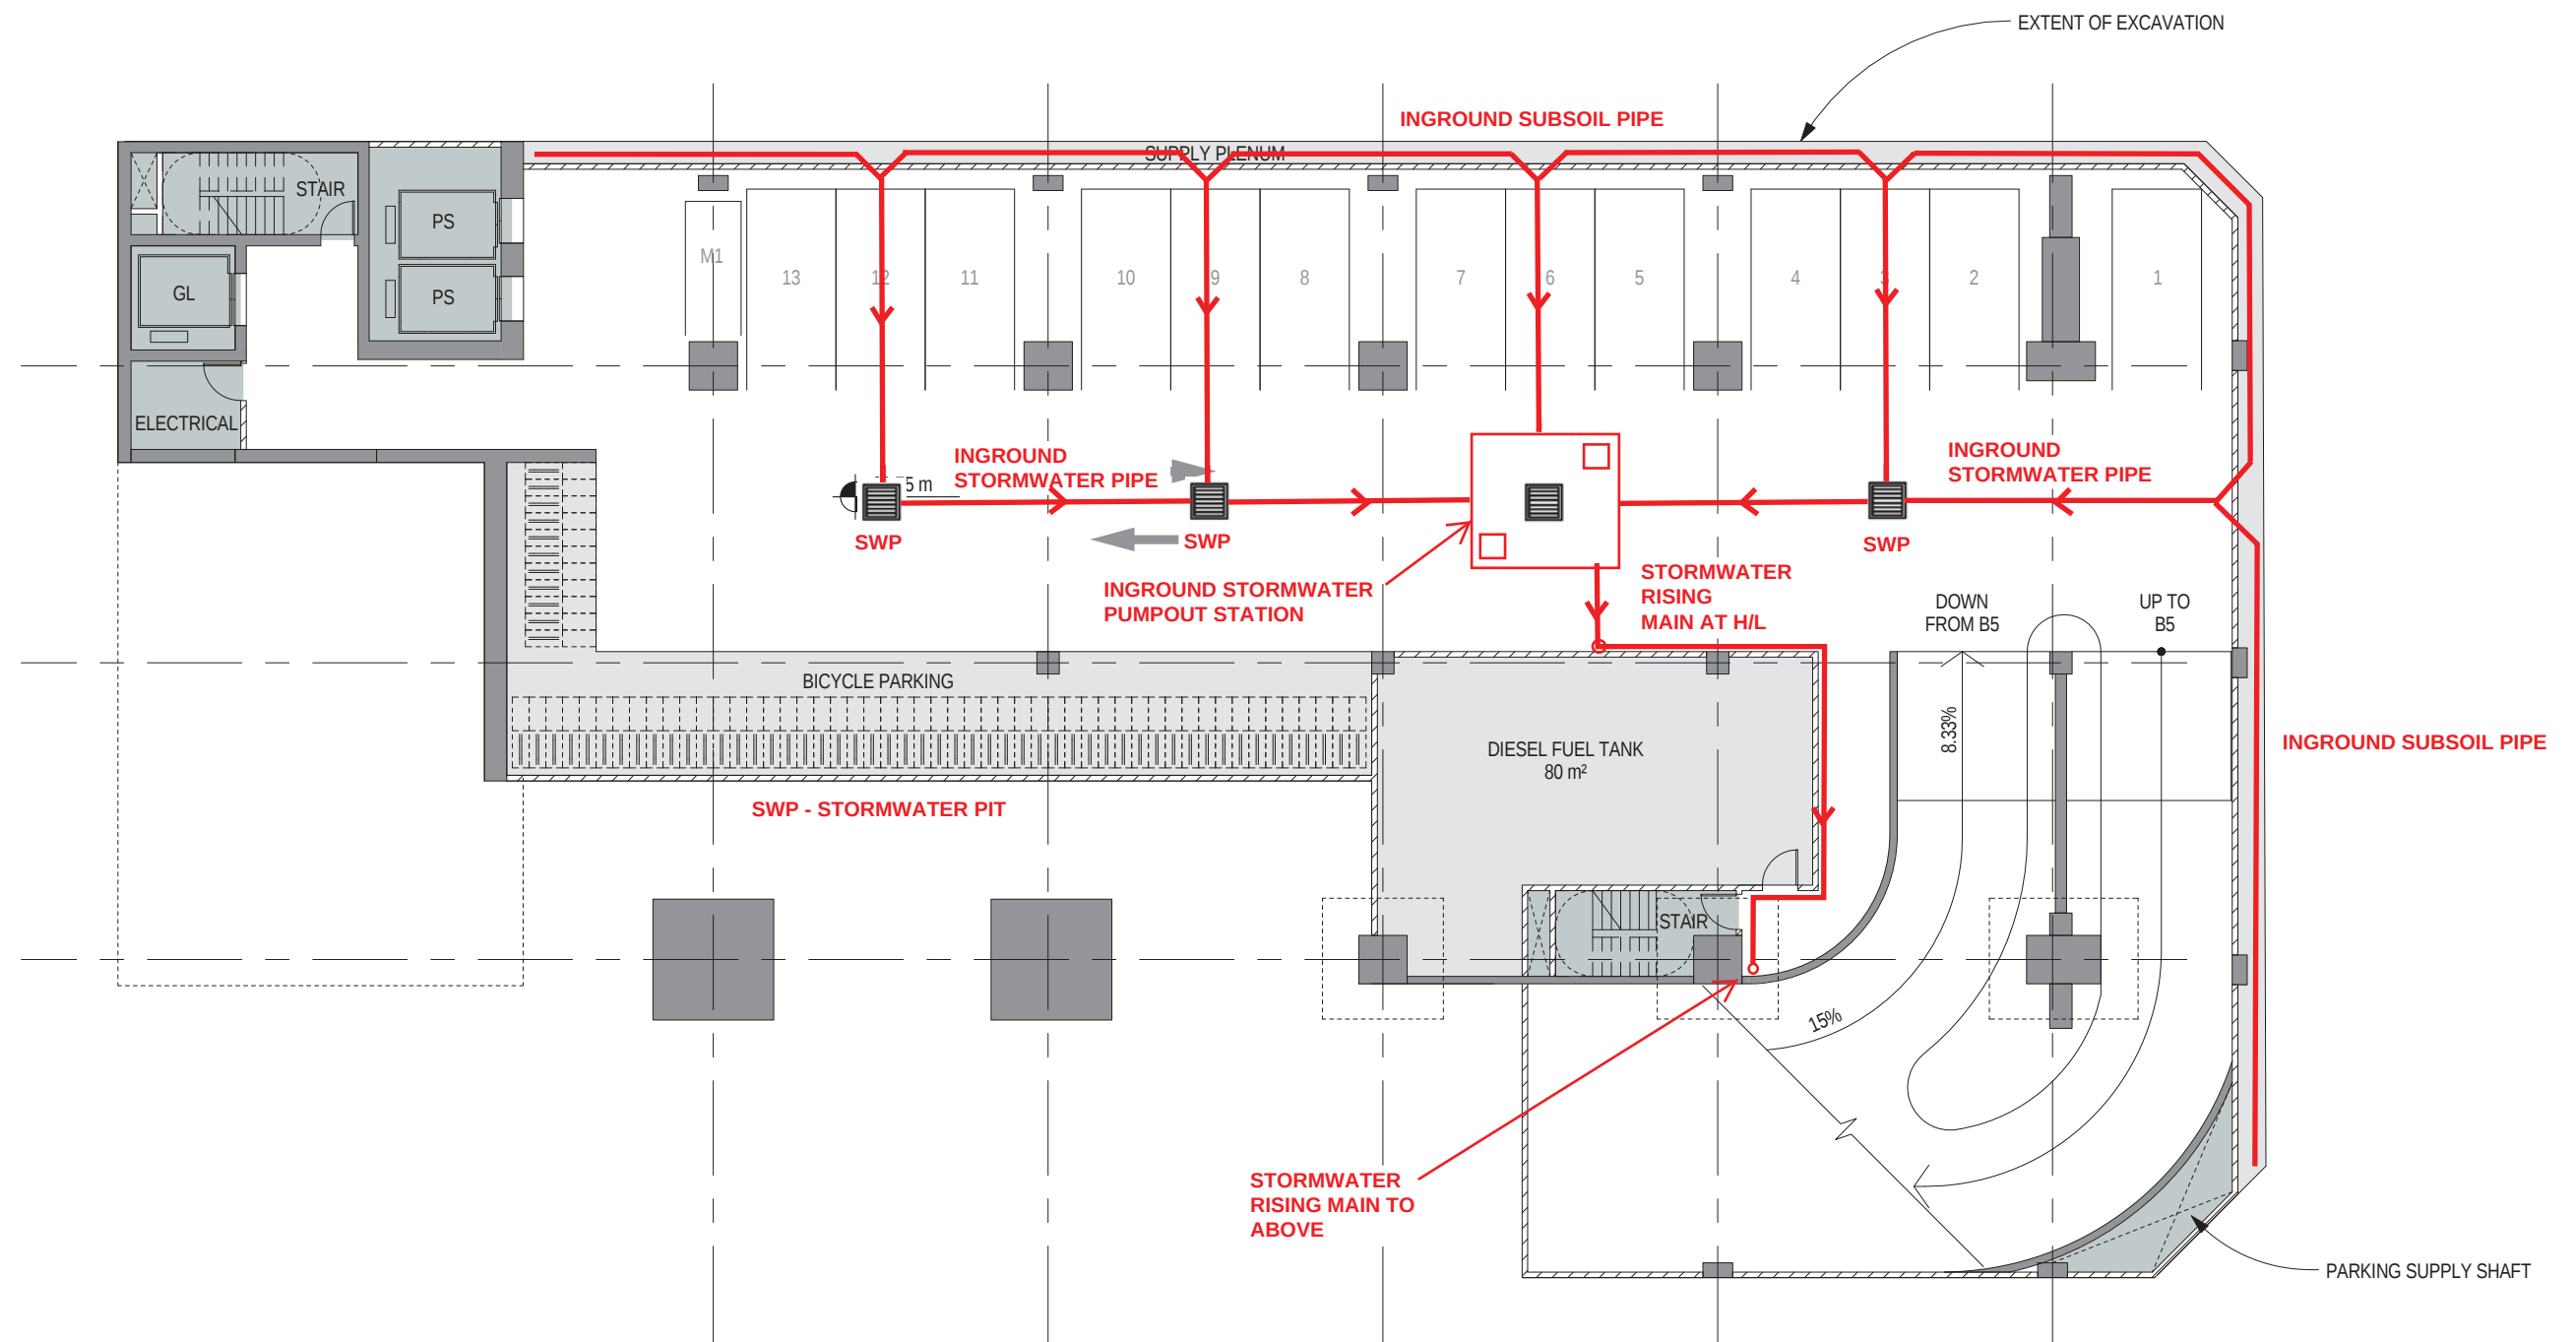

ARUP

Project Name	100 Mount Street
Project No.	221811-00
Drawing Title	Stormwater Drainage Plan Sheet 4 of 4
Drawing No.	SK-H-04
Date	10 / 8 / 2011

PLAN - B6 LEVEL