


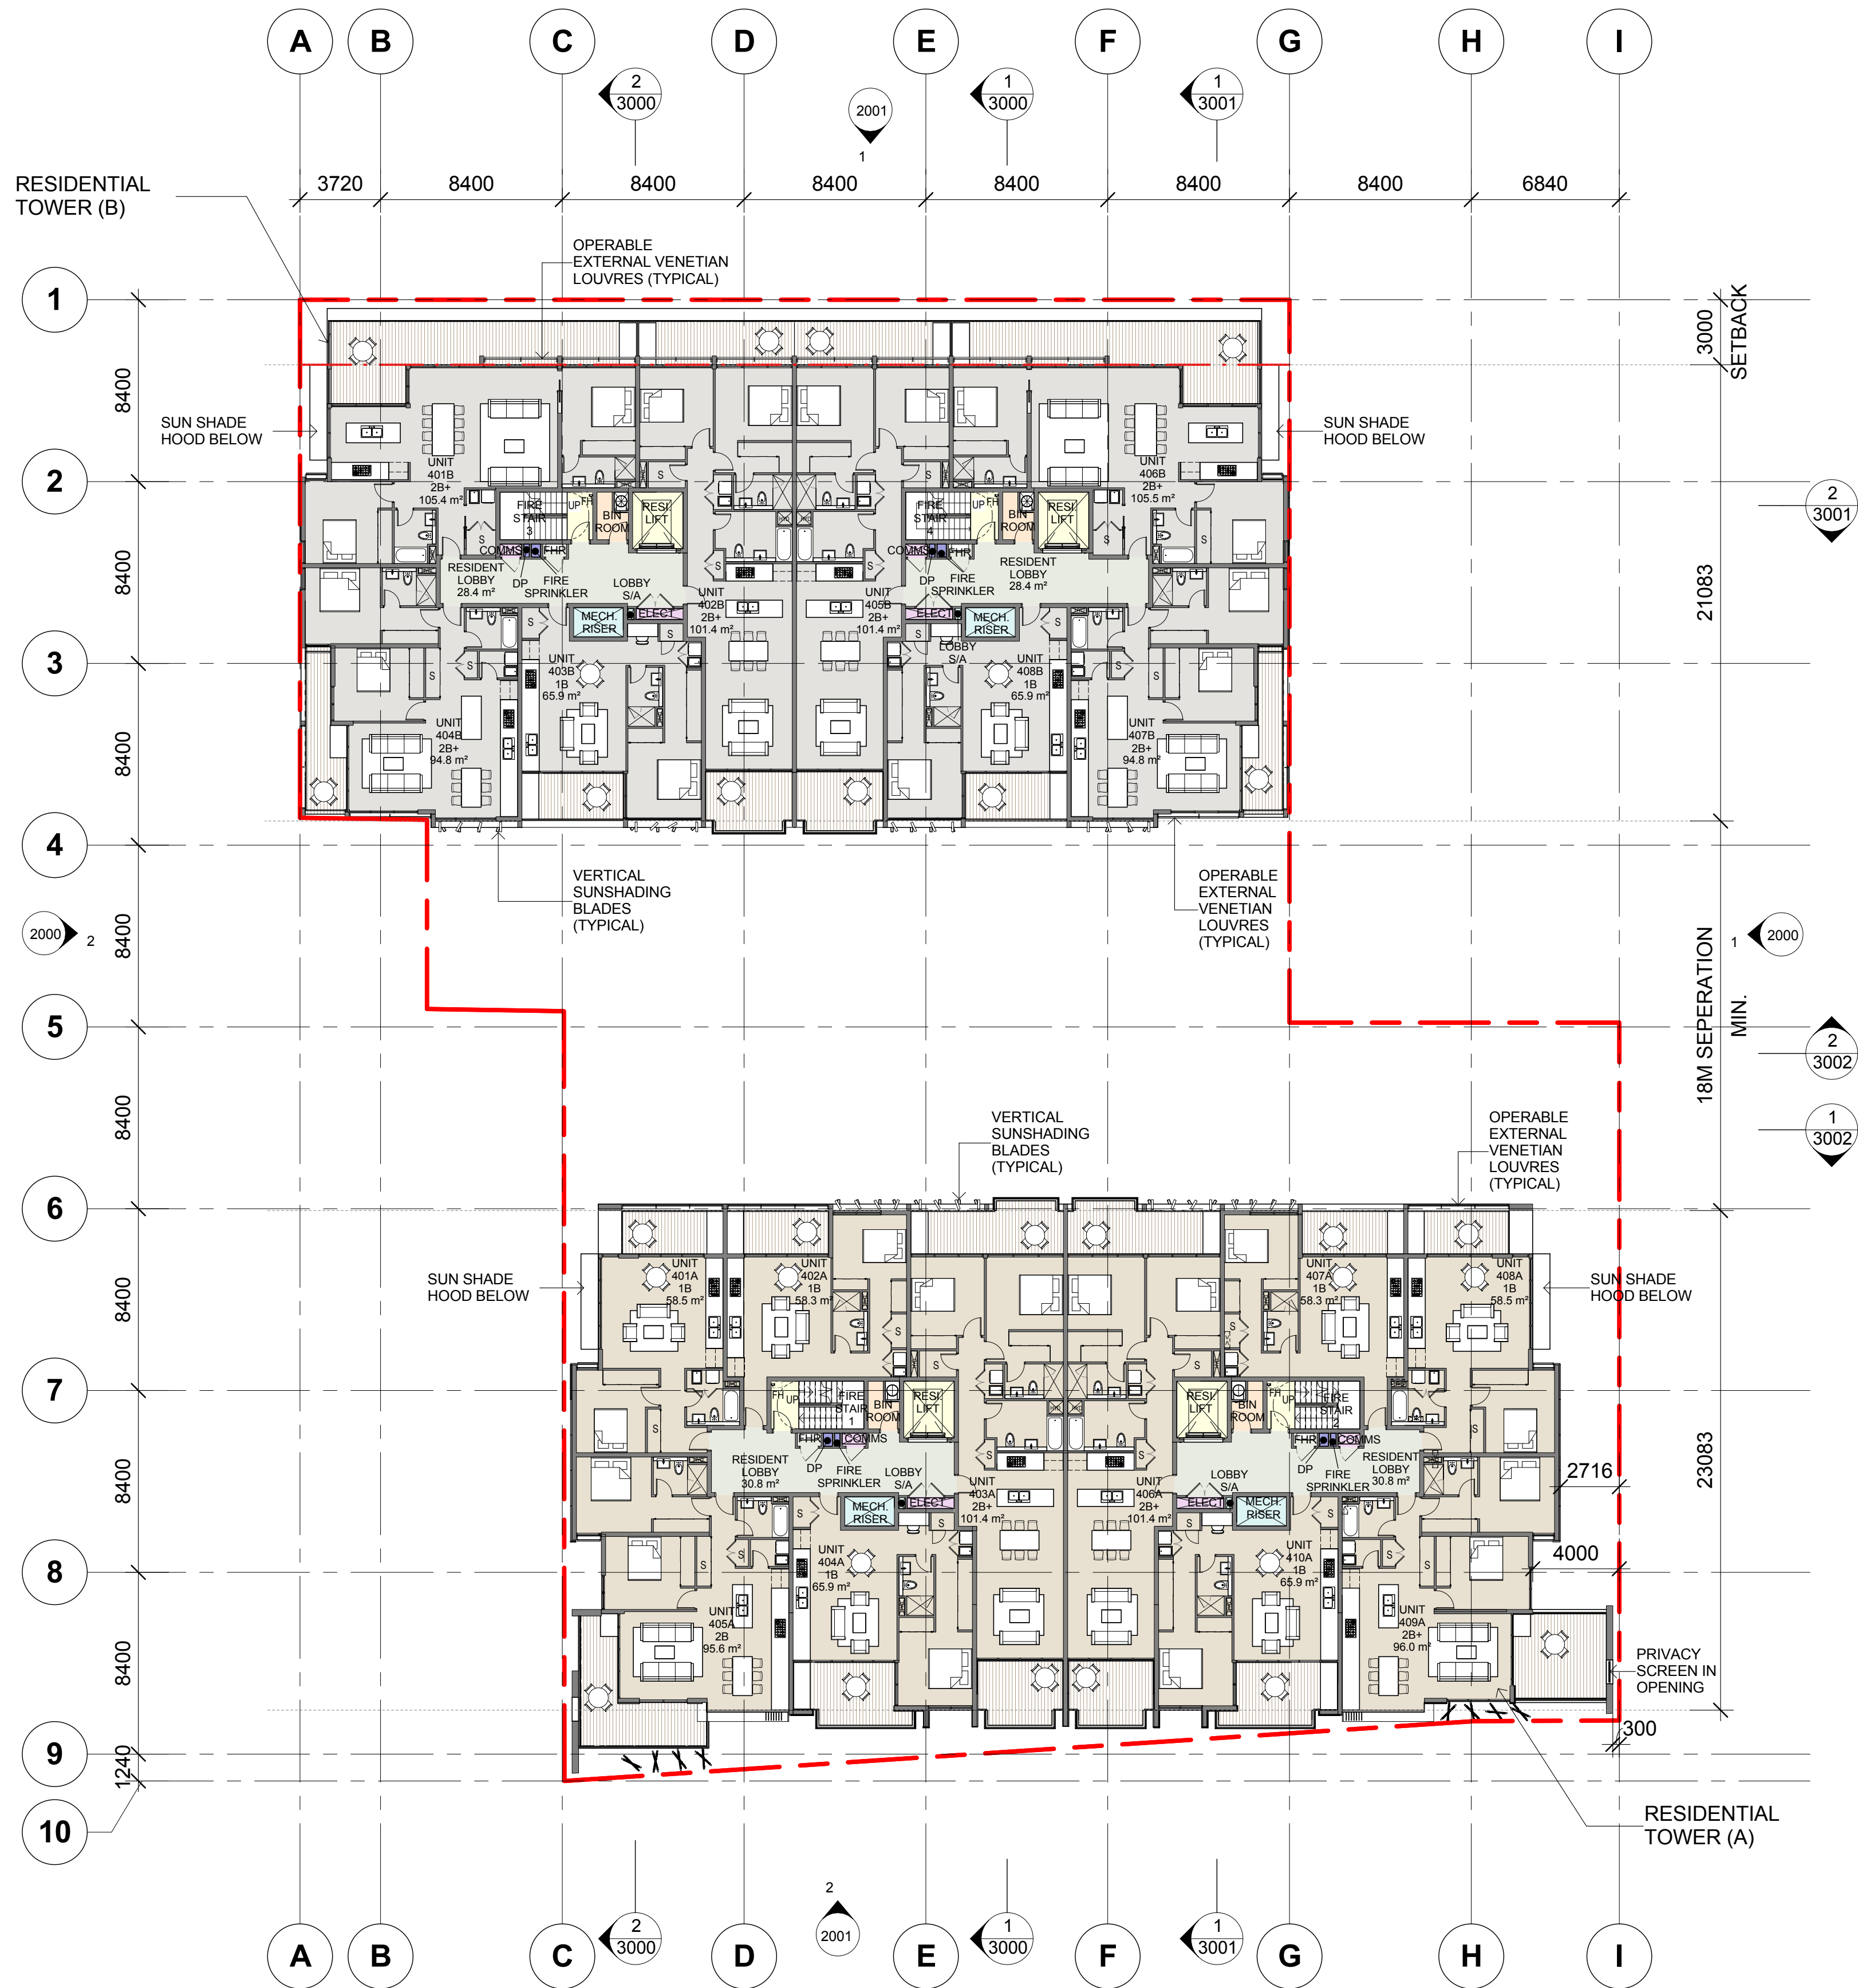

COLOR FILL LEGEND

- AMENITY
- CIRCULATION
- ELECTRICAL RISER
- GARBAGE
- HORIZONTAL TRANSPORTATION
- HYD/FIRE RISER
- MECH. RISER
- PARKING
- PUBLIC AREA
- RESIDENT(A)
- RESIDENT(B)
- RETAIL
- SERVICE ZONE
- TANKS
- VERTICAL TRANSPORTATION

1 LEVEL 4
1007 SCALE 1 : 200

Notes
All dimensions and setbacks to be verified prior to commencement, omissions or discrepancies to be notified to the architect.

Copyright
The copyright of this drawing together with any other documents prepared by crone partners architecture studios. ply ltd (cp) remains the property of cp. crone partners grants licence for the use of this document for the purpose for which they are intended. The licence is not transferable without the permission of cp.

Quality Assurance System

Authorised By: _____ Date: _____

Rev	DESCRIPTION	By	Date
A	ISSUED FOR SECTION 75W SUBMISSION	MQ	20/11/2012



ABSA
Certification Number: 1004864102
Certification Date: 14/11/2012
Assessor Name: Rochelle Phillips
Assessor Number: 60865
Assessor Signature: _____
Simulated Geogebra Rating: 21.640m²/m²
Simulated Geogebra CO2-REQ: 0.010m²/m²
6.1

Builder
ANKA (CIVIC CENTER) PTY LTD
LEVEL 3
179-191 NEW SOUTH HEAD RD
EDGECLIFF, SYDNEY NSW 2027
Ph: +61 2 9302 3000
Fax: +61 2 9302 3030

Client
ANKA (CIVIC CENTER) PTY LTD
LEVEL 3
179-191 NEW SOUTH HEAD RD
EDGECLIFF, SYDNEY NSW 2027
Ph: +61 2 9302 3000
Fax: +61 2 9302 3030



Structural Engineer
AECOM
Level 21, 420 George St. Sydney NSW 2000
Ph: 02 8934 0000 Fax: 02 8934 0001

Mechanical Engineer
WOOD & GRIEVE ENGINEERS
Level 3, 454 - 456 Pacific Highway,
St. Leonards, NSW 2000
Ph: 02 8484 7000 Fax: 02 8484 7100


Electrical Engineer
WOOD & GRIEVE ENGINEERS
Level 3, 454 - 456 Pacific Highway,
St. Leonards, NSW 2000
Ph: 02 8484 7000 Fax: 02 8484 7100

Hydraulic Engineer
INSYNC SERVICES
Suite 8, Level 2, 56 Church Ave.
Mascot, NSW 2015
Ph: 02 9669 4311 Fax: 02 9669 4322

Landscape Architect
ASPECT Studios
Studio 61 - Level 6, 61 Marlborough St
Surry Hills, NSW 2010
Ph: 02 9699 7182 Fax: 02 9699 7192

KEY

Scale 1 : 200 @A1

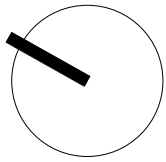

cronepartners
Cronepartners
level 2, 364 Kent street,
sydney, nsw 2000, australia
Ph: +61 2 8295 5300
Fax: +61 2 8295 5301

Project
LINDFIELD MIXED-USE DEVELOPMENT
23-37 LINDFIELD AVE & 11 HAVILAH LA
LINDFIELD NSW 2070

Drawn: MQ	Checked: VD	Date: 20/11/2012
-----------	-------------	------------------

Drawing Title
LEVEL 4 FLOOR PLAN

SECTION 75W SUBMISSION

CA 2924	ADAZ	1007	A
Project no.	Drawing Phase.	Drawing No.	Rev

SECTION 75W SUBMISSION

Cad File No: C:\Users\michaelq\Documents\CA-2924-Z-M3-AR-Main_Model-Central_michaelq.rvt Plot Date: 19/11/2012 11:11:10 AM