


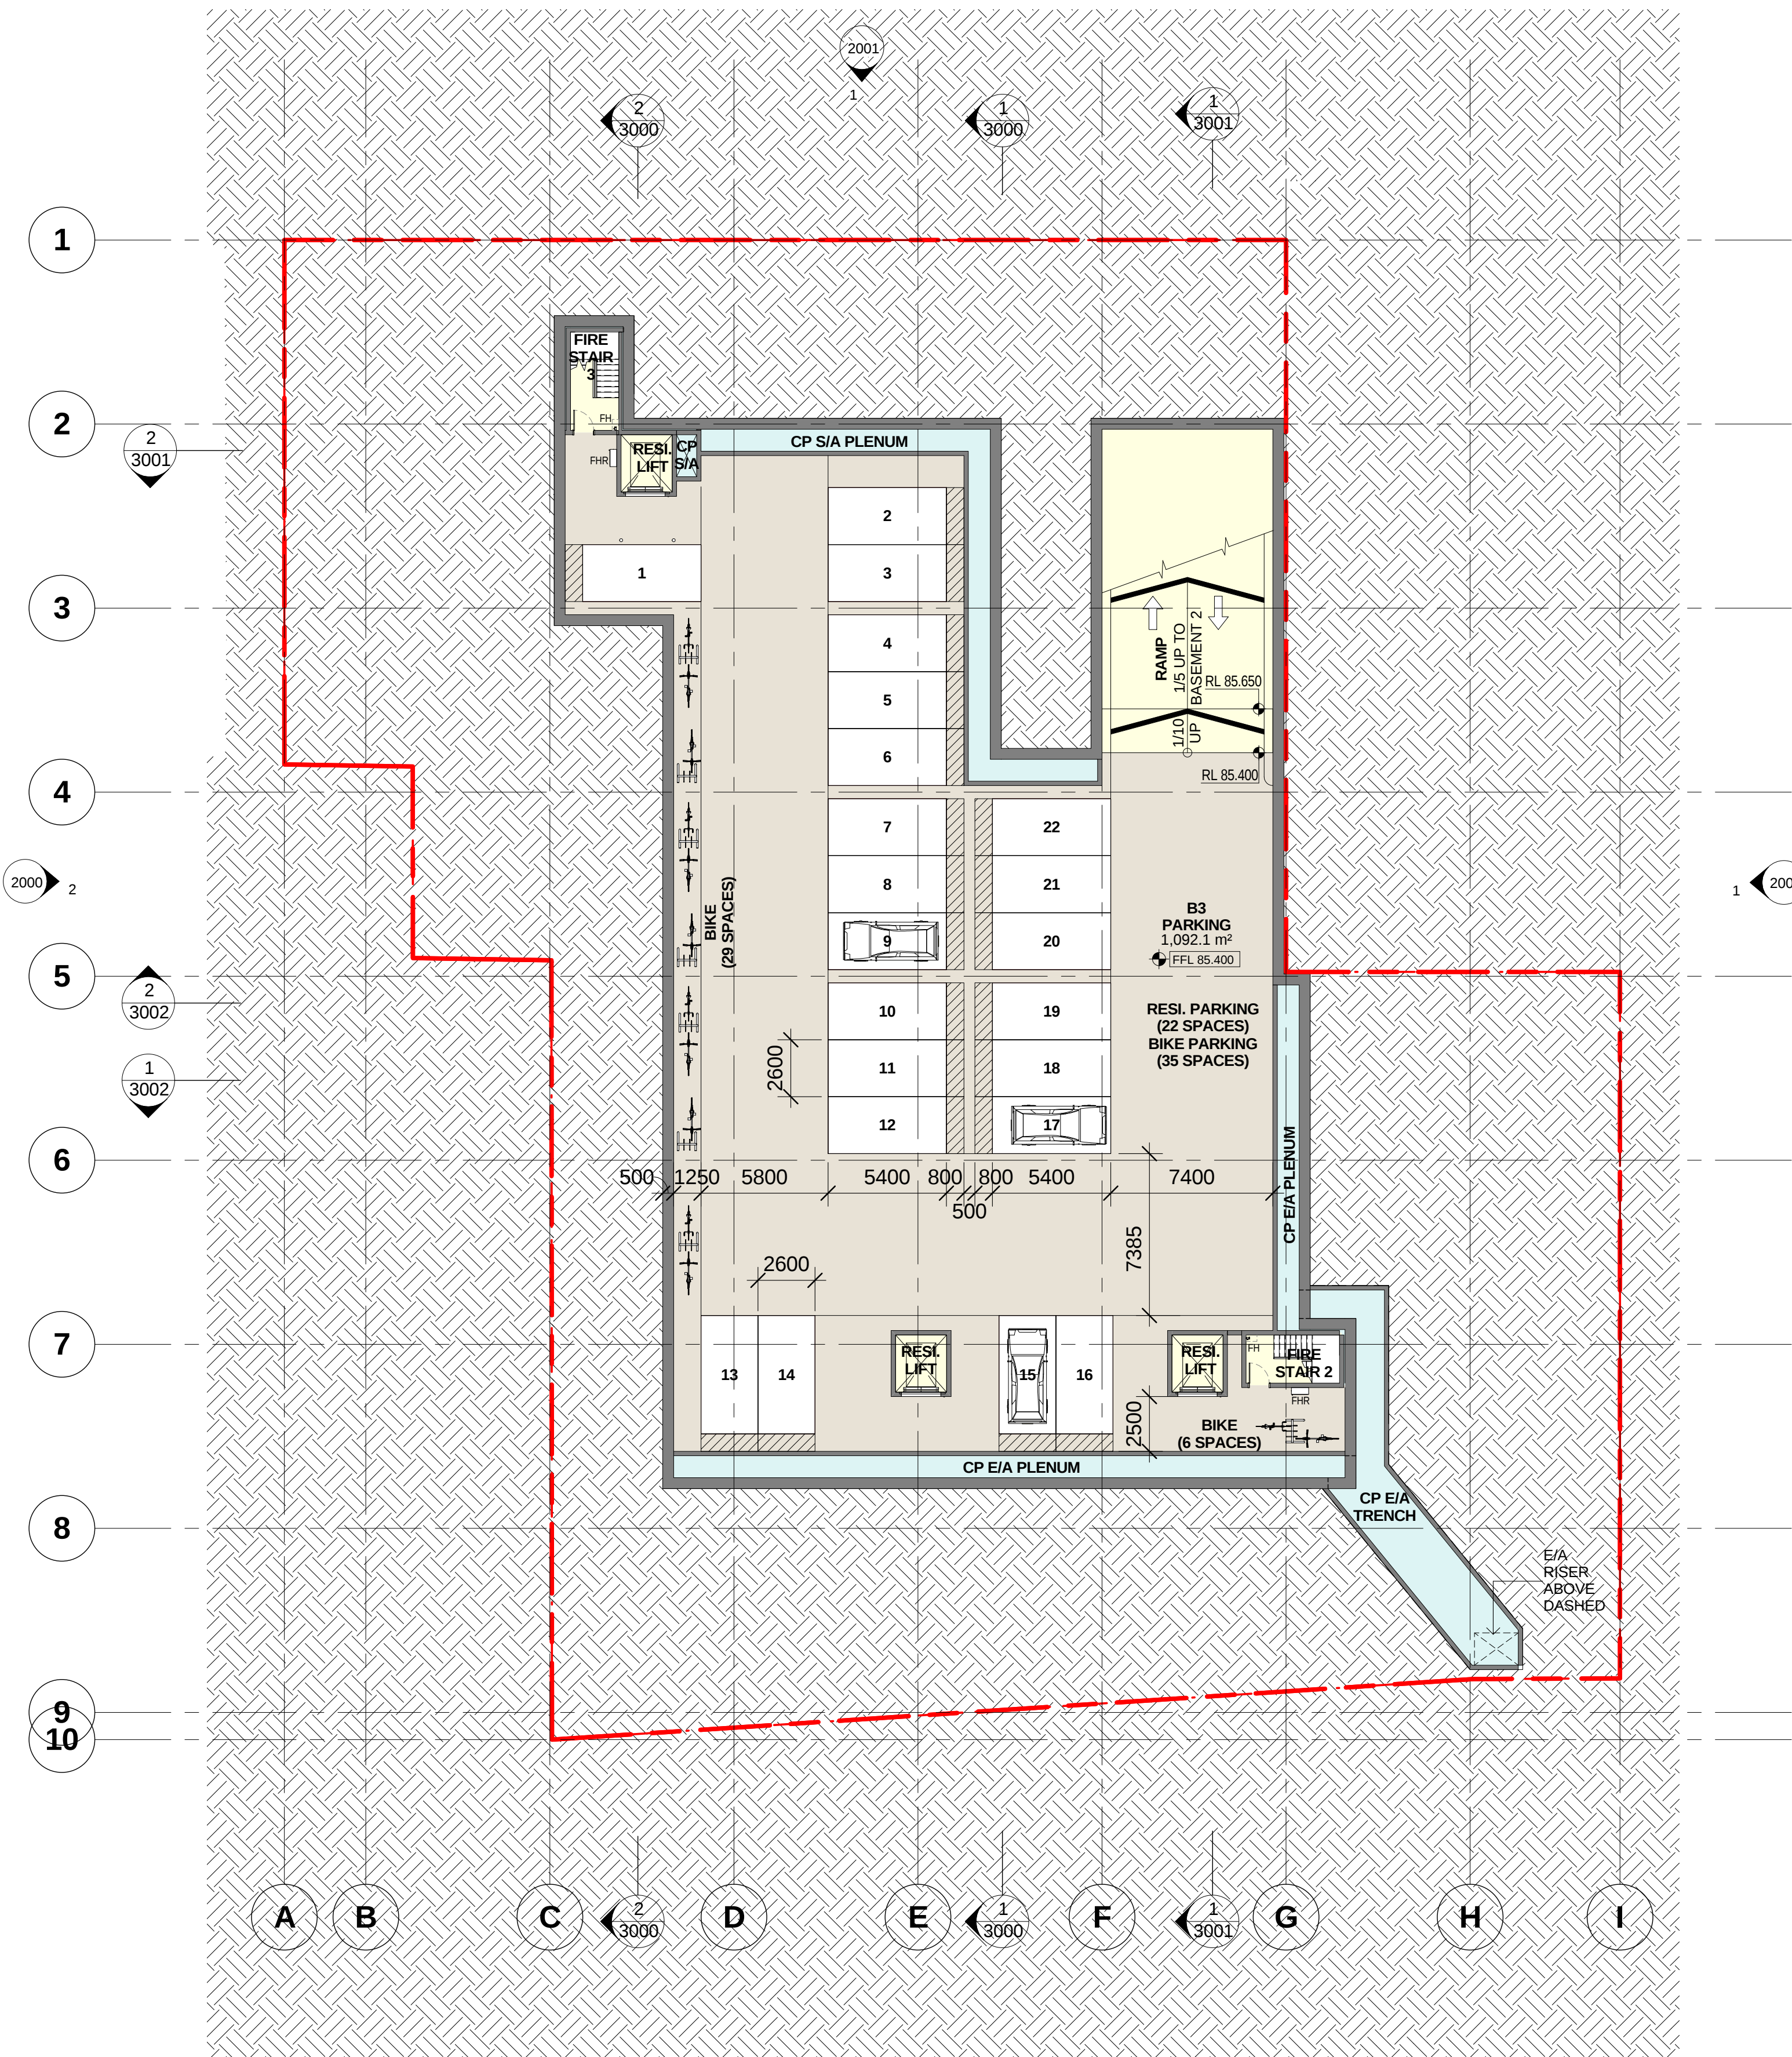

COLOR FILL LEGEND

- | | | | | |
|------------------|---------------------------|-------------|-------------|-------------------------|
| AMENITY | GARBAGE | MECH. RISER | RESIDENT(A) | SERVICE ZONE |
| CIRCULATION | HORIZONTAL TRANSPORTATION | PARKING | RESIDENT(B) | TANKS |
| ELECTRICAL RISER | HYD/FIRE RISER | PUBLIC AREA | RETAIL | VERTICAL TRANSPORTATION |

1 BASEMENT 3
1000 SCALE 1 : 200

Parking Schedule By Levels	
Parking Type	Level

BASEMENT 3	
Resident Parking Spaces: 2600x5400	BASEMENT 3
22	
BASEMENT 3: 22	
BASEMENT 2	
Resident Parking Spaces: 2600x5400	BASEMENT 2
55	
Resident Parking Spaces: 2600x5400 (Accessible)	BASEMENT 2
4	
BASEMENT 2: 59	
BASEMENT 1	
Resident Parking Spaces(Visitor): 2600x5400	BASEMENT 1
11	
Resident Parking Spaces(Visitor): 2600x5400 (Accessible)	BASEMENT 1
1	
Resident Parking Spaces: 2600x5400	BASEMENT 1
37	
Retail Parking Spaces (Staff): 2600x5400 (Staff)	BASEMENT 1
10	
BASEMENT 1: 59	
LOWER GROUND	
Retail Parking Spaces: 2600x5400	LOWER GROUND
42	
Retail Parking Spaces: 2600x5400 (Accessible)	LOWER GROUND
2	
LOWER GROUND: 44	
Grand total: 184	

Parking Space Schedule	
Parking Spaces	Count

Resident Parking Spaces	118
118 (B1 / B2 / B3)	
Resident Parking Spaces(Visitor)	12
12 (B1)	
Retail Parking Spaces	44
44 (Lower Ground)	
Retail Parking Spaces (Staff)	10
10 (B1)	
Grand total: 184	

Notes
All dimensions and setbacks to be verified prior to commencement, omissions or discrepancies to be notified to the architect.

Copyright
The copyright of this drawing together with any other documents prepared by crone partners architecture studios. pty ltd (cp) remains the property of cp. crone partners grants licence for the use of this document for the purpose for which they are intended. The licence is not transferable without the permission of cp.

Quality Assurance System

Authorised By: _____ Date: _____

Rev	DESCRIPTION	By	Date
A	ISSUED FOR SECTION 75W SUBMISSION	MQ	20/11/2012
B	ISSUED FOR PREFERRED PROJECT REPORT SUBMISSION	MQ	20/05/2013

Builder

Client
ANKA (CIVIC CENTER) PTY LTD
LEVEL 3
179-191 NEW SOUTH HEAD RD
EDGECLIFF, SYDNEY NSW 2027
Ph: +61 2 9302 3000
Fax: +61 2 9302 3030

Structural Engineer
AECOM
Level 21, 420 George St, Sydney NSW 2000
Ph: 02 8934 0000 Fax: 02 8934 0001

Mechanical Engineer
WOOD & GRIEVE ENGINEERS
Level 454, 456 Pacific Highway,
St. Leonards, NSW 2000
Ph: 02 8484 7000 Fax: 02 8484 7100

Electrical Engineer
WOOD & GRIEVE ENGINEERS
Level 454, 456 Pacific Highway,
St. Leonards, NSW 2000
Ph: 02 8484 7000 Fax: 02 8484 7100

Hydraulic Engineer
INSYNC SERVICES
Suite 8, Level 2, 56 Church Ave,
Mascot, NSW 2015
Ph: 02 9669 4311 Fax: 02 9669 4322

Landscape Architect
ASPECT Studios
Studio G1 - Level 6, 61 Marlborough St
Surry Hills, NSW 2010
Ph: 02 9699 7182 Fax: 02 9699 7192

KEY

Scale 1 : 200 @A1

cronepartners
Cronepartners
level 2, 364 Kent street,
sydney, nsw 2000, australia
Ph: +61 2 8295 5300
Fax: +61 2 8295 5301

Project
LINDFIELD MIXED-USE DEVELOPMENT
23-37 LINDFIELD AVE & 11 HAVILAH LA
LINDFIELD NSW 2070


Drawn: MQ	Checked: VD	Date: 20/05/2013
-----------	-------------	------------------

Drawing Title
BASEMENT 3 PLAN

PREFERRED PROJECT SUBMISSION

CA 2924 Project no.	ADAZ Drawing Phase.	1000 Drawing No.	B Rev
-------------------------------	-------------------------------	----------------------------	-----------------

PREFERRED PROJECT REPORT SUBMISSION

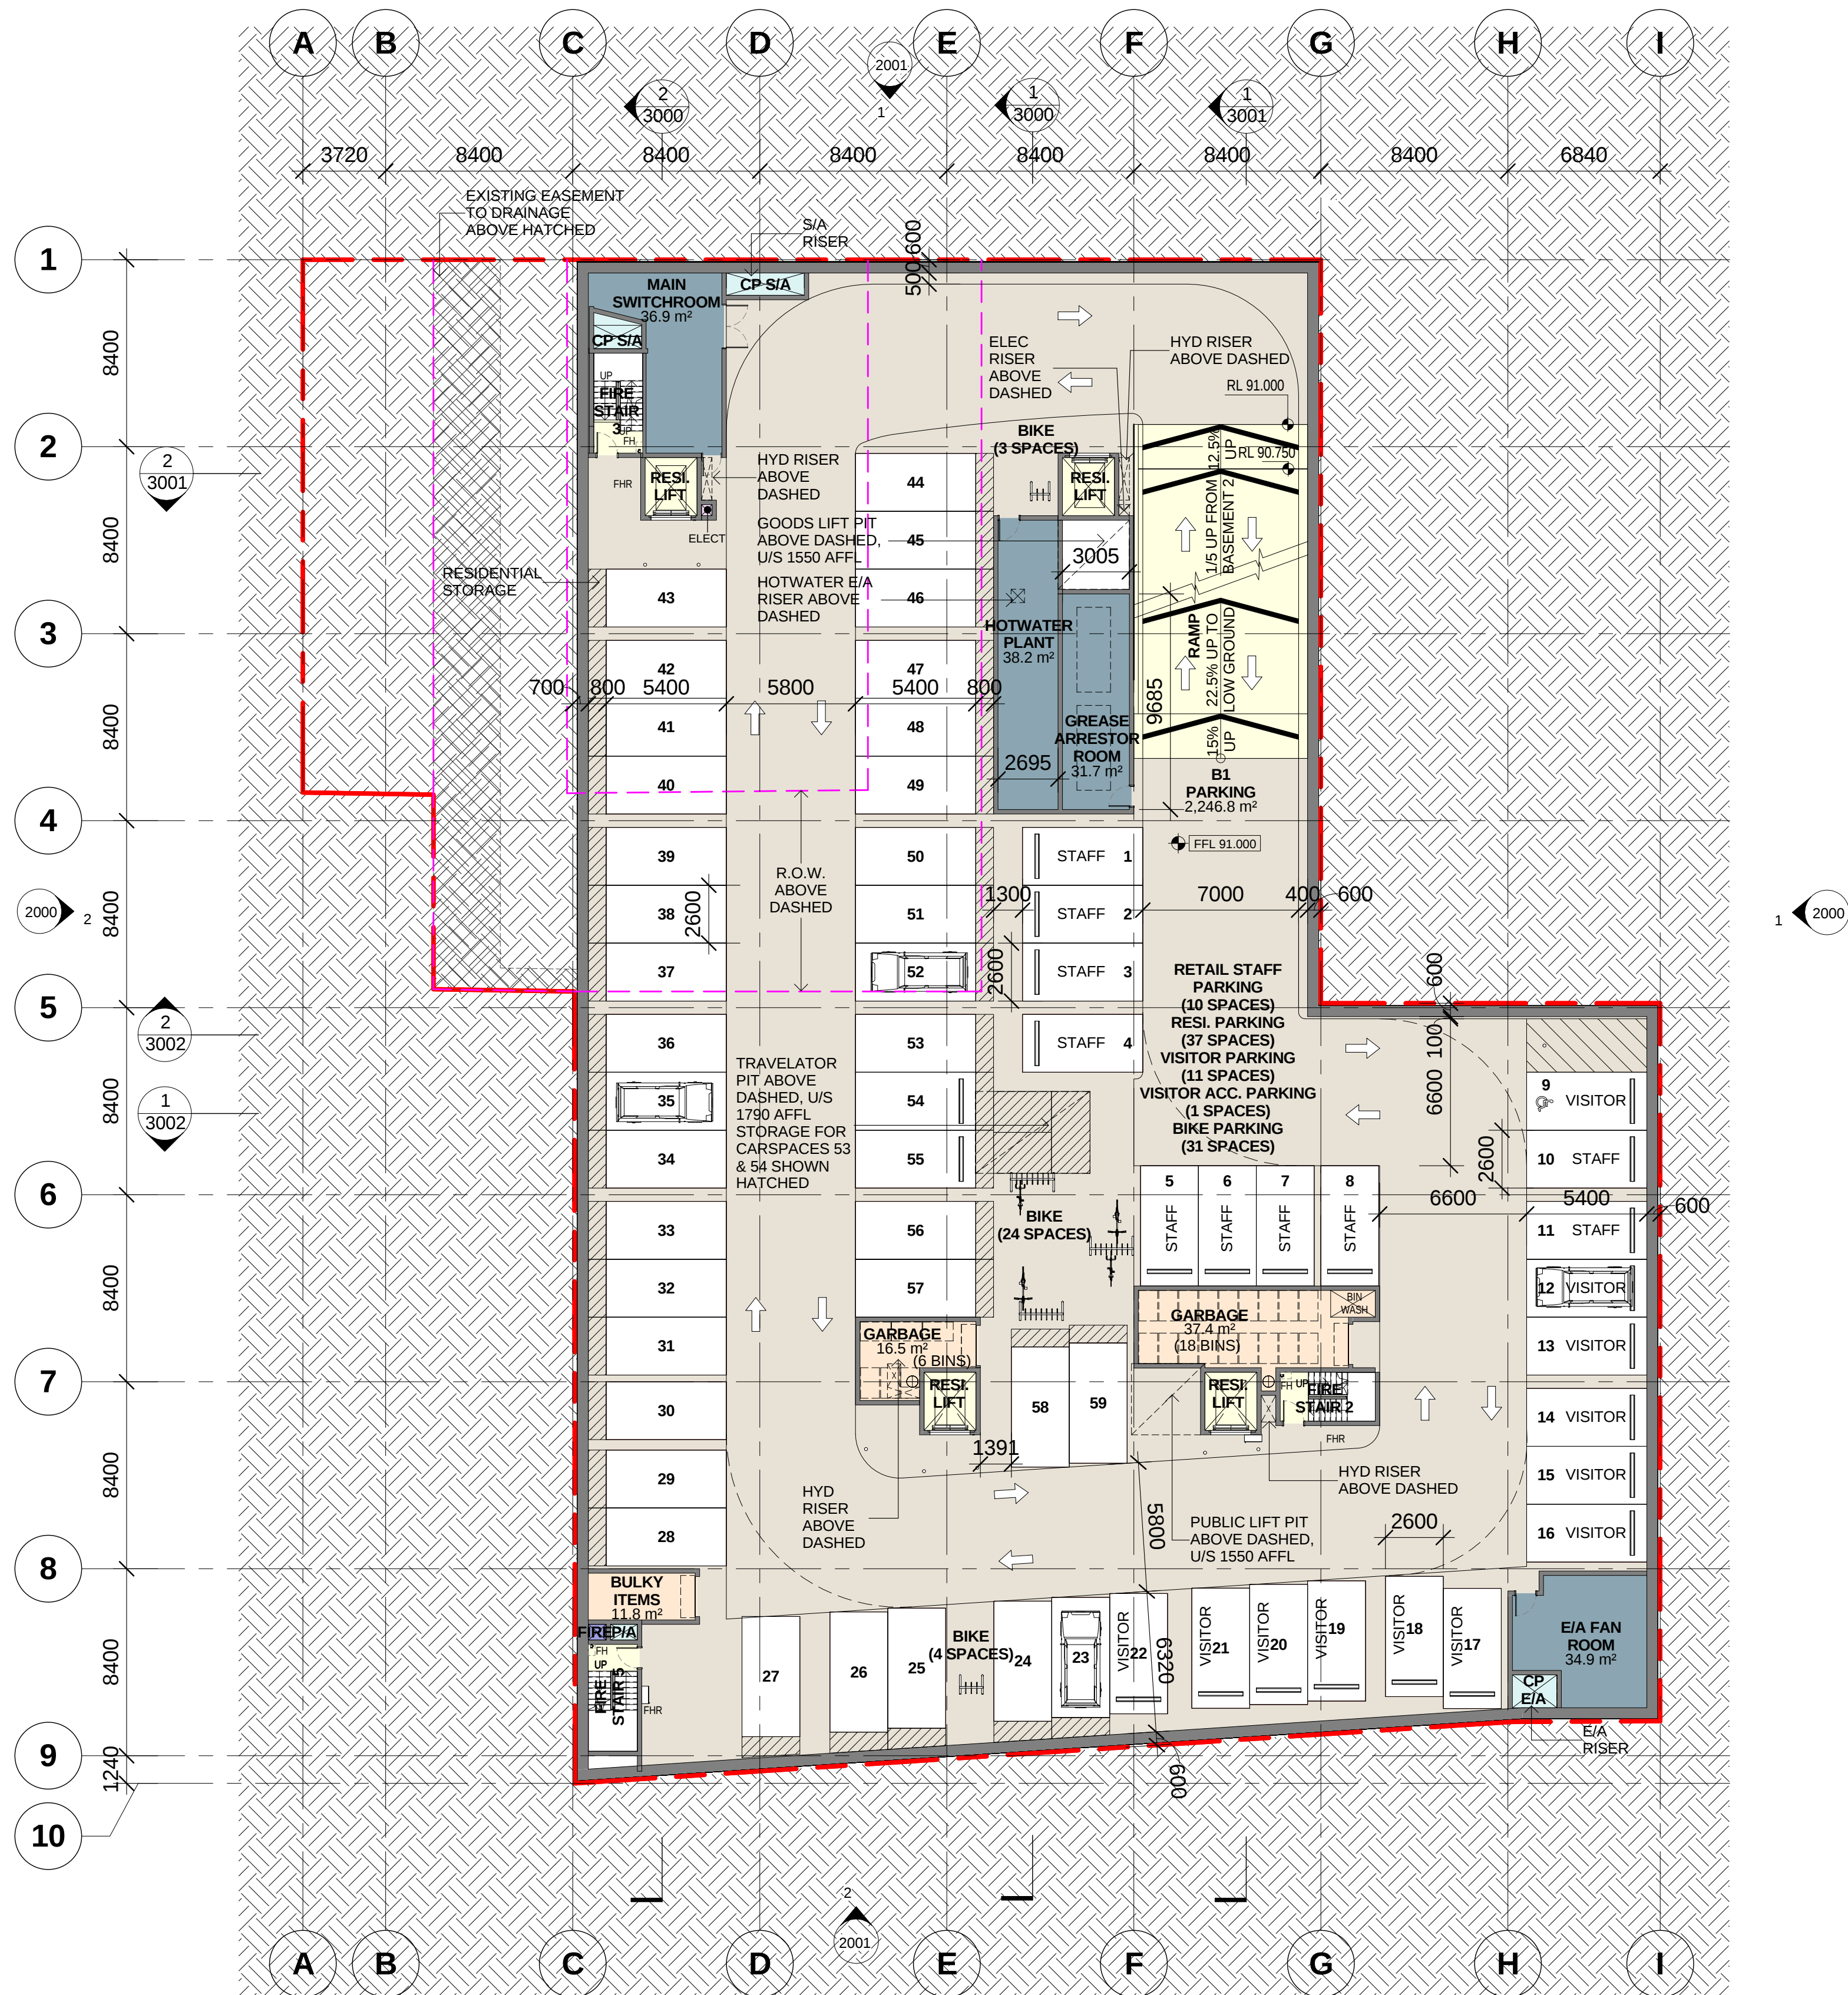

COLOR FILL LEGEND

- AMENITY

CIRCULATION

ELECTRICAL RISER
- GARBAGE

HORIZONTAL TRANSPORTATION

HYD/FIRE RISER
- MECH. RISER

PARKING

PUBLIC AREA
- RESIDENT(A)

RESIDENT(B)

RETAIL
- SERVICE ZONE

TANKS

VERTICAL TRANSPORTATION

1 BASEMENT 1
1002 SCALE 1 : 200

Parking Schedule By Levels	
Parking Type	Level

BASEMENT 3	
Resident Parking Spaces: 2600x5400	BASEMENT 3
22	
BASEMENT 3: 22	
BASEMENT 2	
Resident Parking Spaces: 2600x5400	BASEMENT 2
55	
Resident Parking Spaces: 2600x5400 (Accessible)	BASEMENT 2
4	
BASEMENT 2: 59	
BASEMENT 1	
Resident Parking Spaces(Visitor): 2600x5400	BASEMENT 1
11	
Resident Parking Spaces(Visitor): 2600x5400 (Accessible)	BASEMENT 1
1	
Resident Parking Spaces: 2600x5400	BASEMENT 1
37	
Retail Parking Spaces (Staff): 2600x5400 (Staff)	BASEMENT 1
10	
BASEMENT 1: 59	
LOWER GROUND	
Retail Parking Spaces: 2600x5400	LOWER GROUND
42	
Retail Parking Spaces: 2600x5400 (Accessible)	LOWER GROUND
2	
LOWER GROUND: 44	
Grand total: 184	

Parking Space Schedule	
Parking Spaces	Count

Resident Parking Spaces	118
118 (B1 / B2 / B3)	
Resident Parking Spaces(Visitor)	12
12 (B1)	
Retail Parking Spaces	44
44 (Lower Ground)	
Retail Parking Spaces (Staff)	10
10 (B1)	
Grand total: 184	

Notes

All dimensions and setbacks to be verified prior to commencement, omissions or discrepancies to be notified to the architect.

Copyright

The copyright of this drawing together with any other documents prepared by crone partners architecture studios. pty ltd (cp) remains the property of cp. crone partners grants licence for the use of this document for the purpose for which they are intended. The licence is not transferable without the permission of cp.

Quality Assurance System

Authorised By: _____ Date: _____

Rev	DESCRIPTION	By	Date
A	ISSUED FOR SECTION 75W SUBMISSION	MQ	20/11/2012
B	ISSUED FOR PREFERRED PROJECT REPORT SUBMISSION	MQ	20/05/2013

Builder

Client
ANKA (CIVIC CENTER) PTY LTD
LEVEL 3
179-191 NEW SOUTH HEAD RD
EDGECLIFF, SYDNEY NSW 2027
Ph: +61 2 9302 3000
Fax: +61 2 9302 3030

Structural Engineer
AECOM
Level 21, 420 George St, Sydney NSW 2000
Ph: 02 8934 0000 Fax: 02 8934 0001

Mechanical Engineer
WOOD & GRIEVE ENGINEERS
Level 3, 454 - 456 Pacific Highway,
St. Leonards, NSW 2000
Ph: 02 9484 7000 Fax: 02 9484 7100

Electrical Engineer
WOOD & GRIEVE ENGINEERS
Level 3, 454 - 456 Pacific Highway,
St. Leonards, NSW 2000
Ph: 02 9484 7000 Fax: 02 9484 7100

Hydraulic Engineer
INSYNC SERVICES
Suite 8, Level 2, 56 Church Ave.
Mascot, NSW 2015
Ph: 02 9669 4311 Fax: 02 9669 4322

Landscape Architect
ASPECT Studios
Studio 61 - Level 6, 61 Marlborough St
Surry Hills, NSW 2010
Ph: 02 9699 7182 Fax: 02 9699 7192

KEY

Scale 1 : 200 @A1

cronepartners

Cronepartners
level 2, 364 Kent street,
sydney, nsw 2000, australia
Ph: +61 2 8295 5300
Fax: +61 2 8295 5301

Project
LINDFIELD MIXED-USE DEVELOPMENT
23-37 LINDFIELD AVE & 11 HAVILAH LA
LINDFIELD NSW 2070


Drawn: MQ Checked: VD Date: 20/05/2013

Drawing Title
BASEMENT 1 PLAN

PREFERRED PROJECT SUBMISSION

CA 2924	ADAZ	1002	B
Project no.	Drawing Phase.	Drawing No.	Rev

PREFERRED PROJECT REPORT SUBMISSION

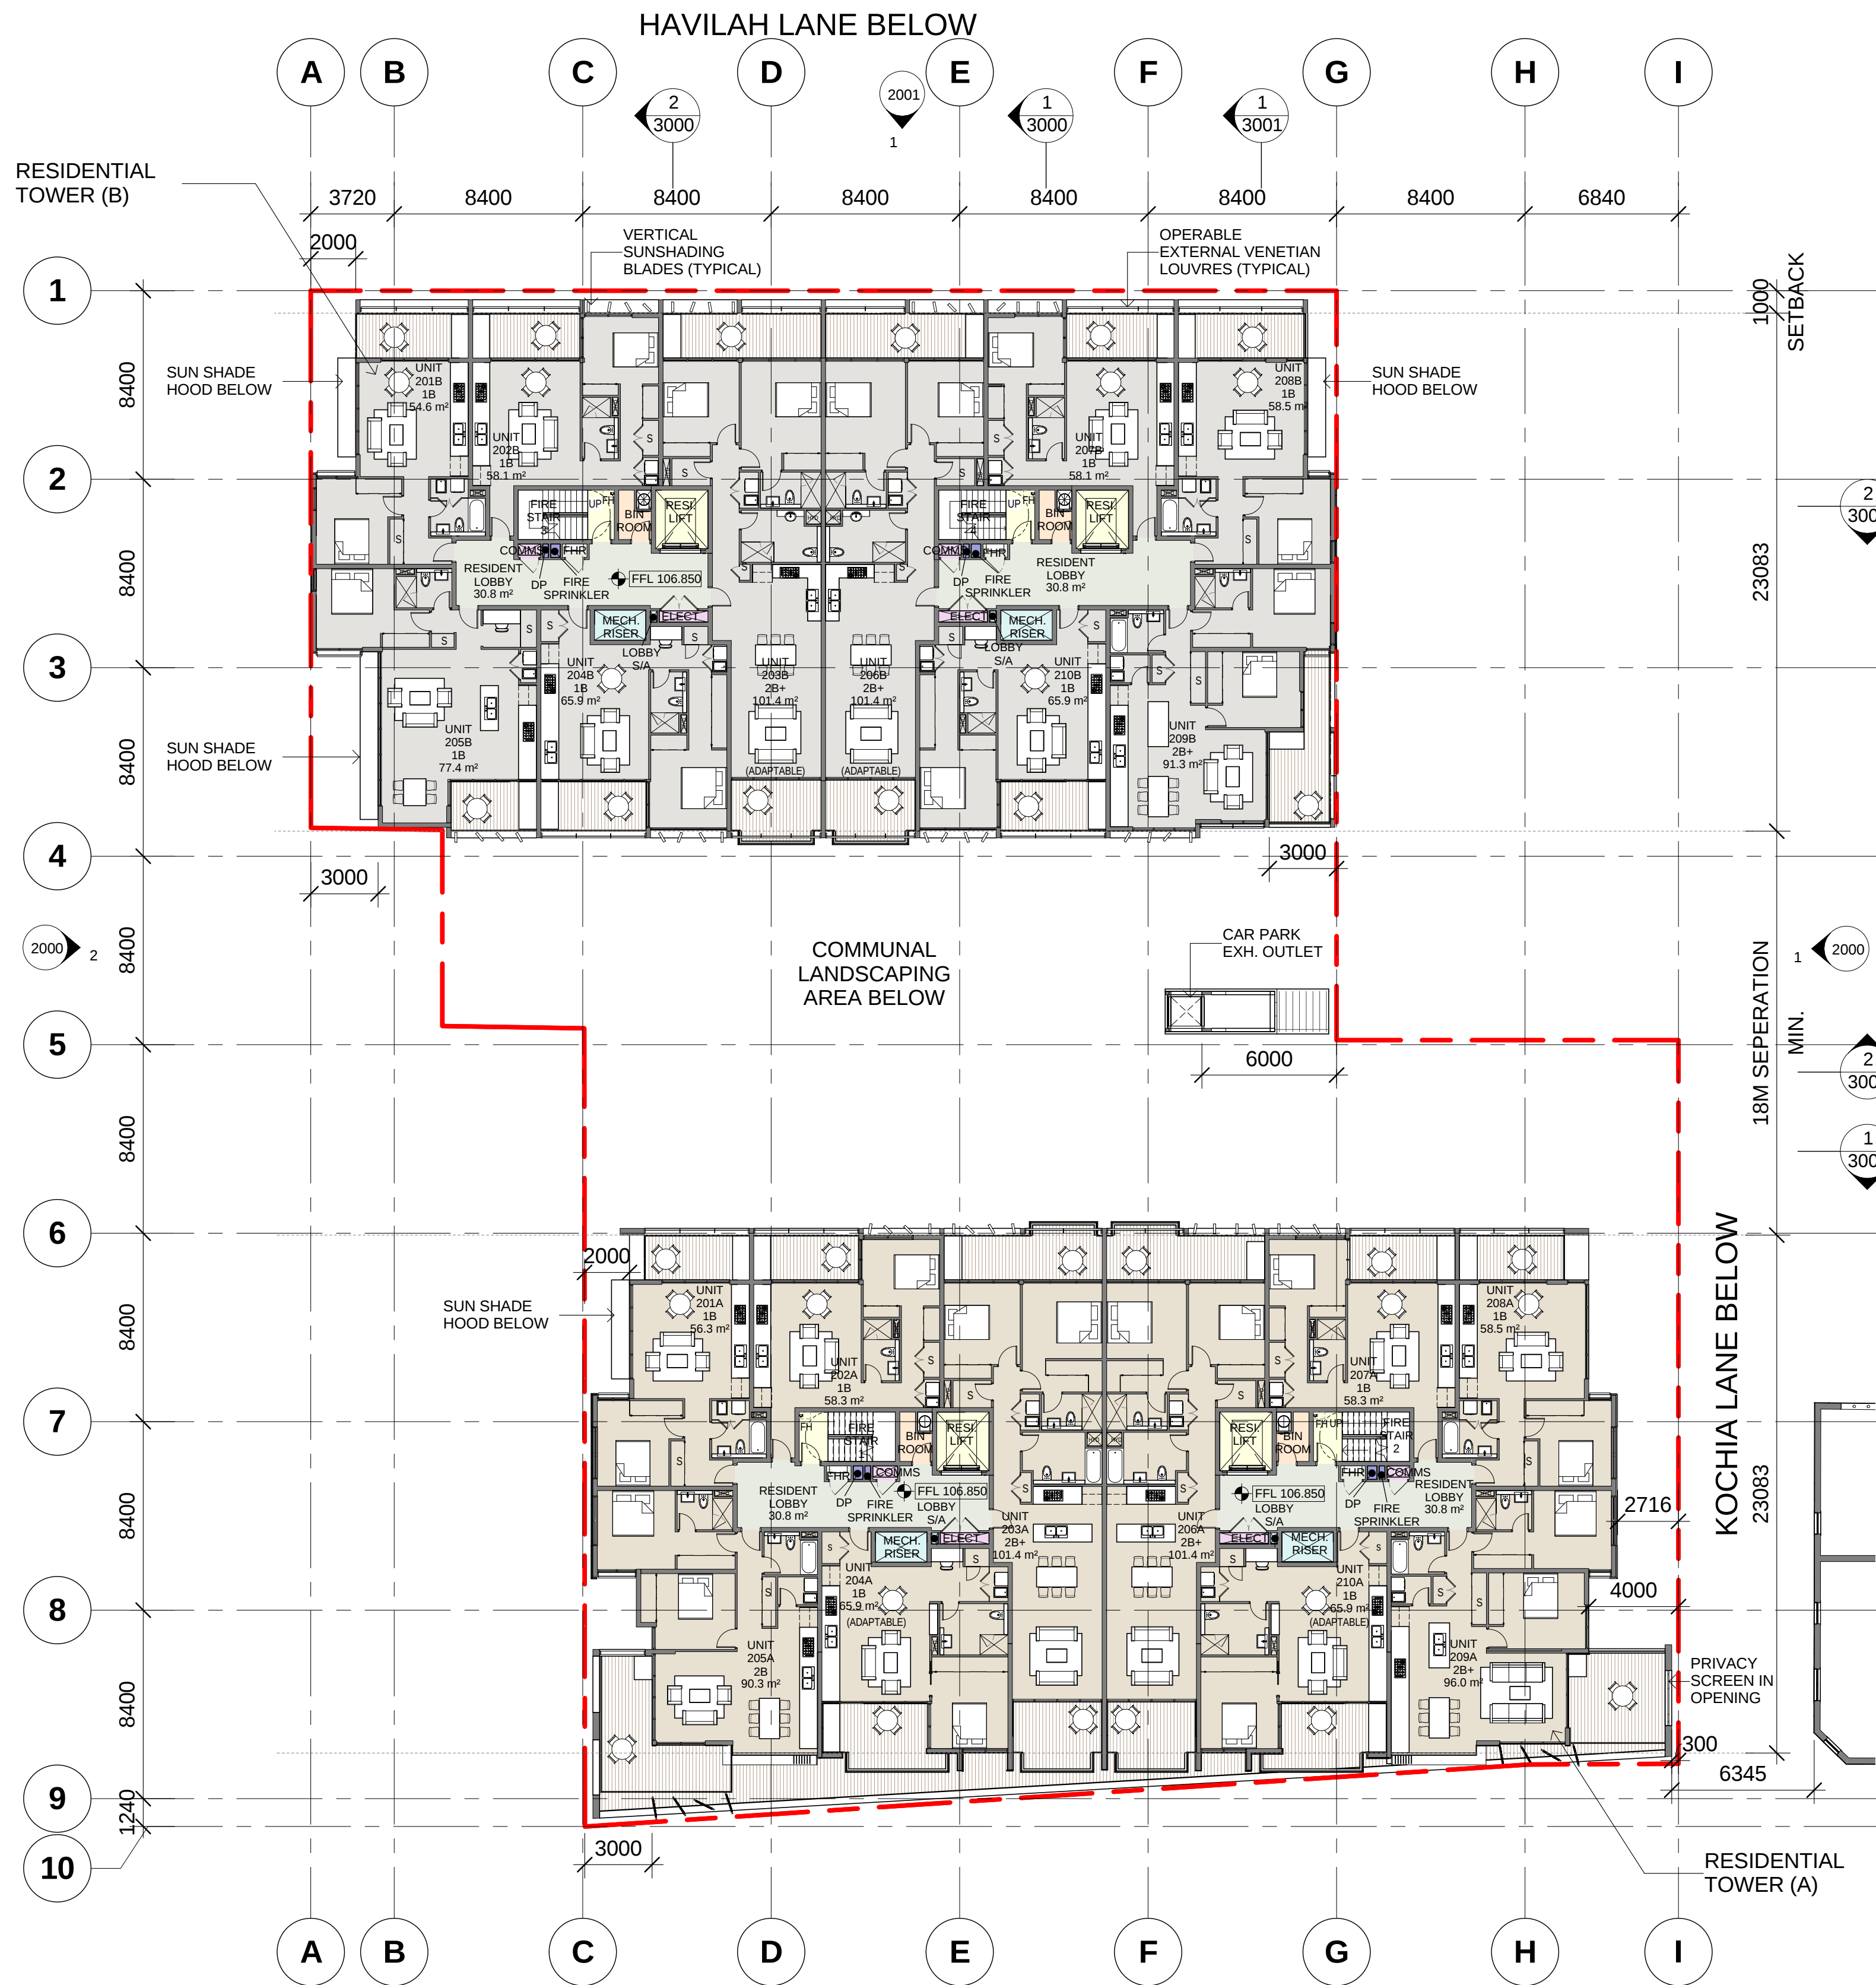

COLOR FILL LEGEND

- AMENITY
- CIRCULATION
- ELECTRICAL RISER
- GARBAGE
- HORIZONTAL TRANSPORTATION
- HYD/FIRE RISER
- MECH. RISER
- PARKING
- RESIDENT(A)
- RESIDENT(B)
- RETAIL
- SERVICE ZONE
- TANKS
- VERTICAL TRANSPORTATION

Notes
All dimensions and setbacks to be verified prior to commencement, omissions or discrepancies to be notified to the architect.

Copyright
The copyright of this drawing together with any other documents prepared by crone partners architecture studios. pty ltd (cp) remains the property of cp. crone partners grants licence for the use of this document for the purpose for which they are intended. The licence is not transferable without the permission of cp.

Quality Assurance System

Authorised By:	Date:		
Rev	DESCRIPTION	By	Date
A	ISSUED FOR SECTION 75W SUBMISSION	MQ	20/11/2012
B	ISSUED FOR PREFERRED PROJECT REPORT SUBMISSION	MQ	20/05/2013

Builder

Client
ANKA (CIVIC CENTER) PTY LTD
LEVEL 3
179-191 NEW SOUTH HEAD RD
EDGECLIFF, SYDNEY NSW 2027
Ph: +61 2 9302 3000
Fax: +61 2 9302 3030

Structural Engineer
AECOM
Level 21, 420 George St, Sydney NSW 2000
Ph: 02 8934 0000 Fax: 02 8934 0001

Mechanical Engineer
WOOD & GRIEVE ENGINEERS
Level 454, 456 Pacific Highway,
St. Leonards, NSW 2000
Ph: 02 8484 7000 Fax: 02 8484 7100

Electrical Engineer
WOOD & GRIEVE ENGINEERS
Level 454, 456 Pacific Highway,
St. Leonards, NSW 2000
Ph: 02 8484 7000 Fax: 02 8484 7100

Hydraulic Engineer
INSYNC SERVICES
Suite 8, Level 2, 56 Church Ave.
Mascot, NSW 2015
Ph: 02 9669 4311 Fax: 02 9669 4322

Landscape Architect
ASPECT Studios
Studio G1 - Level 6, 61 Marlborough St
Surry Hills, NSW 2010
Ph: 02 9699 7182 Fax: 02 9699 7192

KEY

Scale 1 : 200 @A1

cronepartners
Cronepartners
level 2, 364 kent street,
sydney, nsw 2000, australia
Ph: +61 2 8295 5300
Fax: +61 2 8295 5301

Project
LINDFIELD MIXED-USE DEVELOPMENT
23-37 LINDFIELD AVE & 11 HAVILAH LA
LINDFIELD NSW 2070

Drawn: MQ	Checked: VD	Date: 20/05/2013
Drawing Title LEVEL 2 FLOOR PLAN		

PREFERRED PROJECT SUBMISSION

CA 2924	ADAZ	1006	B
Project no.	Drawing Phase.	Drawing No.	Rev

PREFERRED PROJECT REPORT SUBMISSION



COLOR FILL LEGEND

- AMENITY
- CIRCULATION
- ELECTRICAL RISER
- GARBAGE
- HORIZONTAL TRANSPORTATION
- HYD/FIRE RISER
- MECH. RISER
- PARKING
- PUBLIC AREA
- RESIDENT(A)
- RESIDENT(B)
- RETAIL
- SERVICE ZONE
- TANKS
- VERTICAL TRANSPORTATION

Notes
All dimensions and setbacks to be verified prior to commencement, omissions or discrepancies to be notified to the architect.

Copyright
The copyright of this drawing together with any other documents prepared by crone partners architecture studios. pty ltd (cp) remains the property of cp. crone partners grants licence for the use of this document for the purpose for which they are intended. The licence is not transferable without the permission of cp.

Quality Assurance System

Authorised By: _____ Date: _____

Rev	DESCRIPTION	By	Date
A	ISSUED FOR SECTION 75W SUBMISSION	MQ	20/11/2012
B	ISSUED FOR PREFERRED PROJECT REPORT SUBMISSION	MQ	20/05/2013

Builder

Client
ANKA (CIVIC CENTER) PTY LTD
LEVEL 3
179-191 NEW SOUTH HEAD RD
EDGECLIFF, SYDNEY NSW 2027
Ph: +61 2 9302 3000
Fax: +61 2 9302 3030

Structural Engineer
AECOM
Level 21, 420 George St, Sydney NSW 2000
Ph: 02 8934 0000 Fax: 02 8934 0001

Mechanical Engineer
WOOD & GRIEVE ENGINEERS
Level 454, 456 Pacific Highway,
St. Leonards, NSW 2000
Ph: 02 8484 7000 Fax: 02 8484 7100

Electrical Engineer
WOOD & GRIEVE ENGINEERS
Level 454, 456 Pacific Highway,
St. Leonards, NSW 2000
Ph: 02 8484 7000 Fax: 02 8484 7100

Hydraulic Engineer
INSYNC SERVICES
Suite 8, Level 2, 56 Church Ave.
Mascot, NSW 2015
Ph: 02 9669 4311 Fax: 02 9669 4322

Landscape Architect
ASPECT Studios
Studio G1 - Level 6, 61 Marlborough St
Surry Hills, NSW 2010
Ph: 02 9699 7182 Fax: 02 9699 7192

KEY

Scale 1 : 200 @A1

cronepartners
Cronepartners
level 2, 364 kent street,
sydney, nsw 2000, australia
Ph: +61 2 8295 5300
Fax: +61 2 8295 5301

Project
LINDFIELD MIXED-USE DEVELOPMENT
23-37 LINDFIELD AVE & 11 HAVILAH LA
LINDFIELD NSW 2070


Drawn: MQ	Checked: VD	Date: 20/05/2013
-----------	-------------	------------------

Drawing Title
LEVEL 3 FLOOR PLAN

PREFERRED PROJECT SUBMISSION

CA 2924	ADAZ	1007	B
Project no.	Drawing Phase.	Drawing No.	Rev

PREFERRED PROJECT REPORT SUBMISSION

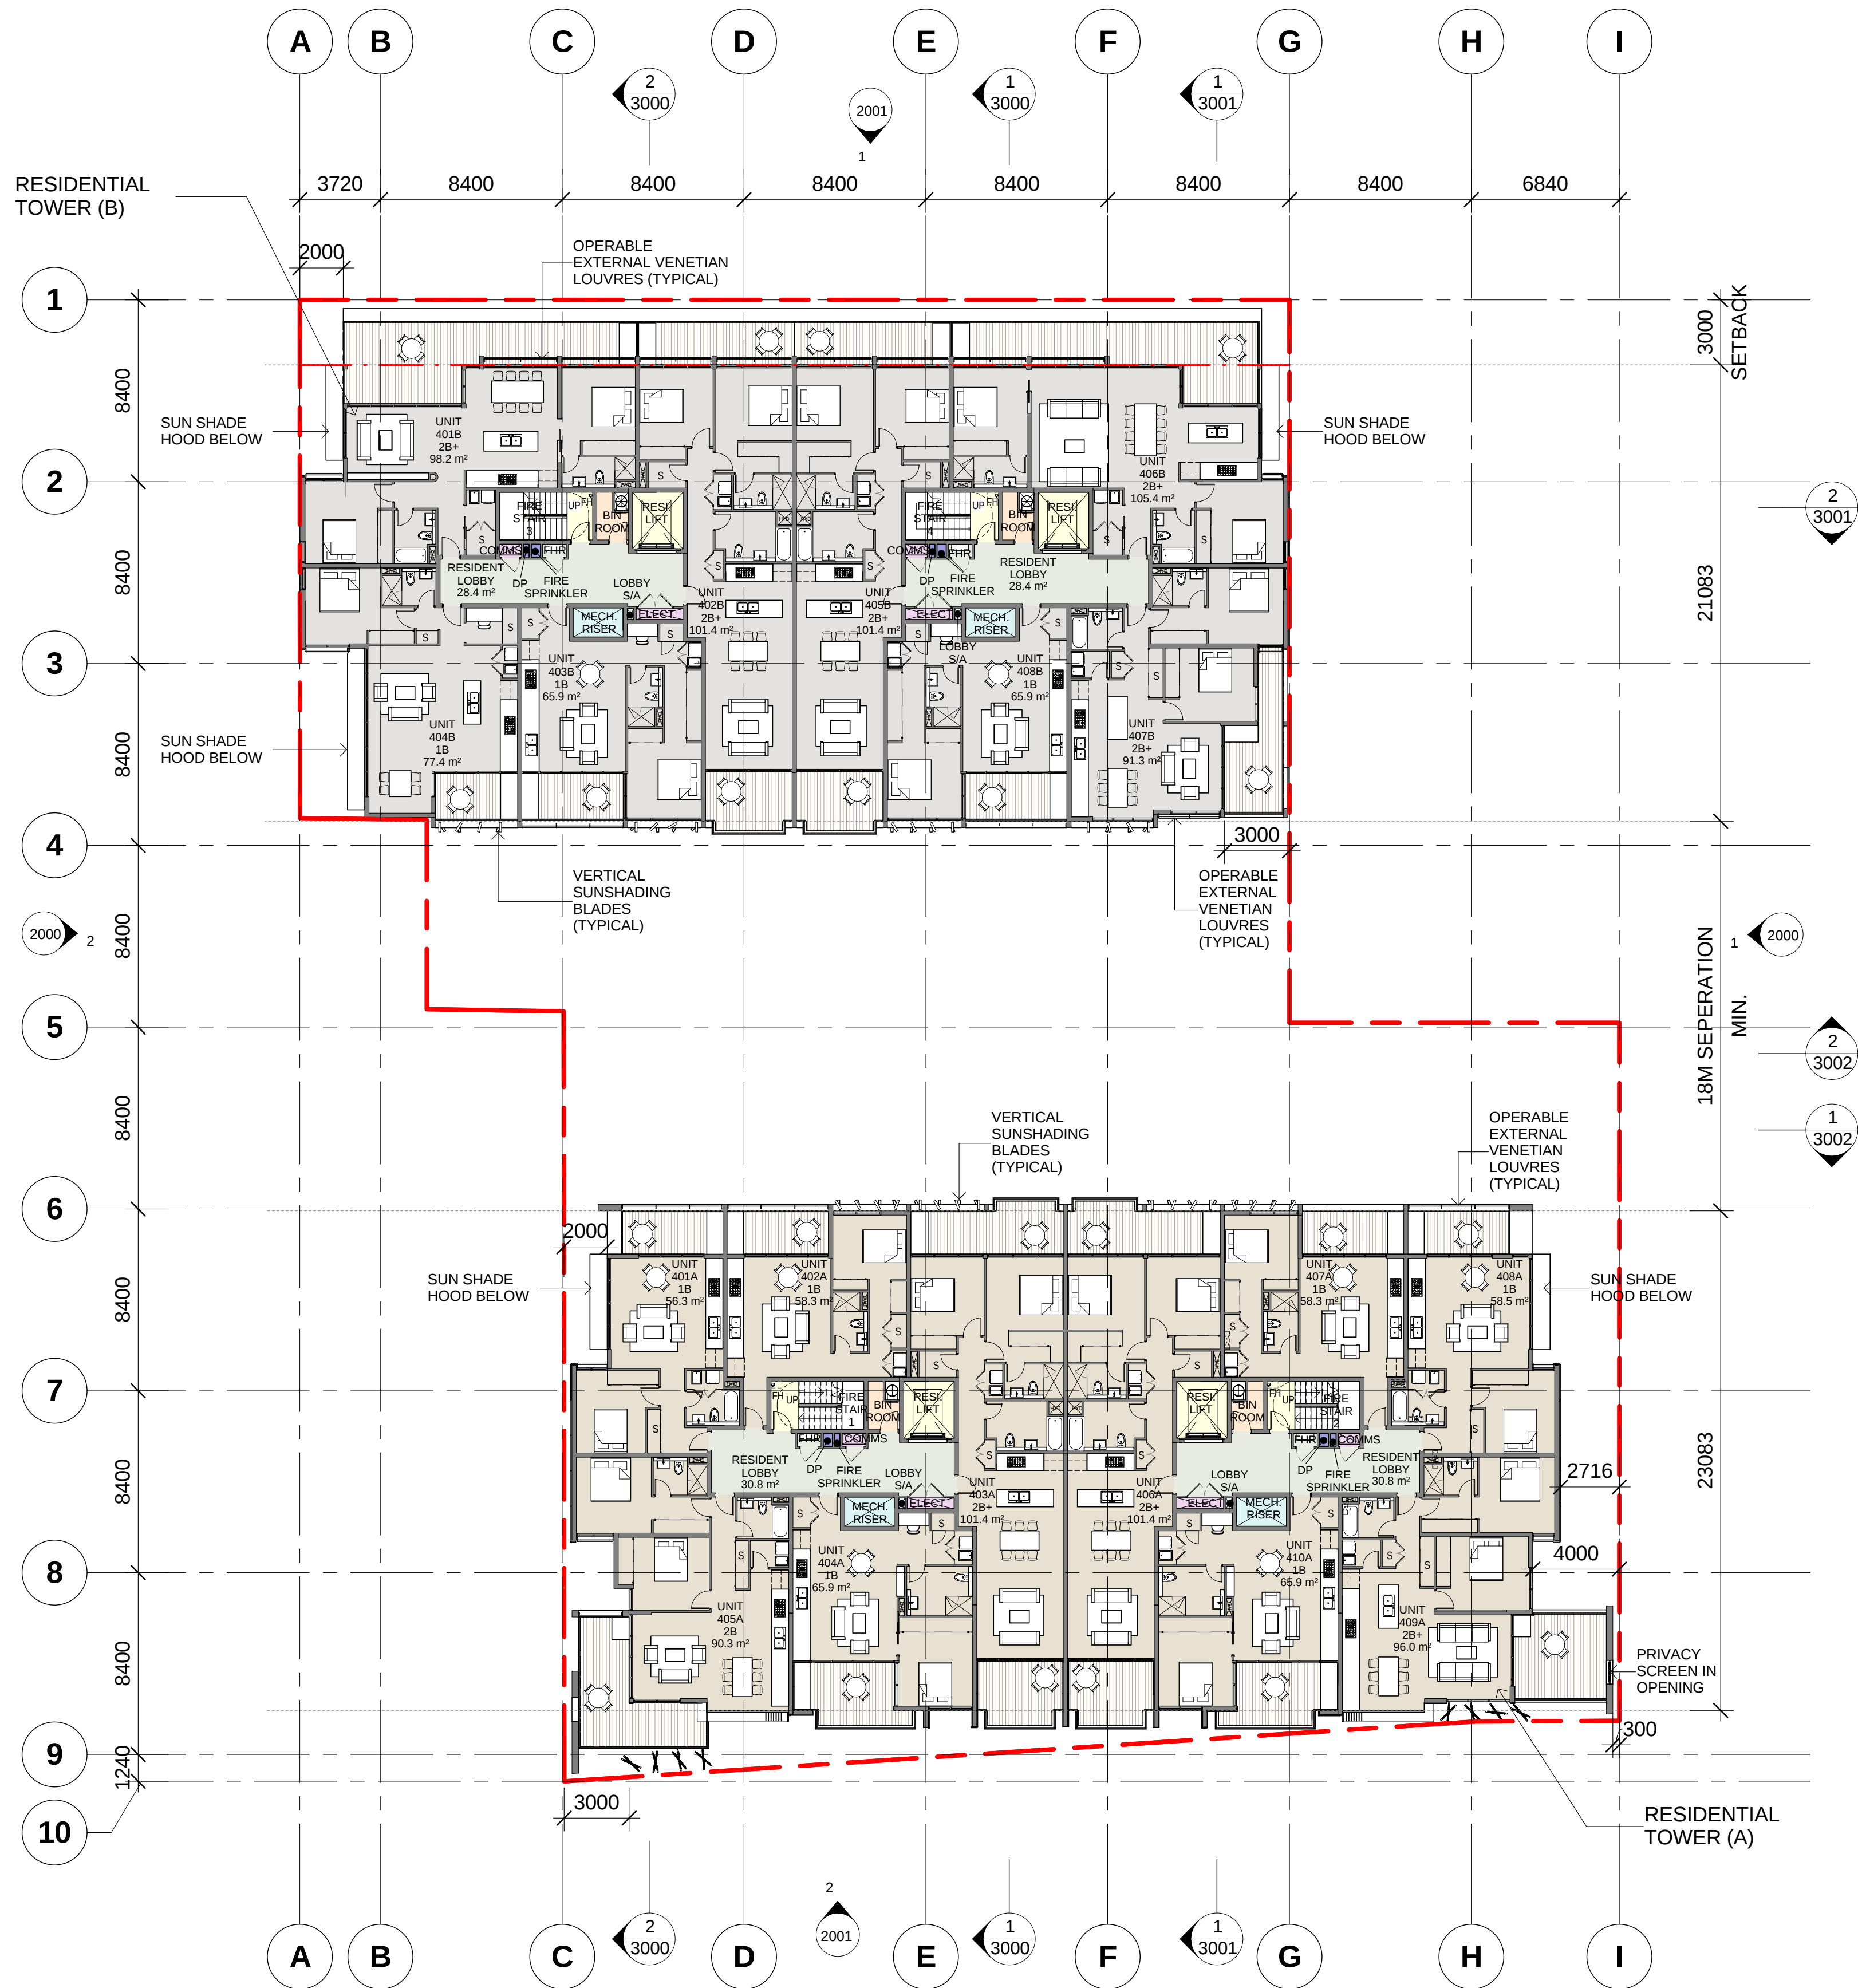

1
1008
LEVEL 4
SCALE 1 : 200

COLOR FILL LEGEND

- AMENITY
- CIRCULATION
- ELECTRICAL RISER
- GARBAGE
- HORIZONTAL TRANSPORTATION
- HYD/FIRE RISER
- MECH. RISER
- PARKING
- PUBLIC AREA
- RESIDENT(A)
- RESIDENT(B)
- RETAIL
- SERVICE ZONE
- TANKS
- VERTICAL TRANSPORTATION

Notes
All dimensions and setbacks to be verified prior to commencement, omissions or discrepancies to be notified to the architect.

Copyright
The copyright of this drawing together with any other documents prepared by crone partners architecture studios. pty ltd (cp) remains the property of cp. crone partners grants licence for the use of this document for the purpose for which they are intended. The licence is not transferable without the permission of cp.

Quality Assurance System

Authorised By: _____ Date: _____

Rev	DESCRIPTION	By	Date
A	ISSUED FOR SECTION 75W SUBMISSION	MQ	20/11/2012
B	ISSUED FOR PREFERRED PROJECT REPORT SUBMISSION	MQ	20/05/2013

Builder

Client
ANKA (CIVIC CENTER) PTY LTD
LEVEL 3
179-191 NEW SOUTH HEAD RD
EDGECLIFF, SYDNEY NSW 2027
Ph: +61 2 9302 3000
Fax: +61 2 9302 3030

Structural Engineer
AECOM
Level 21, 420 George St, Sydney NSW 2000
Ph: 02 8934 0000 Fax: 02 8934 0001

Mechanical Engineer
WOOD & GRIEVE ENGINEERS
Level 454, 456 Pacific Highway,
St. Leonards, NSW 2000
Ph: 02 8484 7000 Fax: 02 8484 7100

Electrical Engineer
WOOD & GRIEVE ENGINEERS
Level 454, 456 Pacific Highway,
St. Leonards, NSW 2000
Ph: 02 8484 7000 Fax: 02 8484 7100

Hydraulic Engineer
INSYNC SERVICES
Suite 8, Level 2, 56 Church Ave.
Mascot, NSW 2015
Ph: 02 9669 4311 Fax: 02 9669 4322

Landscape Architect
ASPECT Studios
Studio G1 - Level 6, 61 Marlborough St
Surry Hills, NSW 2010
Ph: 02 9699 7182 Fax: 02 9699 7192

KEY

Scale 1 : 200 @A1

cronepartners
Cronepartners
level 2, 364 kent street,
sydney, nsw 2000, australia
Ph: +61 2 8295 5300
Fax: +61 2 8295 5301

Project
LINDFIELD MIXED-USE DEVELOPMENT
23-37 LINDFIELD AVE & 11 HAVILAH LA
LINDFIELD NSW 2070

Drawn: MQ	Checked: VD	Date: 20/05/2013
-----------	-------------	------------------

Drawing Title
LEVEL 4 FLOOR PLAN

PREFERRED PROJECT SUBMISSION

CA 2924	ADAZ	1008	B
Project no.	Drawing Phase.	Drawing No.	Rev

PREFERRED PROJECT REPORT SUBMISSION



COLOR FILL LEGEND

- AMENITY
- CIRCULATION
- ELECTRICAL RISER
- GARBAGE
- HORIZONTAL TRANSPORTATION
- HYD/FIRE RISER
- MECH. RISER
- PARKING
- PUBLIC AREA
- RESIDENT(A)
- RESIDENT(B)
- RETAIL
- SERVICE ZONE
- TANKS
- VERTICAL TRANSPORTATION

1 LEVEL 5
1009 SCALE 1 : 200

Notes
All dimensions and setbacks to be verified prior to commencement, omissions or discrepancies to be notified to the architect.
Copyright
The copyright of this drawing together with any other documents prepared by crone partners architecture studios. pty ltd (cp) remains the property of cp. crone partners grants licence for the use of this document for the purpose for which they are intended. The licence is not transferable without the permission of cp.

Quality Assurance System			
Authorised By:		Date:	
Rev	DESCRIPTION	By	Date
A	ISSUED FOR SECTION 75W SUBMISSION	MQ	20/11/2012
B	ISSUED FOR PREFERRED PROJECT REPORT SUBMISSION	MQ	20/05/2013

Builder

Client
ANKA (CIVIC CENTER) PTY LTD
LEVEL 3
179-191 NEW SOUTH HEAD RD
EDGECLIFF, SYDNEY NSW 2027
Ph: +61 2 9302 3000
Fax: +61 2 9302 3030

Structural Engineer
AECOM
Level 21, 420 George St, Sydney NSW 2000
Ph: 02 8934 0000 Fax: 02 8934 0001

Mechanical Engineer
WOOD & GRIEVE ENGINEERS
Level 454, 456 Pacific Highway,
St. Leonards, NSW 2000
Ph: 02 8484 7000 Fax: 02 8484 7100

Electrical Engineer
WOOD & GRIEVE ENGINEERS
Level 454, 456 Pacific Highway,
St. Leonards, NSW 2000
Ph: 02 8484 7000 Fax: 02 8484 7100

Hydraulic Engineer
INSYNC SERVICES
Suite 8, Level 2, 56 Church Ave.
Mascot, NSW 2015
Ph: 02 9669 4311 Fax: 02 9669 4322

Landscape Architect
ASPECT Studios
Studio G1 - Level 6, 61 Marlborough St
Surry Hills, NSW 2010
Ph: 02 9699 7182 Fax: 02 9699 7192

KEY

Scale 1 : 200 @A1

cronepartners
Cronepartners
level 2, 364 kent street,
sydney, nsw 2000, australia
Ph: +61 2 8295 5300
Fax: +61 2 8295 5301


Project
LINDFIELD MIXED-USE DEVELOPMENT
23-37 LINDFIELD AVE & 11 HAVILAH LA
LINDFIELD NSW 2070

Drawn: MQ **Checked: VD** **Date: 20/05/2013**

Drawing Title
LEVEL 5 FLOOR PLAN

PREFERRED PROJECT SUBMISSION			
CA 2924	ADAZ	1009	B
Project no.	Drawing Phase.	Drawing No.	Rev

PREFERRED PROJECT REPORT SUBMISSION

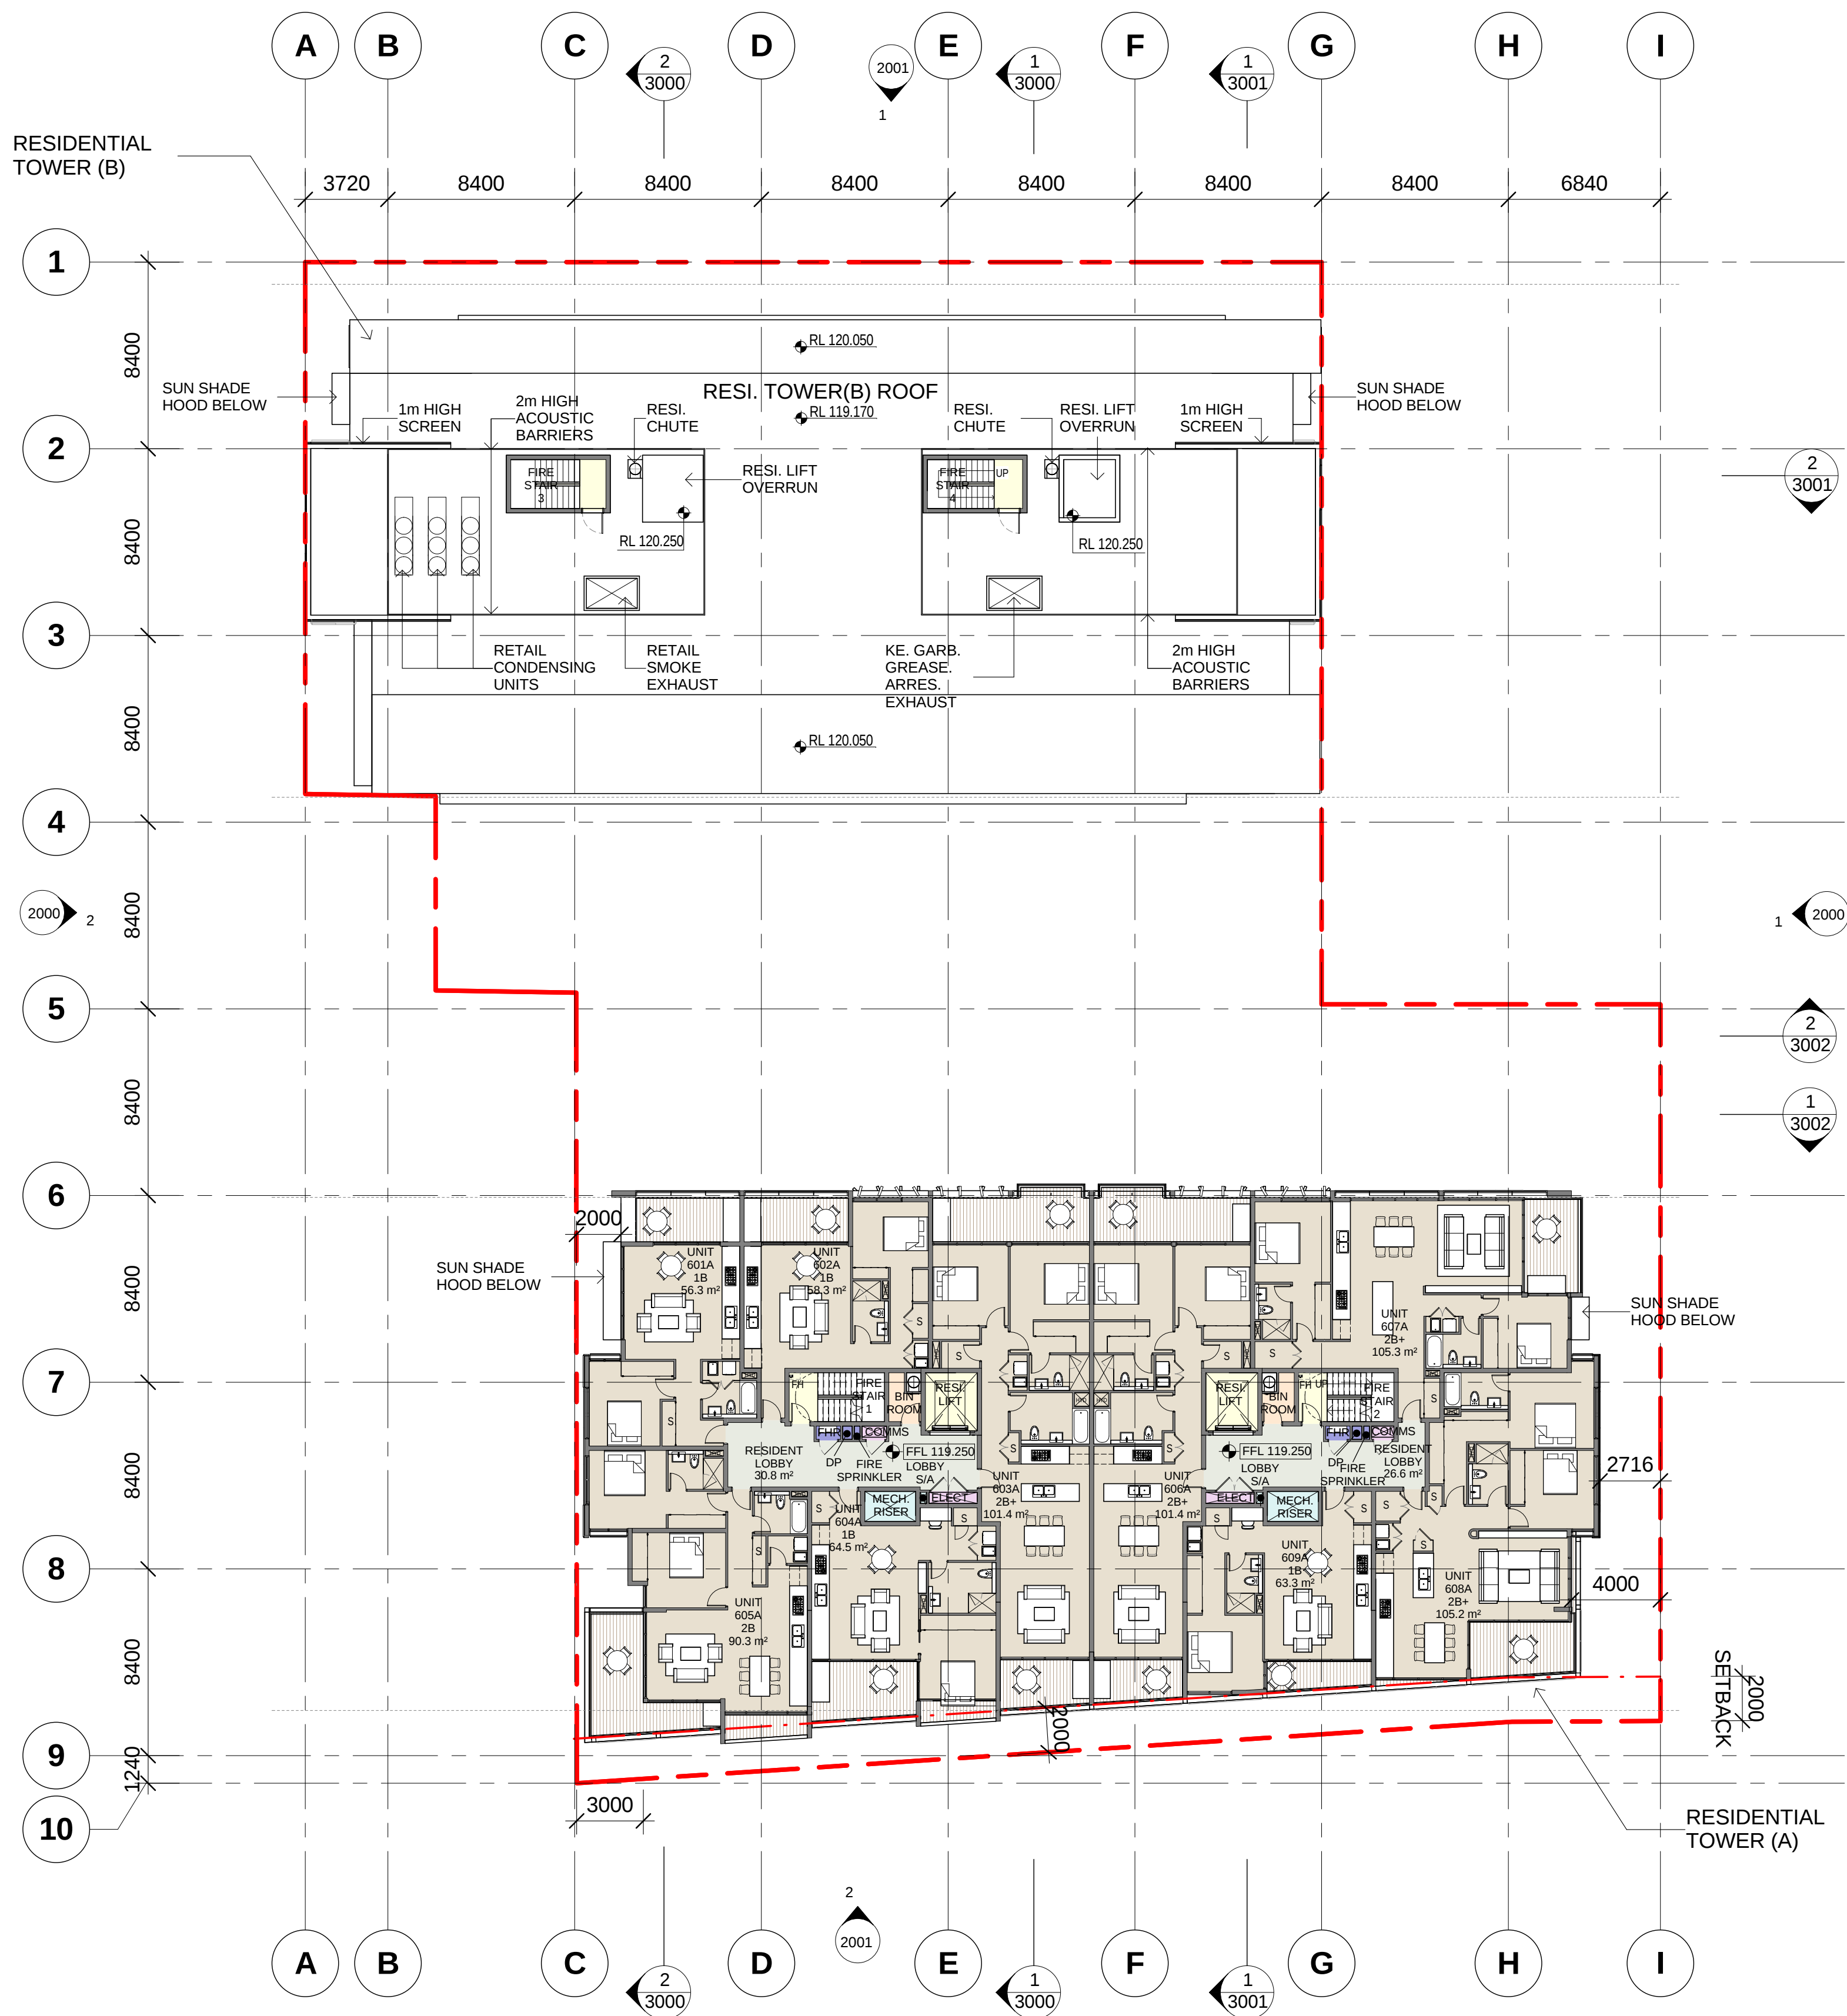

1 LEVEL 6
1010 SCALE 1 : 200

Notes
All dimensions and setbacks to be verified prior to commencement, omissions or discrepancies to be notified to the architect.

Copyright
The copyright of this drawing together with any other documents prepared by crone partners architecture studios. pty ltd (cp) remains the property of cp. crone partners grants licence for the use of this document for the purpose for which they are intended. The licence is not transferable without the permission of cp.

Quality Assurance System

Authorised By: _____ Date: _____

Rev	DESCRIPTION	By	Date
A	ISSUED FOR SECTION 75W SUBMISSION	MQ	20/11/2012
B	ISSUED FOR PREFERRED PROJECT REPORT SUBMISSION	MQ	20/05/2013

Builder

Client
ANKA (CIVIC CENTER) PTY LTD
LEVEL 3
179-191 NEW SOUTH HEAD RD
EDGECLIFF, SYDNEY NSW 2027
Ph: +61 2 9302 3000
Fax: +61 2 9302 3030

Structural Engineer
AECOM
Level 21, 420 George St, Sydney NSW 2000
Ph: 02 8934 0000 Fax: 02 8934 0001

Mechanical Engineer
WOOD & GRIEVE ENGINEERS
Level 454, 456 Pacific Highway,
St. Leonards, NSW 2000
Ph: 02 8484 7000 Fax: 02 8484 7100

Electrical Engineer
WOOD & GRIEVE ENGINEERS
Level 454, 456 Pacific Highway,
St. Leonards, NSW 2000
Ph: 02 8484 7000 Fax: 02 8484 7100

Hydraulic Engineer
INSYNC SERVICES
Suite 8, Level 2, 56 Church Ave.
Mascot, NSW 2015
Ph: 02 9669 4311 Fax: 02 9669 4322

Landscape Architect
ASPECT Studios
Studio G1 - Level 6, 61 Marlborough St
Surry Hills, NSW 2010
Ph: 02 9699 7182 Fax: 02 9699 7192

KEY

Scale 1 : 200 @A1

cronepartners
Cronepartners
level 2, 364 kent street,
sydney, nsw 2000, australia
Ph: +61 2 8295 5300
Fax: +61 2 8295 5301

Project
LINDFIELD MIXED-USE DEVELOPMENT
23-37 LINDFIELD AVE & 11 HAVILAH LA
LINDFIELD NSW 2070


Drawn: MQ	Checked: VD	Date: 20/05/2013
-----------	-------------	------------------

Drawing Title
LEVEL 6 FLOOR PLAN

PREFERRED PROJECT SUBMISSION

CA 2924	ADAZ	1010	B
Project no.	Drawing Phase.	Drawing No.	Rev

PREFERRED PROJECT REPORT SUBMISSION

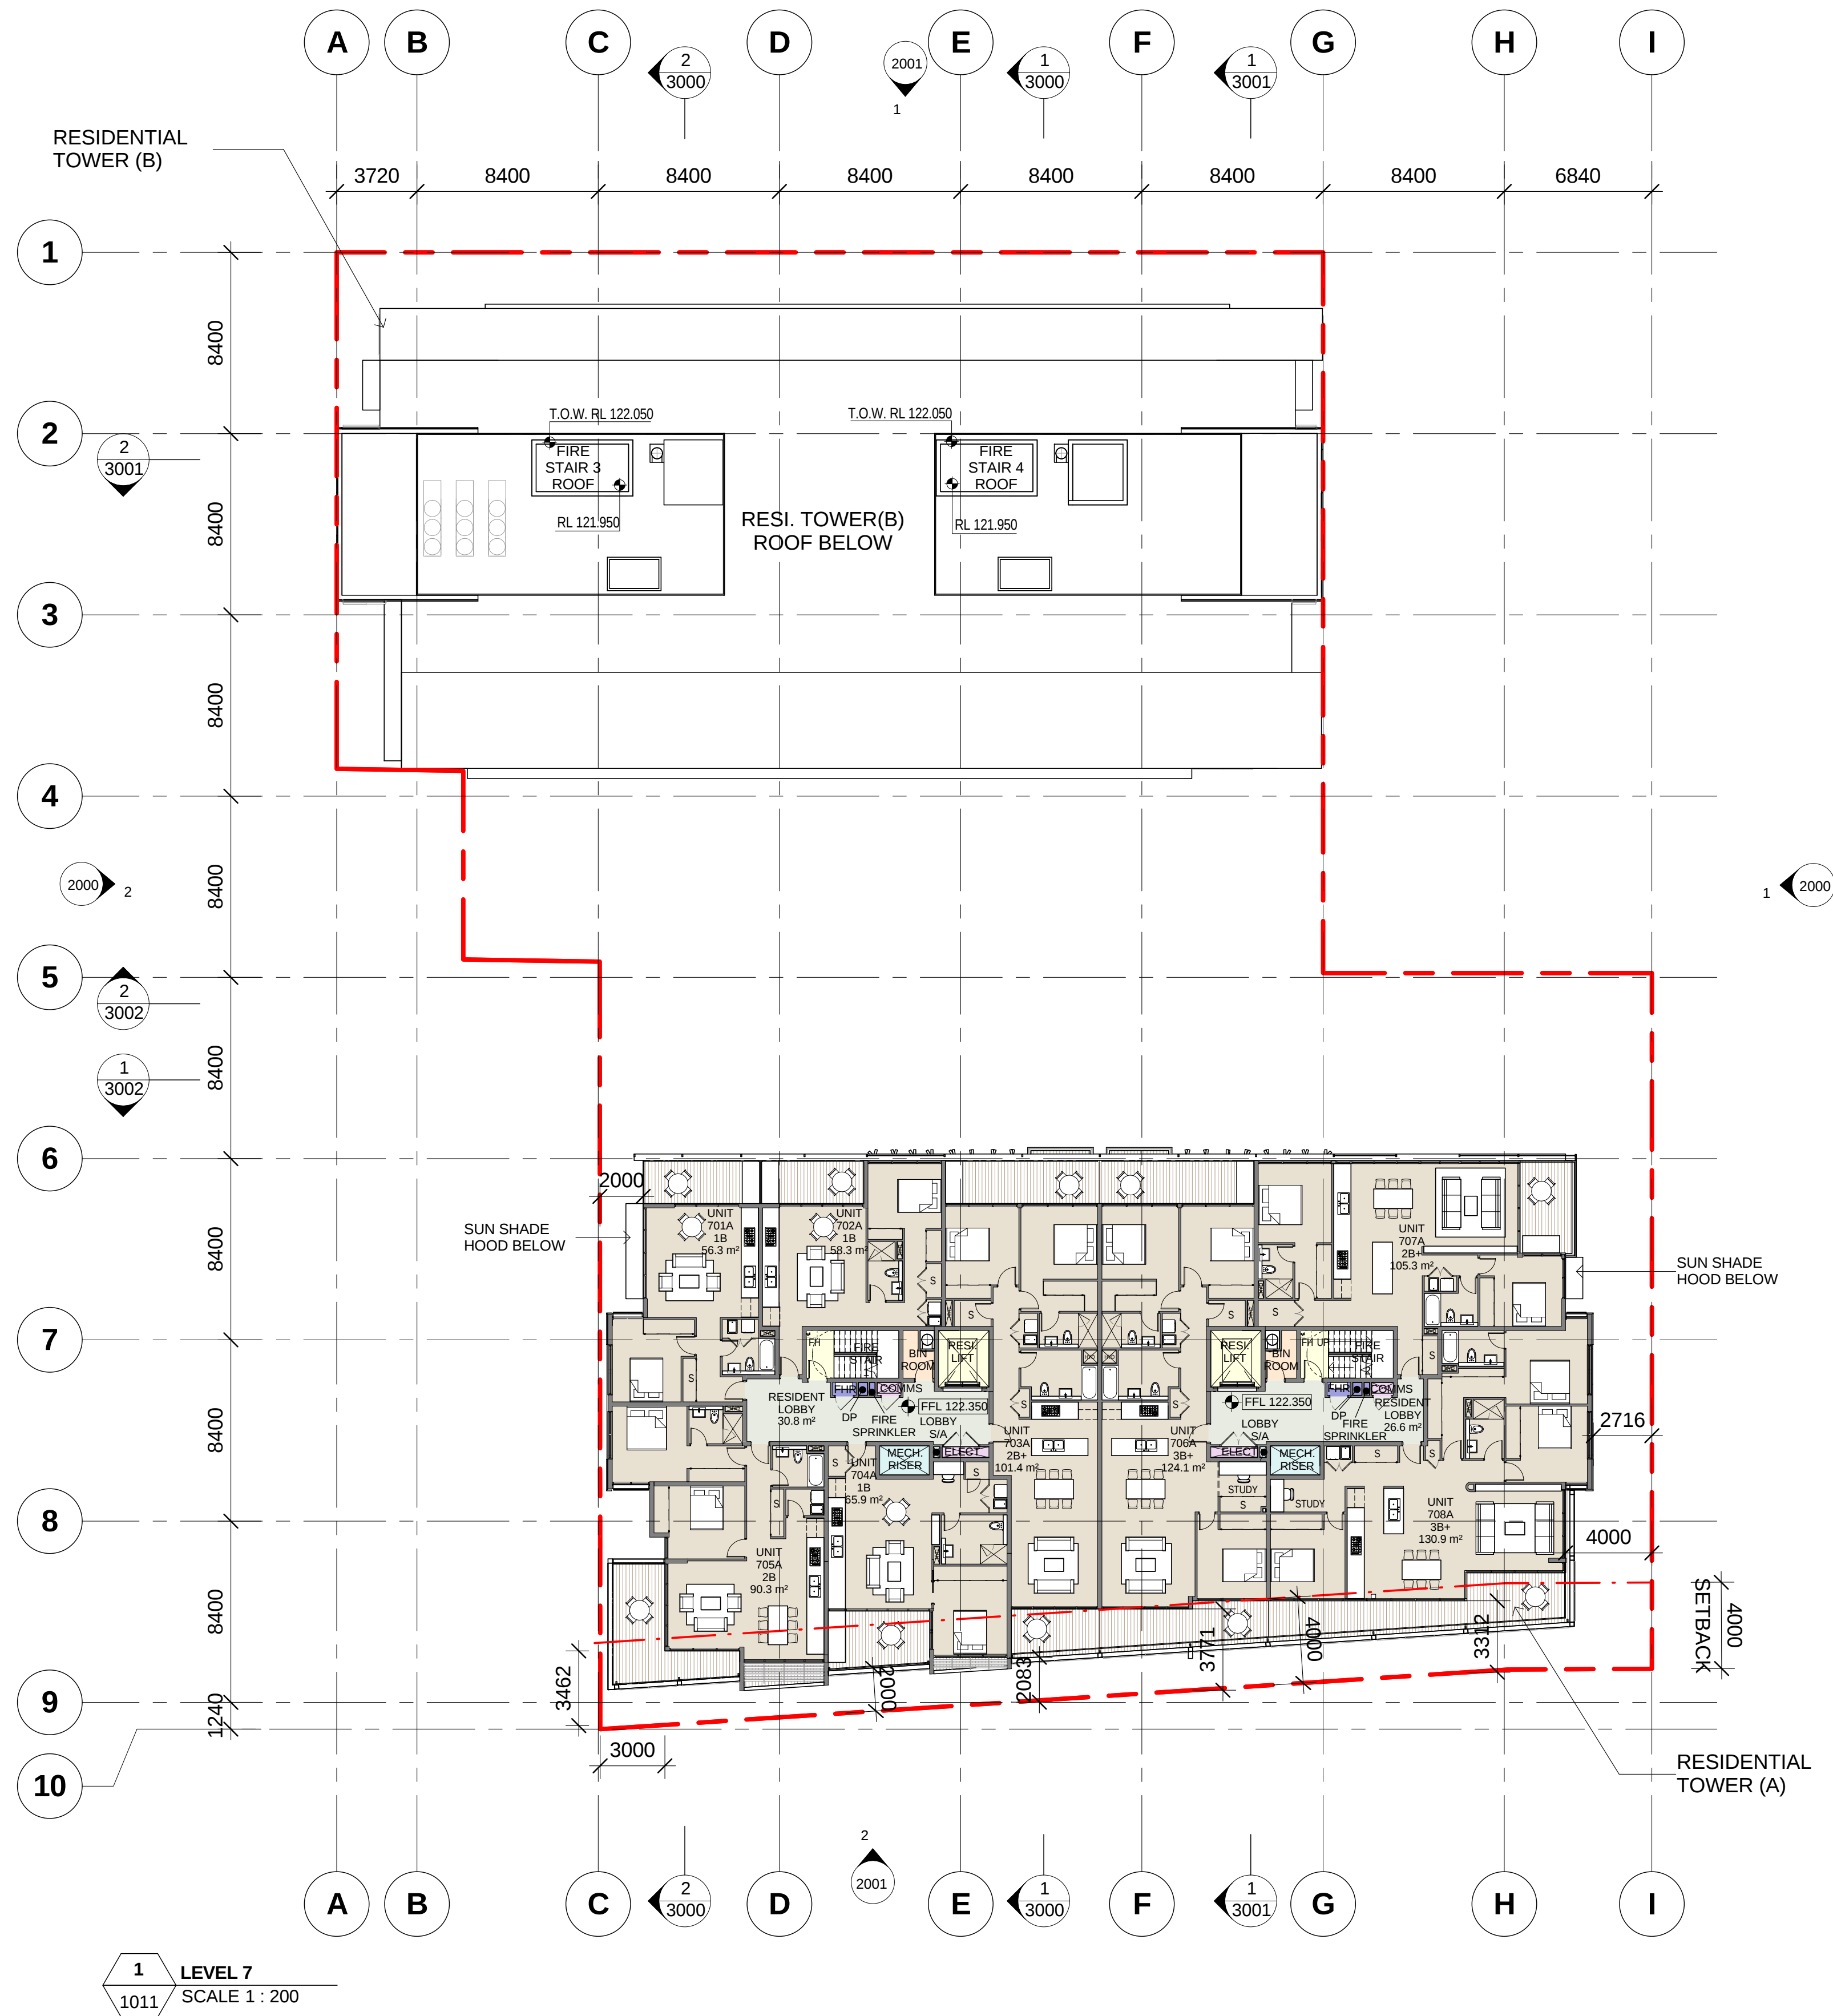

COLOR FILL LEGEND

- AMENITY
- CIRCULATION
- ELECTRICAL RISER
- GARBAGE
- HORIZONTAL TRANSPORTATION
- HYD/FIRE RISER
- MECH. RISER
- PARKING
- PUBLIC AREA
- RESIDENT(A)
- RESIDENT(B)
- RETAIL
- SERVICE ZONE
- TANKS
- VERTICAL TRANSPORTATION

Notes
All dimensions and setbacks to be verified prior to commencement, omissions or discrepancies to be notified to the architect.

Copyright
The copyright of this drawing together with any other documents prepared by crone partners architecture studios. pty ltd (cp) remains the property of cp. crone partners grants licence for the use of this document for the purpose for which they are intended. The licence is not transferable without the permission of cp.

Quality Assurance System

Authorised By: _____ Date: _____

Rev	DESCRIPTION	By	Date
A	ISSUED FOR SECTION 75W SUBMISSION	MQ	20/11/2012
B	ISSUED FOR PREFERRED PROJECT REPORT SUBMISSION	MQ	20/05/2013

Builder

Client
ANKA (CIVIC CENTER) PTY LTD
LEVEL 3
179-191 NEW SOUTH HEAD RD
EDGECLIFF, SYDNEY NSW 2027
Ph: +61 2 9302 3000
Fax: +61 2 9302 3030

Structural Engineer
AECOM
Level 21, 420 George St, Sydney NSW 2000
Ph: 02 8934 0000 Fax: 02 8934 0001

Mechanical Engineer
WOOD & GRIEVE ENGINEERS
Level 454, 456 Pacific Highway,
St. Leonards, NSW 2000
Ph: 02 8484 7000 Fax: 02 8484 7100

Electrical Engineer
WOOD & GRIEVE ENGINEERS
Level 454, 456 Pacific Highway,
St. Leonards, NSW 2000
Ph: 02 8484 7000 Fax: 02 8484 7100

Hydraulic Engineer
INSYNC SERVICES
Suite 8, Level 2, 56 Church Ave.
Mascot, NSW 2015
Ph: 02 9669 4311 Fax: 02 9669 4322

Landscape Architect
ASPECT Studios
Studio G1 - Level 6, 61 Marlborough St
Surry Hills, NSW 2010
Ph: 02 9699 7182 Fax: 02 9699 7192

KEY

Scale 1 : 200 @A1

cronepartners
Cronepartners
level 2, 364 kent street,
sydney, nsw 2000, australia
Ph: +61 2 8295 5300
Fax: +61 2 8295 5301

Project
LINDFIELD MIXED-USE DEVELOPMENT
23-37 LINDFIELD AVE & 11 HAVILAH LA
LINDFIELD NSW 2070

Drawn: MQ	Checked: VD	Date: 20/05/2013
-----------	-------------	------------------

Drawing Title
LEVEL 7 FLOOR PLAN

PREFERRED PROJECT SUBMISSION			
CA 2924	ADAZ	1011	B
Project no.	Drawing Phase.	Drawing No.	Rev

PREFERRED PROJECT REPORT SUBMISSION



Cad File No: C:\Users\michaelq\Documents\CA-2924-Z-M3-AR-Main_Model-Central_Option 1B_michaelq.rvt	Plot Date: 17/05/2013 2:49:22 PM
--	----------------------------------