


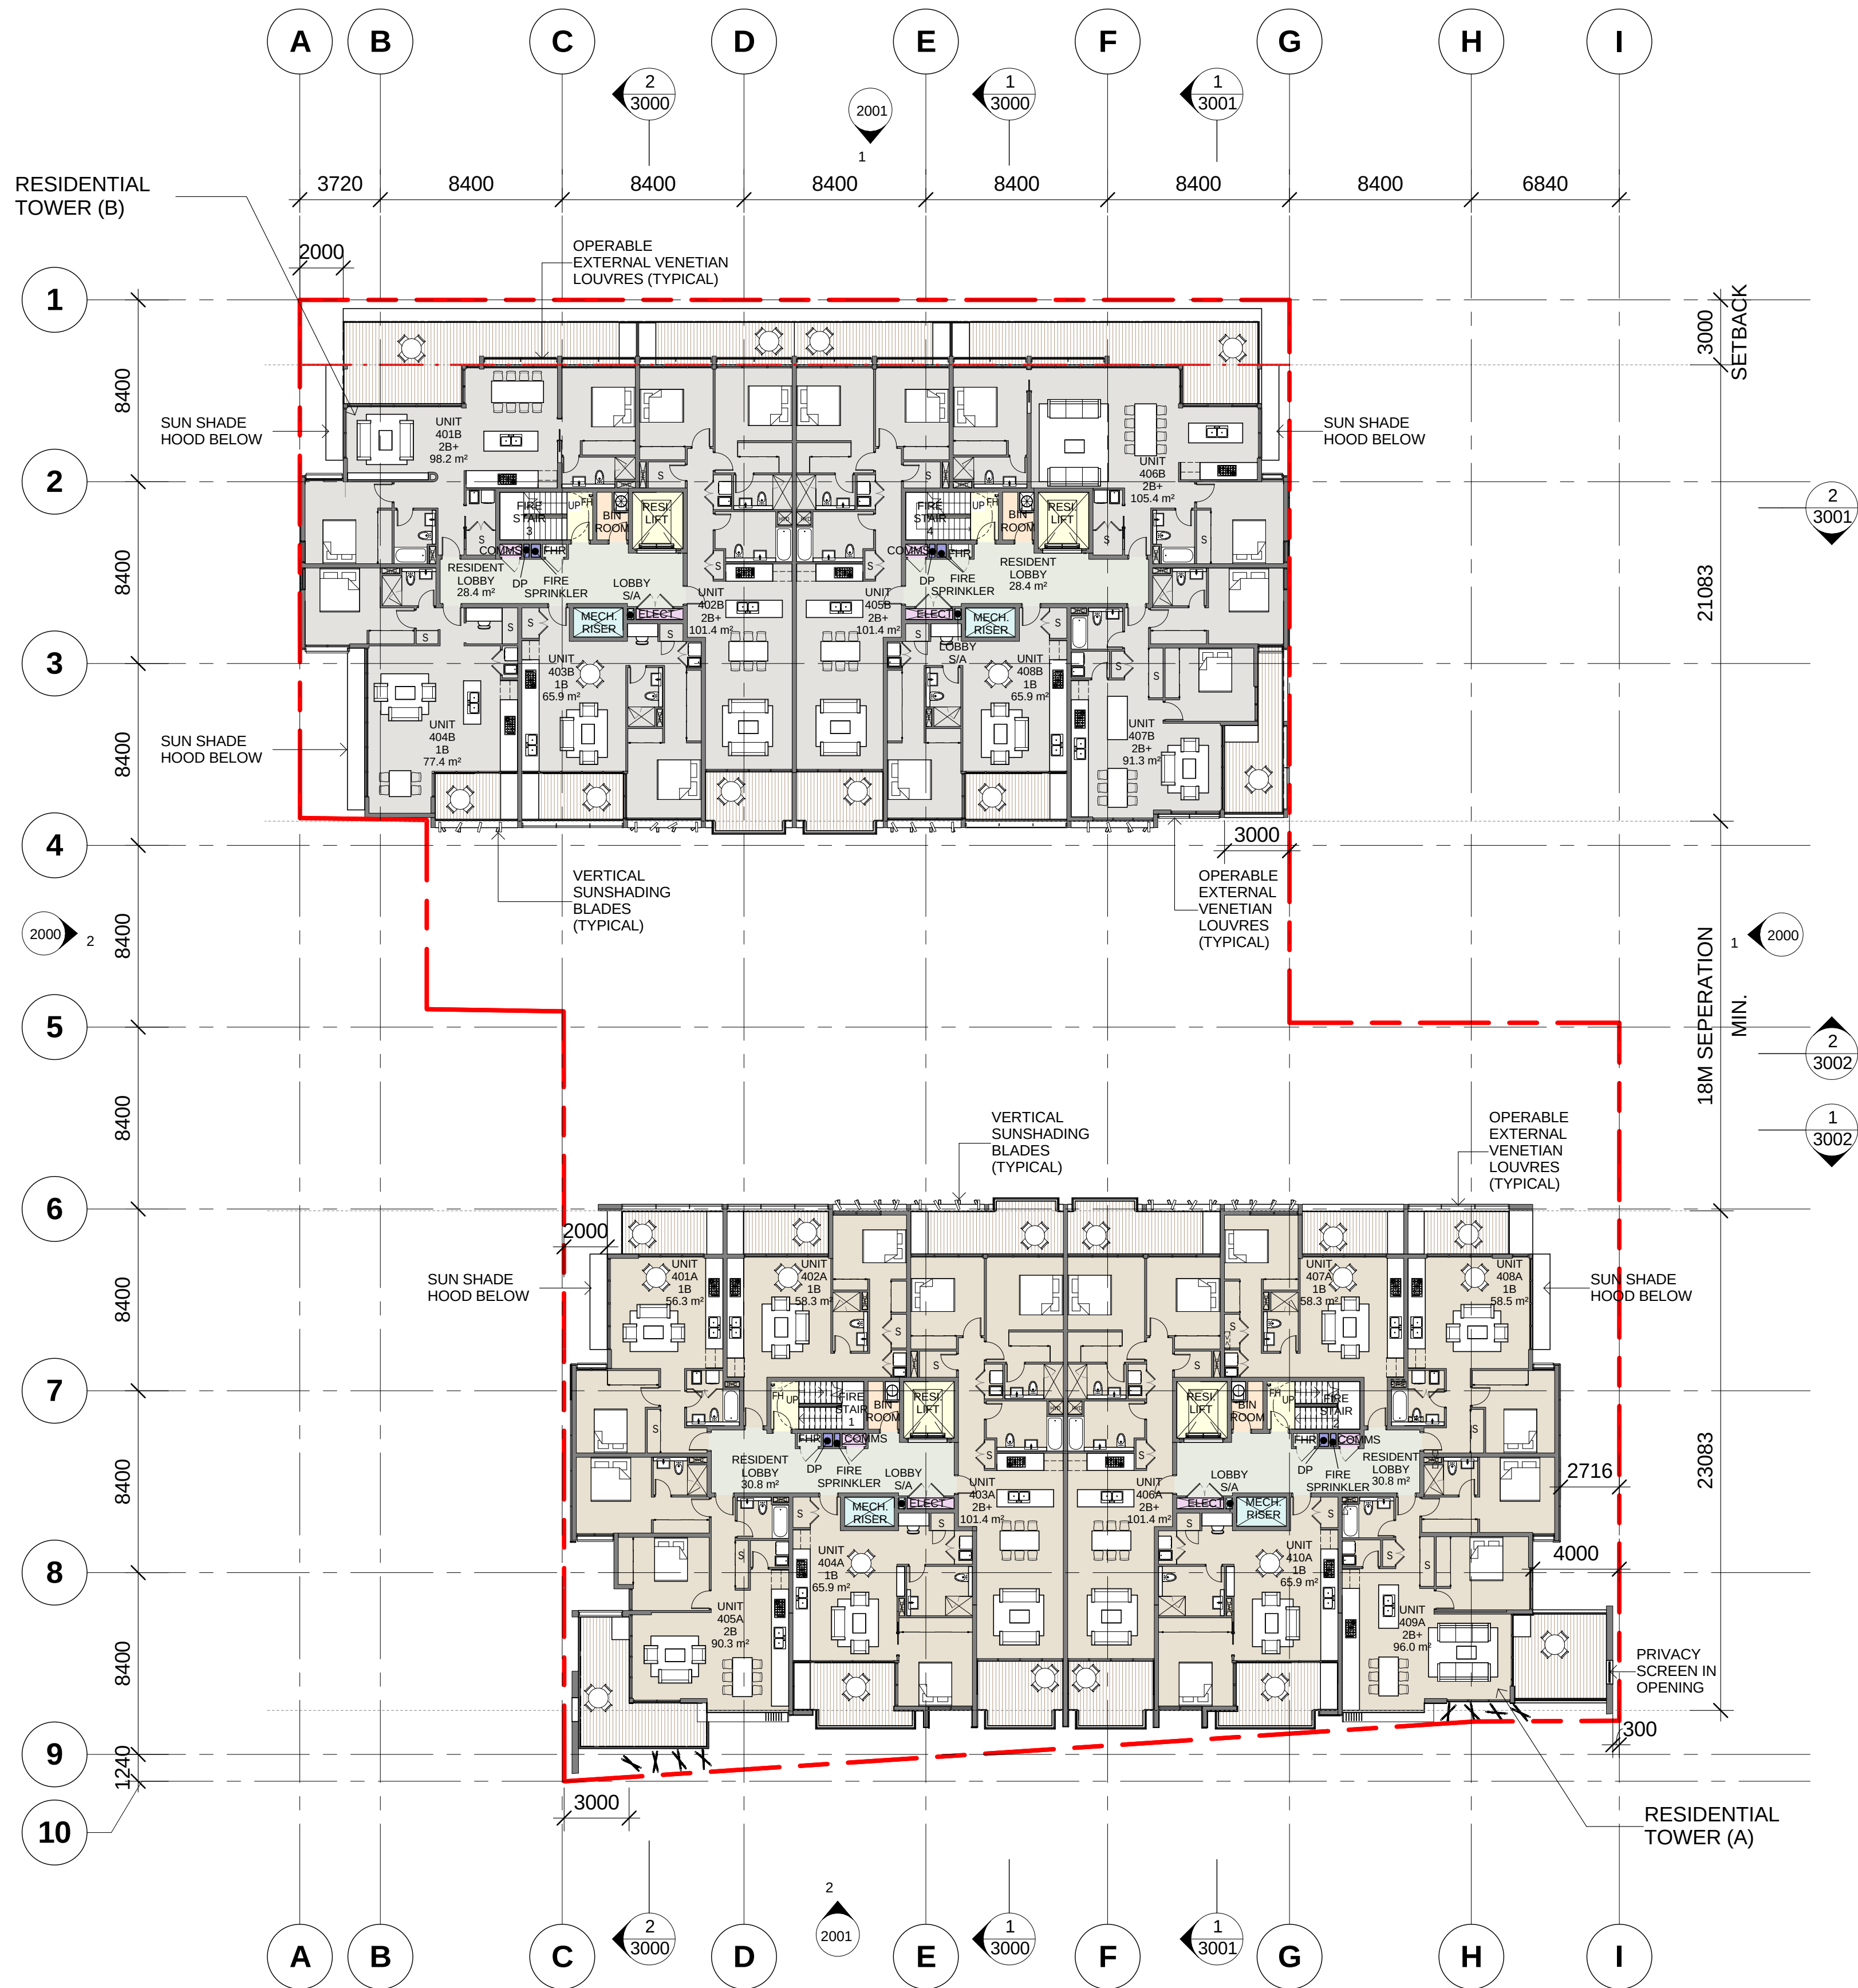

COLOR FILL LEGEND

- AMENITY
- CIRCULATION
- ELECTRICAL RISER
- GARBAGE
- HORIZONTAL TRANSPORTATION
- HYD/FIRE RISER
- MECH. RISER
- PARKING
- PUBLIC AREA
- RESIDENT(A)
- RESIDENT(B)
- RETAIL
- SERVICE ZONE
- TANKS
- VERTICAL TRANSPORTATION

1 LEVEL 4
1008 SCALE 1 : 200

Notes

All dimensions and setbacks to be verified prior to commencement, omissions or discrepancies to be notified to the architect.

Copyright

The copyright of this drawing together with any other documents prepared by crone partners architecture studios. pty ltd (cp) remains the property of cp. crone partners grants licence for the use of this document for the purpose for which they are intended. The licence is not transferable without the permission of cp.

Quality Assurance System

Authorised By: _____ Date: _____

Rev	DESCRIPTION	By	Date
A	ISSUED FOR SECTION 75W SUBMISSION	MQ	20/11/2012
B	ISSUED FOR PREFERRED PROJECT REPORT SUBMISSION	MQ	--/05/2013

ABSA Class 2 Building Project Certification

Certification Number: 1005269553

Certification Date: 15/05/2013

Assessor Name: Rosalinde Phillips

Assessor Number: 60885

Average Simulated Energy: HEATING: 28.8 MJ/m² pa
AVERAGE Simulated Energy: COOLING: 21.1 MJ/m² pa
Rated with Downlights: 14%

Average NatHERS Rating: 5.0 MJ/m² pa

6.2

Builder

Client
ANKA (CIVIC CENTER) PTY LTD
LEVEL 3
179-191 NEW SOUTH HEAD RD
EDGECLIFF, SYDNEY NSW 2027
Ph: +61 2 9302 3000
Fax: +61 2 9302 3030

Structural Engineer
AECOM
Level 21, 420 George St, Sydney NSW 2000
Ph: 02 8934 0000 Fax: 02 8934 0001

Mechanical Engineer
WOOD & GRIEVE ENGINEERS
Level 454, 456 Pacific Highway,
St. Leonards, NSW 2000
Ph: 02 8484 7000 Fax: 02 8484 7100

Electrical Engineer
WOOD & GRIEVE ENGINEERS
Level 454, 456 Pacific Highway,
St. Leonards, NSW 2000
Ph: 02 8484 7000 Fax: 02 8484 7100

Hydraulic Engineer
INSYNC SERVICES
Suite 8, Level 2, 56 Church Ave.
Mascot, NSW 2015
Ph: 02 9669 4311 Fax: 02 9669 4322

Landscape Architect
ASPECT Studios
Studio G1 - Level 6, 61 Marlborough St
Surry Hills, NSW 2010
Ph: 02 9699 7182 Fax: 02 9699 7192

KEY

Scale 1 : 200 @A1

cronepartners
Cronepartners
level 2, 364 kent street,
sydney, nsw 2000, australia
Ph: +61 2 8295 5300
Fax: +61 2 8295 5301

Project
LINDFIELD MIXED-USE DEVELOPMENT
23-37 LINDFIELD AVE & 11 HAVILAH LA
LINDFIELD NSW 2070

Drawn: MQ	Checked: VD	Date: --/05/2013
-----------	-------------	------------------

Drawing Title
LEVEL 4 FLOOR PLAN

PREFERRED PROJECT SUBMISSION

CA 2924	ADAZ	1008	B
Project no.	Drawing Phase.	Drawing No.	Rev

PREFERRED PROJECT REPORT SUBMISSION



COLOR FILL LEGEND

- AMENITY
- CIRCULATION
- ELECTRICAL RISER
- GARBAGE
- HORIZONTAL TRANSPORTATION
- HYD/FIRE RISER
- MECH. RISER
- PARKING
- PUBLIC AREA
- RESIDENT(A)
- RESIDENT(B)
- RETAIL
- SERVICE ZONE
- TANKS
- VERTICAL TRANSPORTATION

1 LEVEL 5
1009 SCALE 1 : 200

Notes
All dimensions and setbacks to be verified prior to commencement, omissions or discrepancies to be notified to the architect.

Copyright
The copyright of this drawing together with any other documents prepared by crone partners architecture studios. pty ltd (cp) remains the property of cp. crone partners grants licence for the use of this document for the purpose for which they are intended. The licence is not transferable without the permission of cp.

Quality Assurance System

Authorised By: _____ Date: _____

Rev	DESCRIPTION	By	Date
A	ISSUED FOR SECTION 75W SUBMISSION	MQ	20/11/2012
B	ISSUED FOR PREFERRED PROJECT REPORT SUBMISSION	MQ	--/05/2013

ABSA Class 2 Building Project Certification

Certification Number: 1005026533
Certification Date: 15/05/2013
Assessor Name: Rochelle Phille
Assessor Number: 60365
Assessor Signature:

Averaged Simulated Energy: HEATING: 28.8 MJ/m2 pa
Averaged Simulated Energy: COOLING: 21.1 MJ/m2 pa
Actual with Downlights: No

Averaged NatHERS Rating: 6.2

Builder

Client
ANKA (CIVIC CENTER) PTY LTD
LEVEL 3
179-191 NEW SOUTH HEAD RD
EDGECLIFF, SYDNEY NSW 2027
Ph: +61 2 9302 3000
Fax: +61 2 9302 3030

Structural Engineer
AECOM
Level 21, 420 George St, Sydney NSW 2000
Ph: 02 8934 0000 Fax: 02 8934 0001

Mechanical Engineer
WOOD & GRIEVE ENGINEERS
Level 454, 456 Pacific Highway,
St. Leonards, NSW 2000
Ph: 02 8484 7000 Fax: 02 8484 7100

Electrical Engineer
WOOD & GRIEVE ENGINEERS
Level 454, 456 Pacific Highway,
St. Leonards, NSW 2000
Ph: 02 8484 7000 Fax: 02 8484 7100

Hydraulic Engineer
INSYNC SERVICES
Suite 8, Level 2, 56 Church Ave,
Mascot, NSW 2015
Ph: 02 9669 4311 Fax: 02 9669 4322

Landscape Architect
ASPECT Studios
Studio G1 - Level 6, 61 Marlborough St
Surry Hills, NSW 2010
Ph: 02 9699 7182 Fax: 02 9699 7192

KEY

Scale 1 : 200 @A1

cronepartners
Cronepartners
level 2, 364 kent street,
sydney, nsw 2000, australia
Ph: +61 2 8295 5300
Fax: +61 2 8295 5301

Project
LINDFIELD MIXED-USE DEVELOPMENT
23-37 LINDFIELD AVE & 11 HAVILAH LA
LINDFIELD NSW 2070


Drawn: MQ	Checked: VD	Date: --/05/2013
-----------	-------------	------------------

Drawing Title
LEVEL 5 FLOOR PLAN

PREFERRED PROJECT SUBMISSION

CA 2924 Project no.	ADAZ Drawing Phase.	1009 Drawing No.	B Rev
-------------------------------	-------------------------------	----------------------------	-----------------

PREFERRED PROJECT REPORT SUBMISSION

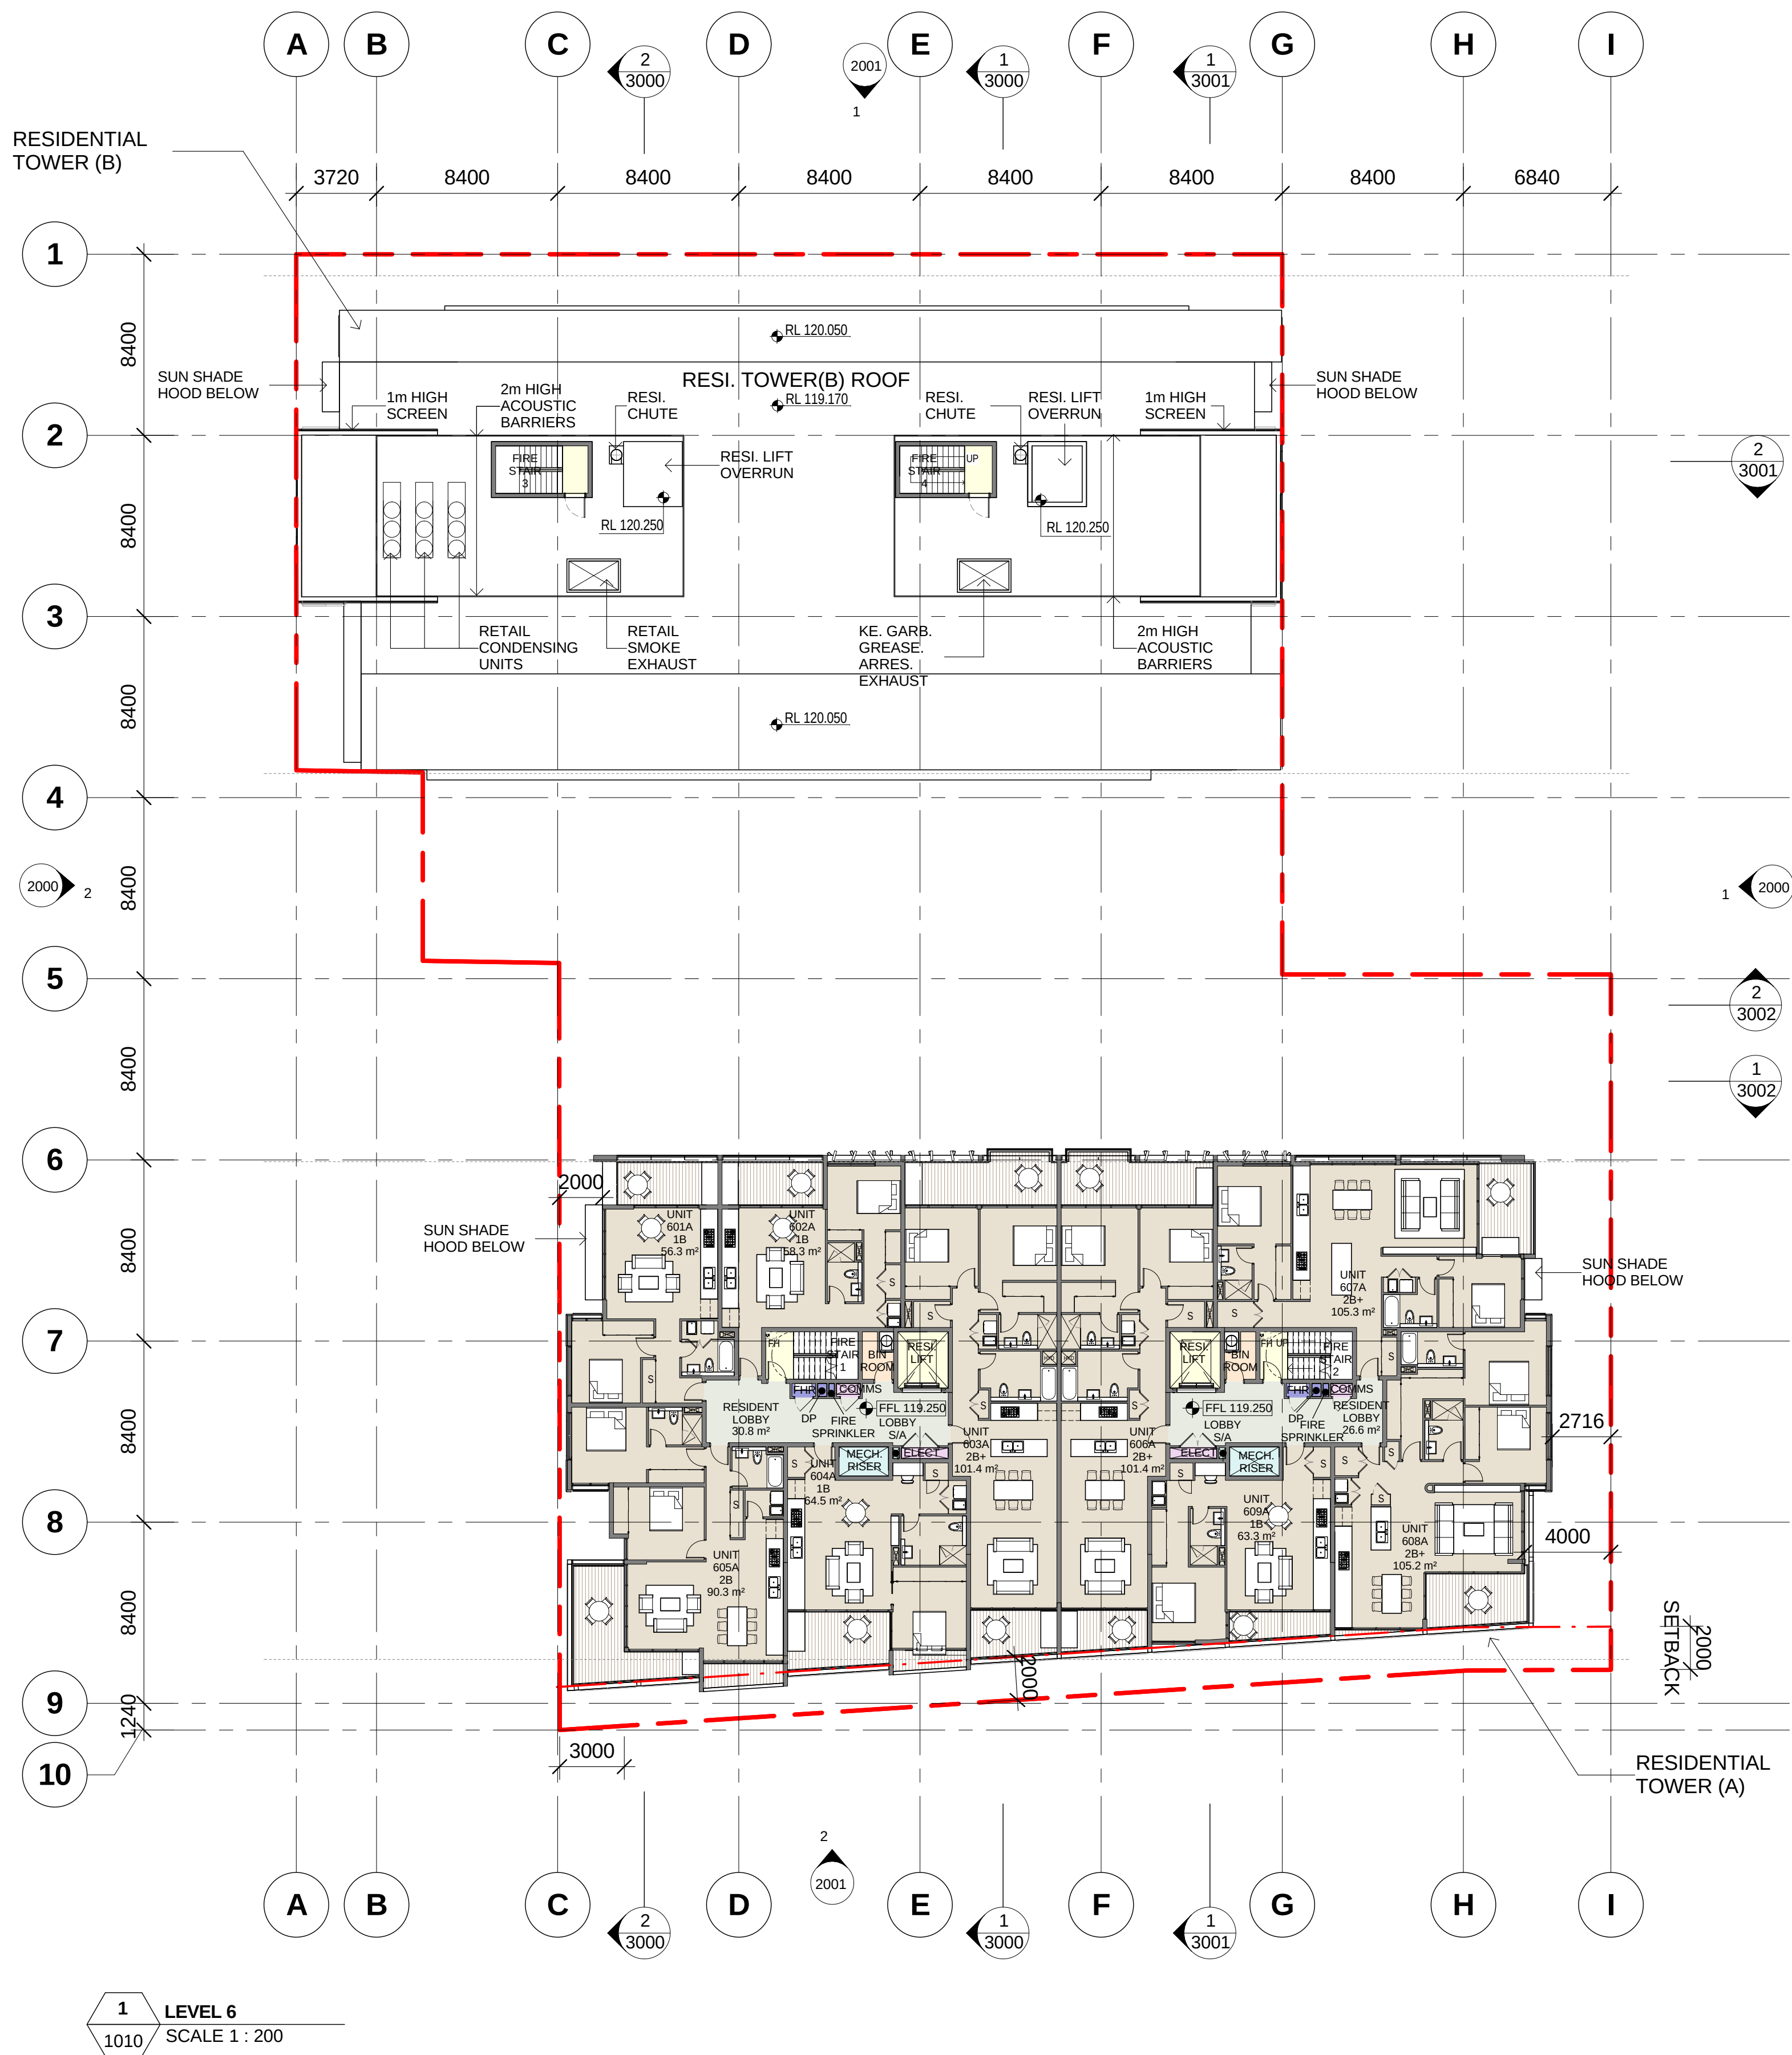

1 LEVEL 6
1010 SCALE 1 : 200

Notes

All dimensions and setbacks to be verified prior to commencement, omissions or discrepancies to be notified to the architect.

Copyright

The copyright of this drawing together with any other documents prepared by crone partners architecture studios. pty ltd (cp) remains the property of cp. crone partners grants licence for the use of this document for the purpose for which they are intended. The licence is not transferable without the permission of cp.

Quality Assurance System

Authorised By:

Date:

Rev

DESCRIPTION

By

Date

A

ISSUED FOR SECTION 75W SUBMISSION

MQ

20/11/2012

B

ISSUED FOR PREFERRED PROJECT REPORT SUBMISSION

MQ

--/05/2013

ABSAClass 2 Building Project Certification

Certification Number1005269533

Certification Date15/05/2013

Assessor NameRochelle Phillis

Assessor Number60895

Assessor Signature

Averaged Simulated Energy HEATING: 28.8 MJ/m2 pa

Averaged Simulated Energy COOLING: 21.1 MJ/m2 pa

Averaged NatHERS Rating: 6.2

Builder

Client

ANKA (CIVIC CENTER) PTY LTD

LEVEL 3

179-191 NEW SOUTH HEAD RD

EDGECLIFF, SYDNEY NSW 2027

Ph: +61 2 9302 3000

Fax: +61 2 9302 3030

Structural Engineer

AECOM

Level 21, 420 George St, Sydney NSW 2000

Ph: 02 8934 0000 Fax: 02 8934 0001

Mechanical Engineer

WOOD & GRIEVE ENGINEERS

Level 3, 454 - 456 Pacific Highway,

St. Leonards, NSW 2000

Ph: 02 8484 7000 Fax: 02 8484 7100

Electrical Engineer

WOOD & GRIEVE ENGINEERS

Level 3, 454 - 456 Pacific Highway,

St. Leonards, NSW 2000

Ph: 02 8484 7000 Fax: 02 8484 7100

Hydraulic Engineer

INSYNC SERVICES

Suite 8, Level 2, 56 Church Ave,

Mascot, NSW 2015

Ph: 02 9669 4311 Fax: 02 9669 4322

Landscape Architect

ASPECT Studios

Studio 61 - Level 6, 61 Marlborough St

Surry Hills, NSW 2010

Ph: 02 9699 7182 Fax: 02 9699 7192

KEY

Scale

1 : 200 @A1

cronepartners

Cronepartners

level 2, 364 kent street,

sydney, nsw 2000, australia

Ph: +61 2 8295 5300

Fax: +61 2 8295 5301

Project

LINDFIELD MIXED-USE DEVELOPMENT

23-37 LINDFIELD AVE & 11 HAVILAH LA

LINDFIELD NSW 2070

Drawn: MQ

Checked: VD

Date: --/05/2013

Drawing Title

LEVEL 6 FLOOR PLAN

PREFERRED PROJECT SUBMISSION

CA 2924

ADAZ

1010

B

Project no.

Drawing Phase.

Drawing No.

Rev

PREFERRED PROJECT REPORT SUBMISSION