


1 SECTION 1
SCALE 1 : 200

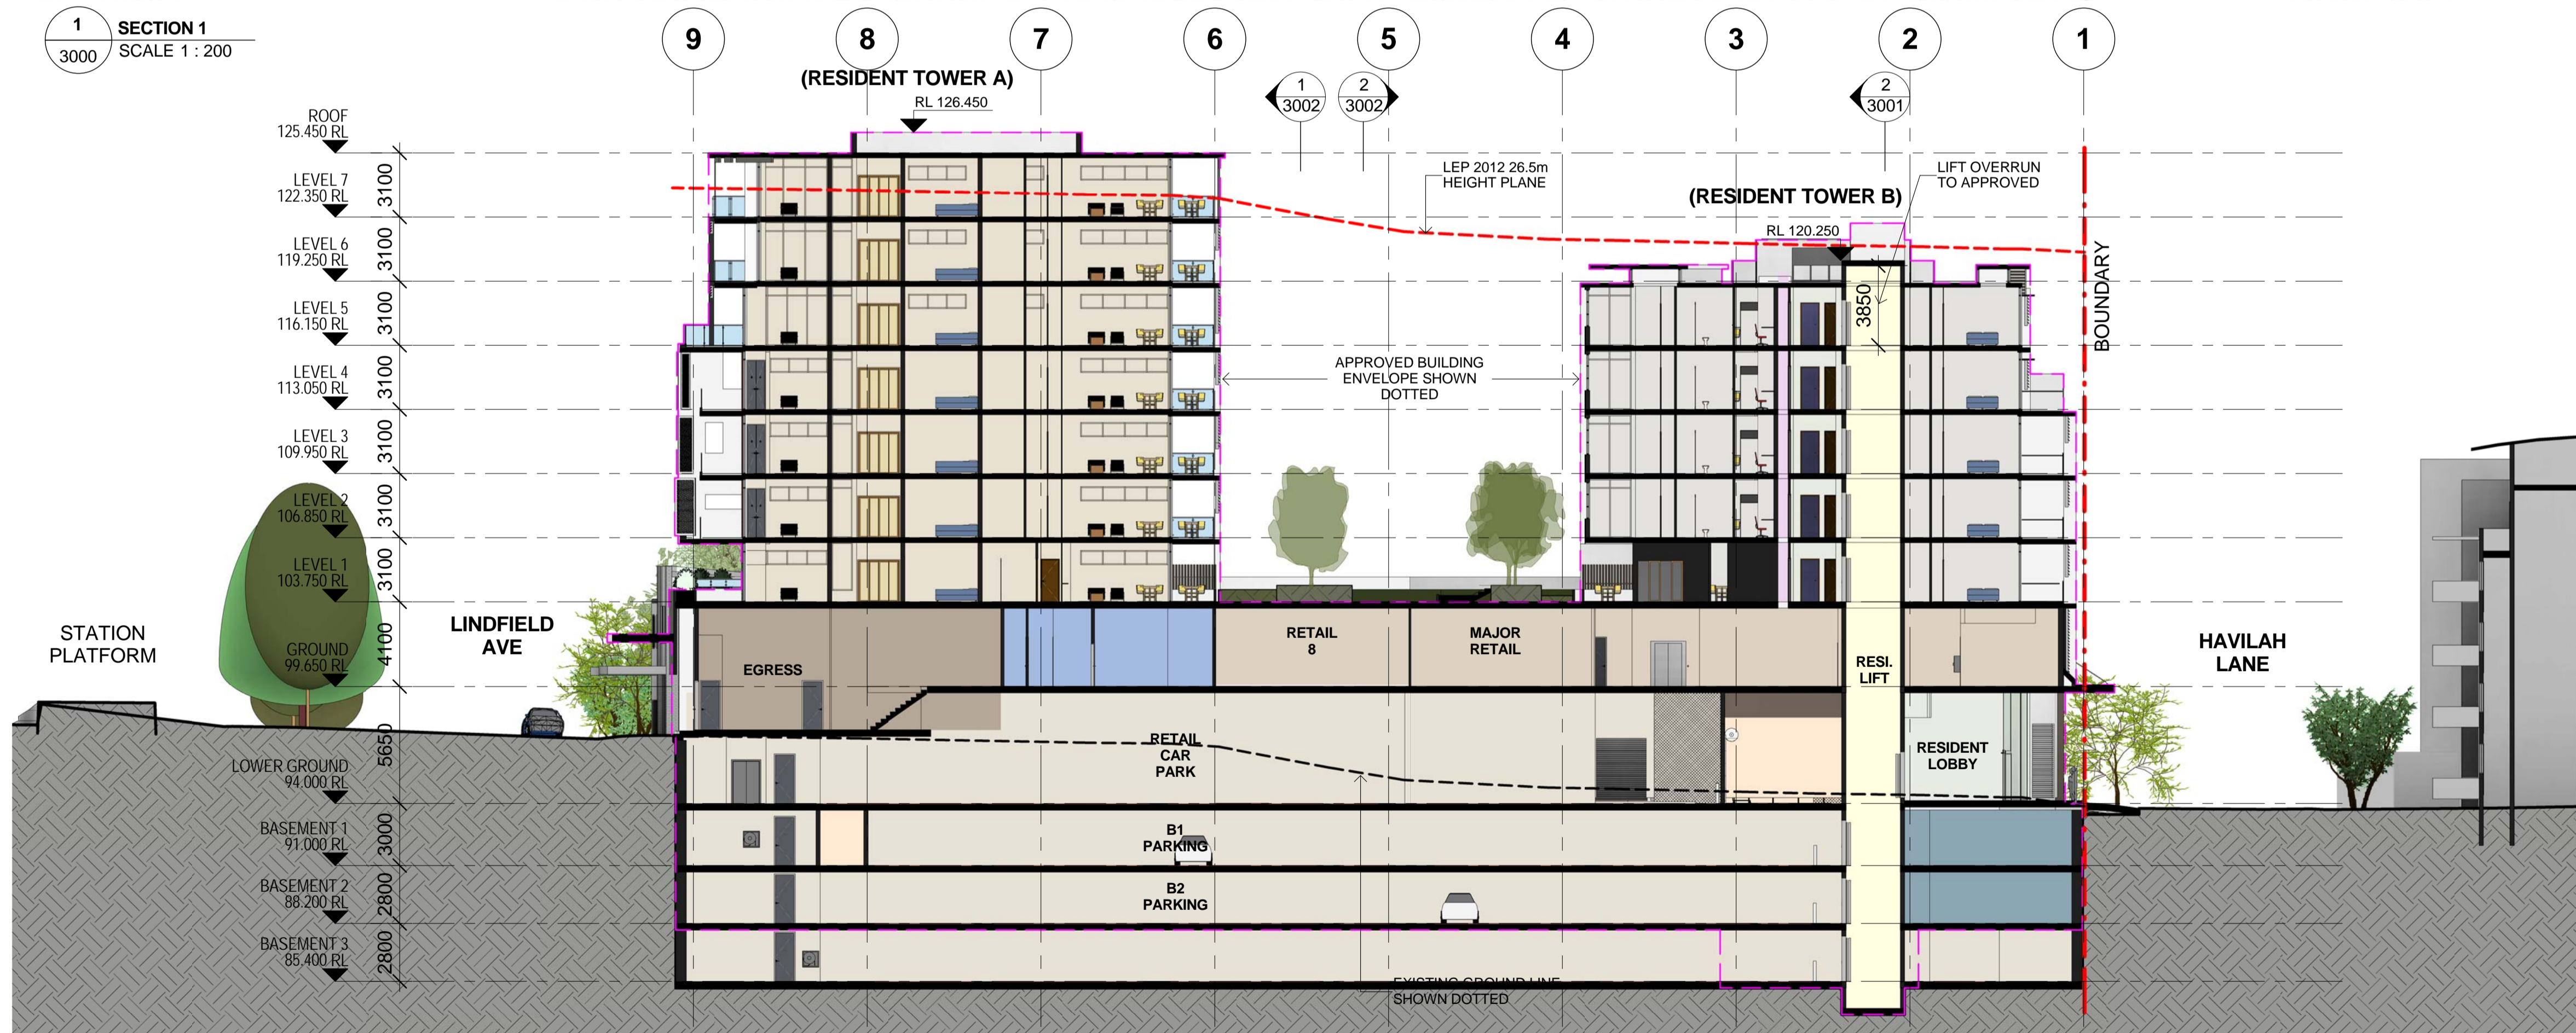

2 SECTION 2
SCALE 1 : 200

COLOR FILL LEGEND

AMENITY	GARBAGE	MECH. RISER	RESIDENT(A)	SERVICE ZONE
CIRCULATION	HORIZONTAL TRANSPORTATION	PARKING	RESIDENT(B)	TANKS
ELECTRICAL RISER	HYD/FIRE RISER	PUBLIC AREA	RETAIL	VERTICAL TRANSPORTATION

MOD 2 PREFERRED PROJECT SUBMISSION

Notes
All dimensions and setbacks to be verified prior to commencement, omissions or discrepancies to be notified to the architect.
Copyright
The copyright of this drawing together with any other documents prepared by crone partners architecture studios, ply ltd (cp) remains the property of cp. crone partners grants licence for the use of this document for the purpose for which they are intended. The licence is not transferable without the permission of cp.

Quality Assurance System

Authorised By: _____ Date: _____

Rev	DESCRIPTION	By	Date
A	ISSUED FOR SECTION 75W SUBMISSION	MQ	20/11/2012
B	ISSUED FOR PREFERRED PROJECT REPORT SUBMISSION	MQ	20/05/2013
C	ISSUED FOR SECTION 75W SUBMISSION	MQ	31/10/2014
D	PREFERRED PROJECT REPORT	MQ	13/02/2015

Builder

Client
AQUALAND
LEVEL 32
225 George Street
SYDNEY NSW 2000
Ph: +61 2 9252 3347
Fax: +61 2 9241 1754



Structural Engineer AECOM Level 21, 420 George St. Sydney NSW 2000 Ph: 02 8934 0000 Fax: 02 8934 0001
Mechanical Engineer WOOD & GRIEVE ENGINEERS Level 3, 454 - 456 Pacific Highway, St. Leonards, NSW 2000 Ph: 02 8484 7000 Fax: 02 8484 7100
Electrical Engineer WOOD & GRIEVE ENGINEERS Levels 454 - 456 Pacific Highway, St. Leonards, NSW 2000 Ph: 02 8484 7000 Fax: 02 8484 7100
Hydraulic Engineer INSYNC SERVICES Suite 8, Level 2, 56 Church Ave, Mascot, NSW 2015 Ph: 02 9669 4311 Fax: 02 9669 4322
Landscape Architect LAND LIV ARCHITECTS 3 Sublime Point Ave Tascone, NSW 2250 Ph: 04 0127 1241

KEY

Scale 1 : 200 @A1

cronepartners
Cronepartners
level 2, 364 kent street,
sydney, nsw 2000, australia
Ph: +61 2 8295 5300
Fax: +61 2 8295 5301

Project
LINDFIELD MIXED-USE DEVELOPMENT
23-37 LINDFIELD AVE & 11 HAVILAH LA
LINDFIELD NSW 2070

Drawn: MQ Checked: VD Date: 31/10/2014

Drawing Title
SECTIONS

SHEET 1 OF 3
PREFERRED PROJECT SUBMISSION

CA 2924	ADAZ	3000	D
Project no.	Drawing Phase.	Drawing No.	Rev