



Rozelle stabling and maintenance depot

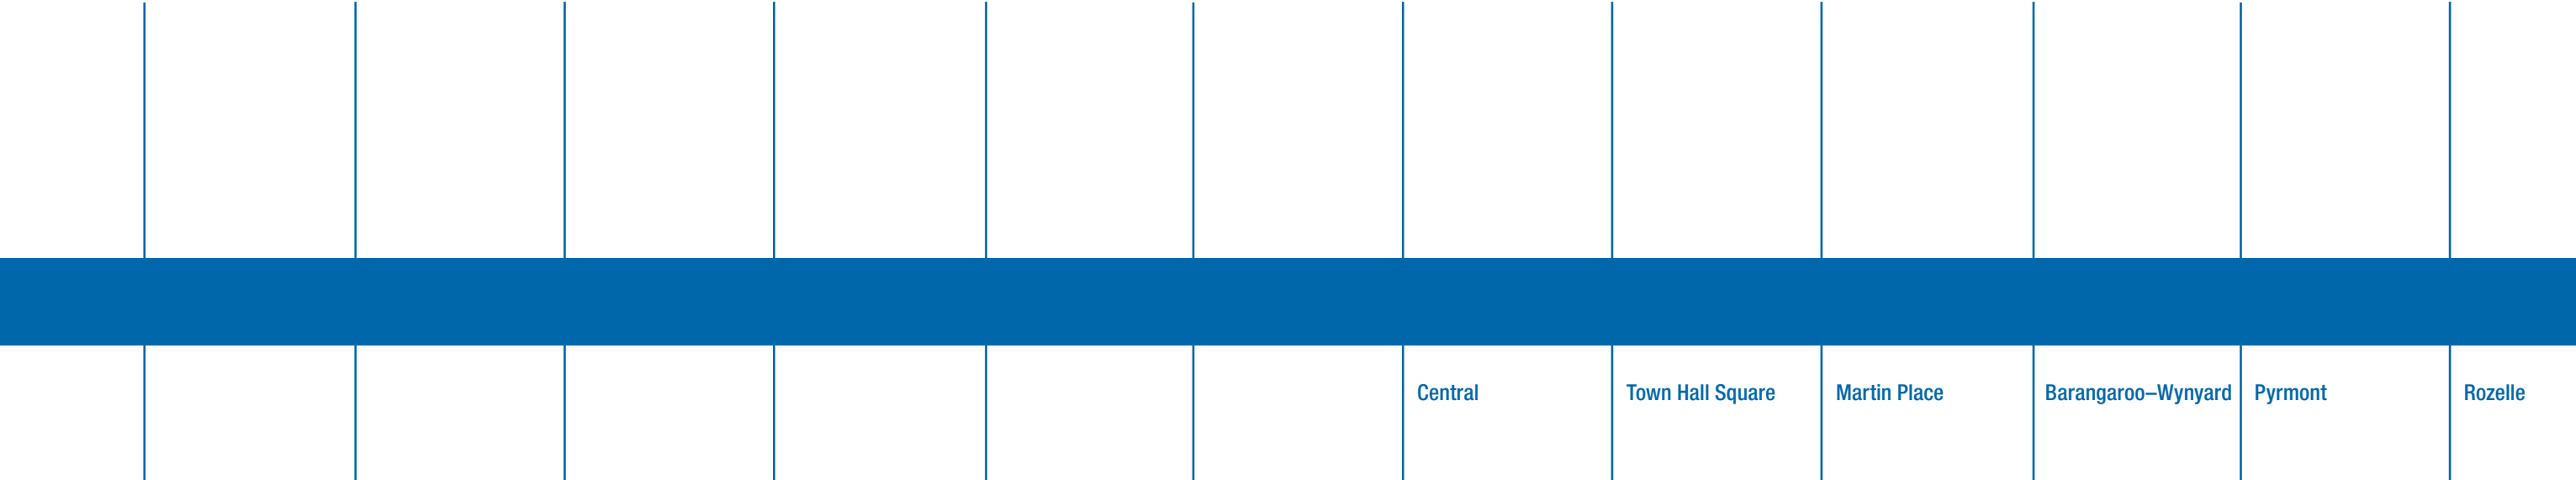

J:\2026\CBD METRO C2100\09_CAD\02 ARCHITECTURAL AR10800_LILYFIELD DEPOT\01 CAD\02 PLOT\01 REFERENCE RD0000_GENERAL\CB2100-02-0800-AR-0100.DWG 3/05/2009 5:48:27 PM

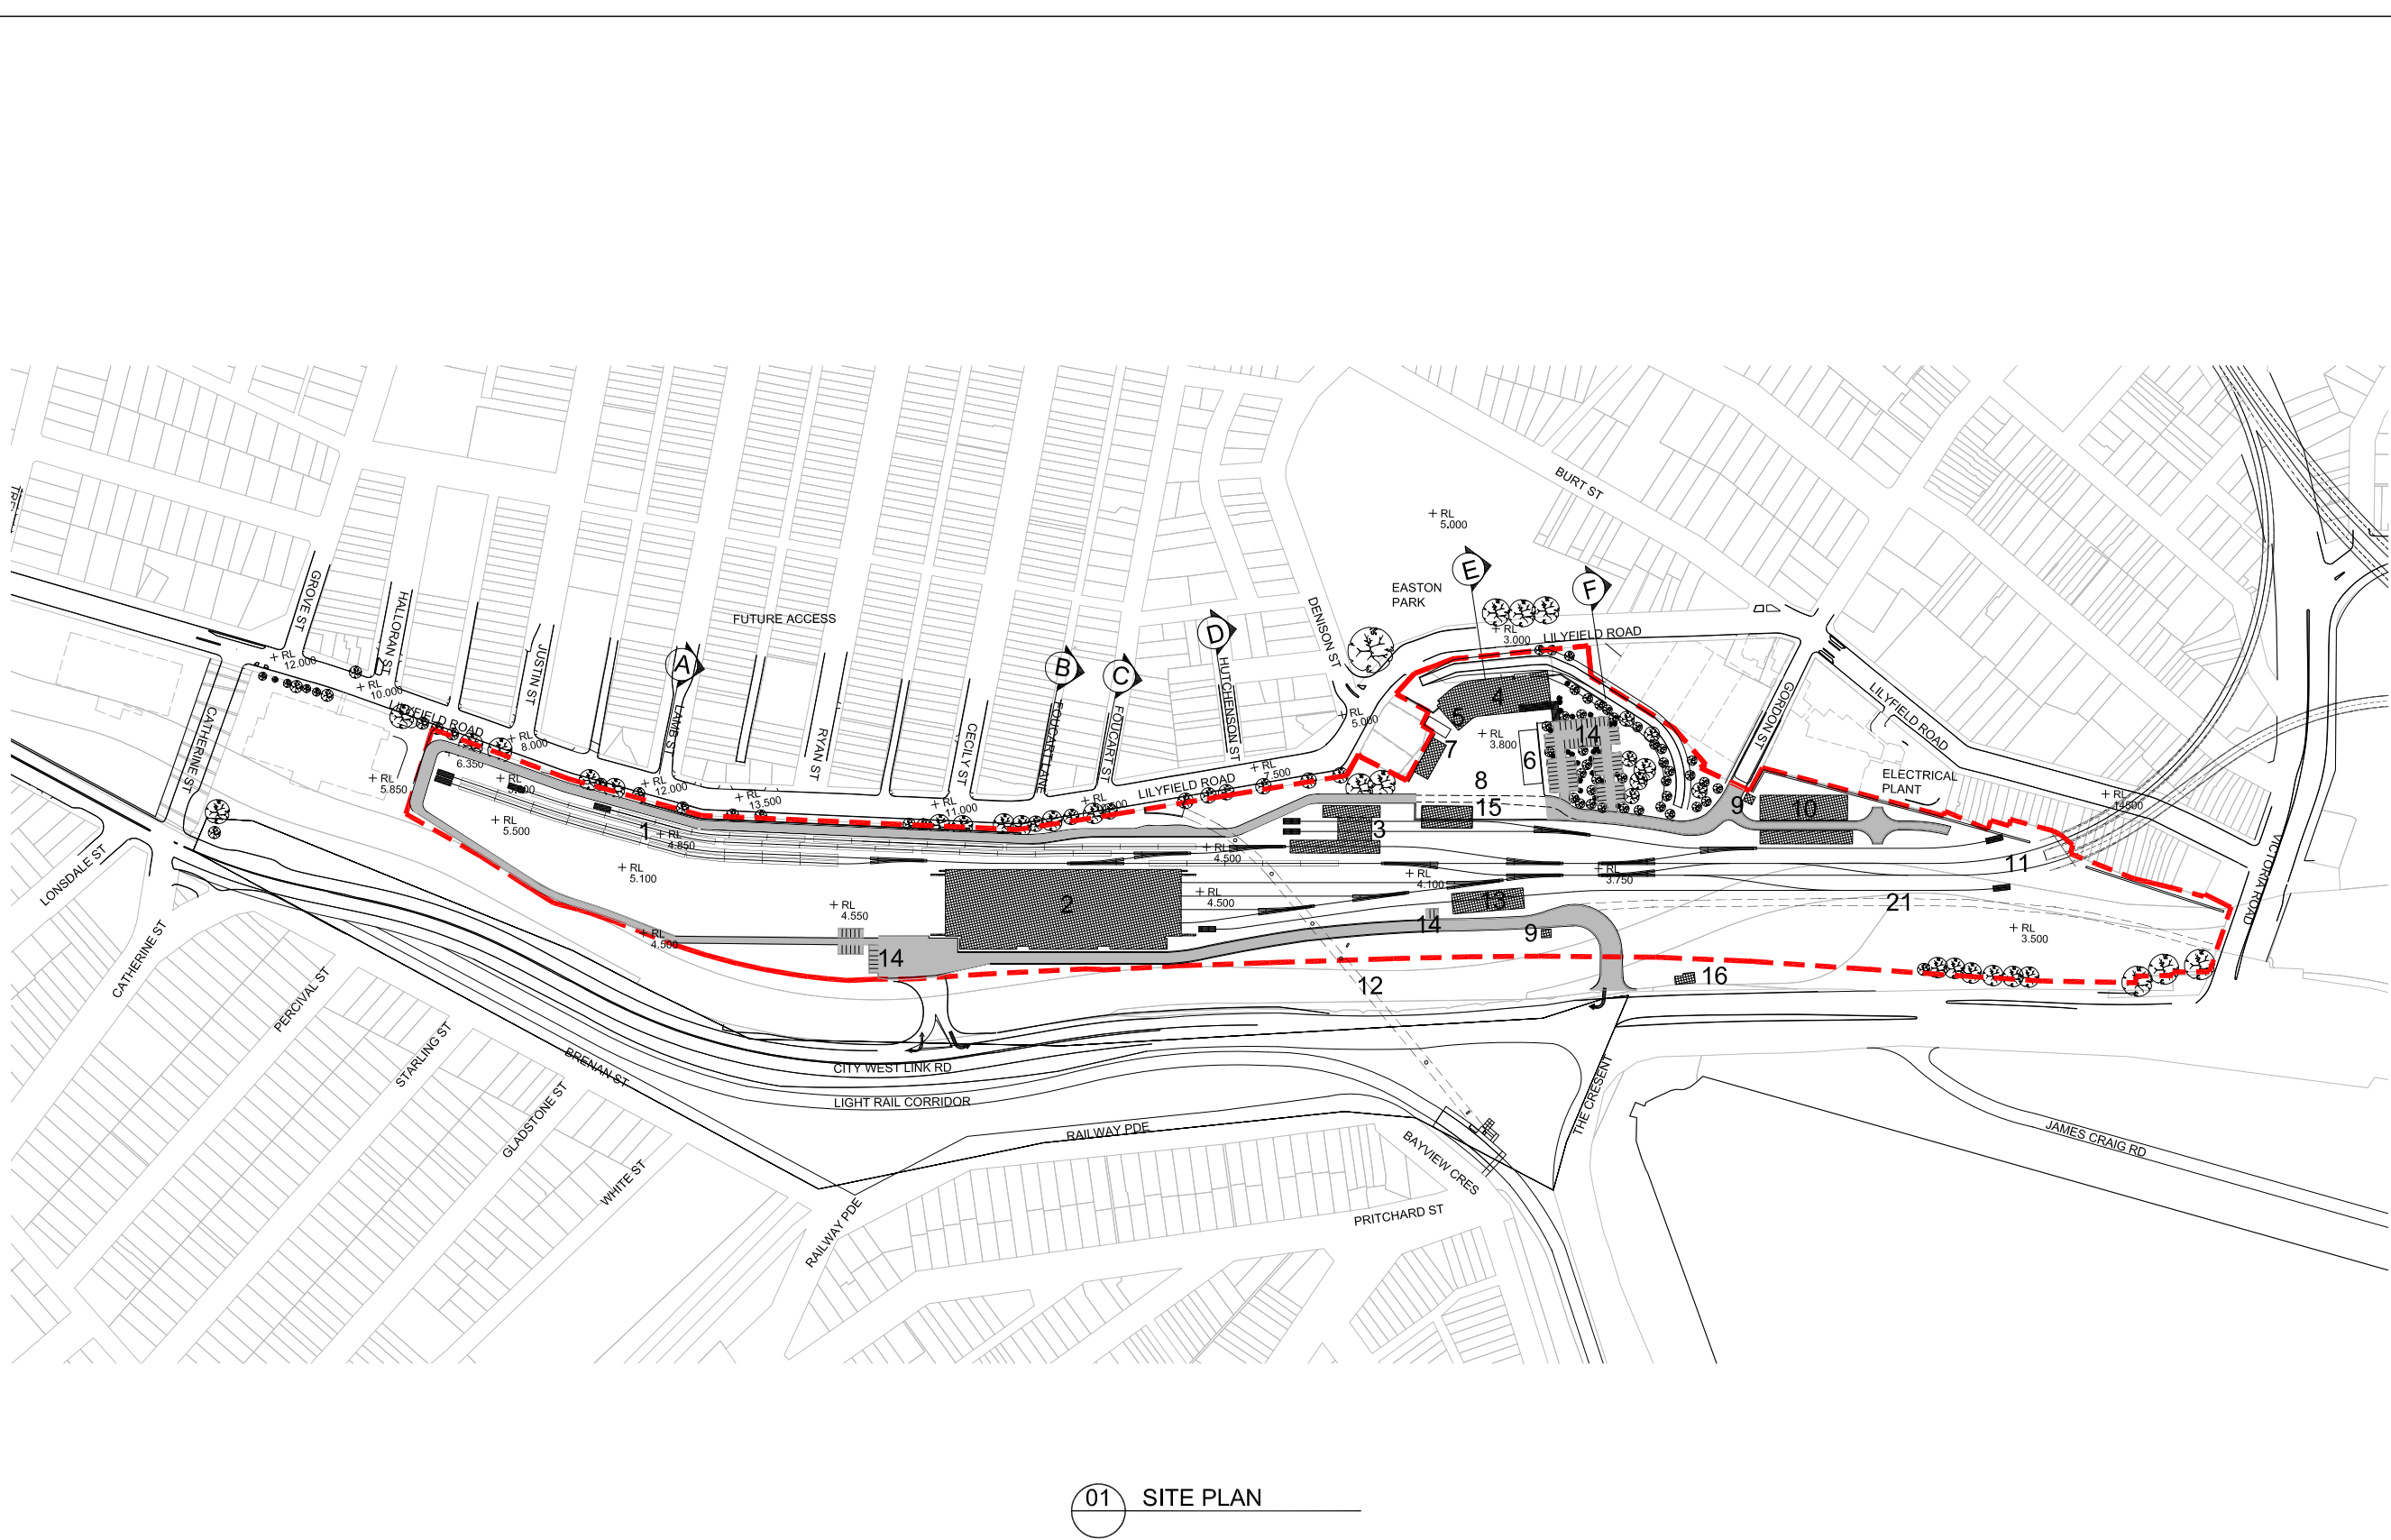


No	Key Plan
1	Train Stabling Area
2	Rolling Stock Maintenance Facility
3	Car Wash Maintenance Facility
4	Administration Building
5	Infrastructure Component Storage Area
6	Rail Storage Area
7	Infrastructure Vehicle Parking
8	Infrastructure Vehicle Marshalling Area
9	Security Office
10	Bulk Power Supply & Traction Power Substations
11	Portal
12	Pedestrian / Bicycle Bridge
13	Wheel Maintenance Facility
14	Car Parking Areas
15	Rail Lifting Gantry
16	Existing Rail Corp Bulk Power Building
17	Flood Water Retention Areas
18	Green Area
19	Planted Bioswales
20	Sedum
21	Future Access

01 SITE PLAN

THIS DRAWING IS INDICATIVE ONLY

01	18.08.09	ISSUED FOR EA	
00	28.07.09	REFERENCE DESIGN ISSUE	
No.	BY	DATE	DESCRIPTION
			APPD

 

THE INFORMATION SHOWN ON THIS DRAWING IS FOR THE PURPOSES OF THE CBD METRO PROJECT ONLY NO WARRANTY IS GIVEN OR IMPLIED AS TO ITS SUITABILITY FOR ANY OTHER PURPOSE.			
APPROVED ORIGINAL OF THIS DRAWING SIGNED & DATED AS INDICATED BELOW			
	PREPARED	CHECKED	PSC APPROVED
DESIGN	RJ		
	AT		ROSS DE LA MOTTE
			28.07.09 DATE
Scales 1:2000@A1 1:1000@A3			
0 20 40 60m			

Professional Services Contractor / Technical Advisor
PB ARUP COX HASSELL

Client

Project Title	CBD METRO		
Drawing Title	ROZELLE DEPOT SITE PLAN		
Status	FINAL	Dwg No.	CBD-2100-RD-0800-AR-0100
		Rev.	01



01		18.08.09	ISSUED FOR EA		
00		28.07.09	REFERENCE DESIGN ISSUE		
No.	BY	DATE	DESCRIPTION		APPD

THE INFORMATION SHOWN ON THIS DRAWING IS FOR THE PURPOSES OF THE CBD METRO PROJECT ONLY NO WARRANTY IS GIVEN OR IMPLIED AS TO ITS SUITABILITY FOR ANY OTHER PURPOSE			
APPROVED ORIGINAL OF THIS DRAWING SIGNED & DATED AS INDICATED BELOW			
DESIGN	PREPARED	CHECKED	PSC APPROVED  ROSS DE LA MOTTE 28.07.2017 DATE
Scales 1:250@A1			


Professional Services Contractor /
Technical Advisor

pboch
PR | ARUP | CDX | HASSELL

	Client
--	--------



Project Title	CBD METRO		
Drawing Title	ROZELLE DEPOT SITE SECTION A-A, B-B & C-C		
Status	FINAL	Dwg No.	CBD-2100-RD-0800-AR-0300

 

01		18.08.09	ISSUED FOR EA		
00		28.07.09	REFERENCE DESIGN ISSUE		
No.	BY	DATE	DESCRIPTION		APPD

A horizontal number line with tick marks at 0, 5, 10, and 15m. The segment between 5 and 10 is shaded with a light gray background.


pboch
PB | ARUP | COX | HASSELL




Dr. No. CBD-2100-BD-0800-AR-0301	
--	--

Rev.	
1	


J:\200864 CBD METRO C2100-09_CAD\02 ARCHITECTURAL\AR10800.ILL\FIELD DEPTOT\1 CAD\02 PLOT\01 REFERENCE RD1000_-500 OR 200 PLANS\ROLLING STOCK\CBD-2100-RD-0800-AR-1120.DWG 30/05/2009 5:48:27 PM

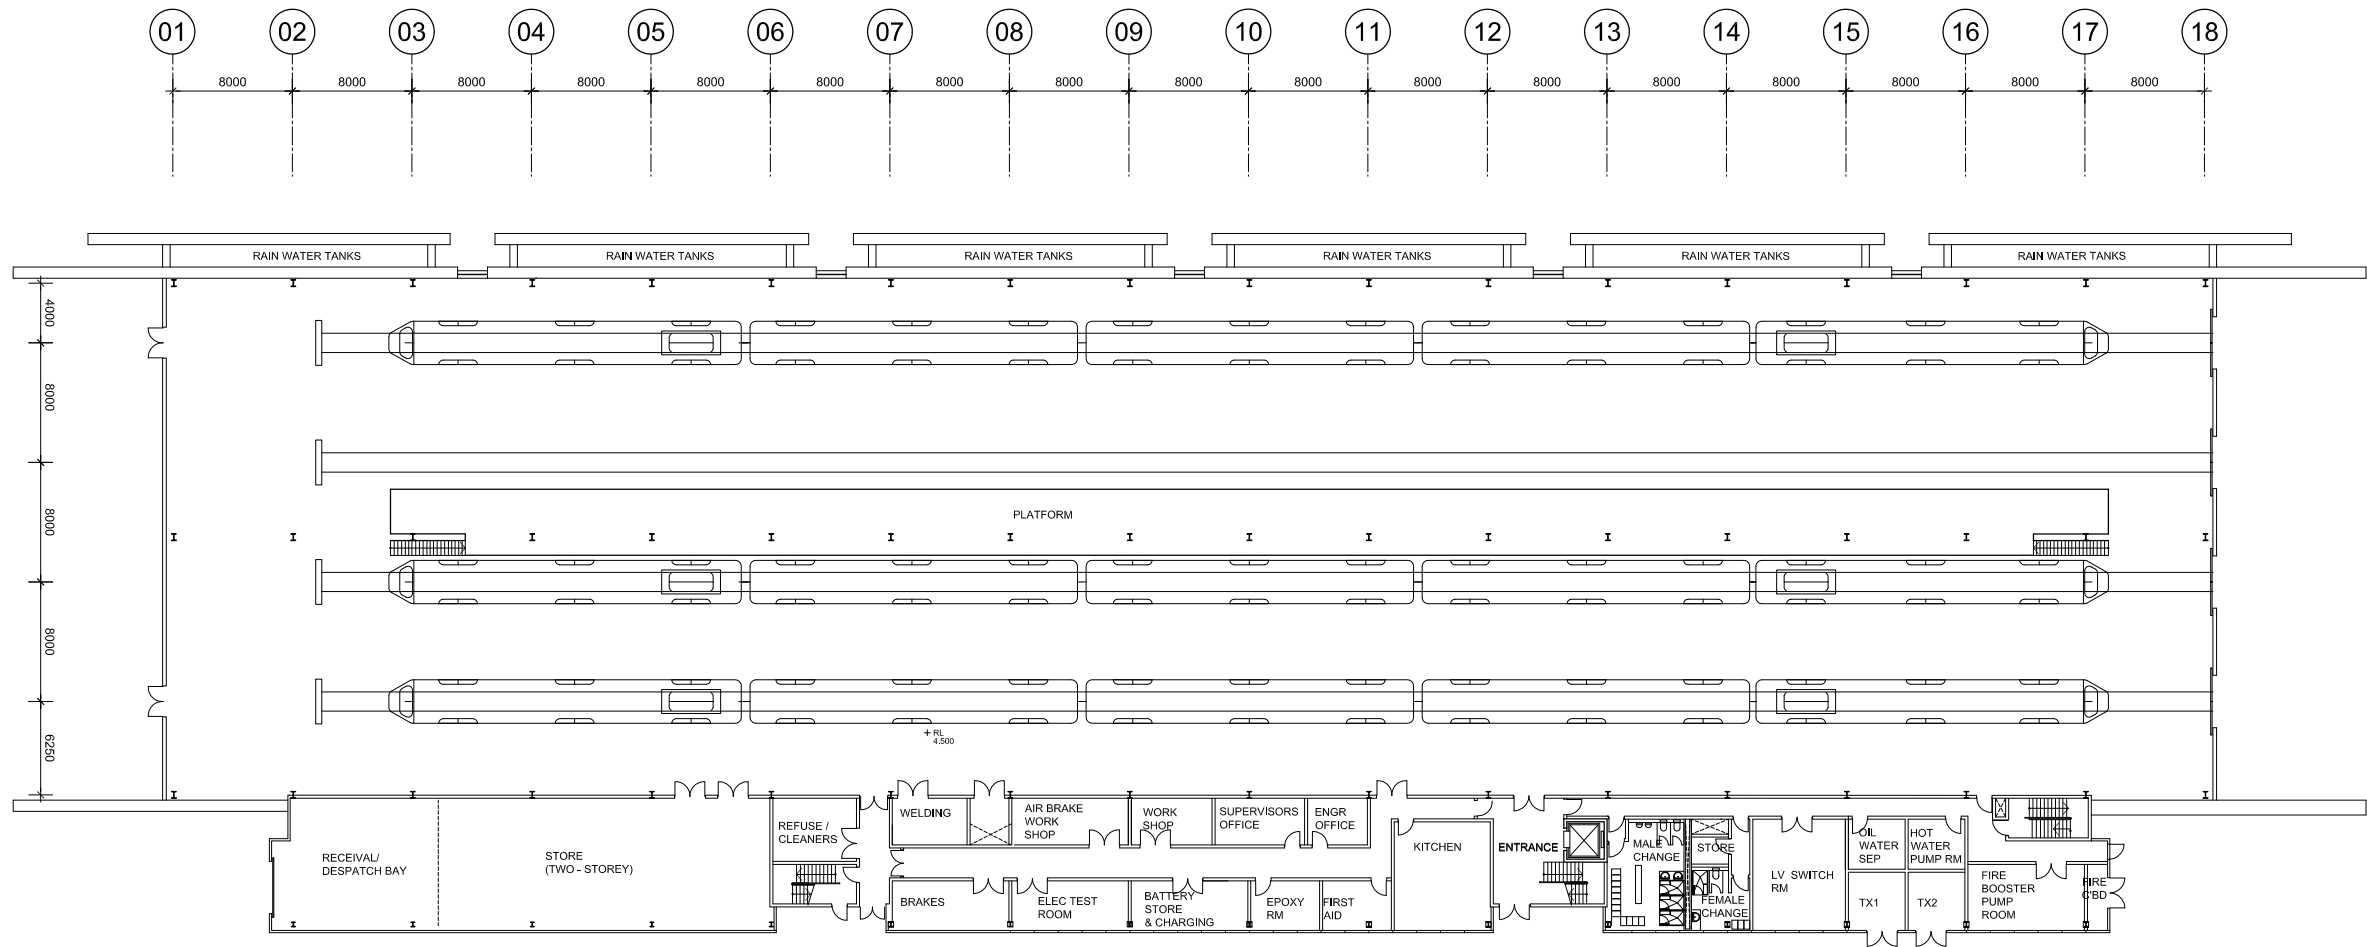

01 GROUND FLOOR PLAN

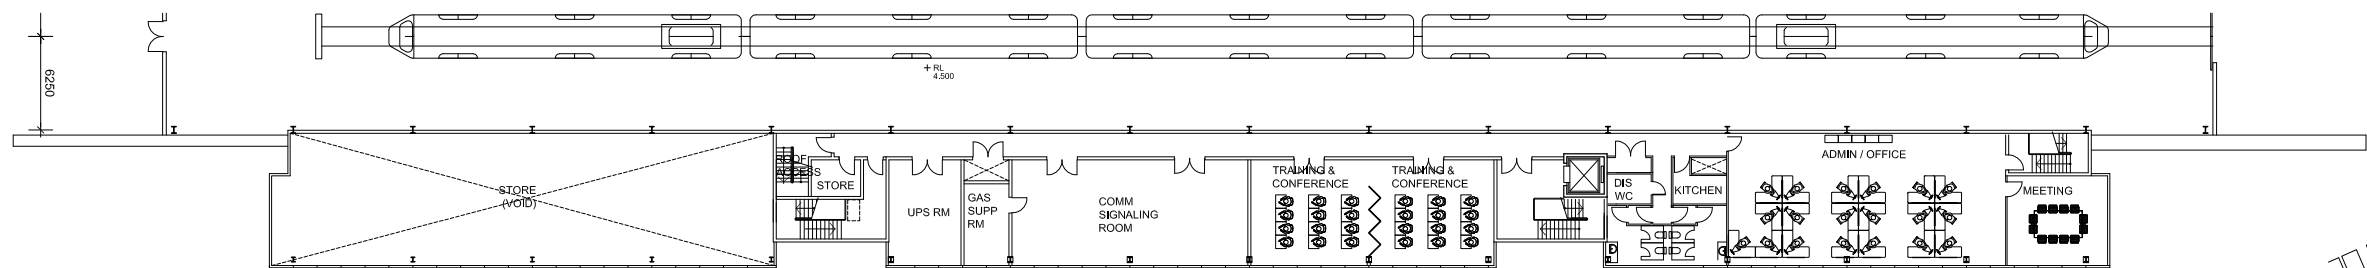

02 FIRST FLOOR PLAN

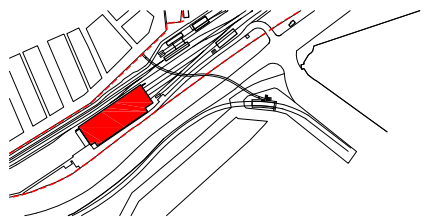

THIS DRAWING IS INDICATIVE ONLY

01	18.08.09	ISSUED FOR EA		
00	28.07.09	REFERENCE DESIGN ISSUE		
No.	BY	DATE	DESCRIPTION	APPD



THE INFORMATION SHOWN ON THIS DRAWING IS FOR THE PURPOSES OF THE CBD METRO PROJECT ONLY NO WARRANTY IS GIVEN OR IMPLIED AS TO ITS SUITABILITY FOR ANY OTHER PURPOSE.		
APPROVED ORIGINAL OF THIS DRAWING SIGNED & DATED AS INDICATED BELOW		
DESIGN	PREPARED	CHECKED
		PSC APPROVED
		ROSS DE LA MOTTE
		28.07.09 DATE
Scales 1:250@A1		
0 5 10 15m		

Professional Services Contractor /
Technical Advisor

pbach
PB | ARUP | COX | HASSELL

Client

SydneyMetro


Project Title
CBD METRO

Drawing Title
**ROZELLE DEPOT
ROLLING STOCK MAINTENANCE -
GROUND & FIRST FLOOR PLANS**


Status
FINAL

Dwg No.
CBD-2100-RD-0800-AR-1120

Rev.
01

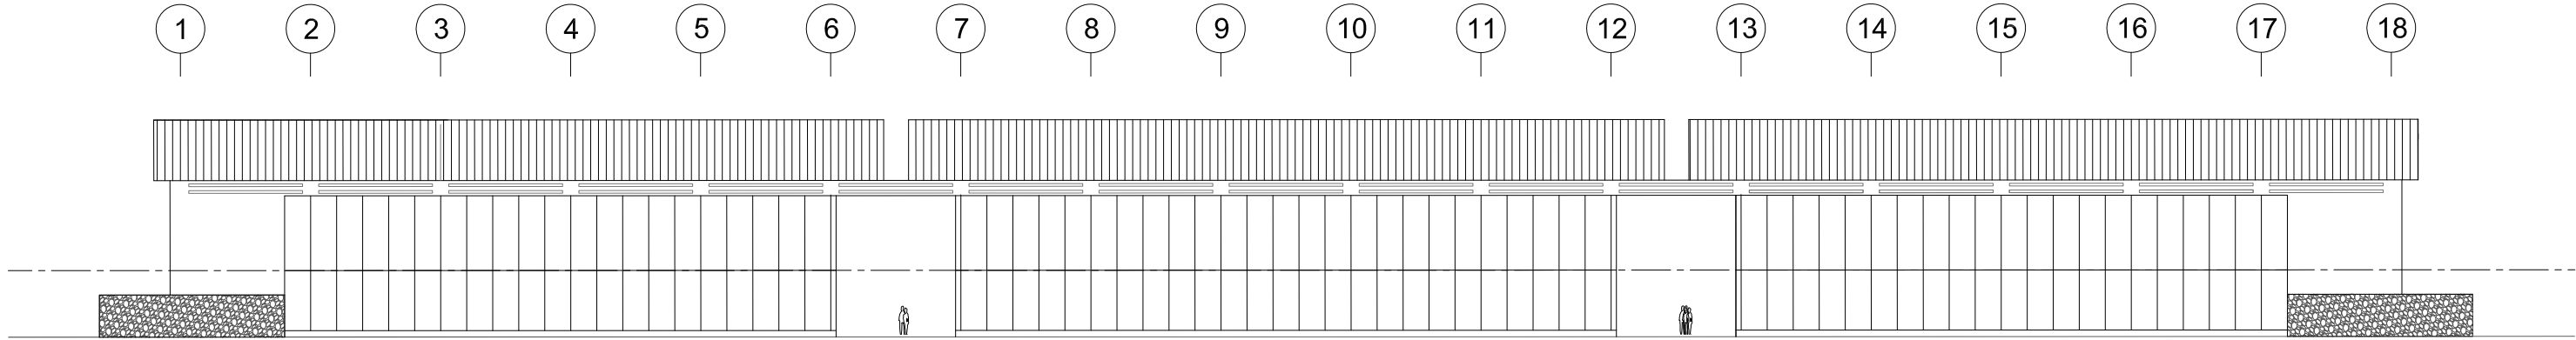


01 ROLLING STOCK BUILDING - SOUTH ELEVATION

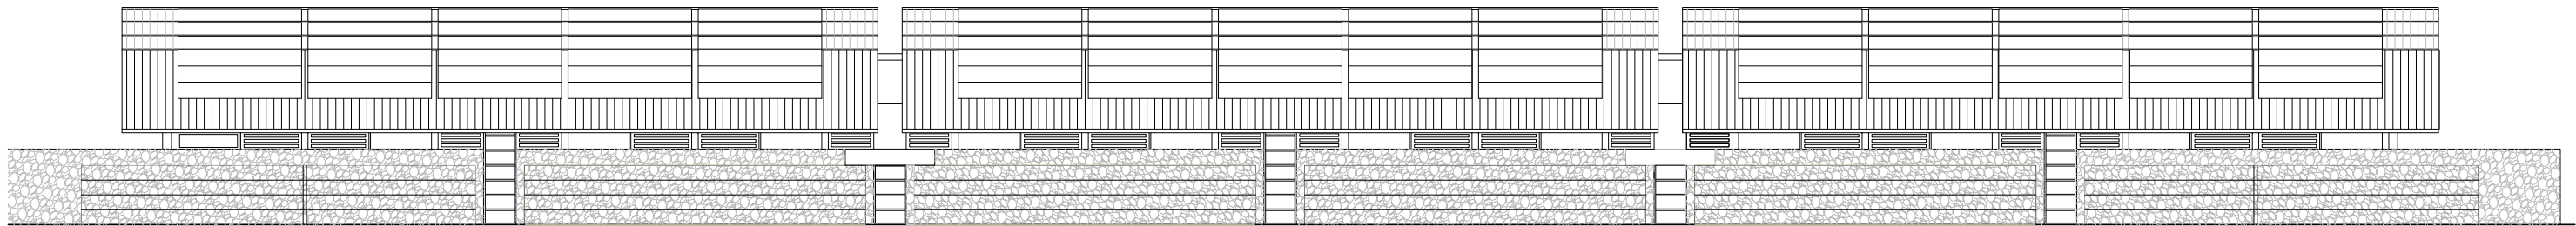

02 ROLLING STOCK BUILDING - NORTH ELEVATION

- LEGEND
- 1 GABION WALL
 - 2 STONE WALL
 - 3 METAL CLADDING
 - 4 LOUVRES
 - 5 GLAZING
 - 6 POLYCARBONATE

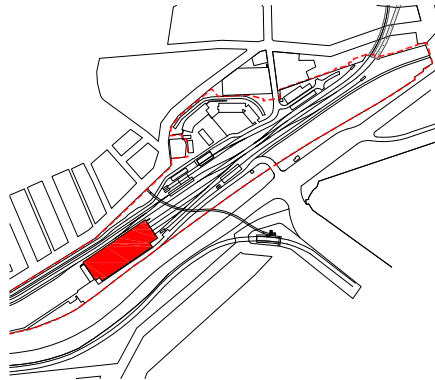

THIS DRAWING IS INDICATIVE ONLY

01		18 08 09	ISSUED FOR EA	
00		28.07.09	REFERENCE DESIGN ISSUE	
No.	BY	DATE	DESCRIPTION	APPD


THE INFORMATION SHOWN ON THIS DRAWING IS FOR THE PURPOSES OF THE CBD METRO PROJECT ONLY NO WARRANTY IS GIVEN OR IMPLIED AS TO ITS SUITABILITY FOR ANY OTHER PURPOSE.			
APPROVED ORIGINAL OF THIS DRAWING SIGNED & DATED AS INDICATED BELOW			
	PREPARED	CHECKED	PSC APPROVED
DESIGN	AT		
	EH		ROSS DE LA MOTTE
			28.07.09 DATE
Scales 1:200@A1			
0 2 4 6m			

Professional Services Contractor /
Technical Advisor


PB | ARUP | COX | HASSELL

Client

Project Title CBD METRO		
Drawing Title ROZELLE DEPOT ROLLING STOCK BUILDING - ELEVATIONS		
Status FINAL	Dwg No. CBD-2100-RD-0800-AR-1130	Rev. 01

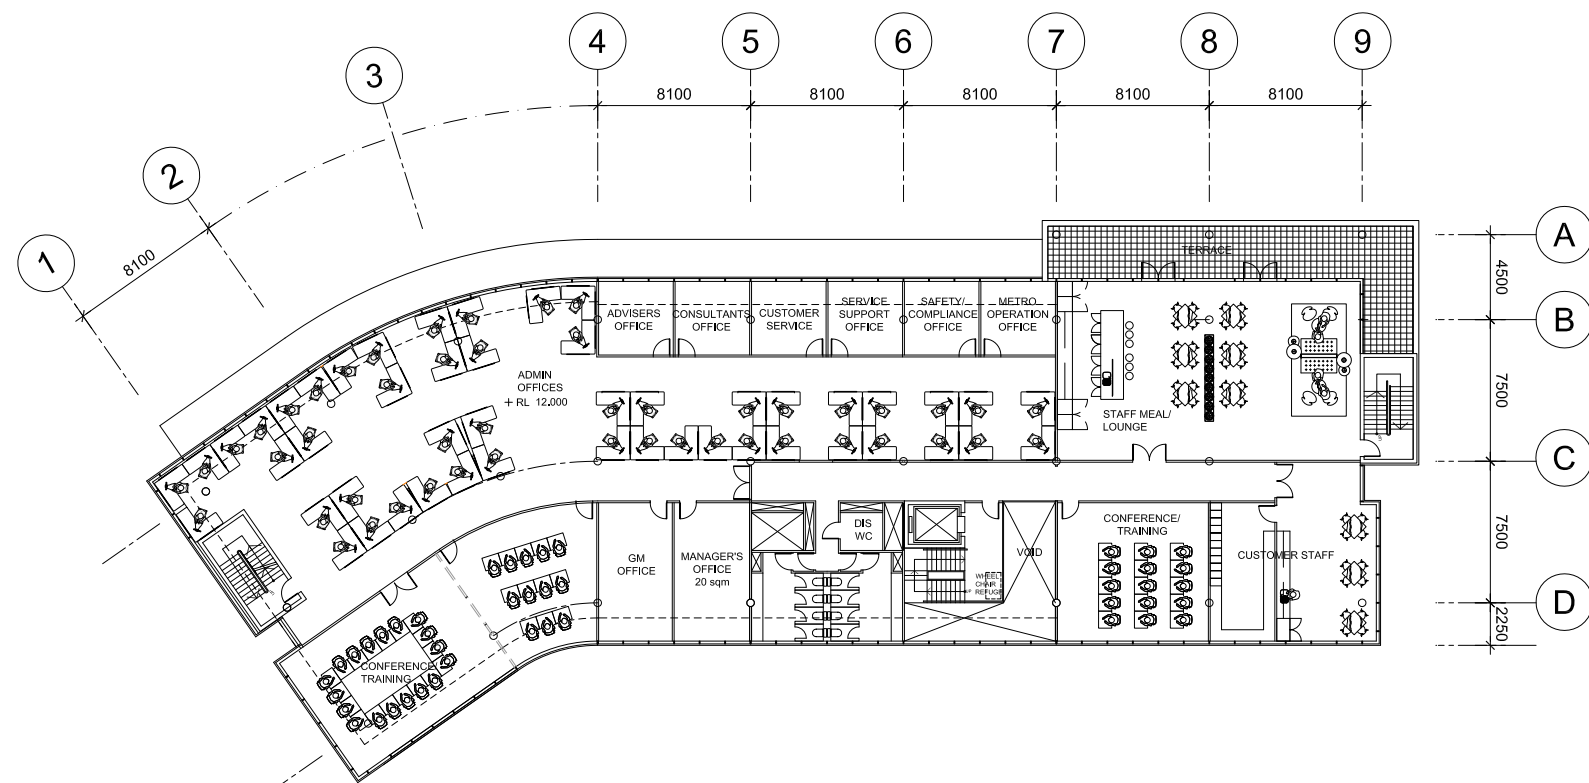


02 ADMIN/ MAINTENANCE INFRASTRUCTURE - LEVEL 1 PLAN

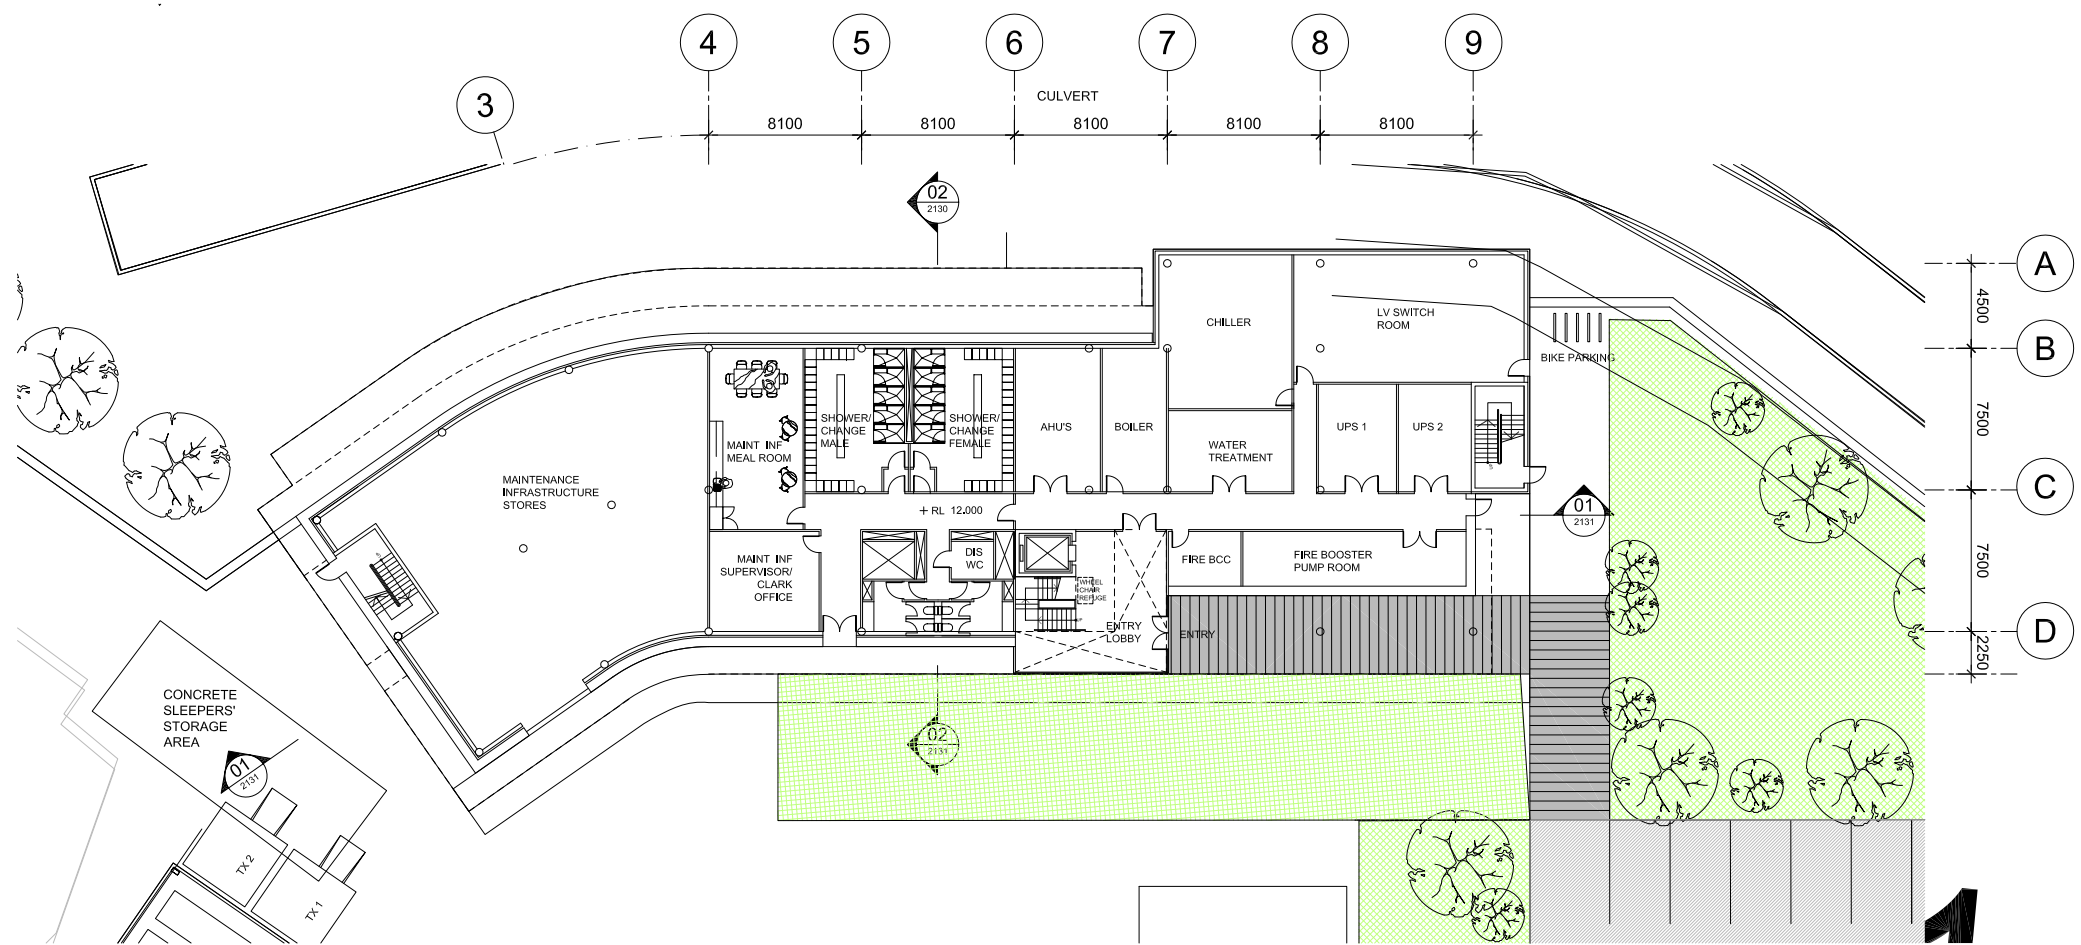

01 ADMIN/ MAINTENANCE INFRASTRUCTURE - GROUND FLOOR PLAN

Rm No	Room Name
ADMIN / MAINTENANCE Building	
1	Entry Lobby
2	Maintenance Infrastructure store
3	Maint Inf supervisor office
4	Maint Inf meal room
5	Fire BBC
6	Fire Booster pump room
7	LV Switch Room
8	Chiller Room
9	Water Treatment Room
10	Boiler Room
11	AHU's Room
12	UPS 1
13	UPS 2
14	Main Inf Change room (male)
15	Main Inf Change room (Female)
16	Conference/ Training Room
17	Customer Staff Room
18	Staff Meal Lounge
19	Admin Offices
20	Advisers Office
21	Consultants Office
22	Customers Office
23	Service Support Office
24	Safety/ Compliance Office
25	Metro Operation Office
26	GM Office
27	Manager's Office
28	Terrace
29	Admin/ Facility Room
30	Incident Control Room
31	Visitors Gallery
32	Staff Meal Room
33	Tech Room 1
34	Tech Room 2
35	Gas SPP
36	Spare Office

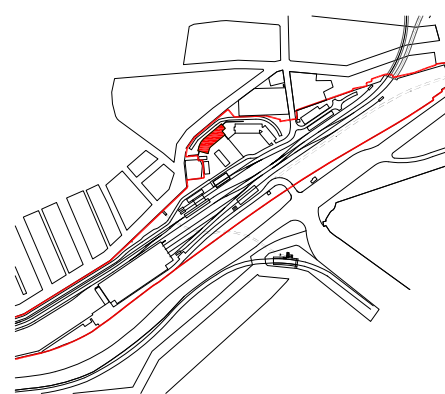

THIS DRAWING IS INDICATIVE ONLY

No.	BY	DATE	DESCRIPTION	APPD
01		18.08.09	ISSUED FOR EA	
00		28.07.09	REFERENCE DESIGN ISSUE	

THE INFORMATION SHOWN ON THIS DRAWING IS FOR THE PURPOSES OF THE CBD METRO PROJECT ONLY
NO WARRANTY IS GIVEN OR IMPLIED AS TO ITS SUITABILITY FOR ANY OTHER PURPOSE.

APPROVED ORIGINAL OF THIS DRAWING SIGNED & DATED AS INDICATED BELOW

DESIGN	PREPARED	CHECKED	PSC APPROVED
			ROSS DE LA MOTTE
			28.07.09
			DATE

Scales 1:200@A1

0 2 4 6m

Professional Services Contractor / Technical Advisor

Client

Project Title

CBD METRO

Drawing Title

ROZELLE DEPOT
ADMIN/ MAINTENANCE INFRASTRUCTURE
- GROUND & LEVEL 1 PLAN

Status

FINAL


Org No

CBD-2100-RD-0800-AR-2121

Rev

01


J:\2008\4 CBD METRO\2100\9 CAD\02 ARCHITECTURAL\AR0800\11\FIELD DEPOT\01 CAD\02 PLOT\02 REFERENCE RD1000_1-500 OR 200 PLANS\ADMIN BUILDING\02\2100-RD-0800-AR-2121.DWG - 30/05/2009 5:46:27 PM

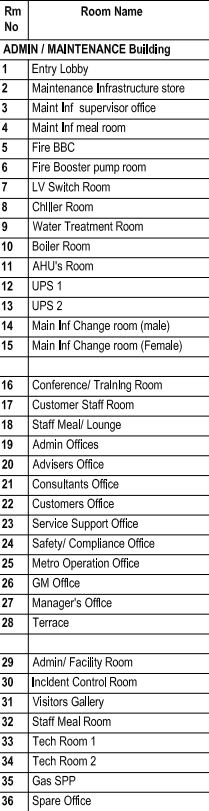

Architectural floor plan of a building. The plan features a curved roof structure and a rectangular plant room on the right side. The plan is overlaid with a grid system. Vertical grid lines are numbered 1 through 9 from left to right. Horizontal grid lines are lettered A through D from top to bottom. Dimensions are indicated for various segments: horizontal segments between grid lines 1-2, 2-3, 3-4, 4-5, 5-6, 6-7, 7-8, and 8-9 are all 8100. Vertical segments are dimensioned as follows: 4500 between A and B, 7500 between B and C, 7500 between C and D, and 2250 below D. The plant room is located between grid lines 7 and 8, and between horizontal lines C and D. It contains three rectangular units. The roof area is labeled 'ROOF'. The building's footprint is defined by a curved outer boundary and a straight inner boundary. A dashed line connects grid line 1 to the roof edge, and another dashed line connects grid line 3 to the roof edge. The plant room is connected to the main building structure by a series of lines.

THIS DRAWING IS INDICATIVE ONLY

01		18.08.09	ISSUED FOR EA		
00		28.07.09	REFERENCE DESIGN ISSUE		
No.	BY	DATE	DESCRIPTION		APPD

 

THE INFORMATION SHOWN ON THIS DRAWING IS FOR THE PURPOSES OF THE CBD MTRP PROJECT ONLY
NO WARRANTY IS GIVEN OR IMPLIED AS TO ITS SUITABILITY FOR ANY OTHER PURPOSE.

APPROVED ORIGINAL OF THIS DRAWING SIGNED & DATED AS INDICATED BELOW

	PREPARED	CHECKED	PSC APPROVED
DESIGN			 ROSS DE LA MOTTE 28.07.09 DATE
Scales 1:200@A1			

Professional Services Contractor / Technical Advisor




Project Title	CBD METRO
---------------	-----------

Drawing Title
 ROZELLE DEPOT
 ADMIN/ MAINTENANCE INFRASTRUCTURE
 - LEVEL 2 & ROOF PLAN


Status	FINAL
--------	-------

Drg No.
CBD-2100-BD-0800-AB-2122


1

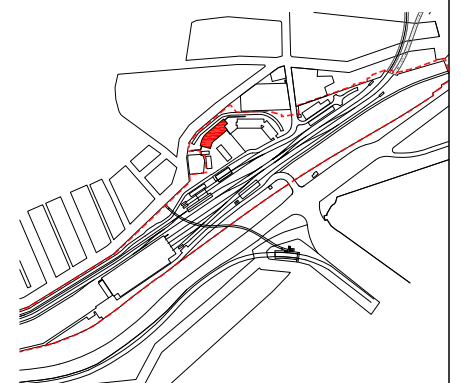


J:\2026\ CBD METRO 021009\ CAD\02 ARCHITECTURAL\ AR0800\ LLYFIELD DEPOT\01 CAD\02 ELEVATIONS\03\ADMIN BUILDING\02-103-00-0800-AR-2130.DWG 20/05/2019 04:46:27 PM

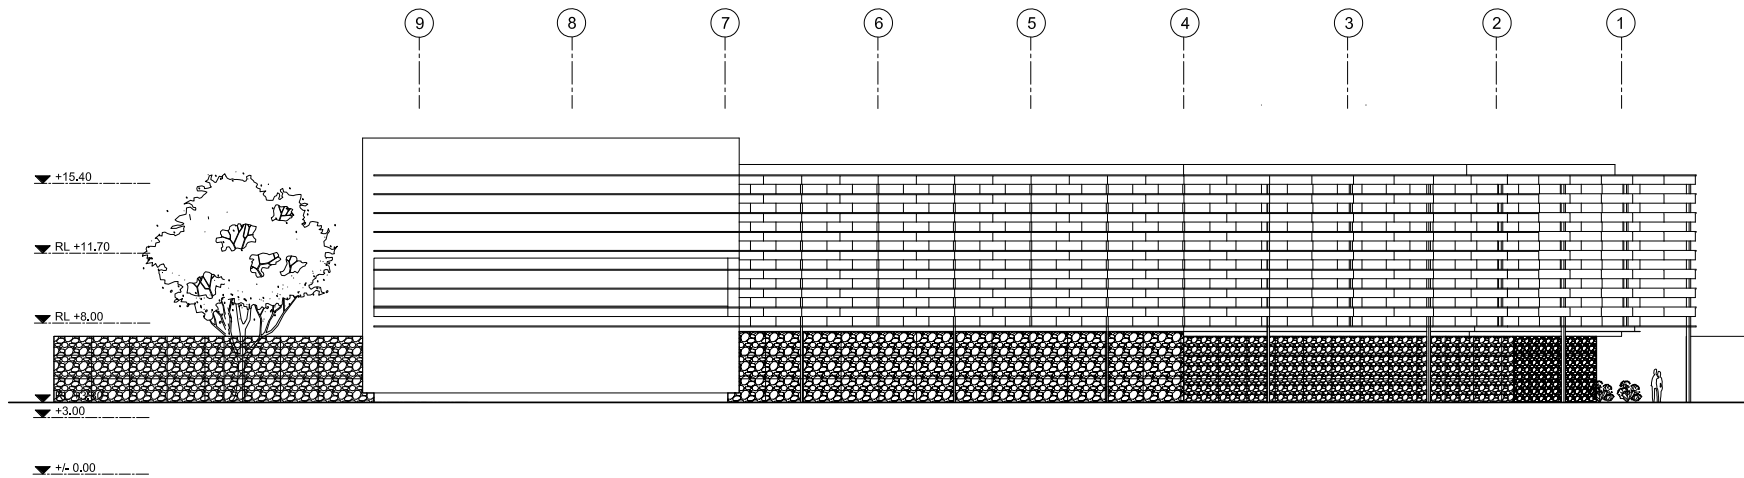


01 ADMIN BUILDING NORTH ELEVATION

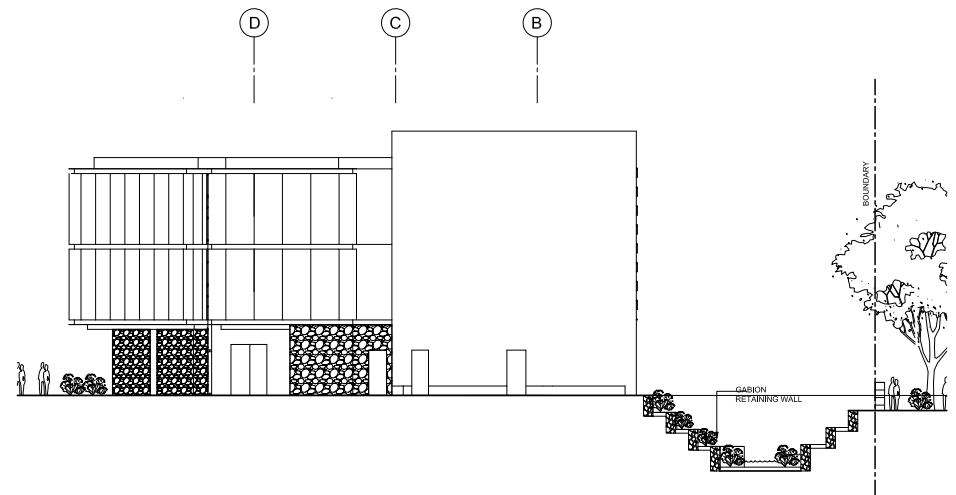

02 ADMIN BUILDING EAST ELEVATION

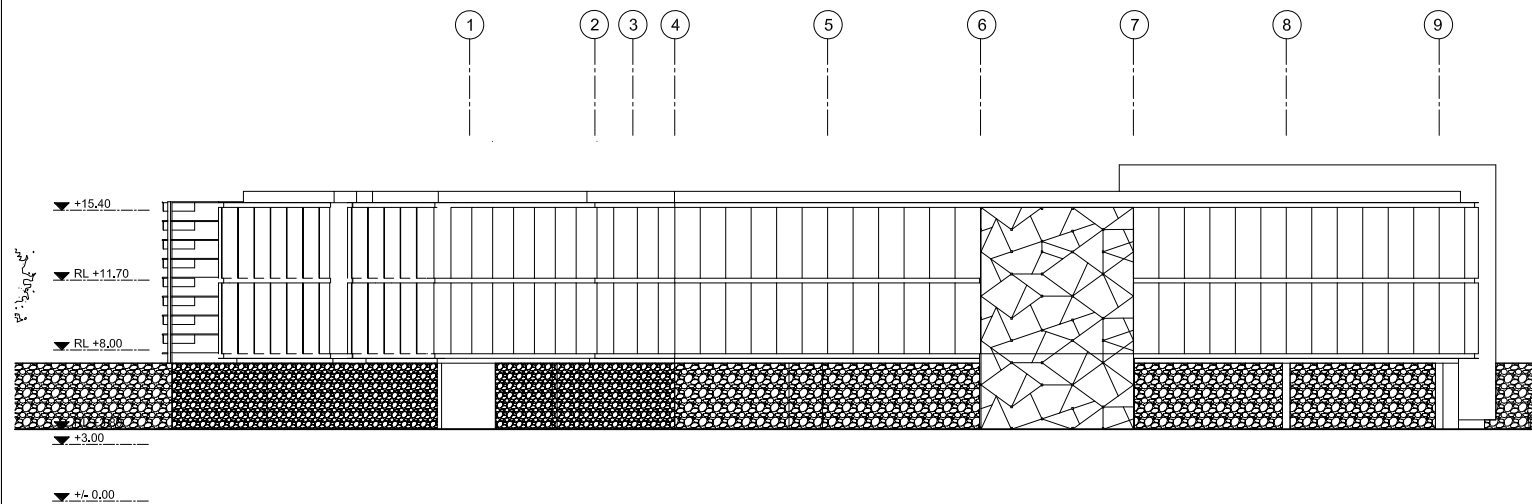


03 ADMIN BUILDING SOUTH ELEVATION

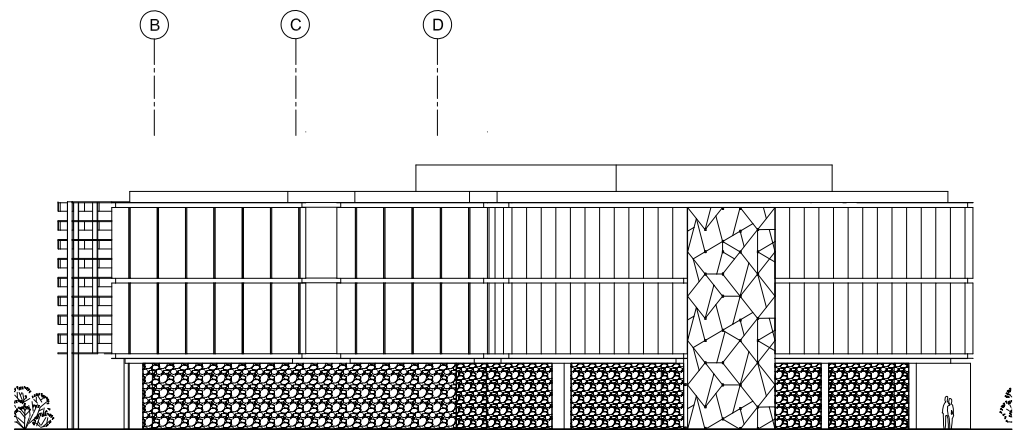

04 ADMIN BUILDING WEST ELEVATION


Rm No	Room Name
ADMIN / MAINTENANCE BUILDING	
1	Entry Lobby
2	Maintenance Infrastructure store
3	Maint Inf supervisor office
4	Maint Inf meal room
5	Fire BBC
6	Fire Booster pump room
7	LV Switch Room
8	Chiller Room
9	Water Treatment Room
10	Boiler Room
11	AHU's Room
12	UPS 1
13	UPS 2
14	Main Inf Change room (male)
15	Main Inf Change room (Female)
16	Conference/ Training Room
17	Customer Staff Room
18	Staff Meal/ Lounge
19	Admin Offices
20	Advisers Office
21	Consultants Office
22	Customers Office
23	Service Support Office
24	Safety/ Compliance Office
25	Metro Operation Office
26	GM Office
27	Manager's Office
28	Terrace
29	Admin/ Facility Room
30	Incident Control Room
31	Visitors Gallery
32	Staff Meal Room
33	Tech Room 1
34	Tech Room 2
35	Gas SPP
36	Spare Office

- LEGEND
- 1 GABION WALL
 - 2 STONE WALL
 - 3 METAL CLADDING
 - 4 LOUVRES
 - 5 GLAZING
 - 6 POLYCARBONATE

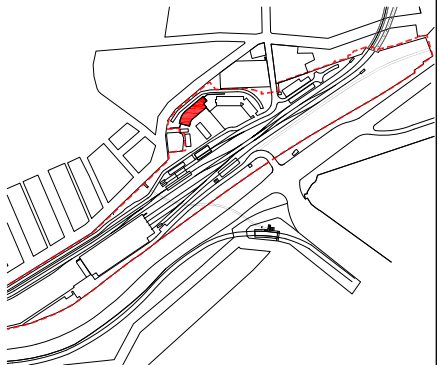

THIS DRAWING IS INDICATIVE ONLY

No.	BY	DATE	DESCRIPTION	APPD
01		18.08.09	ISSUED FOR EA	
00		28.07.09	REFERENCE DESIGN ISSUE	

 

THE INFORMATION SHOWN ON THIS DRAWING IS FOR THE PURPOSES OF THE CBD METRO PROJECT ONLY NO WARRANTY IS GIVEN OR IMPLIED AS TO ITS SUITABILITY FOR ANY OTHER PURPOSE.		
APPROVED ORIGINAL OF THIS DRAWING SIGNED & DATED AS INDICATED BELOW		
DESIGN	PREPARED	CHECKED
Scales 1:200@A1		0 2 4 6m


Professional Services Contractor /
Technical Advisor




Client




Project Title CBD METRO		
Drawing Title ROZELLE DEPOT ADMINISTRATION & MAINTENANCE INFRASTRUCTURE BUILDING - ELEVATIONS		
Status FINAL	Org No CBD-2100-RD-0800-AR-2130	Rev 01

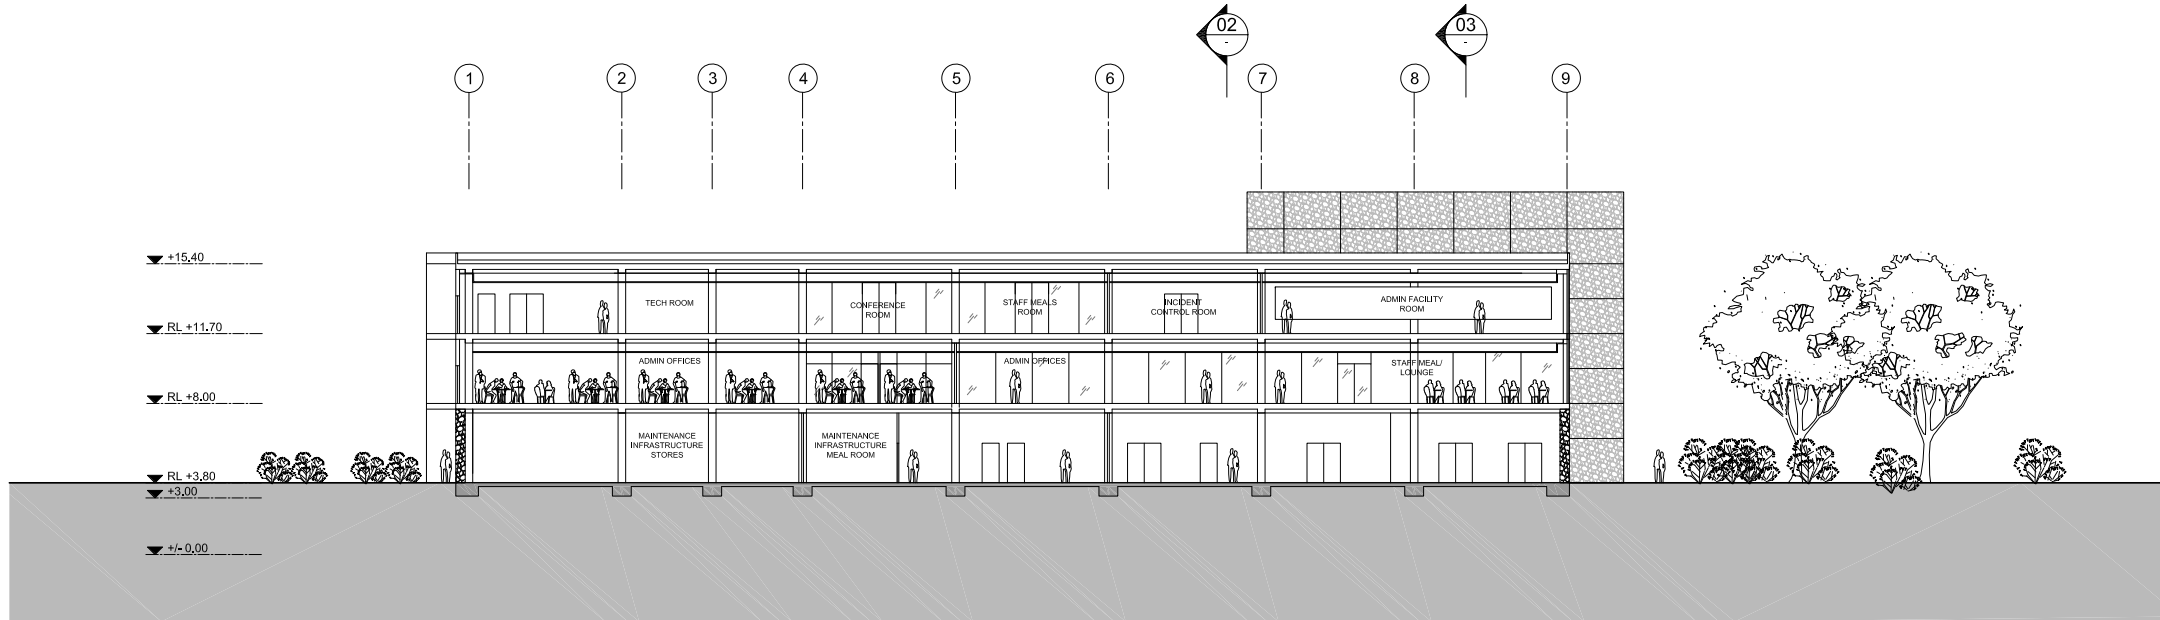

01 ADMIN/ MAINTENANCE INFRASTRUCTURE - SECTION A-A
2120

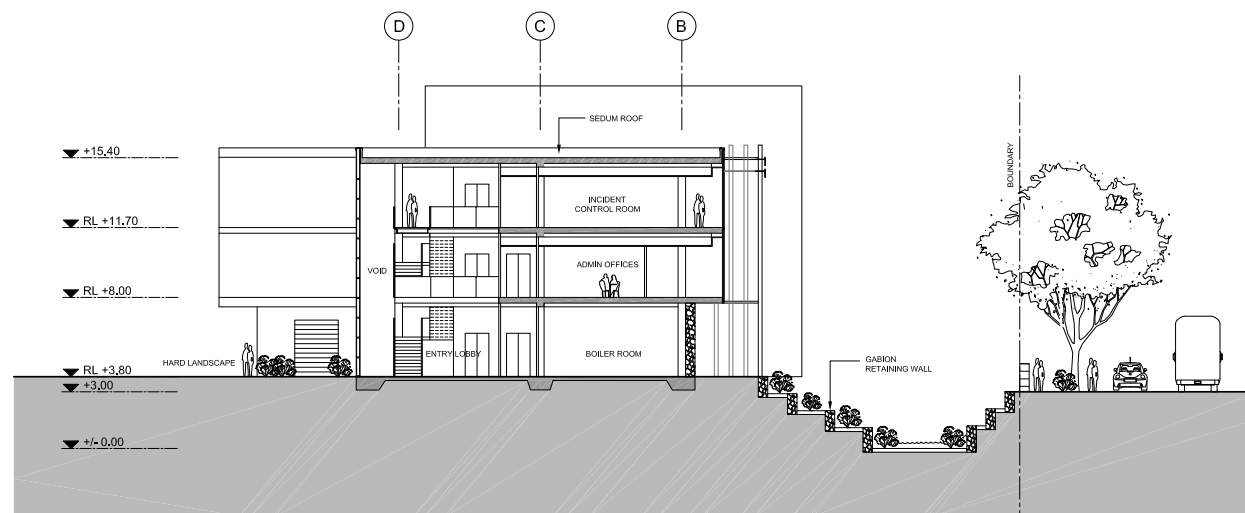


02 ADMIN/ MAINTENANCE INFRASTRUCTURE - SECTION B-B
2120

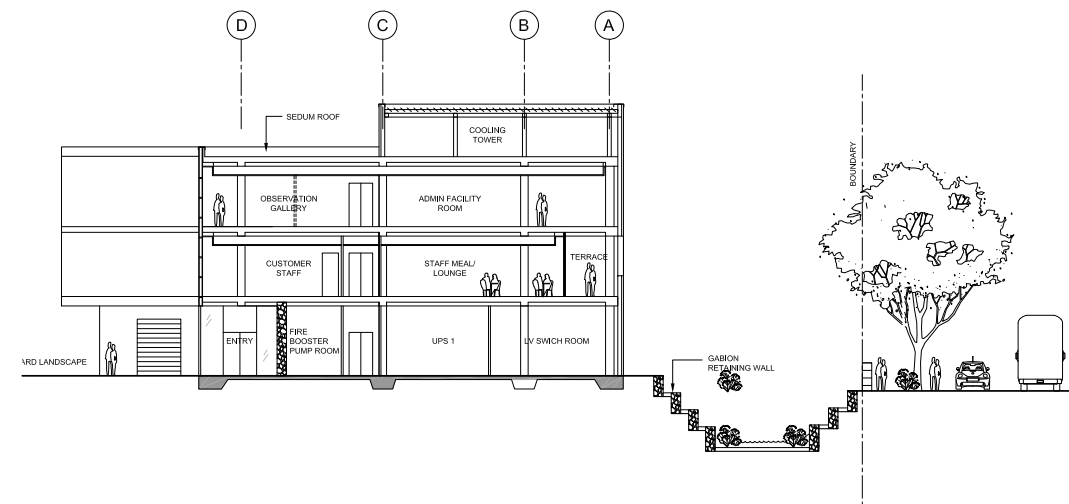


03 ADMIN/ MAINTENANCE INFRASTRUCTURE - SECTION C-C
2120

- LEGEND
- 1 GABION WALL
 - 2 STONE WALL
 - 3 METAL CLADDING
 - 4 LOUVRES
 - 5 GLAZING
 - 6 POLYCARBONATE

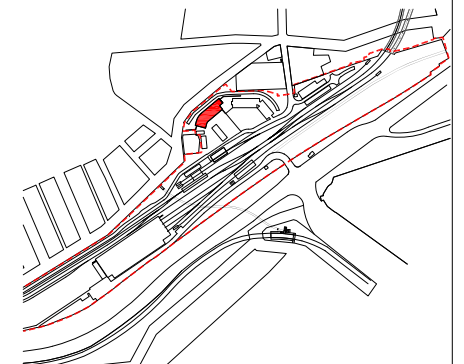

THIS DRAWING IS INDICATIVE ONLY

No.	BY	DATE	DESCRIPTION	APPD
01		18.08.09	ISSUED FOR EA	
00		28.07.09	REFERENCE DESIGN ISSUE	

 


THE INFORMATION SHOWN ON THIS DRAWING IS FOR THE PURPOSES OF THE CBD METRO PROJECT ONLY NO WARRANTY IS GIVEN OR IMPLIED AS TO ITS SUITABILITY FOR ANY OTHER PURPOSE. APPROVED ORIGINAL OF THIS DRAWING SIGNED & DATED AS INDICATED BELOW			
DESIGN	PREPARED	CHECKED	PSC APPROVED
			<i>[Signature]</i>
			ROSS DE LA MOTTE
			28.07.09
			DATE
Scales 1:200@A1			
0 2 4 6m			

Professional Services Contractor / Technical Advisor
pboch PB ARUP COX HASSELL


Client
SydneyMetro

Project Title	CBD METRO		
Drawing Title	ROZELLE DEPOT ADMINISTRATION & MAINTENANCE INFRASTRUCTURE BUILDING - SECTION A-A & B-B		
Status	FINAL	Dwg No.	CBD-2100-RD-0800-AR-2131
		Rev	01

Rm No	Room Name
Car Wash Building	
1	Car Wash
2	Maintenance Area
3	Treatment Plant
4	Recycling Sump
5	Pump Room

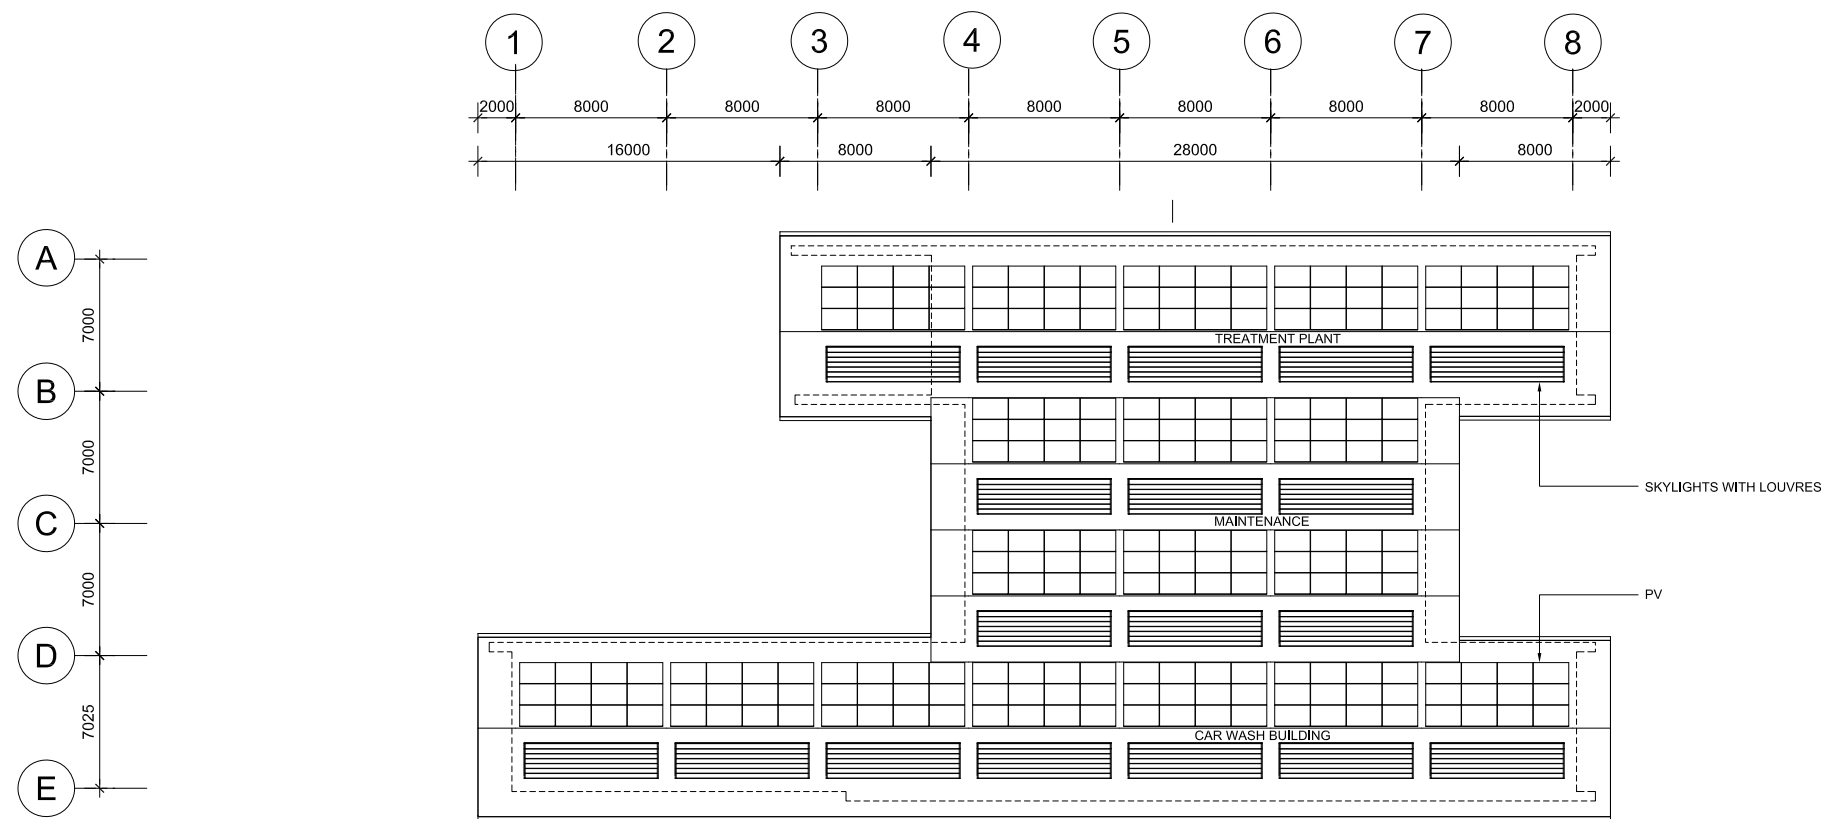


02 CAR WASH PLANT - ROOF PLAN

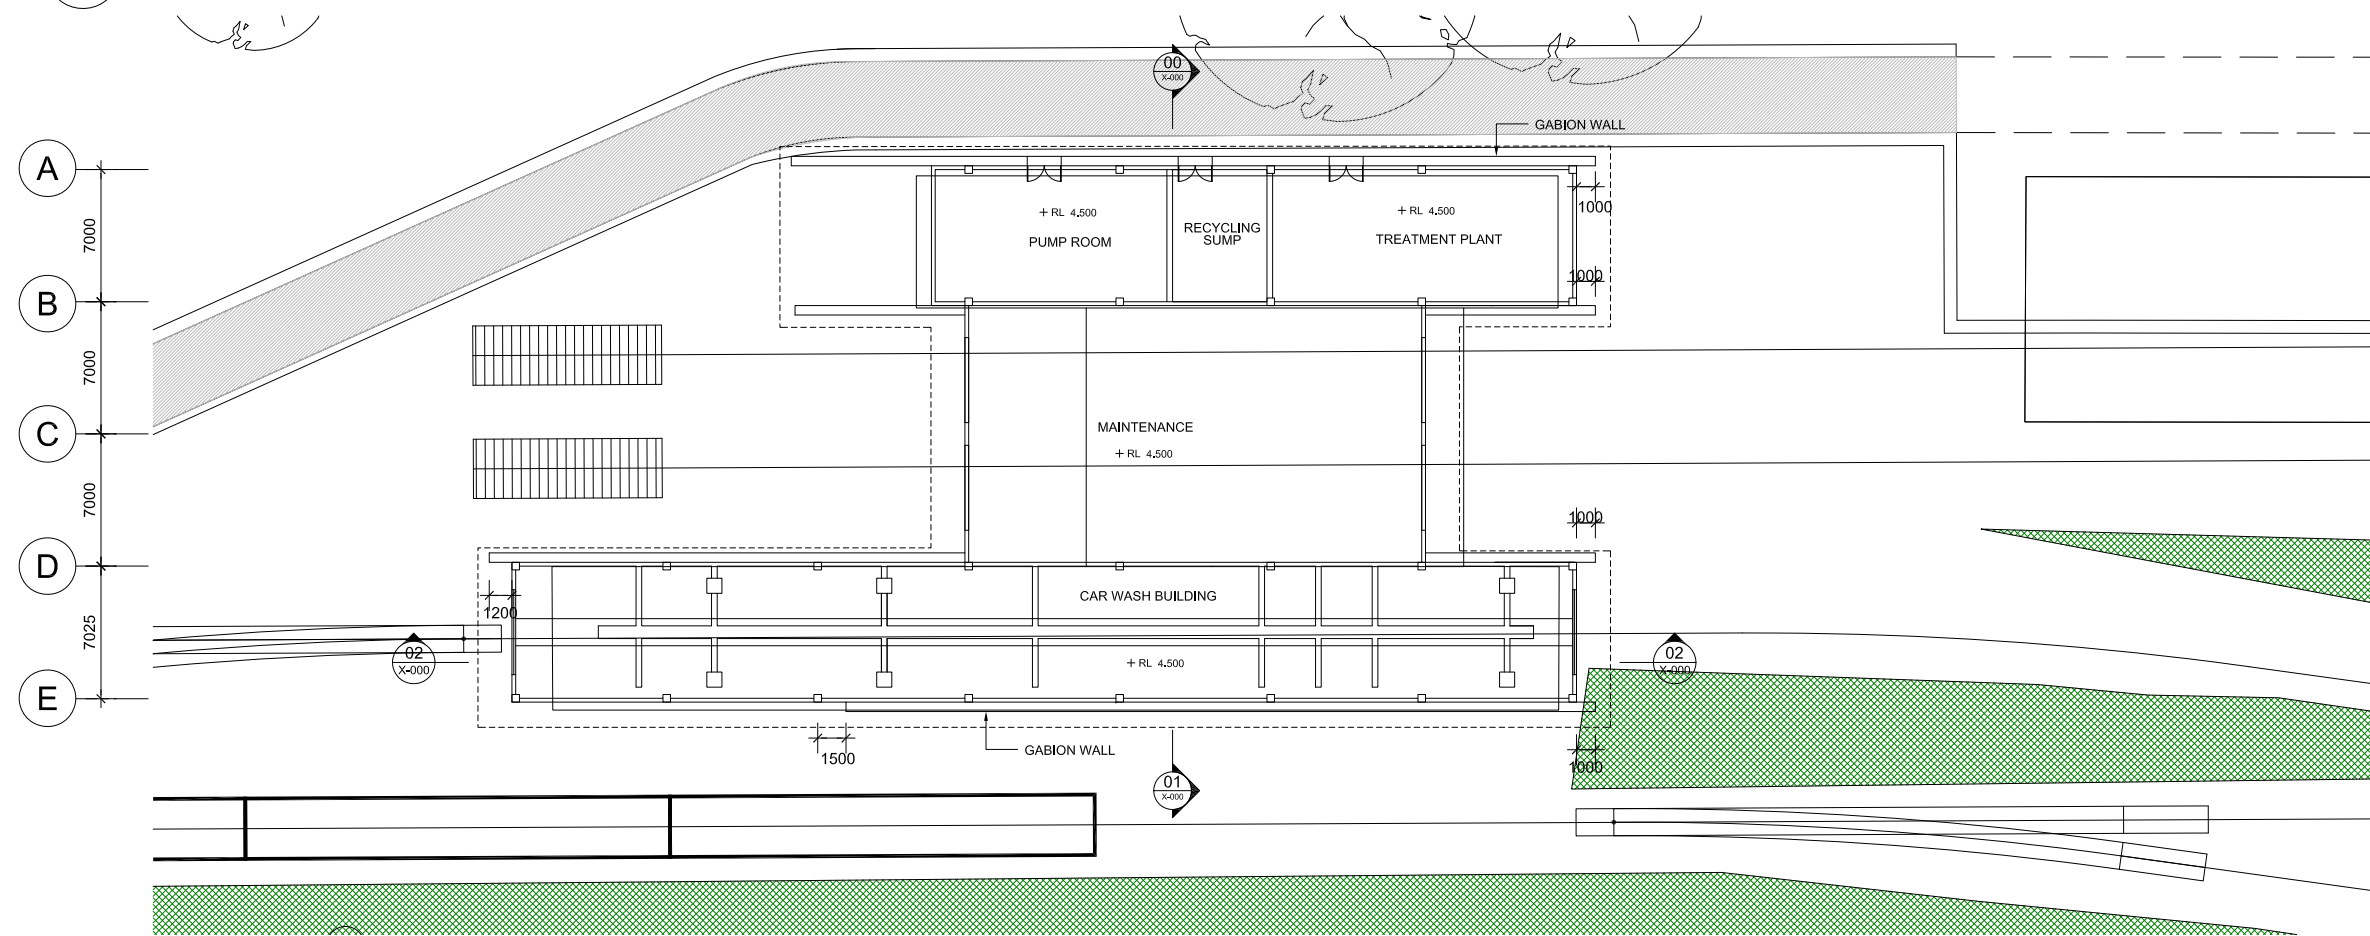

01 CAR WASH PLANT GROUND FLOOR PLAN

01		18.08.09	ISSUED FOR EA	
00		28.07.09	REFERENCE DESIGN ISSUE	
No.	BY	DATE	DESCRIPTION	APPD

 

THE INFORMATION SHOWN ON THIS DRAWING IS FOR THE PURPOSES OF THE CBD METRO PROJECT ONLY
NO WARRANTY IS GIVEN OR IMPLIED AS TO ITS SUITABILITY FOR ANY OTHER PURPOSE.

APPROVED ORIGINAL OF THIS DRAWING SIGNED & DATED AS INDICATED BELOW

APPROVED ORIGINAL OF THIS DRAWING SIGNED & DATED AS INDICATED BELOW			
	PREPARED	CHECKED	PSC APPROVED  ROSS DE LA MOTTE 28.07.01 DATE
DESIGN			

Scales

Professional Services Contractor /
Technical Advisor

Client	
--------	--



Project Title	CBD METRO
---------------	-----------

Drawing Title


ROZELLE DEPOT
CAR WASH PLANT - GROUND & ROOF PLAN

Status	FINAL
--------	-------


Dr. No. CBD-2100-RD-0800-AR-3120	
--	--

Rev.


THIS DRAWING IS INDICATIVE ONLY

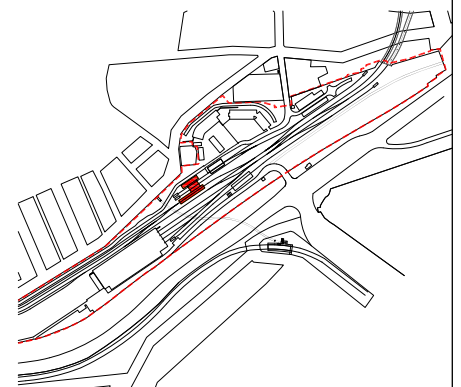


J:\202624 CBD METRO 02\10093 CAD\02 ARCHITECTURAL AR0800 CAR WASH\02 ELEVATIONS\02 CAR WASH\02 RD-2100-RD-0800-AR-3130.DWG 28/07/2009 5:48:27 PM

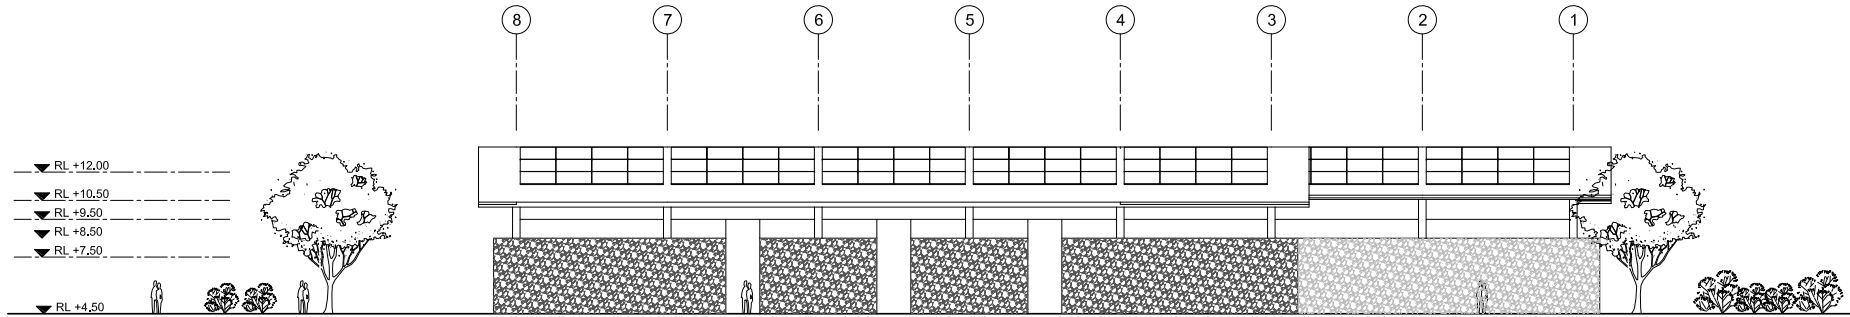


01 CAR WASH BUILDING - NORTH ELEVATION

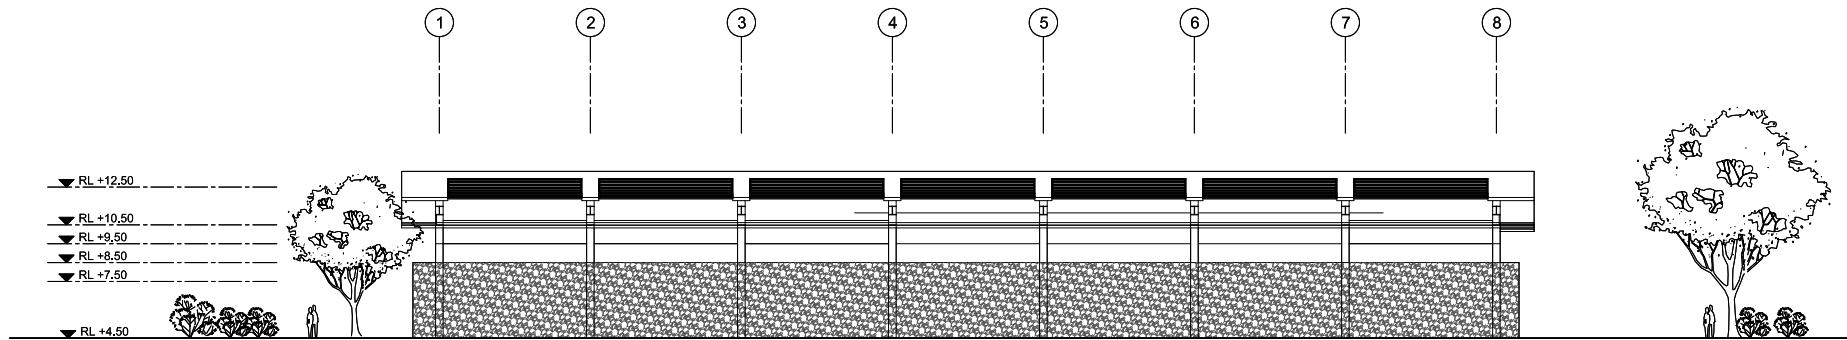

02 CAR WASH BUILDING - SOUTH ELEVATION

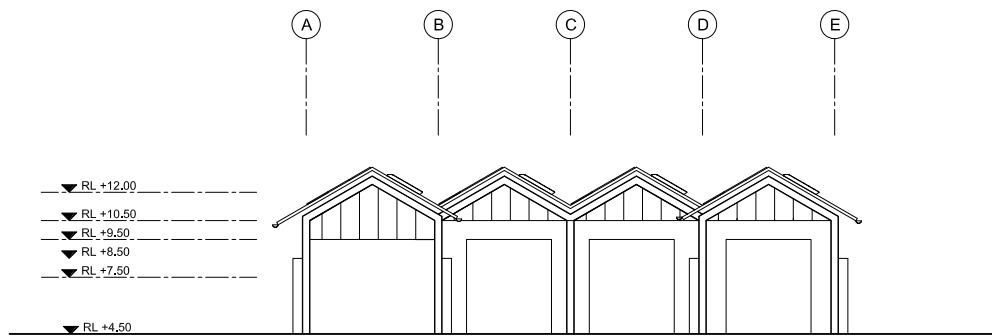


03 CAR WASH BUILDING - NORTH ELEVATION

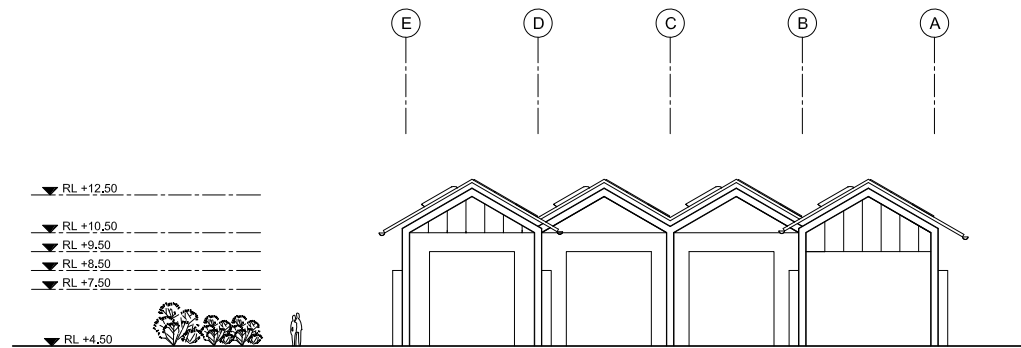

04 CAR WASH BUILDING - SOUTH ELEVATION

LEGEND

- 1 GABION WALL
- 2 STONE WALL
- 3 METAL CLADDING
- 4 LOUVRES
- 5 GLAZING
- 6 POLYCARBONATE

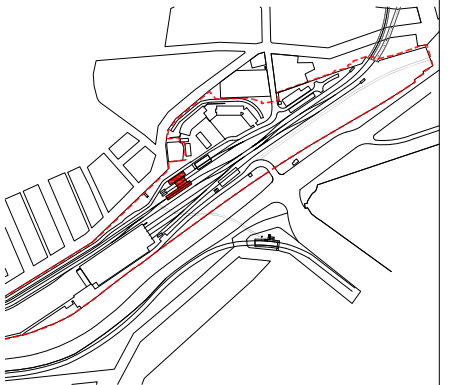

THIS DRAWING IS INDICATIVE ONLY


No.	BY	DATE	DESCRIPTION	APPD
01		18.08.09	ISSUED FOR EA	
00		28.07.09	REFERENCE DESIGN ISSUE	

THE INFORMATION SHOWN ON THIS DRAWING IS FOR THE PURPOSES OF THE CBD METRO PROJECT ONLY NO WARRANTY IS GIVEN OR IMPLIED AS TO ITS SUITABILITY FOR ANY OTHER PURPOSE.		
APPROVED ORIGINAL OF THIS DRAWING SIGNED & DATED AS INDICATED BELOW		
DESIGN	PREPARED AT EH	CHECKED PSC APPROVED ROSS DE LA MOTTE 28.07.09 DATE
Scales 1:200@A1 0 2 4 6m		


Professional Services Contractor / Technical Advisor
 PBOCH ARUP COX HASSELL

Client

Project Title	CBD METRO		
Drawing Title	ROZELLE DEPOT CAR WASH BUILDING - SECTIONS & ELEVATIONS		
Status	FINAL	Dwg No. CBD-2100-RD-0800-AR-3130	Rev 01

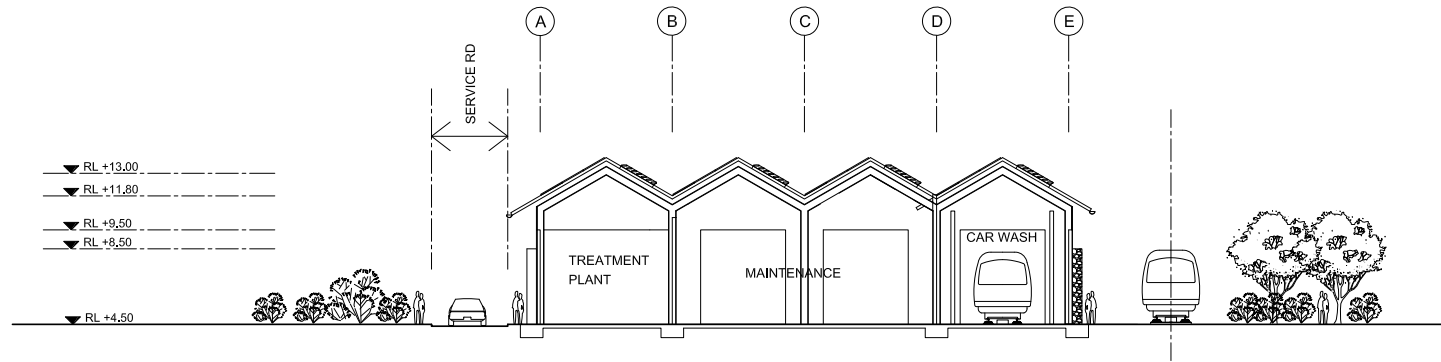


01 CAR WASH BUILDING - SECTION A-A

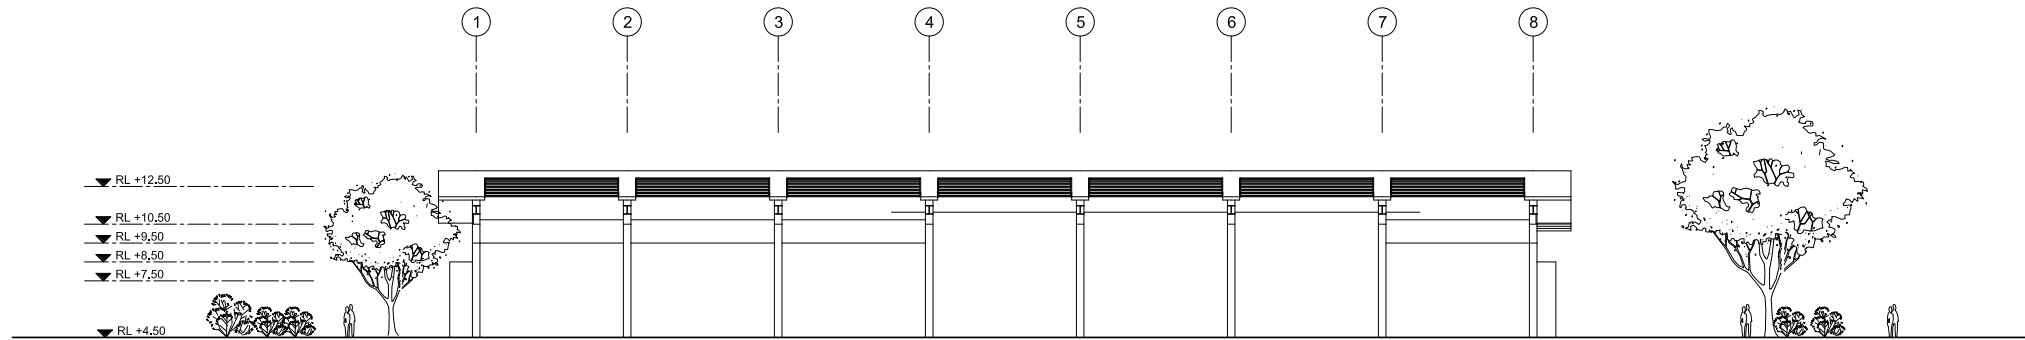

02 CAR WASH BUILDING - SECTION B-B

- LEGEND
- 1 GABION WALL
 - 2 STONE WALL
 - 3 METAL CLADDING
 - 4 LOUVRES
 - 5 GLAZING
 - 6 POLYCARBONATE

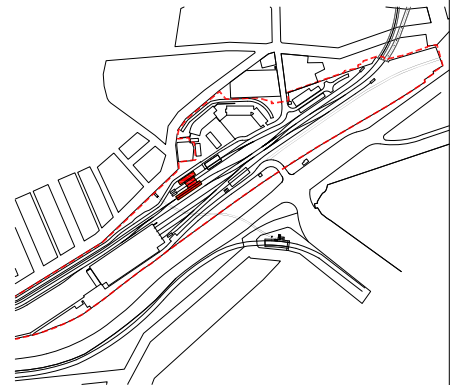

THIS DRAWING IS INDICATIVE ONLY

01	18.08.09	ISSUED FOR EA		
00	28.07.09	REFERENCE DESIGN ISSUE		
No.	BY	DATE	DESCRIPTION	APPD

THE INFORMATION SHOWN ON THIS DRAWING IS FOR THE PURPOSES OF THE CBD METRO PROJECT ONLY NO WARRANTY IS GIVEN OR IMPLIED AS TO ITS SUITABILITY FOR ANY OTHER PURPOSE.		
APPROVED ORIGINAL OF THIS DRAWING SIGNED & DATED AS INDICATED BELOW		
DESIGN	PREPARED AT EH	CHECKED PSC APPROVED <i>[Signature]</i> ROSS DE LA MOTTE 28.07.09 DATE
Scales 1:200@A1 0 2 4 6m		

Professional Services Contractor /
Technical Advisor


pboch
PBOCH | ARUP | COX | HASSELL

Client




Project Title	CBD METRO		
Drawing Title	ROZELLE DEPOT CAR WASH BUILDING - SECTIONS		
Status	FINAL	Dwg No.	CBD-2100-RD-0800-AR-3131
		Rev	01


J:\202624 CBD METRO 02\10093 CAD\02 ARCHITECTURAL AR0800 LLYFIELD DEPOT\01 CAD\02 PLOT\02 REFERENCE RD3000_ELEVATIONS\02XSERVICE BUILDING CBD-2100-RD-0800-AR-4130.DWG - 9/5/2009 5:48:27 PM

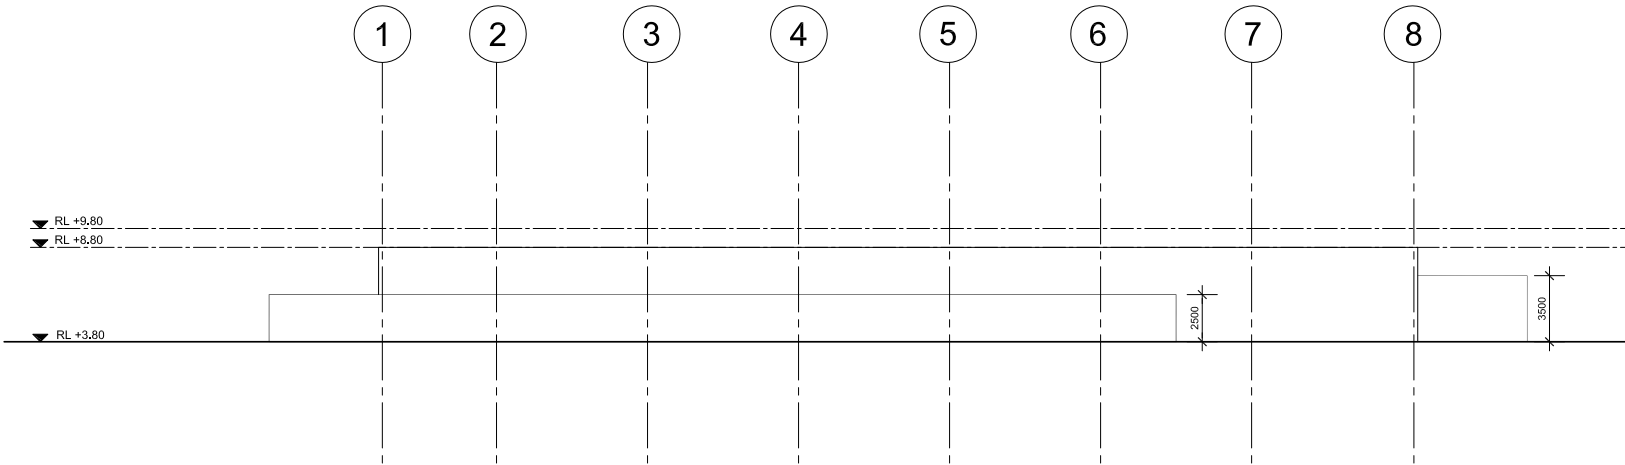


01 ELECTRICAL SERVICE BUILDING - SOUTH ELEVATION

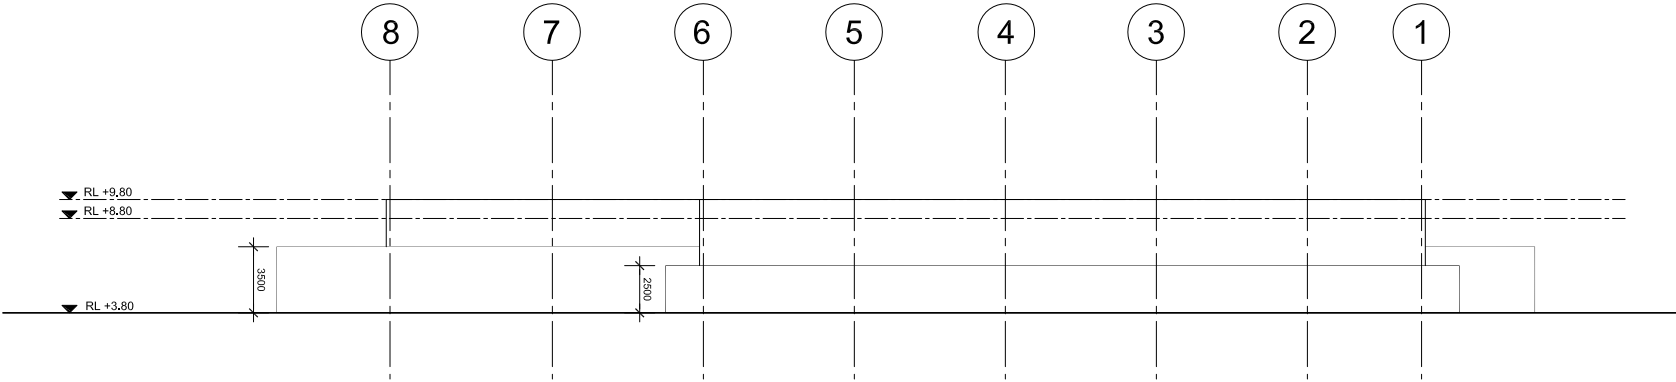

02 ELECTRICAL SERVICE BUILDING - NORTH ELEVATION

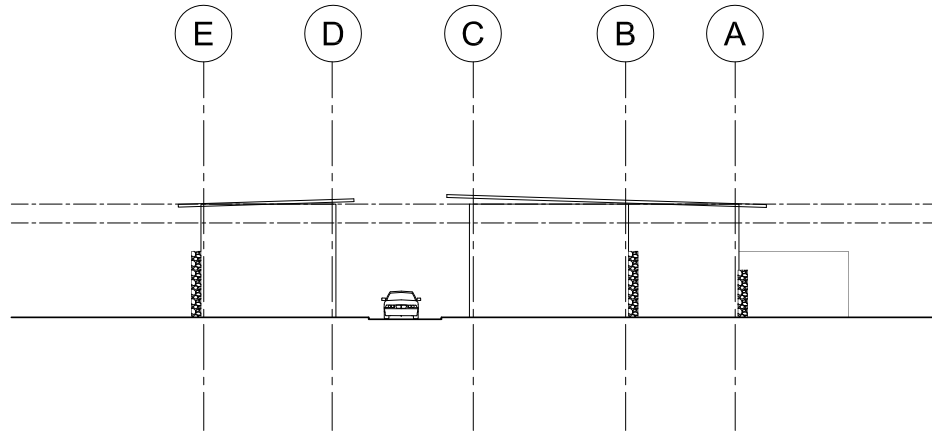


03 ELECTRICAL SERVICE BUILDING - EAST ELEVATION

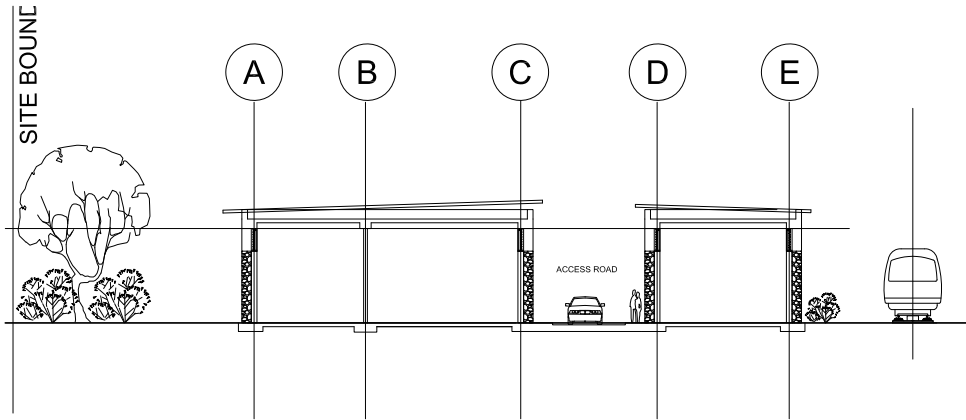

04 ELECTRICAL SERVICE BUILDING - WEST ELEVATION

Rm No	Room Name
Electrical Plant Building	
1	Reactor Room
2	Rectifier Room (4MW TX)
3	DS Switchroom
4	33 kv SWBD TX 1
5	33 kv SWBD TX 2
6	11 kv SWBD
7	11 kv TX
8	Battery Room
9	RMU
10	LV Switch Room (Intake)

LEGEND	
1	GABION WALL
2	STONE WALL
3	METAL CLADDING
4	LOUVRES
5	GLAZING
6	POLYCARBONATE

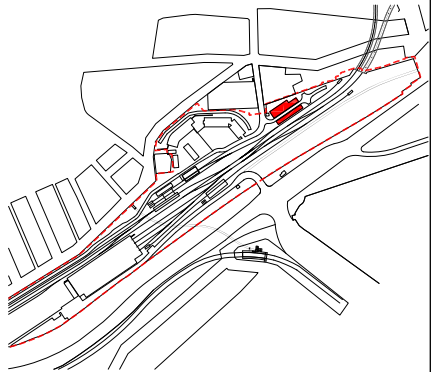

THIS DRAWING IS INDICATIVE ONLY

No.	BY	DATE	DESCRIPTION	APPD
01		18.08.09	ISSUED FOR EA	
00		28.07.09	REFERENCE DESIGN ISSUE	

THE INFORMATION SHOWN ON THIS DRAWING IS FOR THE PURPOSES OF THE CBD METRO PROJECT ONLY NO WARRANTY IS GIVEN OR IMPLIED AS TO ITS SUITABILITY FOR ANY OTHER PURPOSE. APPROVED ORIGINAL OF THIS DRAWING SIGNED & DATED AS INDICATED BELOW			
DESIGN	PREPARED	CHECKED	PSC APPROVED
			ROSS DE LA MOTTE 28.07.09 DATE
Scales			

Professional Services Contractor /
Technical Advisor

pboch
PBOCH | ARUP | COX | HASSELL

Client

SydneyMetro

Project Title
CBD METRO


Drawing Title
ROZELLE DEPOT
ELECTRICAL SERVICE BUILDING - SECTIONS &
ELEVATIONS

Status
FINAL


Org No
CBD-2100-RD-0800-AR-4130

Rev
01


Rm No	Room Name
Wheel Lathe Building	
1	Brake Adjust Area
2	2 Bins For Swarf
3	Machinery Pit
4	Eye Wash & Drinking Fountain
5	Toilet
6	Wheel Monitor
7	Office
8	Storage
9	Tool Bench
10	Waste Truck & Loading Area
11	Roller Door

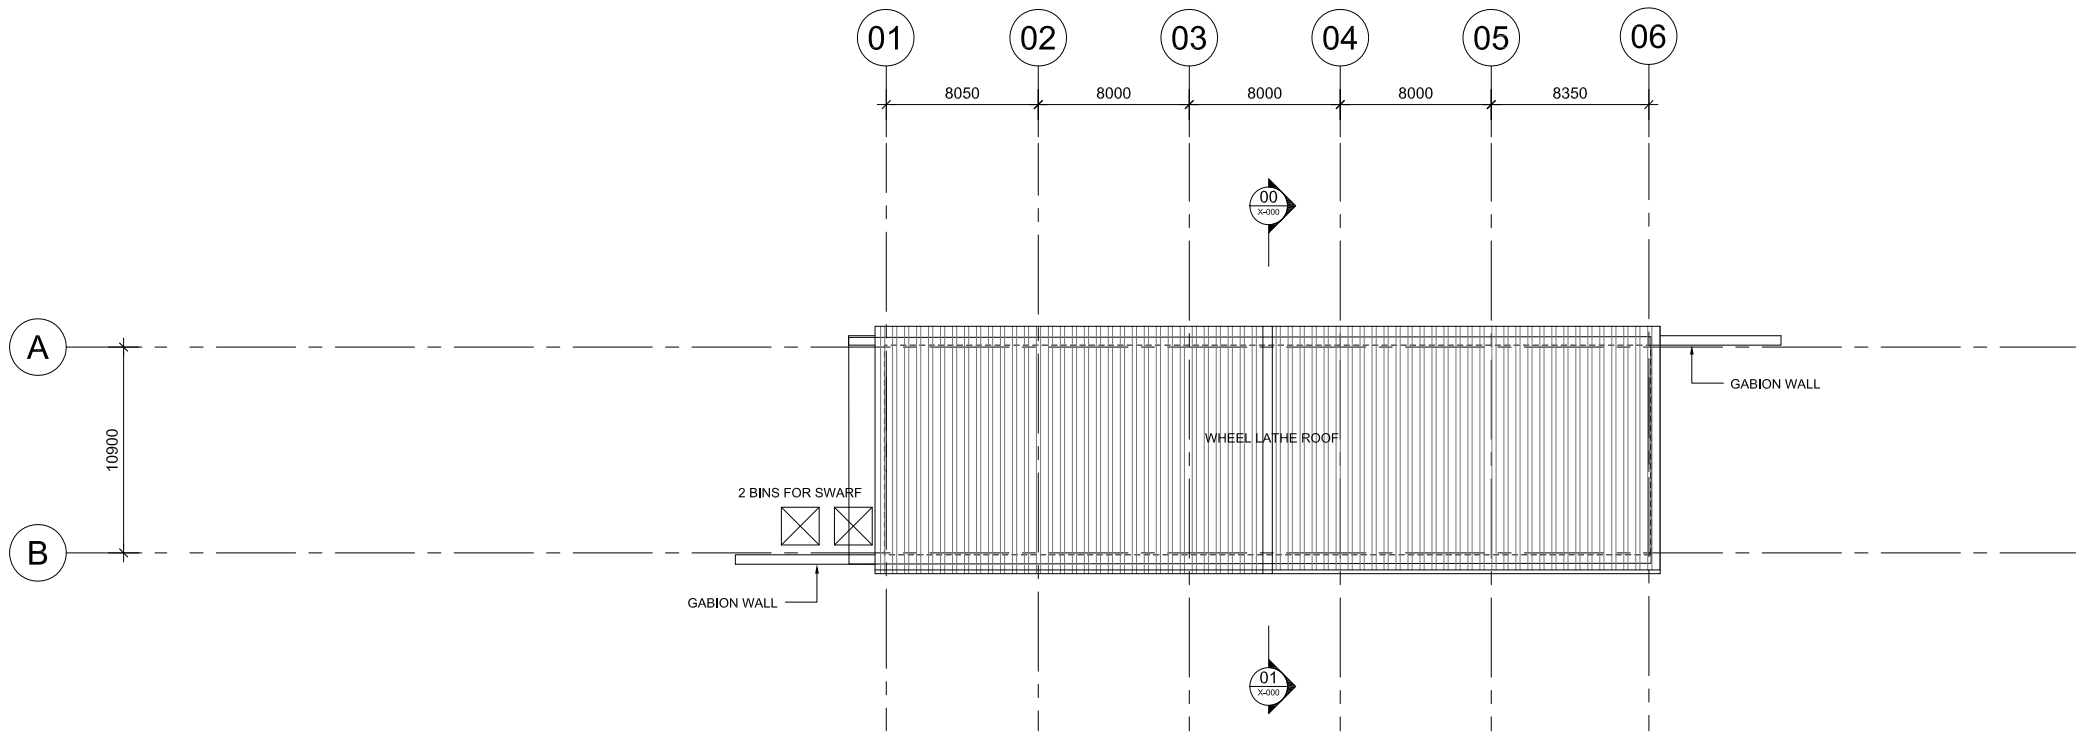

02 WHEEL LATHE BUILDING - ROOF PLAN

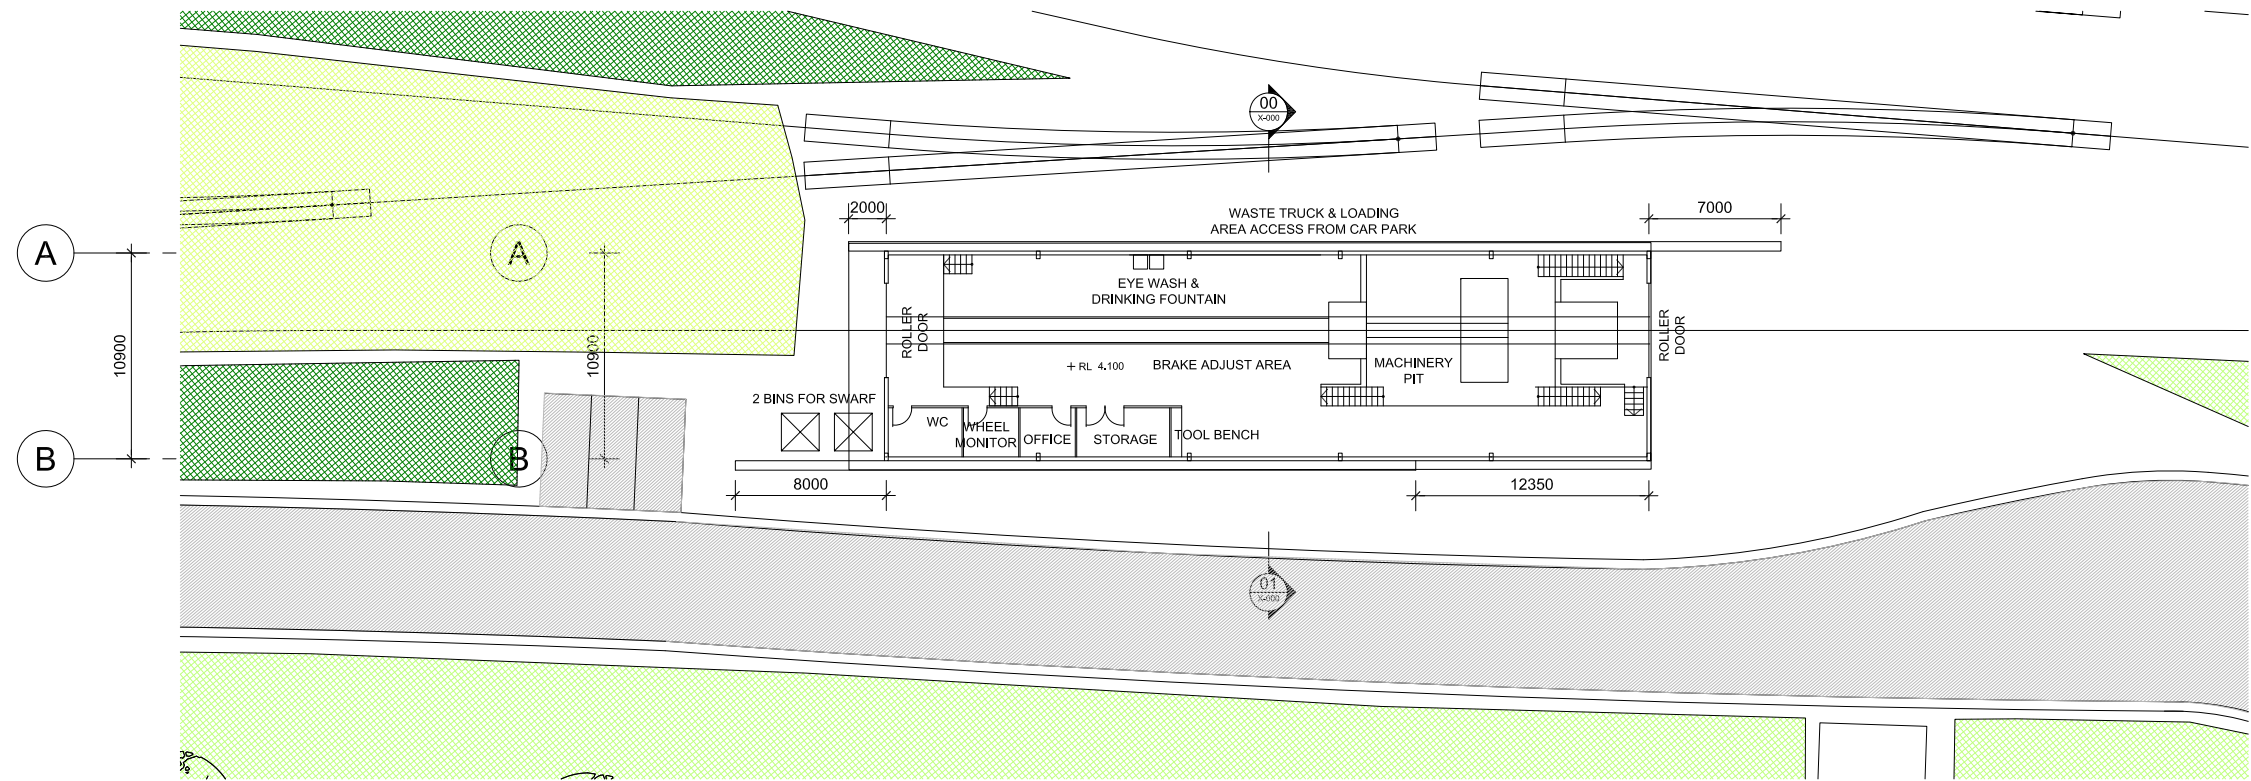

01 WHEEL LATHE BUILDING - GROUND FLOOR PLAN

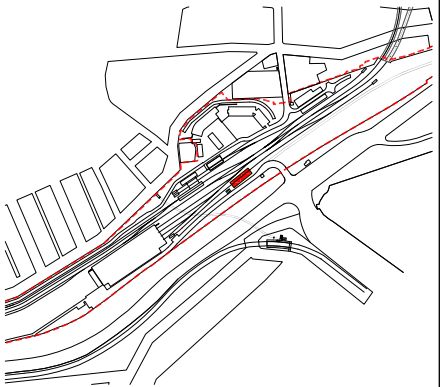

THIS DRAWING IS INDICATIVE ONLY

No.	BY	DATE	DESCRIPTION	APPD
01		18.08.09	ISSUED FOR EA	
00		28.07.09	REFERENCE DESIGN ISSUE	



THE INFORMATION SHOWN ON THIS DRAWING IS FOR THE PURPOSES OF THE CBD METRO PROJECT ONLY. NO WARRANTY IS GIVEN OR IMPLIED AS TO ITS SUITABILITY FOR ANY OTHER PURPOSE.			
APPROVED ORIGINAL OF THIS DRAWING SIGNED & DATED AS INDICATED BELOW			
DESIGN	PREPARED	CHECKED	PSC APPROVED
			ROSS DE LA MOTTE
			28.07.09
			DATE
Scales			
0 2 4 6m			

Professional Services Contractor / Technical Advisor




Client




Project Title			CBD METRO
Drawing Title			ROZELLE DEPOT WHEEL LATHE BUILDING - GROUND FLOOR & ROOF PLAN
Status	FINAL	Org No	CBD-2100-RD-0800-AR-5120
Rev	01		


24/06/2024 CBD METRO C210000 CAD02 ARCHITECTURAL AR0800 LLYFIELD DEPOT01 CAD02 PLOT02 REFERENCE RD0000 ELEVATIONS0000WHEEL LATHE0800-1100-RD-0800-AR-5130.DWG 30/05/2009 5:46:27 PM

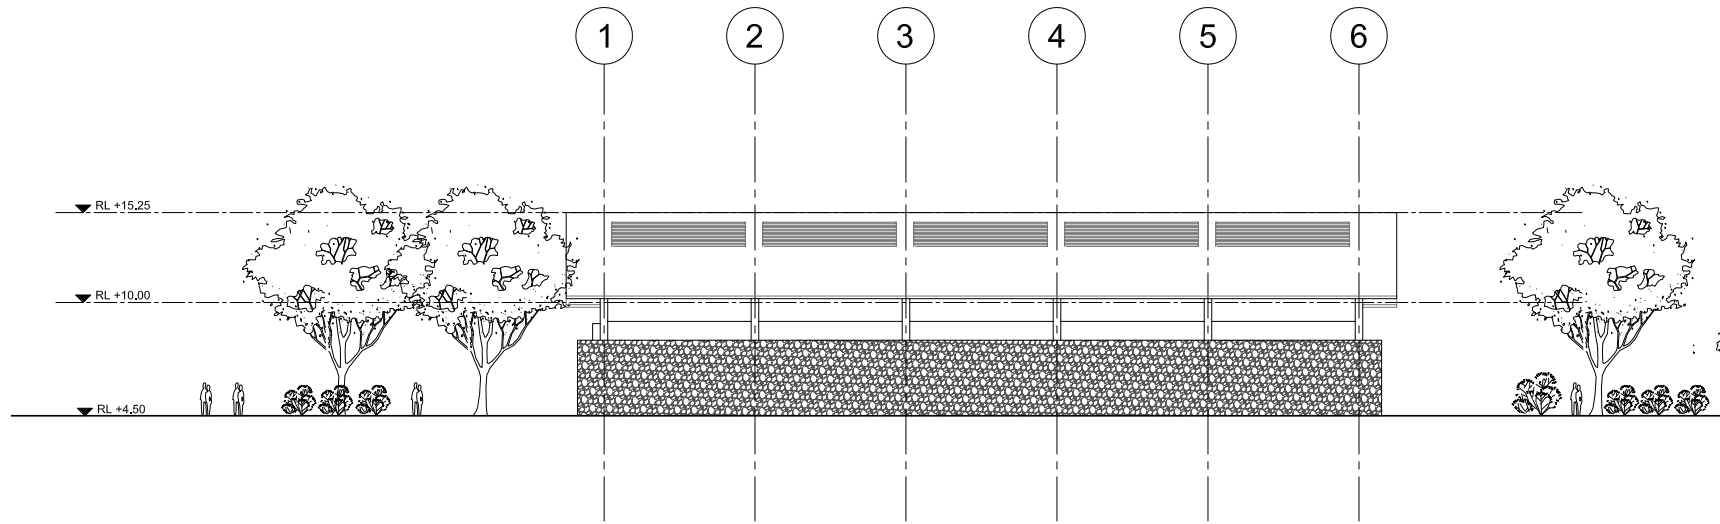


01 SOUTH ELEVATION

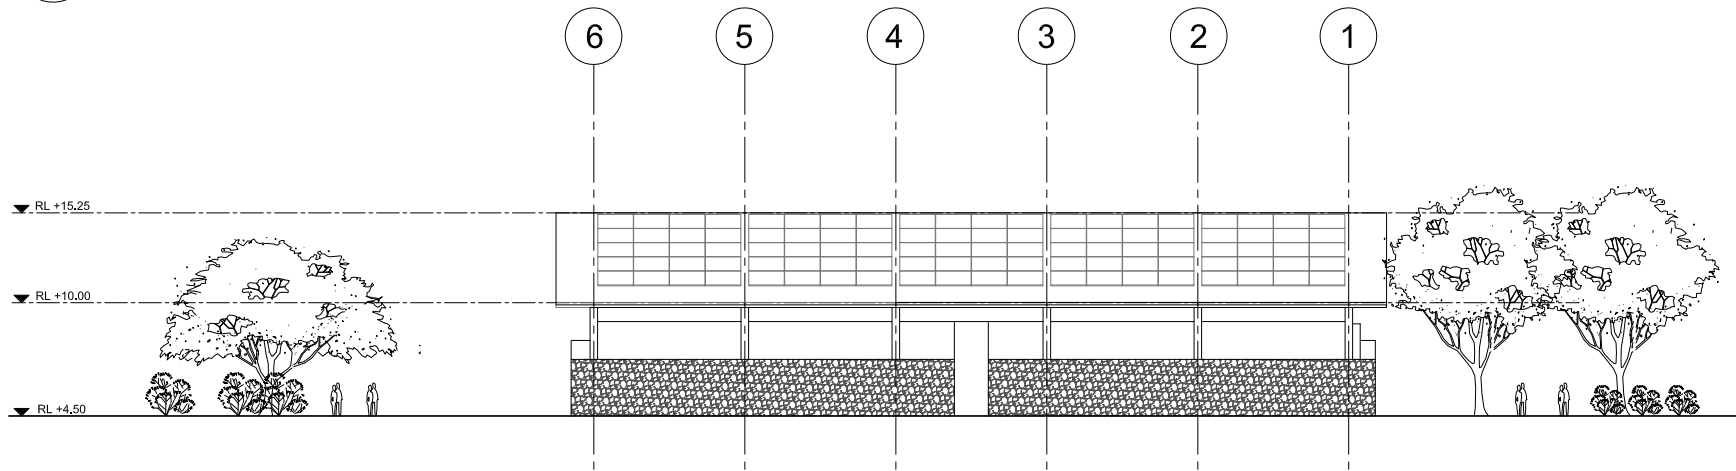

02 NORTH ELEVATION

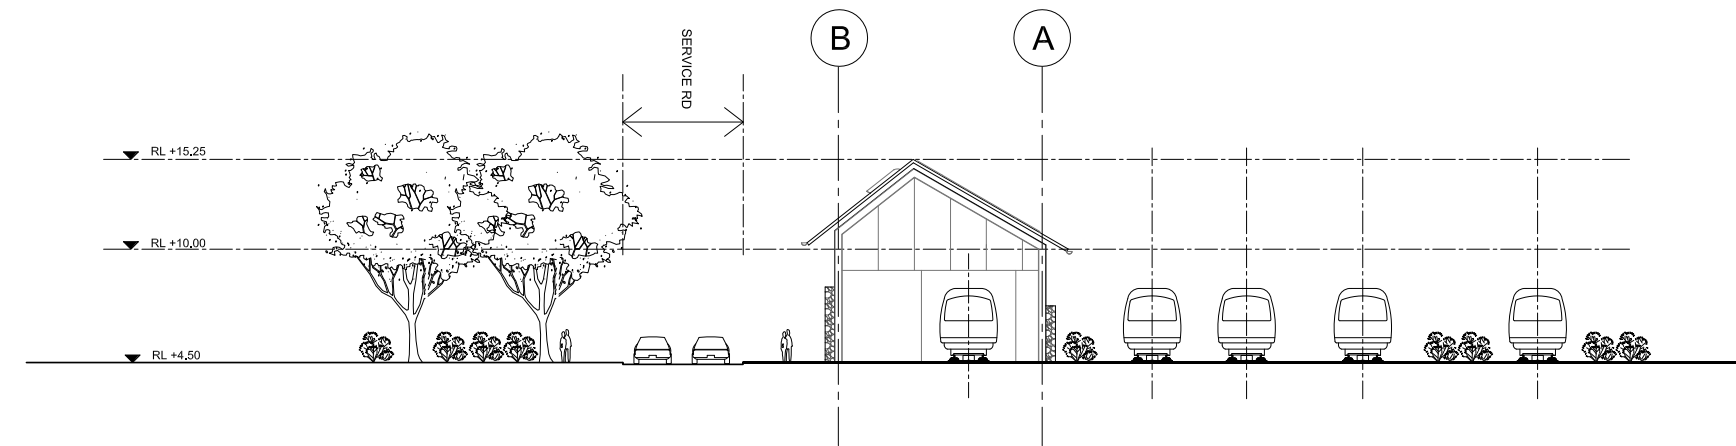


04 EAST ELEVATION

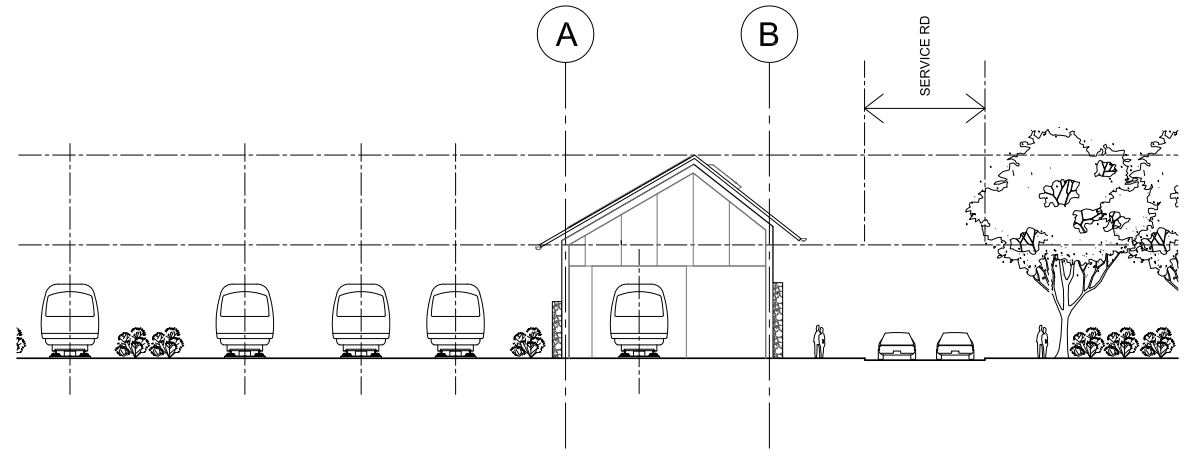

03 WEST ELEVATION

LEGEND

- 1 GABION WALL
- 2 STONE WALL
- 3 METAL CLADDING
- 4 LOUVRES
- 5 GLAZING
- 6 POLYCARBONATE

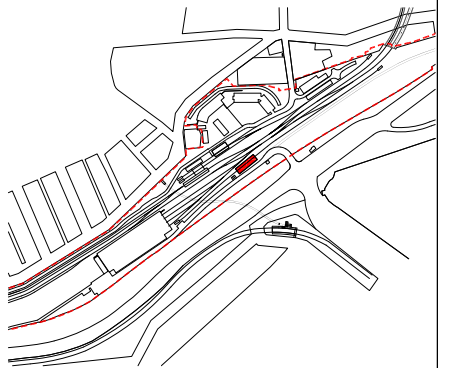

THIS DRAWING IS INDICATIVE ONLY

No.	BY	DATE	DESCRIPTION	APPD
01		18.08.09	ISSUED FOR EA	
00		28.07.09	REFERENCE DESIGN ISSUE	
No.	BY	DATE	DESCRIPTION	APPD

THE INFORMATION SHOWN ON THIS DRAWING IS FOR THE PURPOSES OF THE CBD METRO PROJECT ONLY NO WARRANTY IS GIVEN OR IMPLIED AS TO ITS SUITABILITY FOR ANY OTHER PURPOSE APPROVED ORIGINAL OF THIS DRAWING SIGNED & DATED AS INDICATED BELOW			
DESIGN	PREPARED	CHECKED	PSC APPROVED
			ROSS DE LA MOTTE
Scales 1:250@A1 / 1:500@A3		28.07.09 DATE	

Professional Services Contractor / Technical Advisor
pba ch PB ARUP COX HASSELL

Client


Project Title	CBD METRO		
Drawing Title	ROZELLE DEPOT WHEEL MANAGEMENT BUILDING - SECTIONS & ELEVATIONS		
Status	FINAL	Org No.	CBD-2100-RD-0800-AR-5130
Rev.	01		

Diagram illustrating the proposed station layout, showing the station building, tracks, and surrounding infrastructure. Key features include:

- Station Building: A gabled structure with an "OFFICE" and a "MACHINERY PIT" below it.
- Tracks: Three tracks are shown to the left of the station building, with level markers: RL +15.25, RL +10.00, and RL +4.50.
- Gabion Wall: A wall separating the tracks from the station building.
- Access Road: A road labeled "ACCESS RD" leading to the station building.
- Boundary: A line labeled "BOUNDARY" on the right side of the diagram.
- Vegetation: Trees and shrubs are shown along the boundary and near the tracks.

03 WHEEL LATHE BUILDING - DETAIL SECTION 1

00		28.07.09	REFERENCE DESIGN ISSUE		
No.	BY	DATE	DESCRIPTION		APPD

pboch
PB | ARUP | COX | HASSELL



Status	FINAL
--------	-------

Drp No.	CBD-2100-RD-0800-AR-5131
---------	--------------------------

Re	0
----	---

