

BANCOR

ATCHISON STREET, ST LEONARDS

STORMWATER DRAINAGE CONCEPT PLAN

LEGEND

CIVIL DRAINAGE AND HYDRAULIC SERVICES SYMBOLS

	STW	STORMWATER DRAINAGE PIPE
	STRW	STORMWATER RISING MAIN
		STORMWATER DRAINAGE CHANNEL
	SS	SUB SOIL DRAINAGE WITH CLEAN OUT
	SSRM	SUB SOIL RISING MAIN
	e	EXISTING SERVICE
	e	EXISTING SERVICE TO BE REMOVED
	OF	OVERFLOW PIPE
	RW	RAINWATER REUSE
		DROP TO OR RISE FROM
		RISE TO OR DROP FROM
		TEE DROP
		TEE RISE
	E	ELECTRICAL WIRING IN CONDUIT
	VERT	VERTICAL RISER IN DRAINAGE
	CO	CLEAROUT
		FLOW DIRECTIONAL ARROWS ON ALL PIPING SERVICES
	P	PENETRATION CORE THROUGH STRUCTURAL ELEMENT
	DP 150	DOWNPIPE (150mm DIAMETER)
	RWO	RAINWATER OUTLET
	PDO	PLANT DRAIN OUTLET
		NEW
		SWALE or SPEED HUMP
		OVERLAND FLOW DIRECTIONAL ARROW
		OSD ABOVE GROUND
		KEP - KERB ENTRY PIT
		DOUBLE GRATED GULLY PIT
		JUNCTION PIT WITH COVER
		SURFACE INLET PIT (FLUSH/RAISED)
		SURFACE INLET PIT (DEPRESSED)
		GRATED TRENCH DRAIN
		RISER
		SERVICE
		SIZE
		DROPPER

SERVICES & UTILITIES SYMBOLS

	D	DRAINS
	E	ELECTRICAL
	NG	NATURAL GAS
	S	SEWER
	W	WATER

NOTE:-
 'e' ON SERVICE LINE REPRESENTS EXISTING SERVICE OR THE USE OF LOWER CASE LETTER.
 'x' ON SERVICE LINE REPRESENTS SERVICE TO BE ABANDONED.

SECTION SYMBOL

	A	SECTION NO.
	DAH-03	REFERENCE DRAWING

GENERAL ABBREVIATIONS

CTS	CENTERS
CL	CENTRE LINE
DIA	DIAMETER
DMR	DEPARTMENT OF MAIN ROADS
DWG	DRAWING
Ex.	EXISTING
GALV	GALVANIZED
HD GALV	HOT DIPED GALVANIZED
ID	INTERNAL DIAMETER
L.O.C.	LIMIT OF CONTRACT
MAX	MAXIMUM
MIN	MINIMUM
NB	NOMINAL BORE
N.I.C.	NOT IN CONTRACT
No.	NUMBER
NOM	NOMINAL
NTS	NOT TO SCALE
OD	OUTSIDE DIAMETER
REV	REVISION
RTA	ROADS AND TRAFFIC AUTHORITY
SQ	SQUARE
SRA	STATE RAIL AUTHORITY
STD	STANDARD
UNO	UNLESS NOTED OTHERWISE
VERT	VERTICAL

CIVIL ABBREVIATIONS

DRAINAGE LEVELS	
BWL	BOTTOM WATER LEVEL
IL	INVERT LEVEL
OL	OBVERT LEVEL
SL	SURFACE LEVEL
TWL	TOP WATER LEVEL
GRATES & COVERS	
LD	LIGHT DUTY CLASS 'B'
MD	MEDIUM DUTY CLASS 'C'
HD	HEAVY DUTY CLASS 'D'
EHD	EXTRA HEAVY DUTY CLASS 'E'
MP	MULTI PART COVER OR GRATE
PIIS	
CDS	CDS TECHNOLOGIES
DCP	DISCHARGE CONTROL PIT
DGGP	DOUBLE GRATED GULLY PIT (CAST IRON)
GPT	GROSS POLLUTANT TRAP
JP	JUNCTION PIT
KEP	KERB ENTRY PIT
KEU	KERB ENTRY UNIT
MPC	MULTI PART COVER
MPG	MULTI PART GRATE
SWP	STORMWATER PIT
DRAINAGE LINES	
SS	SUBSOIL DRAINAGE
STRW	STORMWATER RISING MAIN
STW	STORMWATER DRAIN
GD	GRATED TRENCH DRAIN
FEATURES	
CO	CLEAROUT
DP	DOWN PIPE
FP	FLUSHING POINT
IO	INSPECTION OPENING
OF	GUTTER OVERFLOW PIPE
RO	RAINWATER OUTLET
DTU	DRAINAGE TURNUP
OSD	
OSD	ONSITE DETENTION
PSD	PERMISSIBLE SITE DISCHARGE
OPF	OVERFLOW PATH
SWMP	STORM WATER MANAGEMENT PLAN
ESCP	EROSION & SEDIMENT CONTROL PLAN

MATERIALS ABBREVIATIONS

Br	BRASS
CI	CAST IRON
CICL	CAST IRON CEMENT LINED
CONC	CONCRETE
CP	CHROMIUM PLATED
Cu	COPPER
DICL	DUCTILE IRON CEMENT LINED
FRC	FIBRE REINFORCED CEMENT GALVANISED
GMS	MILD STEEL
MS	MILD STEEL
NY	NYLON
PE	POLYETHYLENE
RC	REINFORCED CONCRETE
RCP	REINFORCED CONCRETE PIPE
RHS	RECTANGULAR HOLLOW SECTION
SS	STAINLESS STEEL

LEVELS ABBREVIATIONS

CL	CEILING LEVEL
FFL	FINISHED FLOOR LEVEL
FGL	FINISHED GROUND LEVEL
GL	EXISTING GROUND LEVEL
HL	HIGH LEVEL
HP	HIGH POINT
LL	LOW LEVEL
ML	MID LEVEL
NS	NATURAL SURFACE LEVEL
PL	PLATFORM LEVEL
RL	REDUCED LEVEL
US	UNDER SIDE
USFL	UNDERSIDE FLOOR

MISCELLANEOUS ABBREVIATIONS

A/C	AIR CONDITIONING
B/P	BELOW PLANTER
CIC	CAST IN COLUMN
CIS	CAST IN SLAB
FALL	PIPELINE FALL
GRD	GROUND
MPC	MULTI PART COVER
MPG	MULTI PART GRATE
PECP	PUMP ELECTRICAL CONTROL PANEL
DE	DIESEL EXHAUST

FLUID FLOW ABBREVIATIONS

FU	FIXTURE UNITS
kPa	PRESSURE IN KILOPASCALS
L/s	FLOW IN LITRES PER SECOND
LU	LOADING UNITS
m Head	PRESSURE IN METRES HEAD
m/s	VELOCITY OF FLOW IN METRES PER SECOND

CATCHMENT ABBREVIATIONS

A	CATCHMENT AREA
ARI	AVERAGE RECURRENCE INTERVAL
L/s	LITRES PER SECOND (VELOCITY)
m/s	METRES PER SECOND (VELOCITY)
CUMECs	CUBIC METRES PER SECOND
Q	QUANTITY OF FLOW

CALCULATIONS

INTERNAL DRAINAGE CALCULATIONS BASED ON THE FOLLOWING RAINFALL INTENSITIES

$$1:100YR = 207 \text{ mm/hr}$$

DRAWING LIST

H-100	Title Sheet, Legend and Drawing List
H-101	Basement Level B5 - Stormwater Drainage Plan
H-102	Basement Typical Levels B2-B4 - Stormwater Drainage Plan
H-103	Basement Loading Dock B1 - Stormwater Drainage Plan
H-104	Basement Mezzanine - Stormwater Drainage Plan
H-105	Ground Level Residential Entry (Lower) - Stormwater Drainage Plan
H-106	Ground Level Hotel (Upper) - Stormwater Drainage Plan
H-107	Hotel Level A - Stormwater Drainage Plan
H-108	Hotel Level B - Stormwater Drainage Plan
H-109	Hotel Level C - Stormwater Drainage Plan
H-110	Hotel Level D (Typical 1A Floor Plan) - Stormwater Drainage Plan
H-111	Typical Residential Type 1A (With Lift Overrun) - Stormwater Drainage Plan
H-112	Type 1D Plan - Stormwater Drainage Plan
H-113	Type 2D Plan - Stormwater Drainage Plan
H-114	Type 3C Plan - Stormwater Drainage Plan
H-115	Type 4E Plan - Stormwater Drainage Plan
H-116	Type 4E Penthouse Plan - Stormwater Drainage Plan
H-117	Roof Plan (Plant) - Stormwater Drainage Plan

C:\Users\jmorehen\Documents and Settings\jmorehen\My Recent Documents\1381632314_101.dwg
 Logon Name: jmorehen
 Plot Date: 10/06/2010 03:00:58 PM
 Job No: 3532
 Plot Date: 10 June 2010 3:00:58 PM

CLIENT
BANCOR
 Atchison Street
 St Leonards - NSW

ARCHITECT
 francis-jones morehen thorp

SYDNEY
 Level 5 MCA, 140 George Street
 Sydney NSW 2000 Australia
 T 61 2 951 7077
 F 61 2 951 7072
 E fjmt@fjmt.com.au
 W www.fjmt.com.au

MEMBERED ARCHITECT NO 44011049 (REG 10/2008)

Warren Smith & Partners Pty Ltd

A 1st Floor, 123 Clarence Street, Sydney 2000 NSW Australia
 T 02 9299 1312 F 02 9290 1295 E wsp@warrensmith.com.au

Consulting Engineers
 Hydraulic Services | Civil Engineering | Fire Protection | Sydney Water Accredited • Water Servicing Co-ordinator • Design and Project Management

QUALITY ASSURED COMPANY
 ISO 9001
 Fig. QAC/R6/L0771

SERVING THE CONSTRUCTION INDUSTRY SINCE 1981


ABN 36 300 430 126

ISSUED FOR CONCEPT DESIGN

TITLE
TITLE SHEET, LEGEND & DRAWING LIST


DATE March 2010	DRAWN BY DN	APPROVED BY WJS
JOB No. 3532	DRAWING No. H-100	ISSUE 01

Plot Date: 10 June 2010 3:00:58 PM

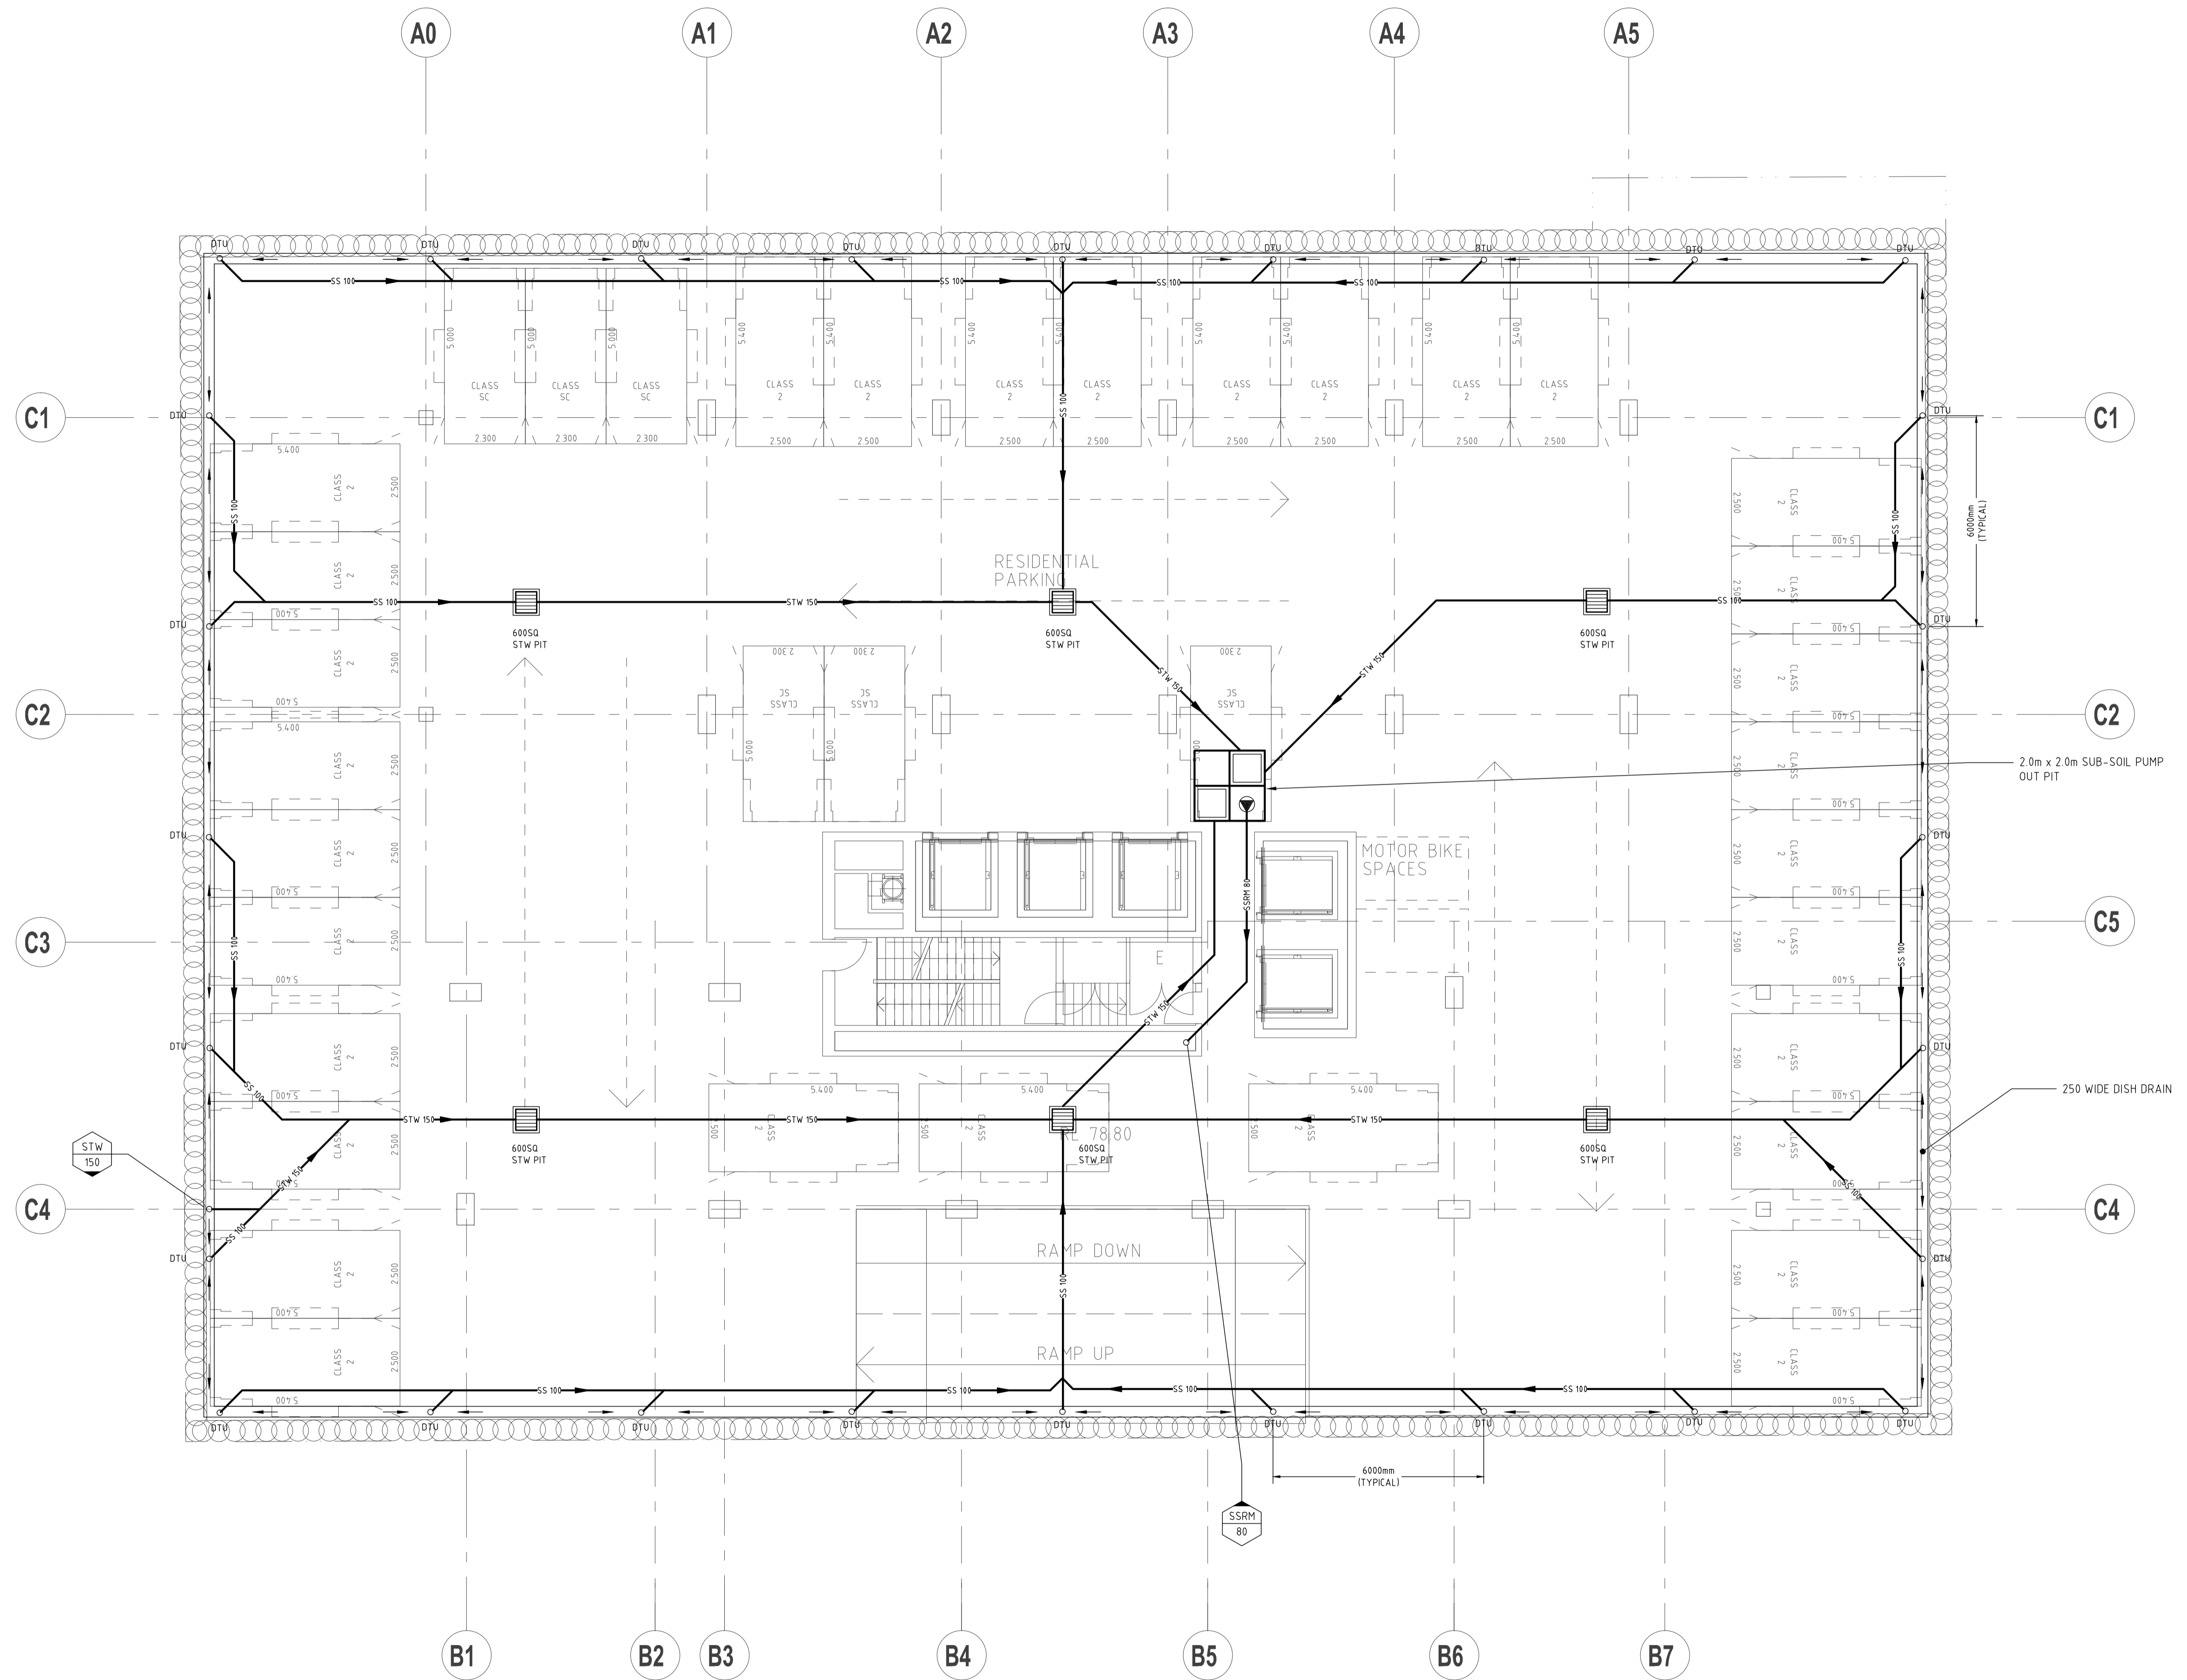

CONCEPT DESIGN
NOT TO BE USED FOR CONSTRUCTION PURPOSES

DO NOT SCALE FROM DRAWINGS, CHECK & VERIFY ALL DIMENSIONS & LEVELS BEFORE COMMENCEMENT OF ANY WORK.
THIS DRAWING IS NOT TO BE COPIED IN PART OR WHOLE WITHOUT WRITTEN PERMISSION FROM WARREN SMITH AND PARTNERS.

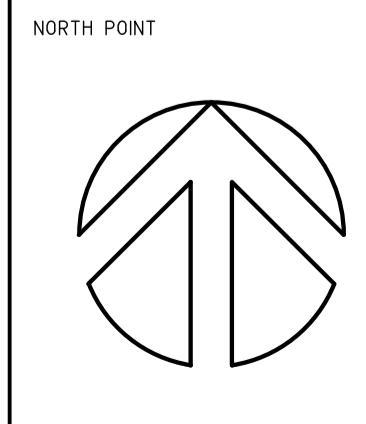

ISSUE	AMENDMENT	DATE	CLIENT	ARCHITECT
01	CONCEPT DESIGN ISSUE	10/06/10	Bancor - Atchison Street St Leonards - NSW	francis-jones morehen thorp fjmt incorporating MGT Sydney

DATE	CLIENT	ARCHITECT
10/06/10	Bancor - Atchison Street St Leonards - NSW	francis-jones morehen thorp fjmt incorporating MGT Sydney

PROJECT	ARCHITECT
Bancor - Atchison Street St Leonards - NSW	francis-jones morehen thorp fjmt incorporating MGT Sydney

Warren Smith & Partners Pty Ltd
A 1st Floor, 123 Clarence Street, Sydney 2000 NSW Australia
T 02 9299 1312 F 02 9290 1295 E wsp@warrensmith.com.au
ABN 36 300 430 126

SERVING THE CONSTRUCTION INDUSTRY SINCE 1981

Consulting Engineers
Hydraulic Services | Civil Engineering | Fire Protection |
Sydney Water Accredited | Water Servicing Co-ordinator
• Design and Project Management


TITLE				
BASEMENT LEVEL B5 STORMWATER DRAINAGE PLAN				
SCALE	1:100 @ A1 1:200 @ A3	DRAWN	DESIGNED	CHECKED
DATE	March 2010	DN	DN	DN
JOB No.	3532	DRAWING No.	H-101	ISSUE
				01

10/06/10 10:14:11 AM - File: Basement Stormwater Drainage Plan - B5 - Rev 1 - 13/06/10
 Plot Date: 10/06/2010 10:14:11 AM - Path: C:\Users\j.smith\Documents\Bancor - Atchison Street - B5 - Rev 1.dwg



CONCEPT DESIGN
NOT TO BE USED FOR CONSTRUCTION PURPOSES

DO NOT SCALE FROM DRAWINGS, CHECK & VERIFY ALL DIMENSIONS & LEVELS BEFORE COMMENCEMENT OF ANY WORK.
THIS DRAWING IS NOT TO BE COPIED IN PART OR WHOLE WITHOUT WRITTEN PERMISSION FROM WARREN SMITH AND PARTNERS.

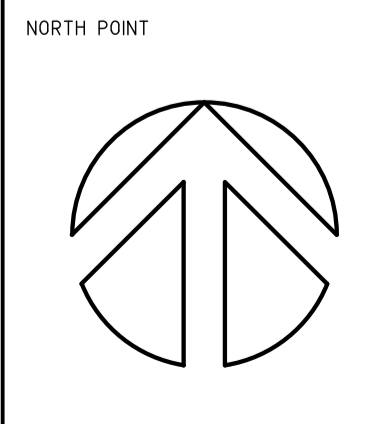

ISSUE	AMENDMENT	DATE	CLIENT
01	CONCEPT DESIGN ISSUE	10/06/10	

ARCHITECT	PROJECT
francis-jones morehen thorp fjmt incorporating MGT Sydney	Bancor - Atchison Street St Leonards - NSW

SYDNEY	WARREN SMITH & PARTNERS PTY LTD
Level 5 MCA, 140 George Street Sydney NSW 2000 Australia T +61 2 9251 7077 F +61 2 9251 7072 E fsm@wsp.com.au W www.fjmt.com.au	A 1st Floor, 123 Clarence Street, Sydney 2000 NSW Australia T 02 9259 1312 F 02 9290 1295 E wsp@warrensmith.com.au ABN 36 300 430 126


Warren Smith & Partners Pty Ltd
SERVING THE CONSTRUCTION INDUSTRY SINCE 1981
Consulting Engineers
Hydraulic Services | Civil Engineering | Fire Protection |
Sydney Water Accredited | Water Servicing Co-ordinator
• Design and Project Management

TITLE				
BASEMENT TYPICAL LEVELS B2 - B4 STORMWATER DRAINAGE PLAN				
SCALE	1:100 @ A1 1:200 @ A3	DRAWN	DESIGNED	CHECKED
DATE	March 2010	DN	DN	DN
JOB No.	3532	DRAWING No.	H-102	ISSUE
				01

10/06/10 10:14 AM - Electronic Meeting - Bancor - Atchison Street - St Leonards - NSW - 10/06/10
 Plot Date: 10/06/2010 10:14 AM - 10/06/2010 10:14 AM - 10/06/2010 10:14 AM - 10/06/2010 10:14 AM

STW FROM SURFACE WATER OUTLETS ABOVE TO CONNECT & DISCHARGE TO COUNCIL STW SYSTEM WITHIN ATCHISON LANE


STW OVERFLOW FROM RAINWATER HARVESTING TANK TO CONNECT & DISCHARGE TO COUNCIL STW SYSTEM WITHIN ATCHISON LANE

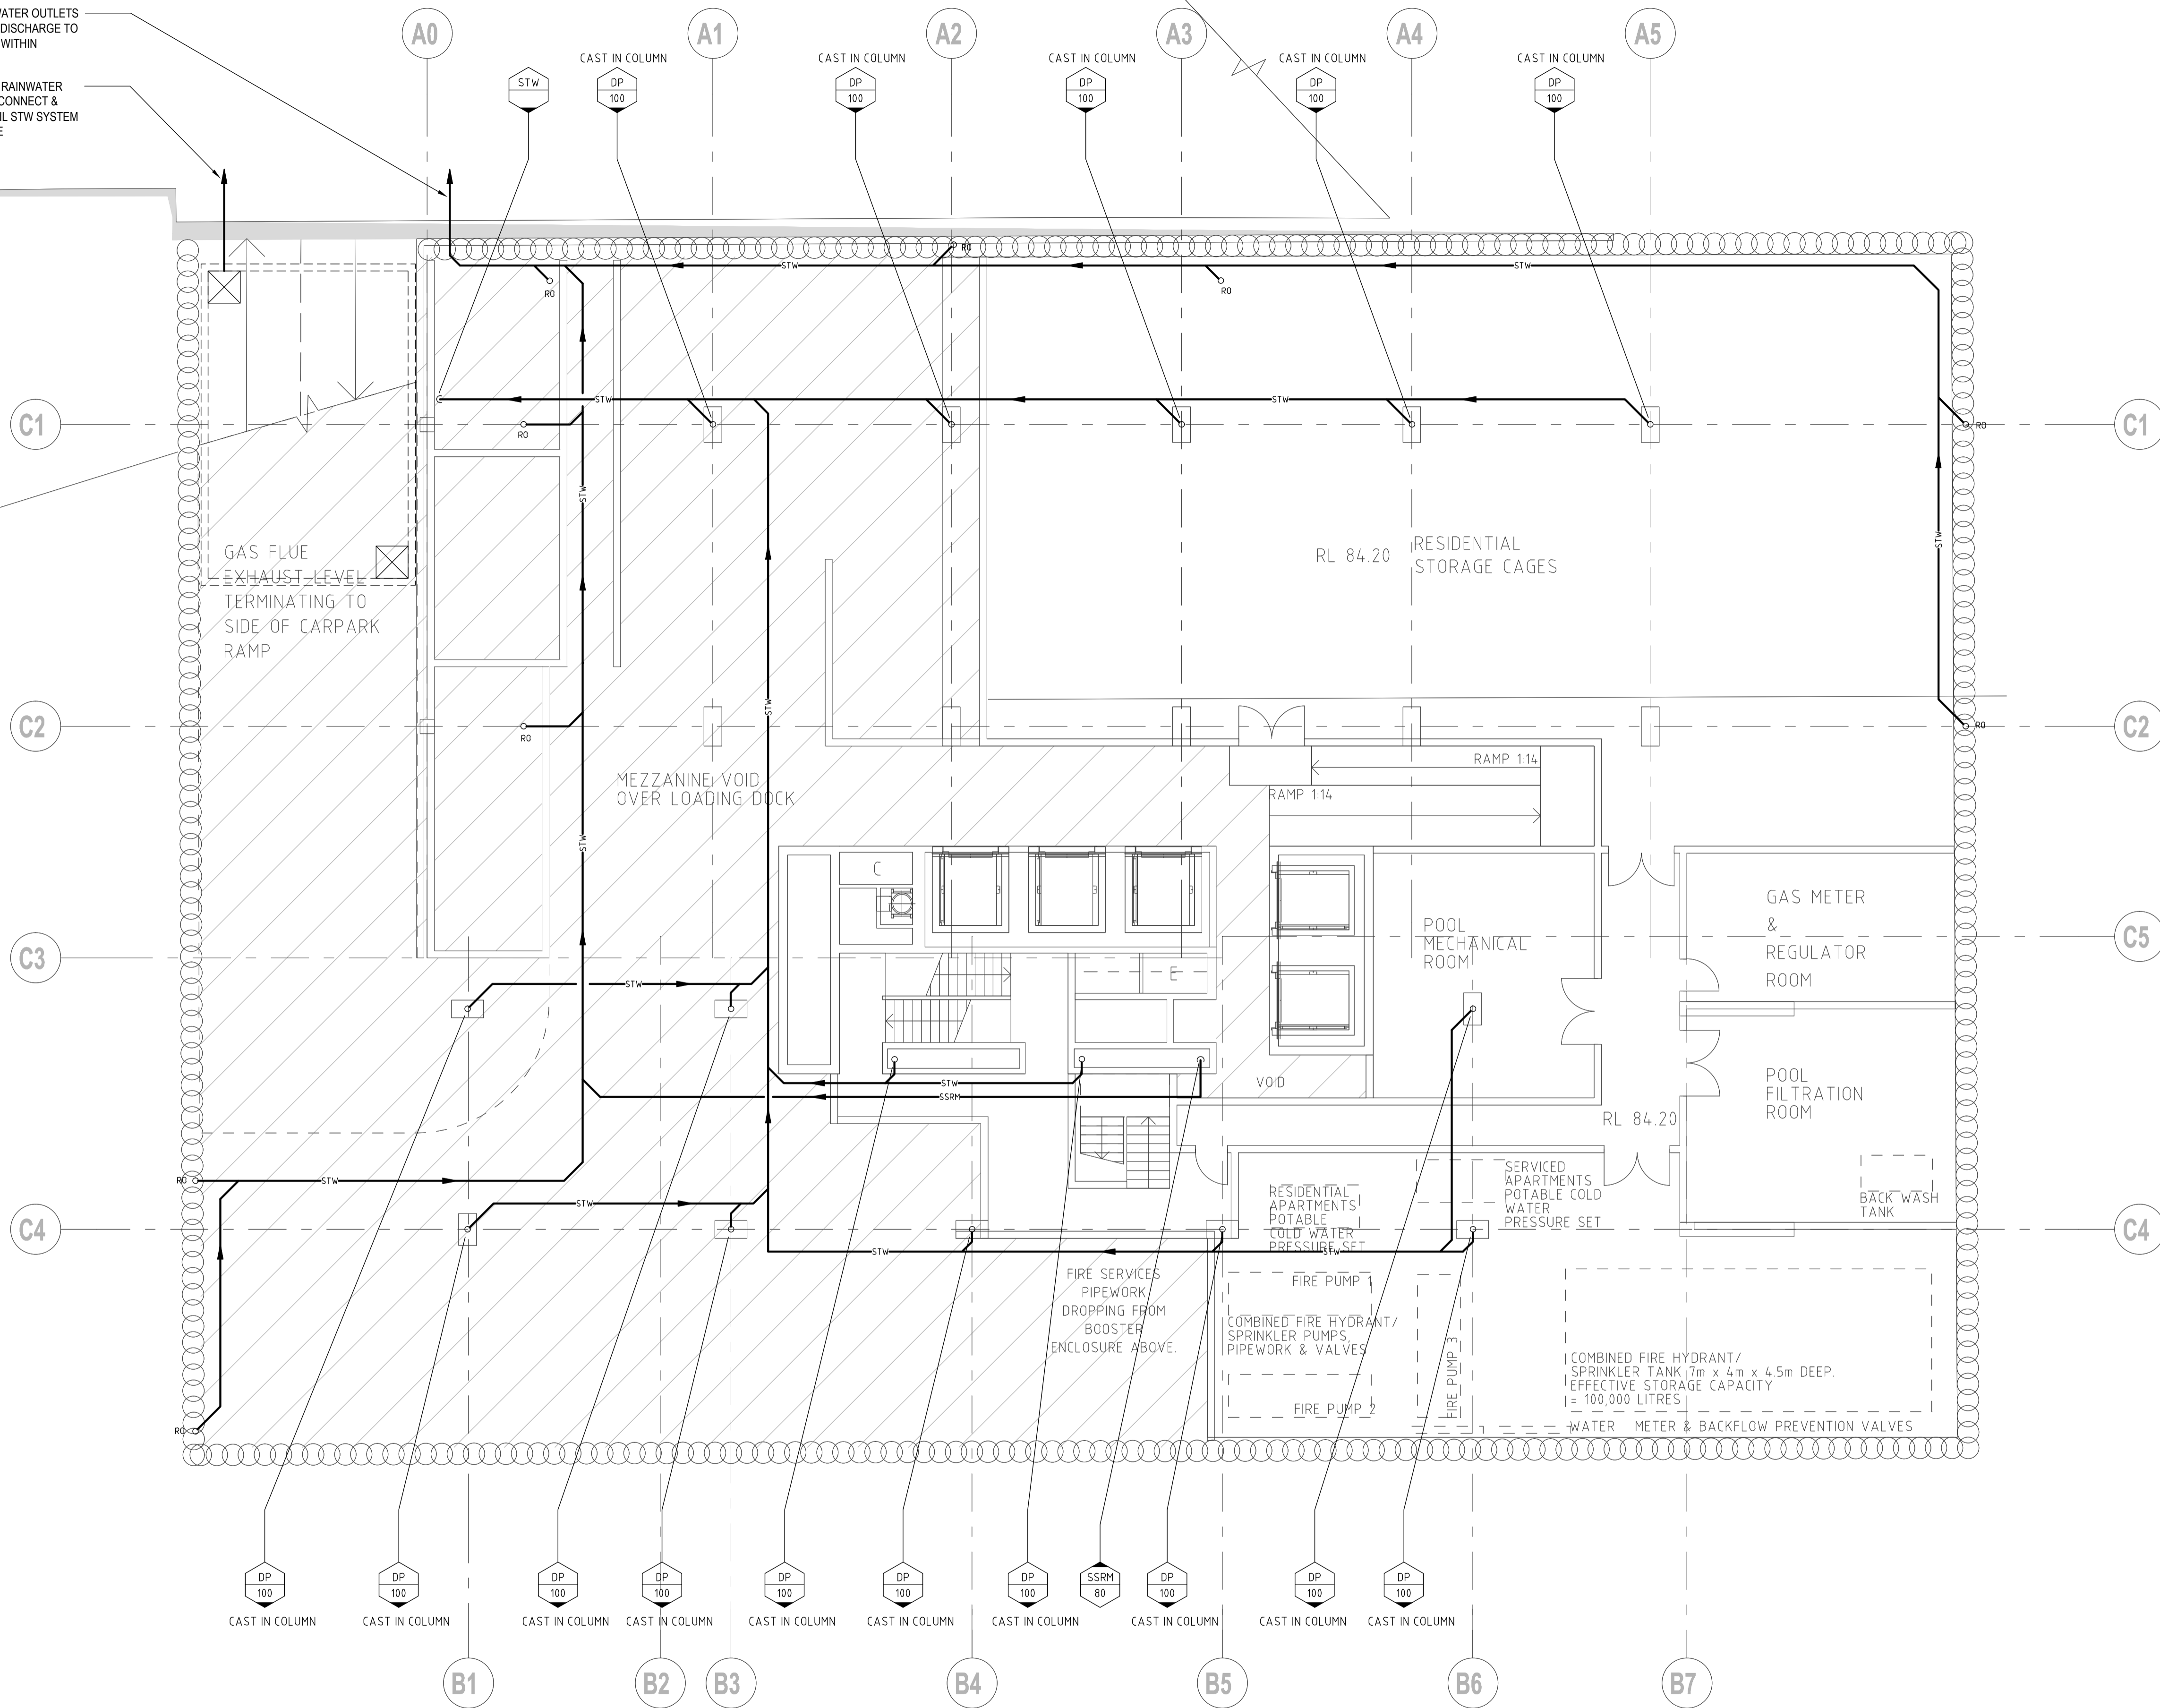

CONCEPT DESIGN
NOT TO BE USED FOR CONSTRUCTION PURPOSES

DO NOT SCALE FROM DRAWINGS, CHECK & VERIFY ALL DIMENSIONS & LEVELS BEFORE COMMENCEMENT OF ANY WORK.

THIS DRAWING IS NOT TO BE COPIED IN PART OR WHOLE WITHOUT WRITTEN PERMISSION FROM WARREN SMITH AND PARTNERS.

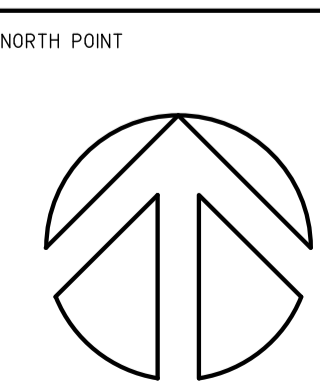

ISSUE	AMENDMENT	DATE	CLIENT	ARCHITECT
01	CONCEPT DESIGN ISSUE	10/06/10	Bancor - Atchison Street St Leonards - NSW	francis-jones morehen thorp fjmt incorporating MGT Sydney


SCALE	DRAWN	DESIGNED	CHECKED	APPROVED
1:100 @ A1 1:200 @ A3	DN	DN		

Warren Smith & Partners Pty Ltd
A 1st Floor, 123 Clarence Street, Sydney 2000 NSW Australia
T 02 9299 1312 F 02 9290 1295 E wsp@warrensmith.com.au
ABN 36 300 430 126

Consulting Engineers
Hydraulic Services | Civil Engineering | Fire Protection |
Sydney Water Accredited | Water Servicing Co-ordinator
• Design and Project Management


DATE	DRAWING No.	ISSUE
March 2010	H-104	01

DATE	JOB No.	SCALE	DRAWN	DESIGNED	CHECKED	APPROVED
March 2010	3532	1:100 @ A1 1:200 @ A3	DN	DN		

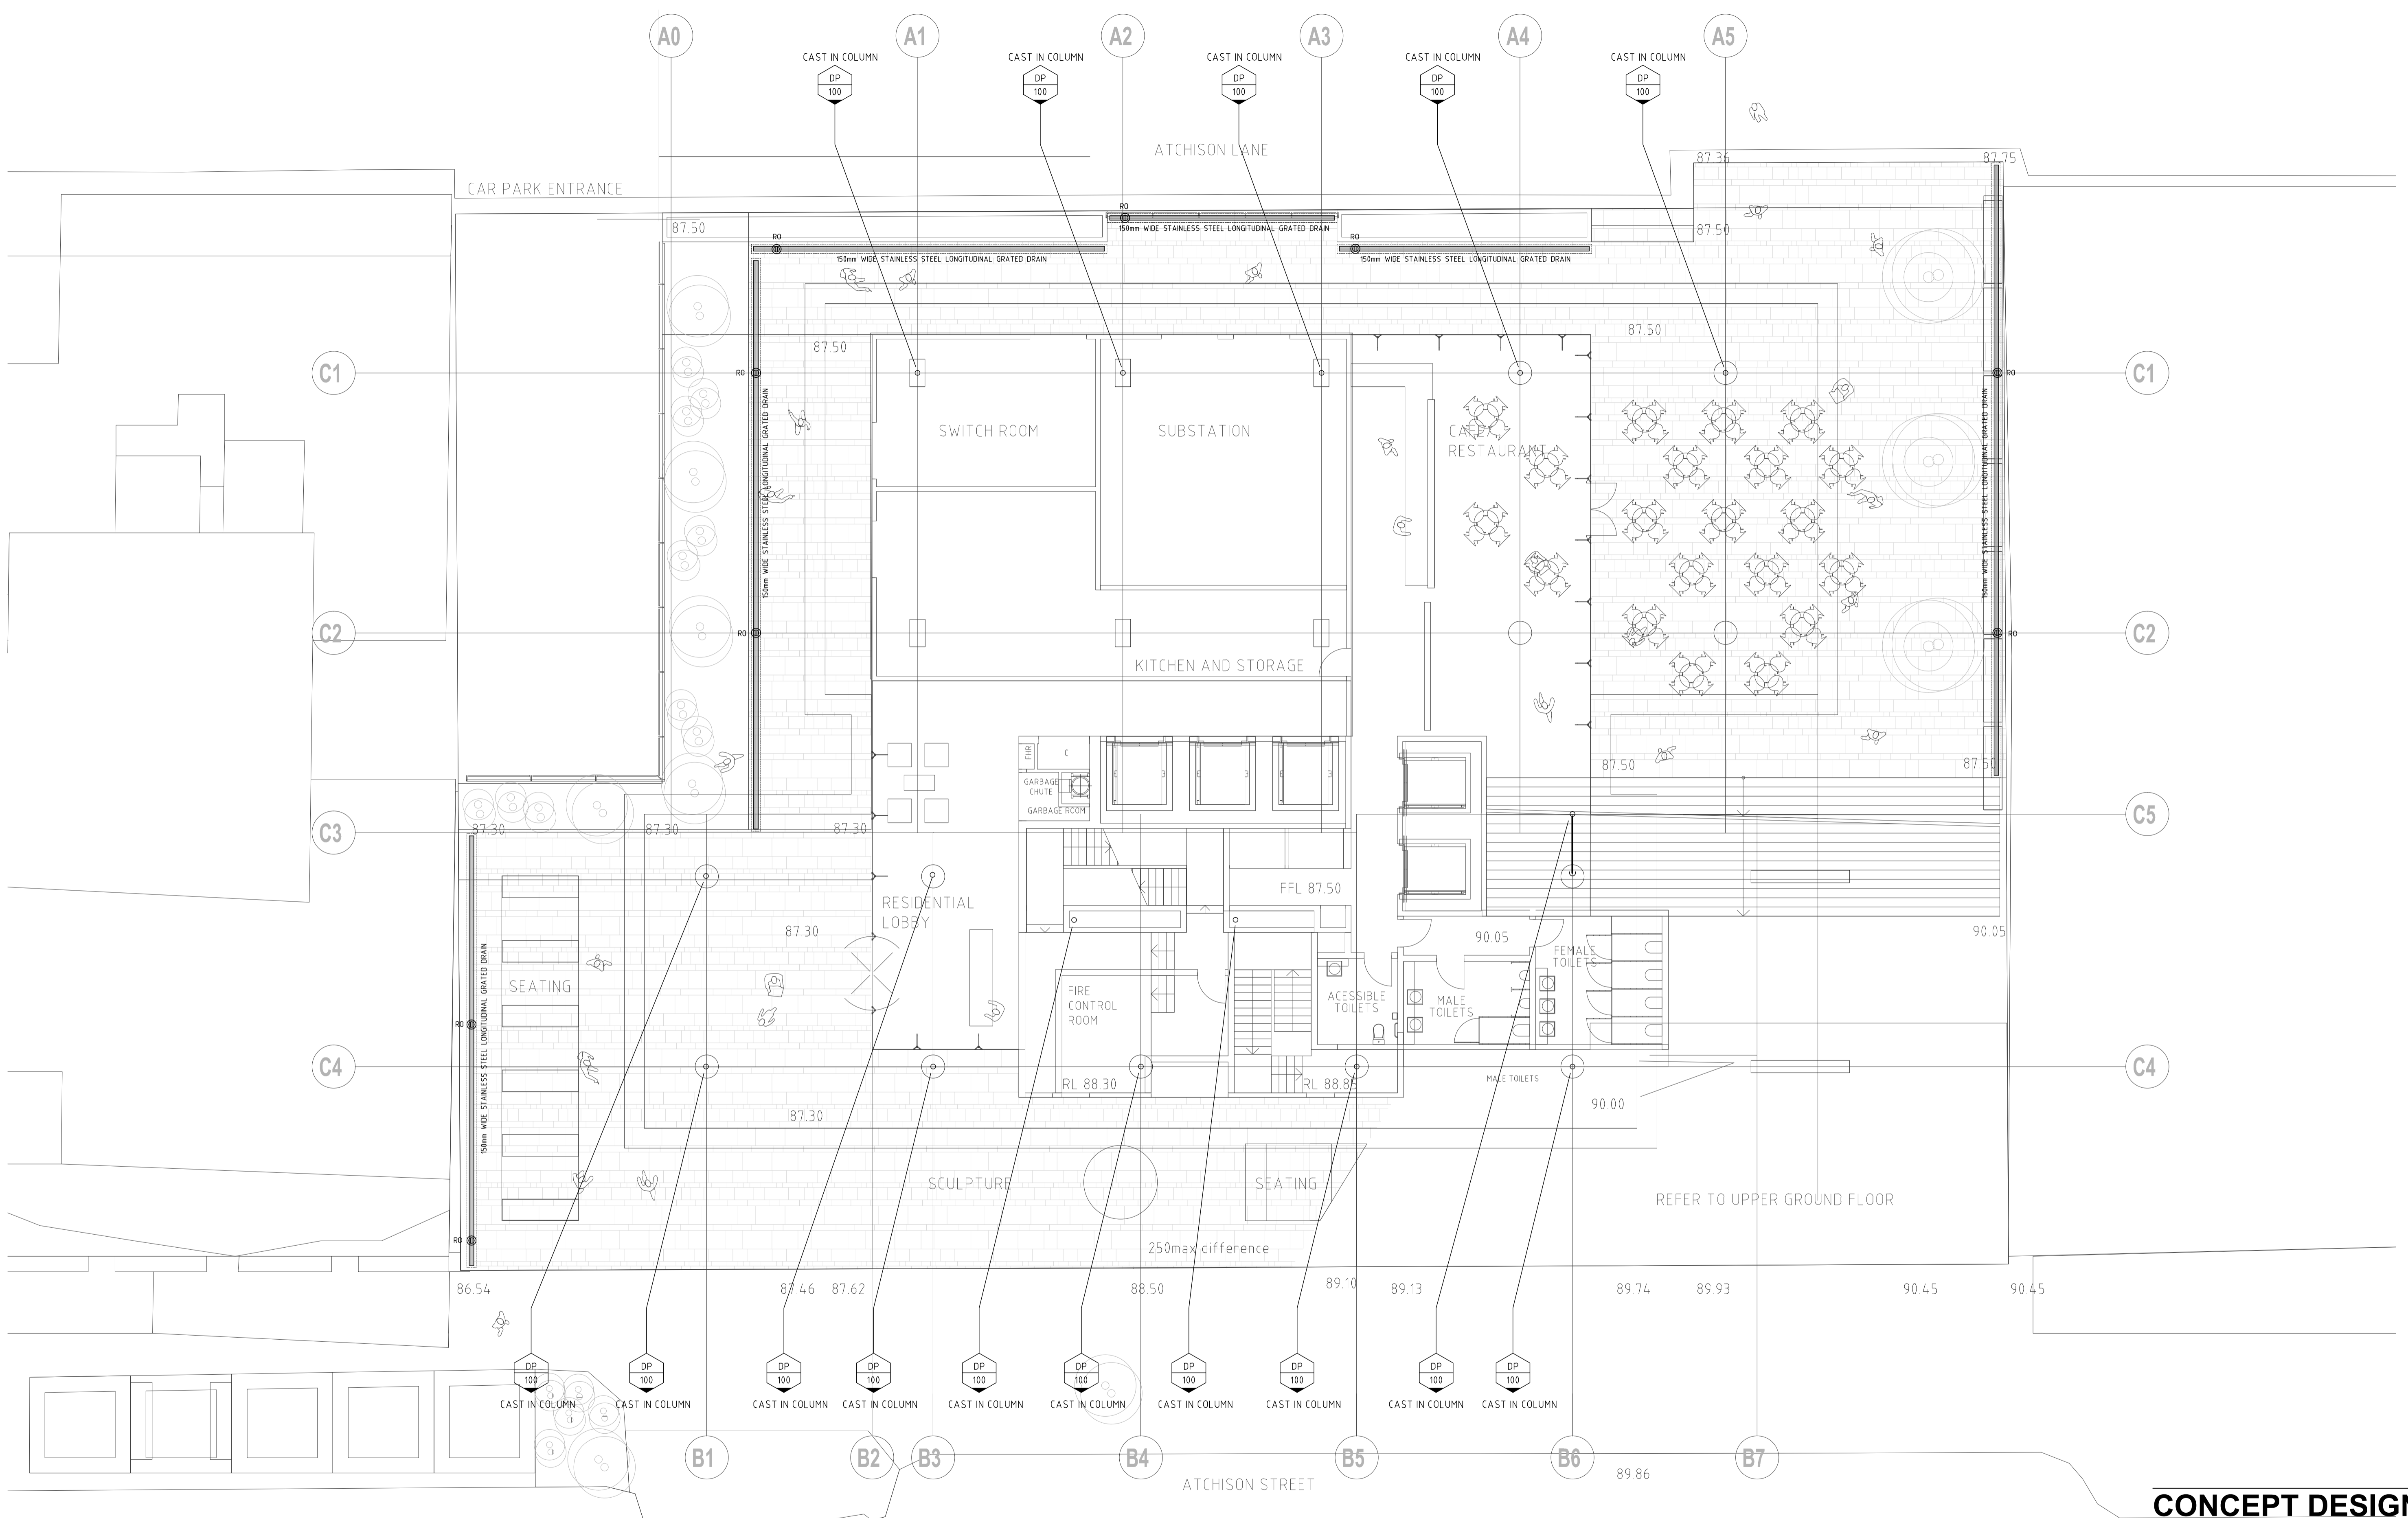

CONCEPT DESIGN
NOT TO BE USED FOR CONSTRUCTION PURPOSES

DO NOT SCALE FROM DRAWINGS, CHECK & VERIFY ALL DIMENSIONS & LEVELS BEFORE COMMENCEMENT OF ANY WORK.
THIS DRAWING IS NOT TO BE COPIED IN PART OR WHOLE WITHOUT WRITTEN PERMISSION FROM WARREN SMITH AND PARTNERS.

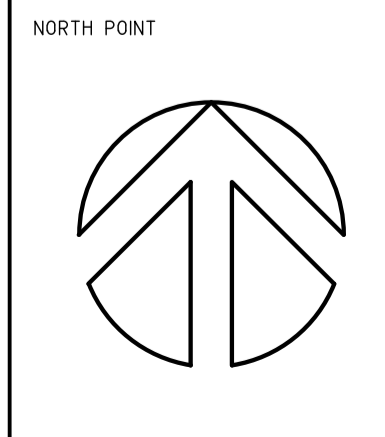

ISSUE	AMENDMENT	DATE	CLIENT	ARCHITECT
01	CONCEPT DESIGN ISSUE	10/06/10	Bancor - Atchison Street St Leonards - NSW	francis-jones morehen thorp fjmt incorporating MGT Sydney

DATE	CLIENT	ARCHITECT
10/06/10	Bancor - Atchison Street St Leonards - NSW	francis-jones morehen thorp fjmt incorporating MGT Sydney

Warren Smith & Partners Pty Ltd
A 1st Floor, 123 Clarence Street, Sydney 2000 NSW Australia
T 02 9299 1312 F 02 9290 1295 E wsp@warrensmith.com.au
ABN 36 300 430 126

Consulting Engineers
Hydraulic Services | Civil Engineering | Fire Protection |
Sydney Water Accredited | Water Servicing Co-ordinator
• Design and Project Management


SINCE 1981

Q
SERVING THE CONSTRUCTION INDUSTRY

SCALE	DRAWN	DESIGNED	CHECKED	APPROVED
1:100 @ A1 1:200 @ A3	DN	DN	DN	DN
DATE March 2010	DRAWING No. H-105		ISSUE 01	
JOB No. 3532				

DATE	DRAWING No.	ISSUE
March 2010	H-105	01


1:100 @ A1
 1:200 @ A3
 10 June 2010 3:01:22 PM

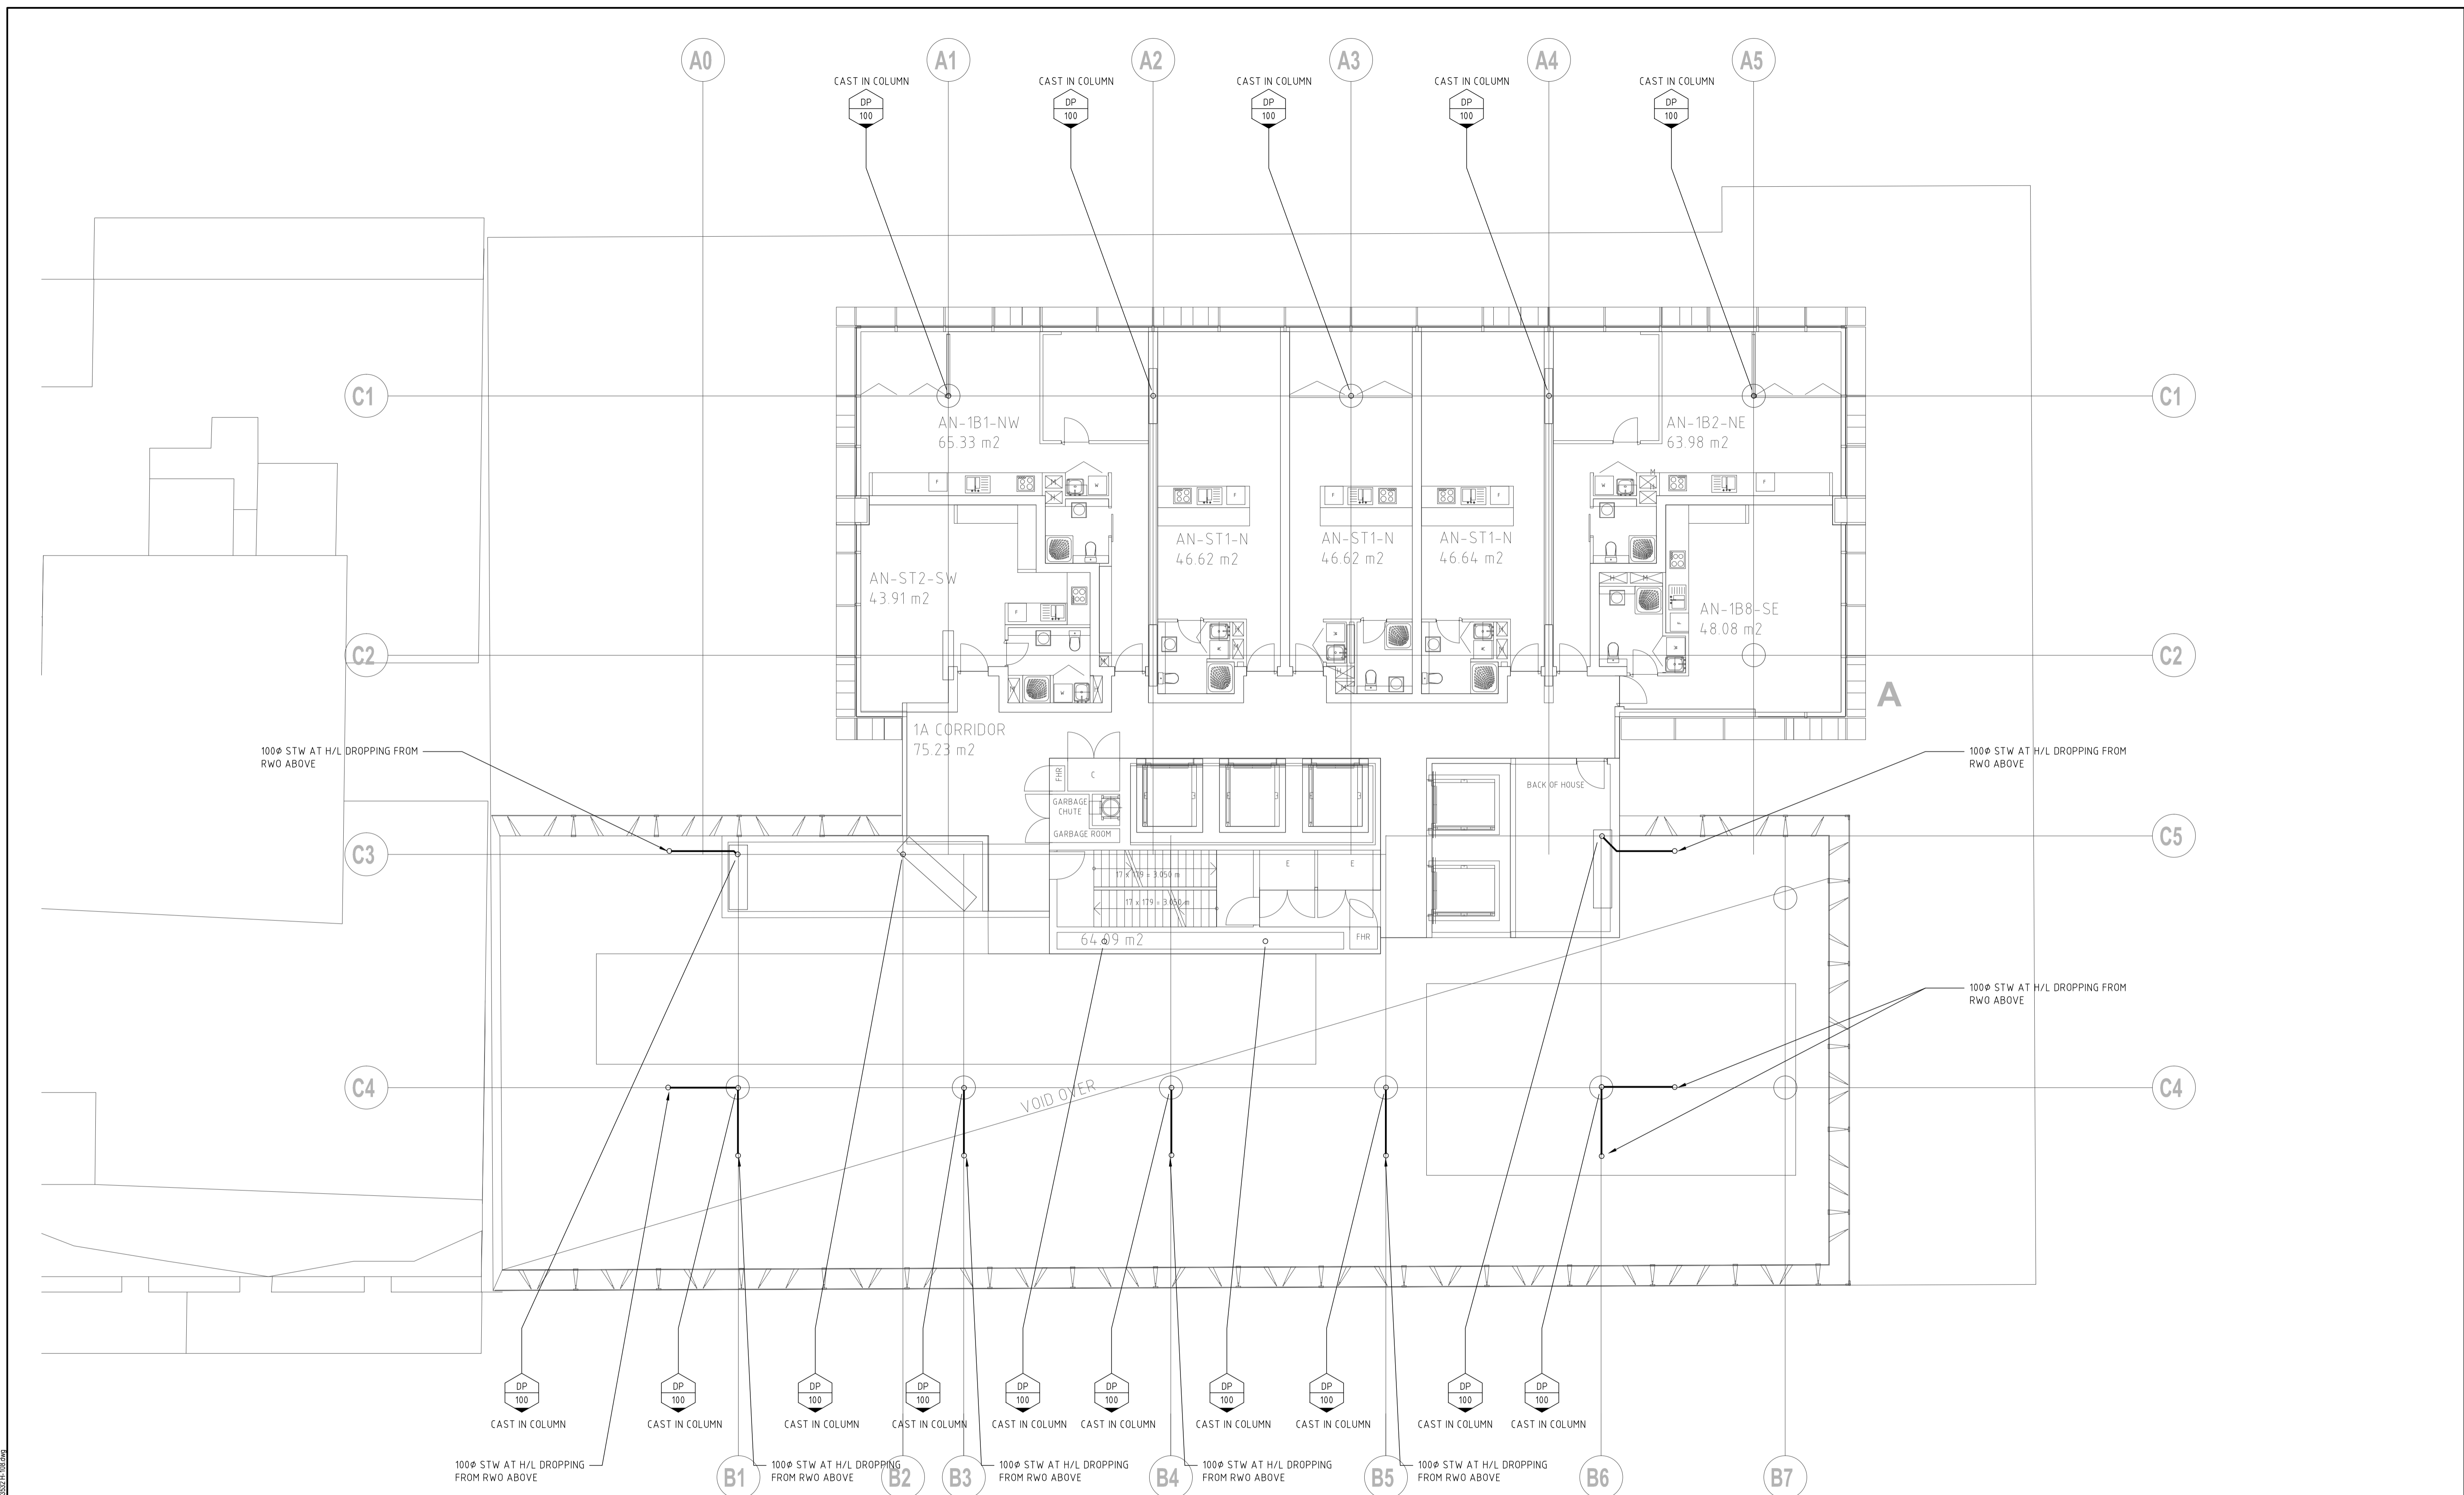

CONCEPT DESIGN
NOT TO BE USED FOR CONSTRUCTION PURPOSES

<p>DO NOT SCALE FROM DRAWINGS, CHECK & VERIFY ALL DIMENSIONS & LEVELS BEFORE COMMENCEMENT OF ANY WORK.</p> <p>THIS DRAWING IS NOT TO BE COPIED IN PART OR WHOLE WITHOUT WRITTEN PERMISSION FROM WARREN SMITH AND PARTNERS.</p>	<p>NORTH POINT</p>	<p>NOTES</p>	<p>ISSUE</p> <p>01</p>	<p>AMENDMENT</p> <p>CONCEPT DESIGN ISSUE</p>	<p>DATE</p> <p>10/06/10</p>	<p>CLIENT</p>	<p>ARCHITECT</p> <p>francis-jones morehen thorp</p> <p>fjmt</p> <p>incorporating MGT Sydney</p>	<p>Warren Smith & Partners Pty Ltd</p> <p>A 1st Floor, 123 Clarence Street, Sydney 2000 NSW Australia T 02 9299 1312 F 02 9290 1295 E wsp@warrensmith.com.au ABN 36 300 430 126</p> <p>SERVING THE CONSTRUCTION INDUSTRY SINCE 1981</p> <p>Consulting Engineers Hydraulic Services Civil Engineering Fire Protection Sydney Water Accredited Water Servicing Co-ordinator • Design and Project Management</p>	<p>TITLE</p> <p>HOTEL LEVEL B STORMWATER SERVICES PLAN</p>	
			<p>PROJECT</p> <p>Bancor - Atchison Street St Leonards - NSW</p>	<p>SYDNEY</p> <p>Level 5/ICA, 140 George Street Sydney NSW 2000 Australia T +61 2 9251 7077 F +61 2 9251 7072 E fjmt@fjmt.com.au W www.fjmt.com.au</p> <p>NON-REGISTERED ARCHITECT (REGNO 17049) (REGNO 162 3056)</p>	<p>SCALE</p> <p>1:100 @ A1 1:200 @ A3</p>	<p>DRAWN</p> <p>DN</p>	<p>DESIGNED</p> <p>DN</p>	<p>CHECKED</p>	<p>APPROVED</p>	<p>DATE</p> <p>March 2010</p>
								<p>JOB No.</p> <p>3532</p>		


Xref: 1002, 1003, 1004, 2839,

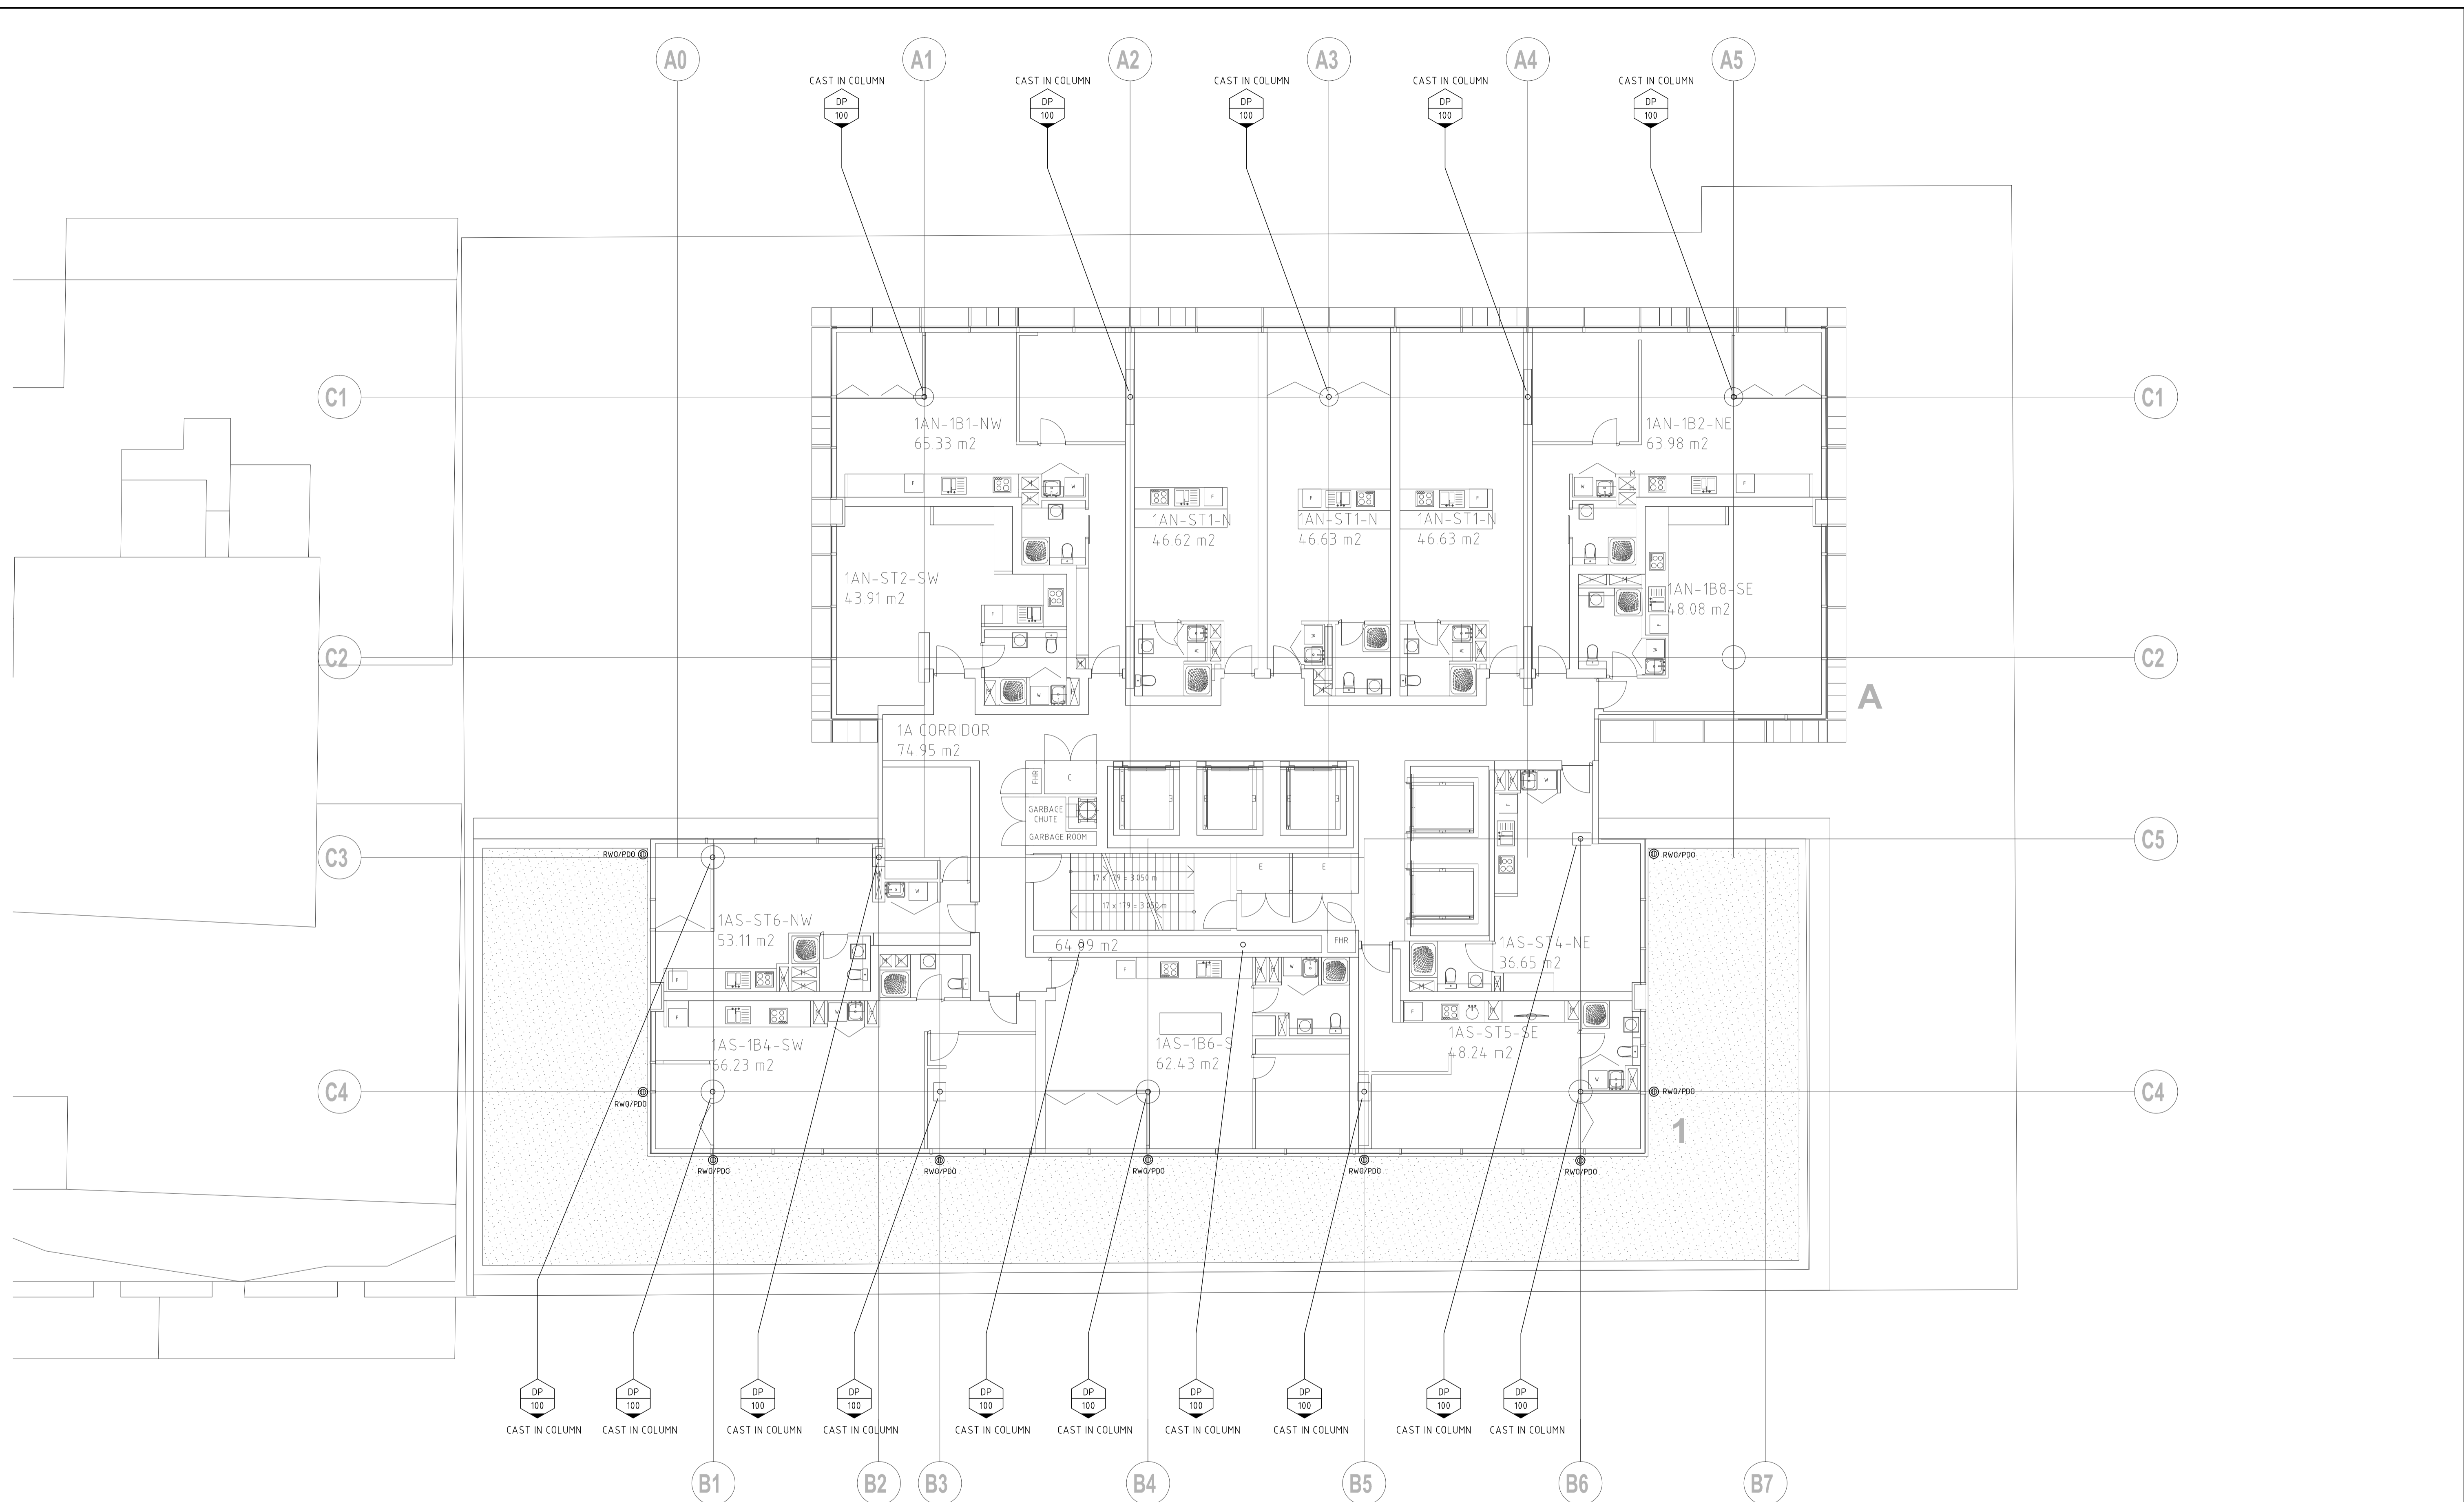

CONCEPT DESIGN
NOT TO BE USED FOR CONSTRUCTION PURPOSES


<p>DO NOT SCALE FROM DRAWINGS, CHECK & VERIFY ALL DIMENSIONS & LEVELS BEFORE COMMENCEMENT OF ANY WORK.</p> <p>THIS DRAWING IS NOT TO BE COPIED IN PART OR WHOLE WITHOUT WRITTEN PERMISSION FROM WARREN SMITH AND PARTNERS.</p>	<p>NORTH POINT</p>	<p>NOTES</p>	<p>ISSUE</p> <p>01</p>	<p>AMENDMENT</p> <p>CONCEPT DESIGN ISSUE</p>	<p>DATE</p> <p>10/06/10</p>	<p>CLIENT</p>	<p>ARCHITECT</p> <p>francis-jones morehen thorp</p> <p>fjmt</p> <p>incorporating MGT Sydney</p>	<p>PROJECT</p> <p>Bancor - Atchison Street St Leonards - NSW</p>	<p>WARREN SMITH & PARTNERS PTY LTD</p> <p>Level 5/111, 111 George Street, Sydney NSW 2000 Australia T: 02 9299 1312 F: 02 9290 1295 E: wsp@warrensmith.com.au ABN: 36 300 430 126</p> <p>SYDNEY Level 5/111, 111 George Street, Sydney NSW 2000 Australia T: +61 2 9251 7077 F: +61 2 9251 7072 E: fjmt@fjmt.com.au W: www.fjmt.com.au</p> <p>NON-REGISTERED ARCHITECT (REGNO 17071)</p>	<p>WARREN SMITH & PARTNERS PTY LTD</p> <p>SERVING THE CONSTRUCTION INDUSTRY SINCE 1981</p> <p>Consulting Engineers Hydraulic Services Civil Engineering Fire Protection Sydney Water Accredited Water Servicing Co-ordinator Design and Project Management</p>	<p>TITLE</p> <p>HOTEL LEVEL C STORMWATER SERVICES PLAN</p>	<table border="1"> <tr> <td>SCALE</td> <td>1:100 @ A1 1:200 @ A3</td> <td>DRAWN</td> <td>DESIGNED</td> <td>CHECKED</td> <td>APPROVED</td> </tr> <tr> <td>DATE</td> <td>March 2010</td> <td colspan="2">DRAWING No.</td> <td colspan="2">ISSUE</td> </tr> <tr> <td>JOB No.</td> <td>3532</td> <td colspan="2">H-109</td> <td colspan="2">01</td> </tr> </table>	SCALE	1:100 @ A1 1:200 @ A3	DRAWN	DESIGNED	CHECKED	APPROVED	DATE	March 2010	DRAWING No.		ISSUE		JOB No.	3532	H-109		01	
			SCALE	1:100 @ A1 1:200 @ A3	DRAWN	DESIGNED	CHECKED	APPROVED																						
DATE	March 2010	DRAWING No.		ISSUE																										
JOB No.	3532	H-109		01																										
<p>Plot Date: 10 June 2010 3:01:30 PM</p>																														

X:\p\3532_101_A1\Hot\Level C - 1.dwg, 14 June 2010 10:06:10 AM, Project 10/06/10, Plot Date: 10/06/2010 10:06:10 AM, User: Warren Smith, Job No: 3532, Job Name: Bancor - Atchison Street - NSW

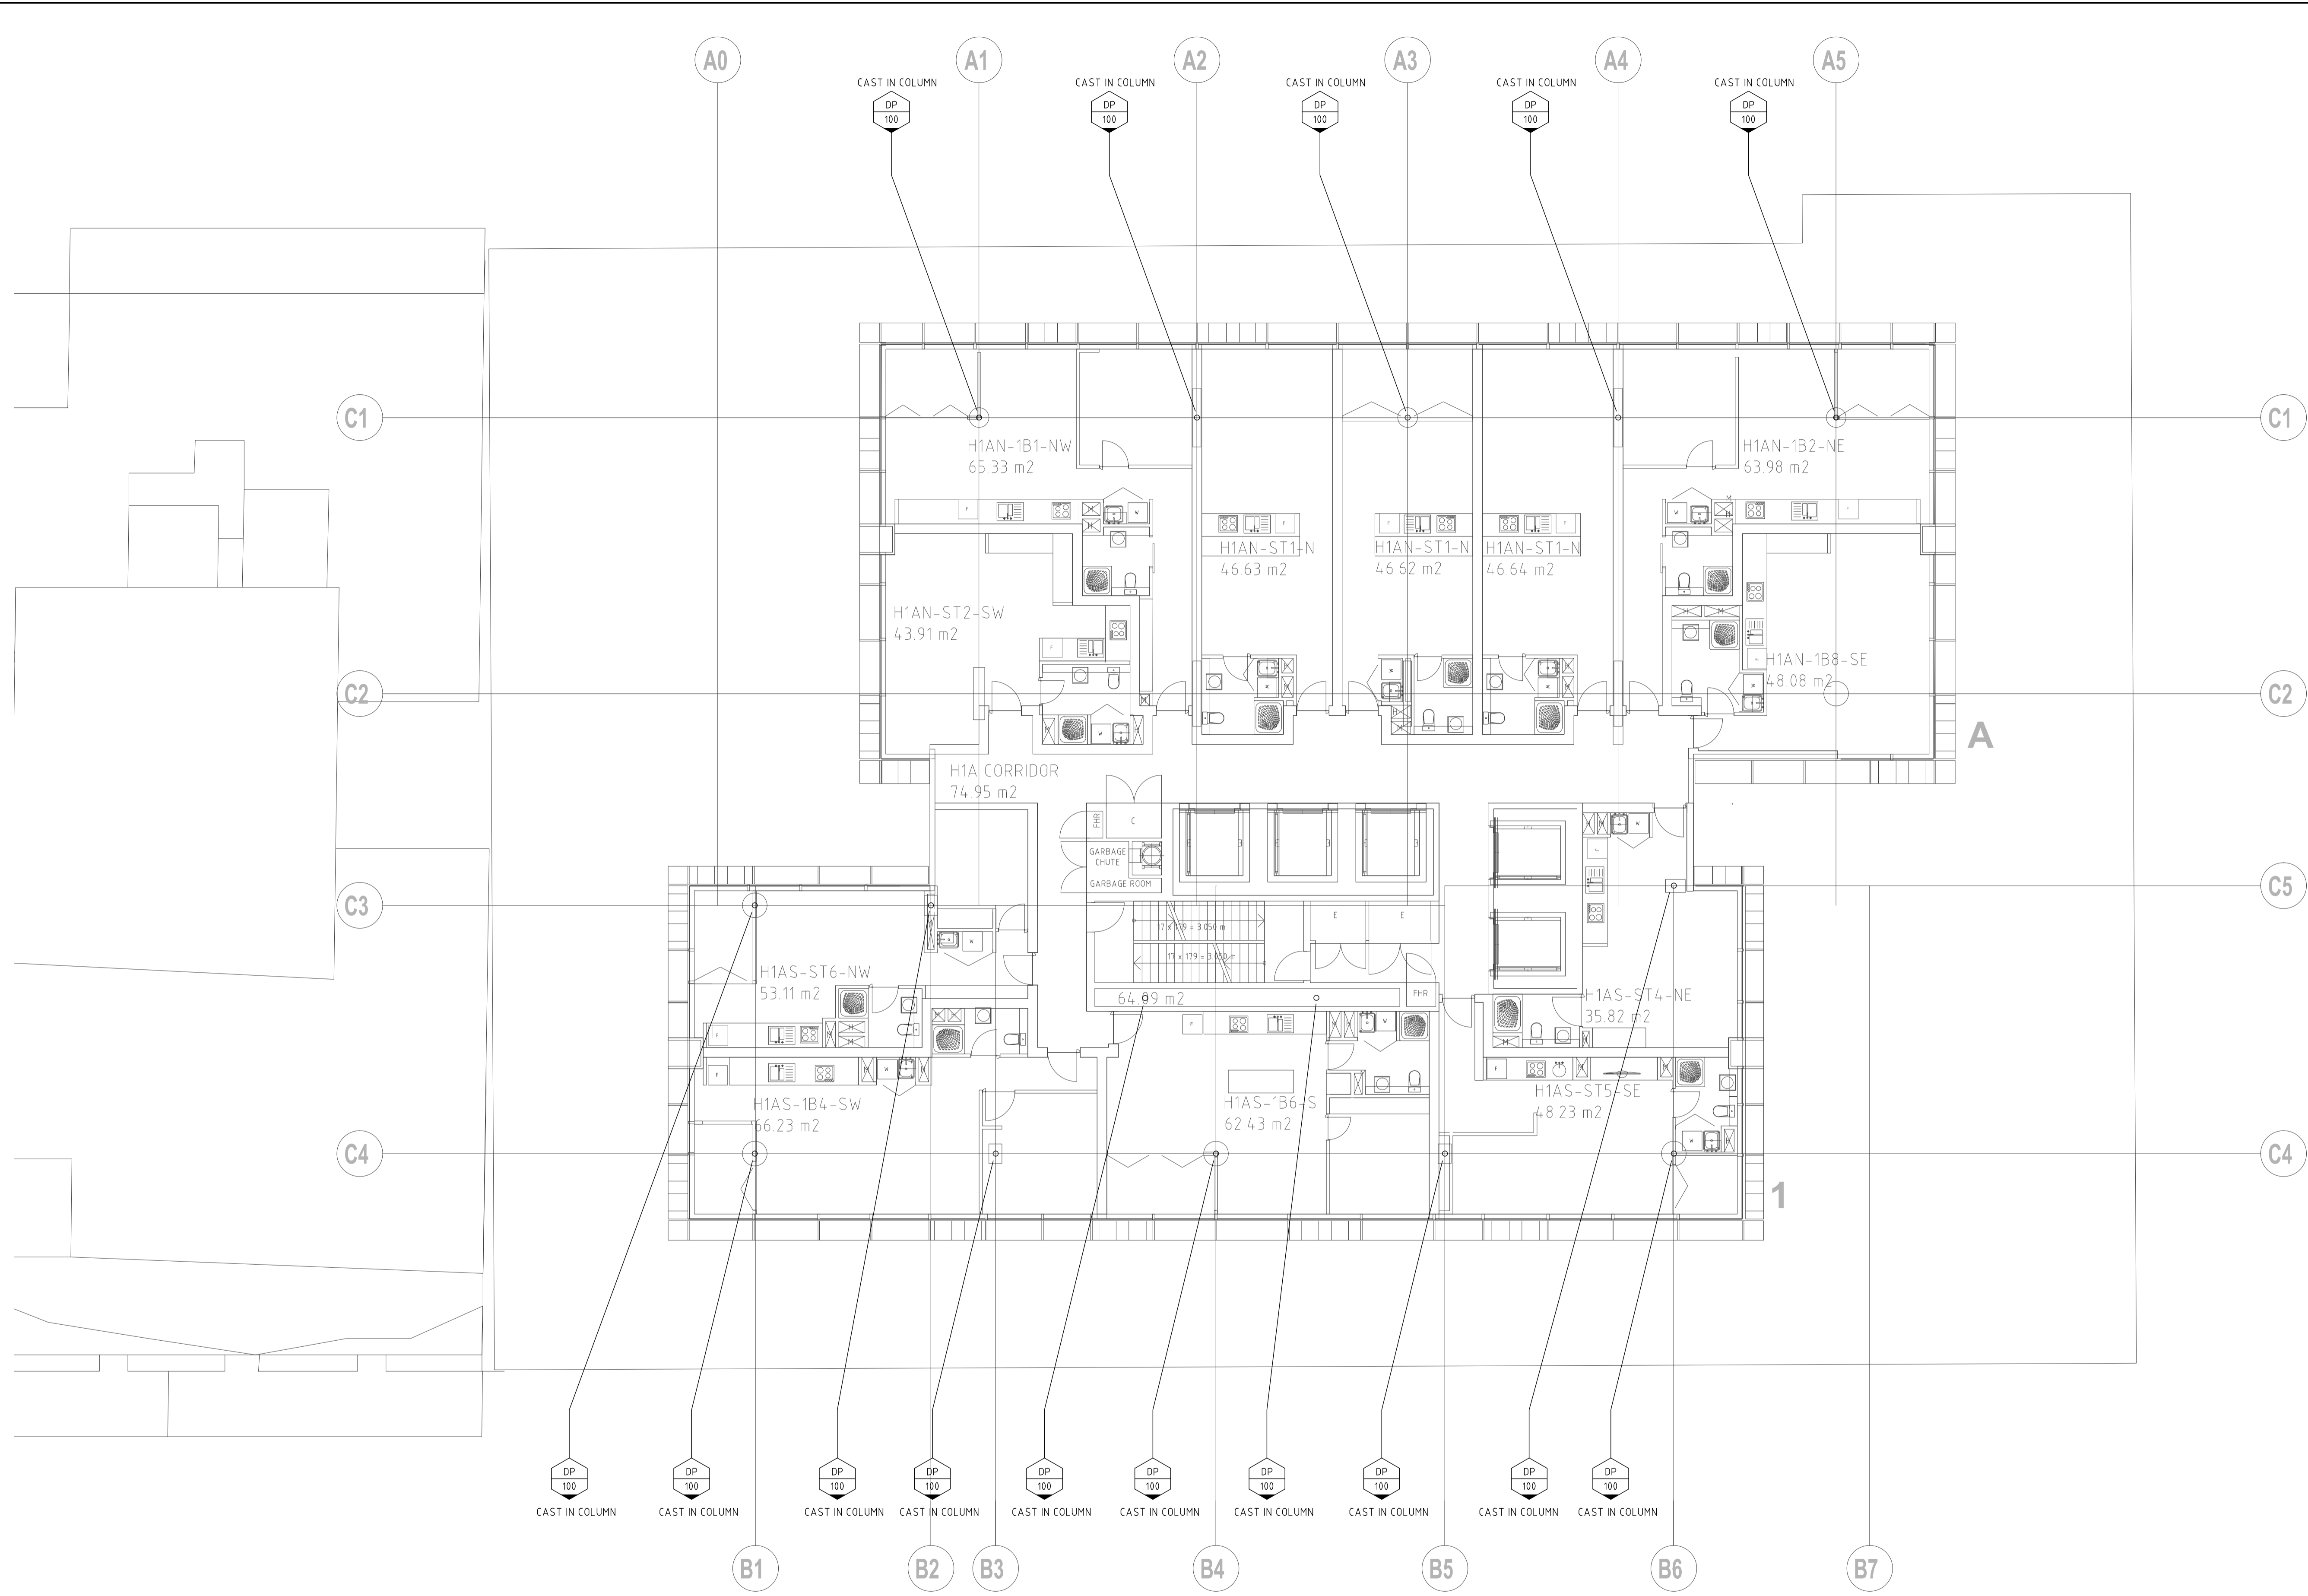

CONCEPT DESIGN
NOT TO BE USED FOR CONSTRUCTION PURPOSES

DO NOT SCALE FROM DRAWINGS, CHECK & VERIFY ALL DIMENSIONS & LEVELS BEFORE COMMENCEMENT OF ANY WORK.
THIS DRAWING IS NOT TO BE COPIED IN PART OR WHOLE WITHOUT WRITTEN PERMISSION FROM WARREN SMITH AND PARTNERS.

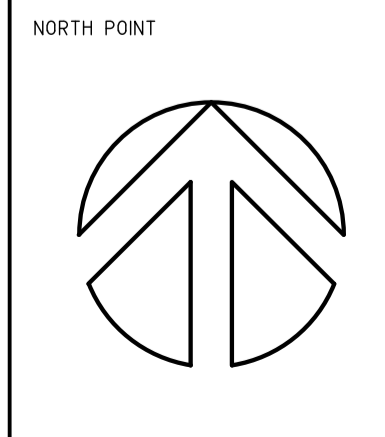

ISSUE	AMENDMENT	DATE	CLIENT	ARCHITECT
01	CONCEPT DESIGN ISSUE	10/06/10	Bancor - Atchison Street St Leonards - NSW	francis-jones morehen thorp fjmt incorporating MGT Sydney SYDNEY Level 5/MA, 140 George Street Sydney NSW 2000 Australia T +61 2 9551 7077 F +61 2 9551 7072 E fjm@fjmt.com.au W www.fjmt.com.au NONRATED ARCHITECT (REGULATED UNDER THE 2003 ACT)

DATE	CLIENT	ARCHITECT
10/06/10	Bancor - Atchison Street St Leonards - NSW	francis-jones morehen thorp fjmt incorporating MGT Sydney SYDNEY Level 5/MA, 140 George Street Sydney NSW 2000 Australia T +61 2 9551 7077 F +61 2 9551 7072 E fjm@fjmt.com.au W www.fjmt.com.au NONRATED ARCHITECT (REGULATED UNDER THE 2003 ACT)


DATE	CLIENT	ARCHITECT
10/06/10	Bancor - Atchison Street St Leonards - NSW	francis-jones morehen thorp fjmt incorporating MGT Sydney SYDNEY Level 5/MA, 140 George Street Sydney NSW 2000 Australia T +61 2 9551 7077 F +61 2 9551 7072 E fjm@fjmt.com.au W www.fjmt.com.au NONRATED ARCHITECT (REGULATED UNDER THE 2003 ACT)

Warren Smith & Partners Pty Ltd
A 1st Floor, 123 Clarence Street, Sydney 2000 NSW Australia
T 02 9299 1312 F 02 9290 1295 E wsp@warrensmith.com.au
ABN 36 300 430 126

SERVING THE CONSTRUCTION INDUSTRY SINCE 1981


Consulting Engineers
Hydraulic Services | Civil Engineering | Fire Protection |
Sydney Water Accredited | Water Servicing Co-ordinator
• Design and Project Management

DATE	CLIENT	ARCHITECT
10/06/10	Bancor - Atchison Street St Leonards - NSW	francis-jones morehen thorp fjmt incorporating MGT Sydney SYDNEY Level 5/MA, 140 George Street Sydney NSW 2000 Australia T +61 2 9551 7077 F +61 2 9551 7072 E fjm@fjmt.com.au W www.fjmt.com.au NONRATED ARCHITECT (REGULATED UNDER THE 2003 ACT)

 

SHEET SIZE: **A1**

Plot Date: 10 June 2010 3:01:45 PM

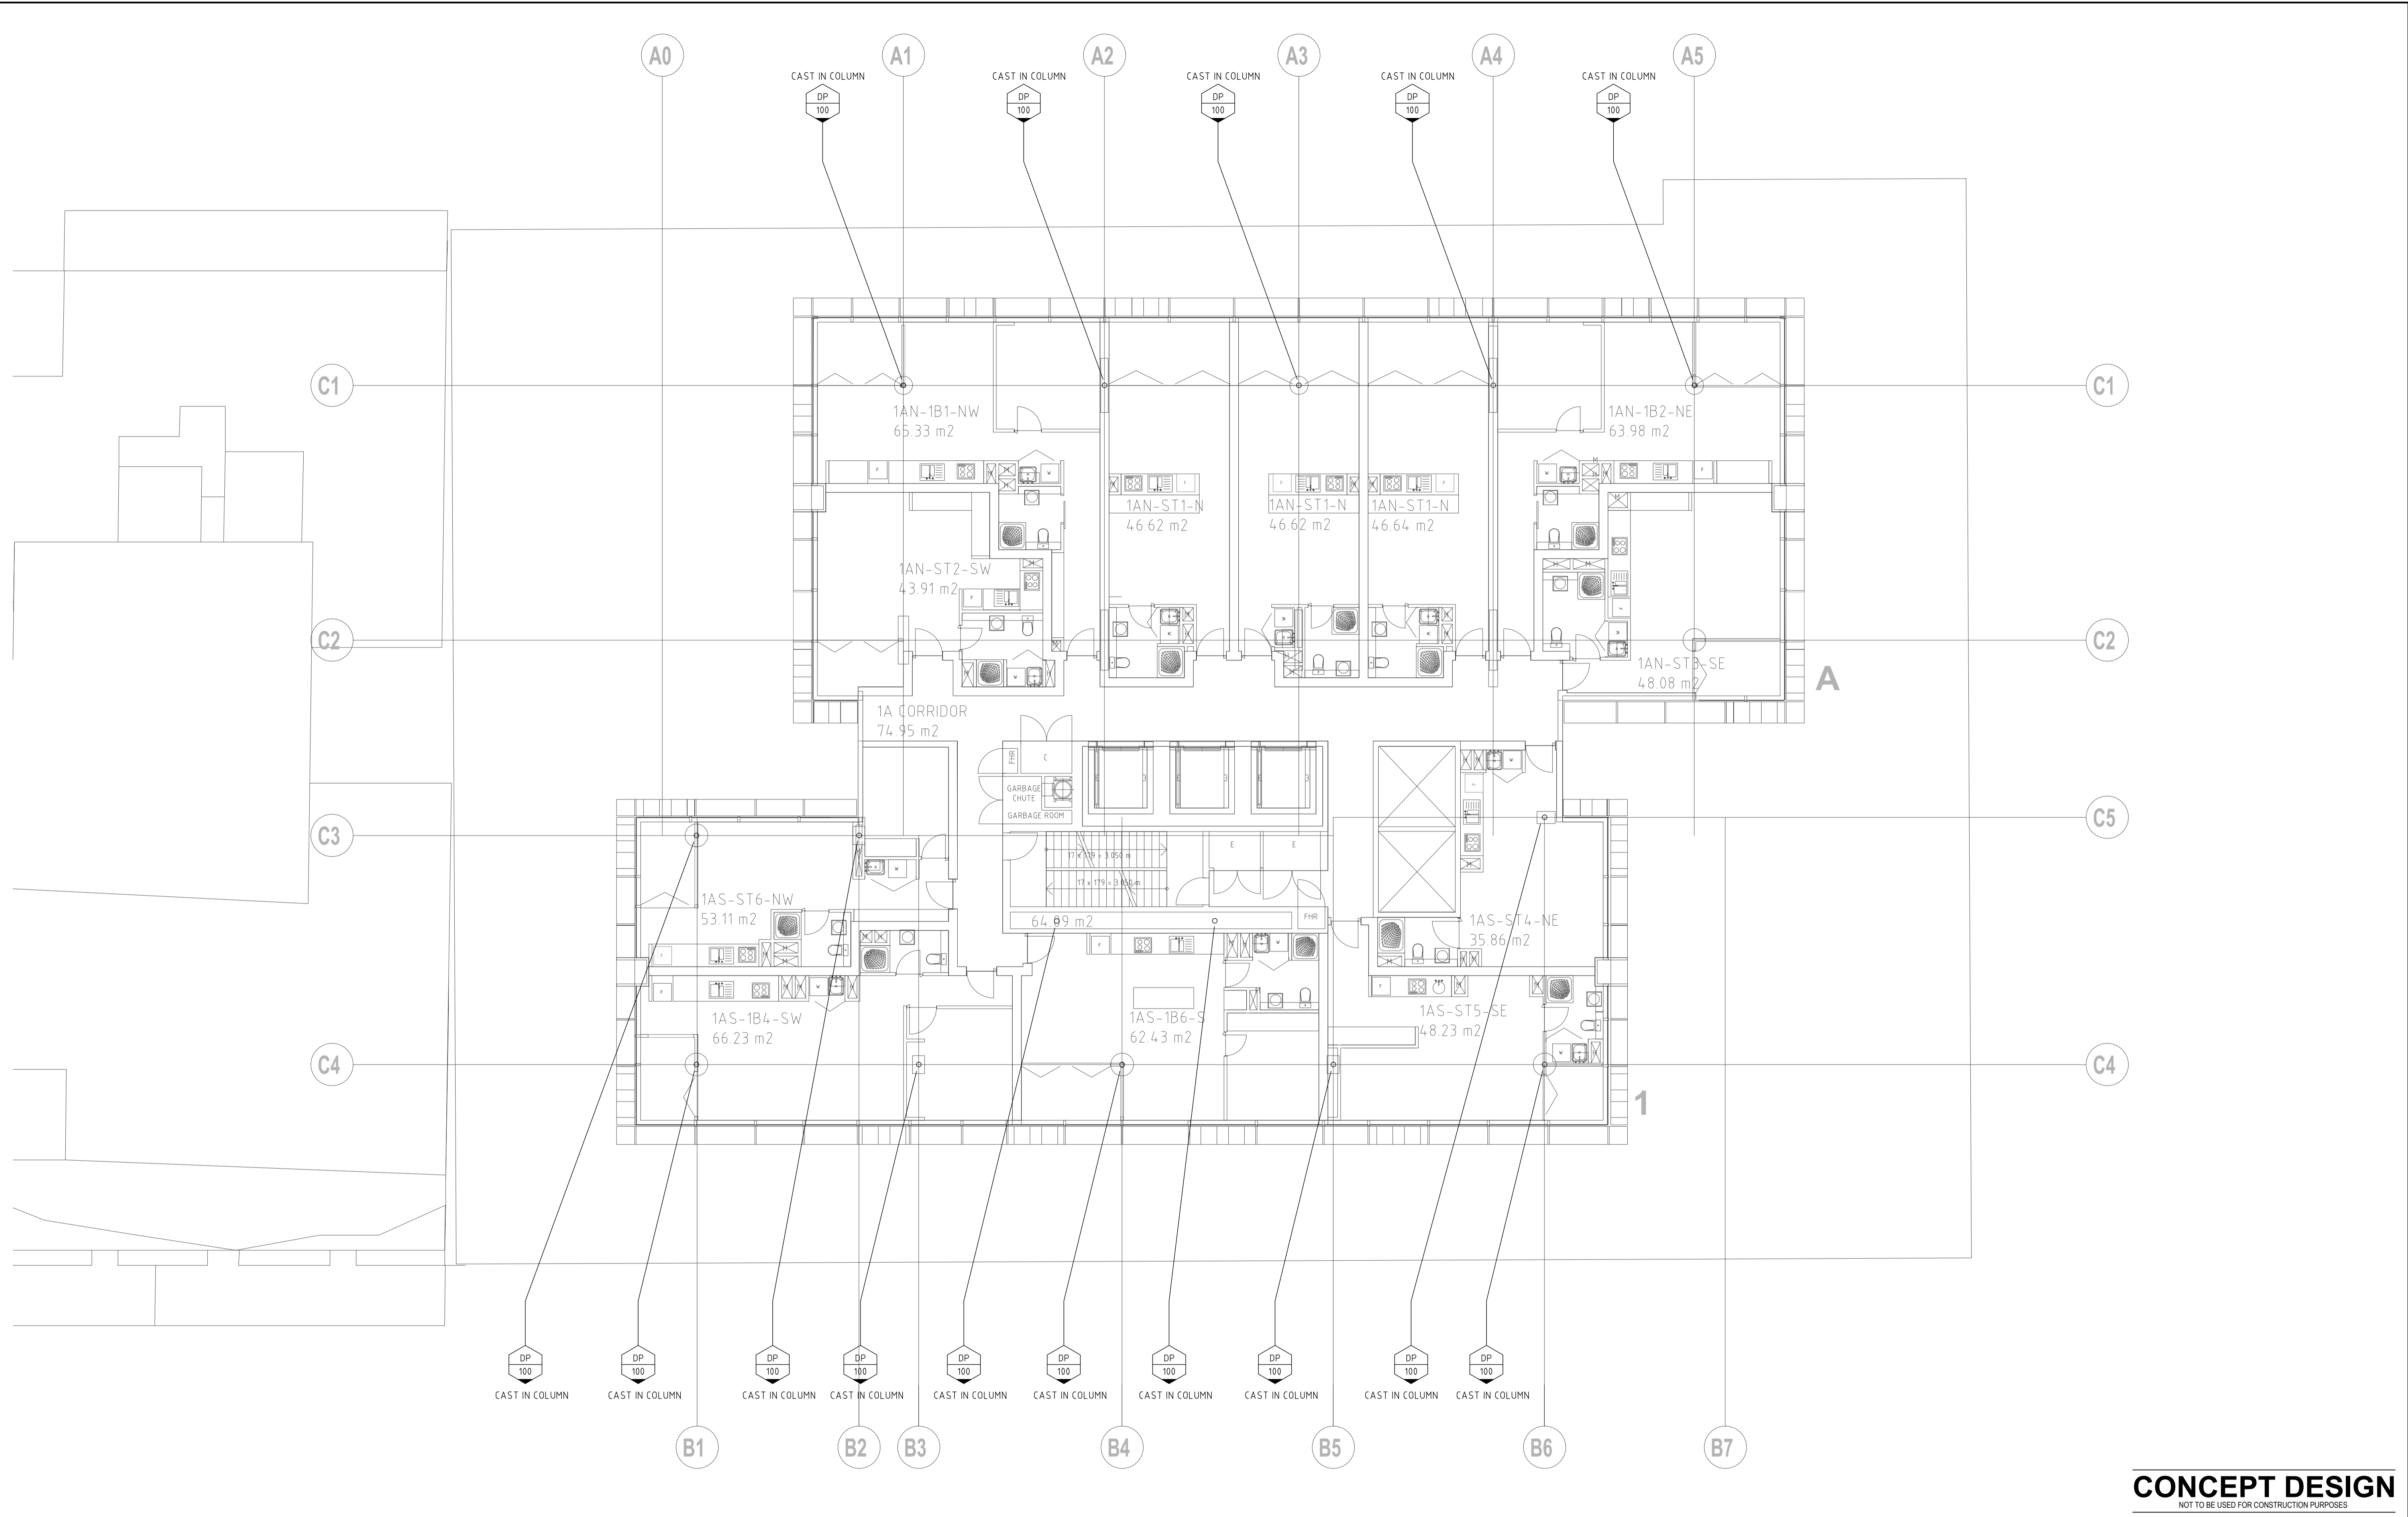

CONCEPT DESIGN
NOT TO BE USED FOR CONSTRUCTION PURPOSES

Xref: 2023_1111_A1_1.dwg (Rev: 1) Path: C:\Users\j.mohr\OneDrive\Documents\1111.dwg (15 Rev: 1) Plot Date: 10/06/2010 3:01:50 PM User: j.mohr

DO NOT SCALE FROM DRAWINGS, CHECK & VERIFY ALL DIMENSIONS & LEVELS BEFORE COMMENCEMENT OF ANY WORK.

THIS DRAWING IS NOT TO BE COPIED IN PART OR WHOLE WITHOUT WRITTEN PERMISSION FROM WARREN SMITH AND PARTNERS.

ISSUE	AMENDMENT	DATE	CLIENT
01	CONCEPT DESIGN ISSUE	10/06/10	

ARCHITECT
francis-jones morehen thorp fjmt incorporating MGT Sydney <small>NON-RATED ARCHITECT (REVISED THORP (RIS) NO 2006)</small>


PROJECT
Bancor - Atchison Street St Leonards - NSW

Warren Smith & Partners Pty Ltd
 A 1st Floor, 123 Clarence Street, Sydney 2000 NSW Australia
 T 02 9299 1312 F 02 9290 1295 E wsp@warrensmith.com.au
 ABN 36 300 430 126

SERVING THE CONSTRUCTION INDUSTRY SINCE 1981

Consulting Engineers
 Hydraulic Services | Civil Engineering | Fire Protection |
 Sydney Water Accredited | Water Servicing Co-ordinator
 • Design and Project Management

TITLE	SCALE	DRAWN	DESIGNED	CHECKED	APPROVED
TYPICAL RESIDENTIAL TYPE 1A (WITH LIFT OVERRUN) STORMWATER SERVICES PLAN	1:100 @ A1 1:200 @ A3	DN	DN		
DATE	DRAWING No.	ISSUE			
March 2010	H-111	01			
JOB No.	3532				

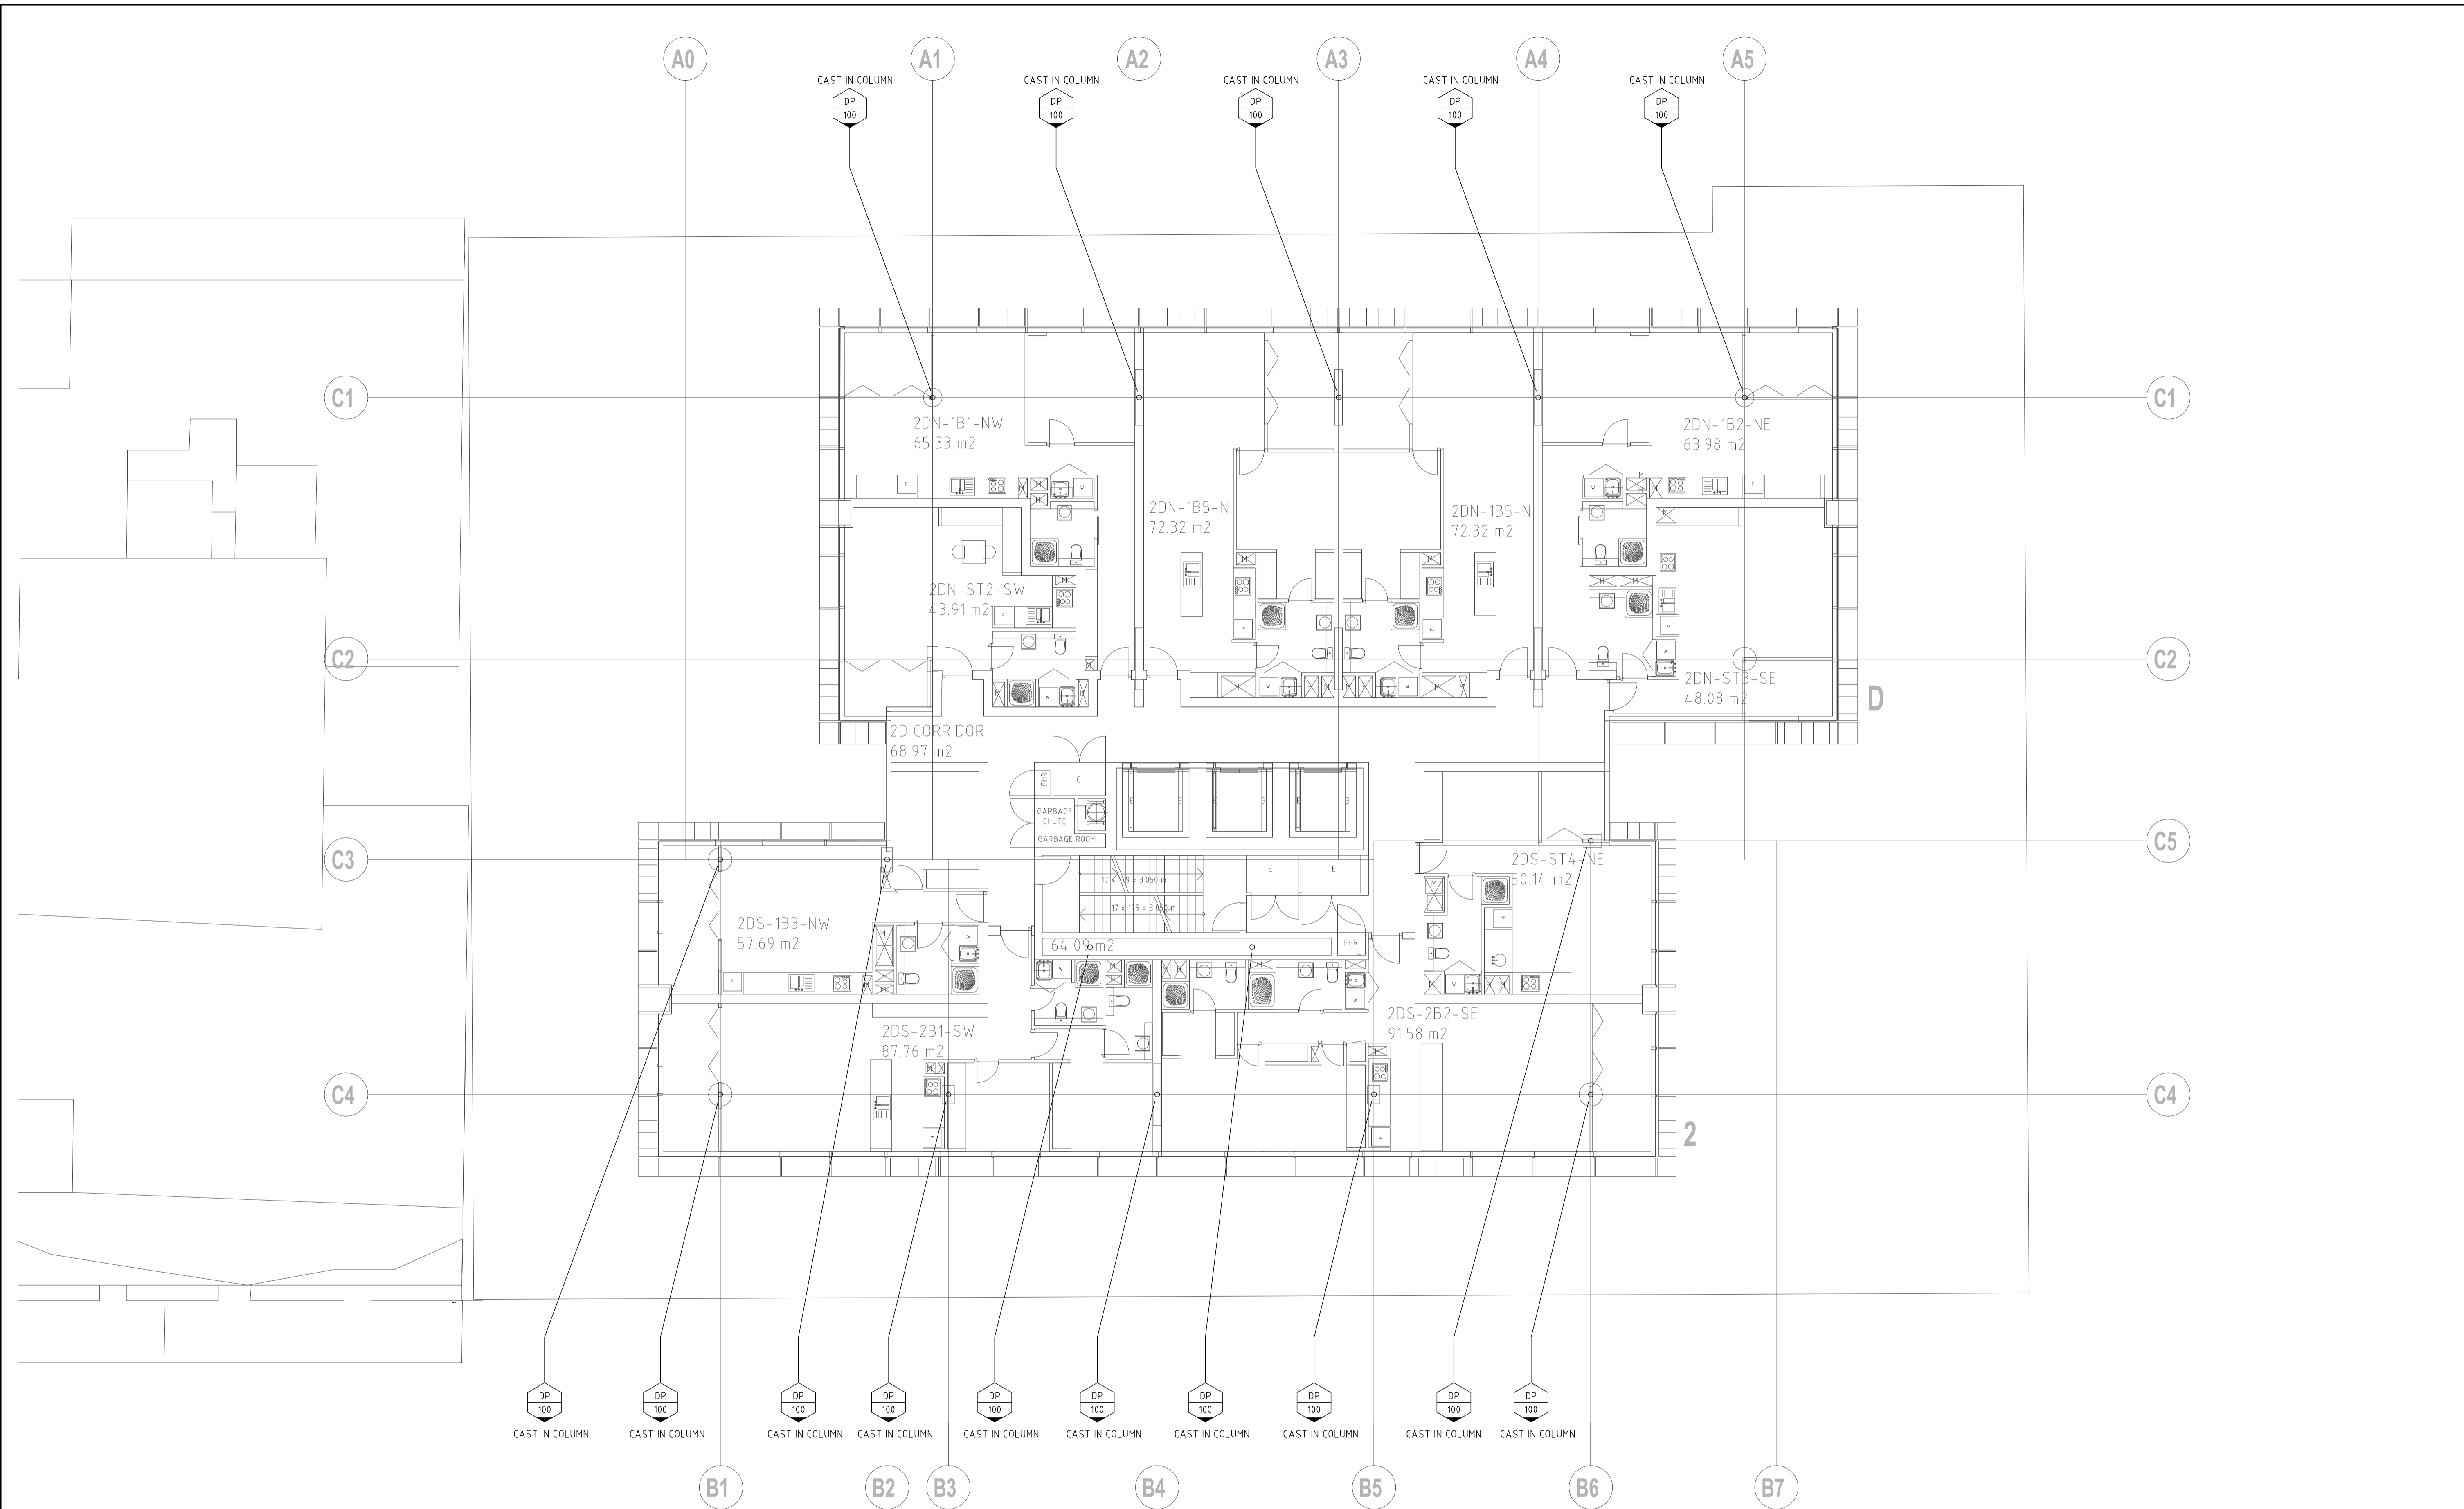

CONCEPT DESIGN
NOT TO BE USED FOR CONSTRUCTION PURPOSES

DO NOT SCALE FROM DRAWINGS, CHECK & VERIFY ALL DIMENSIONS & LEVELS BEFORE COMMENCEMENT OF ANY WORK.
THIS DRAWING IS NOT TO BE COPIED IN PART OR WHOLE WITHOUT WRITTEN PERMISSION FROM WARREN SMITH AND PARTNERS.

ISSUE	AMENDMENT	DATE	CLIENT	ARCHITECT
01	CONCEPT DESIGN ISSUE	10/06/10	Bancor - Atchison Street St Leonards - NSW	francis-jones morehen thorp fjmt incorporating MGT Sydney


DATE	CLIENT	ARCHITECT
10/06/10	Bancor - Atchison Street St Leonards - NSW	francis-jones morehen thorp fjmt incorporating MGT Sydney

Warren Smith & Partners Pty Ltd
A 1st Floor, 123 Clarence Street, Sydney 2000 NSW Australia
T 02 9299 1312 F 02 9290 1295 E wsp@warrensmith.com.au
ABN 36 300 430 126

Consulting Engineers
Hydraulic Services | Civil Engineering | Fire Protection I
Sydney Water Accredited | Water Servicing Co-ordinator
• Design and Project Management

SCALE	DRAWN	DESIGNED	CHECKED	APPROVED
1:100 @ A1 1:200 @ A3	DN	DN		


TITLE	DATE	JOB No.	DRAWING No.	ISSUE
TYPE 2D PLAN STORMWATER SERVICES PLAN	March 2010	3532	H-113	01

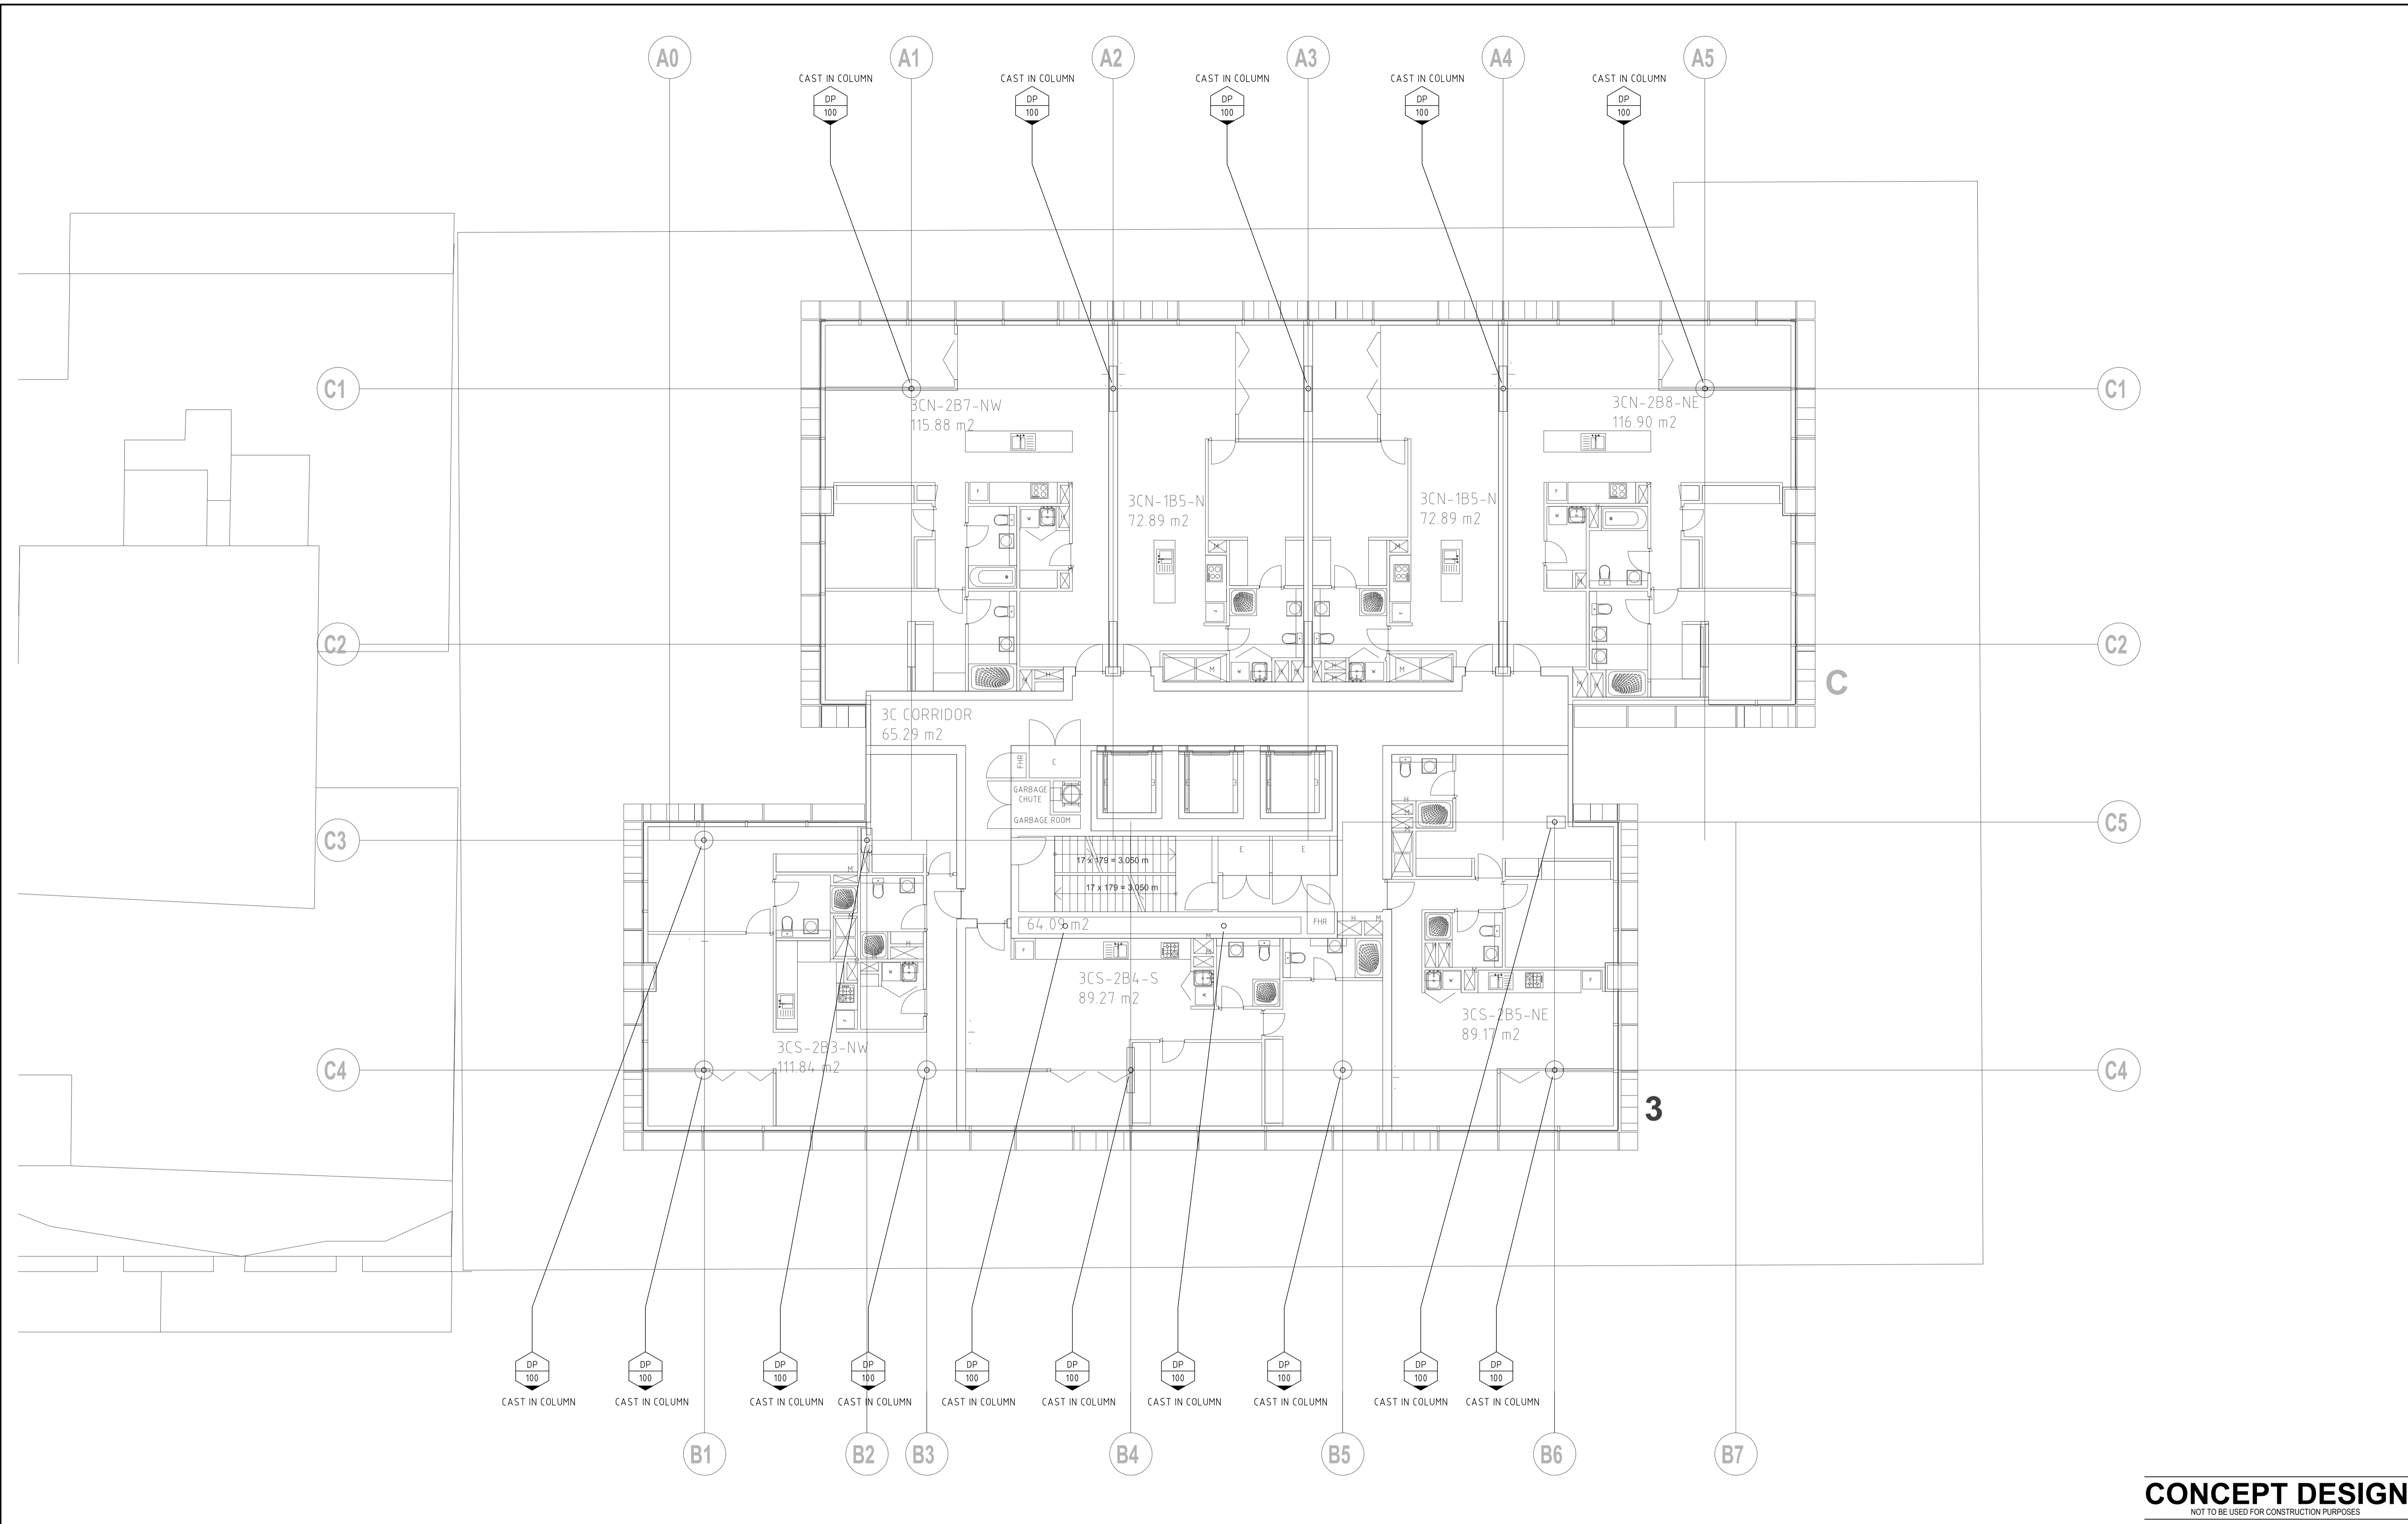

CONCEPT DESIGN
NOT TO BE USED FOR CONSTRUCTION PURPOSES

<p>DO NOT SCALE FROM DRAWINGS, CHECK & VERIFY ALL DIMENSIONS & LEVELS BEFORE COMMENCEMENT OF ANY WORK.</p> <p>THIS DRAWING IS NOT TO BE COPIED IN PART OR WHOLE WITHOUT WRITTEN PERMISSION FROM WARREN SMITH AND PARTNERS.</p>	<p>NORTH POINT</p>	<p>NOTES</p>	<p>ISSUE</p> <p>01</p>	<p>AMENDMENT</p> <p>CONCEPT DESIGN ISSUE</p>	<p>DATE</p> <p>10/06/10</p>	<p>CLIENT</p>	<p>ARCHITECT</p> <p>francis-jones morehen thorp</p> <p>fjmt</p> <p>incorporating MGT Sydney</p>	<p>PROJECT</p> <p>Bancor - Atchison Street</p> <p>St Leonards - NSW</p>	<p>SYDNEY</p> <p>Level 5 MCA, 140 George Street, Sydney NSW 2000 Australia</p> <p>T +61 2 9251 7077</p> <p>F +61 2 9251 7072</p> <p>E fjm@fjmt.com.au</p> <p>W www.fjmt.com.au</p> <p>NON-RATED ARCHITECT (REVISED THORP (REG NO 2006))</p>	<p>Warren Smith & Partners Pty Ltd</p> <p>A 1st Floor, 123 Clarence Street, Sydney 2000 NSW Australia</p> <p>T 02 9259 1312 F 02 9290 1295 E wsp@warrensmith.com.au</p> <p>ABN 36 300 430 126</p> <p>SINCE 1981</p> <p>SERVING THE CONSTRUCTION INDUSTRY</p> <p>Consulting Engineers</p> <p>Hydraulic Services Civil Engineering Fire Protection Sydney Water Accredited Water Servicing Co-ordinator</p> <p>• Design and Project Management</p>	<p>TITLE</p> <p>TYPE 3C PLAN</p> <p>STORMWATER SERVICES PLAN</p>	<table border="1"> <tr> <td>SCALE</td> <td>1:100 @ A1</td> <td>DRAWN</td> <td>DN</td> <td>DESIGNED</td> <td>DN</td> <td>CHECKED</td> <td></td> <td>APPROVED</td> <td></td> </tr> <tr> <td>DATE</td> <td>March 2010</td> <td>DRAWING No.</td> <td colspan="2">H-114</td> <td>ISSUE</td> <td colspan="4">01</td> </tr> <tr> <td>JOB No.</td> <td>3532</td> <td colspan="7"></td> <td></td> </tr> </table>	SCALE	1:100 @ A1	DRAWN	DN	DESIGNED	DN	CHECKED		APPROVED		DATE	March 2010	DRAWING No.	H-114		ISSUE	01				JOB No.	3532								
			SCALE	1:100 @ A1	DRAWN	DN	DESIGNED	DN	CHECKED		APPROVED																															
DATE	March 2010	DRAWING No.	H-114		ISSUE	01																																				
JOB No.	3532																																									
<p>Plot Date: 10 June 2010 3:02:02 PM</p>																																										

Xref: 0023_H114_1_Typ_3C_Plan_10_06_10.dwg
 Plot Date: 10/06/2010 03:02:02
 User: Name: jason
 Cad File: 1335202.dwg

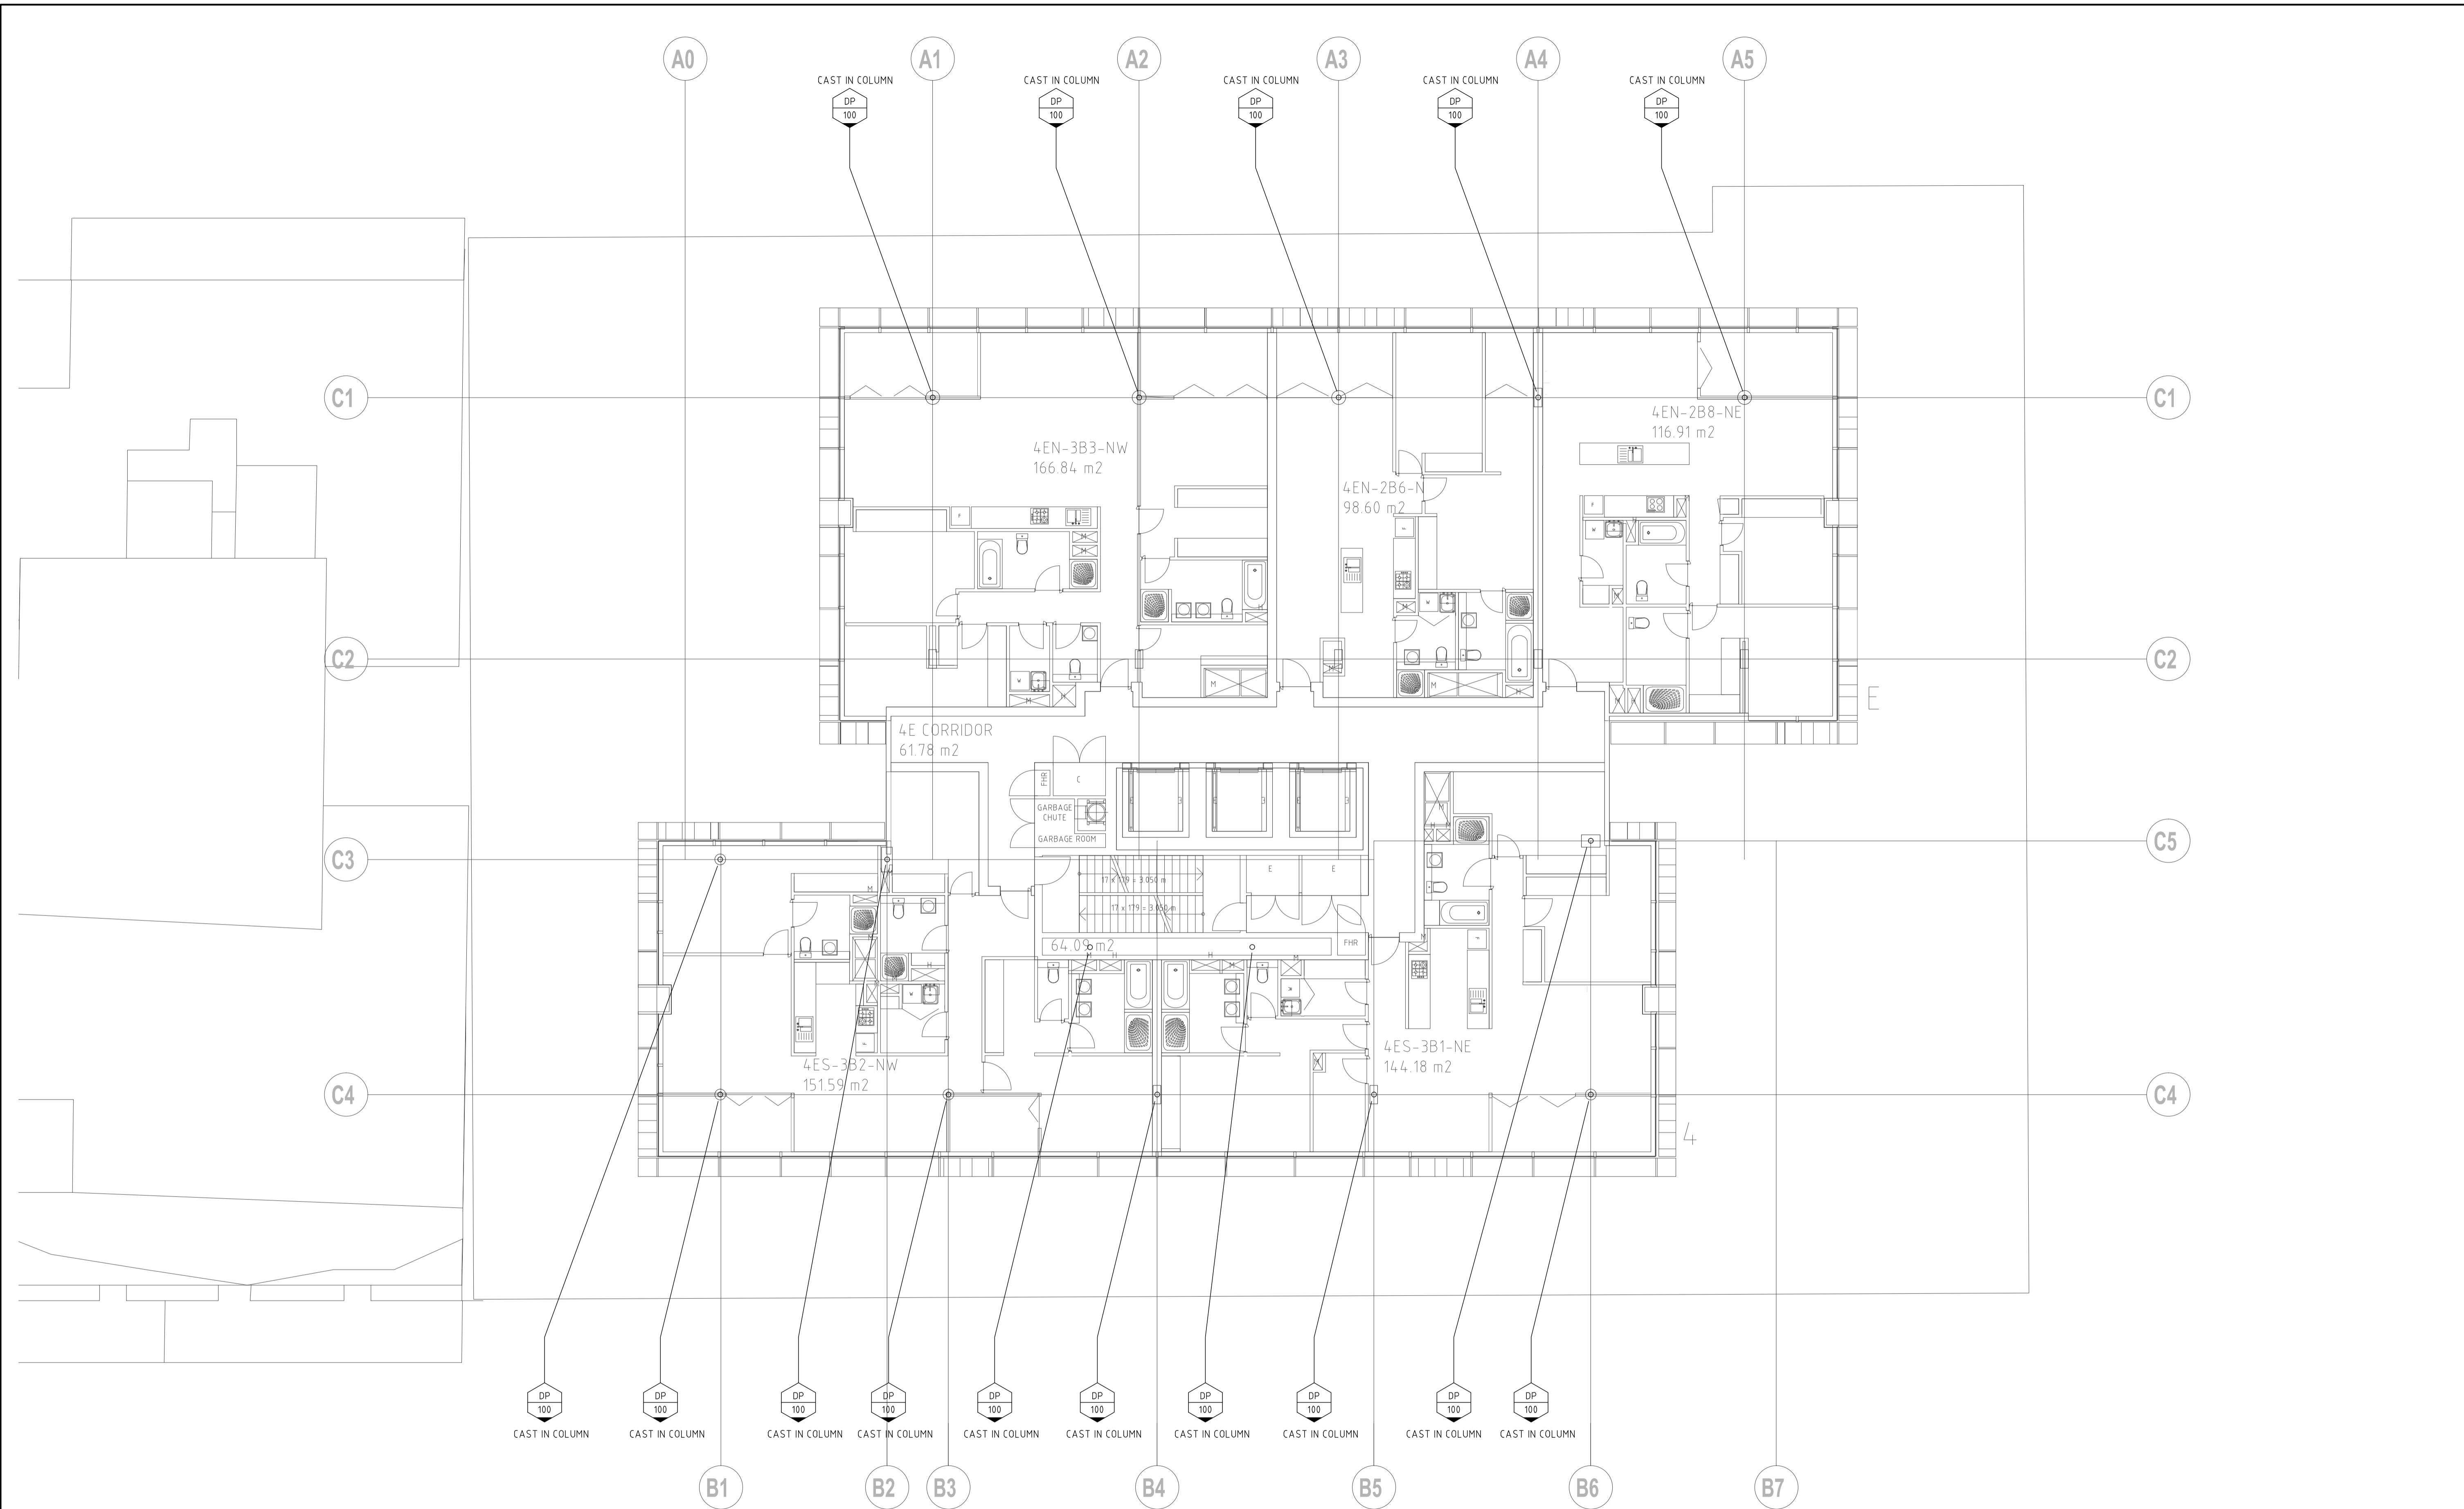

CONCEPT DESIGN
NOT TO BE USED FOR CONSTRUCTION PURPOSES

DO NOT SCALE FROM DRAWINGS, CHECK & VERIFY ALL DIMENSIONS & LEVELS BEFORE COMMENCEMENT OF ANY WORK.

THIS DRAWING IS NOT TO BE COPIED IN PART OR WHOLE WITHOUT WRITTEN PERMISSION FROM WARREN SMITH AND PARTNERS.

ISSUE	AMENDMENT	DATE	CLIENT
01	CONCEPT DESIGN ISSUE	10/06/10	

ARCHITECT
francis-jones morehen thorp fjmt incorporating MGT Sydney SYDNEY Level 5/ICA, 140 George Street Sydney NSW 2000 Australia T +61 2 9251 7077 F +61 2 9251 7072 E fjm@fjmt.com.au W www.fjmt.com.au <small>NON-RATED ARCHITECT (REVISED THORP (RIS) NO 3056)</small>


PROJECT
Bancor - Atchison Street St Leonards - NSW

Warren Smith & Partners Pty Ltd
 A 1st Floor, 123 Clarence Street, Sydney 2000 NSW Australia
 T 02 9299 1312 F 02 9290 1295 E wsp@warrensmith.com.au
 ABN 36 300 430 126

SERVING THE CONSTRUCTION INDUSTRY SINCE 1981

Consulting Engineers
 Hydraulic Services | Civil Engineering | Fire Protection |
 Sydney Water Accredited | Water Servicing Co-ordinator
 • Design and Project Management


TITLE	SCALE	DRAWN	DESIGNED	CHECKED	APPROVED
TYPE 4E PLAN STORMWATER SERVICES PLAN	1:100 @ A1 1:200 @ A3	DN	DN		
DATE March 2010	DRAWING No. H-115	ISSUE 01			
JOB No. 3532					

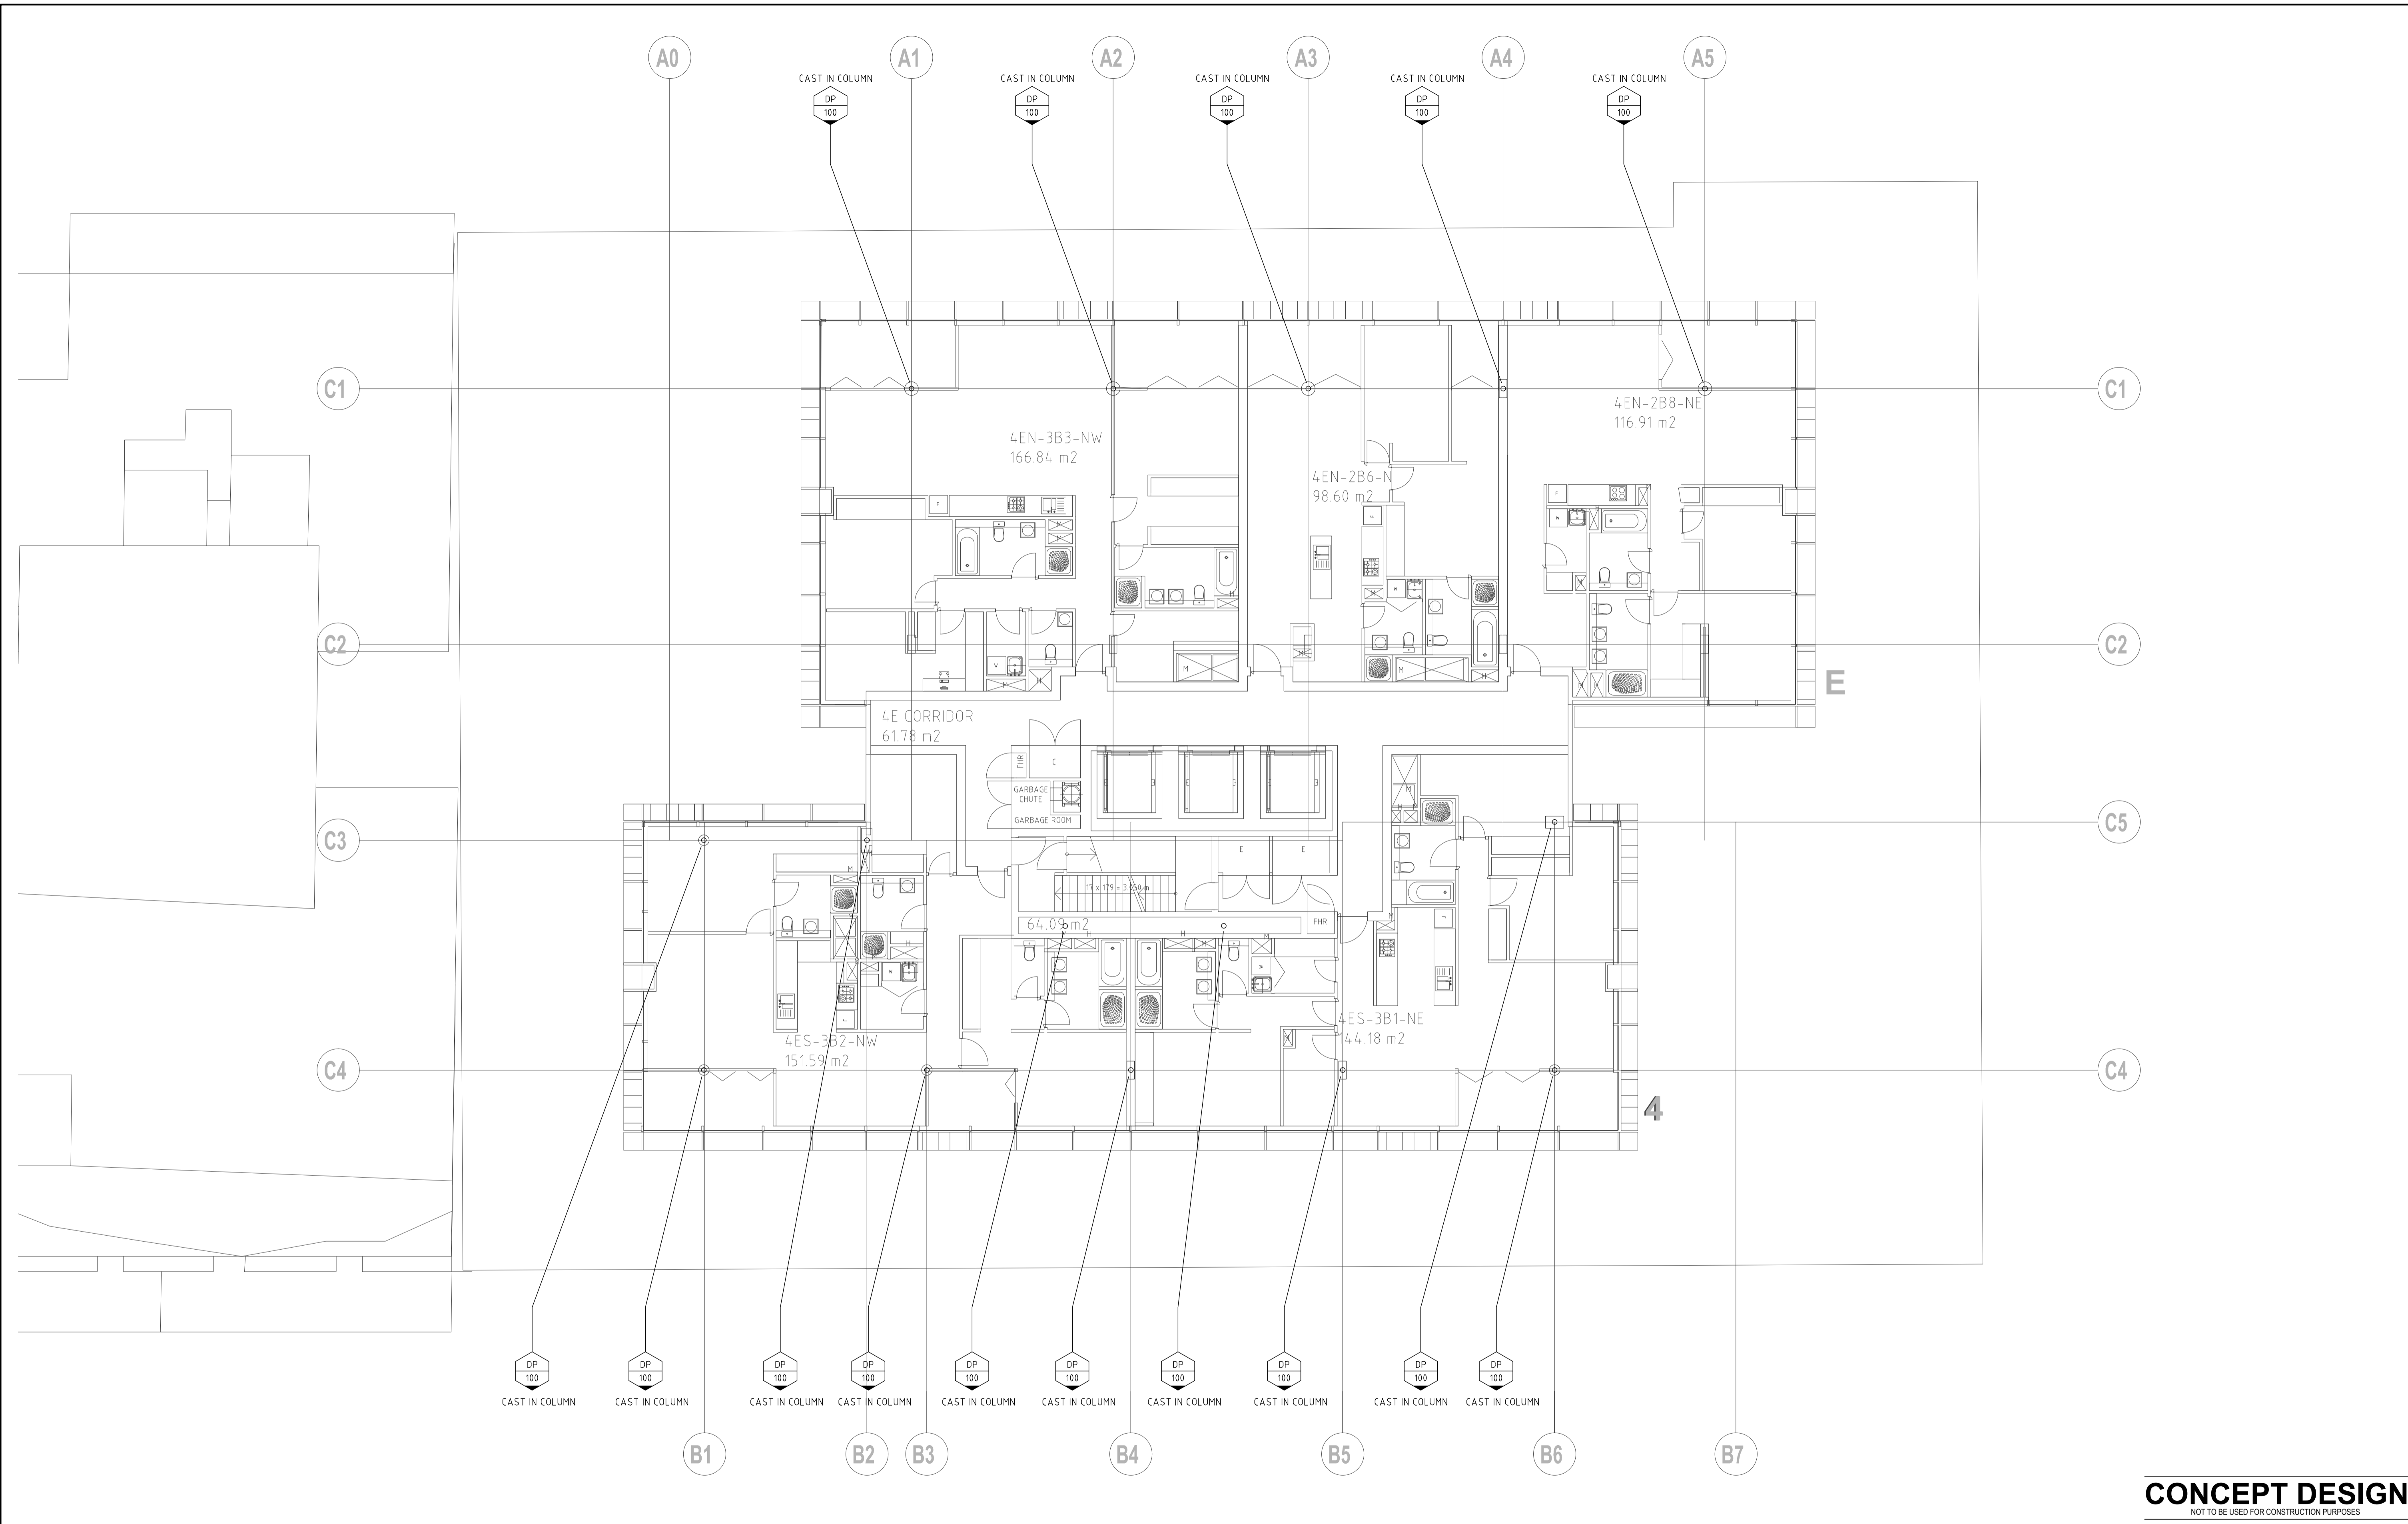

CONCEPT DESIGN
NOT TO BE USED FOR CONSTRUCTION PURPOSES

<p>DO NOT SCALE FROM DRAWINGS, CHECK & VERIFY ALL DIMENSIONS & LEVELS BEFORE COMMENCEMENT OF ANY WORK.</p> <p>THIS DRAWING IS NOT TO BE COPIED IN PART OR WHOLE WITHOUT WRITTEN PERMISSION FROM WARREN SMITH AND PARTNERS.</p>	<p>NORTH POINT</p>	<p>NOTES</p>	<p>ISSUE</p> <p>01</p>	<p>AMENDMENT</p> <p>CONCEPT DESIGN ISSUE</p>	<p>DATE</p> <p>10/06/10</p>	<p>CLIENT</p>	<p>ARCHITECT</p> <p>francis-jones morehen thorp</p> <p>fjmt</p> <p>incorporating MGT Sydney</p>	<p>Warren Smith & Partners Pty Ltd</p> <p>A 1st Floor, 123 Clarence Street, Sydney 2000 NSW Australia T 02 9299 1312 F 02 9290 1295 E wsp@warrensmith.com.au ABN 36 300 430 126</p> <p>SERVING THE CONSTRUCTION INDUSTRY SINCE 1981</p> <p>Consulting Engineers Hydraulic Services Civil Engineering Fire Protection Sydney Water Accredited Water Servicing Co-ordinator • Design and Project Management</p>	<p>TITLE</p> <p>TYPE 4E PENTHOUSE PLAN STORMWATER SERVICES PLAN</p>	<p>SCALE</p> <p>1:100 @ A1 1:200 @ A3</p>	<p>DRAWN</p> <p>DN</p>	<p>DESIGNED</p> <p>DN</p>	<p>CHECKED</p>	<p>APPROVED</p>
			<p>PROJECT</p> <p>Bancor - Atchison Street St Leonards - NSW</p>	<p>DATE</p> <p>March 2010</p>	<p>DRAWING No.</p> <p>H-116</p>	<p>ISSUE</p> <p>01</p>								


Xref: 10251_1114_1_Typ_4E_Penthouse_Plan
 Plot Date: 10/06/2010 10:32:10 AM
 Cad File: 1335202.dwg
 Plot Date: 10/06/2010 10:32:10 AM

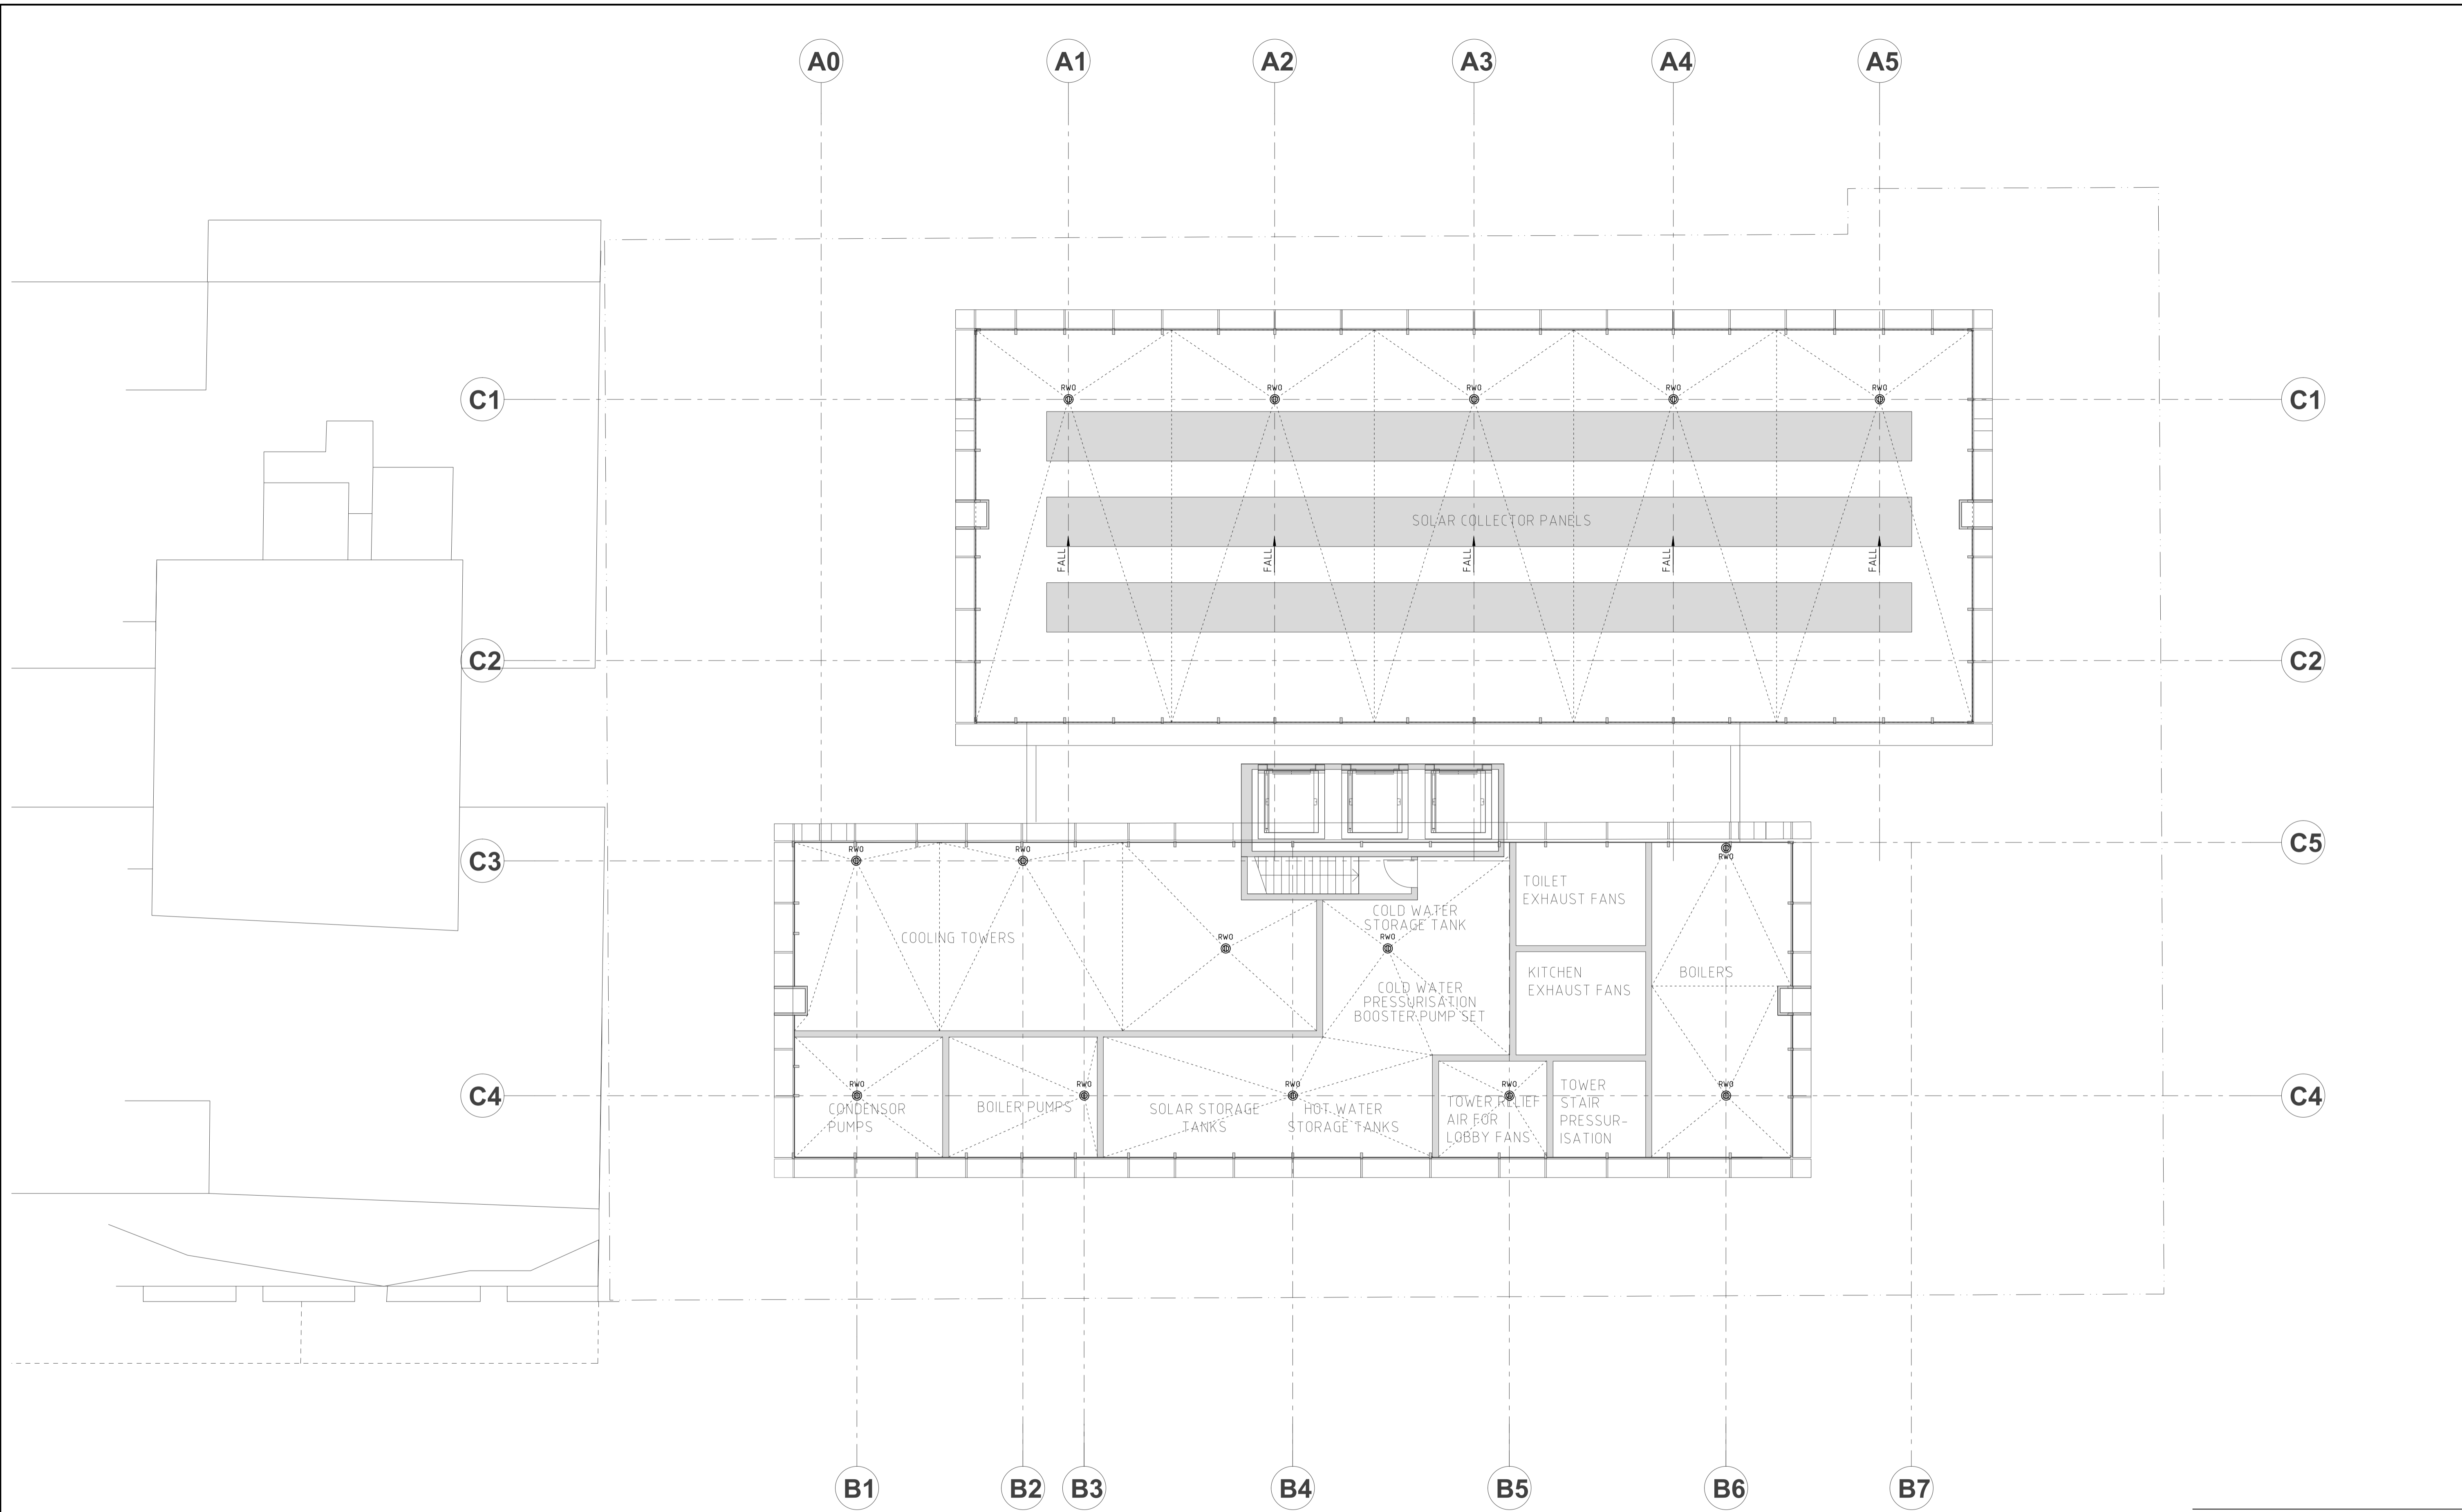

CONCEPT DESIGN
NOT TO BE USED FOR CONSTRUCTION PURPOSES

DO NOT SCALE FROM DRAWINGS, CHECK & VERIFY ALL DIMENSIONS & LEVELS BEFORE COMMENCEMENT OF ANY WORK.

THIS DRAWING IS NOT TO BE COPIED IN PART OR WHOLE WITHOUT WRITTEN PERMISSION FROM WARREN SMITH AND PARTNERS.

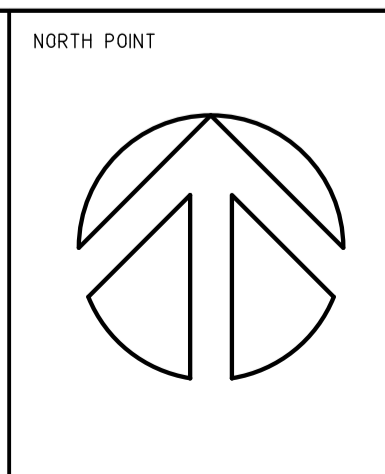

ISSUE	AMENDMENT	DATE	CLIENT	ARCHITECT
01	CONCEPT DESIGN ISSUE	10/06/10	Bancor - Atchison Street St Leonards - NSW	francis-jones morehen thorp fjmt INCORPORATING MGT SYDNEY

SCALE	DRAWN	DESIGNED	CHECKED	APPROVED
1:100 @ A1 1:200 @ A3	DN	DN	WJS	<i>[Signature]</i>

DATE	DRAWING No.	ISSUE
March 2010	H-117	01

Warren Smith & Partners Pty Ltd
A 1st Floor, 123 Clarence Street, Sydney 2000 NSW Australia
T 02 9299 1312 F 02 9290 1295 E wsp@warrensmith.com.au
ABN 36 300 430 126

SERVING THE CONSTRUCTION INDUSTRY
SINCE 1981

Consulting Engineers
Hydraulic Services | Civil Engineering | Fire Protection |
Sydney Water Accredited | Water Servicing Co-ordinator
• Design and Project Management

TITLE
ROOF PLAN (PLANT) STORMWATER SERVICES PLAN

DATE	JOB No.
March 2010	3532