
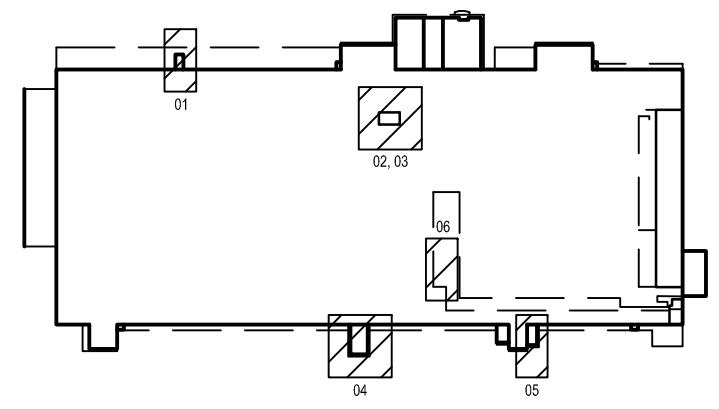


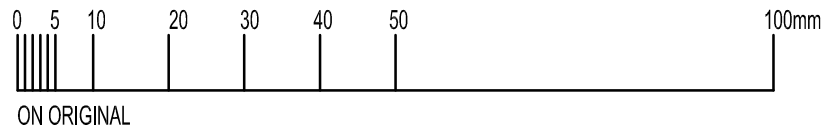


KEY PLAN


THE PROPERTY IN THIS DRAWING AND IN THE CONCEPTS REMAIN WITH MNIA ARCHITECTS PTY LTD. ANY UNAUTHORISED USE OF THIS DRAWING WHETHER AS THE WHOLE OR PART MAY RENDER THE USER LIABLE IN AN ACTION FOR DAMAGES. CONSEQUENTIAL DAMAGES ARISING FROM UNWARRANTED OR UNAUTHORISED USE SHALL NOT RENDER MNIA ARCHITECTS PTY LTD LIABLE.

DIMENSIONS MUST NOT BE SCALED FROM DRAWINGS.


ALL DIMENSIONS TO BE CONFIRMED ON SITE PRIOR TO THE COMMENCEMENT OF ANY WORK.

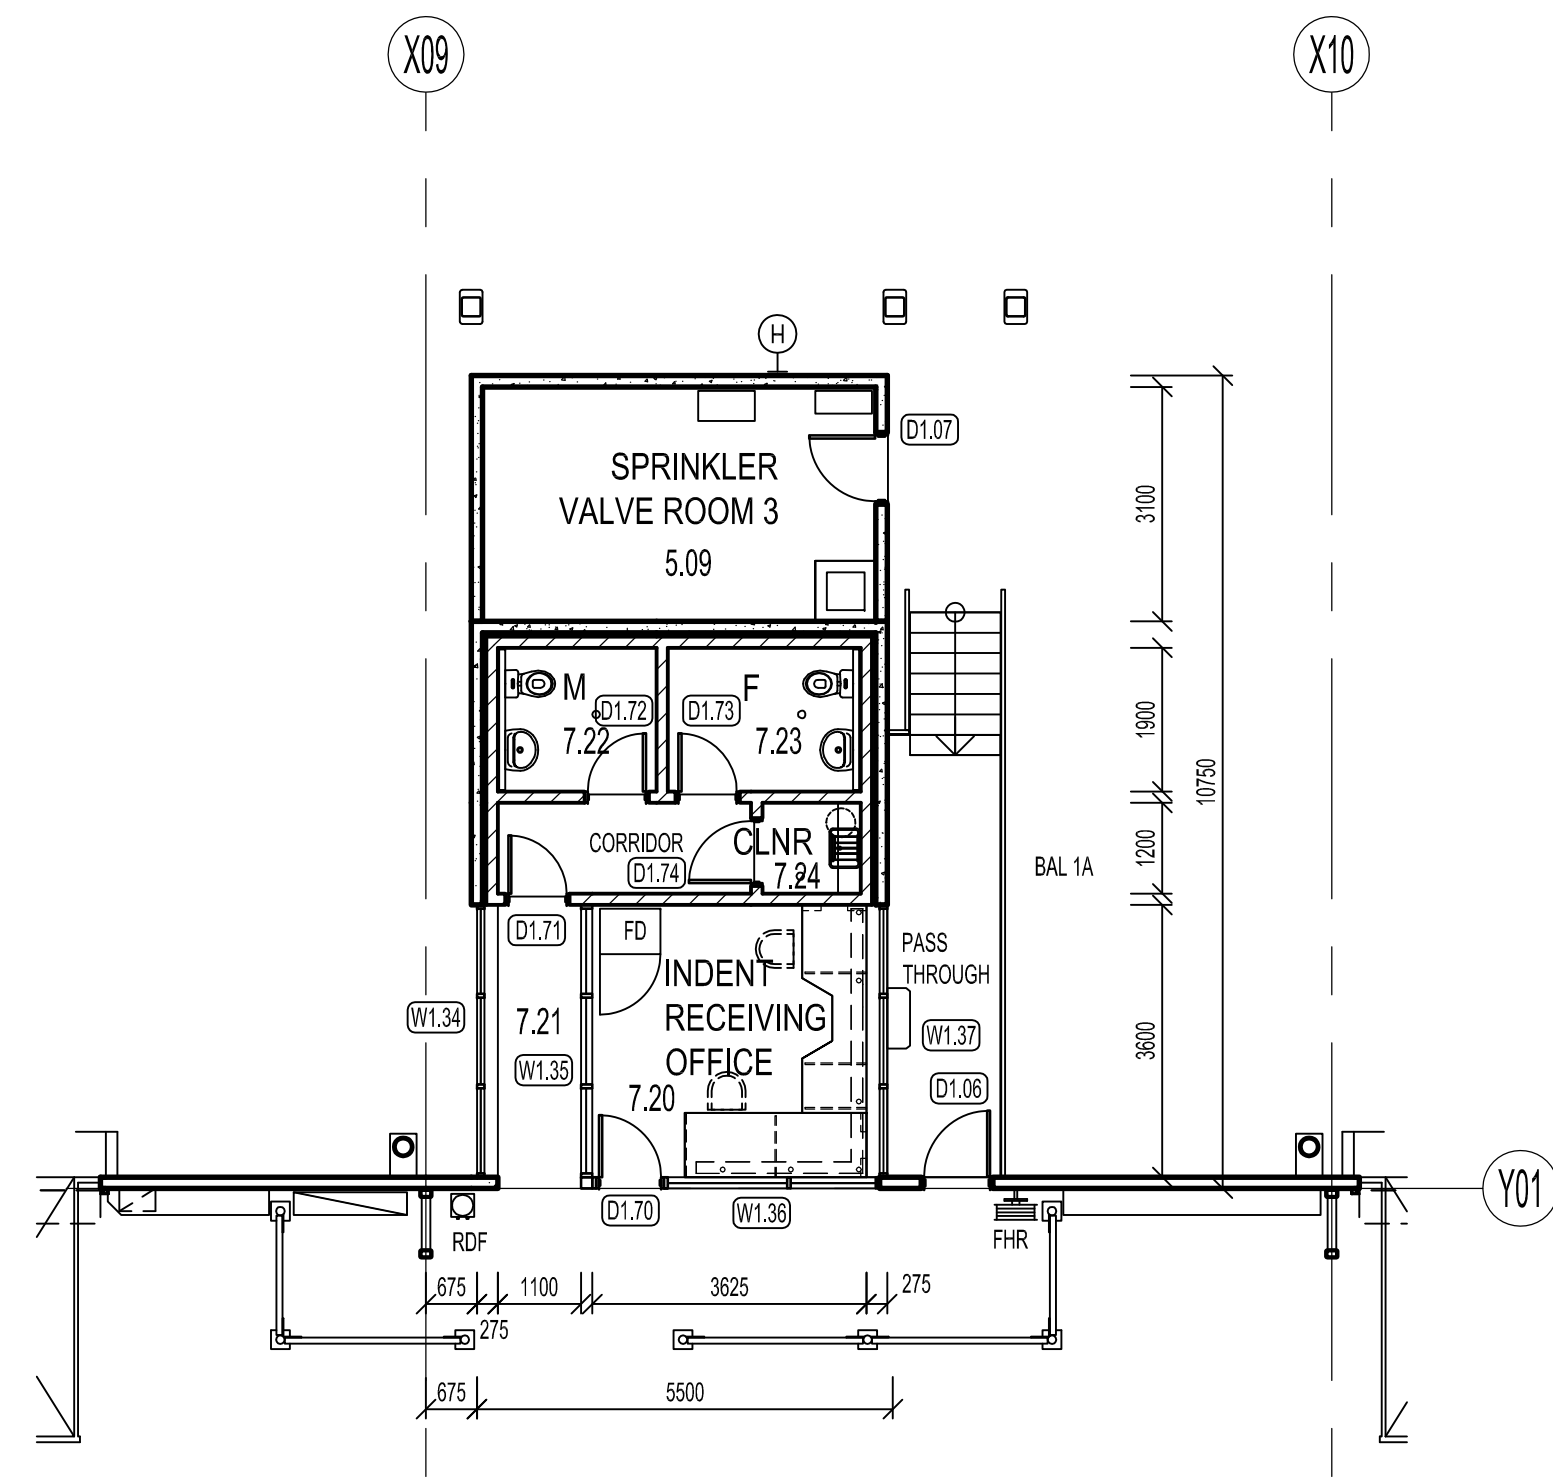


01 FLOOR PLAN
INDENT RECEIVING OFFICE

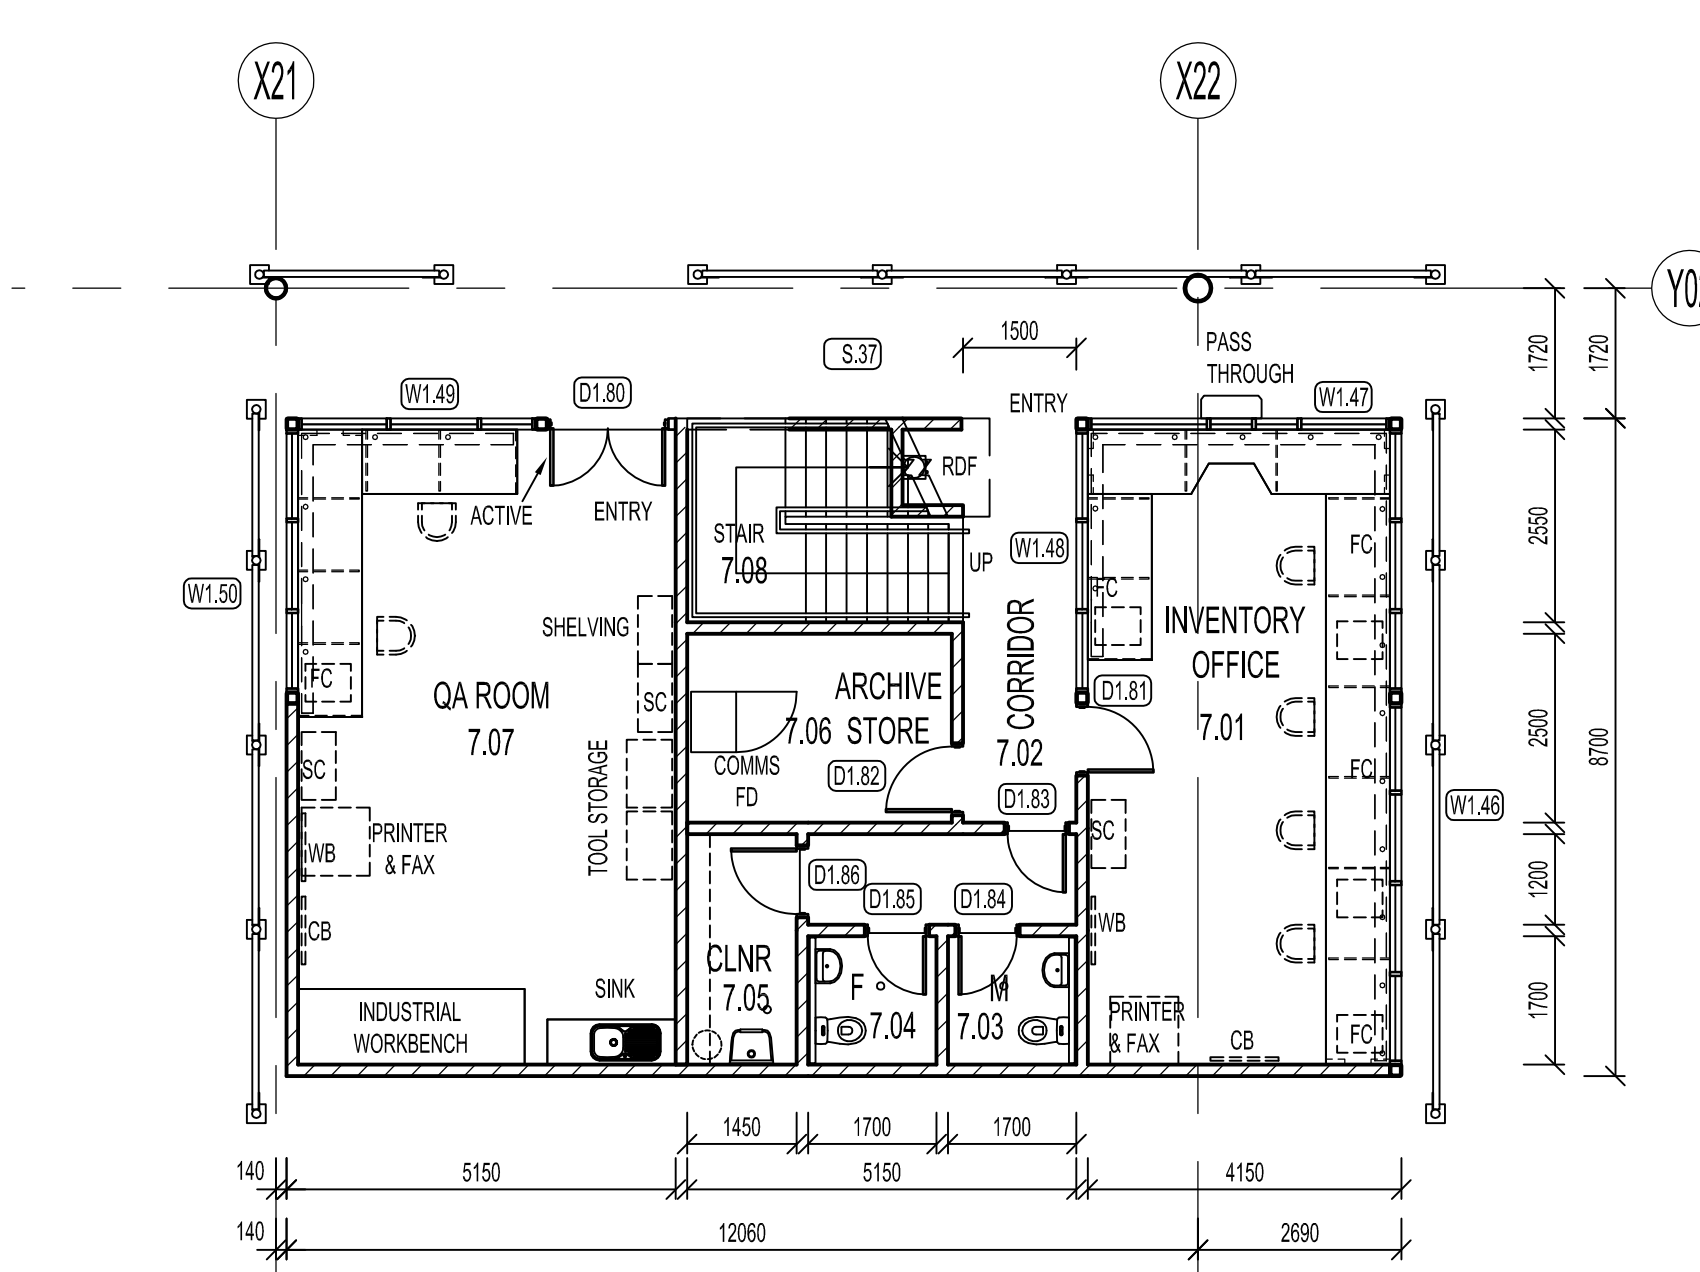


02 FLOOR PLAN
OPERATIONS OFFICE LEVEL 1

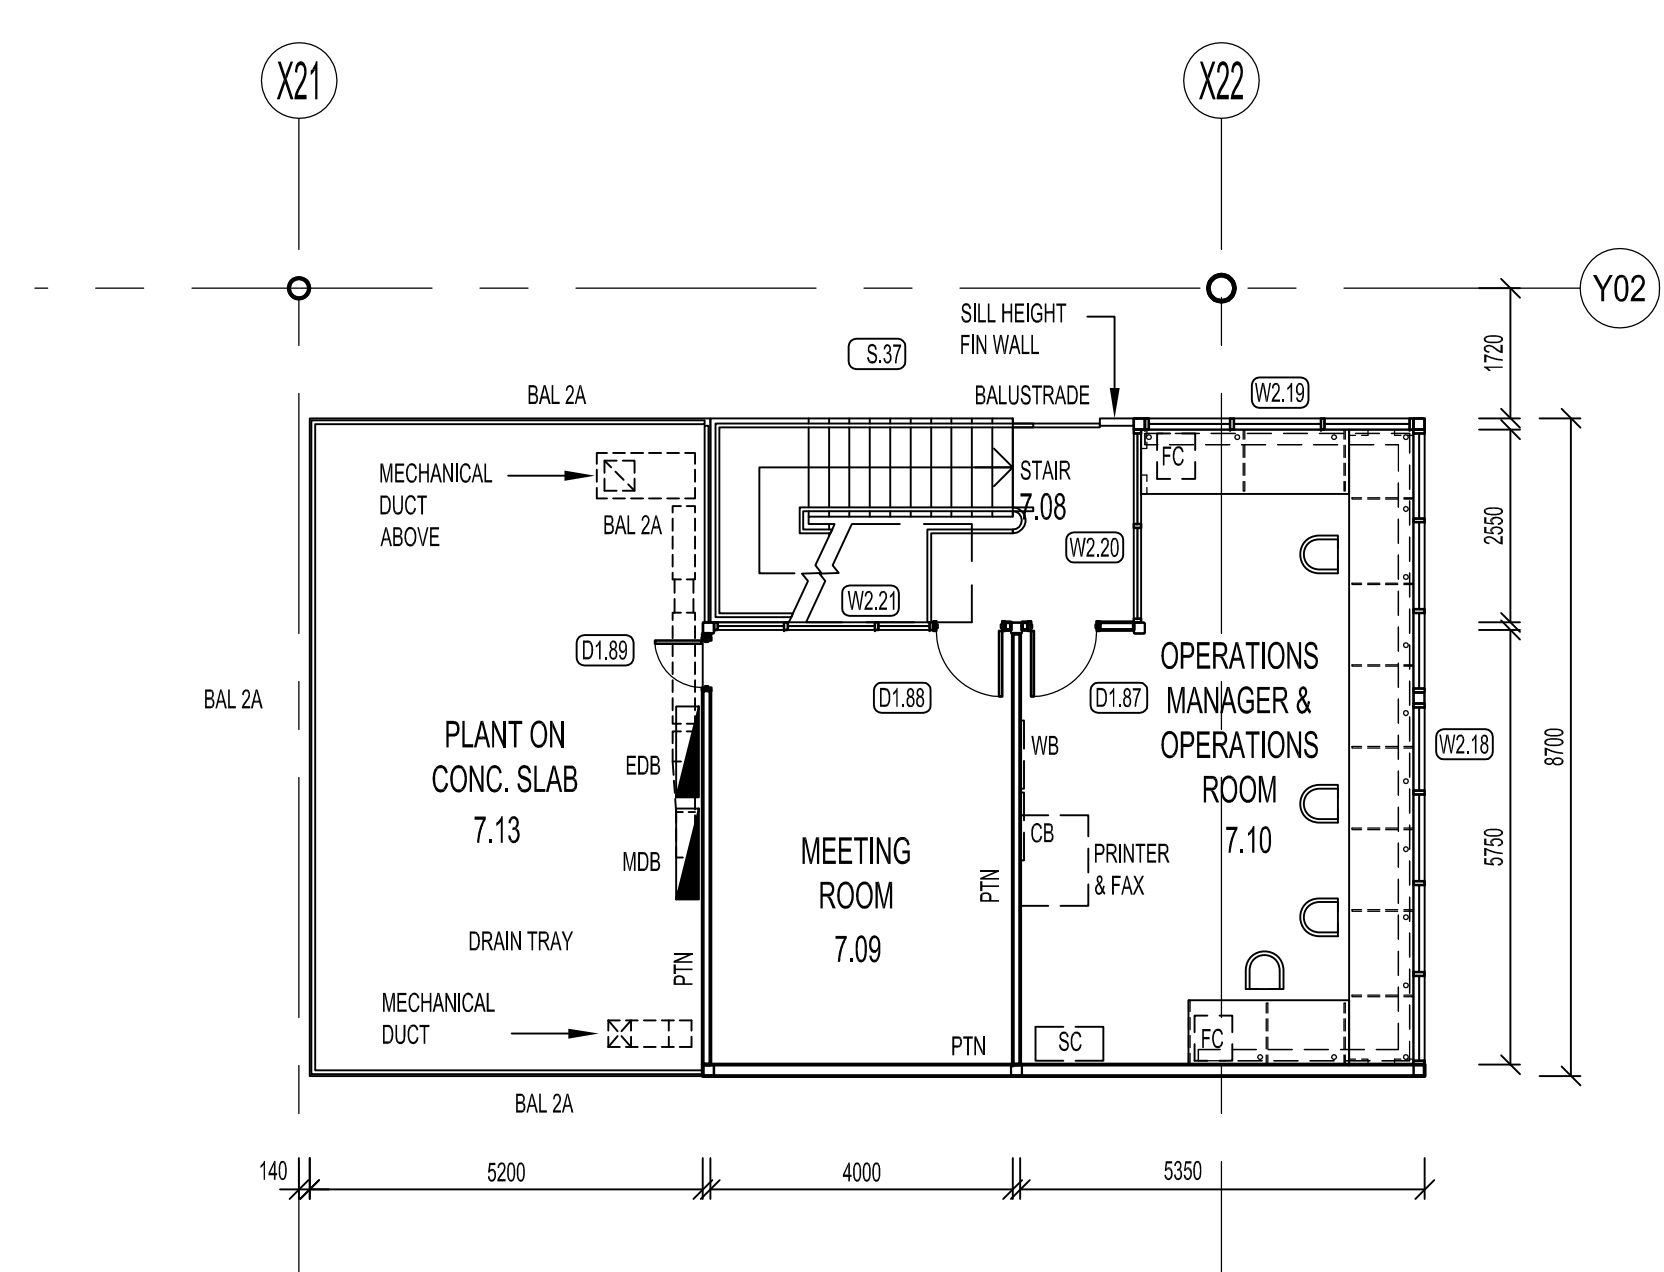


03 FLOOR PLAN
OPERATIONS OFFICE LEVEL 2

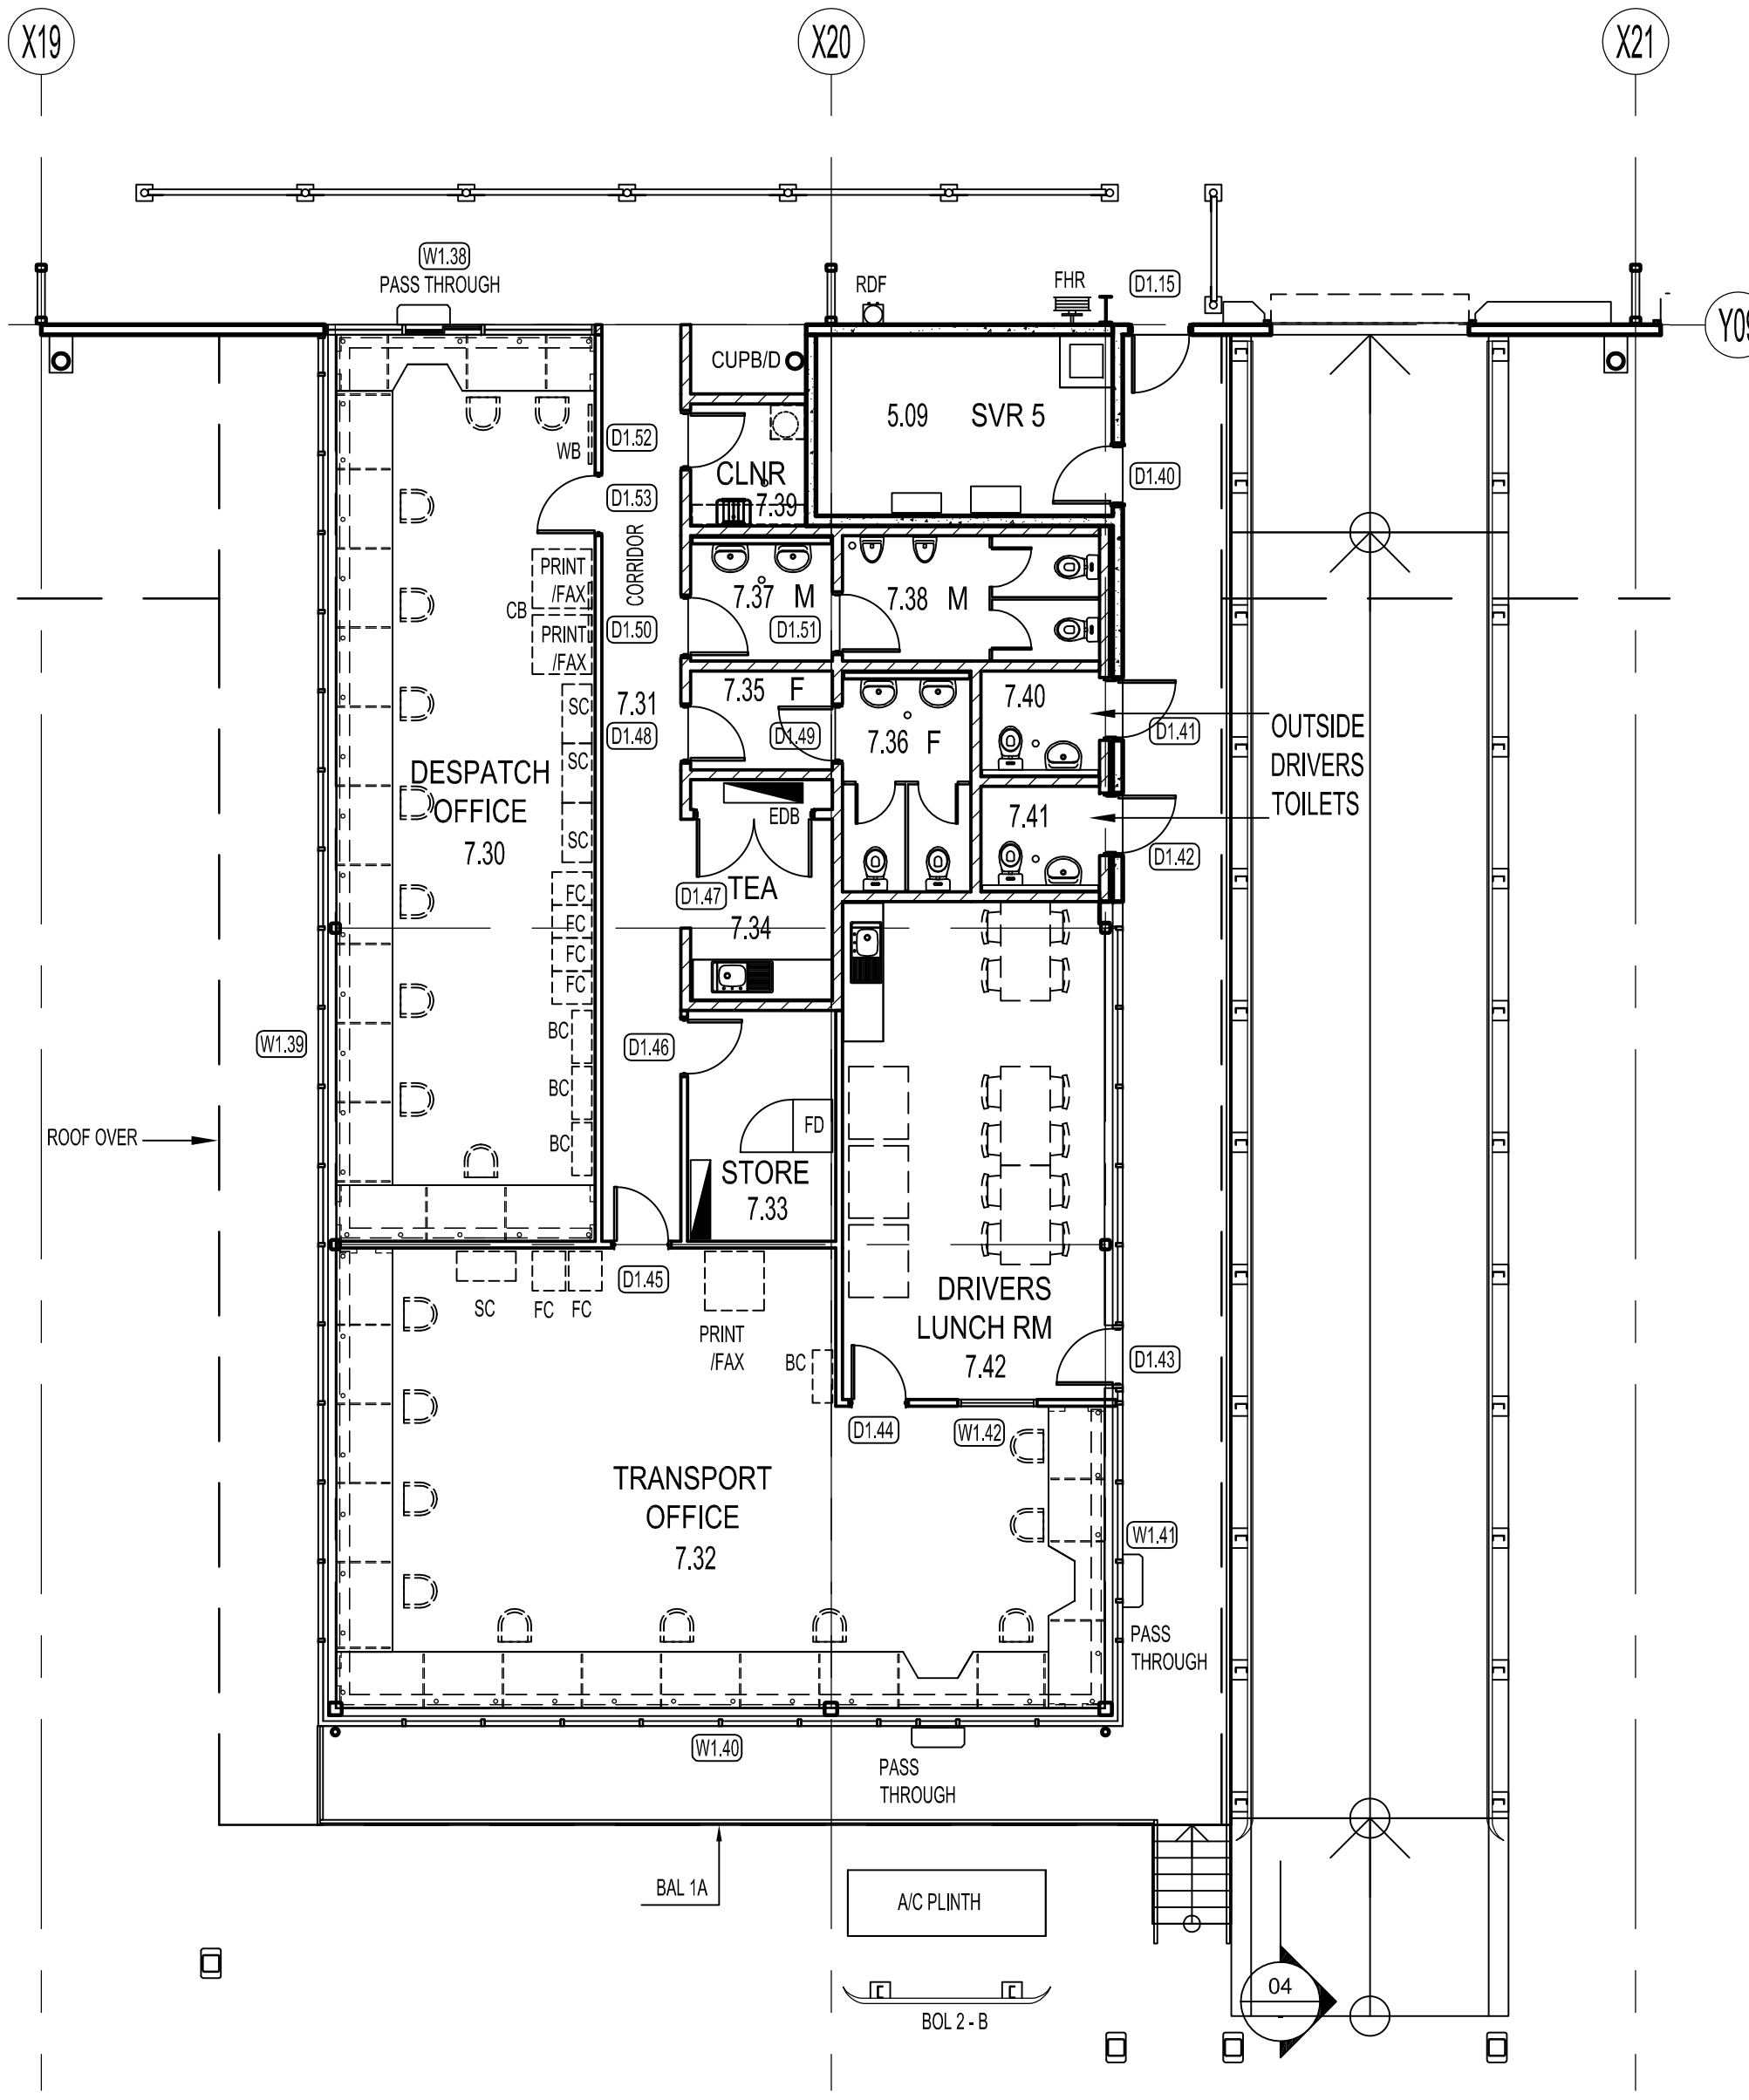

04 FLOOR PLAN
DESPATCH OFFICE

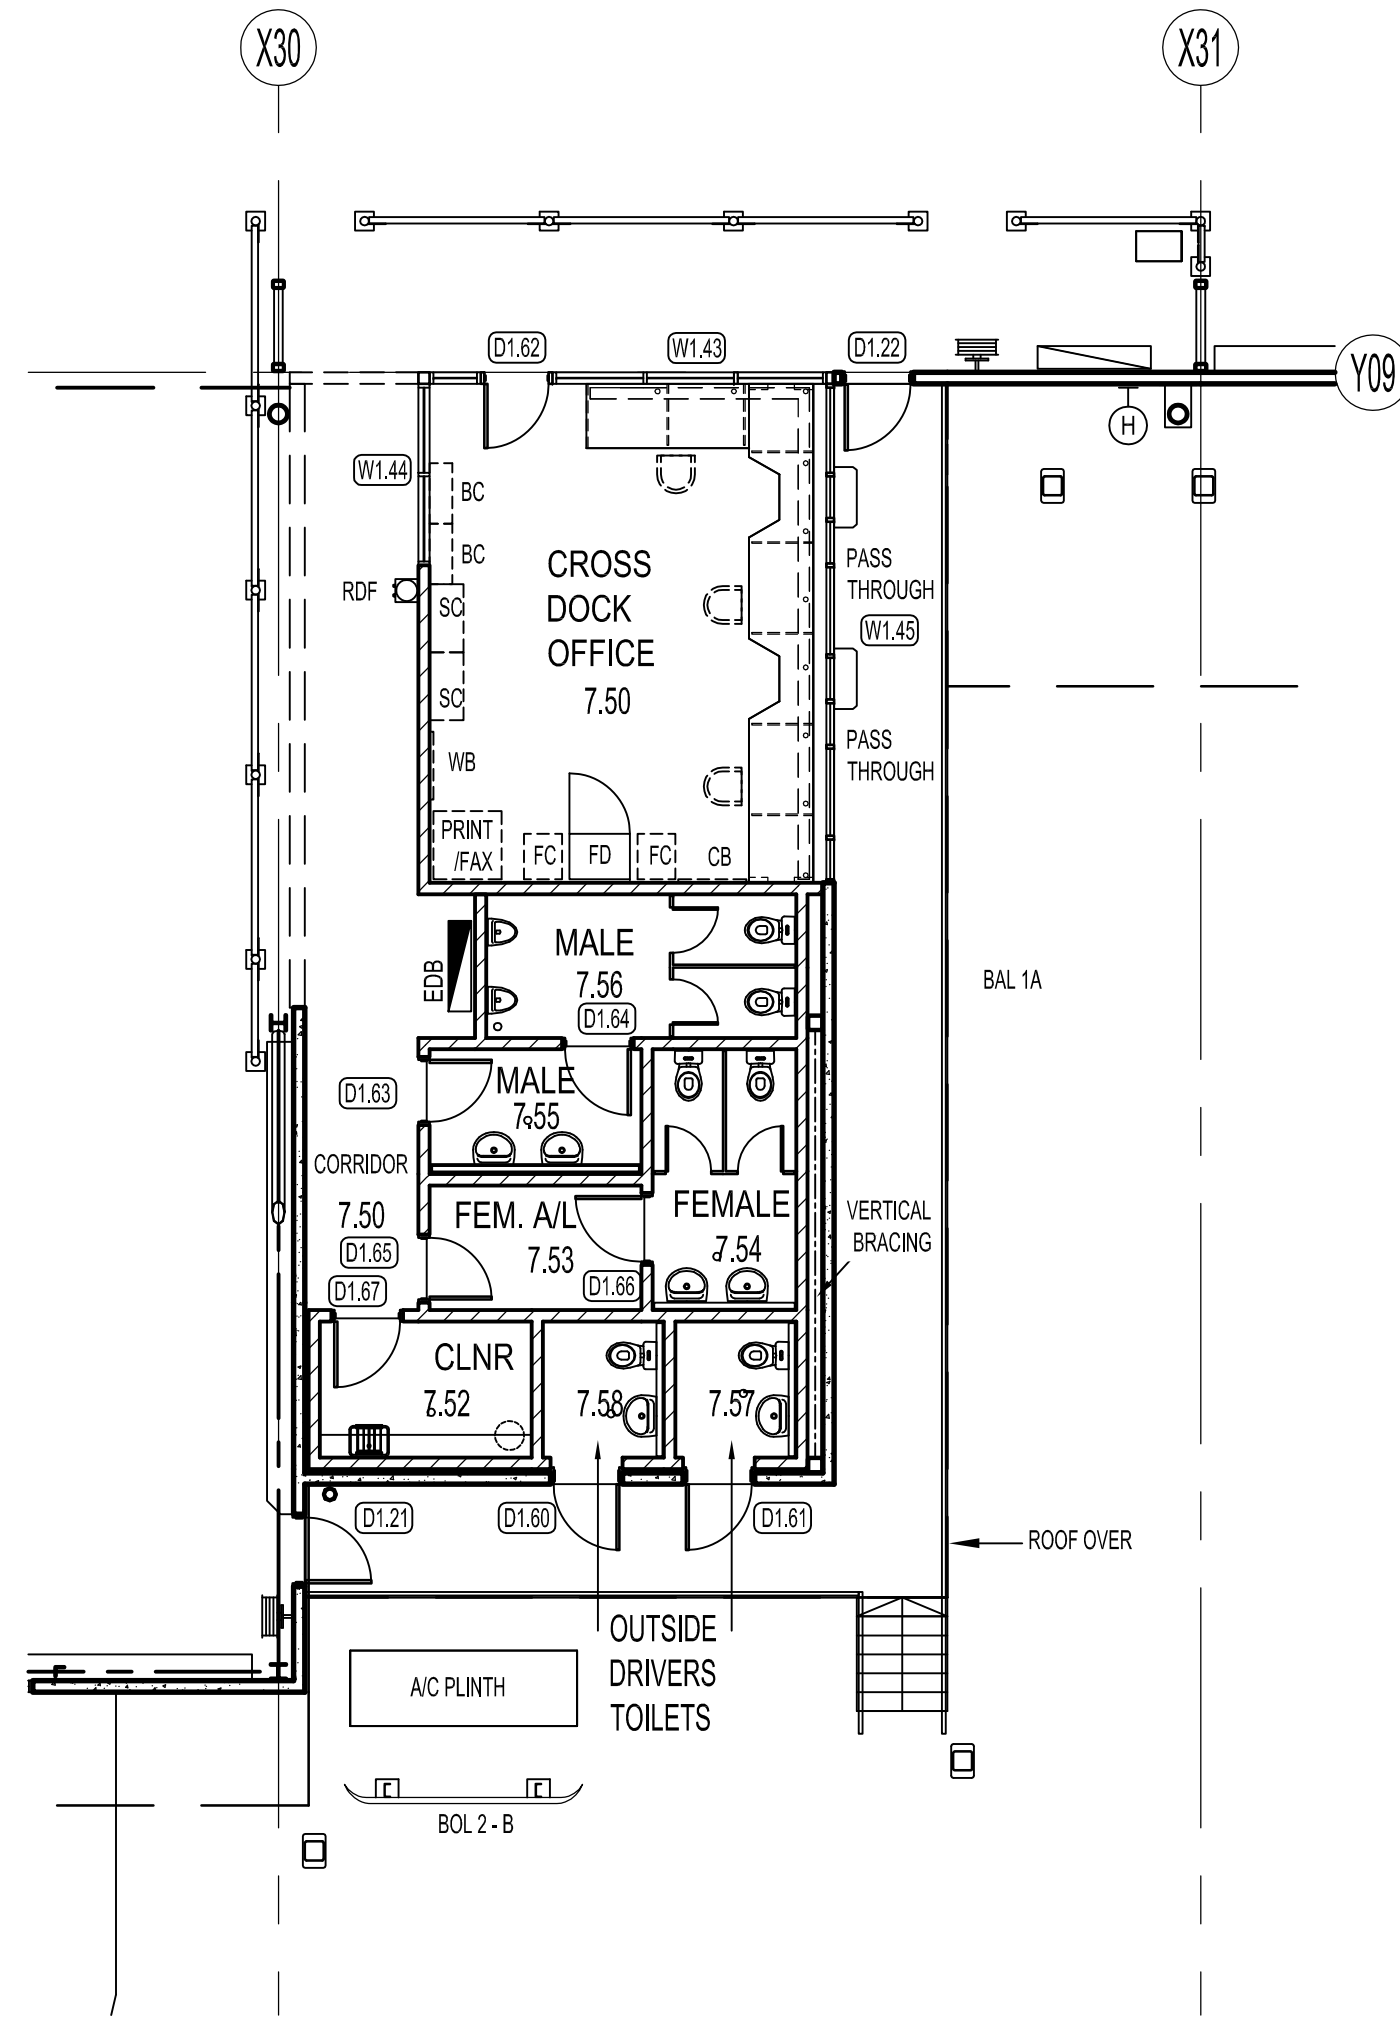

05 FLOOR PLAN
CROSS DOCK OFFICE

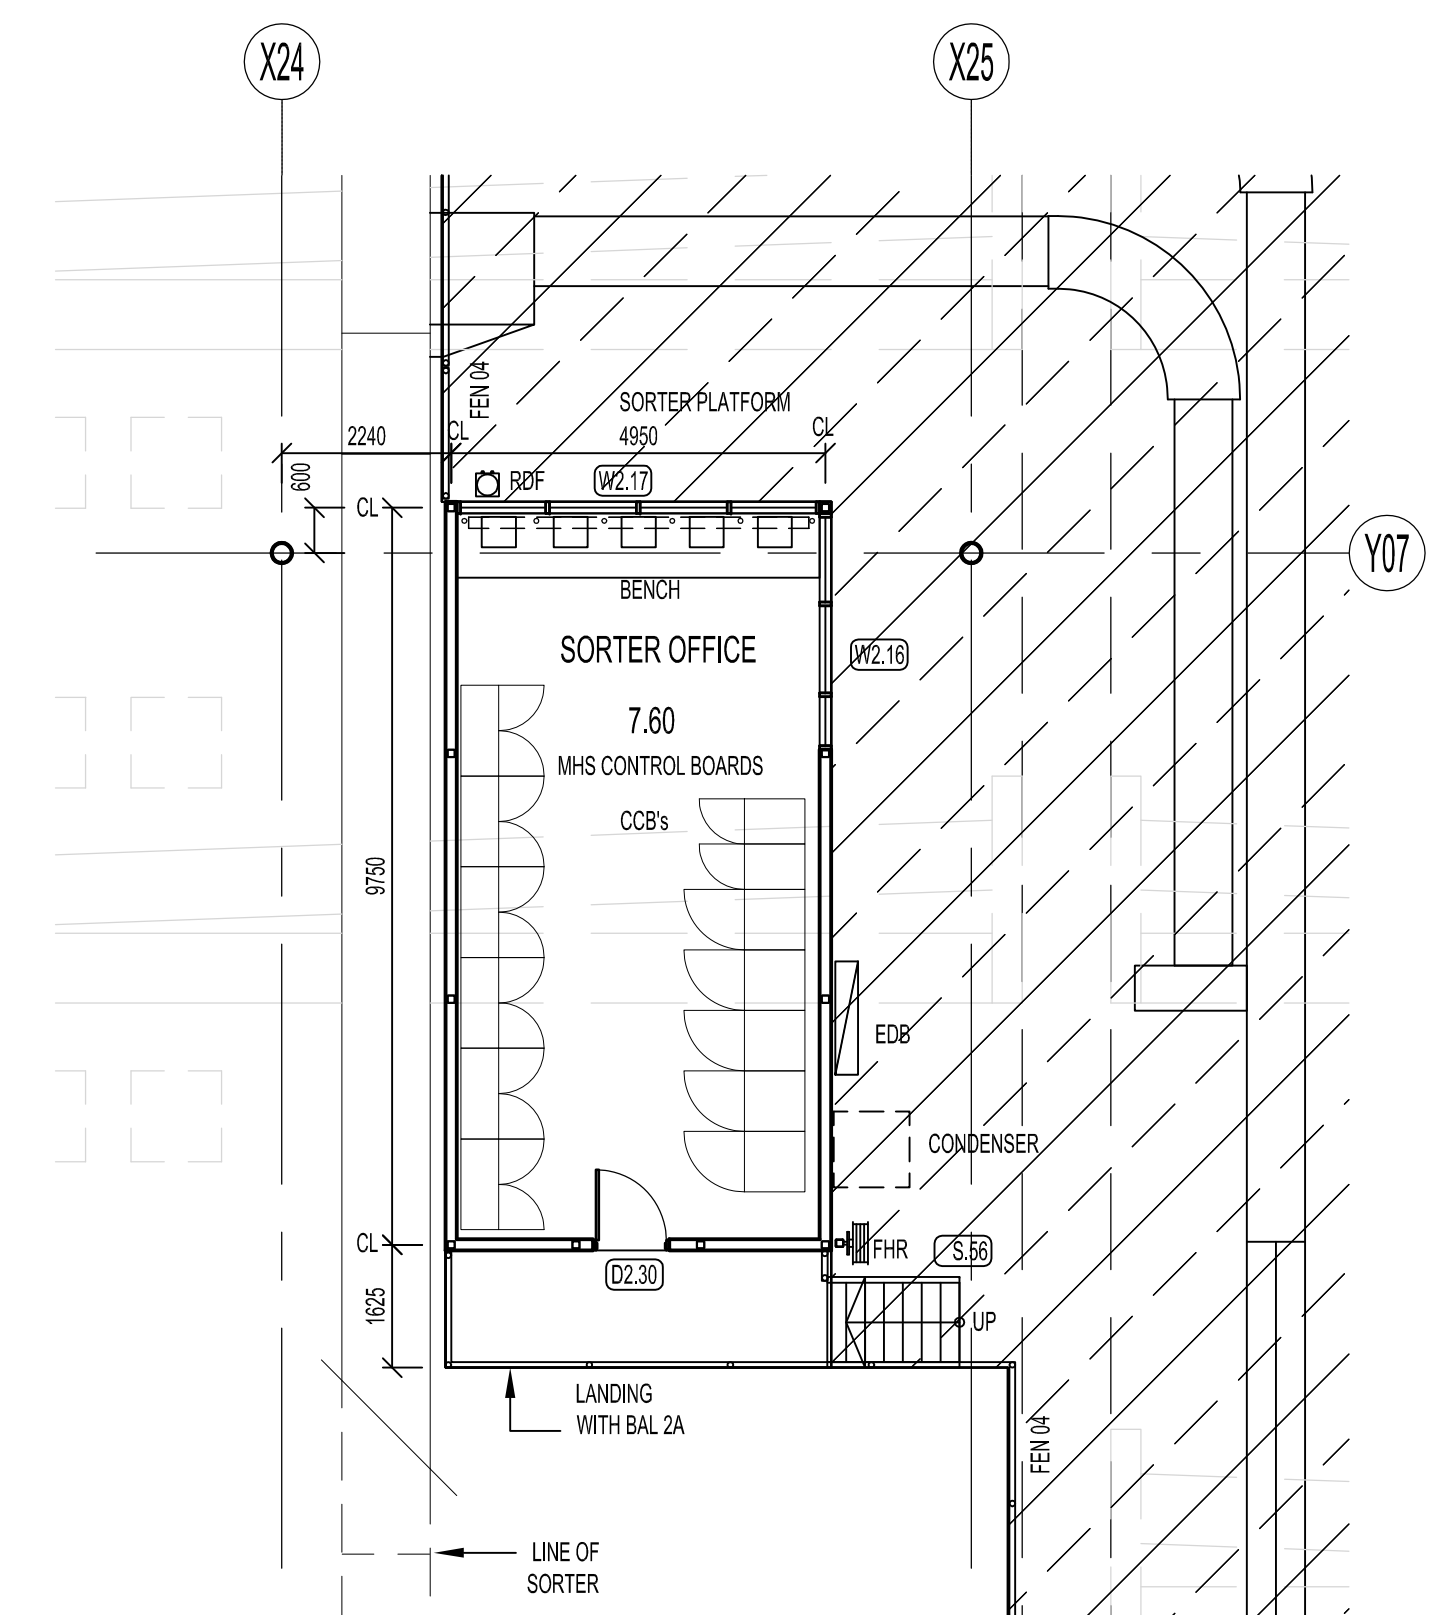

06 FLOOR PLAN
SORTER OFFICE (ON SORTER PLATFORM)

B	05.02.10	TITLE BLOCK ALTERED	FZ
A	18.01.10	NEW DRAWING	FZ
REV.	DATE	AMENDMENT	SIGNED

CLIENT
Mirvac Projects Pty. Ltd
ABN 72 001 089 245
Level 26, 80 Margaret St.
Sydney, NSW, 2000
tel. 02 9080 8000
fax. 02 9080 8181



PROJECT
BIG W
DISTRIBUTION CENTRE
HOXTON PARK NSW

ARCHITECT
MNIA ARCHITECTS
Level 4, 8 Help Street
PO Box 1212
Chatswood NSW 2067
Telephone (02) 9495 6400
Facsimile (02) 9495 6444
mail@mnia.com.au

STRUCTURAL & CIVIL ENGINEERS
COSTIN ROE CONSULTING PTY LTD
Suite 310, 55 Harrington St, The Rocks Sydney NSW 1220
Tel: (02) 9251 7699 Fax: (02) 9241 3731

ELECTRICAL & MECHANICAL ENGINEERS
SHELMERDINES
55 Hume St Crows Nest NSW 2065
Tel: (02) 9436 3021 Fax: (02) 9439 8709

FIRE ENGINEERS
AECON
Level 11, 44 Market St Sydney NSW 2000
Tel: (02) 8295 7535 Fax: (02) 8295 7500

HYDRAULIC ENGINEERS
NIVEN DONNELLY & PARTNERS PTY LTD
Suite 1, 769 Pacific Highway, Chatswood NSW 2067
Tel: (02) 9884 8911 Fax: (02) 9884 8977

TITLE
SATELLITE OFFICE AREAS

DATE	27-11-09	PROJECT No.	0930	STATUS	AR/DA
SCALE	1:100	(B1)			
DRAWN	SRC				
CHECKED		DWG No.		REV No.	
APPROVED			DA 15	/B	