


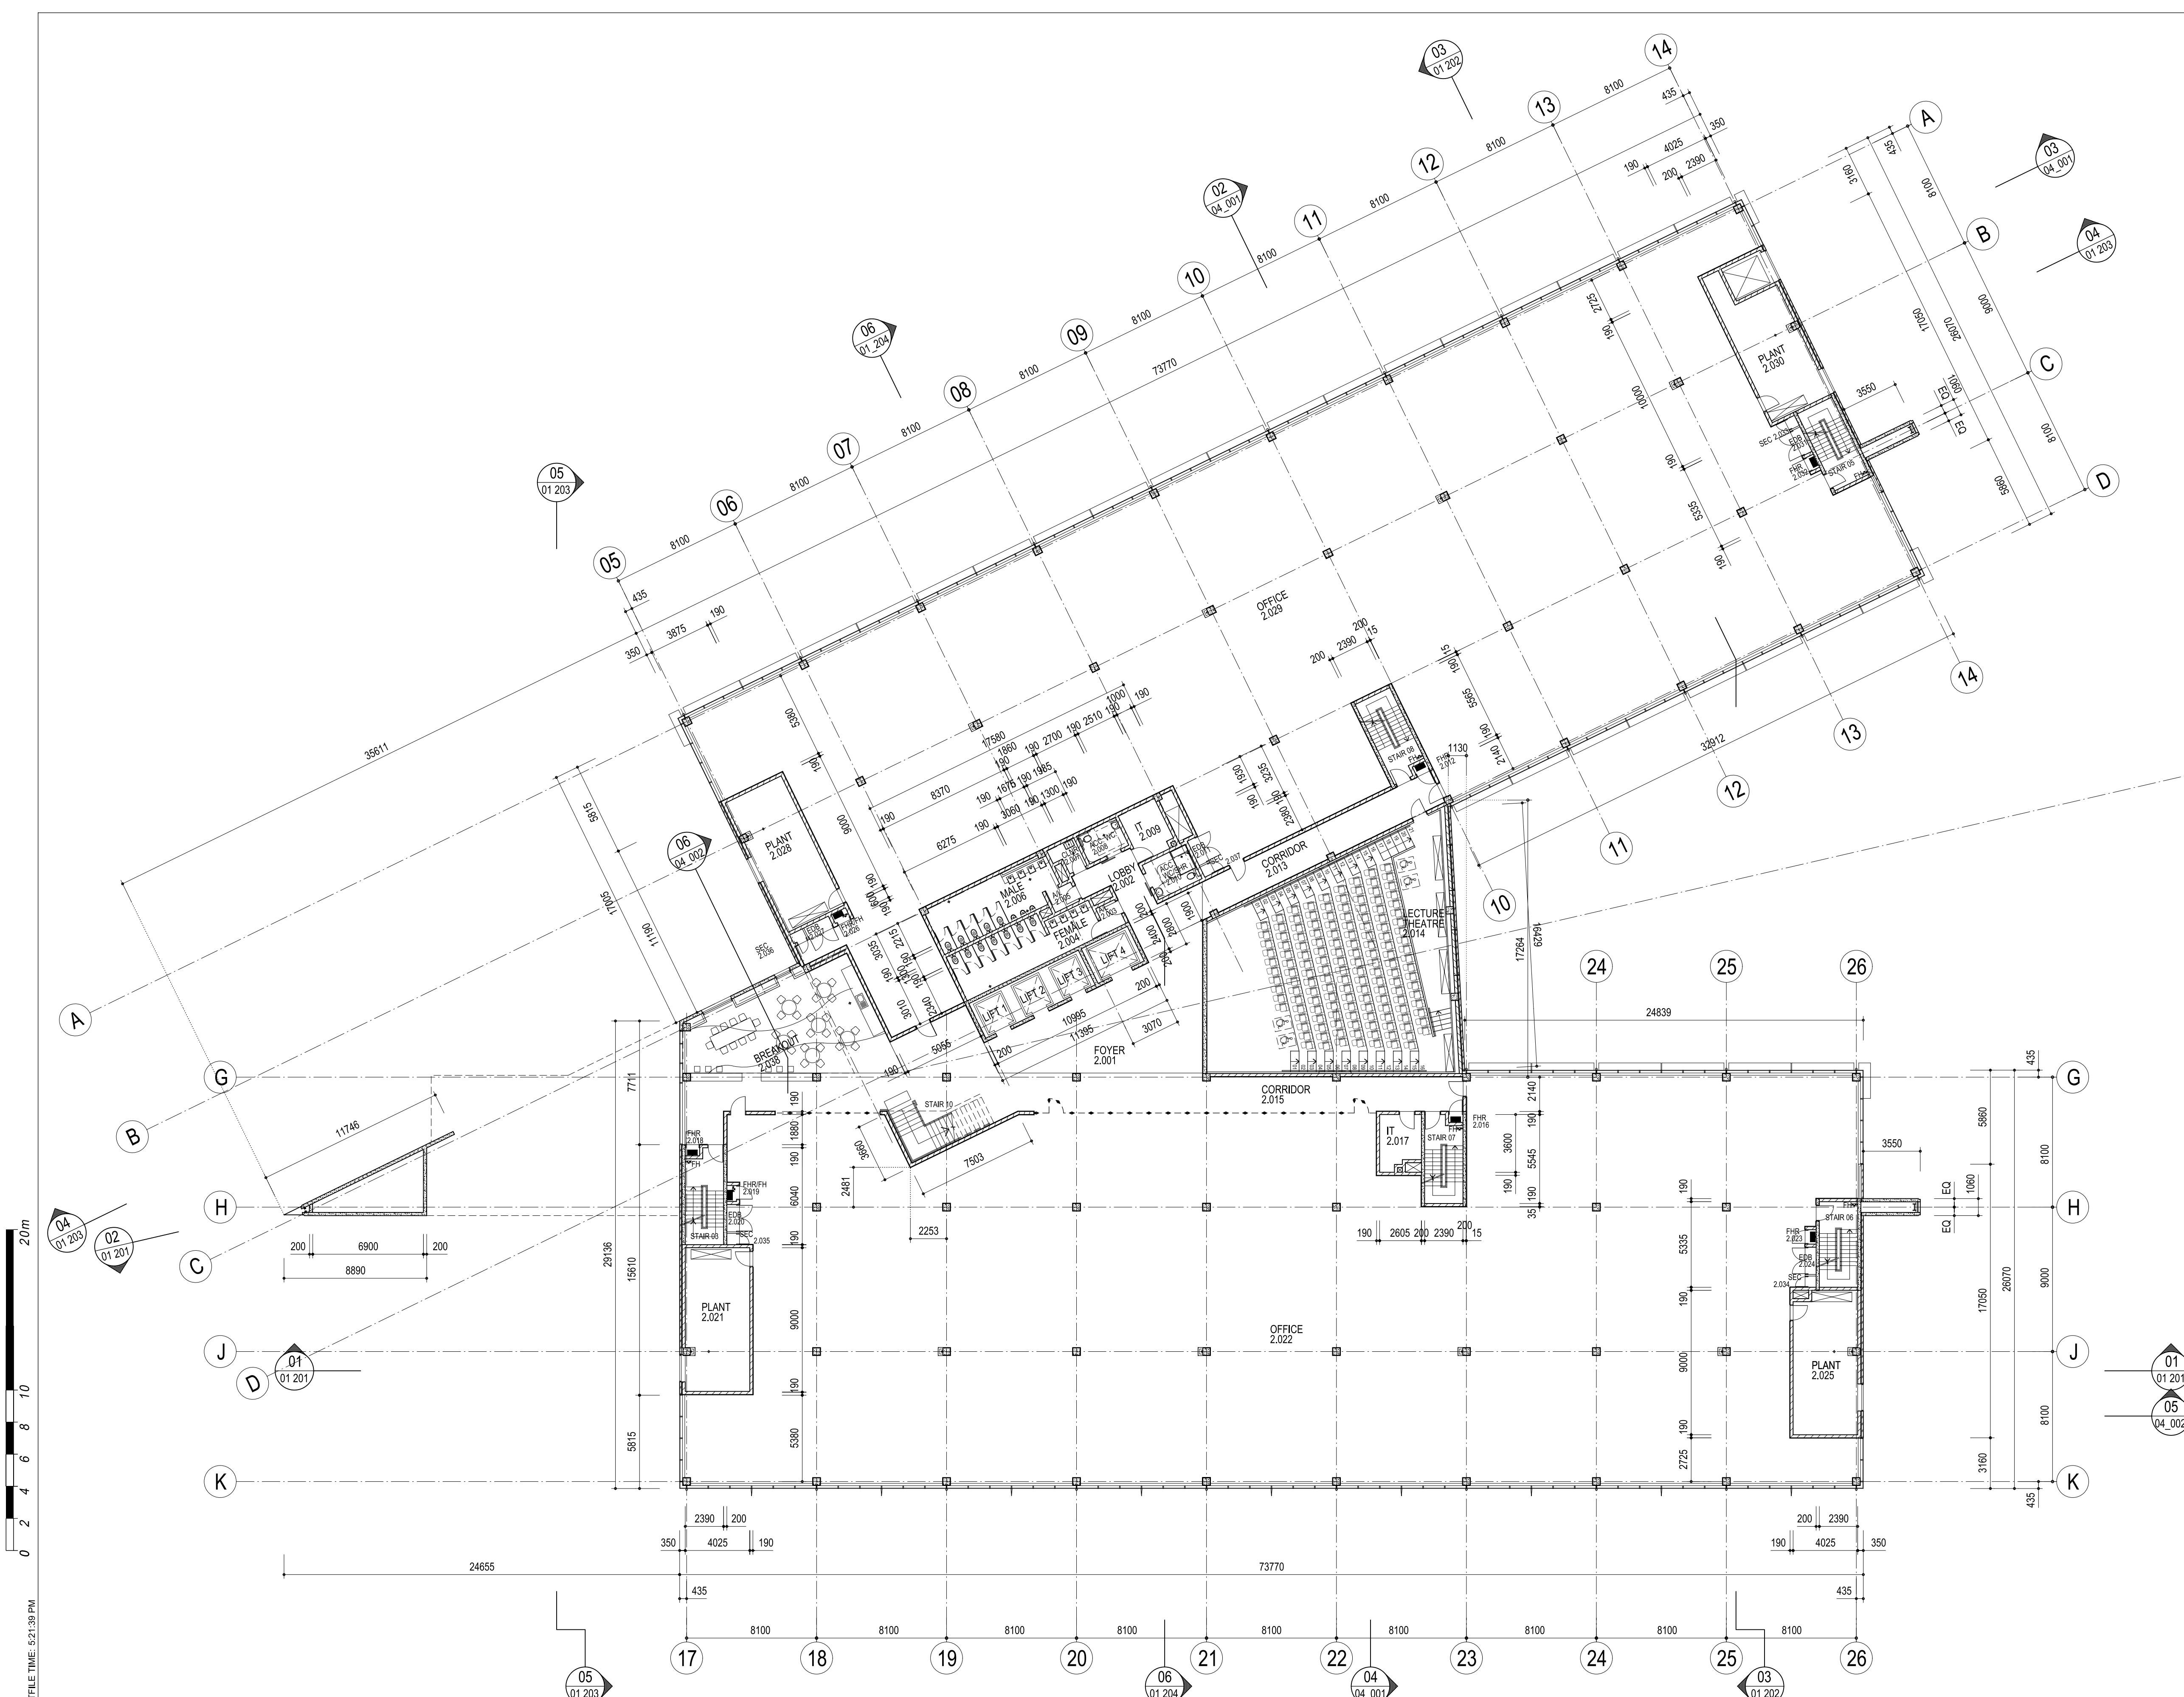

20m
0 2 4 6 8 10
PLOT DATE: 09-Jun-2010, PLOT TIME: 4:21:39 PM

AMENDMENTS	
REV	DATE
1	13.05.10
2	09.06.10

BY
MW
MW

NOTE:
1) THESE DRAWINGS ARE TO BE READ IN CONJUNCTION WITH ALL OTHER WORKING DRAWINGS, SCHEDULES, SPECIFICATIONS AND OTHER INFORMATION PROVIDED.
2) DO NOT OBTAIN DIMENSIONS BY SCALING FROM THESE DRAWINGS.
3) ALL DIMENSIONS TO BE VERIFIED ON SITE PRIOR TO PREPARATION OF SHOP DRAWINGS.

ARCHITECTURAL
PERIMETAL PERAVOLI
ARCHITECTS
T +61 2 9291 0000
F +61 2 9291 0088

PROJECT MANAGER
COFFEE PROJECTS
T +61 2 9297 2100
F +61 2 9297 2188
ELECTRICAL & COMMUNICATIONS
ERBAS & ASSOCIATES
T +61 2 9437 1000
F +61 2 9437 1020
HYDRAULIC
INTERIOR DESIGNER
GEYER
T +61 2 9248 3222

CIVIL & STRUCTURAL
WOODACOTT CONSULTING ENGINEERS
T +61 2 9413 1380
F +61 2 9413 1332
MECHANICAL
ERBAS & ASSOCIATES
T +61 2 9437 1022
F +61 2 9437 1025
BCA
CITY PLAN SERVICES
T +61 2 9270 3500
F +61 2 9270 3501
ESD
CUNDALL
T +61 2 9424 7000
F +61 2 9424 7099

AUSTRALIAN HEARING HUB
AT MACQUARIE UNIVERSITY

LEVEL 2 FLOOR PLAN

SCALES (A1 original) 1:200 @ A1 1:400 @ A3		CONSULTANTS DRAWING REFERENCE NUMBER	
DESIGNED NVE	DRAFTED PPA	VERIFIED PPA	TRUE NORTH DATE 09-June-2010
DRAWING NUMBER AHH		DISCIPLINE CODE -ARC	
PROJECT CODE AHH		DRAWING TYPE -PA	
SERIES NUMBER 01		REVISION 005	