


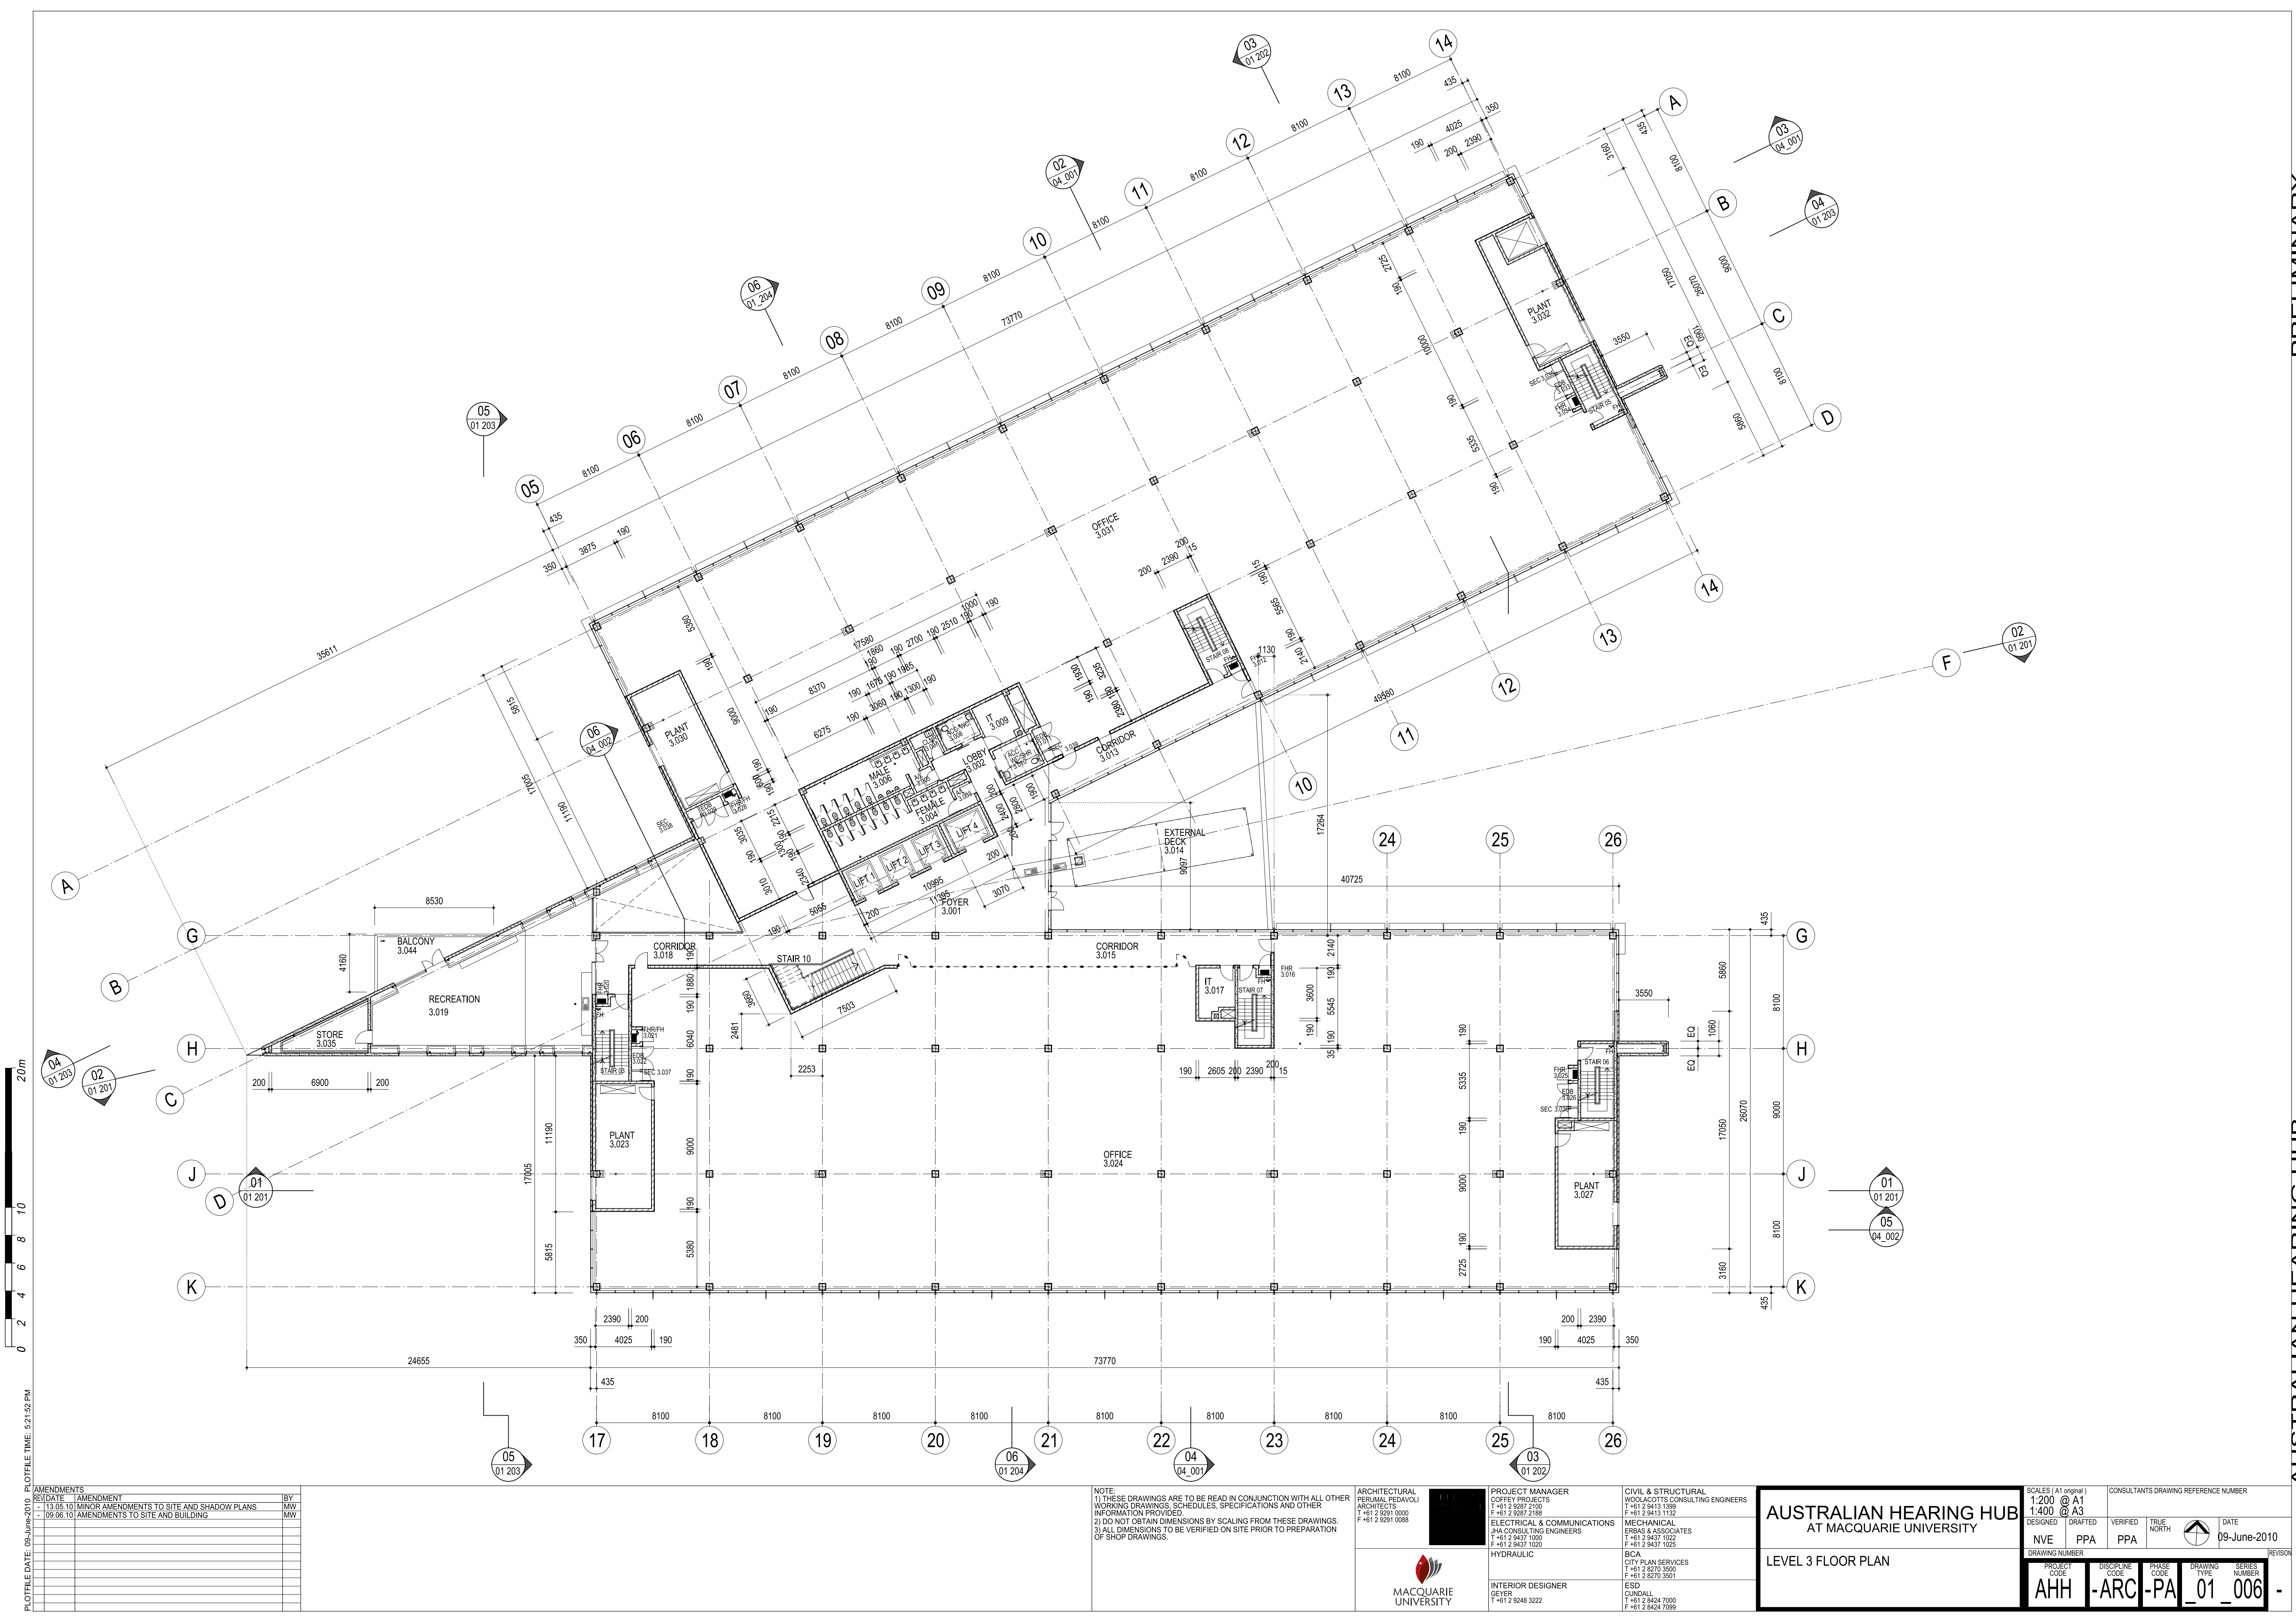

0 2 4 6 8 10 20m

PLOT DATE: 09-Jun-2010, PLOT TIME: 4:21:52 PM

| AMENDMENTS |          |
|------------|----------|
| REV        | DATE     |
| 1          | 13.05.10 |
| 2          | 09.06.10 |

BY  
MW  
MW

NOTE:  
1) THESE DRAWINGS ARE TO BE READ IN CONJUNCTION WITH ALL OTHER WORKING DRAWINGS, SCHEDULES, SPECIFICATIONS AND OTHER INFORMATION PROVIDED.  
2) DO NOT OBTAIN DIMENSIONS BY SCALING FROM THESE DRAWINGS.  
3) ALL DIMENSIONS TO BE VERIFIED ON SITE PRIOR TO PREPARATION OF SHOP DRAWINGS.

ARCHITECTURAL  
PERIMETER PROJECTS  
ARCHITECTS  
T +61 2 9291 0000  
F +61 2 9291 0088

PROJECT MANAGER  
COFFEY PROJECTS  
T +61 2 9297 2100  
F +61 2 9297 2188  
ELECTRICAL & COMMUNICATIONS  
ERBAS & ASSOCIATES  
T +61 2 9437 1000  
F +61 2 9437 1020  
HYDRAULIC  
INTERIOR DESIGNER  
GEYER  
T +61 2 9248 3222

CIVIL & STRUCTURAL  
WOODACOTT CONSULTING ENGINEERS  
T +61 2 9413 1380  
F +61 2 9413 1132  
MECHANICAL  
ERBAS & ASSOCIATES  
T +61 2 9437 1022  
F +61 2 9437 1025  
BCA  
CITY PLAN SERVICES  
T +61 2 9270 3500  
F +61 2 9270 3501  
ESD  
CUNDALL  
T +61 2 9424 7000  
F +61 2 9424 7099

AUSTRALIAN HEARING HUB  
AT MACQUARIE UNIVERSITY

LEVEL 3 FLOOR PLAN

|                                                  |                |                                      |                                    |
|--------------------------------------------------|----------------|--------------------------------------|------------------------------------|
| SCALES (A1 original)<br>1:200 @ A1<br>1:400 @ A3 |                | CONSULTANTS DRAWING REFERENCE NUMBER |                                    |
| DESIGNED<br>NVE                                  | DRAFTED<br>PPA | VERIFIED<br>PPA                      | TRUE NORTH<br>DATE<br>09-June-2010 |
| DRAWING NUMBER<br>AHH                            |                | DISCIPLINE CODE<br>-ARC              |                                    |
| PROJECT CODE<br>AHH                              |                | PHASE CODE<br>-PA                    |                                    |
| TYPE<br>01                                       |                | SERIES NUMBER<br>006                 |                                    |

PRELIMINARY

AUSTRALIAN HEARING HUB