


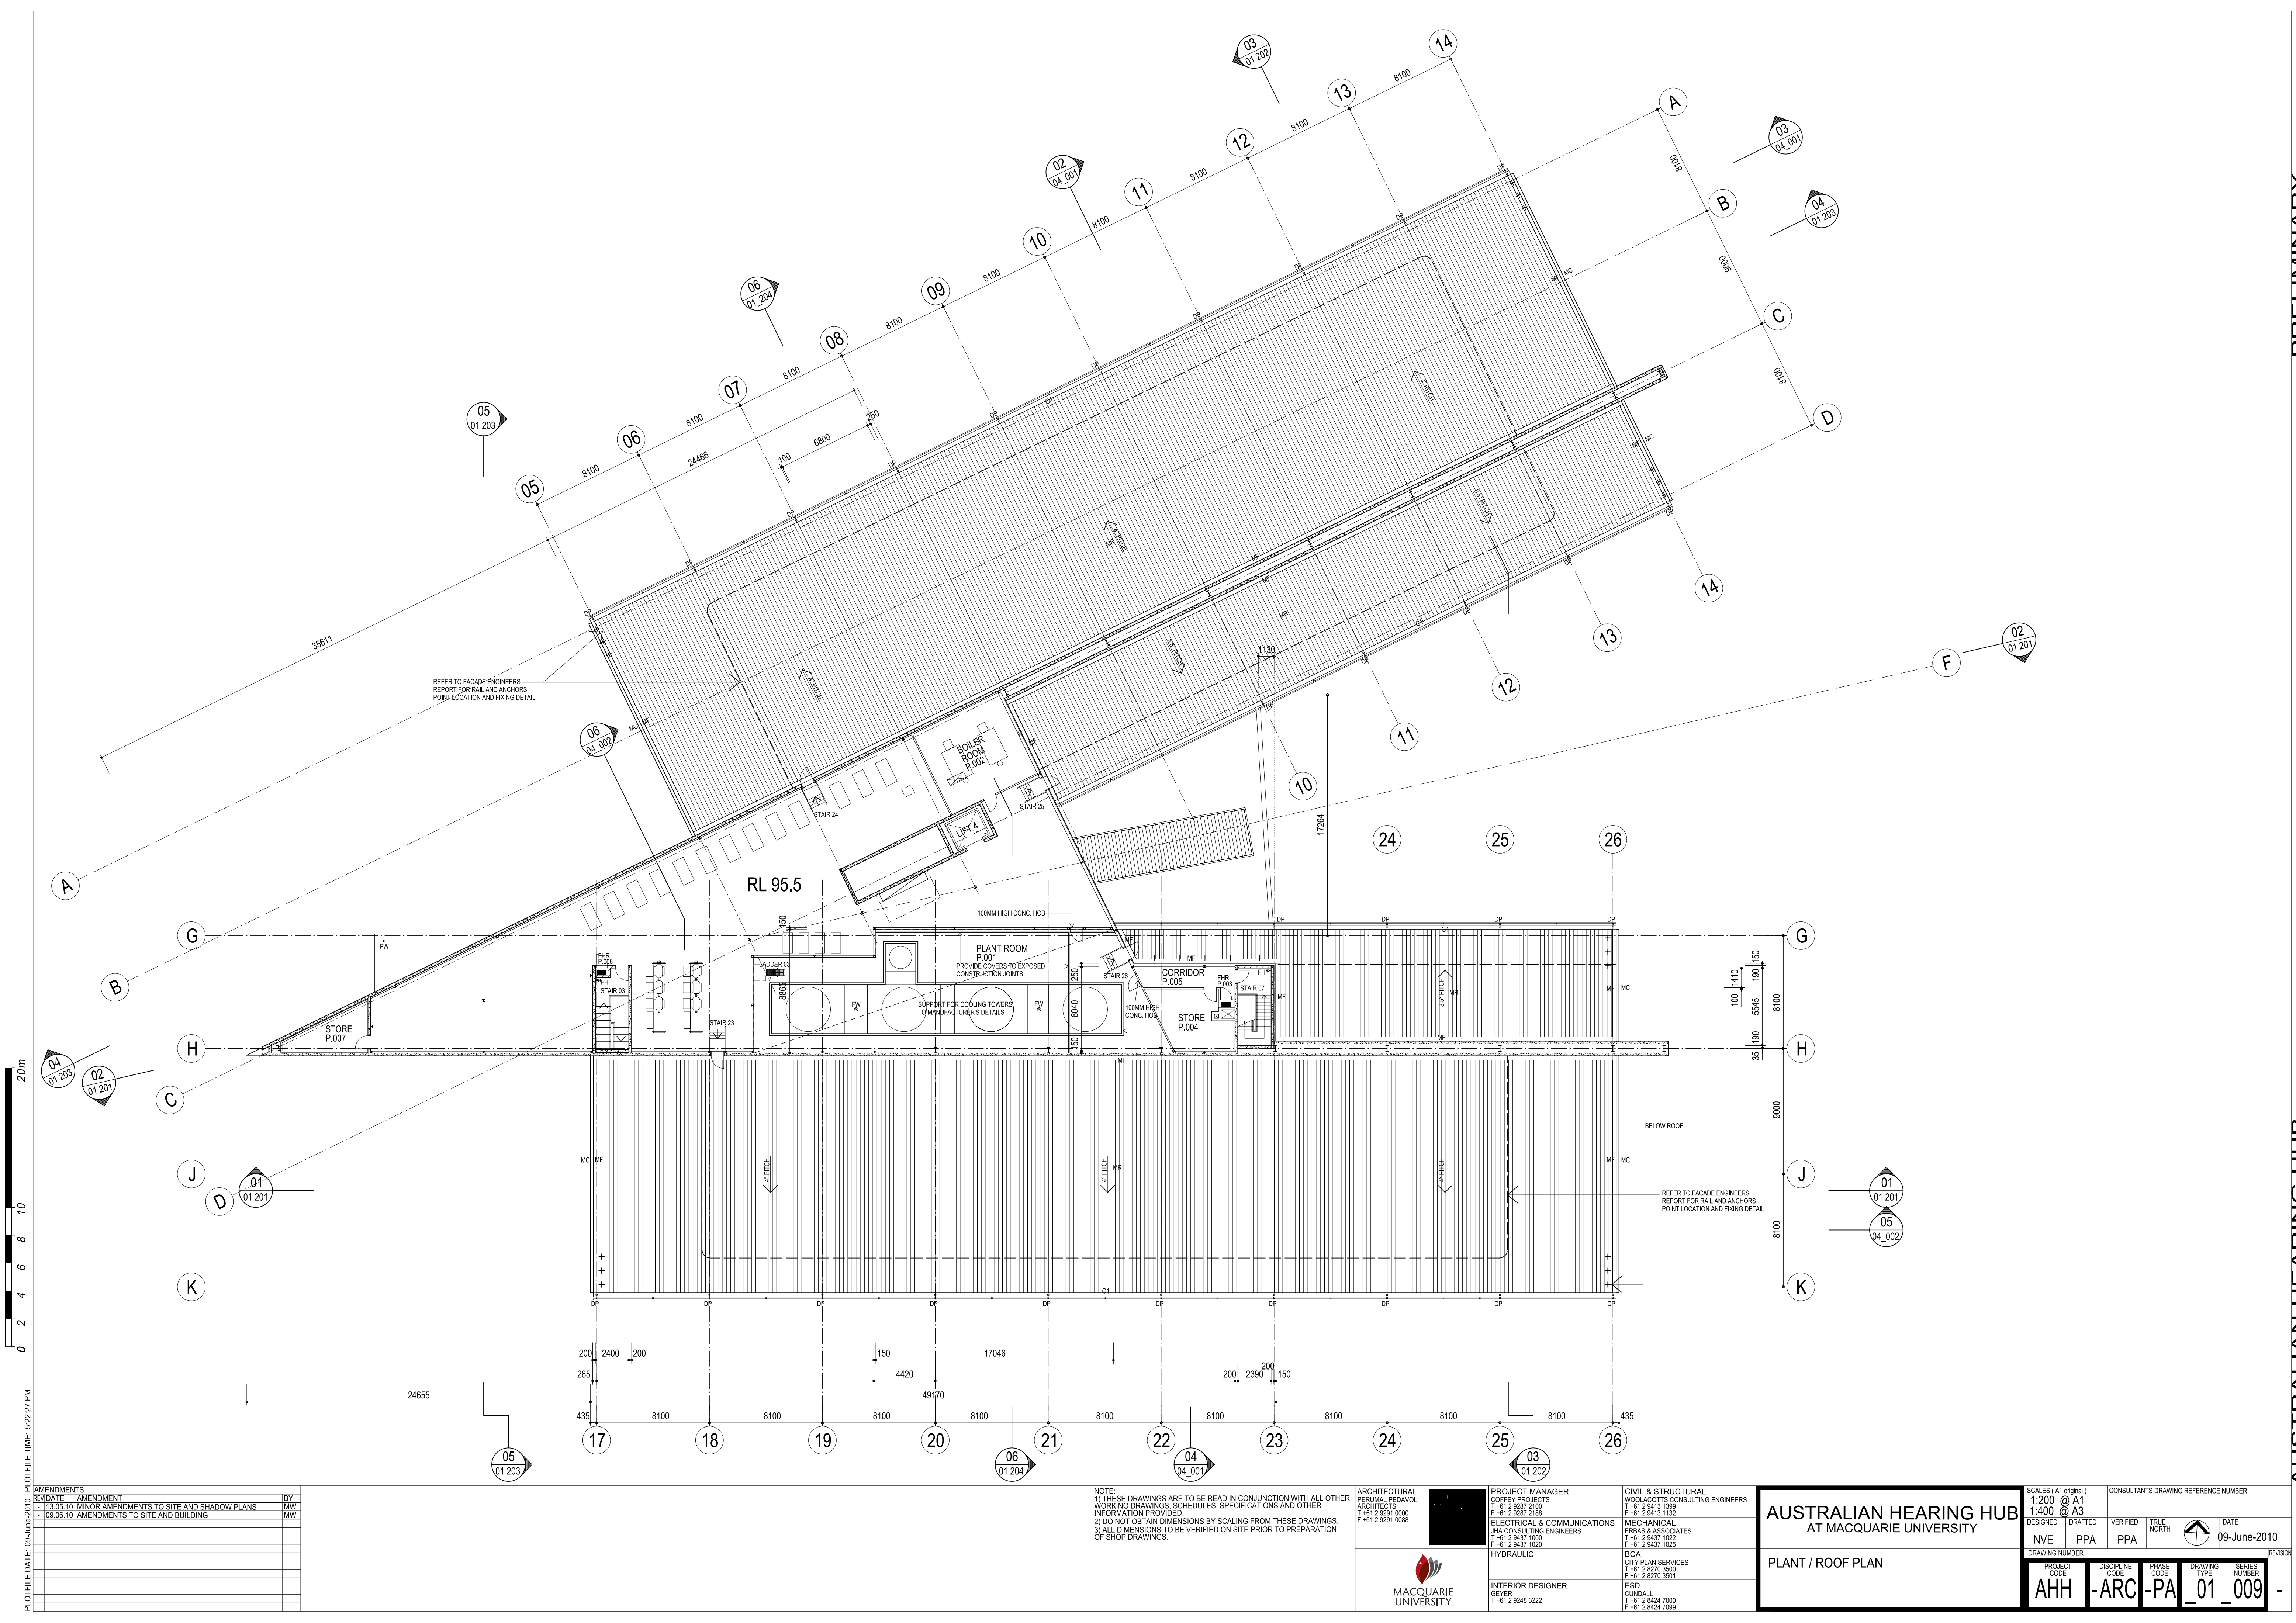

AMENDMENTS		
REV	DATE	DESCRIPTION
01	05.10.10	MINOR AMENDMENTS TO SITE AND SHADOW PLANS
02	05.10.10	AMENDMENTS TO SITE AND BUILDING

BY
IMW
IMW

NOTE:
1) THESE DRAWINGS ARE TO BE READ IN CONJUNCTION WITH ALL OTHER WORKING DRAWINGS, SCHEDULES, SPECIFICATIONS AND OTHER INFORMATION PROVIDED.
2) DO NOT OBTAIN DIMENSIONS BY SCALING FROM THESE DRAWINGS.
3) ALL DIMENSIONS TO BE VERIFIED ON SITE PRIOR TO PREPARATION OF SHOP DRAWINGS.

ARCHITECTURAL
PERIMUL RETNAVOLI
ARCHITECTS
T +61 2 9291 0000
F +61 2 9291 0088

PROJECT MANAGER
COFFEY PROJECTS
T +61 2 9297 2100
F +61 2 9297 2188
ELECTRICAL & COMMUNICATIONS
ERBAS & ASSOCIATES
T +61 2 9437 1000
F +61 2 9437 1020
HYDRAULIC
INTERIOR DESIGNER
GEYER
T +61 2 9248 3222

CIVIL & STRUCTURAL
WOOLACOTT CONSULTING ENGINEERS
T +61 2 9413 1380
F +61 2 9413 1332
MECHANICAL
ERBAS & ASSOCIATES
T +61 2 9437 1022
F +61 2 9437 1025
BCA
CITY PLAN SERVICES
T +61 2 9270 3500
F +61 2 9270 3501
ESD
CUNDALL
T +61 2 9424 7000
F +61 2 9424 7099

AUSTRALIAN HEARING HUB
AT MACQUARIE UNIVERSITY

PLANT / ROOF PLAN

SCALES (A1 @ 10mm)
1:200 @ A1
1:400 @ A3

CONSULTANTS DRAWING REFERENCE NUMBER

DATE
09-June-2010

DESIGNED
NVE

DRAFTED
PPA

VERIFIED
PPA

TRUE NORTH

PROJECT CODE
AHH

DISCIPLINE CODE
-ARC

DRAWING TYPE
-PA

DRAWING NUMBER
01

SERIES NUMBER
009

PRELIMINARY

AUSTRALIAN HEARING HUB