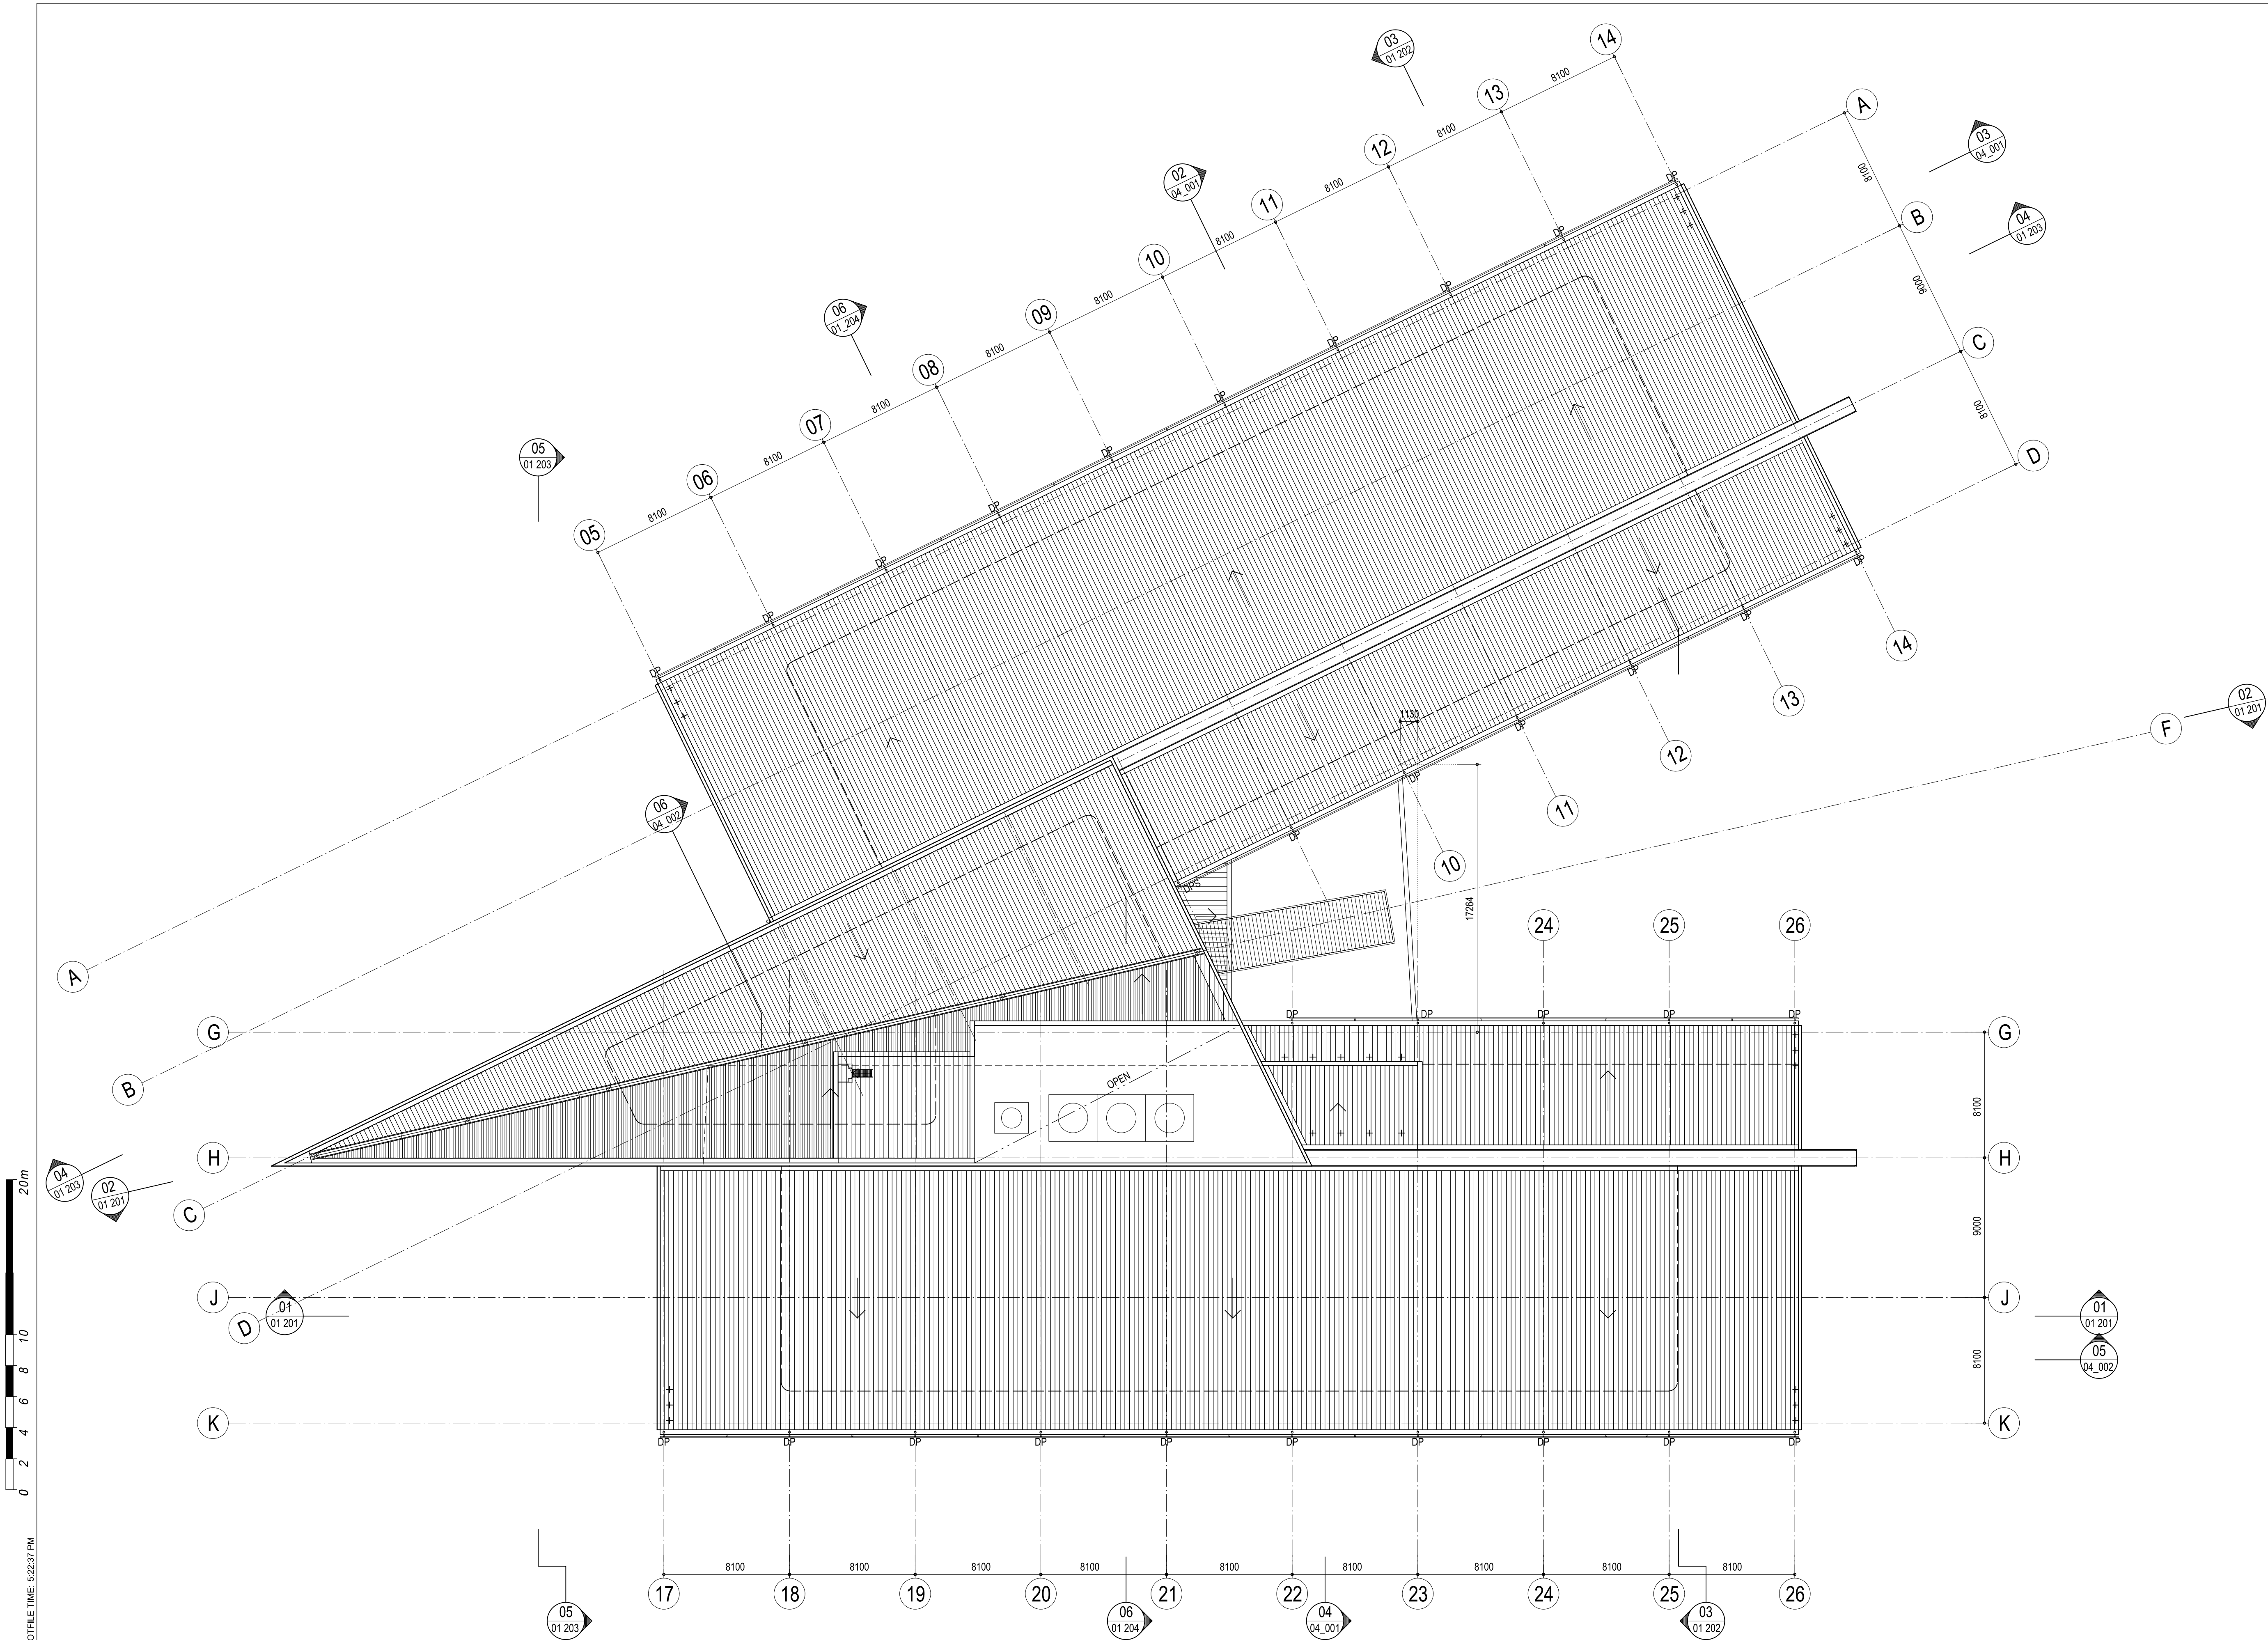


PLOT DATE: 09-Jun-2010, PLOT TIME: 4:22:37 PM

AMENDMENTS	
REV	DATE
1	13.05.10
2	09.06.10

BY
MW
MW

NOTE:
1) THESE DRAWINGS ARE TO BE READ IN CONJUNCTION WITH ALL OTHER WORKING DRAWINGS, SCHEDULES, SPECIFICATIONS AND OTHER INFORMATION PROVIDED.
2) DO NOT OBTAIN DIMENSIONS BY SCALING FROM THESE DRAWINGS.
3) ALL DIMENSIONS TO BE VERIFIED ON SITE PRIOR TO PREPARATION OF SHOP DRAWINGS.

ARCHITECTURAL
PERIMETER RETAINING
ARCHITECTS
T +61 2 9291 0000
F +61 2 9291 0088



PROJECT MANAGER
COFFEY PROJECTS
T +61 2 9297 2100
F +61 2 9297 2188
ELECTRICAL & COMMUNICATIONS
JHA CONSULTING ENGINEERS
T +61 2 9437 1000
F +61 2 9437 1020
HYDRAULIC
INTERIOR DESIGNER
GEYER
T +61 2 9248 3222

CIVIL & STRUCTURAL
WOODACOTT CONSULTING ENGINEERS
T +61 2 9413 1389
F +61 2 9413 1132
MECHANICAL
ERBAS & ASSOCIATES
T +61 2 9437 1022
F +61 2 9437 1025
BCA
CITY PLAN SERVICES
T +61 2 9270 3500
F +61 2 9270 3501
ESD
CUNDALL
T +61 2 9424 7000
F +61 2 9424 7099

AUSTRALIAN HEARING HUB
AT MACQUARIE UNIVERSITY

ROOF PLAN

SCALES (A1 @ 10mm)		CONSULTANTS DRAWING REFERENCE NUMBER	
1:200 @ A1	1:400 @ A3	DESIGNED	VERIFIED
NVE	PPA	PPA	TRUE NORTH
DRAWING NUMBER		DATE	
AHH		09-June-2010	
PROJECT CODE	DISCIPLINE CODE	PHASE CODE	DRAWING TYPE
AHH	-ARC	-PA	01_010

PRELIMINARY

AUSTRALIAN HEARING HUB