

 


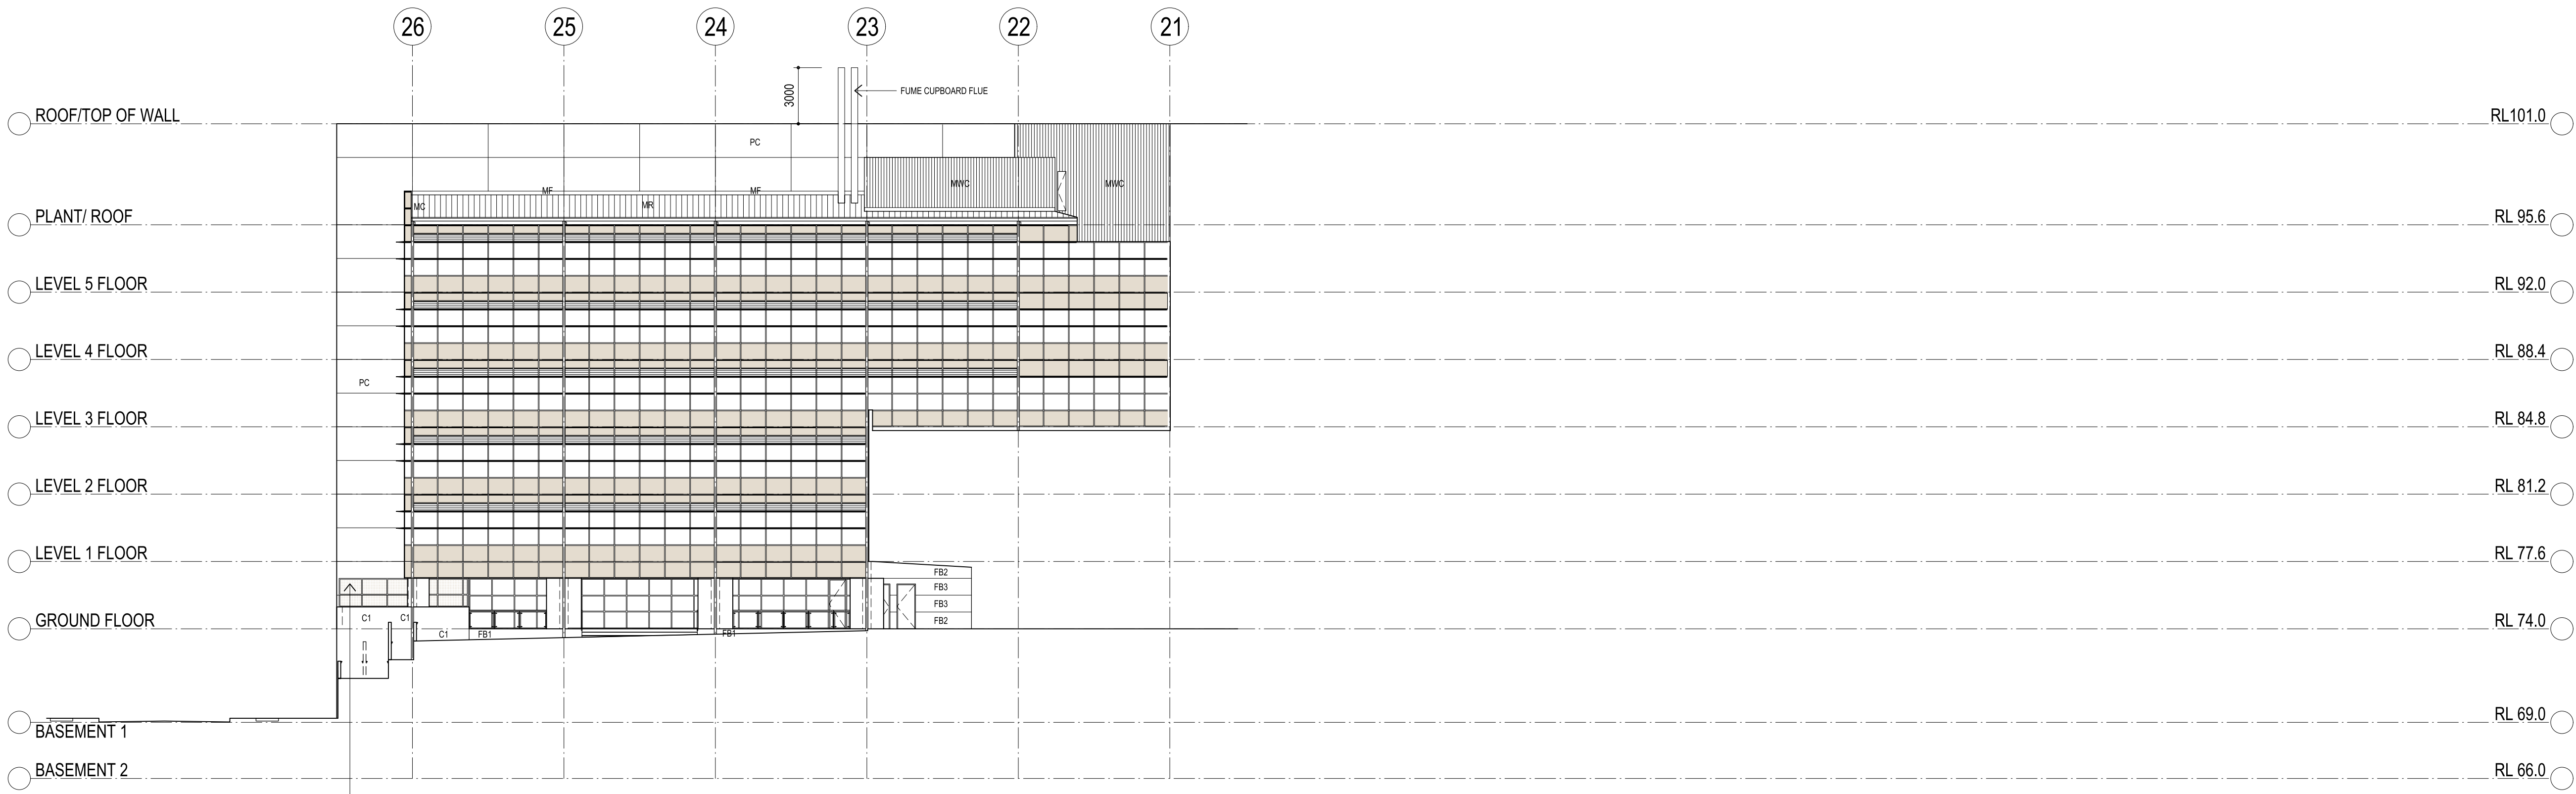

NORTH ELEVATION

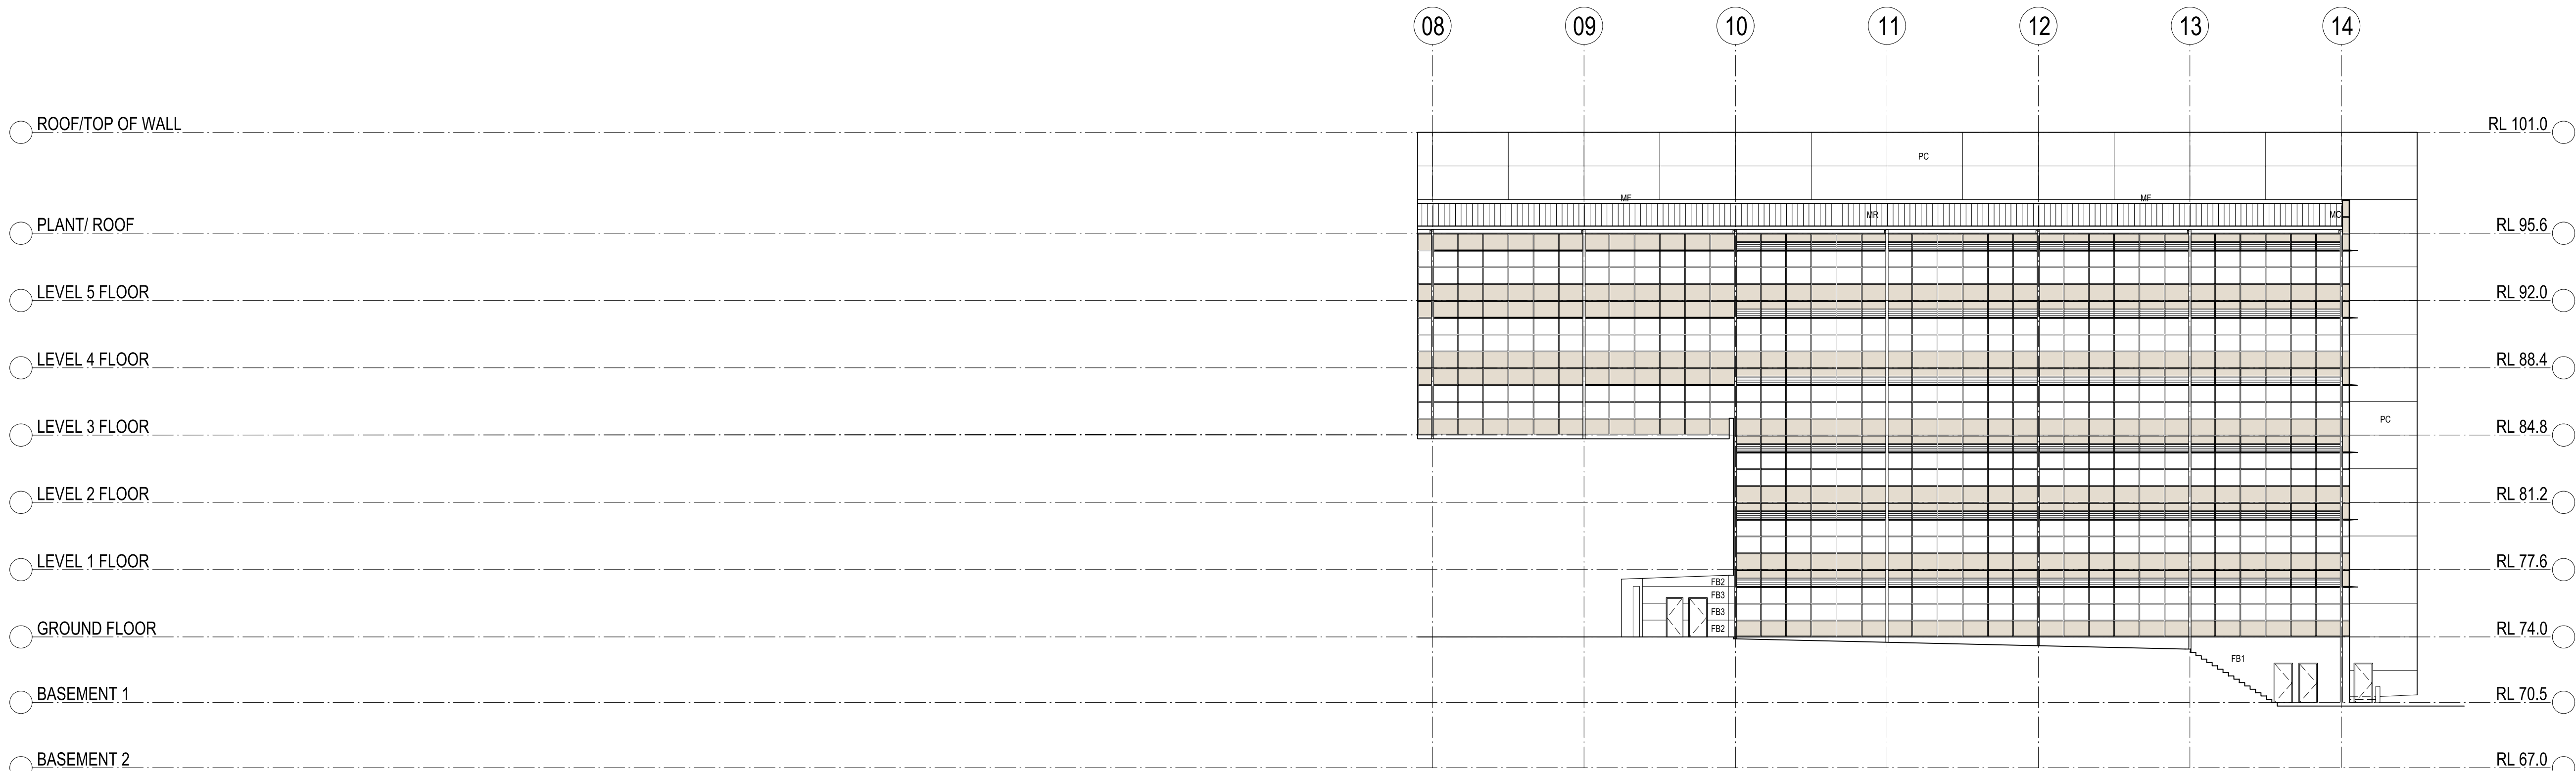


SOUTH EAST ELEVATION



PLOT DATE: 9/06/2010
PLOT TIME: 2:26:47 PM

AMENDMENTS		
REV	DATE	BY
1	13.05.10	IMW
2	09.06.10	IMW

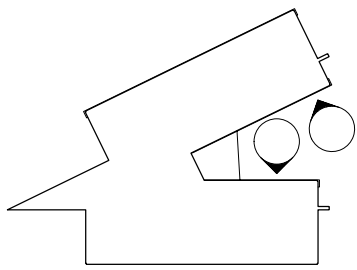

KEY MAP

NOTE:
1) THESE DRAWINGS ARE TO BE READ IN CONJUNCTION WITH ALL OTHER WORKING DRAWINGS, SCHEDULES, SPECIFICATIONS AND OTHER INFORMATION PROVIDED.
2) DO NOT OBTAIN DIMENSIONS BY SCALING FROM THESE DRAWINGS.
3) ALL DIMENSIONS TO BE VERIFIED ON SITE PRIOR TO PREPARATION OF SHOP DRAWINGS.

ARCHITECTURAL
PERIMAR PERAVOLI
ARCHITECTS
T +61 2 9291 0000
F +61 2 9291 0088



PROJECT MANAGER
COFFEY PROJECTS
T +61 2 9287 2100
F +61 2 9287 2188
ELECTRICAL & COMMUNICATIONS
JHA CONSULTING ENGINEERS
T +61 2 9437 1000
F +61 2 9437 1020

HYDRAULIC

INTERIOR DESIGNER
GEYER
T +61 2 9248 3222

CIVIL & STRUCTURAL
WOODCOTT CONSULTING ENGINEERS
T +61 2 9413 1389
F +61 2 9413 1332
MECHANICAL
ERBAS & ASSOCIATES
T +61 2 9437 1022
F +61 2 9437 1025

BCA
CITY PLAN SERVICES
T +61 2 8270 3500
F +61 2 8270 3501

ESD
CUNDALL
T +61 2 9424 7000
F +61 2 9424 7099

AUSTRALIAN HEARING HUB
AT MACQUARIE UNIVERSITY

ELEVATIONS
SHEET 3

SCALES (A1 original)			CONSULTANTS DRAWING REFERENCE NUMBER		
1:200	@ A1		2928-ARC-AD	XXXXXX	dwg
1:400	@ A3				
DESIGNED	DRAFTED	VERIFIED	TRUE NORTH	DATE	REVISION
NVE	PPA	PPA		9/06/2010	
DRAWING NUMBER	PROJECT CODE	DISCIPLINE CODE	PHASE CODE	DRAWING TYPE	SHEET NUMBER
AHH	-ARC	-PA	01	103	-