


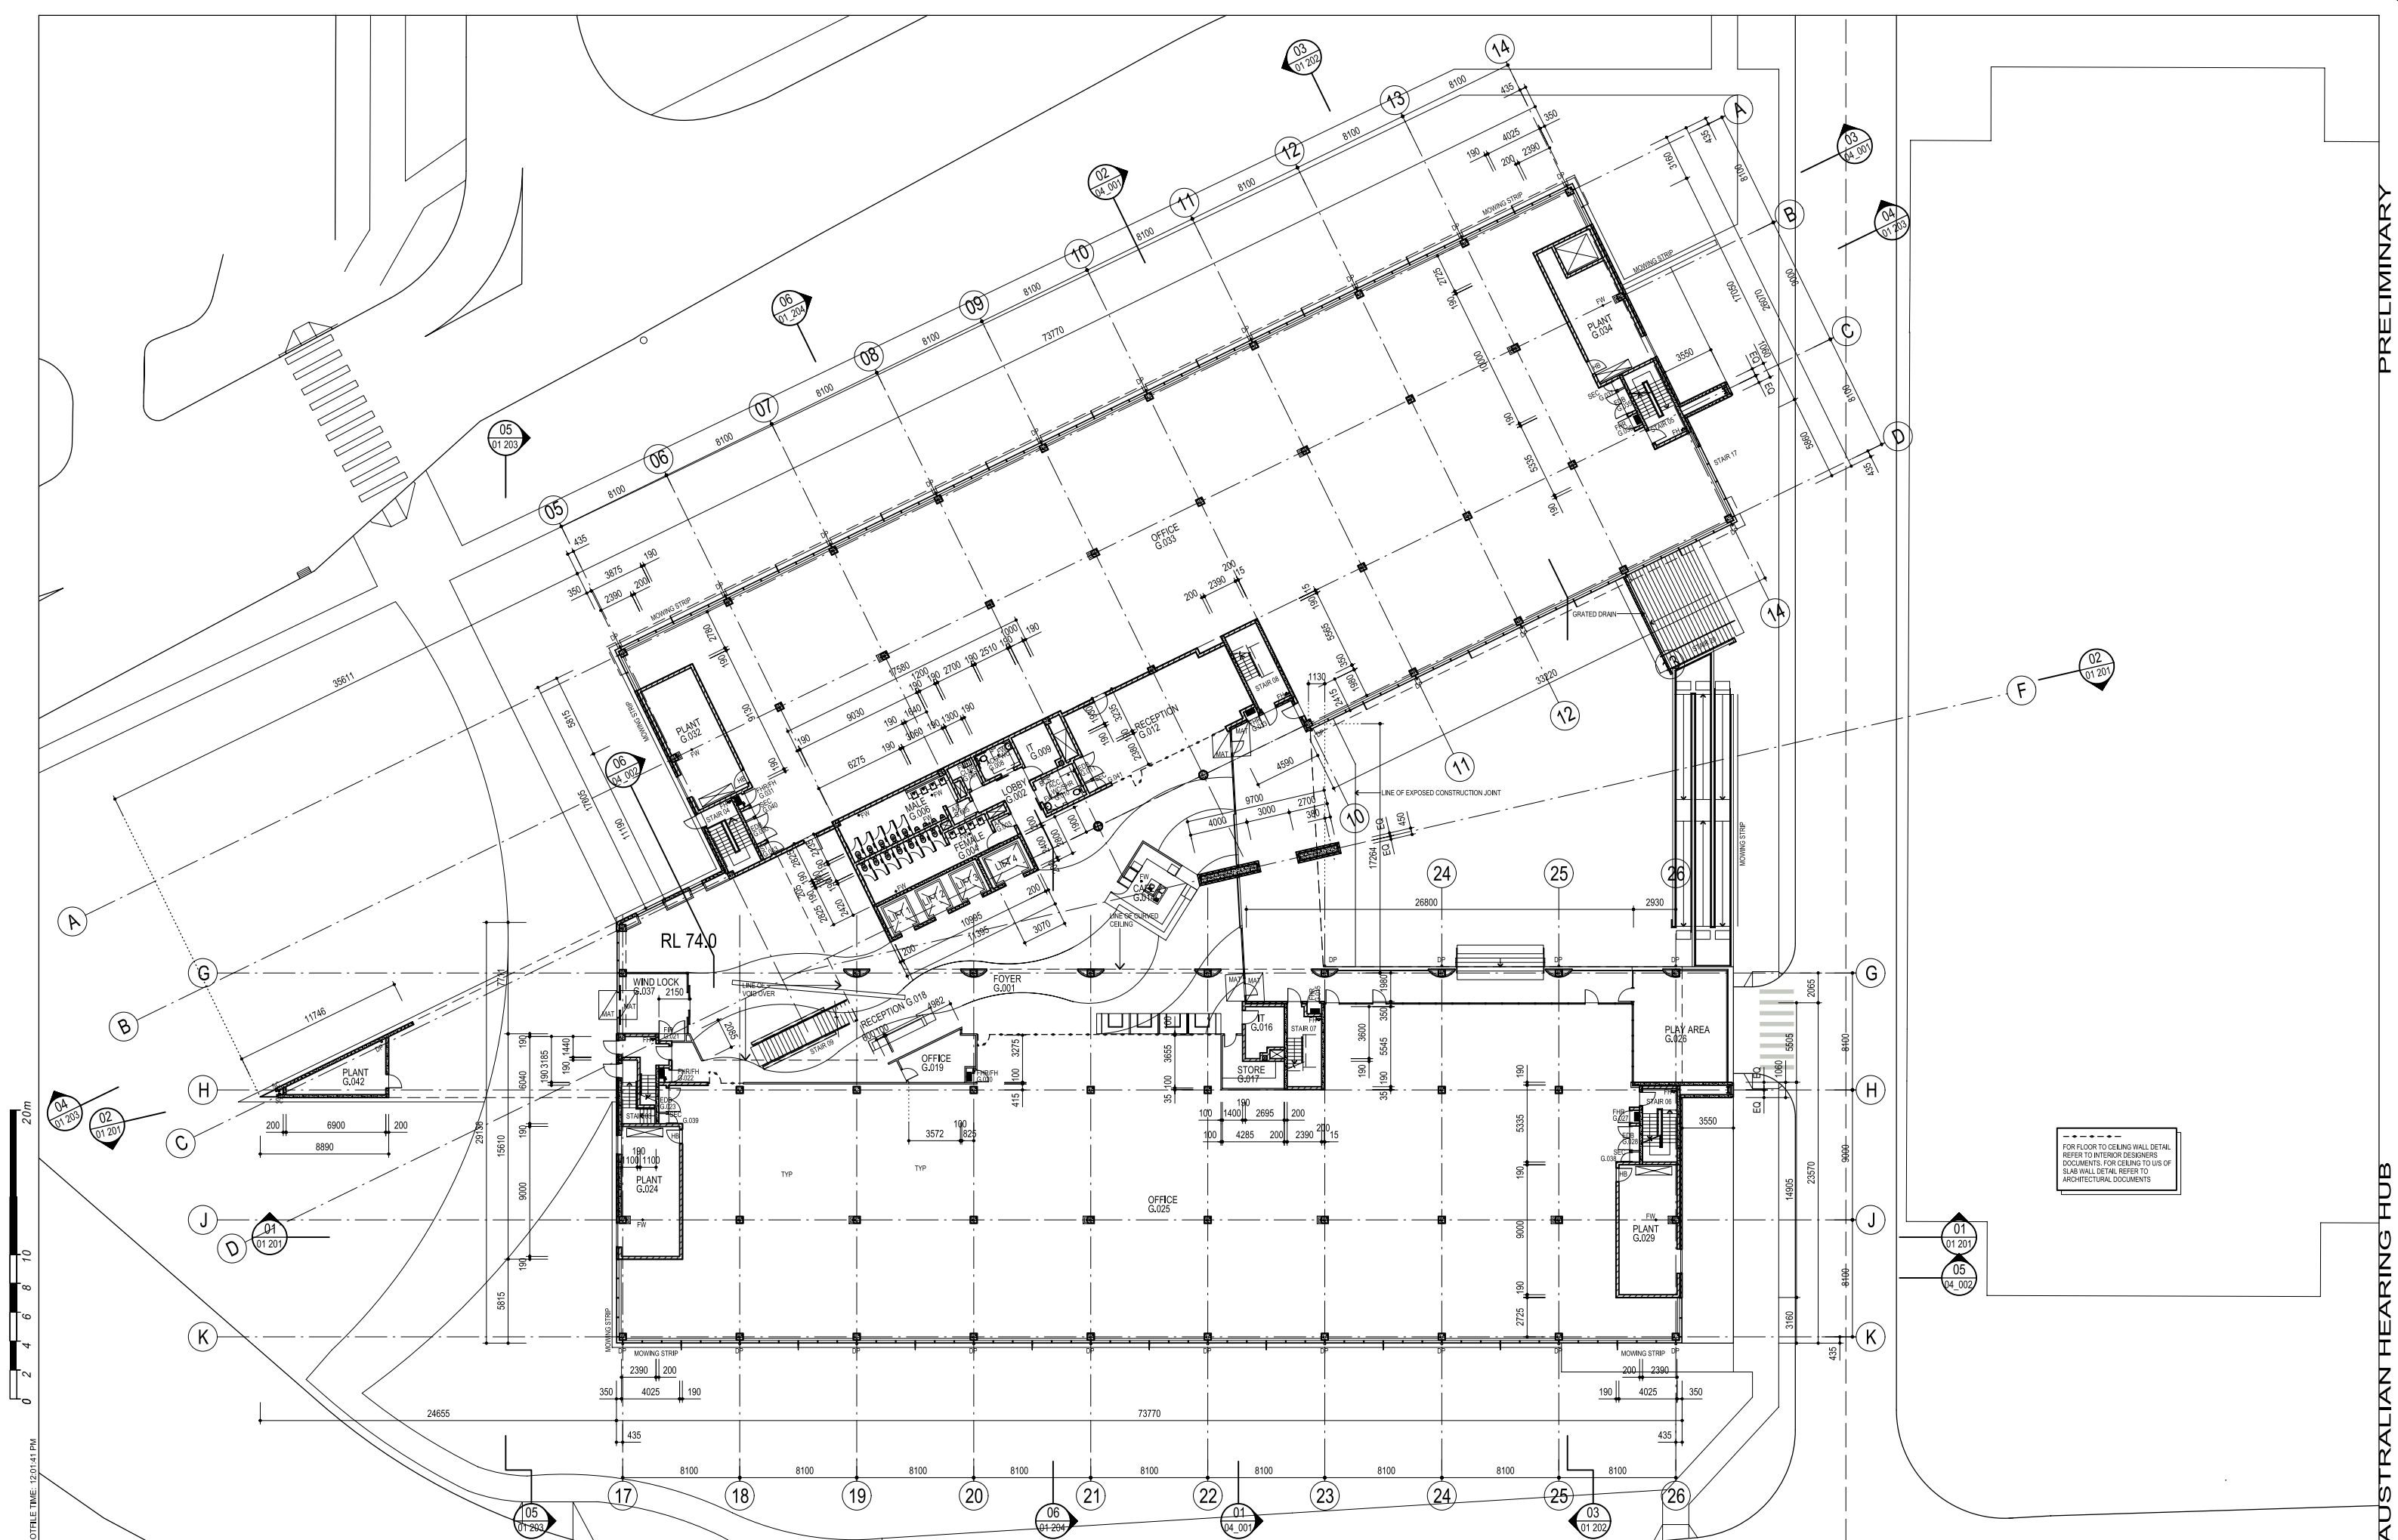

AMENDMENTS

REV	DATE	AMENDMENT	BY
01	2010	MINOR AMENDMENTS TO SITE AND SHADOW PLANS	MM
02	2010	AMENDMENTS TO SITE AND BUILDING	MM
03	2010	SITE & BUILDING PLAN AMENDED	EL
04	2010	ISSUE FOR PA	DW

NOTE:

- 1) THESE DRAWINGS ARE TO BE READ IN CONJUNCTION WITH ALL OTHER WORKING DRAWINGS, SCHEDULES, SPECIFICATIONS AND OTHER INFORMATION PROVIDED.
- 2) DO NOT OBTAIN DIMENSIONS BY SCALING FROM THESE DRAWINGS.
- 3) ALL DIMENSIONS TO BE VERIFIED ON SITE PRIOR TO PREPARATION OF SHOP DRAWINGS.

ARCHITECTURAL

PERUMAL PEDAVOLI ARCHITECTS

T +61 2 9291 2100
F +61 2 9291 0088

PROJECT MANAGER

COFFEY PROJECTS

T +61 2 9291 2100
F +61 2 9291 2188

ELECTRICAL & COMMUNICATIONS

JHA CONSULTING ENGINEERS

T +61 2 9437 1000
F +61 2 9437 1020

HYDRAULIC

INTERIOR DESIGNER

T +61 2 9248 3222

CIVIL & STRUCTURAL

WOOLACOTT CONSULTING ENGINEERS

T +61 2 9413 1399
F +61 2 9413 1132

MECHANICAL

ERBAS & ASSOCIATES

T +61 2 9437 1022
F +61 2 9437 1025

BCA CITY PLAN SERVICES

T +61 2 8270 3500
F +61 2 8270 3501

ESD

CUNDALL

T +61 2 8424 7000
F +61 2 8424 7099

AUSTRALIAN HEARING HUB
AT MACQUARIE UNIVERSITY

GROUND FLOOR PLAN

DRAWING NUMBER		CONSULTANTS DRAWING REFERENCE NUMBER	
DESIGNED	DRAFTED	VERIFIED	TRUE NORTH
NVE	PPA	PPA	

DATE: 29/09/2010

PROJECT CODE	DISCIPLINE CODE	PHASE CODE	DRAWING TYPE	SERIES NUMBER
AHH	-ARC	-PA	_01_003	A

PRELIMINARY

AUSTRALIAN HEARING HUB