


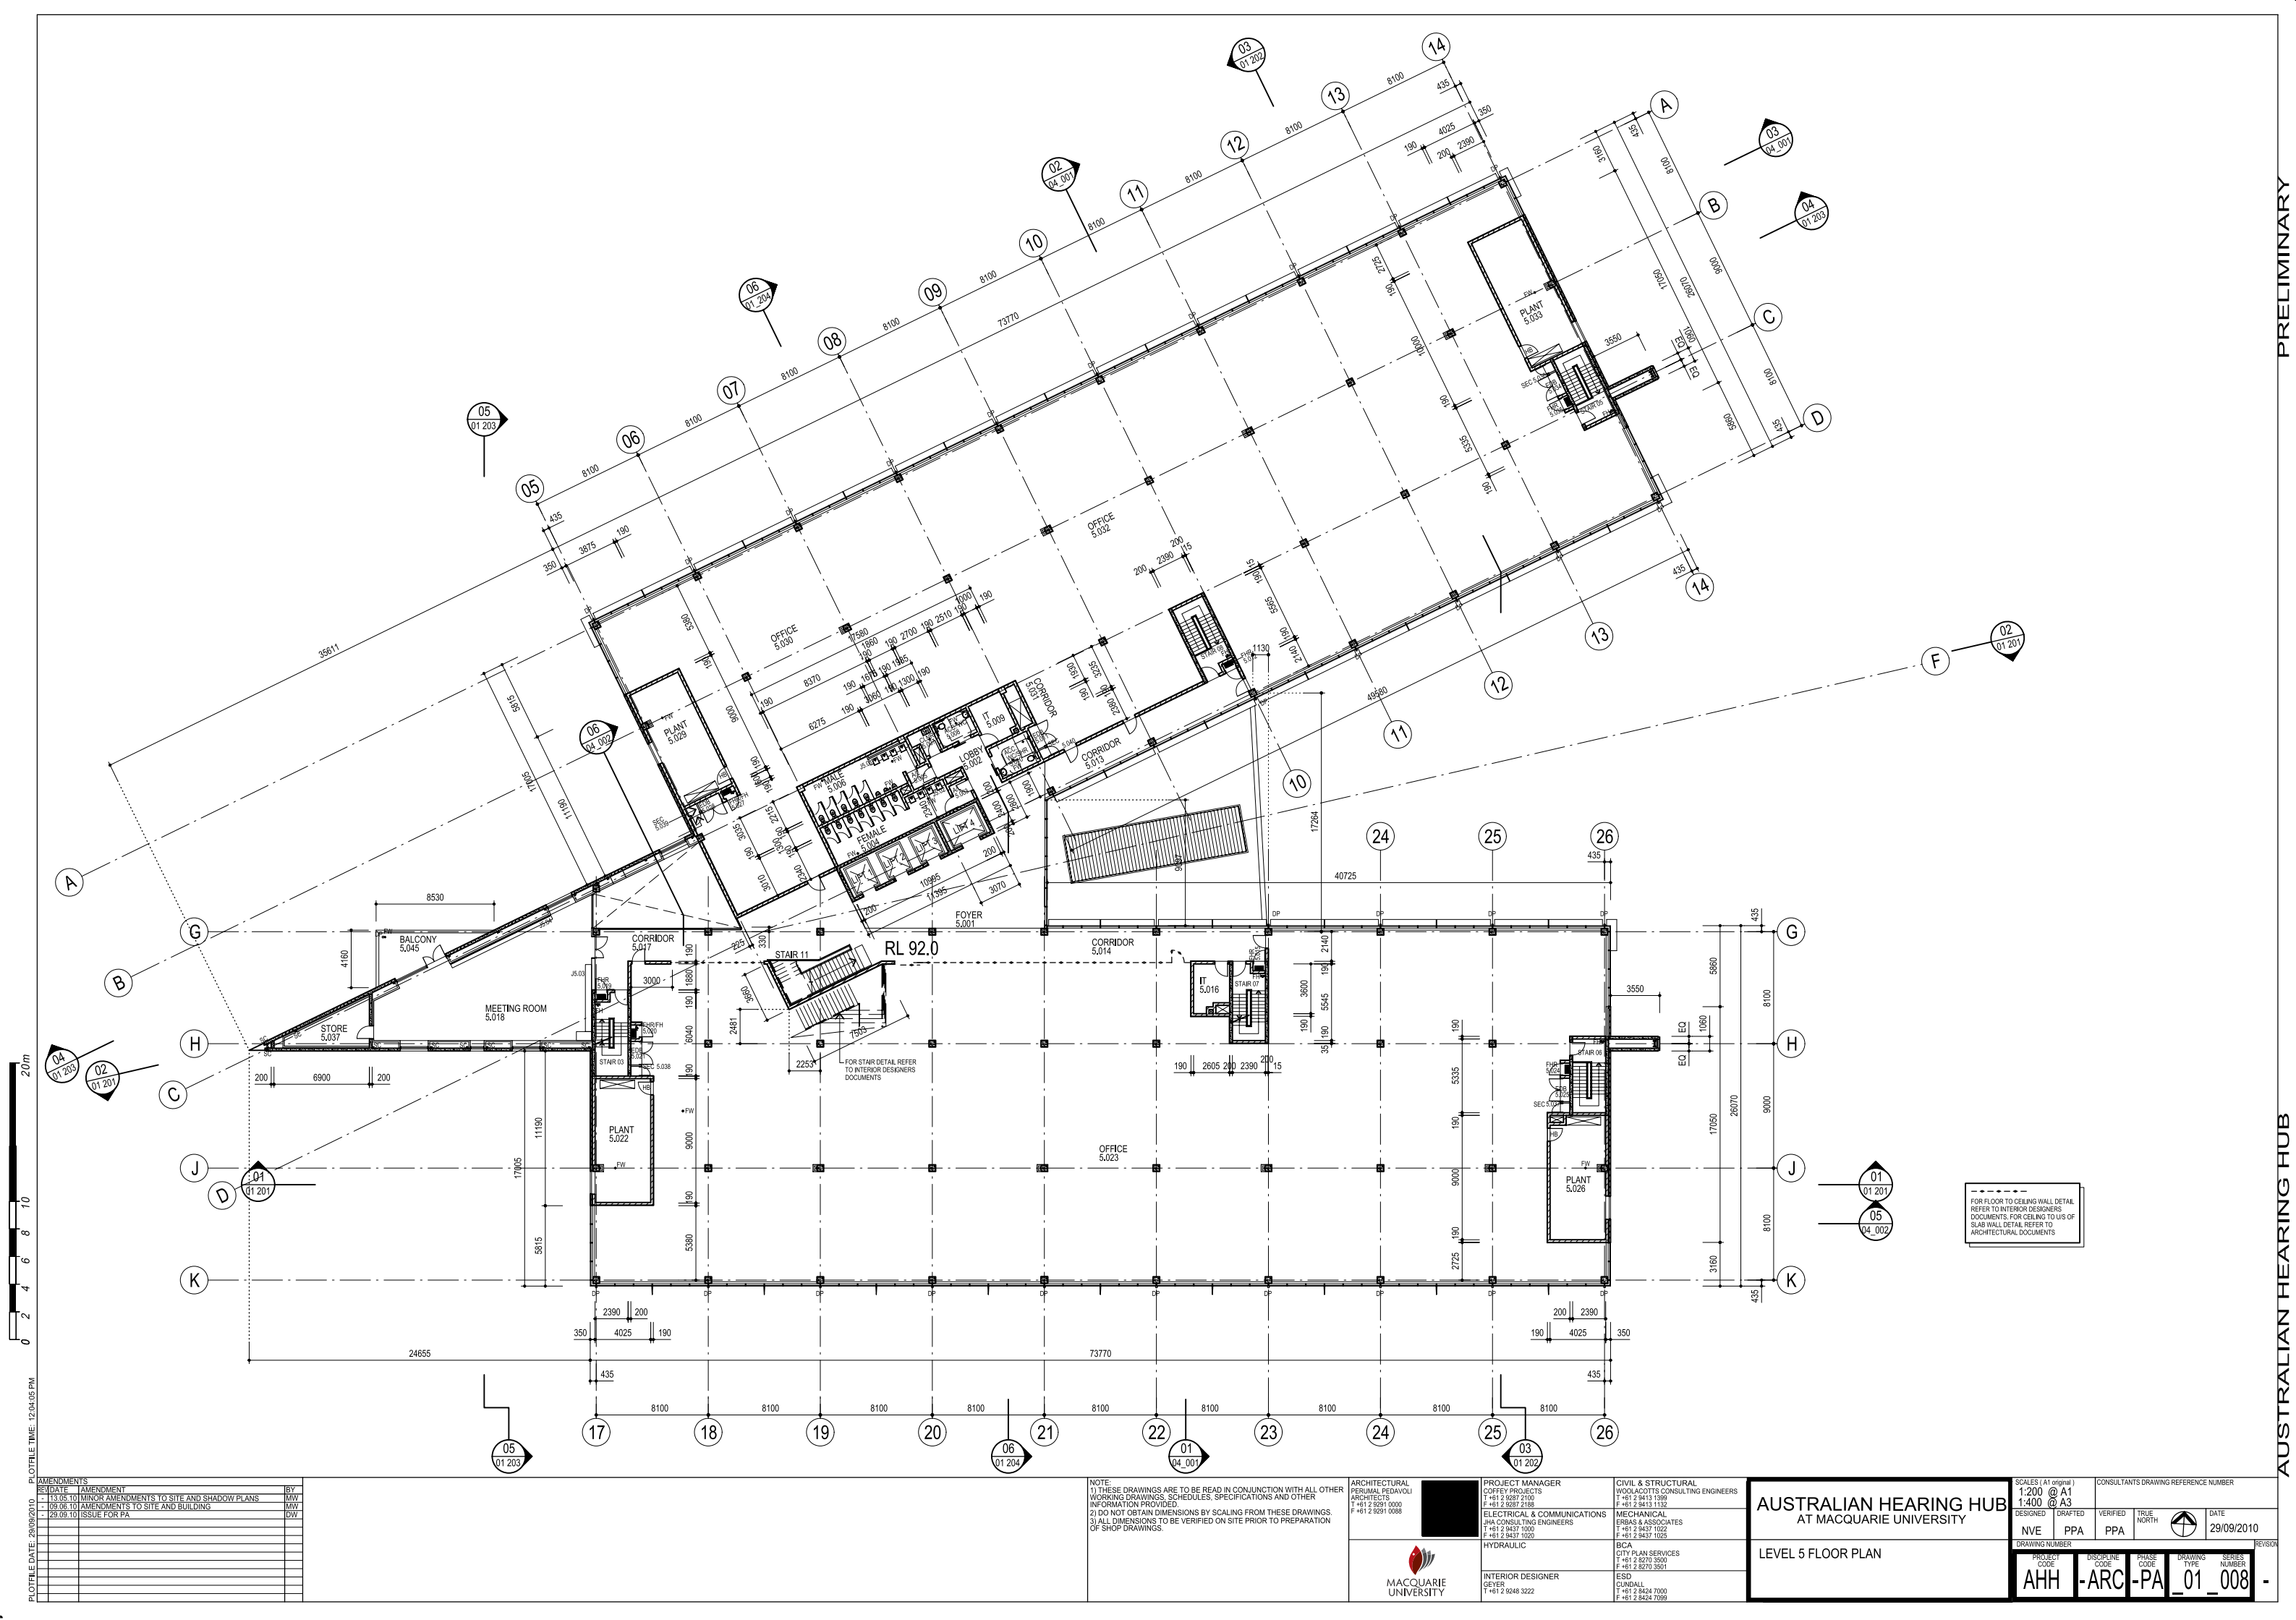

AMENDMENTS		BY
REVISION	AMENDMENT	
01	13.05.10 MINOR AMENDMENTS TO SITE AND SHADOW PLANS	MW
02	09.06.10 AMENDMENTS TO SITE AND BUILDING	MW
03	29.09.10 ISSUE FOR PA	DW

PLOT FILE DATE: 28/09/2010
PLOT FILE TIME: 12:04:05 PM

NOTE:
1) THESE DRAWINGS ARE TO BE READ IN CONJUNCTION WITH ALL OTHER WORKING DRAWINGS, SCHEDULES, SPECIFICATIONS AND OTHER INFORMATION PROVIDED.
2) DO NOT OBTAIN DIMENSIONS BY SCALING FROM THESE DRAWINGS.
3) ALL DIMENSIONS TO BE VERIFIED ON SITE PRIOR TO PREPARATION OF SHOP DRAWINGS.

ARCHITECTURAL
PERUMAL PEDAVOLI
ARCHITECTS
T +61 2 9291 2100
F +61 2 9291 0088



PROJECT MANAGER
COFFEY PROJECTS
T +61 2 9287 2100
F +61 2 9287 2188
ELECTRICAL & COMMUNICATIONS
JHA CONSULTING ENGINEERS
T +61 2 9437 1000
F +61 2 9437 1020
HYDRAULIC
INTERIOR DESIGNER
T +61 2 9248 3222

CIVIL & STRUCTURAL
WOOLACOTT'S CONSULTING ENGINEERS
T +61 2 9413 1399
F +61 2 9413 1132
MECHANICAL
ERBAS & ASSOCIATES
T +61 2 9437 1022
F +61 2 9437 1025
BCA
CITY PLAN SERVICES
T +61 2 8270 3500
F +61 2 8270 3501
ESD
CUNDALL
T +61 2 8424 7000
F +61 2 8424 7099

AUSTRALIAN HEARING HUB
AT MACQUARIE UNIVERSITY

LEVEL 5 FLOOR PLAN

SCALES (At original)
1:200 @ A1
1:400 @ A3

CONSULTANTS DRAWING REFERENCE NUMBER

DRAWING NUMBER
NVE PPA PPA
PROJECT CODE
AHH -ARC -PA

DATE
29/09/2010

REVISION