


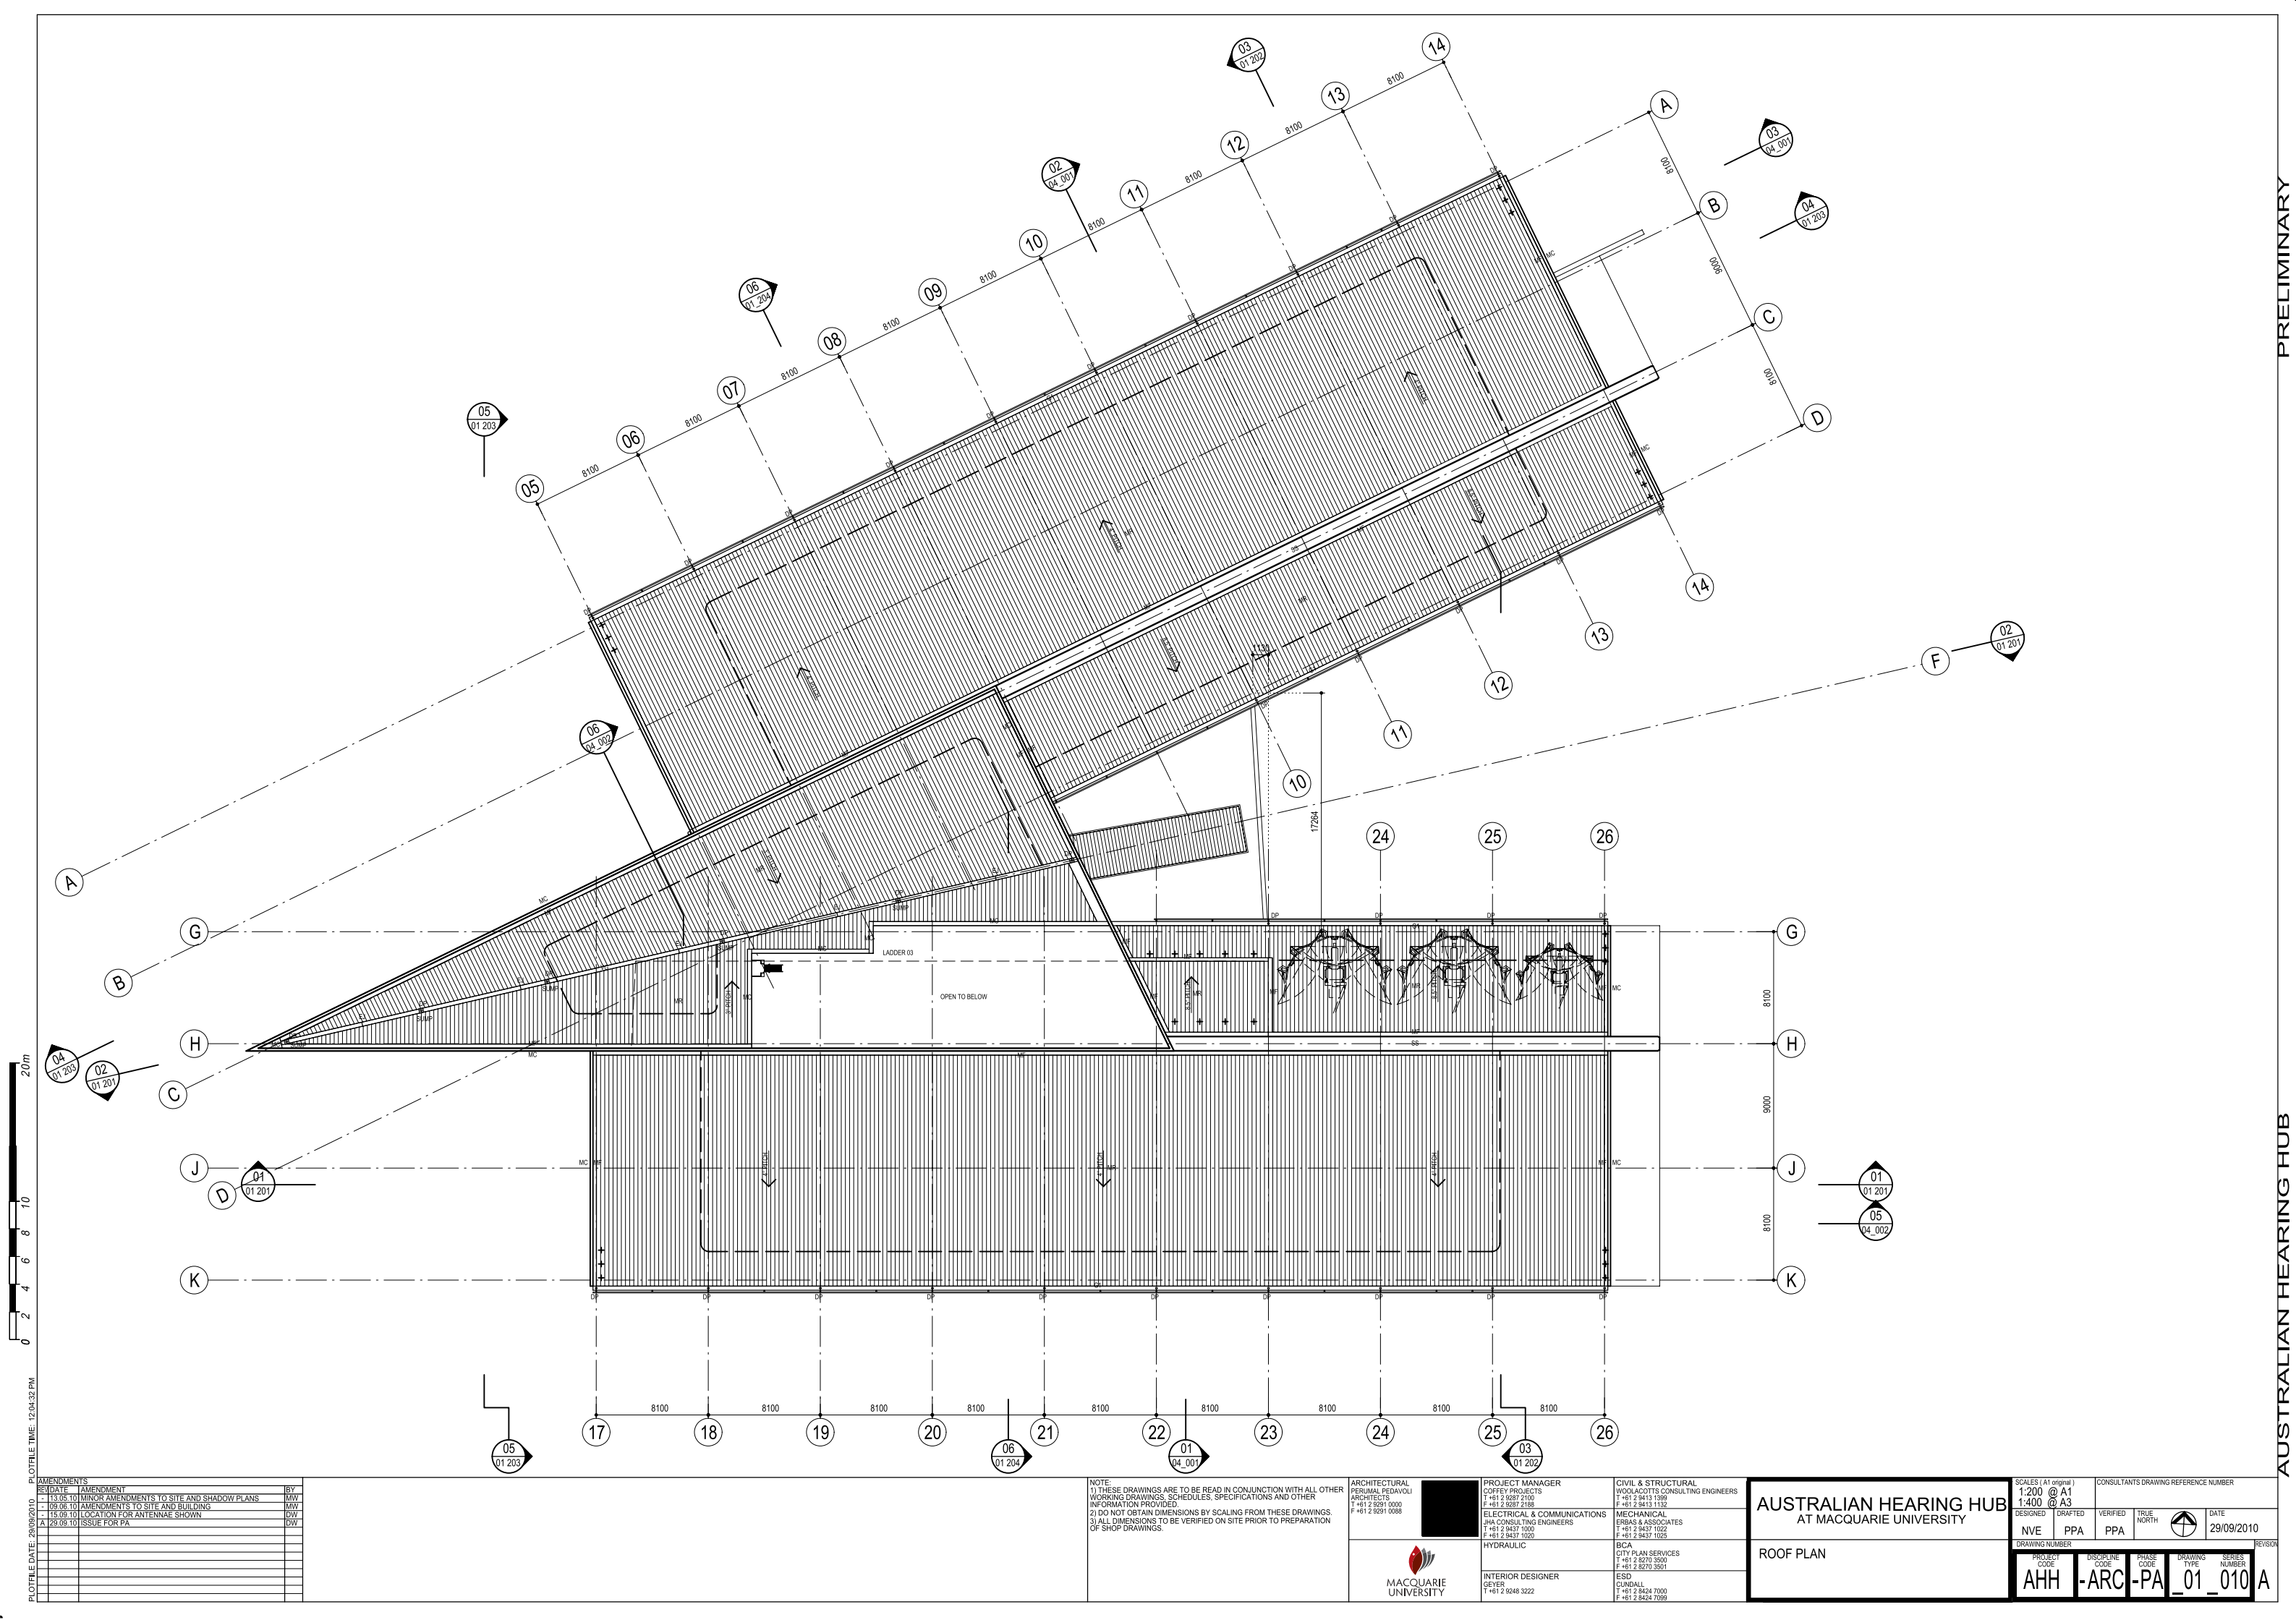

AMENDMENTS	
REV	DATE
01	2010
02	2010
03	2010
04	2010
05	2010
06	2010
07	2010
08	2010
09	2010
10	2010
11	2010
12	2010
13	2010
14	2010
15	2010
16	2010
17	2010
18	2010
19	2010
20	2010
21	2010
22	2010
23	2010
24	2010
25	2010
26	2010

BY	DATE	AMENDMENT
MM	09/09/10	MINOR AMENDMENTS TO SITE AND SHADOW PLANS
MM	09/09/10	AMENDMENTS TO SITE AND BUILDING
DW	15/09/10	LOCATION FOR ANTENNAE SHOWN
DW	29/09/10	ISSUE FOR PA

NOTE:
1) THESE DRAWINGS ARE TO BE READ IN CONJUNCTION WITH ALL OTHER WORKING DRAWINGS, SCHEDULES, SPECIFICATIONS AND OTHER INFORMATION PROVIDED.
2) DO NOT OBTAIN DIMENSIONS BY SCALING FROM THESE DRAWINGS.
3) ALL DIMENSIONS TO BE VERIFIED ON SITE PRIOR TO PREPARATION OF SHOP DRAWINGS.

ARCHITECTURAL
PERUMAL PEDAVOLI
ARCHITECTS
T +61 2 9287 2100
F +61 2 9291 0008



PROJECT MANAGER
COFFEY PROJECTS
T +61 2 9287 2100
F +61 2 9287 2188
ELECTRICAL & COMMUNICATIONS
JHA CONSULTING ENGINEERS
T +61 2 9437 1000
F +61 2 9437 1020
HYDRAULIC
INTERIOR DESIGNER
T +61 2 9246 3222

CIVIL & STRUCTURAL
WOOLACOTT CONSULTING ENGINEERS
T +61 2 9413 1399
F +61 2 9413 1132
MECHANICAL
ERBAS & ASSOCIATES
T +61 2 9437 1022
F +61 2 9437 1025
CITY PLAN SERVICES
T +61 2 8270 3500
F +61 2 8270 3501
ESD
CUNDALL
T +61 2 8424 7000
F +61 2 8424 7099

AUSTRALIAN HEARING HUB
AT MACQUARIE UNIVERSITY

ROOF PLAN

SCALES (At original)
1:200 @ A1
1:400 @ A3

CONSULTANTS DRAWING REFERENCE NUMBER

DRAWING NUMBER

PROJECT CODE
AHH

DISCIPLINE CODE
-ARC

PHASE CODE
-PA

DRAWING TYPE
_01_010

SERIES NUMBER
A

DESIGNED
NVE

DRAFTED
PPA

VERIFIED
PPA

TRUE NORTH
N

DATE
29/09/2010

REVISION

PLOT FILE DATE: 29/09/2010
PLOT FILE TIME: 12:04:32 PM

0 2 4 6 8 10 20m