



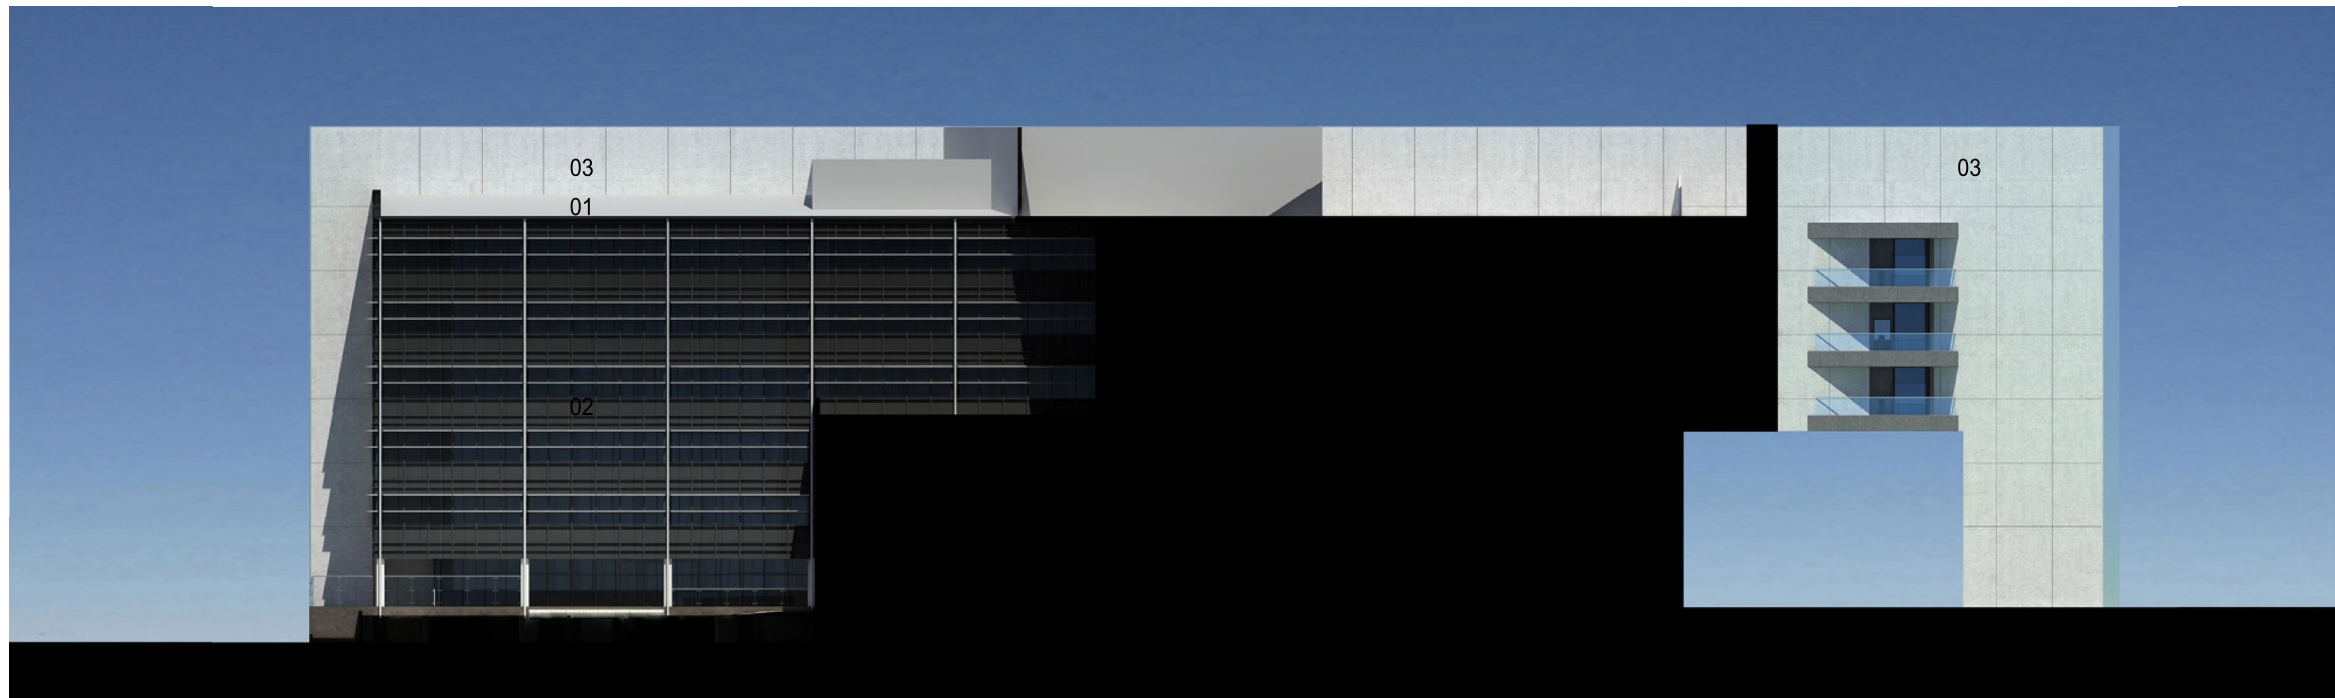

NORTH ELEVATION

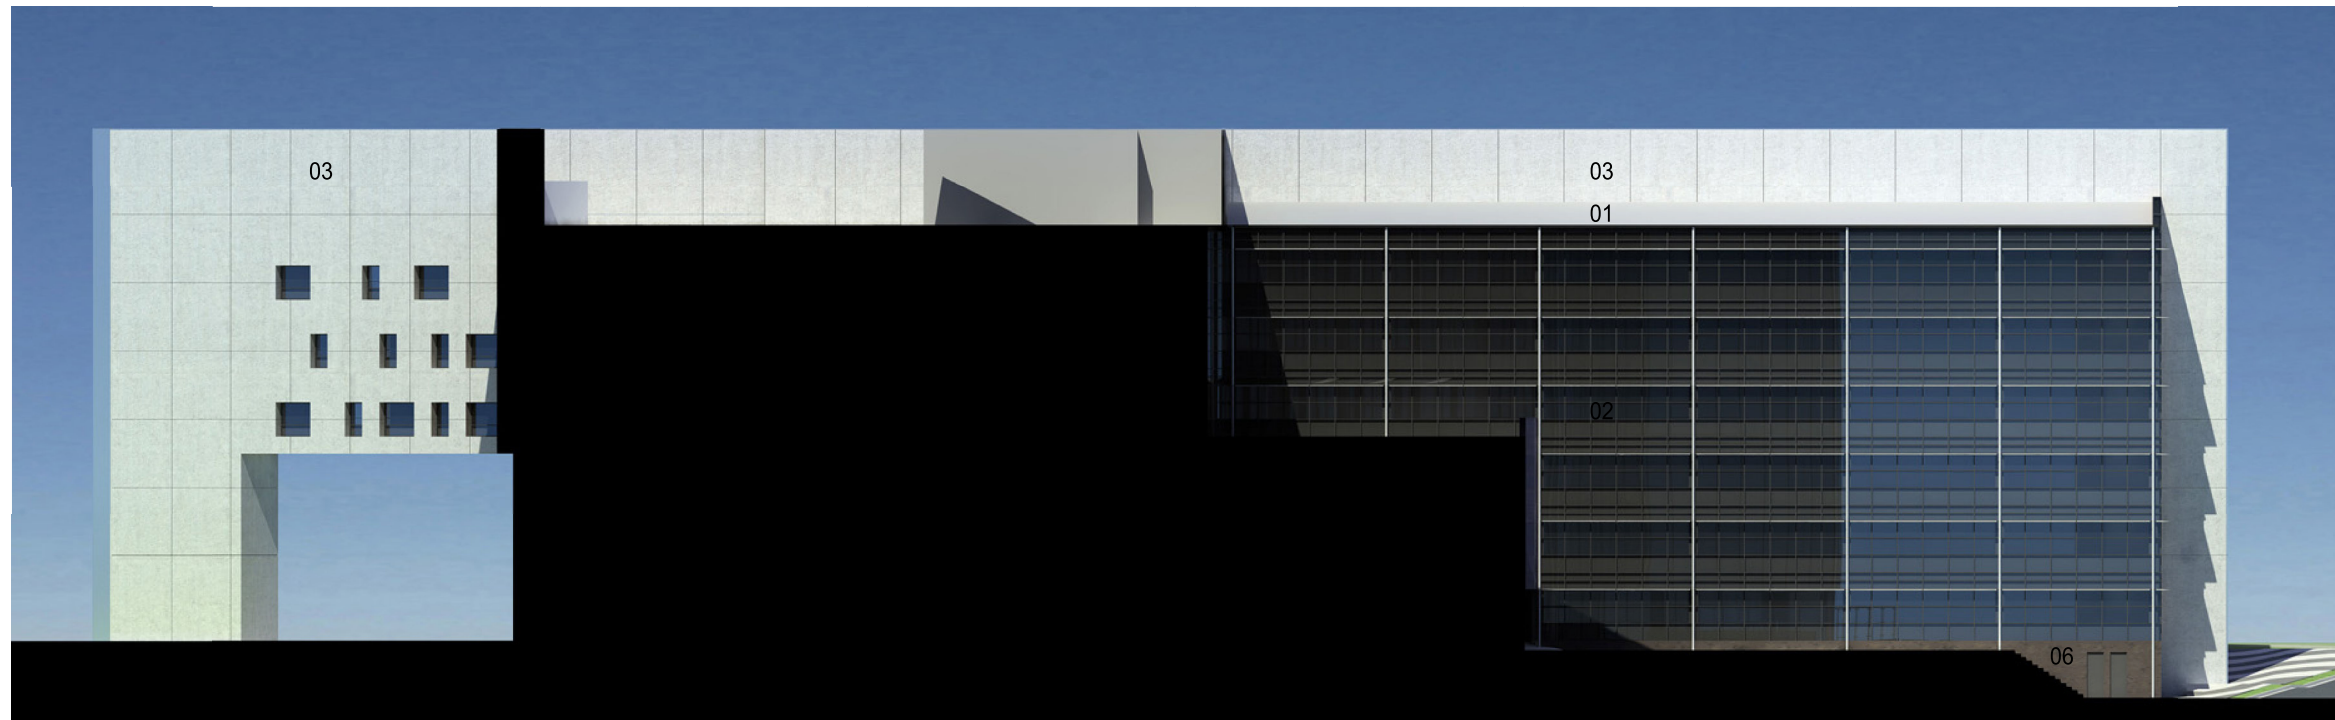


SOUTH EAST ELEVATION

PLOTFILE DATE: 29/09/2010 PLOTFILE TIME: 12:06:08 PM[illegible]

LEGEND:

01	MR - METAL ROOF
02	WINDOW/DOOR FRAMING
03	PC - PRECAST CONCRETE PANELS
04	FB2 - FACE BRICK
05	FB3 - FACE BRICK
06	FB1 - FACE BRICK
07	FB5 - FACE BRICK
08	FB4 - FACE BRICK
09	FB6 - FACE BRICK

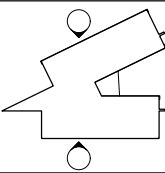

KEY MAP

NOTE:

- 1) THESE DRAWINGS ARE TO BE READ IN CONJUNCTION WITH ALL OTHER WORKING DRAWINGS, SCHEDULES, SPECIFICATIONS AND OTHER INFORMATION PROVIDED.
- 2) DO NOT OBTAIN DIMENSIONS BY SCALING FROM THESE DRAWINGS.
- 3) ALL DIMENSIONS TO BE VERIFIED ON SITE PRIOR TO PREPARATION OF SHOP DRAWINGS.

ARCHITECTURAL
PERUMAL PEDAVOLI
ARCHITECTS
T +61 2 9291 0000
F +61 2 9291 0088



PROJECT MANAGER
COFFEY PROJECTS
T +61 2 9287 2100
F +61 2 9287 2188

ELECTRICAL & COMMUNICATIONS
JHA CONSULTING ENGINEERS
T +61 2 9437 1000
F +61 2 9437 1020

HYDRAULIC

INTERIOR DESIGNER
GEYER
T +61 2 9248 3222

CIVIL & STRUCTURAL
WOOLACOTTS CONSULTING ENGINEERS
T +61 2 9413 1399
F +61 2 9413 1132
MECHANICAL

ERBAS & ASSOCIATES
T +61 2 9437 1022
F +61 2 9437 1025

BCA
CITY PLAN SERVICES
T +61 2 8270 3500
F +61 2 8270 3501

ESD
CUNDALL
T +61 2 8424 7000
F +61 2 8424 7099

ESD
CUNDALL
T +61 2 8424 7000
F +61 2 8424 7099

AUSTRALIAN HEARING HUB
AT MACQUARIE UNIVERSITY

COLOURED ELEVATIONS 03

SCALES (A1 original) ~1:200 @ A1 ~1:400 @ A3		CONSULTANTS DRAWING REFERENCE NUMBER				
DESIGNED	DRAFTED	VERIFIED	TRUE NORTH	DATE		
NVE	PPA	PPA		29/09/2010		
DRAWING NUMBER						REVISION
PROJECT CODE	DISCIPLINE CODE	PHASE CODE	DRAWING TYPE	SERIES NUMBER		
AHH	-ARC	-PA	_01	_114		-