

ISSUE	DATE	FOR
1	02.08.10	SPP PDP
2	19.08.10	DA
3	23.08.10	DA
4	25.08.10	DA


 



PROJECT

**WESTMEAD
MILLENNIUM INSTITUTE &
RESEARCH HUB**
BVN PROJECT NUMBER

s0911005

DRAWING KEY

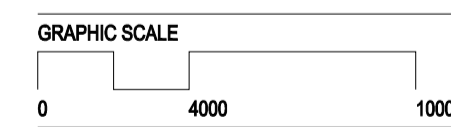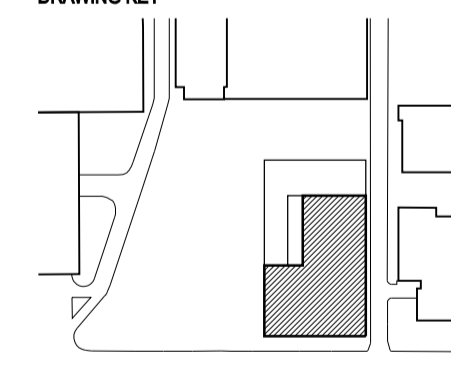


SCALE
1:400 at A3
1:200 at A1
DO NOT SCALE

STATUS
PRELIMINARY
DRAWING

**FLOOR PLAN
LEVEL 04**

DRAWING NUMBER
DA-D-04

ISSUE
4

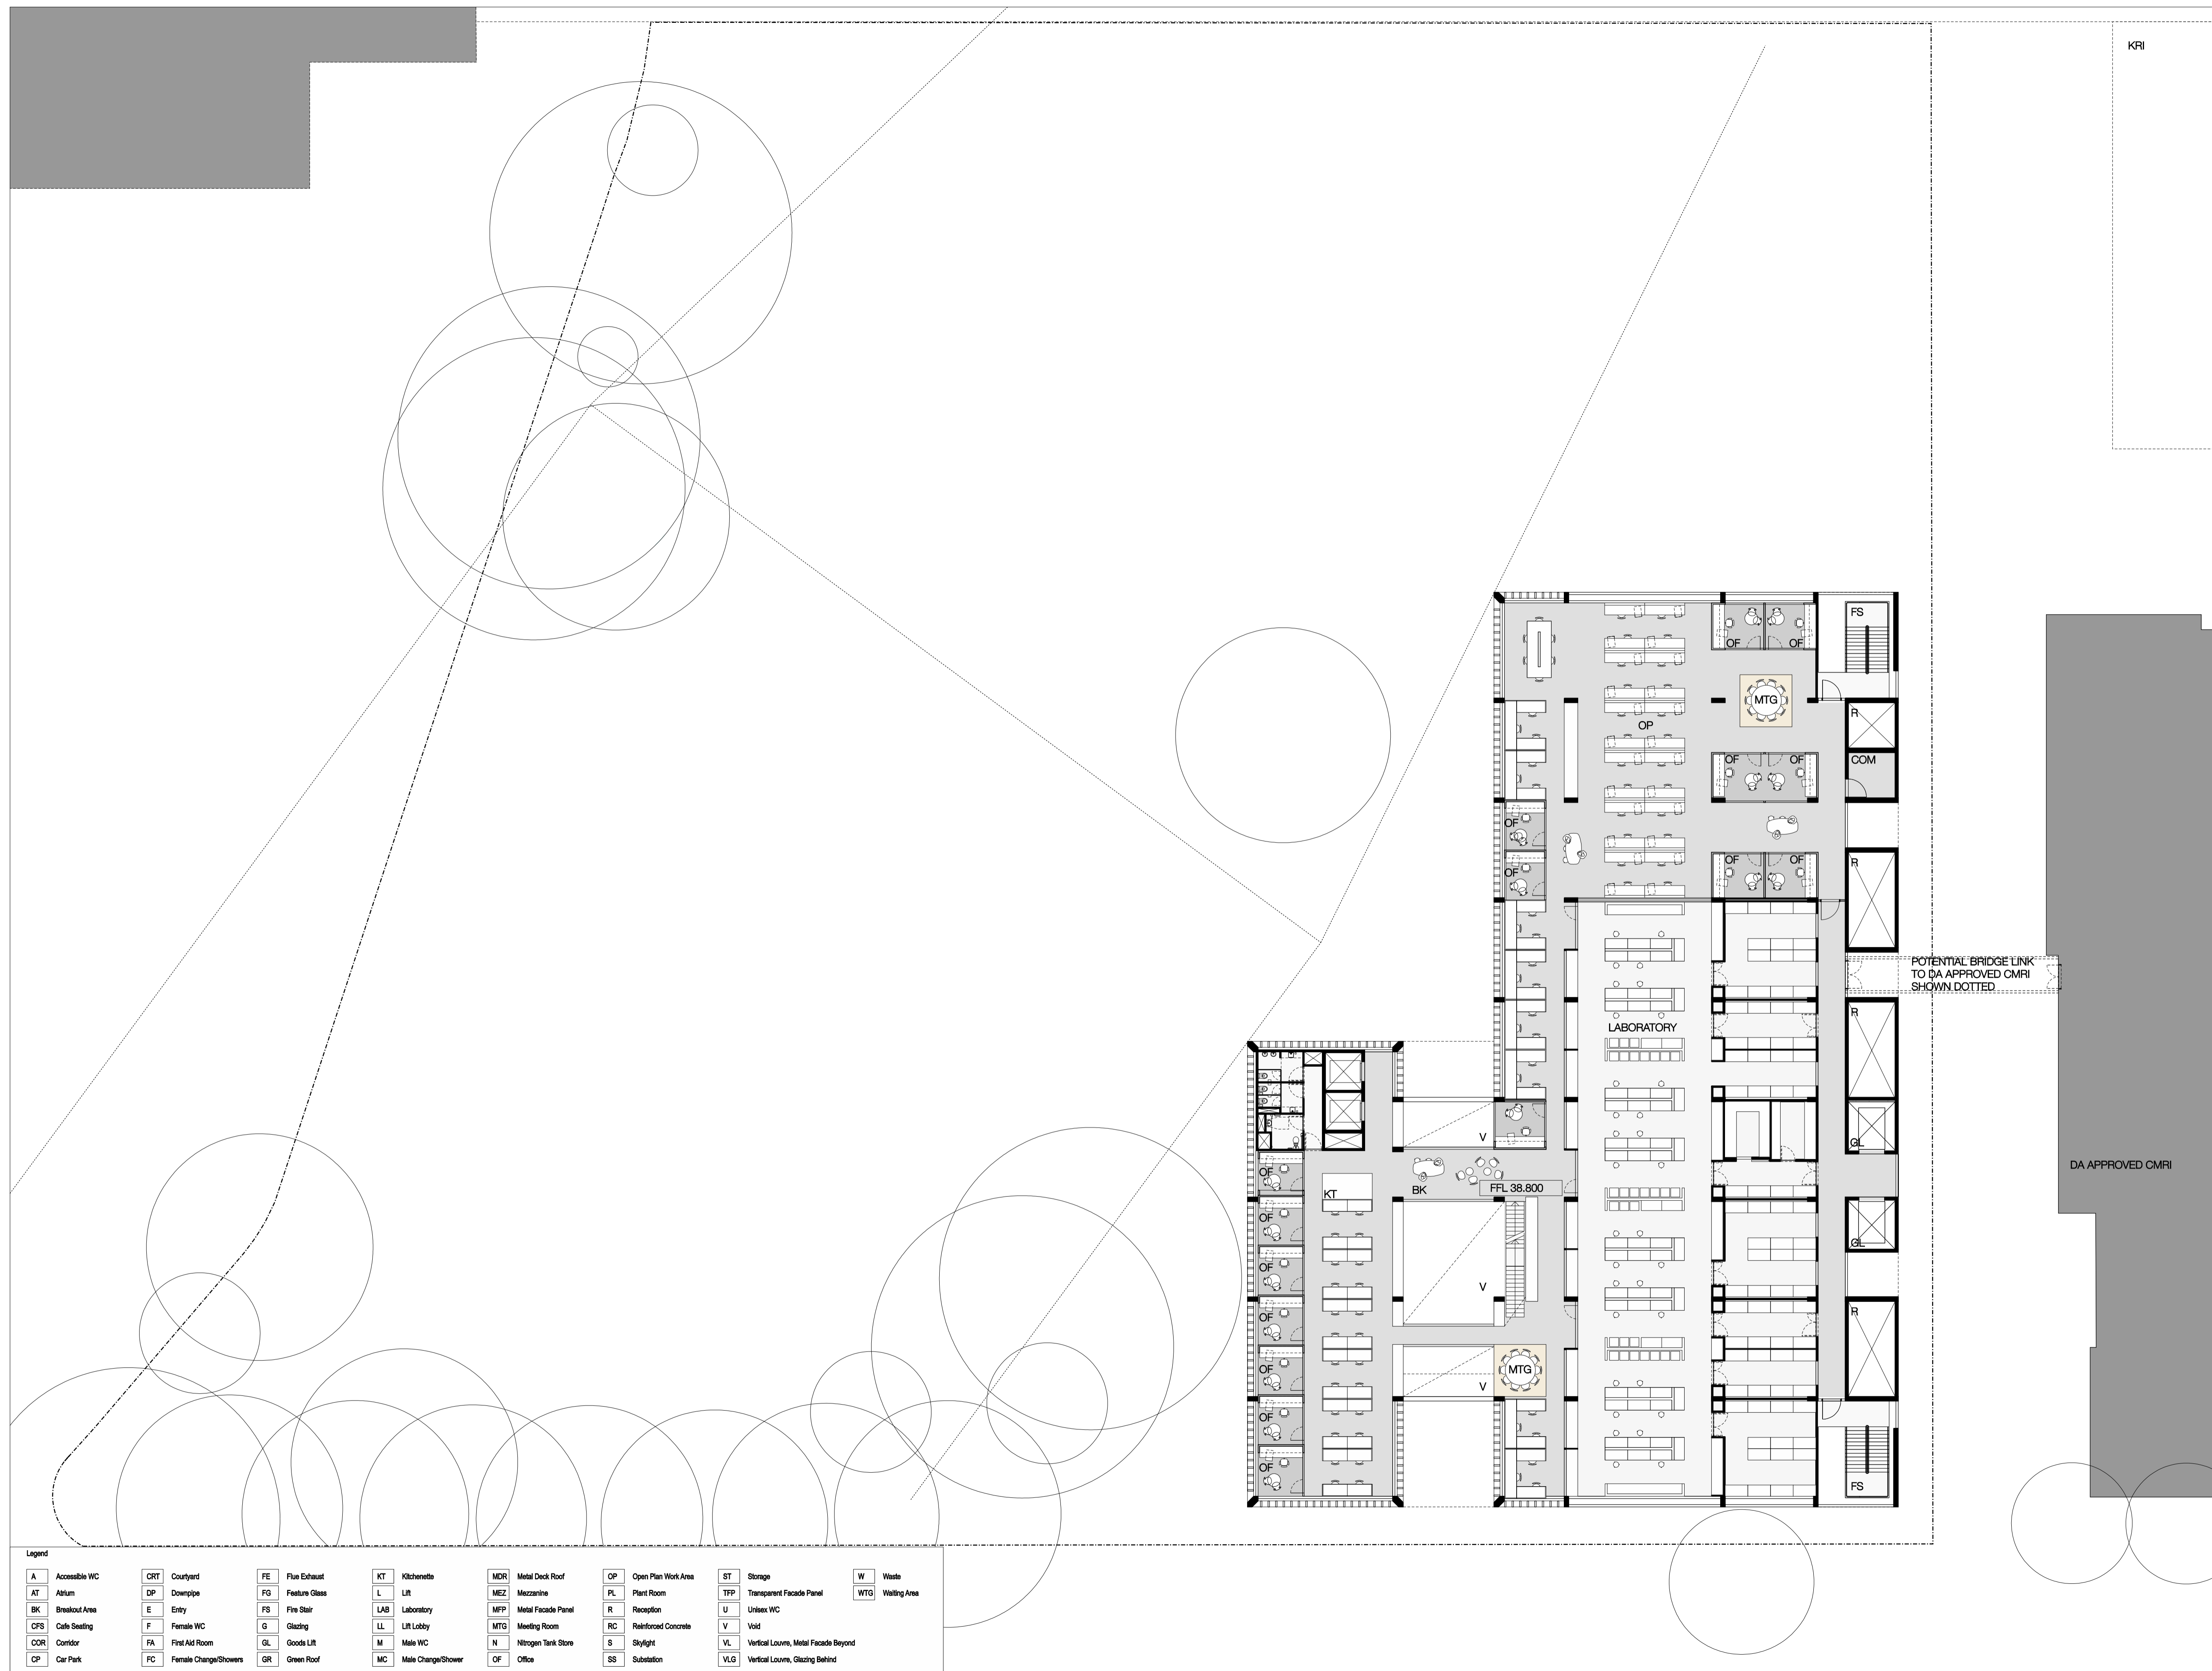

Legend

A	Accessible WC	CRT	Courtyard	FE	Flue Exhaust	KT	Kitchenette	MDR	Metal Deck Roof	OP	Open Plan Work Area	ST	Storage	W	Waste
AT	Album	DP	Downpipe	FG	Feature Glass	L	Lift	MEZ	Mezzanine	PL	Plant Room	TFP	Transparent Facade Panel	WTG	Waiting Area
BK	Breakout Area	E	Entry	FS	Fire Stair	LAB	Laboratory	MFP	Metal Facade Panel	R	Reception	U	Unisex WC		
CFS	Cafe Seating	F	Female WC	G	Glazing	LL	Lift Lobby	MTG	Meeting Room	RC	Reinforced Concrete	V	Void		
COR	Corridor	FA	First Aid Room	GL	Goods Lift	M	Male WC	N	Nitrogen Tank Store	S	Skylight	VL	Vertical Louvre, Metal Facade Beyond		
CP	Car Park	FC	Female Change/Showers	GR	Green Roof	MC	Male Change/Showers	OF	Office	SS	Substation	VLG	Vertical Louvre, Glazing Behind		